



SEE 600 CEILING HEIGHT UNLESS NOTED OTHERWISE U.S.

SEE 600 CEILING HEIGHT UNLESS NOTED OTHERWISE U.S.

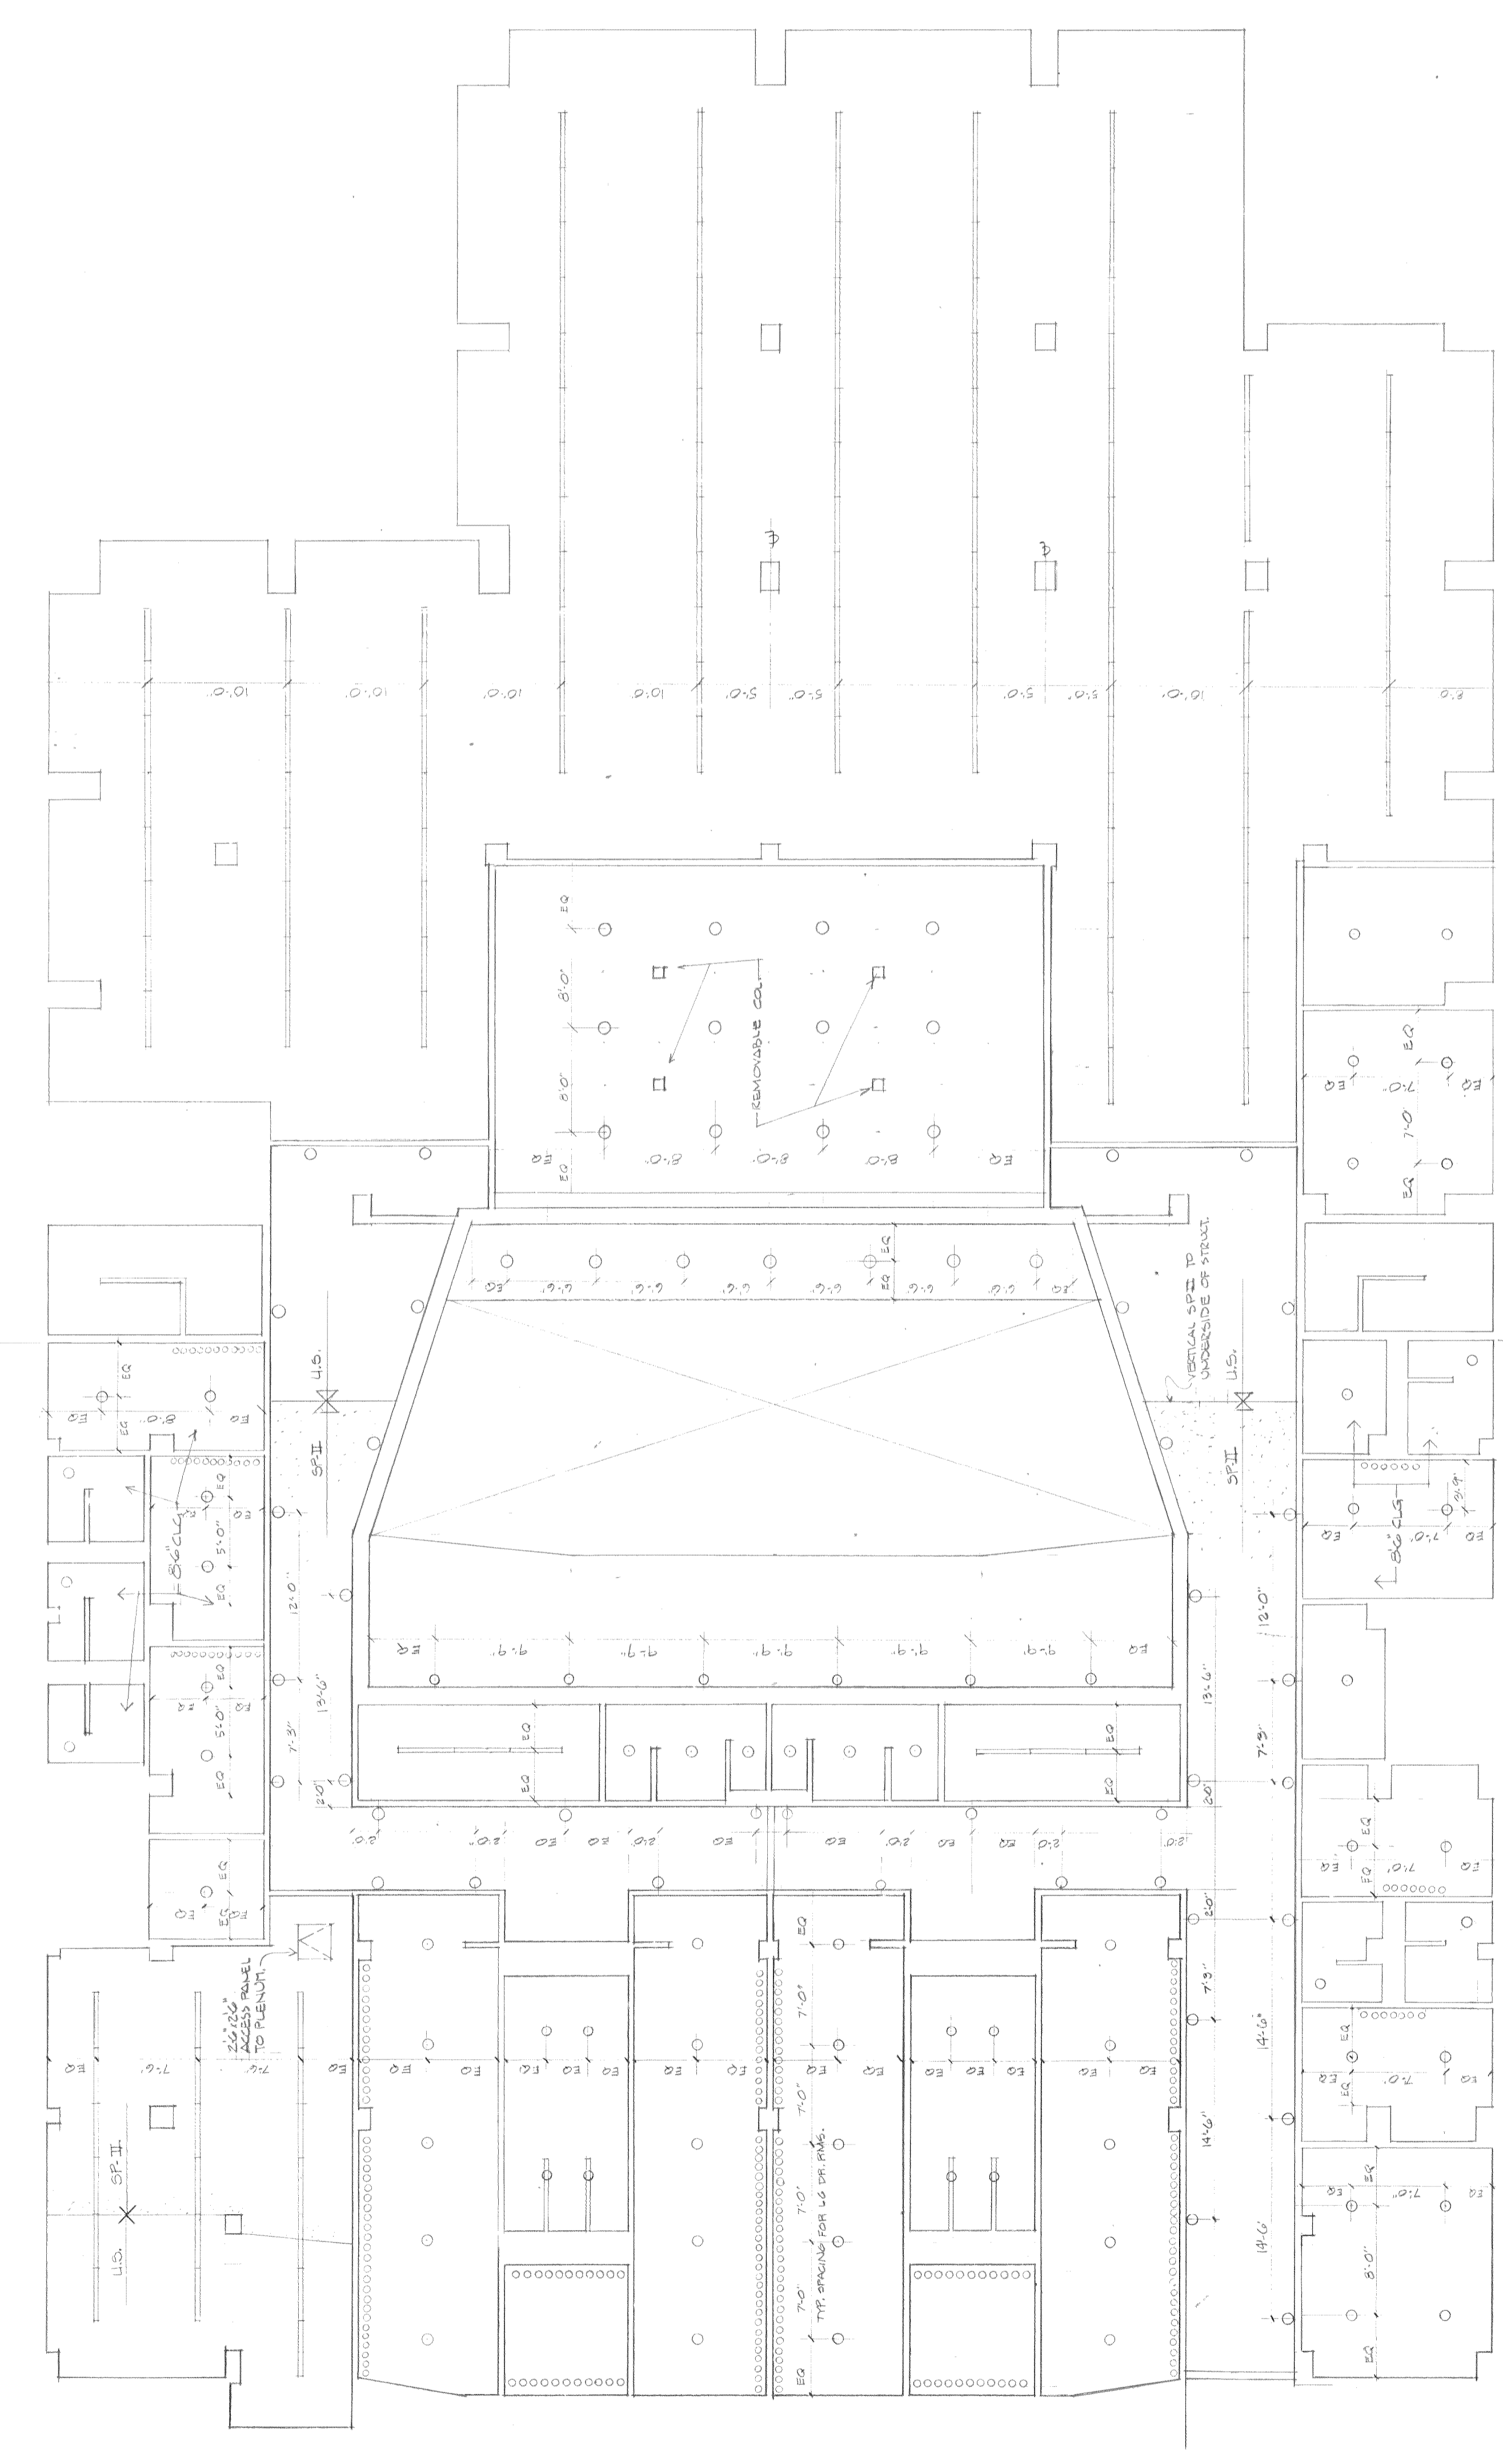

NOTE: TYPICAL WALL MOUNTED FEATURE IN CORRIDOR TO BE 60" ABOVE FIN. FLOOR



STATE UNIVERSITY OF NEW YORK COLLEGE AT
PURCHASE
STATE UNIVERSITY CONSTRUCTION FUND
2000

PERFORMING ARTS CENTER

ARCHITECT:
EDWARD LARSEN BARNES P.A.A.
LANDSCAPE ARCHITECT:
PETER C. ROLLAND
CONSULTING ENGINEERS:
WESKOFF AND PROCTOR
SEANER AND DALTON
BOLE BERANEK AND NEWMAN
ARCHITECT CONSULTANTS

REFLECTED CEILING PLAN
DRESSING ROOM LEVEL

PAC B204

SCALE: 1/8" = 1'-0"

DATE: 10/24/1972

CONFORMED DWG