



SEE 600 CEILING HEIGHT UNLESS NOTED DIFFERENT U.S.

SEE 600 CEILING HEIGHT UNLESS NOTED DIFFERENT U.S.

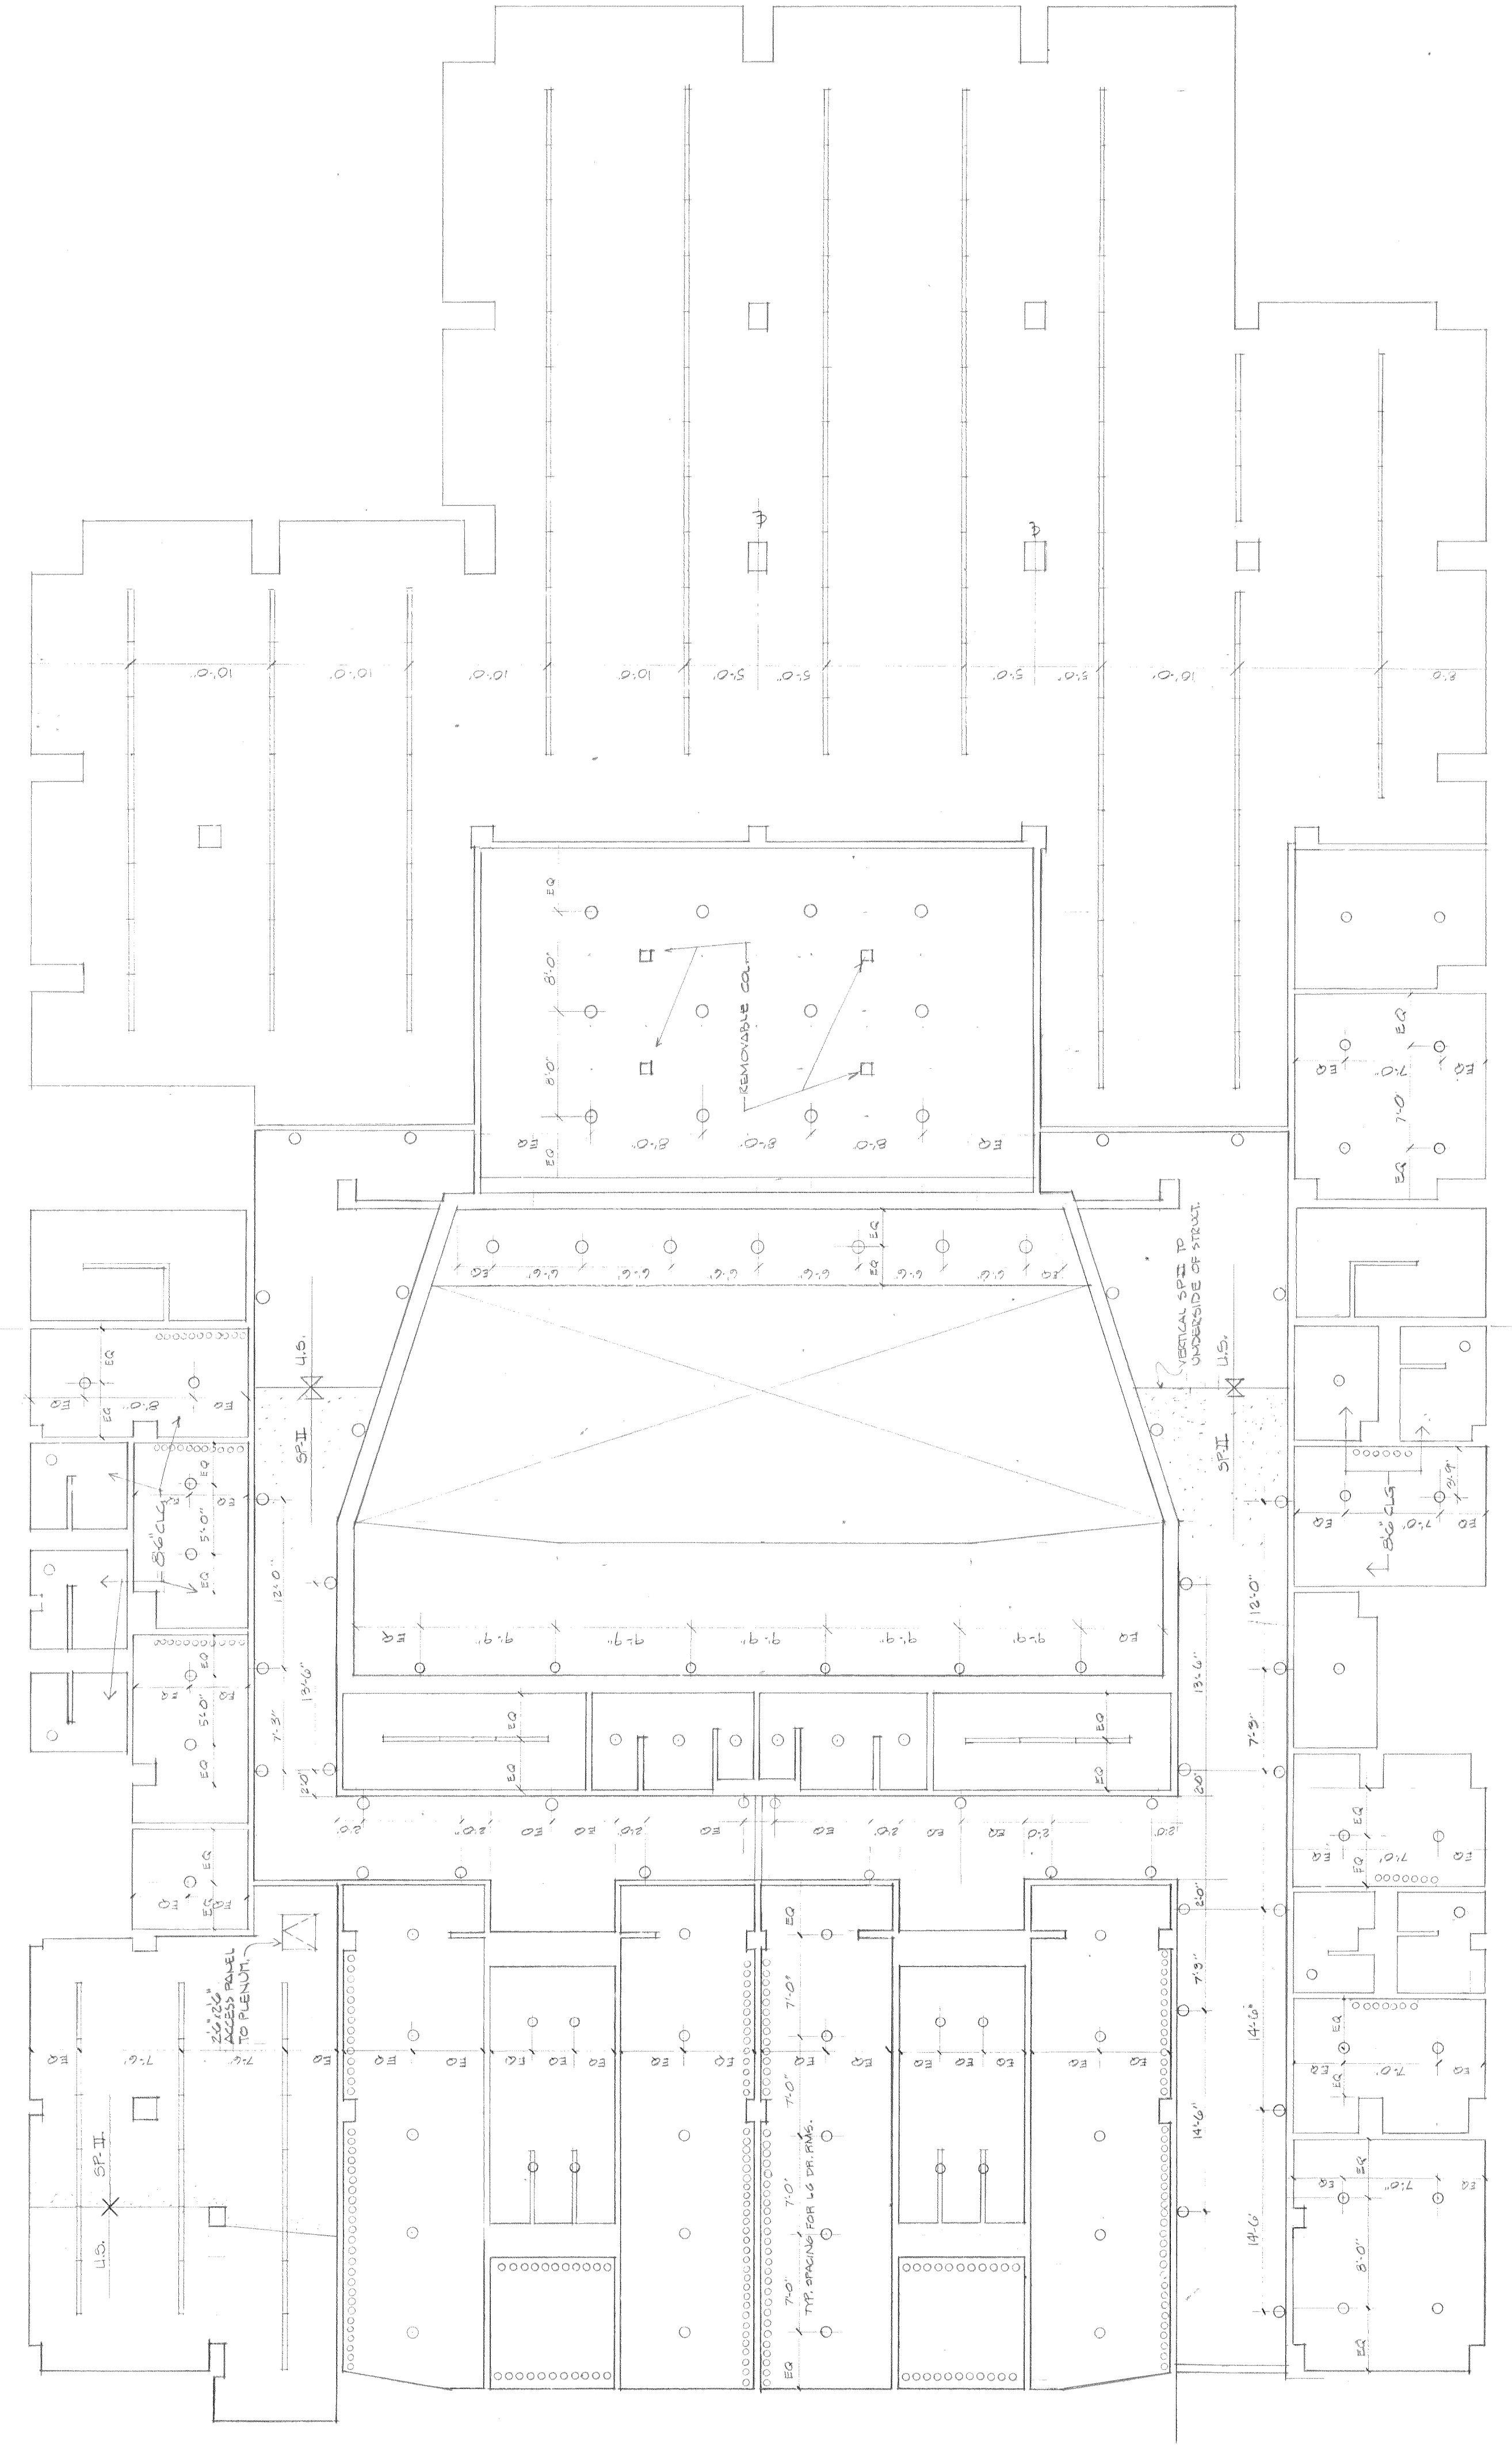


NOTE: TYPICAL WALL MOUNTED FEATURE IN CORRIDOR TO BE 60\"/>

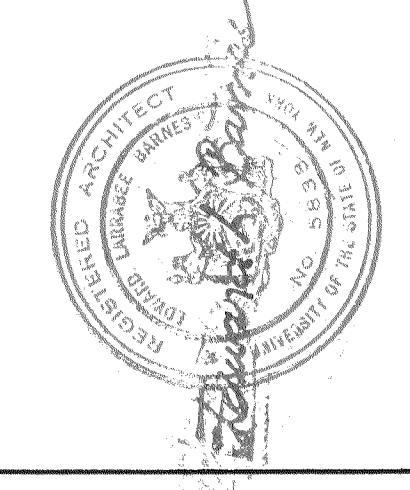

STATE UNIVERSITY OF NEW YORK COLLEGE AT PURCHASE
 STATE UNIVERSITY CONSTRUCTION FUND
 2000

PURCHASE
PERFORMING ARTS CENTER
 EDWARD LARSEN BARNES P.A.A.
 PETER C. ROLLAND
 WESLOFF AND PROCTOR
 SEGNER AND DALTON
 BOLE BERANEK AND NEWMAN

ARCHITECT
 LANDSCAPE ARCHITECT
 CONSULTING ENGINEERS
 CONSULTING ENGINEERS
 ARCHITECTURAL CONSULTANTS

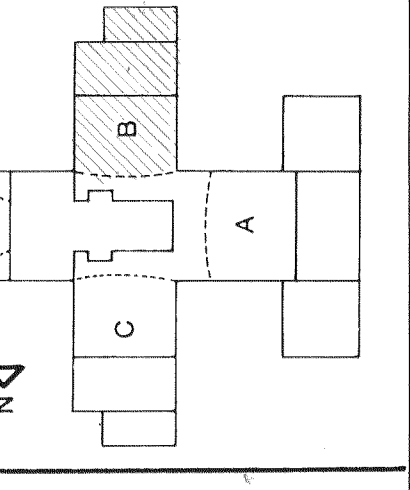

REFLECTED CEILING PLAN
 DRESSING ROOM LEVEL
PAC B204
 SCALE: 1/8" = 1'-0"
 DATE: 10/24/1972
 DRAWN:

CONFIRMED DWG