



3 SCALE: 1/2" = 1'-0"

4 SCALE: 1/2" = 1'-0"



NOTE: PANEL TO BE LOCATED
SLIGHTLY ABOVE LIGHT FIXTURES

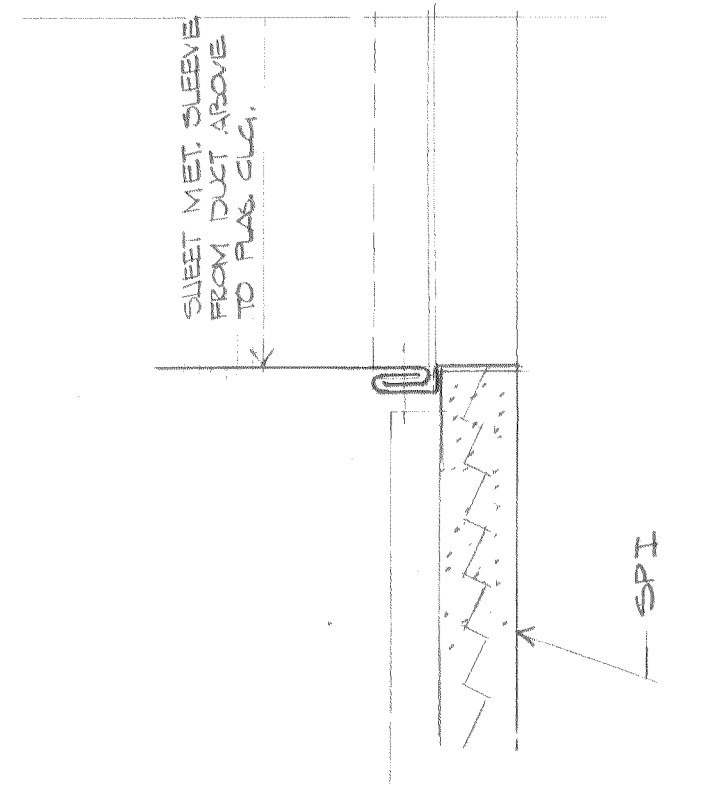


5 DETAIL SCALE: 5/8" = 1'-0"

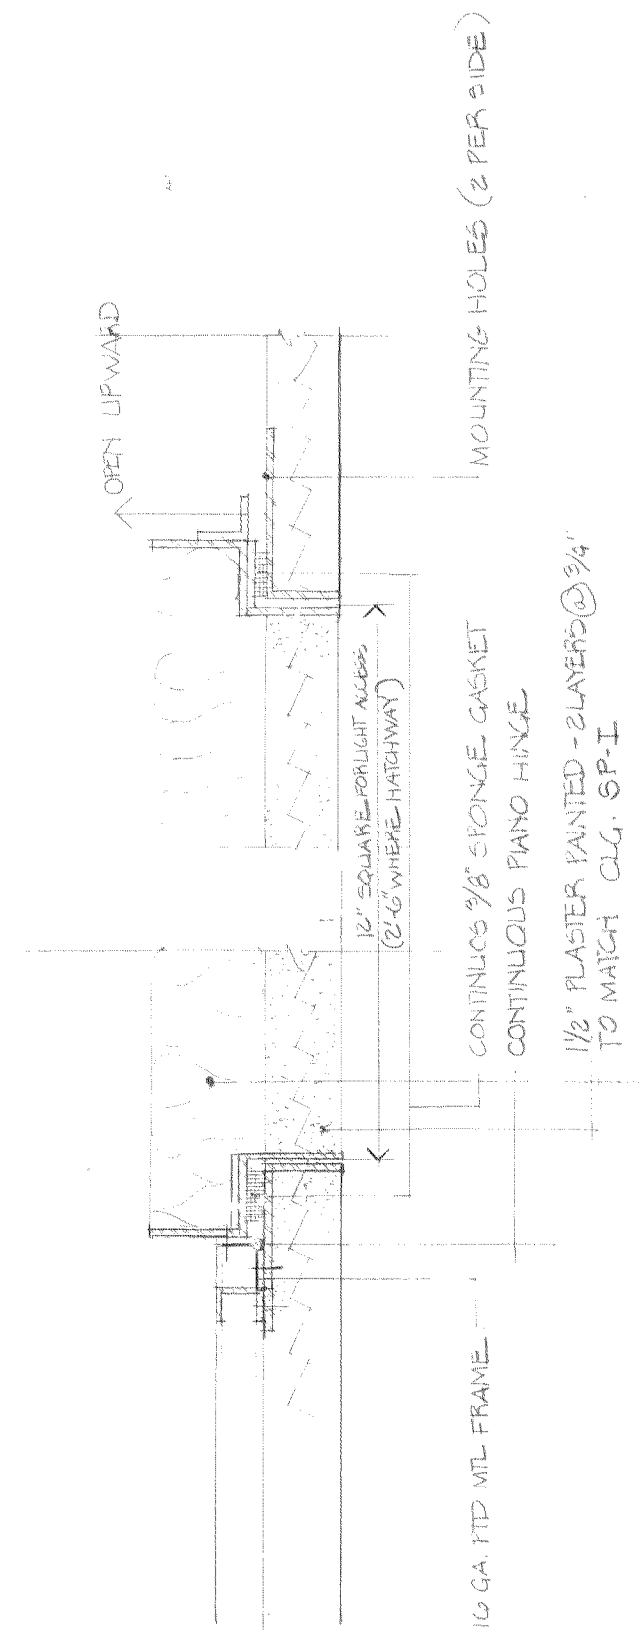

6 ACCESS PANEL SCALE: 5/8" = 1'-0"

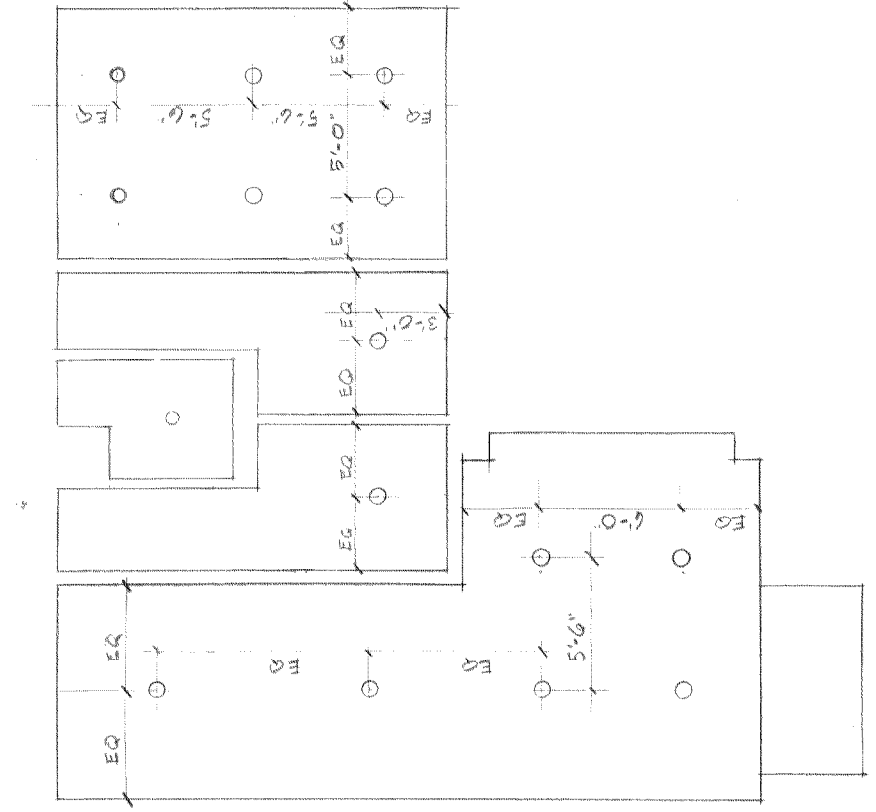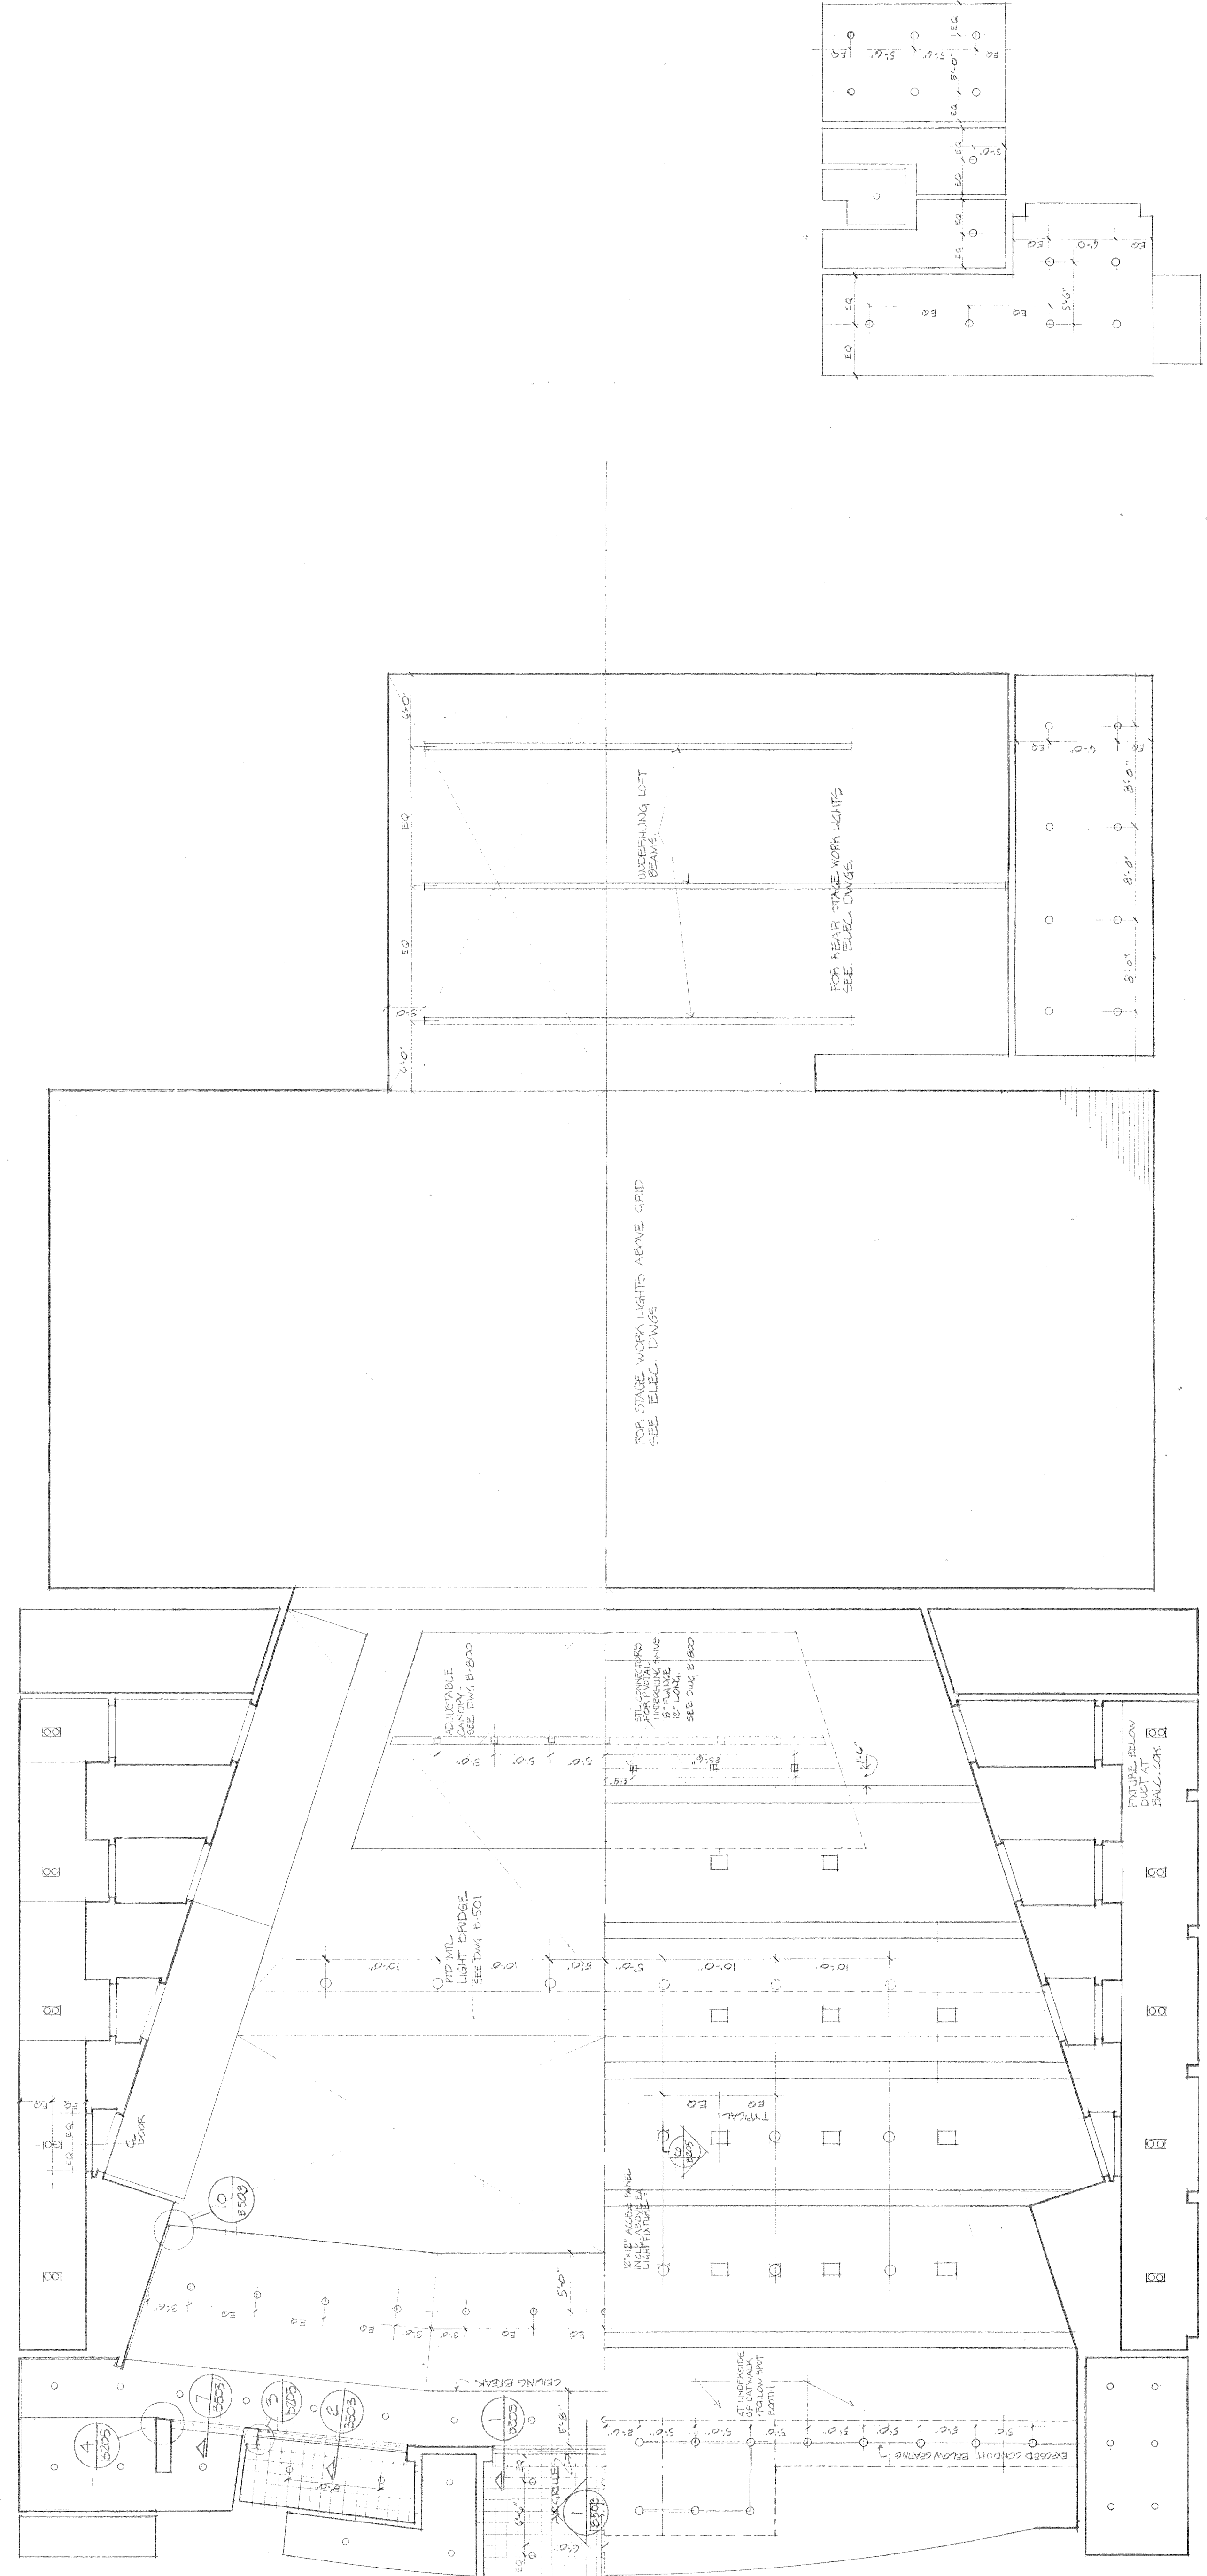

STATE UNIVERSITY OF NEW YORK COLLEGE AT
PURCHASE
 STATE UNIVERSITY CONSTRUCTION FUND
 PROJECT NUMBER 2920
PERFORMING ARTS CENTER
 EDWARD LARRABEE BARNES F.A.J.A.
 ARCHITECT
 PETER G. ROLLAND
 WESLOFF AND FOKKEMOORTH
 SCHEIDT AND DALTON
 ROBT. BERNICK AND KATZMAN
 BUILDING ARCHITECT
 CONSULTING ENGINEERS
 CONSULTING ENGINEERS
 CONSULTING ENGINEERS

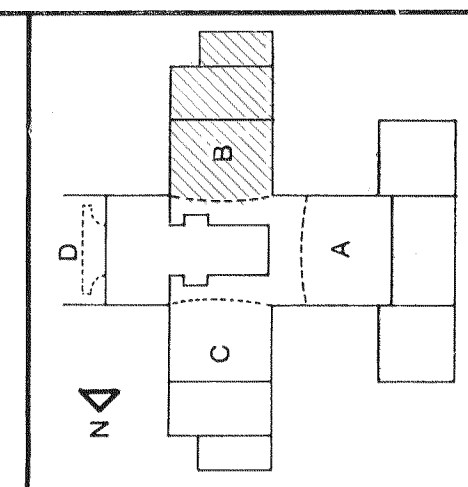

DATE: 16 MAY 1972
 DRAWN: **B205**
 SCALE: 1/8"

REFLECTED CEILING PLAN
 SEE BALCONY LEVEL HALF PLAN