

DRAWING INDEX							ISSUE DATE			
NO.	DRAWING NUMBER	DRAWING NAME	2013-44-01 DESIGN MANUAL				2013-01-15 100% CONSTRUCTION			
			2014-45-28 BID DOCUMENTS				2017-04-06 GROUP III AV BID DOCUMENTS			
1	TA000.0	AUDIOVISUAL COVER SHEET & NOTES	X	X	X	X				
2	TA102.0	AUDIOVISUAL - FACILITY - ENTRY PAVILION - CONCOURSE PLAN	X	X	X	X				
3	TA103.0	AUDIOVISUAL - FACILITY - ENTRY PAVILION - 1ST FLOOR PLAN	X							
4	TA112.0	AUDIOVISUAL - FACILITY - CITL BUILDING - CONCOURSE PLAN	X	X	X	X				
5	TA113.0	AUDIOVISUAL - FACILITY - CITL BUILDING - 1ST FLOOR PLAN	X	X	X	X				
6	TA114.0	AUDIOVISUAL - FACILITY - CITL BUILDING - 2ND FLOOR PLAN	X	X	X	X				
7	TA115.0	AUDIOVISUAL - FACILITY - CITL BUILDING - 3RD FLOOR PLAN	X	X	X	X				
8	TA202.0	AUDIOVISUAL - FACILITY - CITL BUILDING - BASEMENT LEVEL RCP					X			
9	TA203.0	AUDIOVISUAL - FACILITY - ENTRY PAVILION - 1ST FLOOR RCP	X							
10	TA212.0	AUDIOVISUAL - FACILITY - CITL BUILDING - CONCOURSE RCP	X	X	X	X				
11	TA213.0	AUDIOVISUAL - FACILITY - CITL BUILDING - 1ST FLOOR RCP	X	X	X	X				
12	TA214.0	AUDIOVISUAL - FACILITY - CITL BUILDING - 2ND FLOOR RCP	X	X	X	X				
13	TA215.0	AUDIOVISUAL - FACILITY - CITL BUILDING - 3RD FLOOR RCP	X	X	X	X				
14	TA302.0	AUDIOVISUAL - ELECTRICAL - ENTRY PAVILION - CONCOURSE PLAN	X	X	X	X				
15	TA303.0	AUDIOVISUAL - ELECTRICAL - ENTRY PAVILION - 1ST FLOOR PLAN	X							
16	TA312.0	AUDIOVISUAL - ELECTRICAL - CITL BUILDING - CONCOURSE PLAN	X	X	X	X				
17	TA313.0	AUDIOVISUAL - ELECTRICAL - CITL BUILDING - 1ST FLOOR PLAN	X	X	X	X				
18	TA314.0	AUDIOVISUAL - ELECTRICAL - CITL BUILDING - 2ND FLOOR PLAN	X	X	X	X				
19	TA315.0	AUDIOVISUAL - ELECTRICAL - CITL BUILDING - 3RD FLOOR PLAN	X	X	X	X				
20	TA403.0	AUDIOVISUAL - ELECTRICAL - ENTRY PAVILION - 1ST FLOOR RCP	X							
21	TA412.0	AUDIOVISUAL - ELECTRICAL - CITL BUILDING - CONCOURSE RCP	X	X	X	X				
22	TA413.0	AUDIOVISUAL - ELECTRICAL - CITL BUILDING - 1ST FLOOR RCP	X	X	X	X				
23	TA414.0	AUDIOVISUAL - ELECTRICAL - CITL BUILDING - 2ND FLOOR RCP	X	X	X	X				
24	TA415.0	AUDIOVISUAL - ELECTRICAL - CITL BUILDING - 3RD FLOOR RCP	X	X	X	X				
25	TA501.0	AUDIOVISUAL - ELECTRICAL CONDUIT RISER DIAGRAMS	X	X	X	X				
26	TA502.0	AUDIOVISUAL - ELECTRICAL CONDUIT RISER DIAGRAMS	X	X	X	X				
27	TA701.0	AUDIOVISUAL - DETAILS					X			
28	TA702.0	AUDIOVISUAL - DETAILS					X			
29	AATA12.0	AUDIOVISUAL - ADD ALTERNATE FACILITY CONCOURSE PLAN		X	X	X				
30	AATA202.0	AUDIOVISUAL - ADD ALTERNATE FACILITY BASEMENT LEVEL RCP					X			
31	AATA12.0	AUDIOVISUAL - ADD ALTERNATE FACILITY CONCOURSE RCP		X	X	X				
32	AATA312.0	AUDIOVISUAL - ADD ALTERNATE ELECTRICAL CONCOURSE PLAN		X	X	X				
33	AATA412.0	AUDIOVISUAL - ADD ALTERNATE ELECTRICAL CONCOURSE RCP		X	X	X				
34	TA08.01	AUDIOVISUAL - STUDIO CLASSROOM B AV SYSTEMS BLOCK DIAGRAMS					X			
35	TA08.02	AUDIOVISUAL - CRIT ROOM AV SYSTEMS BLOCK DIAGRAMS					X			
36	TA8.03	AUDIOVISUAL - FABRICATION LAB AV SYSTEMS BLOCK DIAGRAMS					X			
37	TA8.04	AUDIOVISUAL - SMART CLASSROOM AV SYSTEMS BLOCK DIAGRAMS					X			
38	TA8.05	AUDIOVISUAL - COMPUTER LAB AV SYSTEMS BLOCK DIAGRAMS					X			
39	TA8.06	AUDIOVISUAL - SOUND STAGE AV SYSTEMS BLOCK DIAGRAMS					X			
40	TA8.07	AUDIOVISUAL - DIGITAL SIGNAGE AV SYSTEMS BLOCK DIAGRAMS					X			
41	TA8.08	AUDIOVISUAL - PERFORMANCE THEATER AV SYSTEMS BLOCK DIAGRAMS					X			
42	TA8.09	AUDIOVISUAL - PERFORMANCE THEATER AV SYSTEMS BLOCK DIAGRAMS					X			
43	TA8.10	AUDIOVISUAL - PERFORMANCE THEATER AV SYSTEMS BLOCK DIAGRAMS					X			
44	TA08.12	AUDIOVISUAL - ENTRY PAVILION AV SYSTEMS BLOCK DIAGRAMS					X			
45	TA08.13	AUDIOVISUAL - ENTRY PAVILION AV SYSTEMS BLOCK DIAGRAMS					X			

ESTIMATED SIZE HVAC LOADS						
1. THE NORMAL HVAC PROVISIONS FOR THE CONFERENCE ROOMS SHOULD BE SUFFICIENT TO HANDLE ANY ADDITIONAL HEAT LOAD PRESENTED BY THE AUDIOVISUAL SYSTEM COMPONENTS WITHIN THE CONFERENCE ROOMS - EXCEPT SPECIFIC AREA AS NOTED IN THE CHART BELOW.						
2. A THERMOSTAT WITHIN EACH CONFERENCE ROOM IS RECOMMENDED TO PROPERLY MAINTAIN ROOM TEMPERATURE.						
3. ROOM TEMPERATURE MUST NOT EXCEED 80 DEGREES FAHRENHEIT DURING CONFERENCING TO PREVENT AUTOMATIC SHUTDOWN OF SOME ESSENTIAL EQUIPMENT.						
4. RATING ESTIMATES FOR EQUIPMENT OTHER THAN AUDIO AMPLIFIERS ARE BASED ON THE AV COMPONENTS' PUBLISHED MAXIMUM POWER CONSUMPTION ("PHASE VALUE") AND THE FOLLOWING FORMULA: WATTS X 3.41 X 75% = BTU/HR						
5. RATING ESTIMATES FOR AUDIO AMPLIFIERS ARE BASED ON THE AV COMPONENTS' PUBLISHED BTU/HR AT 1/8TH POWER						
6. IN THE CASE WHERE AUDIOVISUAL EQUIPMENT CABINETS ARE LOCATED IN CLOSETS, CABINETS, OR FURNITURE, ADEQUATE VENTILATION MUST BE PROVIDED TO ALLOW FRESH AIR EXCHANGE WITHIN THE ENCLOSURE.						
POWER LOAD ESTIMATE (W)			HEAT LOAD ESTIMATE (BTU/hr)			
NON-TYPICAL ROOMS			ROOM OPEN AIR	ROOM CREDENZA	AV CLOSET	ROOM OPEN AIR
PERFORMANCE THEATER "E" AMP ROOM 141					10500	
PERFORMANCE THEATER "E" CONTROL ROOM			2200			7500
PERFORMANCE STUDIO CONTROL ROOM 342			2200			7500
PERFORMANCE STUDIO AMP ROOM				8000		27300
STUDIO CLASSROOM "B"			1320	4500		3375
TYPICAL AREAS			ROOM OPEN AIR	ROOM CREDENZA	AV CLOSET	ROOM OPEN AIR
CLASSROOMS			950			2500
LOBBY			5700	1200		14500
						3000

CABLE TYPES SCHEDULE						
1. THESE CABLE TYPES ARE CITED TO ILLUSTRATE THE MINIMUM CABLE PERFORMANCE REQUIREMENTS. UNLESS OTHERWISE NOTED, CABLES FROM OTHER MANUFACTURERS (I.E. WEST PENN, COMM SCOPE, LIBERTY CABLE, ETC.) WILL BE CONSIDERED ACCEPTABLE IF DATA SHEETS ARE SUBMITTED PRIOR TO INSTALLATION AND APPROVED BY AV CONSULTANT AND COLLEGE CTS.						
2. THE USE OF PLENUM RATED CABLING IS REQUIRED FOR ALL AV CABLING RUN OUTSIDE OF METAL CONDUIT.						
3. THE CONTRACTOR SHALL ONLY USE PLUGS AND JACKS SPECIFICALLY MANUFACTURED AND DESIGNED FOR THE CABLE USED. UNLESS OTHERWISE NOTED, THIRD-CONNECTORS FROM MANUFACTURERS OTHER THAN THE CABLE MANUFACTURER, I.E. KINGS, SWITCHCRAFT, AMP, AMPHENOL, LEMO, NEUTRIK, ETC. WILL BE CONSIDERED ACCEPTABLE IF DATA SHEETS ARE SUBMITTED PRIOR TO INSTALLATION.						
CABLE TYPE	DESCRIPTION	MANUFACTURER	NON-PLENUM		PLENUM	
			MODEL	O.D.	MODEL	O.D.
AUDIO						
AUDIO (MICROPHONE & LINE LEVEL)	(1) PAIR 22 AWG TWISTED PAIR	BELDEN	9451	0.135"	9451P	0.127"
AUDIO (DIGITAL)	(1) PAIR 24 AWG (110 OHM) TWISTED PAIR	BELDEN	1800F	0.211"	1801B	0.165"
AUDIO (SPEAKER LEVEL, 70V)	2 CONDUCTOR 18 AWG STRANDED	BELDEN	5300UP	0.184"	82740	0.143"
AUDIO (SPEAKER LEVEL, SPEECH)	2 CONDUCTOR 16 AWG STRANDED	BELDEN	5200UP	0.208"	6200UE	0.176"
AUDIO (SPEAKER LEVEL, PROGRAM)	2 CONDUCTOR 14 AWG STRANDED	BELDEN	5100UP	0.260"	6100UE	0.218"
AUDIO (SPEAKER LEVEL, PERFORMANCE)	2 CONDUCTOR 12 AWG STRANDED	BELDEN	5000UP	0.302"	6000UE	0.252"
AUDIO (SPEAKER LEVEL, HIGH WATTAGE)	2 CONDUCTOR 10 AWG STRANDED	BELDEN	5T00UP	0.356"	6T00UP	0.308"
VIDEO						
RGBHV (COMPUTER VIDEO, INTRARACK ONLY)	(5) 26 AWG MINI COAX	EXTRON	MHR-5	0.357"	MHR-5P	0.304"
RGBHV (COMPUTER VIDEO)	(5) RG-59/U 20 AWG 75 OHM COAX	WEST PENN	WP8195	0.720"	WP258195	0.595"
VIDEO (UTP NON-CATEGORY)	(4) PAIR 24 AWG LOW-SKEW TWISTED PAIR	BELDEN	7987R	0.195"	7987P	0.201"
VIDEO (UTP CATEGORY)	REFER TO IT PROJECT STANDARDS					
VIDEO (ANALOG COMPONENT VIDEO)	RG-59/U 20 AWG 75 OHM COAX	BELDEN	8281	0.305"	88281	0.271"
VIDEO (DIGITAL VIDEO)	RG-59/U 20 AWG 75 OHM COAX	BELDEN	1505A	0.233"	1506A	0.196"
RF / CATV / ALS / WIRELESS ANT COAX						
RF (HARDLINE)	HARDLINE (75 OHM)	COMMSCOPE	P3-500 SERIES JCAR			
RF (COAX <150')	RG-6/U (75 OHM)	BELDEN	9118	0.275"	1152A	0.275"
RF (COAX <250')	RG-11/U (75 OHM)	BELDEN	9064	0.400"	1153A	0.387"
RF (COAX TRIAX)	RG-11/U (75 OHM)	BELDEN	1858A	0.520"	1859A	0.406"
RF (WIRELESS ANTENNA)	RG-8/U (50 OHM)	BELDEN	9913F7	0.405"	89913	0.364"
RF (MICROWAVE ANTENNA; RISER-RATED)	HELIX (50 OHM)	ANDREW	LDF4-50A	0.63"	-	-
CONTROL						
CONTROL (SERIAL APPLICATIONS)	(2) PAIR 22 AWG TWISTED PAIR	BELDEN	8723	0.160"	88723	0.148"
CONTROL (TOUCH/CONTROL SYSTEM APPLICATIONS)	(1) PAIR 22 AWG TWISTED PAIR &	BELDEN	1502R	0.250"	1502P	0.205"
	(1) PAIR 18 AWG					
CONTROL (NETWORK)	REFER TO IT PROJECT STANDARDS (Belden 7852A)					
FIBER						
MULTIMODE (HORIZONTAL)	(2) 62.5µM (FIBER COUNT MAY CHANGE)	COMMSCOPE	N-002-DS-6F-FSUOR	0.15"	P-002-DS-6F-FSUOR	0.15"
MULTIMODE (RISER)	(2) 62.5µM (FIBER COUNT MAY CHANGE)				R-002-DS-6F-FSU/L	0.15"
SINGLEMODE (HORIZONTAL)	(2) 250µM (FIBER COUNT MAY CHANGE)				P-002-DS-8W-FSU/L	0.15"
SINGLEMODE (RISER)	(2) 250µM (FIBER COUNT MAY CHANGE)				R-002-DS-8W-FSU/L	0.15"
SMPT6 304M CAMERA	(4) 20AWG COPPER, (2) 24AWG COPPER, (2) SINGLE MODE FIBER	MOHAWK	96040	0.362"	96920	0.294

FACILITY KEYNOTE LEGEND	
	EQUIPMENT RACKS: 1 - 1 Full Height
	CONNECTIVITY: 2 - 1 Floor Box 2 - 2 Wall Plate 2 - 3 Access Point at Ceiling Pipe Grid
	CONTROL/SCHEDULING: 3 - 1 Wall Mounted Controller 3 - 2 Volume Controller 3 - 3 Raise Lower Switch
	AUDIO INPUT: 4 - 1 Wireless Microphone Antenna
	AUDIO OUTPUT: 5 - 1 Ceiling Recessed Loudspeaker 5 - 2 Portable speaker Mounted on Pipe Grid 5-2A Portable Speaker Mounted on Catwalk 5 - 3 Portable Subwoofer Loudspeaker Mounted on Pipe Grid 5 - 4 Assistive Listening Emitter/Antenna 5 - 5 Ceiling Hanging Pendant Speaker
	VIDEO ORIGIN/SOURCE: 6 - 1 LOW LIGHT VIDEO CAMERA
	VIDEO DISPLAY (Type 1): 7 - 1 (170") Wall Mounted Flat Panel Display 7 - 2 (55") Wall Mounted Flat Panel Display 7 - 3 (55") Wall Mounted Digital Signage Display 7 - 4 (46") Wall Mounted Flat Panel Display
	VIDEO DISPLAY (Type 2): 8 - 1 Video Projector, Pole Mounted 8 - 2 Video Projector, Fixed at Projection Booth 8 - 3 Video Projector, OFE
	VIDEO DISPLAY (Type 3): 9 - 1 (50"x80"W) Ceiling Recessed Front Projection Screen 9 - 1A (50"x80"W) Wall Mounted Front Projection Screen 9 - 2 (144"x289"W) Ceiling Mounted Suspended Front Projection Screen. See TV and TR drawings for exact rigging details and locations. 9 - 3 120" x 213" Ceiling Recessed Front Projection Screen 9 - 4 (65" X 116) Ceiling Recessed Front Projection Screen 9 - 5 Painted projection surface 9 - 6 57.5" x 92" Ceiling Recessed Front Projection Screens 9 - 7 108" x 192" Ceiling Mounted Suspended Front Projection Screen. See TV and TR drawings for exact rigging details and locations.
	MISCELLANEOUS: 10 - 1 Theatrical Intercom
NOTE: EQUIPMENT SHOWN IN THIS SERIES IS FOR REFERENCE AND COORDINATION ONLY AND WILL BE FURNISHED BY THE OWNER. REFER TO GENERAL SPEC SECTION 011110 AND AUDIOVISUAL SPEC SECTION 274000	

AUDIOVISUAL ELECTRICAL LEGEND

SYMBOL	DESCRIPTION
	MULTI-DISCIPLINE FLOOR BOX OR POKE-THRU, WITH HINGED COVER PLATE AND CARPET FLANGE, WITH DIVIDED COMPARTMENTS FOR SHARED ACCESS WITH VOICE, DATA AND 120VAC POWER. FLUSH MOUNT IN FLOOR UNLESS OTHERWISE INDICATED. (4" DEEP MINIMUM) UNLESS OTHERWISE INDICATED. SEE AUDIOVISUAL DETAIL SHEETS.
	SCREW COVER JUNCTION BOX FOR AUDIOVISUAL CONDUIT TERMINATION; SIZED ACCORDINGLY. ALL CONDUITS TERMINATE AT THIS BOX UNLESS OTHERWISE INDICATED.
	MULTI-DISCIPLINE IN-WALL BOX, WITH DIVIDED COMPARTMENTS FOR SHARED ACCESS WITH VOICE, DATA AND 120VAC POWER. MOUNT FLUSH WITH FINISHED WALL TREATMENT, BEHIND DISPLAY, UNLESS OTHERWISE INDICATED. SEE AUDIOVISUAL DETAIL SHEETS.
	GANGABLE WALL BOX, 4-11/16" HIGH X 2-1/2" DEEP, FOR AUDIO/VIDEO RECEPTACLES. MOUNT FLUSH WITH FINISHED WALL TREATMENT, AT BASE BUILDING ELECTRICAL SWITCH HEIGHT UNLESS OTHERWISE INDICATED. SUBNUMBER INDICATE GANG #
	WALL BOX, HEIGHT AND WIDTH AS SPECIFIED, FOR AUDIO/VIDEO RECEPTACLES. MOUNT FLUSH WITH FINISHED WALL TREATMENT, AT BASE BUILDING ELECTRICAL SWITCH HEIGHT UNLESS OTHERWISE INDICATED.
	GANGABLE WALL BOX, 4-11/16" HIGH X 2-1/2" DEEP, FOR INTERCOM RECEPTACLES. MOUNT FLUSH WITH FINISHED WALL TREATMENT, AT BASE BUILDING ELECTRICAL SWITCH HEIGHT UNLESS OTHERWISE INDICATED. SUBNUMBER INDICATES GANG #
	GANGABLE WALL BOX, 4-11/16" HIGH X 2-1/2" DEEP, FOR WALL MOUNTED VOLUME CONTROLLER. MOUNT FLUSH WITH FINISHED WALL TREATMENT; COORDINATE HEIGHT WITH ARCHITECTURAL AND ADA REQUIREMENTS. SUBNUMBER INDICATES GANG #
	BACK BOX FOR WALL-MOUNTED AUDIOVISUAL CONTROL SYSTEM TOUCH PANEL. BACK BOX TO BE OEM BY MANUFACTURER, REFERENCED TO MODEL NUMBER. MOUNT FLUSH WITH FINISHED WALL TREATMENT. COORDINATE HEIGHT WITH ARCHITECTURAL AND ADA REQUIREMENTS.
	SINGLE-GANG WALL BOX, 4-11/16" HIGH X 2-1/2" DEEP, FOR MICROPHONE ANTENNA OR ASSISTIVE LISTENING ANTENNA. MOUNT FLUSH WITH FINISHED WALL TREATMENT, AT SPECIFIED HEIGHT. SUBNUMBER INDICATES GANG #
	SINGLE-GANG WALL BOX, 4-11/16" HIGH X 2-1/2" DEEP, WITH 1-1/4" CONDUIT KNOCKOUTS AND BLANK COVER PLATE, FOR PIPE MOUNTED SPEAKER OR SUBWOOFER. MOUNT ON PIPE GRID.
	WALL SWITCH FOR PROJECTION SCREEN, RAISE/STOP/LOWER, SUPPLIED WITH SCREEN. MOUNT FLUSH WITH FINISHED WALL TREATMENT, AT BASE BUILDING ELECTRICAL SWITCH HEIGHT UNLESS OTHERWISE INDICATED.
	POWER RECEPTACLE, DUPLEX, 120 VAC, 20 AMP, HOSPITAL GRADE ORANGE. MOUNT AT BASE BUILDING OUTLET HEIGHT, UNLESS OTHERWISE INDICATED.
	WALL-MOUNTED TELECOM VOICE/DATA OUTLET BOX; QUANTITY AND TYPE OF CABLING AS PER PROJECT STANDARDS. UNLESS OTHERWISE NOTED, REFER TO THE ARCHITECTURAL DRAWINGS FOR DIMENSIONED LOCATION; MOUNT AT BASE BUILDING OUTLET HEIGHT, UNLESS OTHERWISE INDICATED.
	GANGABLE WALL BOX, 4-11/16" HIGH X 2-1/2" DEEP, WITH 1-1/4" CONDUIT KNOCKOUTS AND BLANK COVER PLATE, FOR AUDIOVISUAL CONNECTIVITY. MOUNT FLUSH WITH FINISHED CEILING TREATMENT. SUBNUMBER INDICATES NUMBER OF GANG.
	CEILING LOUDSPEAKER BACK BOX, GRILLE AND TILE BRIDGE. MOUNT FLUSH WITH FINISHED CEILING, AS SHOWN ON THE ARCHITECTURAL CEILING PLANS. UNLESS OTHERWISE INDICATED. CONFIRM THE INTEGRITY OF THE CEILING GRID SYSTEM WITH THE STRUCTURAL ENGINEER.
	PROJECTION SCREEN, PROJECTOR LIFT OR SHADE WITH LOW-VOLTAGE INTERFACE, SUPPLIED WITH DEVICE. MOUNT ABOVE FINISHED CEILING UNLESS OTHERWISE INDICATED. MAINTENANCE ACCESS TO BOX SHALL BE PROVIDED IN NON-ACCESSIBLE CEILINGS. PROVIDE UTILITY-GRADE 120VAC UNLESS OTHERWISE INDICATED.
	POWER RECEPTACLE, DUPLEX, 120 VAC, 20 AMP, HOSPITAL GRADE ORANGE, SEPARATE CIRCUIT. MOUNT FLUSH WITH FINISHED CEILING UNLESS OTHERWISE INDICATED.
	CEILING MOUNTED TELECOM DATA OUTLET BOX; QUANTITY AND TYPE OF CABLING AS PER PROJECT STANDARDS, UNLESS OTHERWISE INDICATED. REFER TO THE ARCHITECTURAL DRAWINGS FOR DIMENSIONED LOCATION.

AUDIOVISUAL ELECTRICAL NOTES


- POWER AND DATA ON THE AV DRAWINGS ARE FOR REFERENCE ONLY. PLEASE REFER TO ALL ELECTRICAL AND LOW VOLTAGE DRAWINGS FOR EXACT QUANTITIES AND LOCATIONS ASSOCIATED AV CONDUIT AND BOXES ON THE AV DRAWINGS ARE FOR DESIGN AND CONSTRUCTION ISSUE.
- WHERE EXACT DIMENSIONS ARE NOT CALLED FOR, THE SCALE OF THIS DRAWING IS SUFFICIENTLY ACCURATE FOR DETERMINING ROUGH LOCATION OF EQUIPMENT, JUNCTION BOXES, OUTLET BOXES, WIREWAYS, PANELS, ETC. WHERE EXACT DIMENSIONS ARE CALLED FOR, THE REFERENCE SURFACE SHALL BE THE FINAL FINISHED SURFACE INCLUDING ANY ACOUSTICAL TREATMENT. ROOM DIMENSIONS ON THIS DRAWING HAVE BEEN TAKEN FROM PRELIMINARY ARCHITECTURAL DRAWINGS.
- POWER CONDUIT, POWER WIREWAYS AND POWER JUNCTION BOXES ARE TO BE REVIEWED BY THE ELECTRICAL ENGINEER FOR CODE COMPLIANCE.
- EMPTY CONDUITS RUNS ON THIS DRAWING SHOW ONLY INTERCONNECTION BETWEEN THE TERMINATION POINTS. THE EXACT PATH OF CONDUIT ARE TO BE DETERMINED BY FIELD CONDITIONS.
- ALL EMPTY CONDUIT ON THIS DRAWING TO BE 1" UNLESS OTHERWISE NOTED. ALL EMPTY CONDUIT SHALL BE DEBURRED, CLEANED, CAPPED, TAGGED AND FURNISHED WITH PULL WIRES.
- THERE SHALL BE A MINIMUM OF ONE PULL BOX FOR EVERY 100 FEET OF STRAIGHT EMPTY CONDUIT AND A PULL BOX FOR MORE THAN TWO 90° BENDS IN A CONDUIT RUN.
- POWER BREAKER PANELS SHOWN ON THIS DRAWING ARE DEDICATED TO SPECIFIC AUDIOVISUAL AND TELEVISION EQUIPMENT. REFER TO ELECTRICAL DRAWINGS FOR ADDITIONAL UTILITY POWER RECEPTACLES.
- POWER BREAKER PANELS ARE SIZED AND SPECIFIED BY THE ELECTRICAL ENGINEER. REFER TO ELECTRICAL DRAWINGS. ALL CIRCUITS SHALL BE PROTECTED BY 120VAC, 20 AMP BREAKERS UNLESS OTHERWISE DETEALD.
- WHERE POWER CIRCUITS ARE SHOWN TERMINATING IN JUNCTION BOXES WITHOUT RECEPTACLES, THE WIRES SHALL BE TAPED AND THE BOXES COVERED. THESE CIRCUITS WILL BE CONNECTED BY OTHERS DURING INSTALLATION OF THE AUDIOVISUAL SYSTEMS EQUIPMENT.
- THE METHOD OF INSTALLATION OF BOXES IN WALLS, AND THE METHOD OF PASSAGE OF CONDUITS AND WIREWAYS THROUGH ACOUSTICALLY SENSITIVE WALLS SHALL BE COORDINATED WITH THE ACOUSTICAL CONSULTANT.

MATERIAL KEYING LEGEND:

KEY PLAN

5	GROUP III AV BID DOCUMENTS	08.06.2017
2	BID DOCUMENTS	5.28.2014
1	DESIGN MANUAL PHASE SUBMISSION	4.01.2013

NO.	REVISIONS / SUBMISSIONS
-----	-------------------------

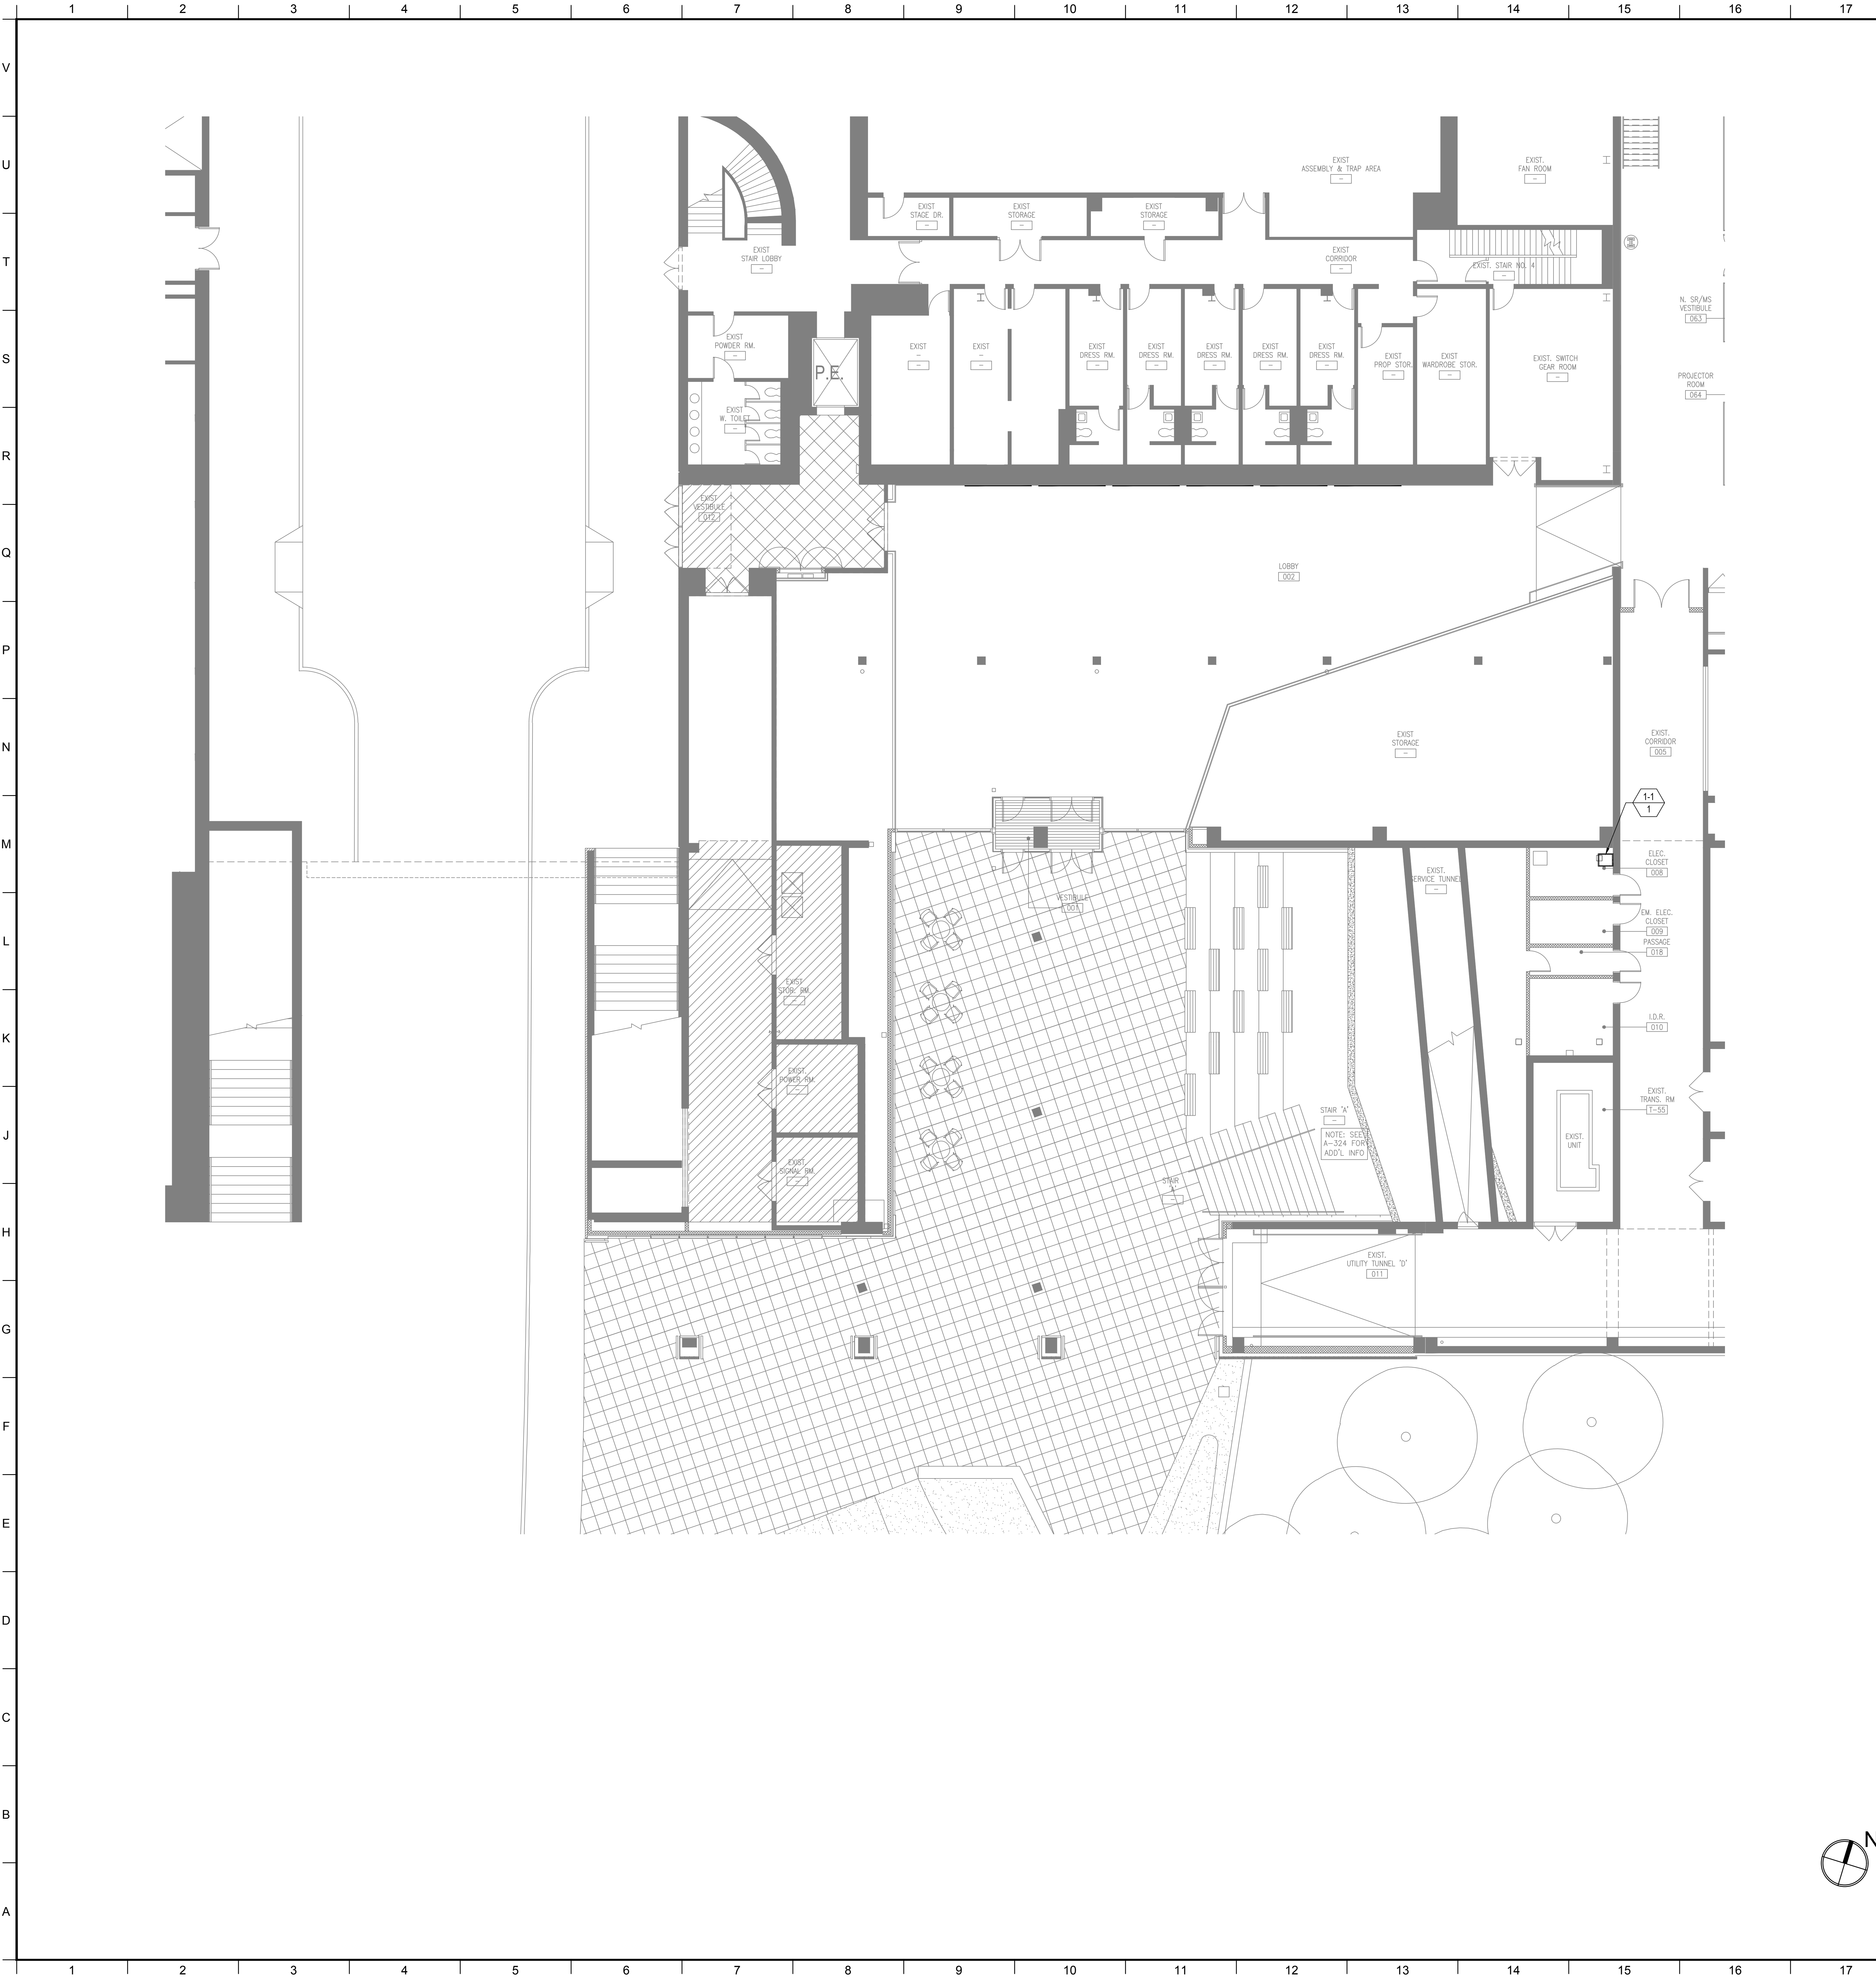

FACILITY KEYNOTE LEGEND	
	EQUIPMENT RACKS: 1-1 Full Height
	CONNECTIVITY: 2-1 Floor Box 2-2 Wall Plate 2-3 Access Point at Ceiling Pipe Grid
	CONTROL/SCHEDULING: 3-1 Wall Mounted Controller 3-2 Volume Controller 3-3 Raise Lower Switch
	AUDIO INPUT: 4-1 Wireless Microphone Antenna
	AUDIO OUTPUT: 5-1 Ceiling Recessed Loudspeaker 5-2 Portable speaker Mounted on Pipe Grid 5-2A Portable Speaker Mounted on Catwalk 5-3 Portable Subwoofer Loudspeaker Mounted on Pipe Grid 5-4 Assistive Listening Emitter/Antenna 5-5 Ceiling Hanging Pendant Speaker
	VIDEO ORIGIN/SOURCE: 6-1 LOW LIGHT VIDEO CAMERA
	VIDEO DISPLAY (Type 1): 7-1 (70") Wall Mounted Flat Panel Display 7-2 (65") Wall Mounted Flat Panel Display 7-3 (65") Wall Mounted Digital Signage Display 7-4 (46") Wall Mounted Flat Panel Display
	VIDEO DISPLAY (Type 2): 8-1 Video Projector, Pole Mounted 8-2 Video Projector, Fixed at Projection Booth 8-3 Video Projector, OFE
	VIDEO DISPLAY (Type 3): 9-1 (50"x80"W) Ceiling Recessed Front Projection Screen 9-1A (50"x80"W) Wall Mounted Front Projection Screen 9-2 (144"x256"W) Ceiling Mounted Suspended Front Projection Screen. See TV and TR drawings for exact rigging details and locations. 9-3 120" x 213" Ceiling Recessed Front Projection Screen 9-4 (65" X 116) Ceiling Recessed Front Projection Screen 9-5 Painted projection surface 9-6 57.5" x 92" Ceiling Recessed Front Projection Screens 9-7 108" x 192" Ceiling Mounted Suspended Front Projection Screen. See TV and TR drawings for exact rigging details and locations.
	MISCELLANEOUS: 10-1 Theatrical Intercom
NOTE: EQUIPMENT SHOWN IN THIS SERIES IS FOR REFERENCE AND COORDINATION ONLY AND WILL BE FURNISHED BY THE OWNER. REFER TO GENERAL SPEC SECTION 011110 AND AUDIOVISUAL SPEC SECTION 274000	

MATERIAL KEYING LEGEND:

KEY PLAN

5 GROUP III AV BID DOCUMENTS 09.06.2017

2 BID DOCUMENTS 05.28.2014

1 DESIGN MANUAL PHASE SUBMISSION 04.01.2013

NO.	REVISIONS / SUBMISSIONS	DATE
-----	-------------------------	------

FX FOWLE

FX FOWLE ARCHITECTS, LLP | 22 WEST 10TH STREET | NEW YORK, NY 10011 | T 212.427.1700 | F 212.453.8716 | WWW.FX FOWLE.COM

ARCHITECTURAL ENGINEER:
DESIMONE CONSULTING ENGINEERS
18 West 18th Street, 10th Floor, New York, New York 10011 212-532-2211

MECHANICAL, ELECTRICAL, PLUMBING, FIRE PROTECTION ENGINEER:
COLLADO ENGINEERING
2 Holmdel Avenue, White Plains, NY 10603 914-332-7658

THEATER PLANNING CONSULTANT:
FISHER DACHS ASSOCIATES
22 West 10th Street, 8th Floor, New York, NY 10011 212-691-3020

ACQUISITION & AUDIO VISUAL CONSULTANT:
CERAMI & ASSOCIATES
404 Fifth Avenue, New York, NY 10018 212-370-1776

LIGHTING CONSULTANT:
ILLUMINATION ARTS
605 Bloomfield Avenue, Suite 101, Bloomfield NJ 07003 973-771-1558

LANDSCAPE CONSULTANT:
W ARCHITECTURE & LANDSCAPE ARCHITECTURE, LLC
105 Fifth Avenue, Third Floor New York, NY 10010 P 212-951-3533 / F 212-620-0798

CIVIL ENGINEER & LANDSCAPE ARCHITECT:
LANGAN
21 Penn Plaza 360 West 31st Street 8th Floor New York, NY 10001 212-479-5400 212-479-5444 (fax)

ELEVATOR CONSULTANT:
VDA (VAN DEUSEN & ASSOCIATES)
Seven Penn Plaza, Suite 404 New York, NY 10001 Phone: 212-808-9090 Fax: 212-808-9099

IT CONSULTANT:
GRID ASSOCIATES, LLC
P.O. Box 1770 Hoboken, NJ 07030 T 946.722.6600 / F 946.722.6625

SUSTAINABILITY LEAD:
YR&G
161 Bowery - 4th Floor, New York, NY 10002 T 917.677.8023 / F 917.677.8023

GUEST ESTIMATING CONSULTANT:
TOSCANO CLEMENTS TAYLOR, LLC
16 Oakwood Road Huntington, NY 11743 T 631.392.1400 / F 631.392.1399

C.I.T.L. PROJ. # 29402
SUNY PURCHASE COLLEGE
735 ANDERSON HILL ROAD | PURCHASE, NY 10577

DRAWING TITLE:
AUDIOVISUAL-FACILITY - ENTRY PAVILION
CONCOURSE (BASEMENT LEVEL) PLAN

Seal:	Drawn:	Project No.:
	AJC	29402 (SUCF) / 09018.L00 (FXF)
	Checked:	Cal File:
	BJM	
	Reviewed:	Drawing No.:
	BJM	
	Date:	



Scale:
1/8" = 1'-0"

TA-102.0

© 2009 FX FOWLE ARCHITECTS, LLP | ALL RIGHTS RESERVED

V
U
T
S
R
Q
P
N
M
L
K
J
H
G
F
E
D
C
B
A

1 2 3 4 5 6 7 8 9 10 11 12 13 14 15 16 17 18 19 20

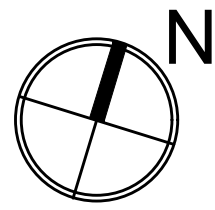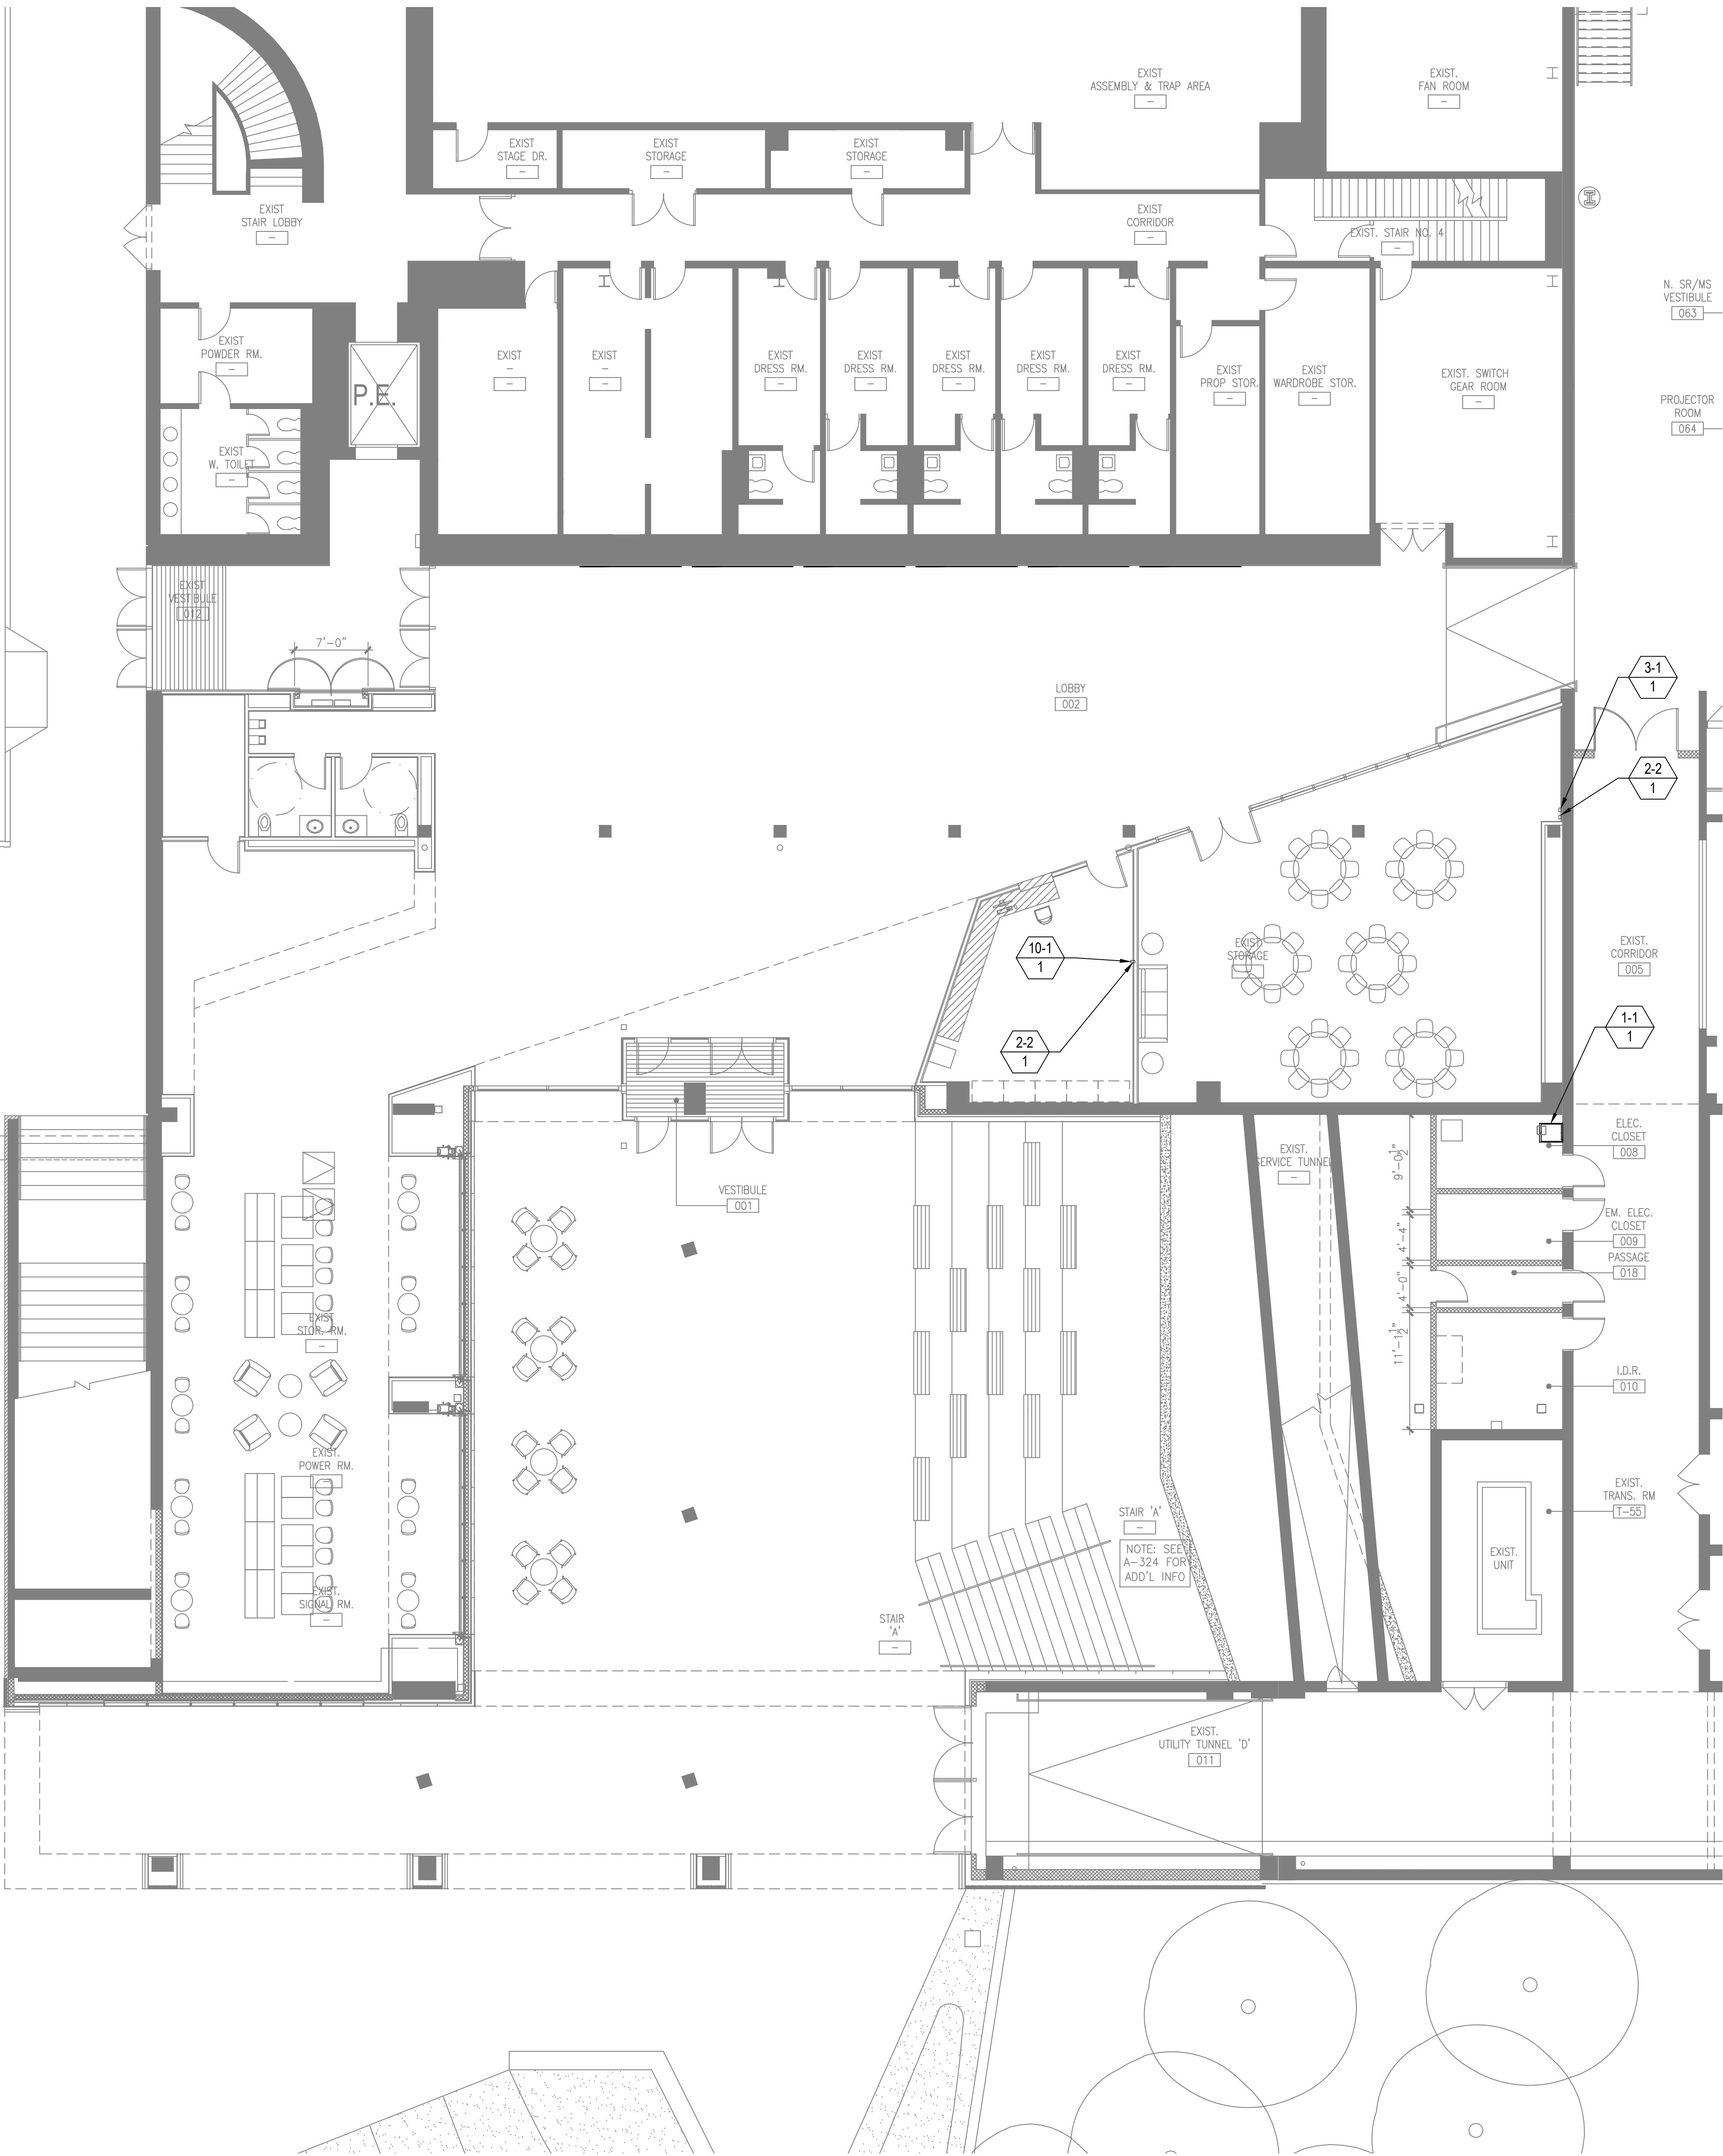

FACILITY KEYNOTE LEGEND	
	EQUIPMENT RACKS: 1-1 Full Height
	CONNECTIVITY: 2-1 Floor Box 2-2 Wall Plate 2-3 Access Point at Ceiling Pipe Grid
	CONTROL/SCHEDULING: 3-1 Wall Mounted Controller 3-2 Volume Controller 3-3 Raise Lower Switch
	AUDIO INPUT: 4-1 Wireless Microphone Antenna
	AUDIO OUTPUT: 5-1 Ceiling Recessed Loudspeaker 5-2 Portable speaker Mounted on Pipe Grid 5-2A Portable Speaker Mounted on Catwalk 5-3 Portable Subwoofer Loudspeaker Mounted on Pipe Grid 5-4 Assistive Listening Emitter/Antenna 5-5 Ceiling Hanging Pendant Speaker
	VIDEO ORIGIN/SOURCE: 6-1 LOW LIGHT VIDEO CAMERA
	VIDEO DISPLAY (Type 1): 7-1 (70") Wall Mounted Flat Panel Display 7-2 (55") Wall Mounted Flat Panel Display 7-3 (55") Wall Mounted Digital Signage Display 7-4 (46") Wall Mounted Flat Panel Display
	VIDEO DISPLAY (Type 2): 8-1 Video Projector; Pole Mounted 8-2 Video Projector; Fixed at Projection Booth 8-3 Video Projector; OFE
	VIDEO DISPLAY (Type 3): 9-1 (50"x80"W) Ceiling Recessed Front Projection Screen 9-1A (50"x80"W) Wall Mounted Front Projection Screen 9-2 (144"x256"W) Ceiling Mounted Suspended Front Projection Screen. See TV and TR drawings for exact rigging details and locations. 9-3 120" x 213" Ceiling Recessed Front Projection Screen 9-4 (65" X 116) Ceiling Recessed Front Projection Screen 9-5 Painted projection surface 9-6 57.5" x 92" Ceiling Recessed Front Projection Screens 9-7 108" x 192" Ceiling Mounted Suspended Front Projection Screen. See TV and TR drawings for exact rigging details and locations.

MATERIAL KEYING LEGEND:


KEY PLAN

5	GROUP III AV BID DOCUMENTS	09.06.2017
2	DESIGN MANUAL PHASE SUBMISSION	04.01.2013
1	30% PRICING SET	03.07.2013
NO.	REVISIONS / SUBMISSIONS	DATE
FX FOWLE		
FX FOWLE ARCHITECTS, LLP 22 WEST 10TH STREET NEW YORK, NY 10011 T 212.627.1700 F 212.453.8716 WWW.FX FOWLE.COM		
2D/3D CAD ENGINEERS: DESMONE CONSULTING ENGINEERS 18 West 18th Street, 10th Floor, New York, New York 10011 212-532-2211		
MECHANICAL, ELECTRICAL, PLUMBING, FIRE PROTECTION ENGINEER: COLLADO ENGINEERING 2 Holland Avenue, White Plains, NY 10603 914-332-7656		
THEATER PLANNING CONSULTANT: FISHER DACHS ASSOCIATES 22 West 10th Street, 8th Floor, New York, NY 10011 212-691-3020		
ACoustics & AUDIO VISUAL CONSULTANT: CERAM & ASSOCIATES 404 Fifth Avenue, New York, NY 10018 212-370-1776		
LIGHTING CONSULTANT: ILLUMINATION ARTS 605 Bloomfield Avenue, Suite 101, Bloomfield NJ 07003 973-771-1556		
LANDSCAPE CONSULTANT: W ARCHITECTURE & LANDSCAPE ARCHITECTURE, LLC 105 Fifth Avenue, Third Floor New York, NY 10010 P 212-951-3533 F 212-623-0758		
CIVIL ENGINEER & LANDSCAPE ARCHITECT: LANGAN 21 Penn Plaza 360 West 31st Street 8th Floor New York, NY 10001 212-479-5400 212-479-5444 (fax)		
ELEVATOR CONSULTANT: VDA (VAN DEUSEN & ASSOCIATES) Seven Penn Plaza, Suite 404 New York, NY 10001 Phone: 212-808-9090 Fax: 212-808-9099		
IT CONSULTANT: GRID ASSOCIATES, LLC P.O. Box 1770 Hoboken, NJ 07030 T 946.722.6600 / F 946.722.6625		
SUSTAINABILITY LEED: YR&G 161 Bowery - 4th Floor, New York, NY 10002 T 917.677.8023 / F 917.677.8023		
GUEST ESTIMATING CONSULTANT: TOSCANO CLEMENTS TAYLOR, LLC 16 Oakwood Road Huntington, NY 11743 T 631.392.1400 / F 631.392.1399		
C.I.T.L. PROJ. # 29402 SUNY PURCHASE COLLEGE 735 ANDERSON HILL ROAD PURCHASE, NY 10577		

DRAWING TITLE:
AUDIOVISUAL-FACILITY - ENTRY PAVILION
CONCOURSE (BASEMENT LEVEL) PLAN

Seal:	Drawn: AJC	Project No.: 29402 (SUCF) / 05018.L00 (FXF)
	Checked: BJM	Cad File:
	Reviewed: BJM	Drawing No.:
	Date:	
	Scale: 1/8" = 1'-0"	

TA102.0_AA

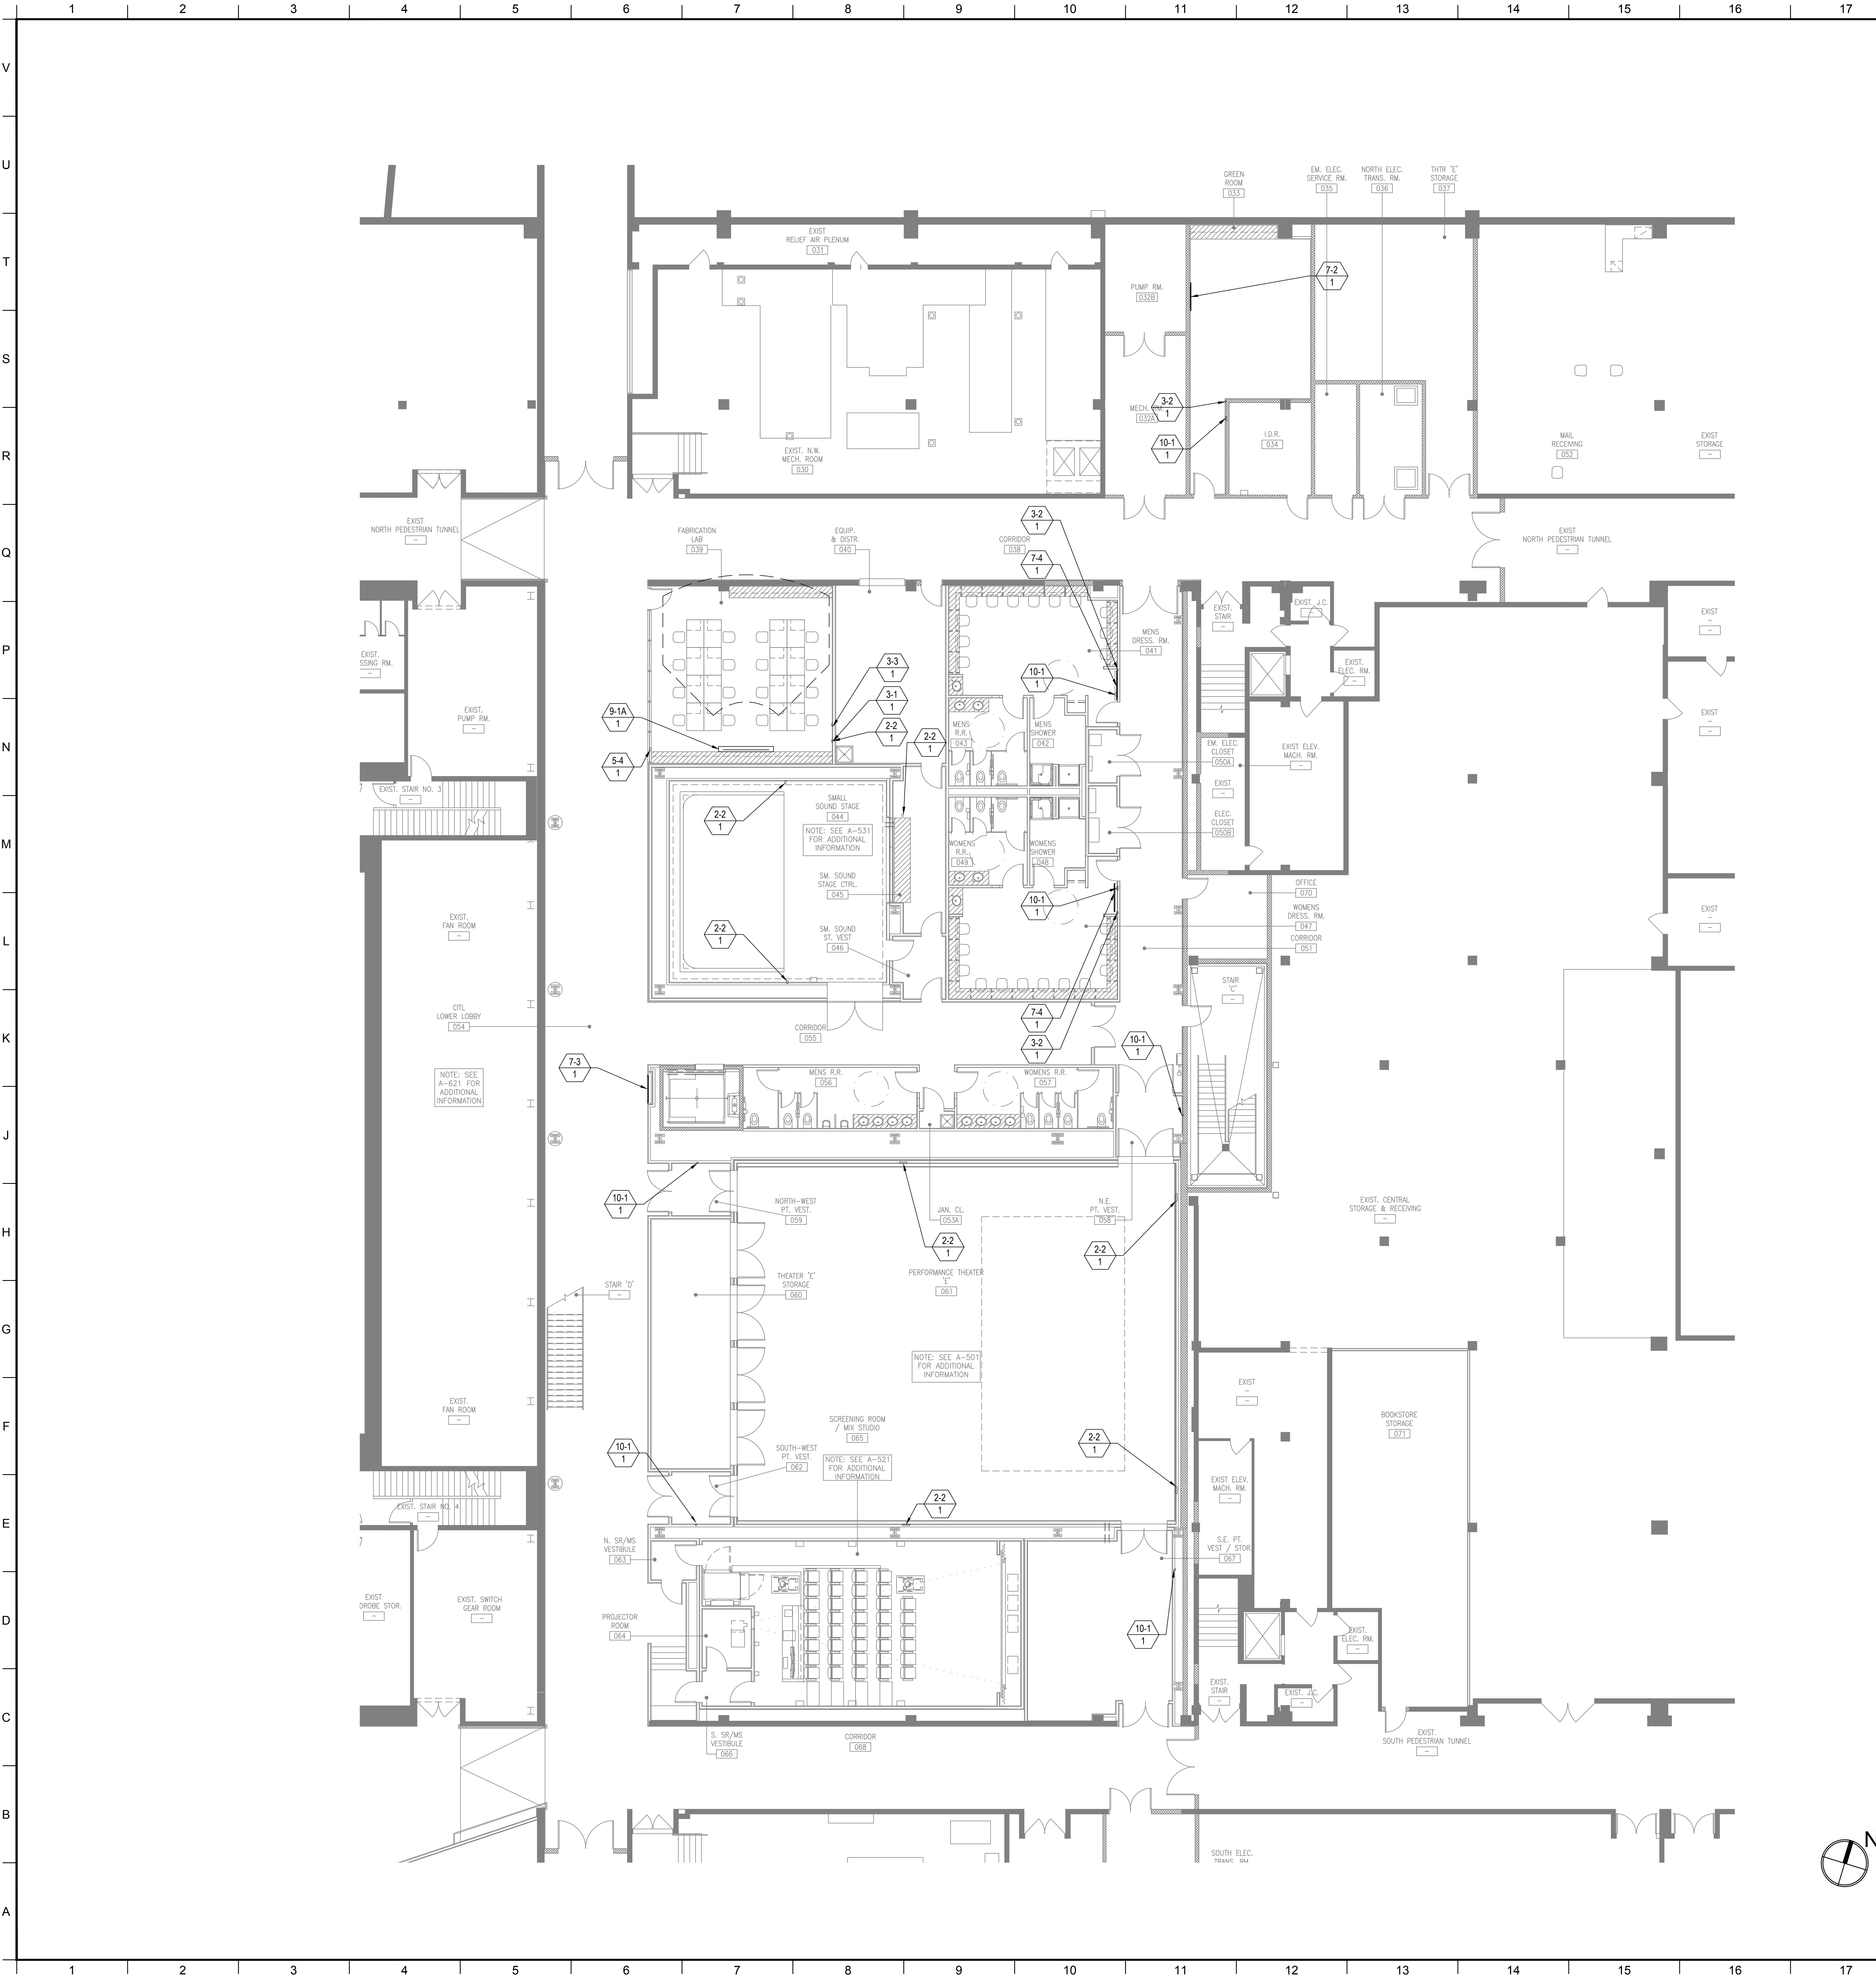


FACILITY KEYNOTE LEGEND

	EQUIPMENT RACKS: 1-1 Full Height
	CONNECTIVITY: 2-1 Floor Box 2-2 Wall Plate 2-3 Access Point at Ceiling Pipe Grid
	CONTROL/SCHEDULING: 3-1 Wall Mounted Controller 3-2 Volume Controller 3-3 Raise Lower Switch
	AUDIO INPUT: 4-1 Wireless Microphone Antenna
	AUDIO OUTPUT: 5-1 Ceiling Recessed Loudspeaker 5-2 Portable speaker Mounted on Pipe Grid 5-2A Portable Speaker Mounted on Catwalk 5-3 Portable Subwoofer Loudspeaker Mounted on Pipe Grid 5-4 Assistive Listening Emitter/Antenna 5-5 Ceiling Hanging Pendant Speaker
	VIDEO ORIGIN/SOURCE: 6-1 LOW LIGHT VIDEO CAMERA
	VIDEO DISPLAY (Type 1): 7-1 (70") Wall Mounted Flat Panel Display 7-2 (65") Wall Mounted Flat Panel Display 7-3 (65") Wall Mounted Digital Signage Display 7-4 (46") Wall Mounted Flat Panel Display
	VIDEO DISPLAY (Type 2): 8-1 Video Projector, Pole Mounted 8-2 Video Projector, Fixed at Projection Booth 8-3 Video Projector, OFE
	VIDEO DISPLAY (Type 3): 9-1 (50"x80"W) Ceiling Recessed Front Projection Screen 9-1A (50"x80"W) Wall Mounted Front Projection Screen 9-2 (144"x256"W) Ceiling Mounted Suspended Front Projection Screen. See TV and TR drawings for exact rigging details and locations. 9-3 120" x 213" Ceiling Recessed Front Projection Screen 9-4 (65" X 116) Ceiling Recessed Front Projection Screen 9-5 Painted projection surface 9-6 57.5" x 92" Ceiling Recessed Front Projection Screens 9-7 108" x 192" Ceiling Mounted Suspended Front Projection Screen. See TV and TR drawings for exact rigging details and locations.
	MISCELLANEOUS: 10-1 Theatrical Intercom

NOTE: EQUIPMENT SHOWN IN THIS SERIES IS FOR REFERENCE AND COORDINATION ONLY AND WILL BE FURNISHED BY THE OWNER. REFER TO GENERAL SPEC SECTION 011110 AND AUDIOVISUAL SPEC SECTION 274000

MATERIAL KEYING LEGEND:

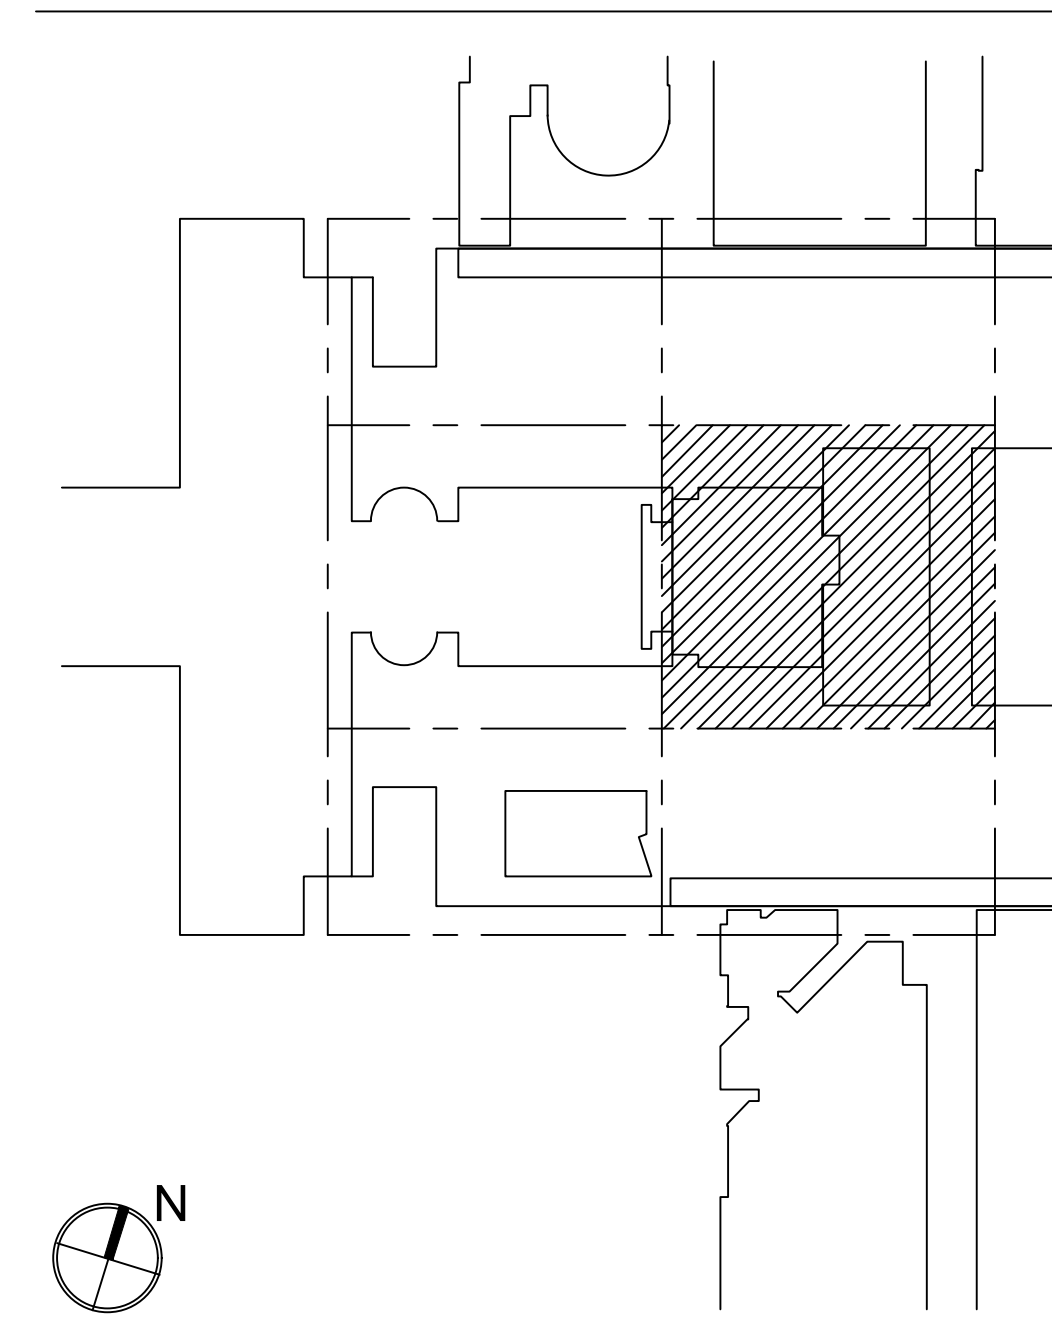

KEY PLAN

5 GROUP III AV BID DOCUMENTS 09.06.2017

2 BID DOCUMENTS 05.28.2014
1 DESIGN MANUAL PHASE SUBMISSION 04.01.2013

NO. REVISIONS / SUBMISSIONS DATE

FX FOWLE

FX FOWLE ARCHITECTS, LLP | 22 WEST 10TH STREET | NEW YORK, NY 10011 | T 212.427.1700 | F 212.425.8716 | WWW.FX FOWLE.COM

DESIGN/ARCHITECTS:
DESIMONE CONSULTING ENGINEERS
18 West 18th Street, 10th Floor, New York, New York 10011 212-532-2211

MECHANICAL, ELECTRICAL, PLUMBING, FIRE PROTECTION ENGINEER:
COLLADO ENGINEERING
2 Highland Avenue, White Plains, NY 10603 914-332-7658

THEATER PLANNING CONSULTANT:
FISHER DACHS ASSOCIATES
22 West 10th Street, 8th Floor, New York, New York 10011 212-691-3020

ACoustics & AUDIO VISUAL CONSULTANT:
CERAMI & ASSOCIATES
404 Fifth Avenue, New York, NY 10018 212-370-1776

LIGHTING CONSULTANT:
ILLUMINATION ARTS
605 Broadview Avenue, Suite 101, Bloomfield NJ 07003 973-771-1558

LANDSCAPE CONSULTANT:
W ARCHITECTURE & LANDSCAPE ARCHITECTURE, LLC
105 Fifth Avenue, Third Floor New York, NY 10010 P 212-951-3533 F 212-620-0798

DATA ENGINEER & ANALYST:
LANGAN
21 Penn Plaza 360 West 31st Street 8th Floor New York, NY 10001 212-479-5400 212-479-5444 (fax)

ELEVATOR CONSULTANT:
VDA (VAN DEUSEN & ASSOCIATES)
Seven Penn Plaza, Suite 404 New York, NY 10001 Phone: 212-808-9090 Fax: 212-808-9099

IT CONSULTANT:
GRID ASSOCIATES, LLC
P.O. Box 1770 Hicksville, NY 11743 T 646-722-9600 / F 646-722-9625

SUSTAINABILITY LEAD:
YR&G
161 Bowery - 4th Floor, New York, NY 10002 T 917-677-8023 / F 917-677-8023

GUEST ESTIMATING CONSULTANT:
TOSCANO CLEMENTS TAYLOR, LLC
16 Oakwood Road Huntington, NY 11743 T 631-392-1400 / F 631-392-1399

C.I.T.L. PROJ. # 29402
SUNY PURCHASE COLLEGE
735 ANDERSON HILL ROAD | PURCHASE, NY 10577

DRAWING TITLE:
AUDIOVISUAL-FACILITY - CITL BUILDING CONOURSE (BASEMENT LEVEL) PLAN


Seal: Drawn: AJC Project No.: 29402 (SUCF) / 09018.L00 (FXP)
Checked: BJM
Reviewed: BJM
Date:

Drawing No.: TA-112.0

Scale: 1/8" = 1'-0"


© 2009 FX FOWLE ARCHITECTS, LLP | ALL RIGHTS RESERVED

V
U
T
S
R
Q
P
N
M
L
K
J
H
G
F
E
D
C
B
A

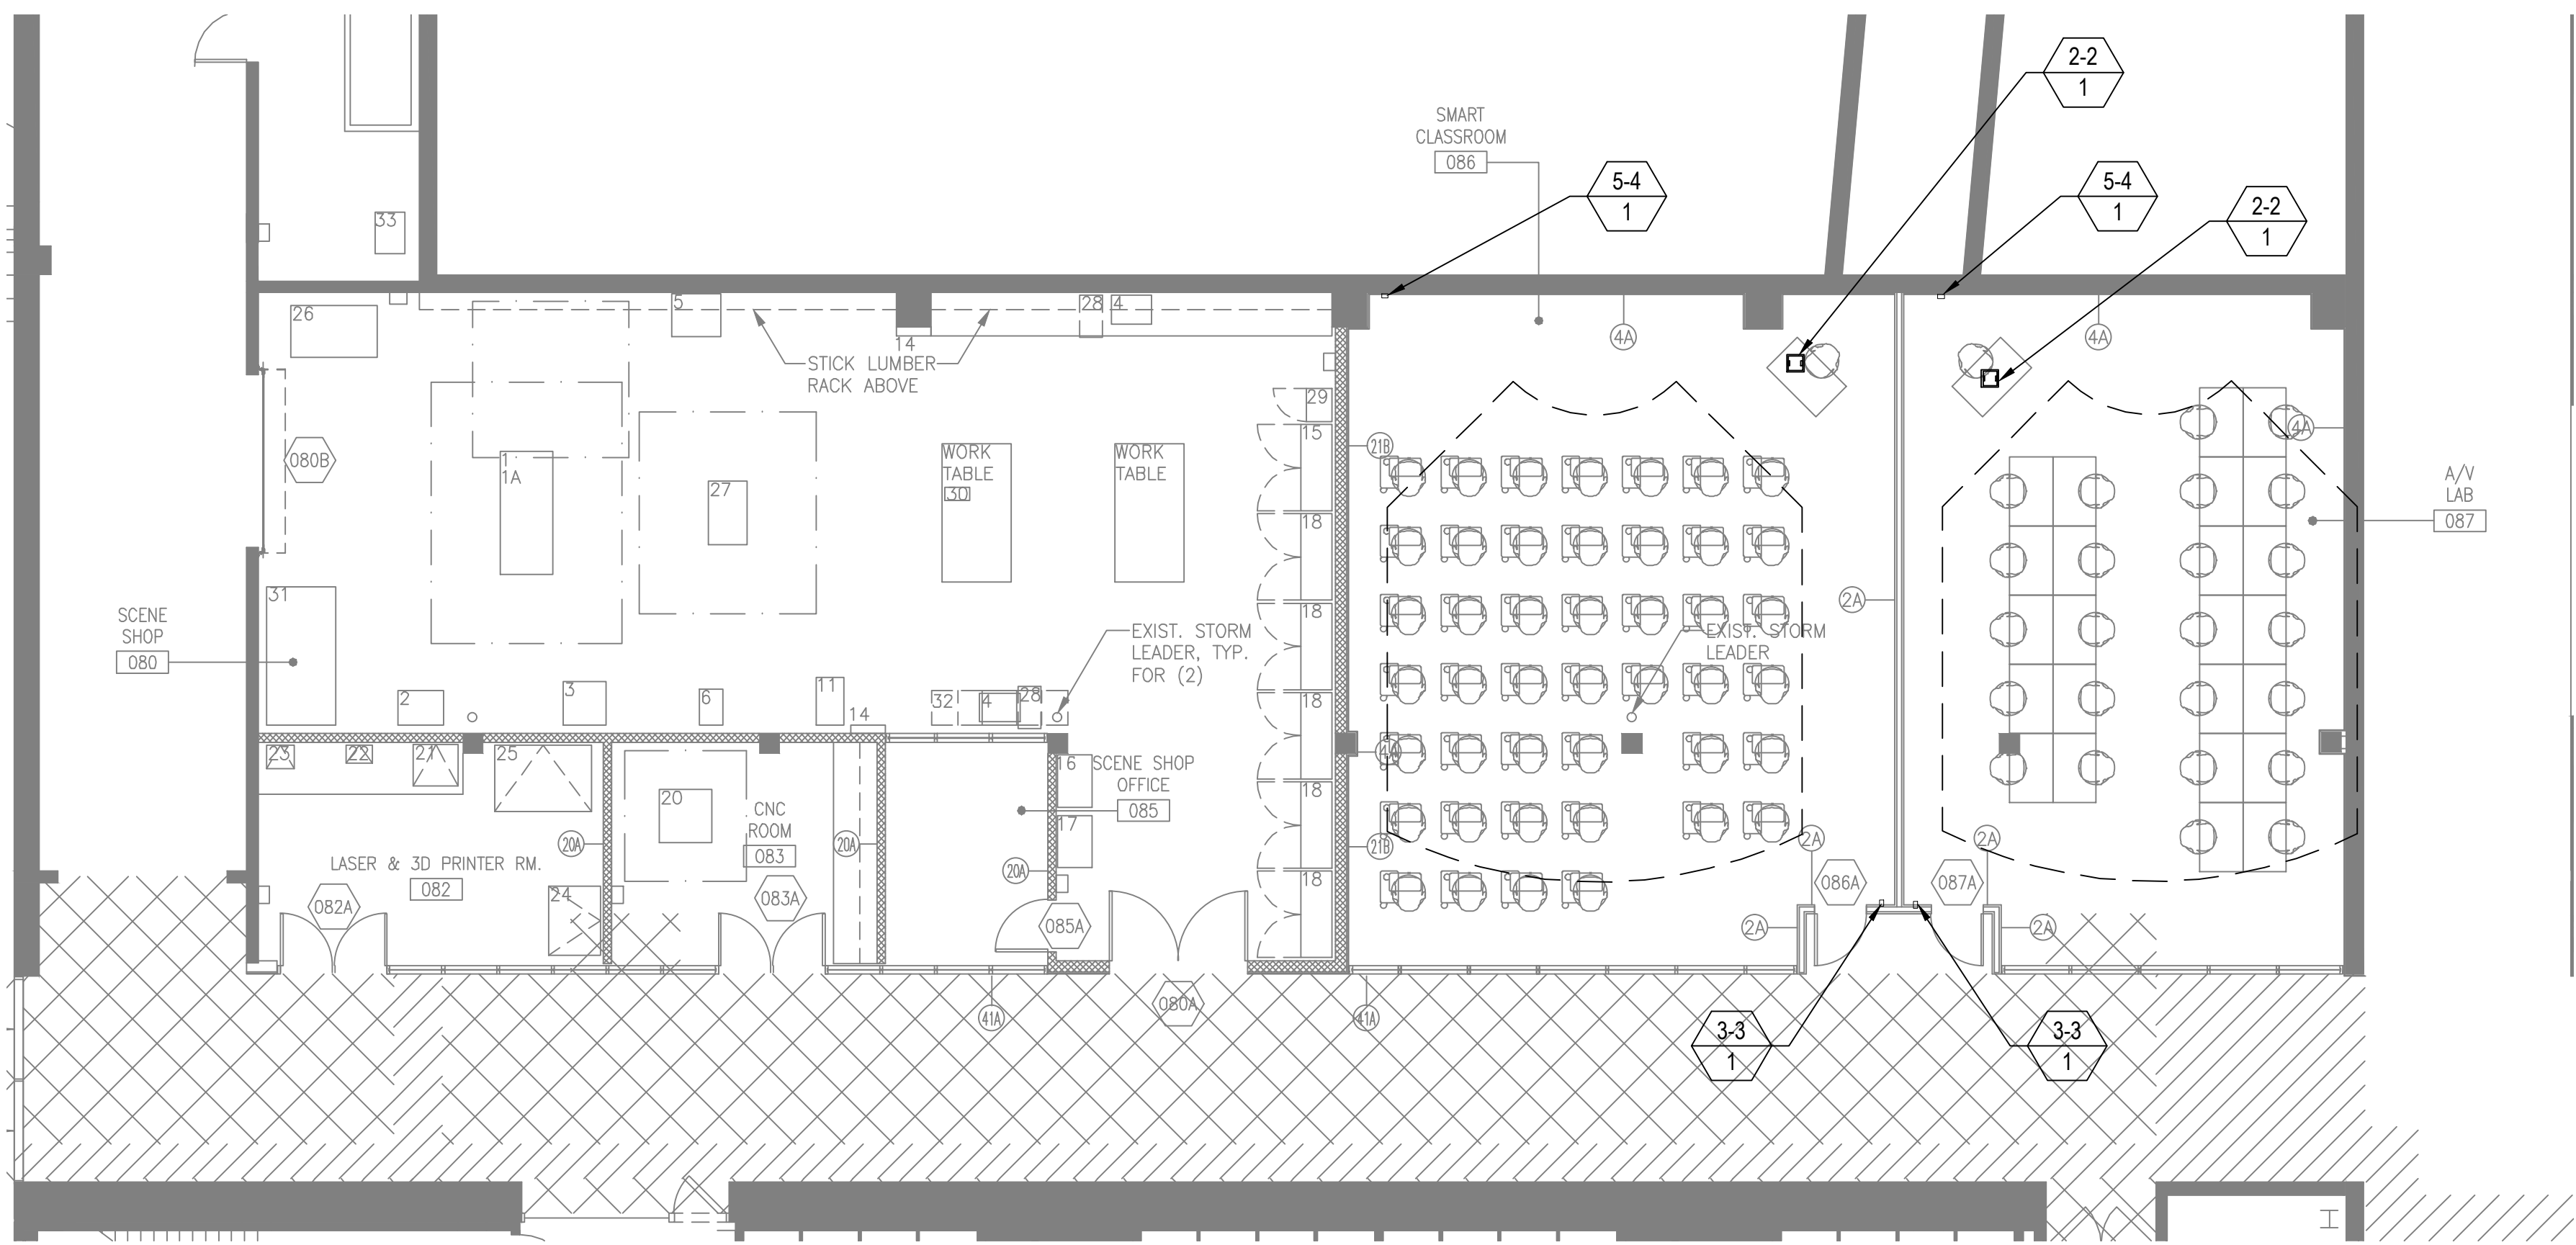

FACILITY KEYNOTE LEGEND	
	EQUIPMENT RACKS: 1-1 Full Height
	CONNECTIVITY: 2-1 Floor Box 2-2 Wall Plate 2-3 Access Point at Ceiling Pipe Grid
	CONTROL/SCHEDULING: 3-1 Wall Mounted Controller 3-2 Volume Controller 3-3 Raise Lower Switch
	AUDIO INPUT: 4-1 Wireless Microphone Antenna
	AUDIO OUTPUT: 5-1 Ceiling Recessed Loudspeaker 5-2 Portable speaker Mounted on Pipe Grid 5-2A Portable Speaker Mounted on Catwalk 5-3 Portable Subwoofer Loudspeaker Mounted on Pipe Grid 5-4 Assistive Listening Emitter/Antenna 5-5 Ceiling Hanging Pendant Speaker
	VIDEO ORIGIN/SOURCE: 6-1 LOW LIGHT VIDEO CAMERA
	VIDEO DISPLAY (Type 1): 7-1 (70") Wall Mounted Flat Panel Display 7-2 (55") Wall Mounted Flat Panel Display 7-3 (55") Wall Mounted Digital Signage Display 7-4 (46") Wall Mounted Flat Panel Display
	VIDEO DISPLAY (Type 2): 8-1 Video Projector, Pole Mounted 8-2 Video Projector, Fixed at Projection Booth 8-3 Video Projector, OFE
	VIDEO DISPLAY (Type 3): 9-1 (50"Hx80"W) Ceiling Recessed Front Projection Screen 9-1A (50"Hx80"W) Wall Mounted Front Projection Screen 9-2 (144"Hx256"W) Ceiling Mounted Suspended Front Projection Screen. See TV and TR drawings for exact rigging details and locations. 9-3 120" x 213" Ceiling Recessed Front Projection Screen 9-4 (65" X 116) Ceiling Recessed Front Projection Screen 9-5 Painted projection surface 9-6 57.5" x 92" Ceiling Recessed Front Projection Screens 9-7 108" x 192" Ceiling Mounted Suspended Front Projection Screen. See TV and TR drawings for exact rigging details and locations.

MATERIAL KEYING LEGEND:

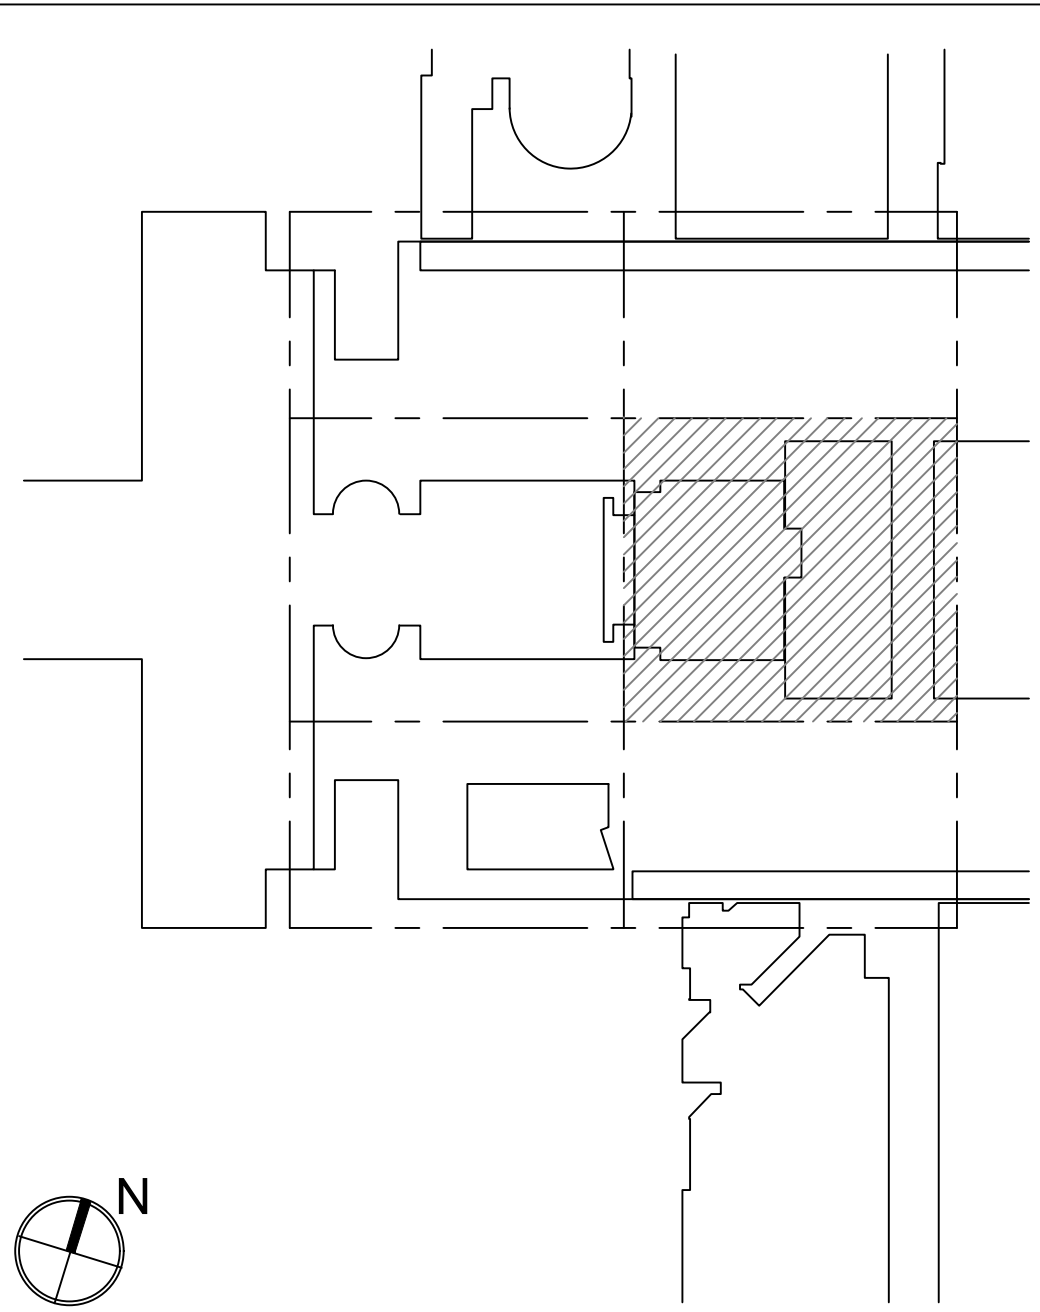

KEY PLAN

5	GROUP III AV BID DOCUMENTS	09.06.2017
2	BID DOCUMENTS	05.28.2014
1	DESIGN MANUAL PHASE SUBMISSION	04.01.2013
NO.	REVISIONS / SUBMISSIONS	DATE

FX FOWLE

FXFOWLE ARCHITECTS, LLP | 22 WEST 18TH STREET | NEW YORK, NY 10011 | T 212.627.1700 | F 212.453.8716 | WWW.FXFOWLE.COM

DESIGN/ARCHITECTURAL ENGINEER:
DISMONE CONSULTING ENGINEERS
18 West 18th Street, 10th Floor, New York, New York 10011 212-532-2211

MECHANICAL, ELECTRICAL, PLUMBING, FIRE PROTECTION ENGINEER:
COLLAO ENGINEERING
2 Hickland Avenue, White Plains, NY 10603 914-332-7658

THEATER PLANNING CONSULTANT:
FISHER DACHS ASSOCIATES
22 West 18th Street, 8th Floor, New York, NY 10011 212-691-3020

ACoustics & AUDIO / VISUAL CONSULTANT:
CERAMI & ASSOCIATES
404 Fifth Avenue, New York, NY 10018 212-370-1776

LIGHTING CONSULTANT:
ILLUMINATION ARTS
650 Bloomfield Avenue, Suite 101, Bloomfield NJ 07003 973-771-1558

LANDSCAPE CONSULTANT:
W ARCHITECTURE & LANDSCAPE ARCHITECTURE, LLC
100 Fifth Avenue Third Floor New York, NY 10010 P 212-961-3633 F 212-620-0798

Civil ENGINEER & LANDSCAPE ARCHITECT:
LANGAN
21 Penn Plaza 360 West 31st Street 8th Floor New York, NY 10001 212-479-5400 212-479-5444 (fax)

ELEVATOR CONSULTANT:
VDA (VAN DEUSEN & ASSOCIATES)
Seven Penn Plaza, Suite 404 New York, NY 10001 Phone: 212-808-9090 Fax: 212-808-9099

IT CONSULTANT:
GRID ASSOCIATES, LLC
P.O. Box 1700 Hoboken, NJ 07030 T 946.722.6600 / F 946.722.6625

SUSTAINABILITY / LEED:
YR&G
161 Bowery - 4th Floor, New York, NY 10002 T 917.677.8023 / F 917.677.8023


COST ESTIMATING CONSULTANT:
TOSCANO CLEMENTS TAYLOR, LLC
16 Oakwood Road Huntington, NY 11743 T 631.392.1400 / F 631.392.1399

C.I.T.L. PROJ. # 29402
SUNY PURCHASE COLLEGE
735 ANDERSON HILL ROAD | PURCHASE, NY 10577

DRAWING TITLE:
AUDIOVISUAL-FACILITY - ADD ALTERNATE CONCOURSE (BASEMENT LEVEL) PLAN

Seal:	Drawn: AJC	Project No.: 29402 (SUCF) / 09018.L00 (FXF)
	Checked: BJM	Cal File:
	Reviewed: BJM	Drawing No.:
	Date:	
	Scale: 1/8" = 1'-0"	

TA112.0_AA

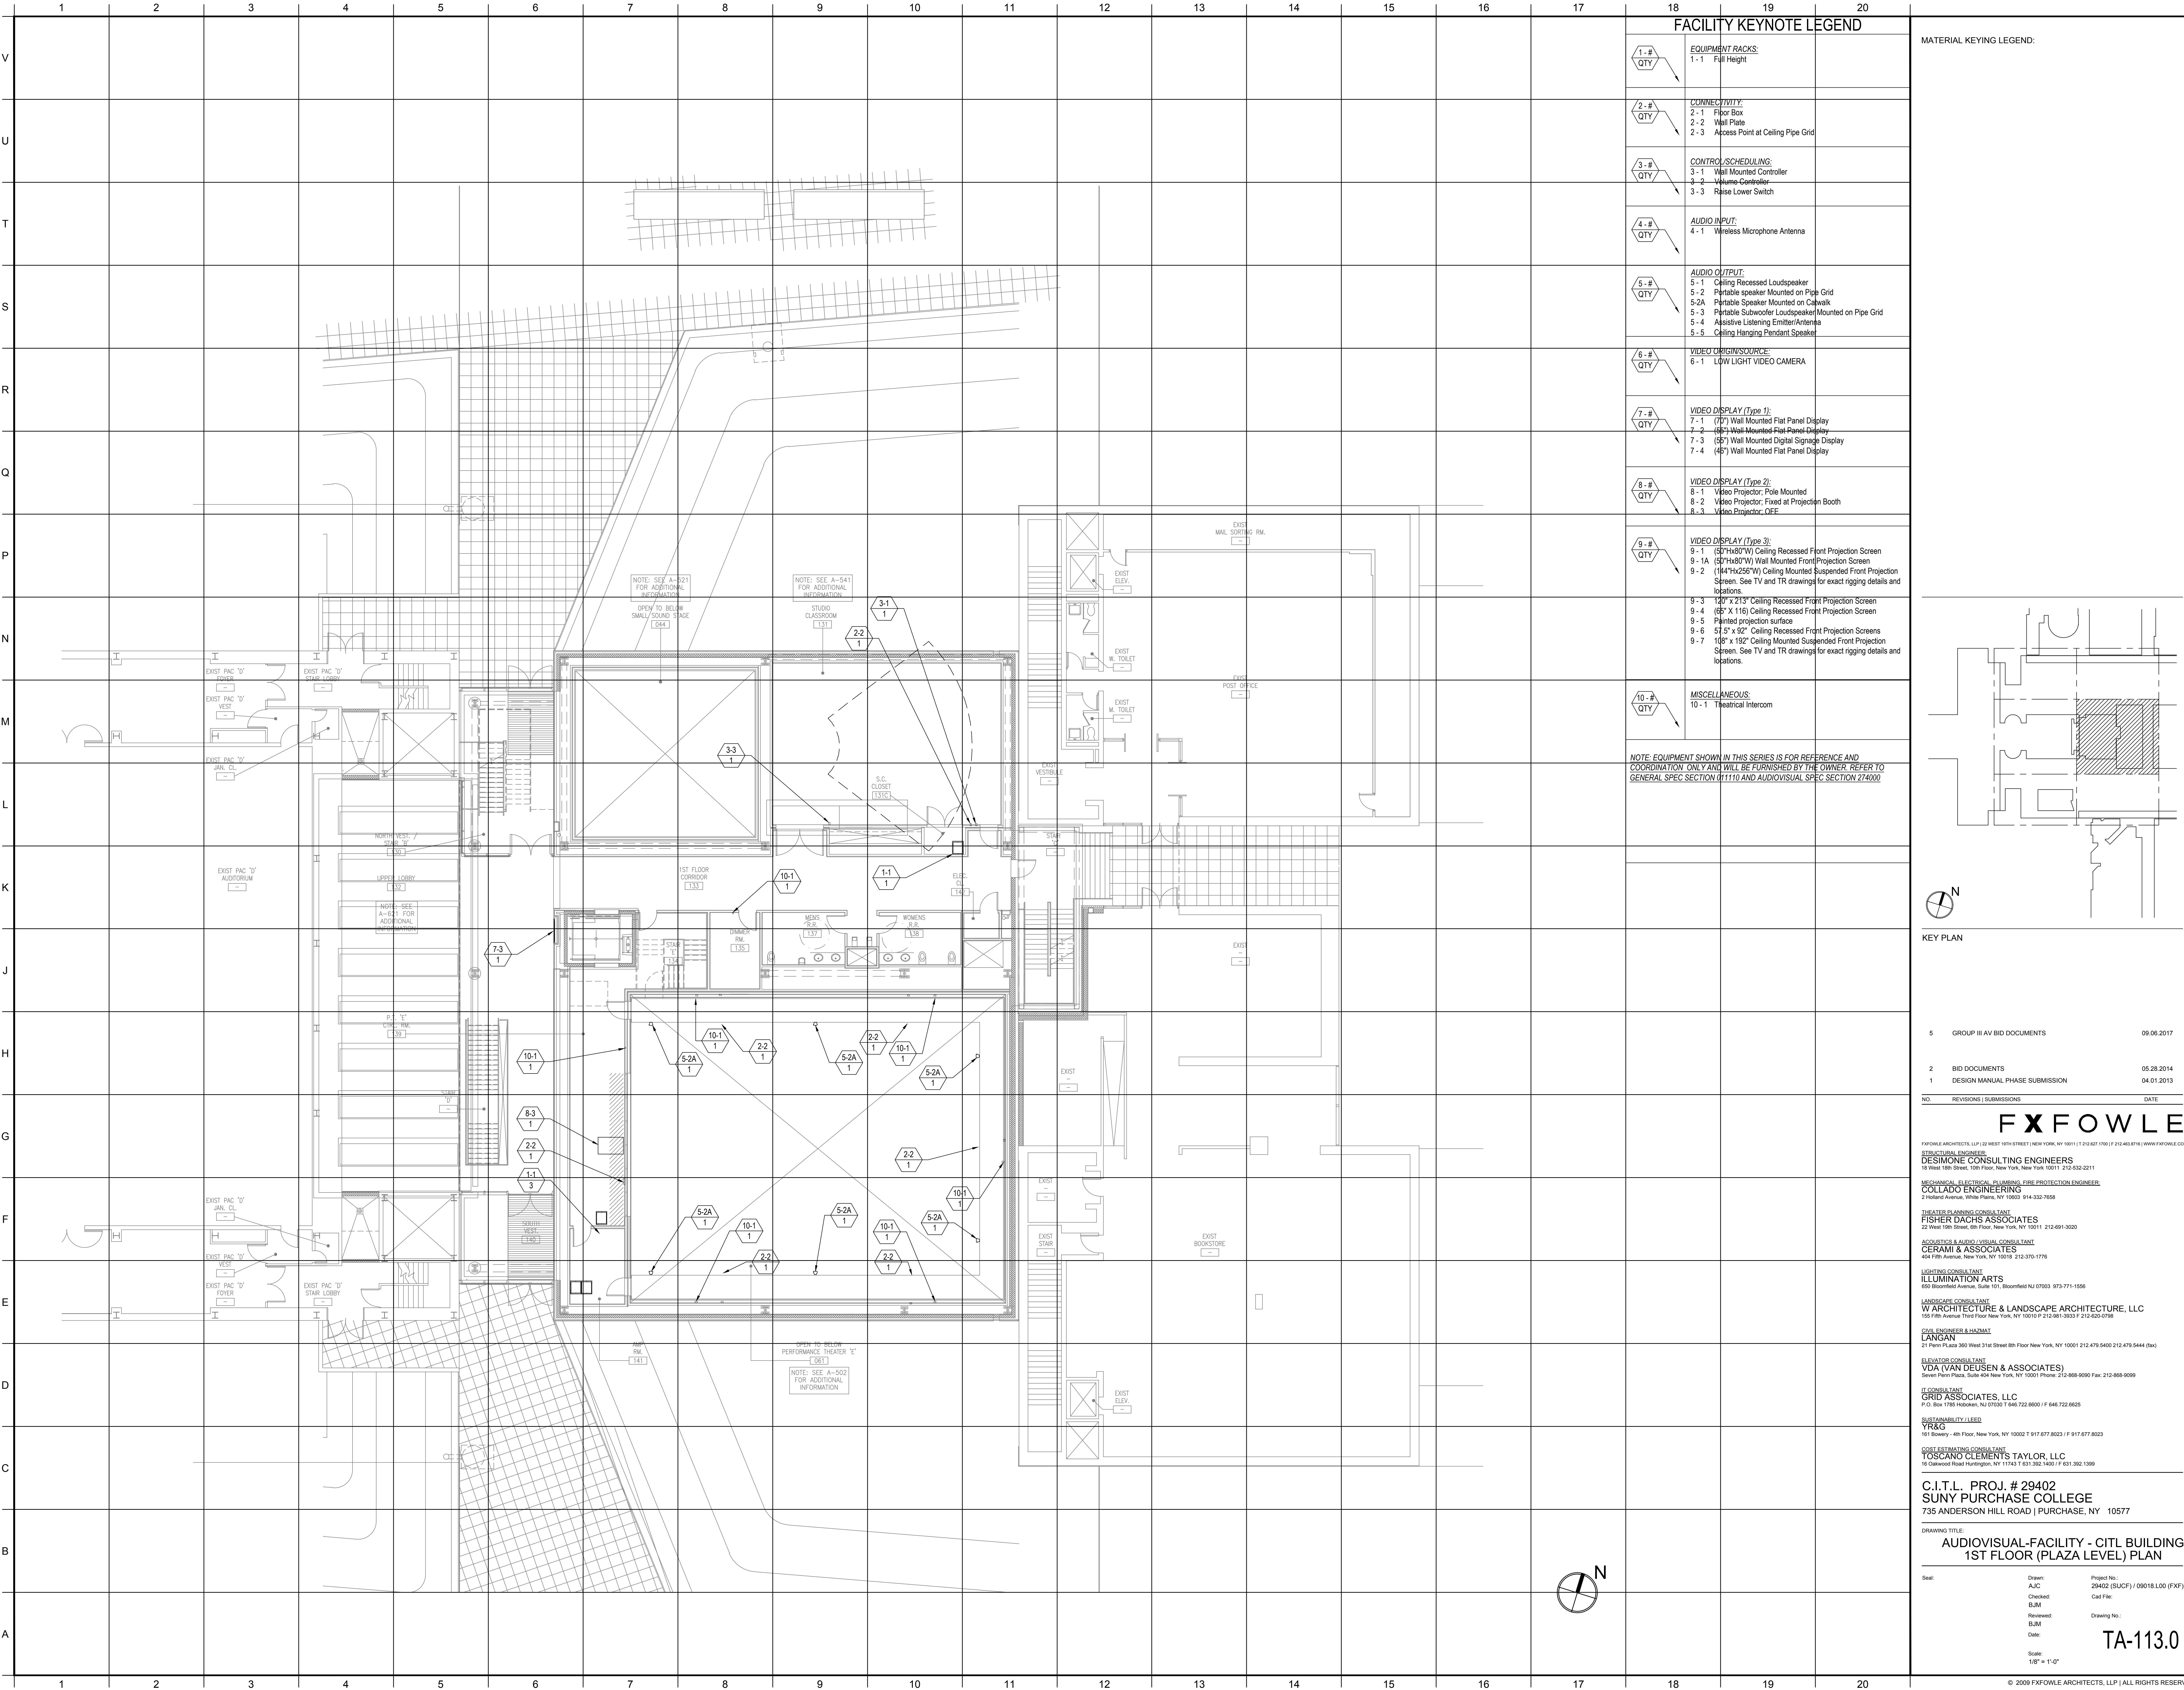


FACILITY KEYNOTE LEGEND

1-# QTY	EQUIPMENT RACKS: 1-1 Full Height
2-# QTY	CONNECTIVITY: 2-1 Floor Box 2-2 Wall Plate 2-3 Access Point at Ceiling Pipe Grid
3-# QTY	CONTROL/SCHEDULING: 3-1 Wall Mounted Controller 3-2 Volume Controller 3-3 Raise Lower Switch
4-# QTY	AUDIO INPUT: 4-1 Wireless Microphone Antenna
5-# QTY	AUDIO OUTPUT: 5-1 Ceiling Recessed Loudspeaker 5-2 Portable speaker Mounted on Pipe Grid 5-2A Portable Speaker Mounted on Catwalk 5-3 Portable Subwoofer Loudspeaker Mounted on Pipe Grid 5-4 Assistive Listening Emitter/Antenna 5-5 Ceiling Hanging Pendant Speaker
6-# QTY	VIDEO ORIGINS/SOURCE: 6-1 LOW LIGHT VIDEO CAMERA
7-# QTY	VIDEO DISPLAY (Type 1): 7-1 (70" Wall Mounted Flat Panel Display 7-2 (65" Wall Mounted Flat Panel Display 7-3 (65" Wall Mounted Digital Signage Display 7-4 (48" Wall Mounted Flat Panel Display
8-# QTY	VIDEO DISPLAY (Type 2): 8-1 Video Projector, Pole Mounted 8-2 Video Projector, Fixed at Projection Booth 8-3 Video Projector, OFF
9-# QTY	VIDEO DISPLAY (Type 3): 9-1 (37"x80"W) Ceiling Recessed Front Projection Screen 9-1A (50"x80"W) Wall Mounted Front Projection Screen 9-2 (164"x256"W) Ceiling Mounted Suspended Front Projection Screen. See TV and TR drawings for exact rigging details and locations.
10-# QTY	MISCELLANEOUS: 10-1 Theatrical Intercom

NOTE: EQUIPMENT SHOWN IN THIS SERIES IS FOR REFERENCE AND COORDINATION ONLY AND WILL BE FURNISHED BY THE OWNER. REFER TO GENERAL SPEC SECTION 011110 AND AUDIOVISUAL SPEC SECTION 274000

MATERIAL KEYING LEGEND:

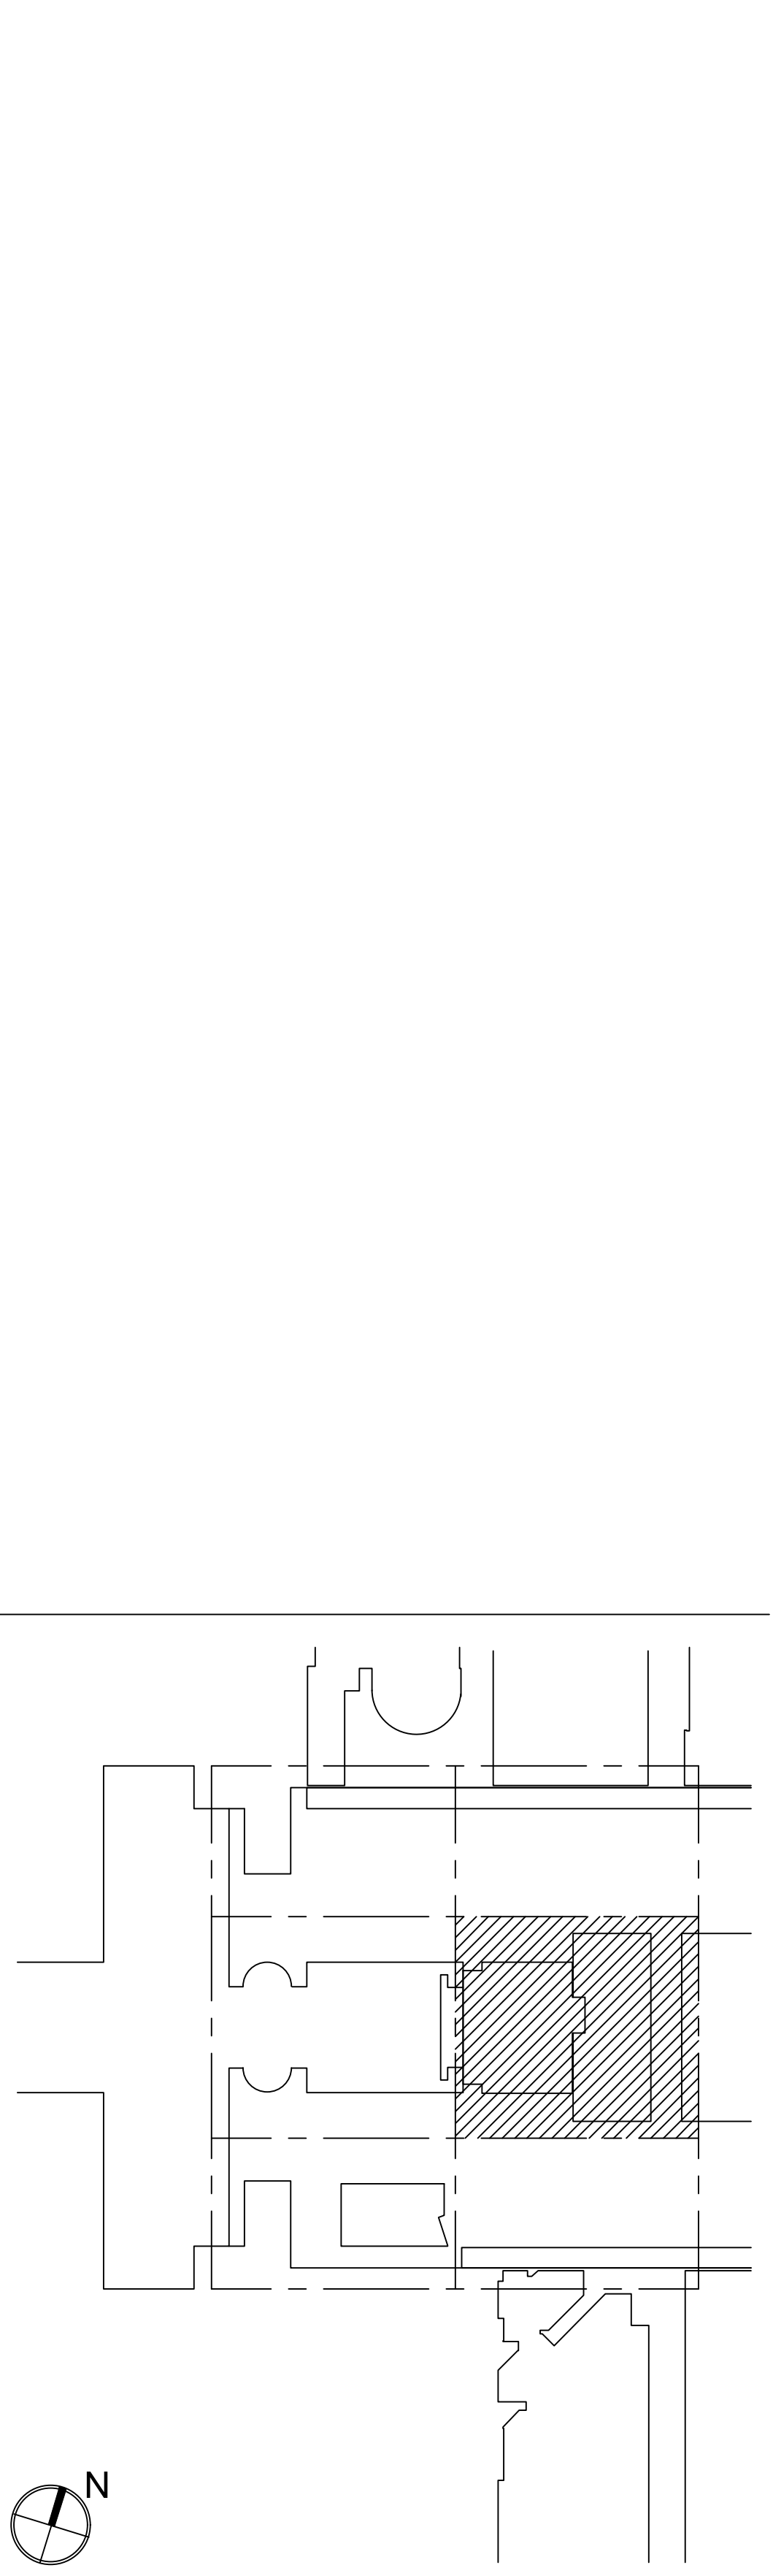

KEY PLAN



5	GROUP III AV BID DOCUMENTS	08.06.2017
2	BID DOCUMENTS	05.28.2014
1	DESIGN MANUAL PHASE SUBMISSION	04.01.2013

NO.	REVISIONS / SUBMISSIONS	DATE
-----	-------------------------	------



FXFOWLE ARCHITECTS, LLP | 22 WEST 10TH STREET | NEW YORK, NY 10011 | T 212.627.1700 | F 212.453.8716 | WWW.FXFOWLE.COM
REGISTERED ENGINEERS
DESIGNSOME CONSULTING ENGINEERS
18 West 18th Street, 10th Floor, New York, New York 10011 | 212-627-2211

MECHANICAL, ELECTRICAL, PLUMBING, FIRE PROTECTION ENGINEER:
COLLADO ENGINEERING
2 Holmdel Avenue, White Plains, NY 10603 | 914-332-7658

THEATER PLANNING CONSULTANT:
FISHER DACHS ASSOCIATES
22 West 10th Street, 8th Floor, New York, NY 10011 | 212-691-3020

ACQUISITION & AUDIO VISUAL CONSULTANT:
CERAMI & ASSOCIATES
404 Fifth Avenue, New York, NY 10018 | 212-370-1776

LIGHTING CONSULTANT:
ILLUMINATION ARTS
605 Broadview Avenue, Suite 101, Bloomfield NJ 07003 | 973-771-1558

LANDSCAPE CONSULTANT:
W ARCHITECTURE & LANDSCAPE ARCHITECTURE, LLC
105 Fifth Avenue, Third Floor New York, NY 10010 | P 212-951-3533 / F 212-620-0758

CIVIL ENGINEER & LANDSCAPE ARCHITECT:
LANGAN
21 Penn Plaza 360 West 31st Street 8th Floor New York, NY 10001 | 212-479-5400 | 212-479-5444 (fax)

ELEVATOR CONSULTANT:
VDA (VAN DEUSEN & ASSOCIATES)
South Penn Plaza, Suite 404 New York, NY 10001 | Phone: 212-808-9090 Fax: 212-808-9099

IT CONSULTANT:
GRID ASSOCIATES, LLC
P.O. Box 1770 Hicksville, NY 11743 | T 516-722-9600 / F 516-722-9625

SUSTAINABILITY LEAD:
YR&G
161 Bowery - 4th Floor, New York, NY 10002 | T 917-677-8023 / F 917-677-8023

COST ESTIMATING CONSULTANT:
TOSCANO CLEMENTS TAYLOR, LLC
16 Oakwood Road Huntington, NY 11743 | T 631-392-1400 / F 631-392-1399


C.I.T.L. PROJ. # 29402
SUNY PURCHASE COLLEGE
735 ANDERSON HILL ROAD | PURCHASE, NY 10577

DRAWING TITLE:
AUDIOVISUAL-FACILITY - CITL BUILDING
1ST FLOOR (PLAZA LEVEL) PLAN


Seal:	Drawn: AJC	Project No.: 29402 (SUCF) / 05018.L00 (FXF)
	Checked: BJM	Calc File:
	Reviewed: BJM	Drawing No.:
	Date:	
	Scale: 1/8" = 1'-0"	

TA-113.0

V
U
T
S
R
Q
P
N
M
L
K
J
H
G
F
E
D
C
B
A

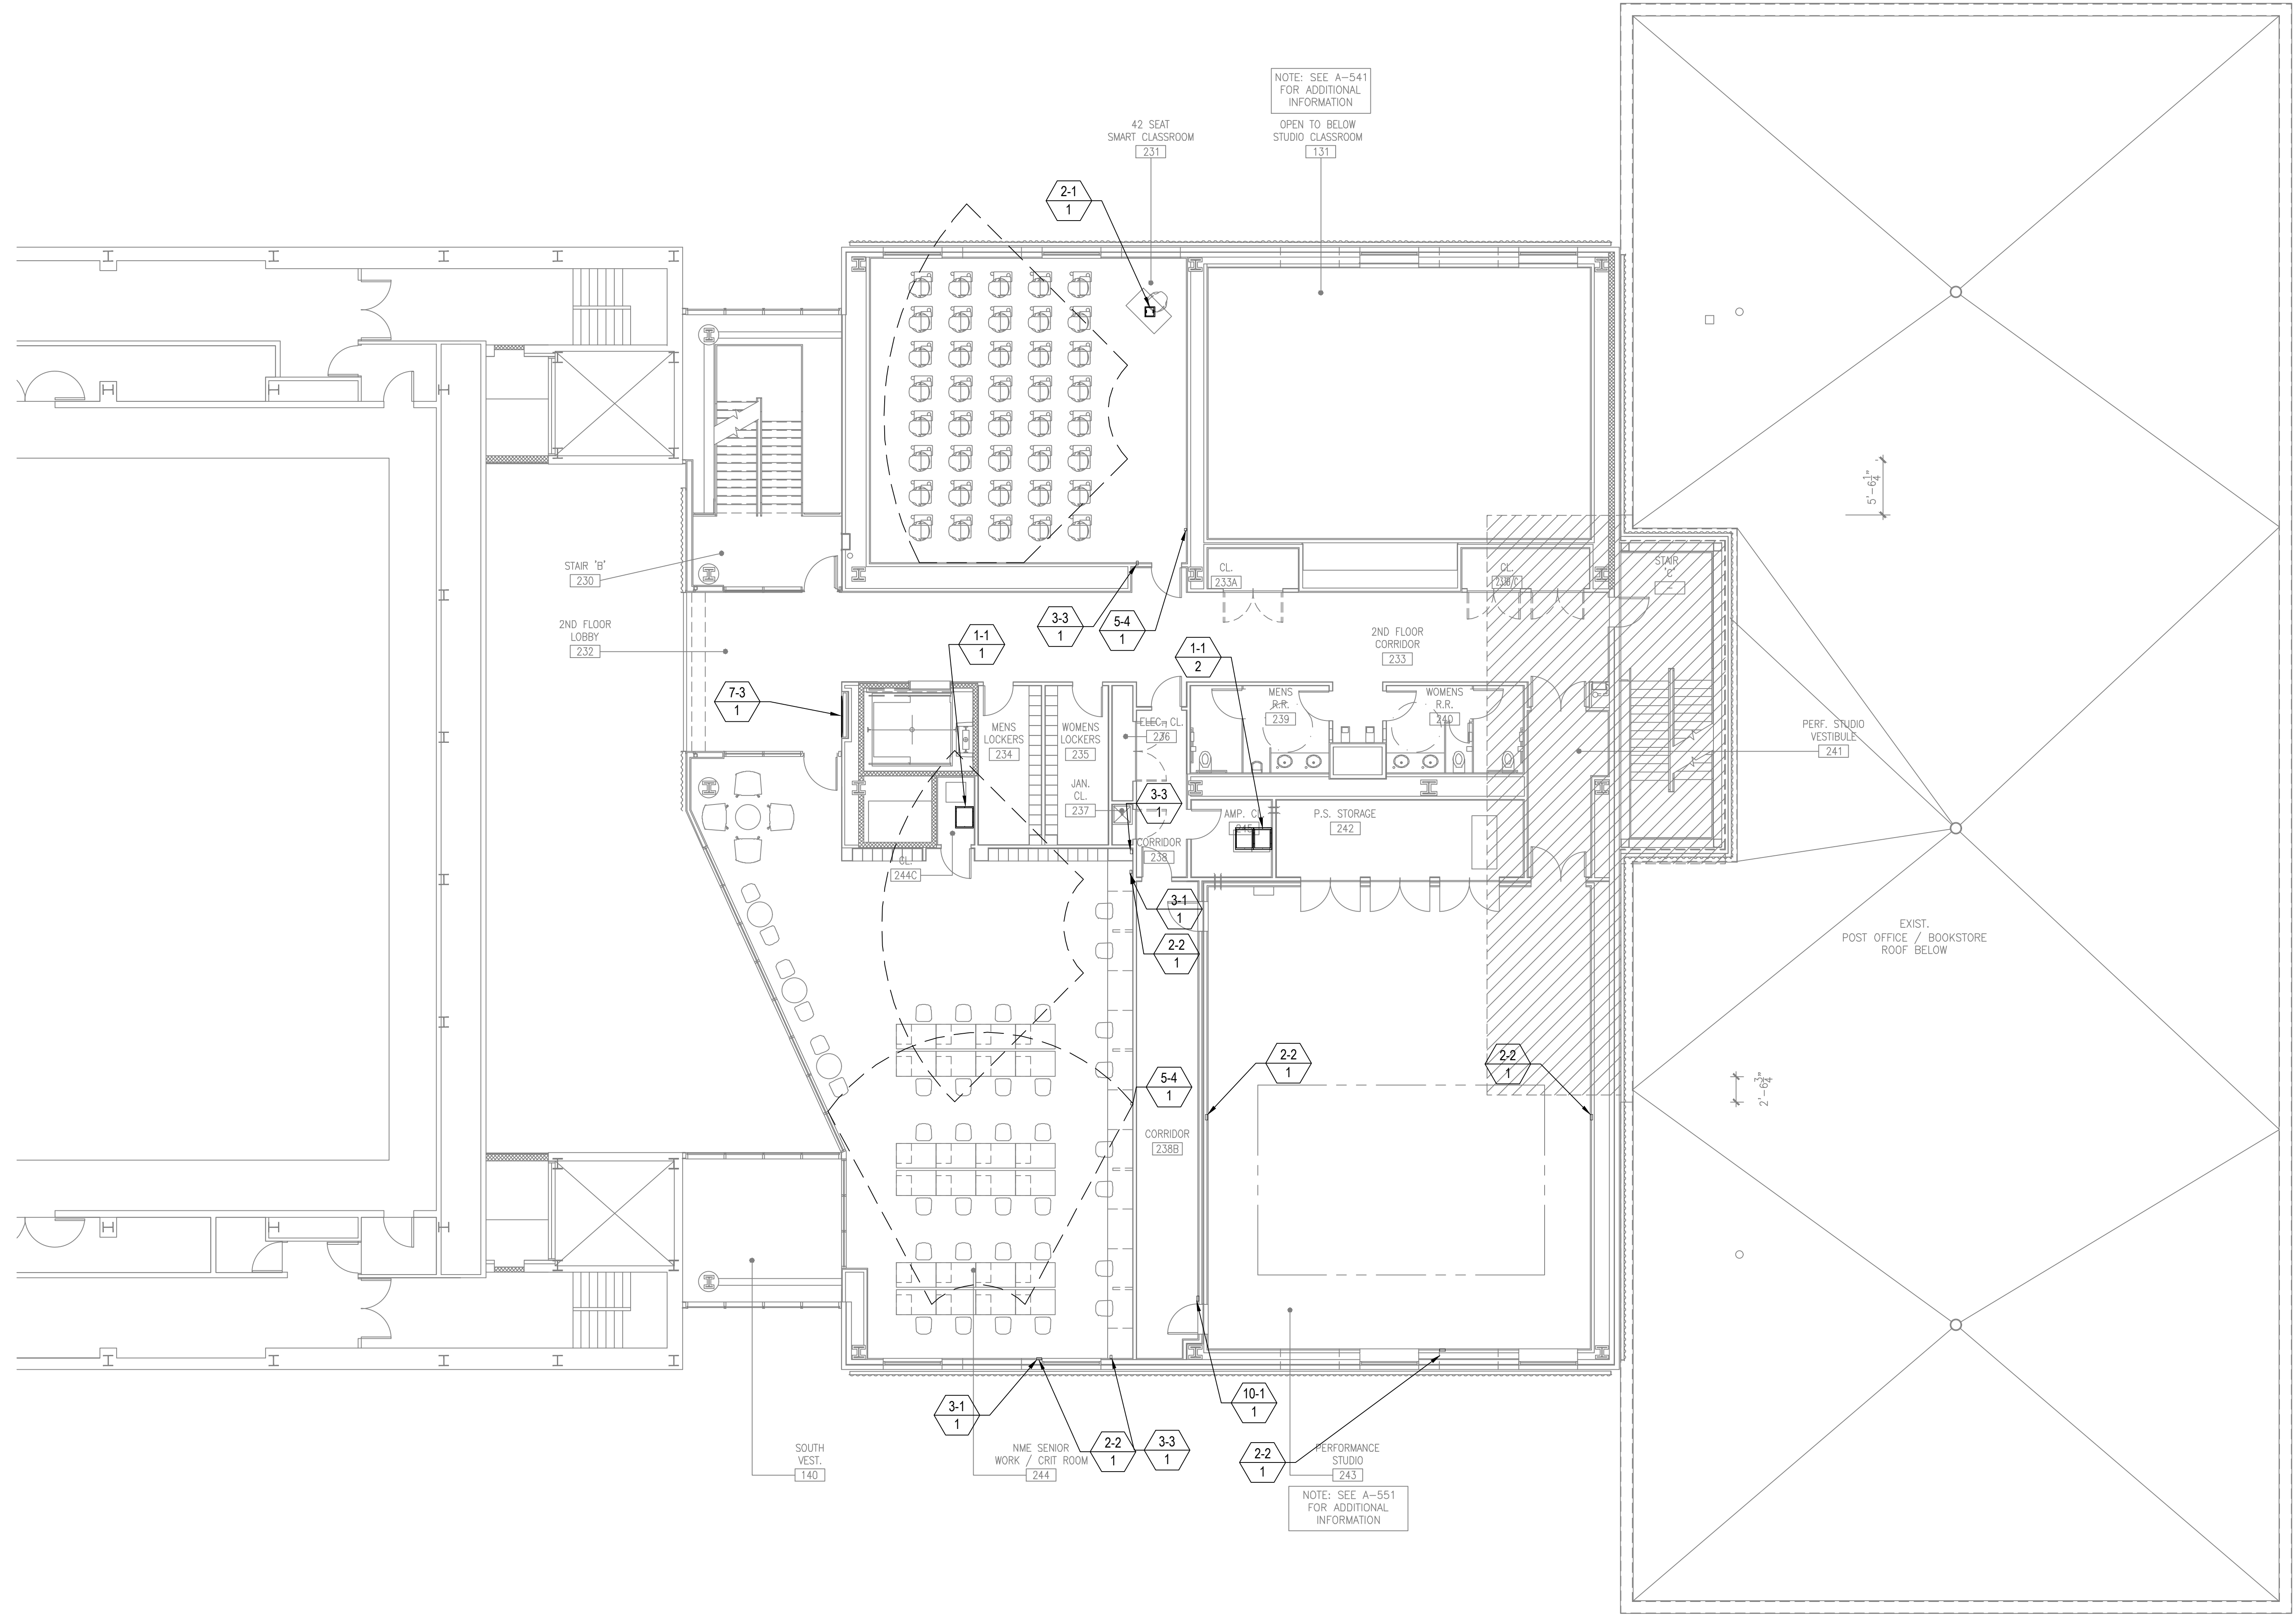


FACILITY KEYNOTE LEGEND	
	EQUIPMENT RACKS: 1-1 Full Height
	CONNECTIVITY: 2-1 Floor Box 2-2 Wall Plate 2-3 Access Point at Ceiling Pipe Grid
	CONTROL/SCHEDULING: 3-1 Wall Mounted Controller 3-2 Volume Controller 3-3 Raise Lower Switch
	AUDIO INPUT: 4-1 Wireless Microphone Antenna
	AUDIO OUTPUT: 5-1 Ceiling Recessed Loudspeaker 5-2 Portable speaker Mounted on Pipe Grid 5-2A Portable Speaker Mounted on Catwalk 5-3 Portable Subwoofer Loudspeaker Mounted on Pipe Grid 5-4 Assistive Listening Emitter/Antenna 5-5 Ceiling Hanging Pendant Speaker
	VIDEO ORIGIN/SOURCE: 6-1 LOW LIGHT VIDEO CAMERA
	VIDEO DISPLAY (Type 1): 7-1 (70") Wall Mounted Flat Panel Display 7-2 (55") Wall Mounted Flat Panel Display 7-3 (55") Wall Mounted Digital Signage Display 7-4 (46") Wall Mounted Flat Panel Display
	VIDEO DISPLAY (Type 2): 8-1 Video Projector; Pole Mounted 8-2 Video Projector; Fixed at Projection Booth 8-3 Video Projector; OFE
	VIDEO DISPLAY (Type 3): 9-1 (50"Hx80"W) Ceiling Recessed Front Projection Screen 9-1A (50"Hx80"W) Wall Mounted Front Projection Screen 9-2 (144"Hx256"W) Ceiling Mounted Suspended Front Projection Screen. See TV and TR drawings for exact rigging details and locations. 9-3 120" x 213" Ceiling Recessed Front Projection Screen 9-4 (65" X 116) Ceiling Recessed Front Projection Screen 9-5 Painted projection surface 9-6 57.5" x 92" Ceiling Recessed Front Projection Screens 9-7 108" x 192" Ceiling Mounted Suspended Front Projection Screen. See TV and TR drawings for exact rigging details and locations.

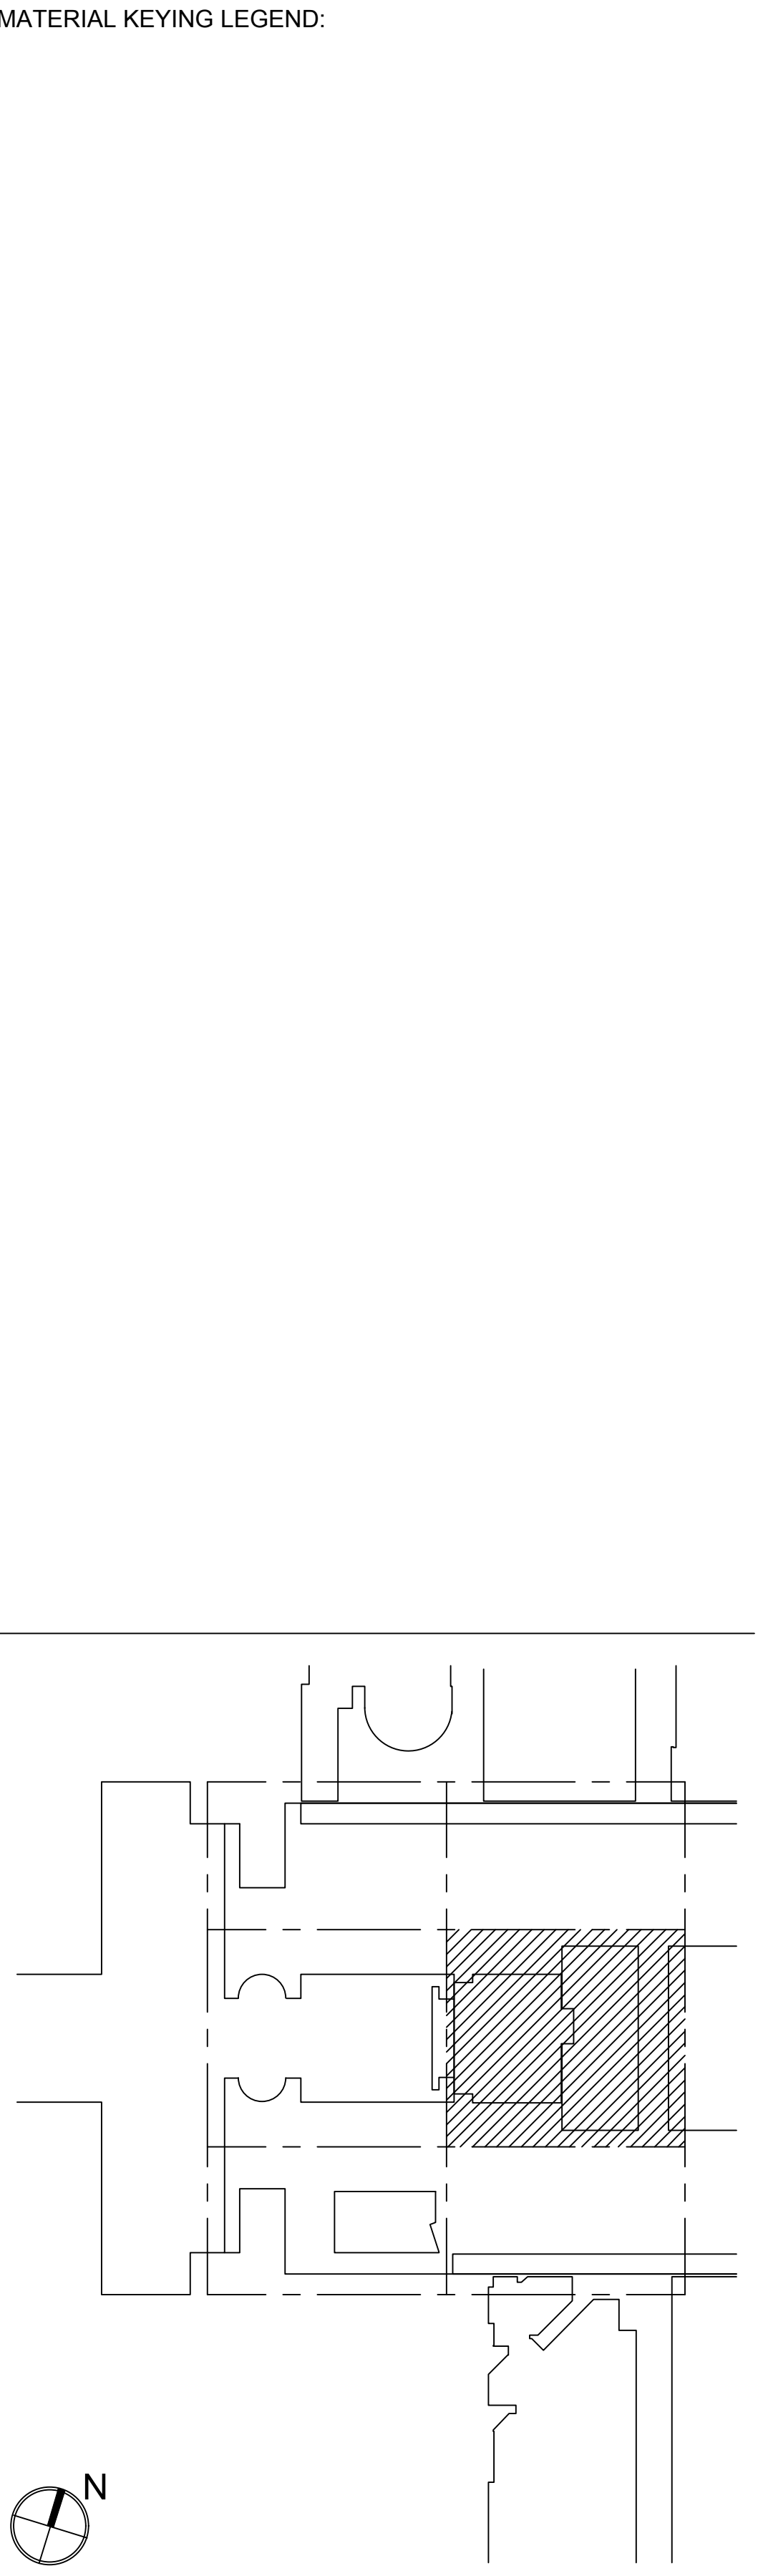

KEY PLAN	
5	GROUP III AV BID DOCUMENTS 08.06.2017
2	BID DOCUMENTS 05.28.2014
1	DESIGN MANUAL PHASE SUBMISSION 04.01.2013
NO.	REVISIONS / SUBMISSIONS DATE
FX FOWLE	
FX FOWLE ARCHITECTS, LLP 22 WEST 18TH STREET NEW YORK, NY 10011 T 212.427.1700 F 212.425.8716 WWW.FX FOWLE.COM	
DESIGN ENGINEER: DRESIMONE CONSULTING ENGINEERS 18 West 18th Street, 10th Floor, New York, New York 10011 212-532-2211	
MECHANICAL, ELECTRICAL, PLUMBING, FIRE PROTECTION ENGINEER: COLLADO ENGINEERING 2 Hickory Avenue, White Plains, NY 10603 914-332-7658	
THEATER PLANNING CONSULTANT: FISHER DACHS ASSOCIATES 22 West 18th Street, 8th Floor, New York, NY 10011 212-691-3020	
ACoustics & AUDIO VISUAL CONSULTANT: CERAMI & ASSOCIATES 404 Fifth Avenue, New York, NY 10018 212-370-1776	
LIGHTING CONSULTANT: ILLUMINATION ARTS 605 Bloomfield Avenue, Suite 101, Bloomfield NJ 07003 973-771-1558	
LANDSCAPE CONSULTANT: W ARCHITECTURE & LANDSCAPE ARCHITECTURE, LLC 105 Fifth Avenue Third Floor New York, NY 10010 P 212-951-3533 F 212-620-0758	
CHAIR ENGINEER & HAZMAT: LANGAN 21 Penn Plaza 360 West 31st Street 8th Floor New York, NY 10001 212-479-5400 212-479-5444 (fax)	
ELEVATOR CONSULTANT: VDA (VAN DEUSEN & ASSOCIATES) South Penn Plaza, Suite 404 New York, NY 10001 Phone: 212-608-9090 Fax: 212-608-9099	
IT CONSULTANT: GRID ASSOCIATES, LLC P.O. Box 1700 Hicksville, NY 11743 T 516.722.6600 / F 516.722.6625	
SUSTAINABILITY LEAD: YR&G 161 Bowery - 4th Floor, New York, NY 10002 T 917.677.8023 / F 917.677.8023	
COST ESTIMATING CONSULTANT: TOSCANO CLEMENTS TAYLOR, LLC 16 Oakwood Road Huntington, NY 11743 T 631.392.1400 / F 631.392.1399	


C.I.T.L. PROJ. # 29402 SUNY PURCHASE COLLEGE 735 ANDERSON HILL ROAD PURCHASE, NY 10577	
DRAWING TITLE: AUDIOVISUAL-FACILITY - CITL BUILDING 2ND FLOOR (PLAZA +1 LEVEL) PLAN	
Seal:	Drawn: AUC Checked: BJM Reviewed: BJM Date:
Project No.: 29402 (SUCF) / 09018.L00 (FXP) Cad File: Drawing No.: Scale: 1/8" = 1'-0"	
TA-114.0	

V
U
T
S
R
Q
P
N
M
L
K
J
H
G
F
E
D
C
B
A

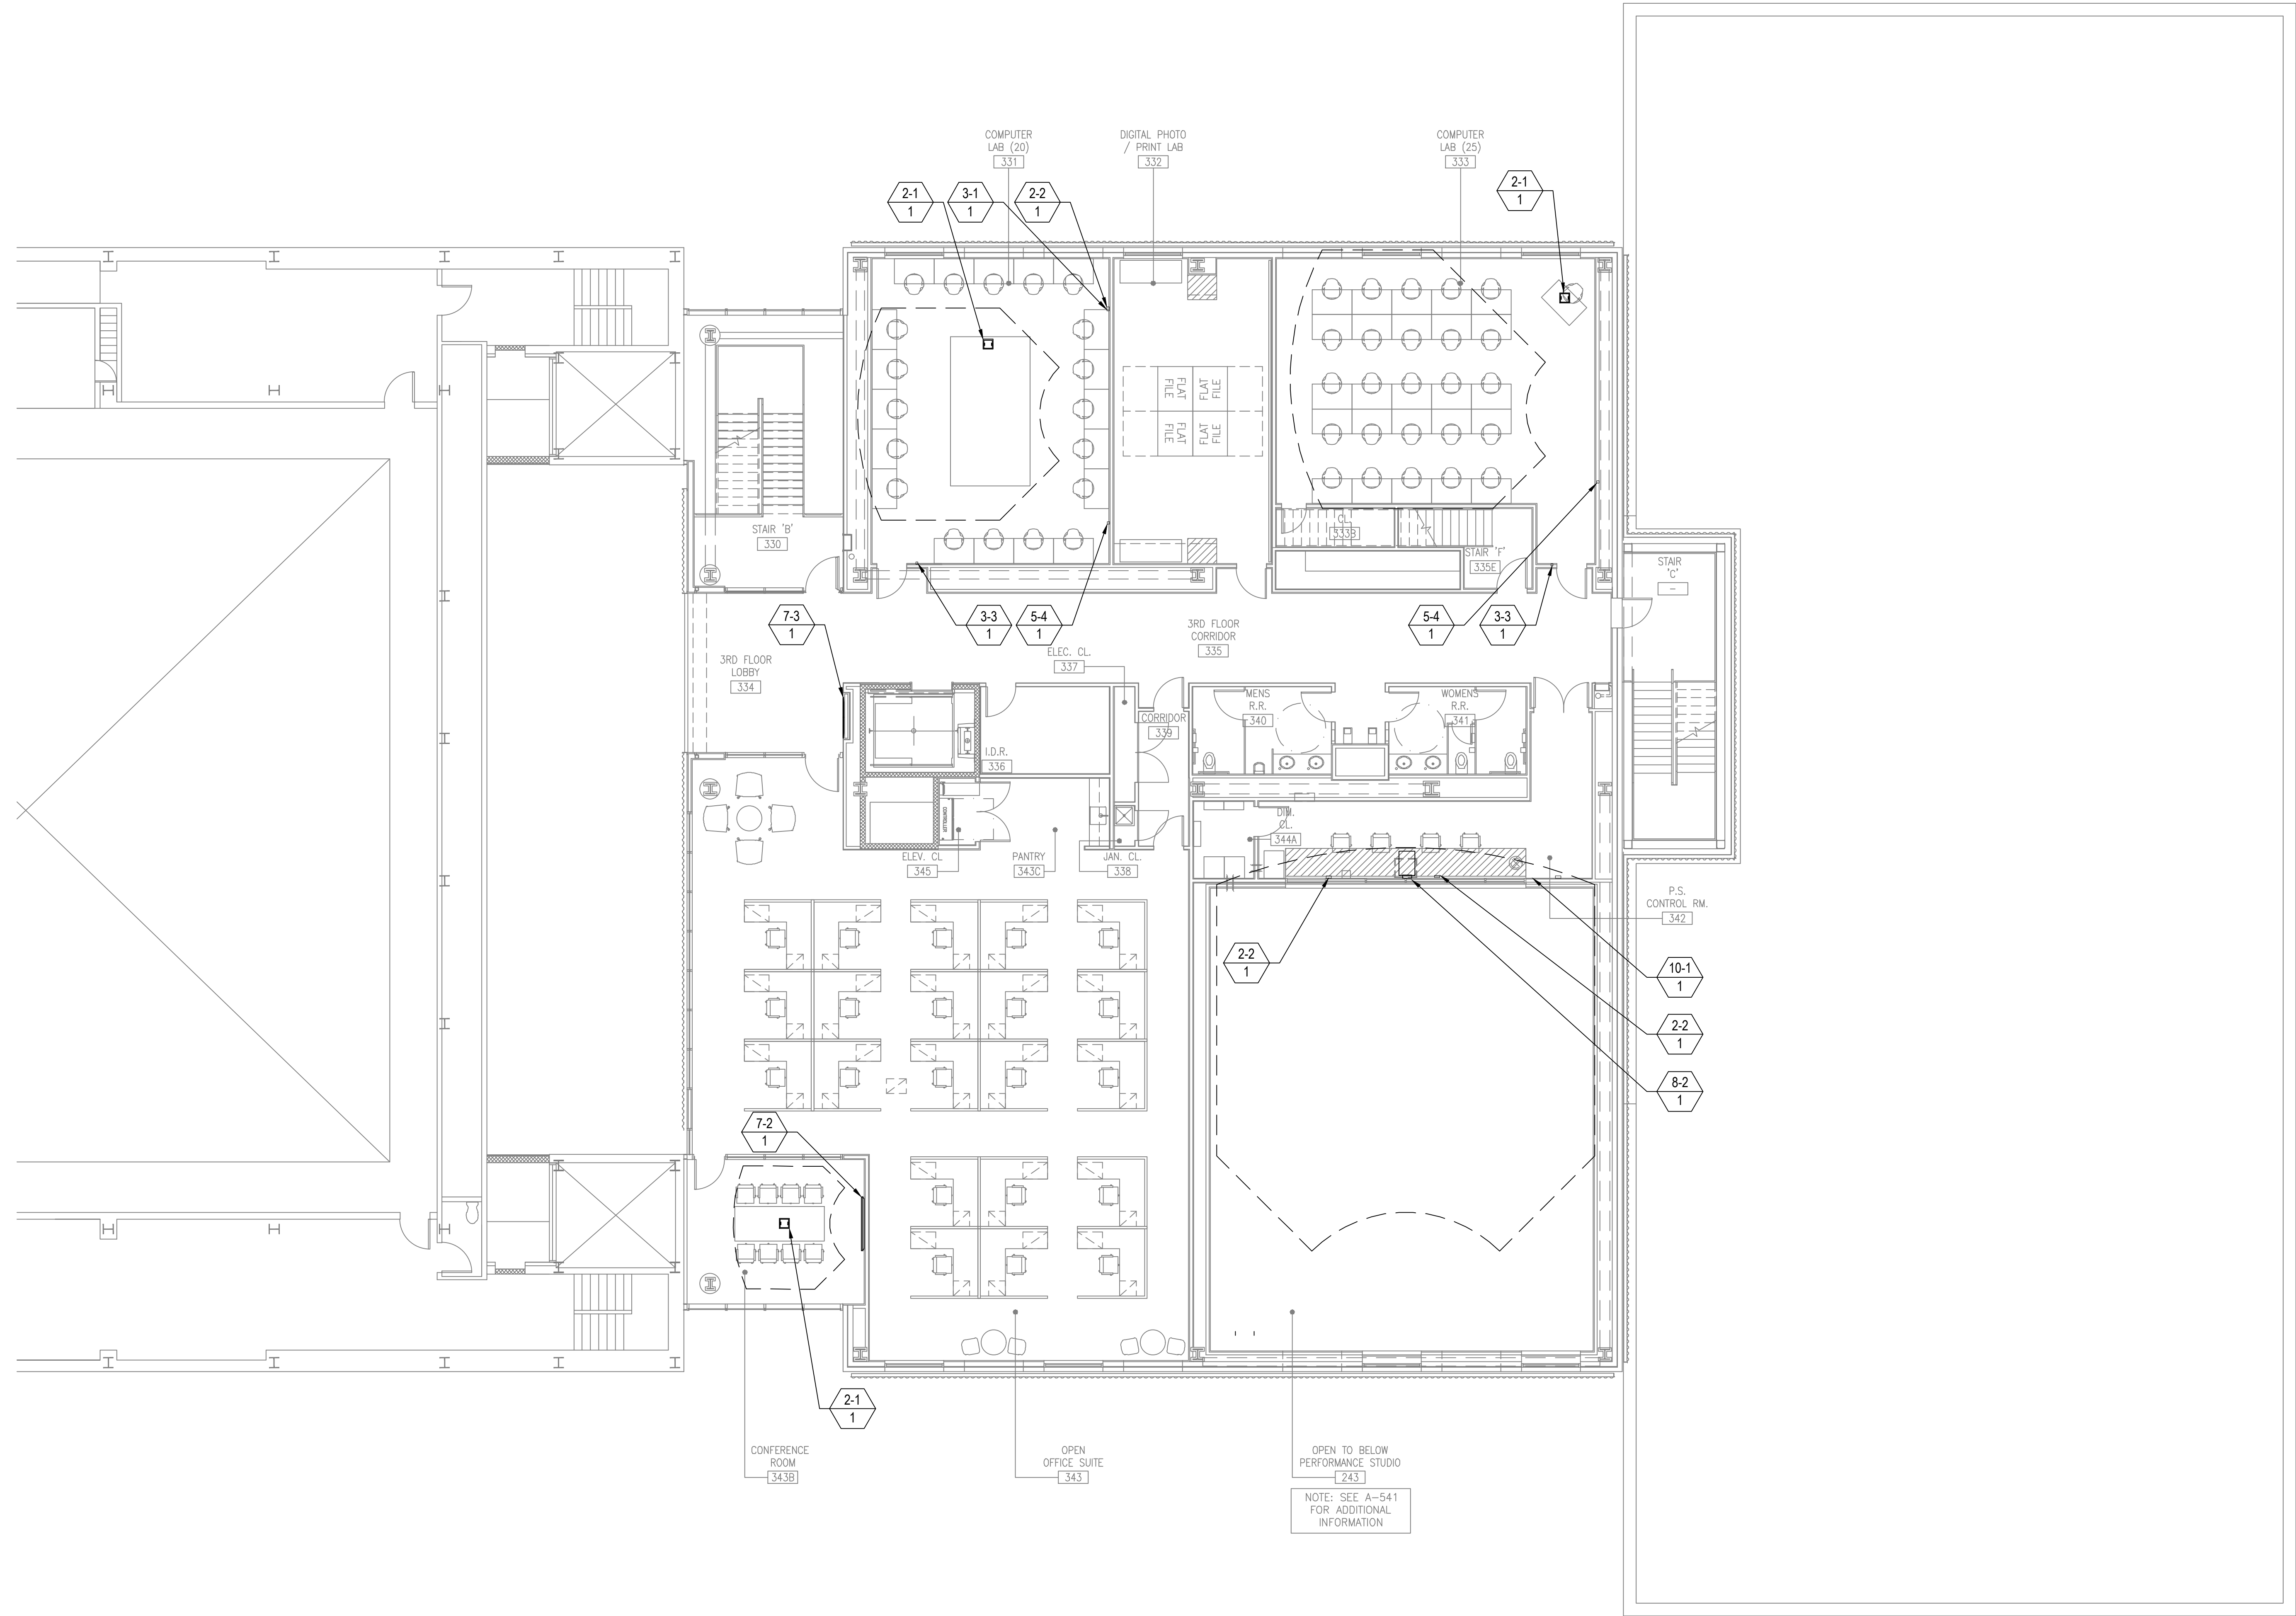

FACILITY KEYNOTE LEGEND	
	EQUIPMENT RACKS: 1-1 Full Height
	CONNECTIVITY: 2-1 Floor Box 2-2 Wall Plate 2-3 Access Point at Ceiling Pipe Grid
	CONTROL/SCHEDULING: 3-1 Wall Mounted Controller 3-2 Volume Controller 3-3 Raise Lower Switch
	AUDIO INPUT: 4-1 Wireless Microphone Antenna
	AUDIO OUTPUT: 5-1 Ceiling Recessed Loudspeaker 5-2 Portable speaker Mounted on Pipe Grid 5-2A Portable Speaker Mounted on Catwalk 5-3 Portable Subwoofer Loudspeaker Mounted on Pipe Grid 5-4 Assistive Listening Emitter/Antenna 5-5 Ceiling Hanging Pendant Speaker
	VIDEO ORIGIN/SOURCE: 6-1 LOW LIGHT VIDEO CAMERA
	VIDEO DISPLAY (Type 1): 7-1 (70") Wall Mounted Flat Panel Display 7-2 (55") Wall Mounted Flat Panel Display 7-3 (55") Wall Mounted Digital Signage Display 7-4 (46") Wall Mounted Flat Panel Display
	VIDEO DISPLAY (Type 2): 8-1 Video Projector; Pole Mounted 8-2 Video Projector; Fixed at Projection Booth 8-3 Video Projector; OFE
	VIDEO DISPLAY (Type 3): 9-1 (50"Hx80"W) Ceiling Recessed Front Projection Screen 9-1A (50"Hx80"W) Wall Mounted Front Projection Screen 9-2 (144"Hx256"W) Ceiling Mounted Suspended Front Projection Screen. See TV and TR drawings for exact rigging details and locations. 9-3 120" x 213" Ceiling Recessed Front Projection Screen 9-4 (65" X 116) Ceiling Recessed Front Projection Screen 9-5 Painted projection surface 9-6 57.5" x 92" Ceiling Recessed Front Projection Screens 9-7 108" x 192" Ceiling Mounted Suspended Front Projection Screen. See TV and TR drawings for exact rigging details and locations.

MATERIAL KEYING LEGEND:

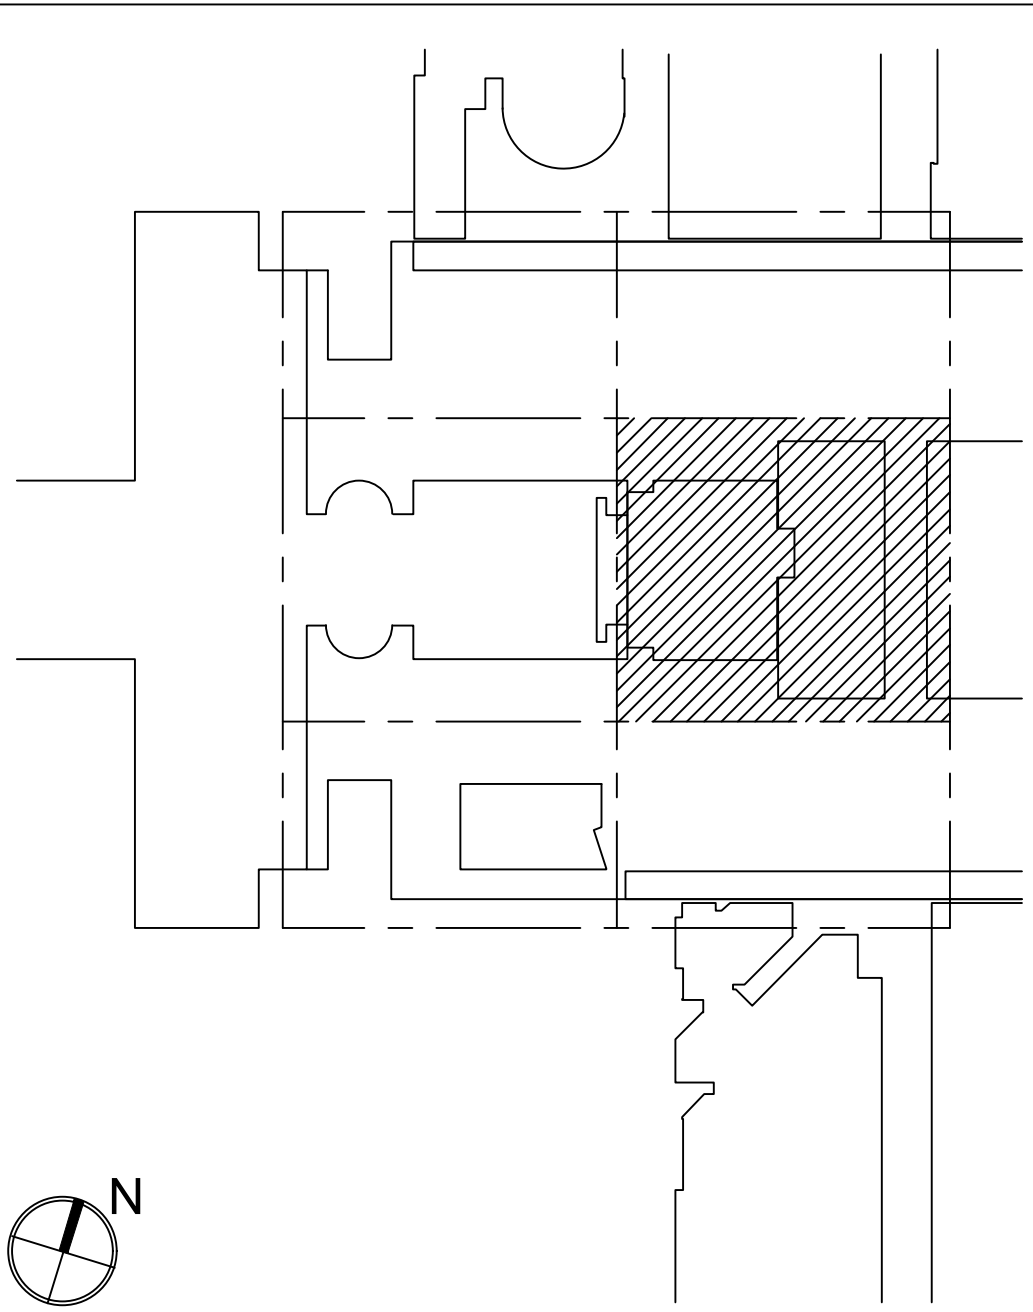

KEY PLAN

5	GROUP III AV BID DOCUMENTS	09.06.2017
2	BID DOCUMENTS	05.28.2014
1	DESIGN MANUAL PHASE SUBMISSION	04.01.2013
NO.	REVISIONS / SUBMISSIONS	DATE

FX FOWLE

FX FOWLE ARCHITECTS, LLP | 22 WEST 10TH STREET | NEW YORK, NY 10011 | T 212.627.1700 | F 212.453.8716 | WWW.FX FOWLE.COM
DESIGN/ARCHITECTS:
DESIMONE CONSULTING ENGINEERS
18 West 18th Street, 10th Floor, New York, New York 10011 212-532-2211

MECHANICAL, ELECTRICAL, PLUMBING, FIRE PROTECTION ENGINEER:
COLLADO ENGINEERING
2 Hickland Avenue, White Plains, NY 10603 914-332-7658

THEATER PLANNING CONSULTANT:
FISHER DACHS ASSOCIATES
22 West 10th Street, 8th Floor, New York, NY 10011 212-691-3020

ACQUISITION & AUDIO VISUAL CONSULTANT:
CERAMI & ASSOCIATES
404 Fifth Avenue, New York, NY 10018 212-370-1776

LIGHTING CONSULTANT:
ILLUMINATION ARTS
600 Bloomfield Avenue, Suite 101, Bloomfield NJ 07003 973-771-1558

LANDSCAPE CONSULTANT:
W ARCHITECTURE & LANDSCAPE ARCHITECTURE, LLC
105 Fifth Avenue Third Floor New York, NY 10010 P 212-951-3533 F 212-620-0758

CIVIL ENGINEER & LANDMARK:
LANGAN
21 Penn Plaza 360 West 31st Street 8th Floor New York, NY 10001 212-479-5400 212-479-5444 (fax)

ELEVATOR CONSULTANT:
VDA (VAN DEUSEN & ASSOCIATES)
Seven Penn Plaza, Suite 404 New York, NY 10001 Phone: 212-608-9090 Fax: 212-608-9099

IT CONSULTANT:
GRID ASSOCIATES, LLC
P.O. Box 1700 Hicksville, NY 11743 T 516.722.6600 / F 516.722.6625

SUSTAINABILITY LEAD:
YR&G
161 Bowery - 4th Floor, New York, NY 10002 T 917.677.8023 / F 917.677.8023


COST ESTIMATING CONSULTANT:
TOSCANO CLEMENTS TAYLOR, LLC
16 Oakwood Road Huntington, NY 11743 T 631.392.1400 / F 631.392.1399

C.I.T.L. PROJ. # 29402
SUNY PURCHASE COLLEGE
735 ANDERSON HILL ROAD | PURCHASE, NY 10577

DRAWING TITLE:
AUDIOVISUAL-FACILITY - CITL BUILDING
3RD FLOOR (PLAZA +2 LEVEL) PLAN

Seal:	Drawn: AJC	Project No.: 29402 (SUCF) / 09018.L00 (FXF)
	Checked: BJM	Cost File:
	Reviewed: BJM	Drawing No.:
	Date:	
Scale: 1/8" = 1'-0"		

TA-115.0


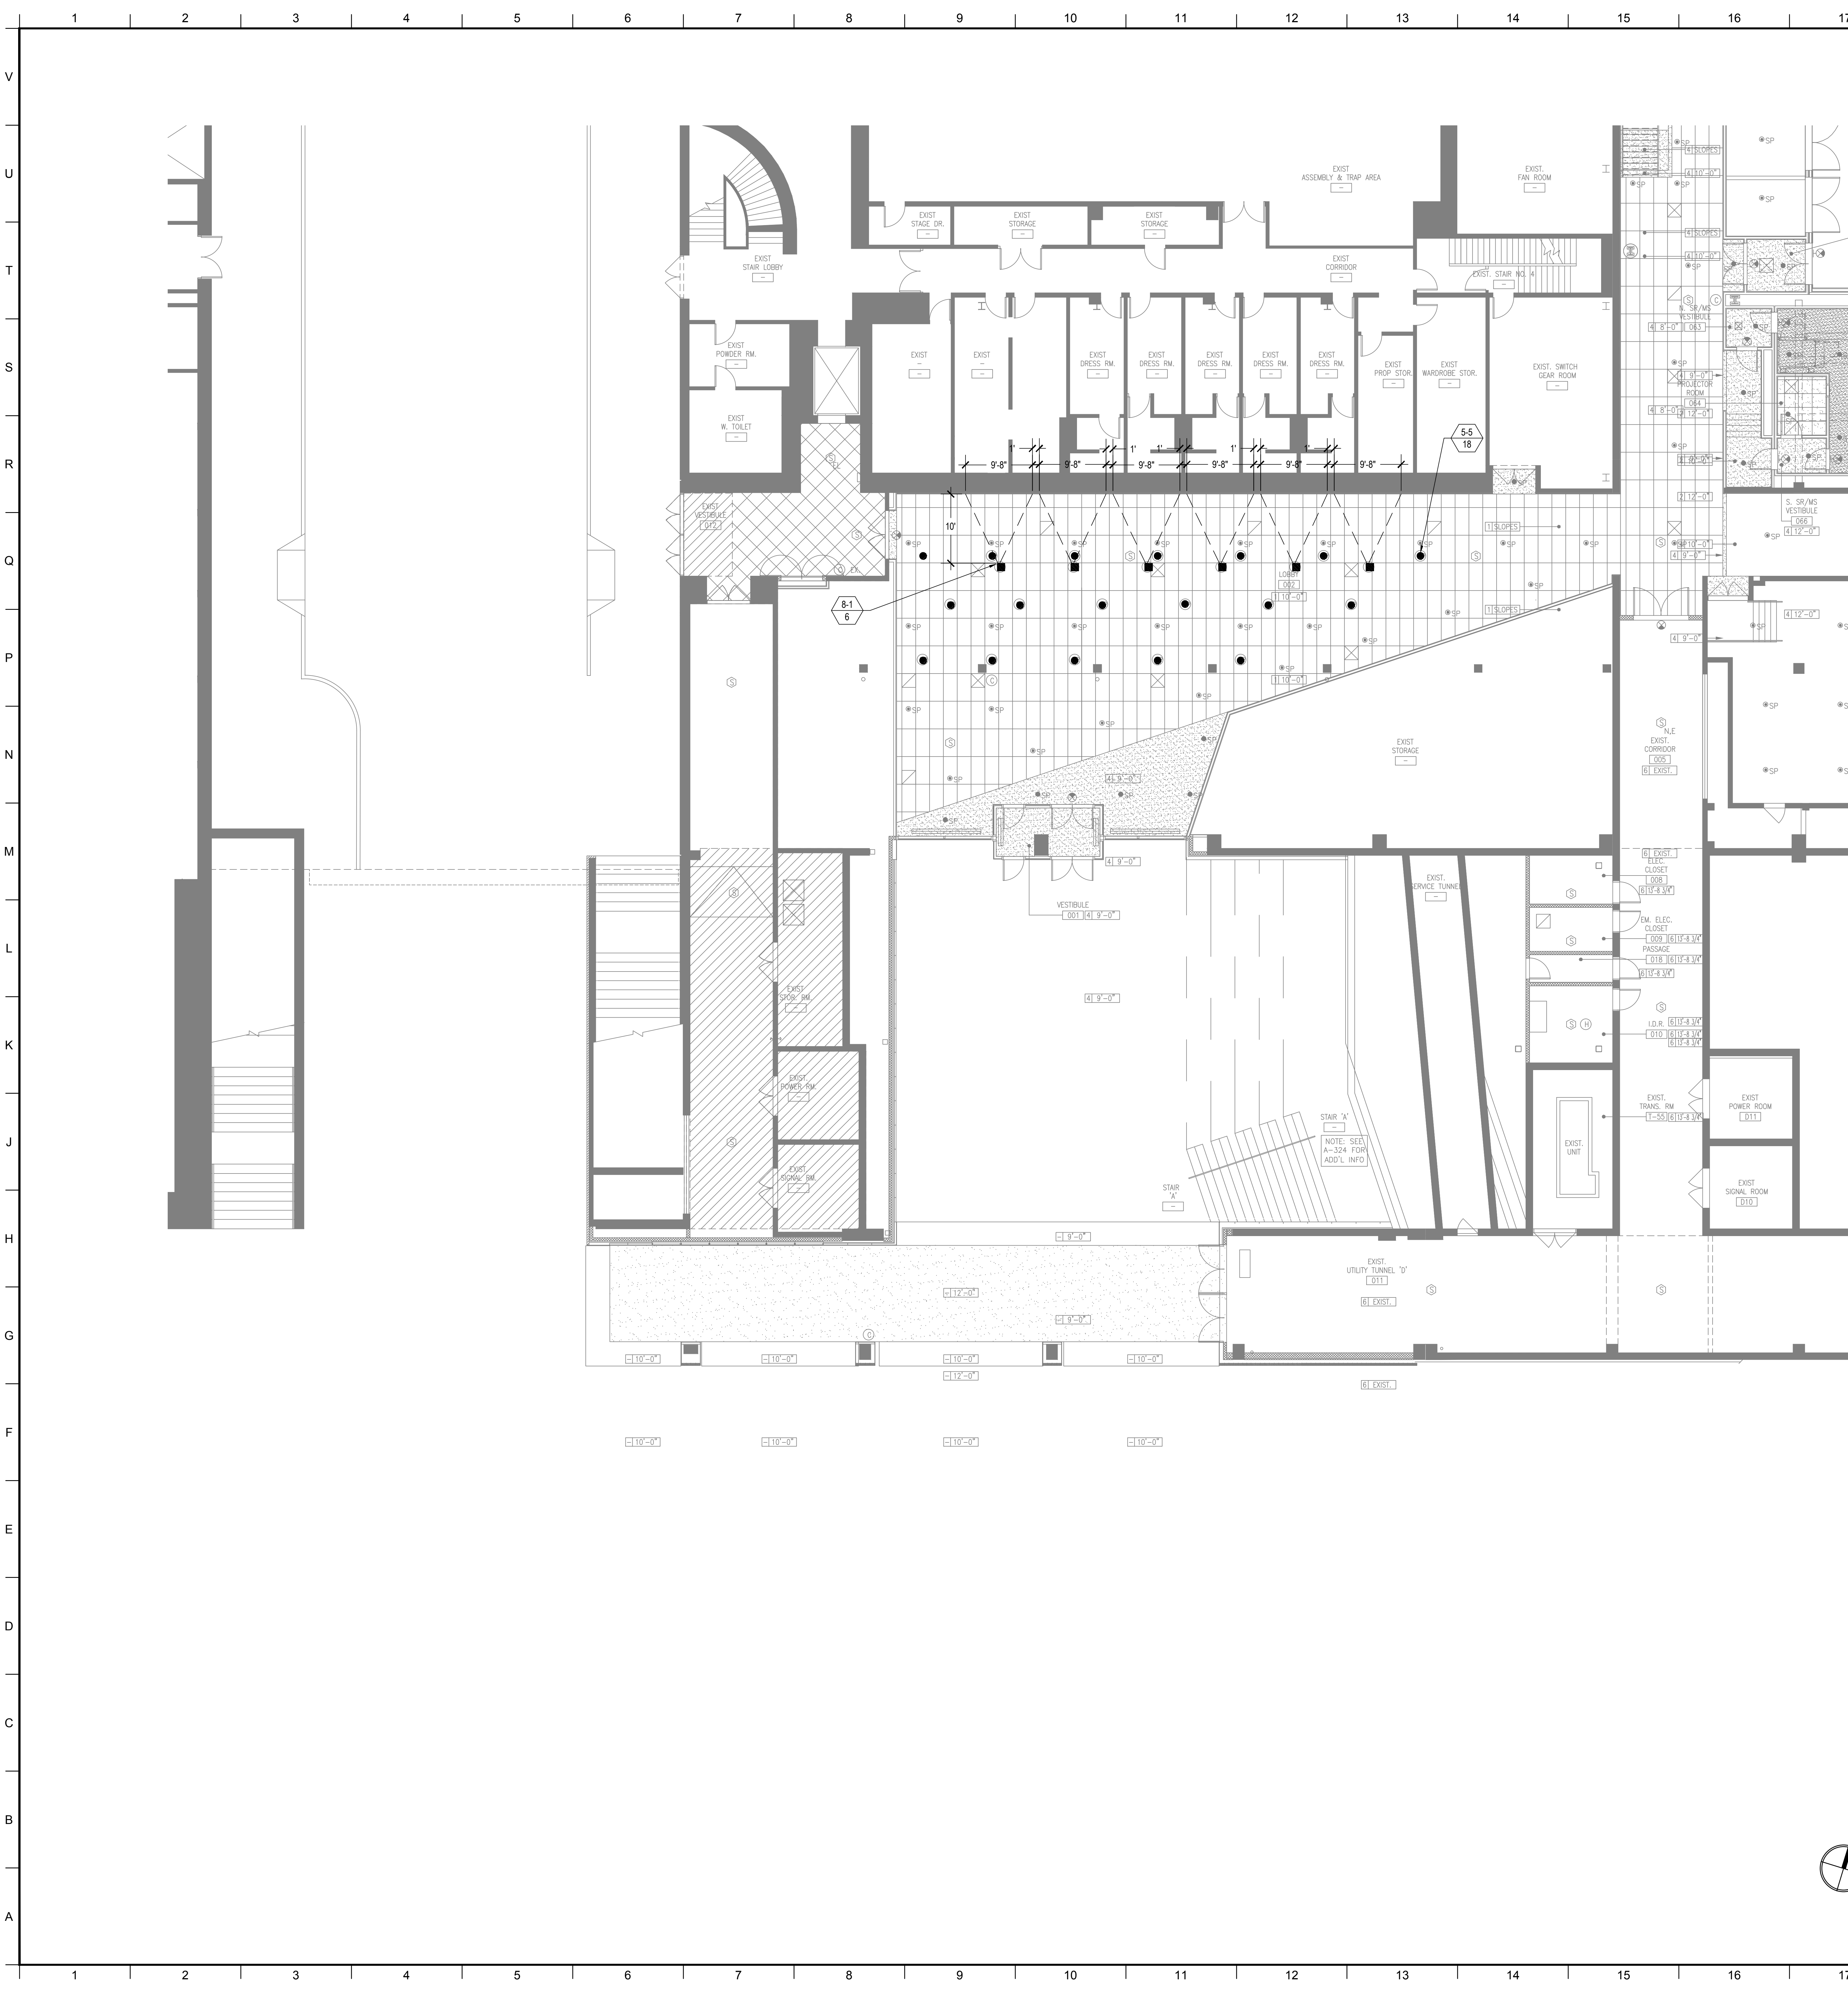


FACILITY KEYNOTE LEGEND

1-# QTY	EQUIPMENT RACKS: 1-1 Full Height
2-# QTY	CONNECTIVITY: 2-1 Floor Box 2-2 Wall Plate 2-3 Access Point at Ceiling Pipe Grid
3-# QTY	CONTROL/SCHEDULING: 3-1 Wall Mounted Controller 3-2 Volume Controller 3-3 Raise Lower Switch
4-# QTY	AUDIO INPUT: 4-1 Wireless Microphone Antenna
5-# QTY	AUDIO OUTPUT: 5-1 Ceiling Recessed Loudspeaker 5-2 Portable speaker Mounted on Pipe Grid 5-2A Portable Speaker Mounted on Catwalk 5-3 Portable Subwoofer Loudspeaker Mounted on Pipe Grid 5-4 Assistive Listening Emitter/Antenna 5-5 Ceiling Hanging Pendant Speaker
6-# QTY	VIDEO ORIGIN/SOURCE: 6-1 LOW LIGHT VIDEO CAMERA
7-# QTY	VIDEO DISPLAY (Type 1): 7-1 (70") Wall Mounted Flat Panel Display 7-2 (65") Wall Mounted Flat Panel Display 7-3 (65") Wall Mounted Digital Signage Display 7-4 (46") Wall Mounted Flat Panel Display
8-# QTY	VIDEO DISPLAY (Type 2): 8-1 Video Projector; Pole Mounted 8-2 Video Projector; Fixed at Projection Booth 8-3 Video Projector; OFE
9-# QTY	VIDEO DISPLAY (Type 3): 9-1 (50"x80"W) Ceiling Recessed Front Projection Screen 9-1A (50"x80"W) Wall Mounted Front Projection Screen 9-2 (144"x256"W) Ceiling Mounted Suspended Front Projection Screen. See TV and TR drawings for exact rigging details and locations. 9-3 120" x 213" Ceiling Recessed Front Projection Screen 9-4 (65" X 116) Ceiling Recessed Front Projection Screen 9-5 Painted projection surface 9-6 57.5" x 92" Ceiling Recessed Front Projection Screens 9-7 108" x 192" Ceiling Mounted Suspended Front Projection Screen. See TV and TR drawings for exact rigging details and locations.
10-# QTY	MISCELLANEOUS: 10-1 Theatrical Intercom

NOTE: EQUIPMENT SHOWN IN THIS SERIES IS FOR REFERENCE AND COORDINATION ONLY AND WILL BE FURNISHED BY THE OWNER. REFER TO GENERAL SPEC SECTION 011110 AND AUDIOVISUAL SPEC SECTION 274000

MATERIAL KEYING LEGEND:

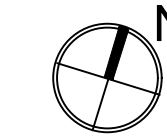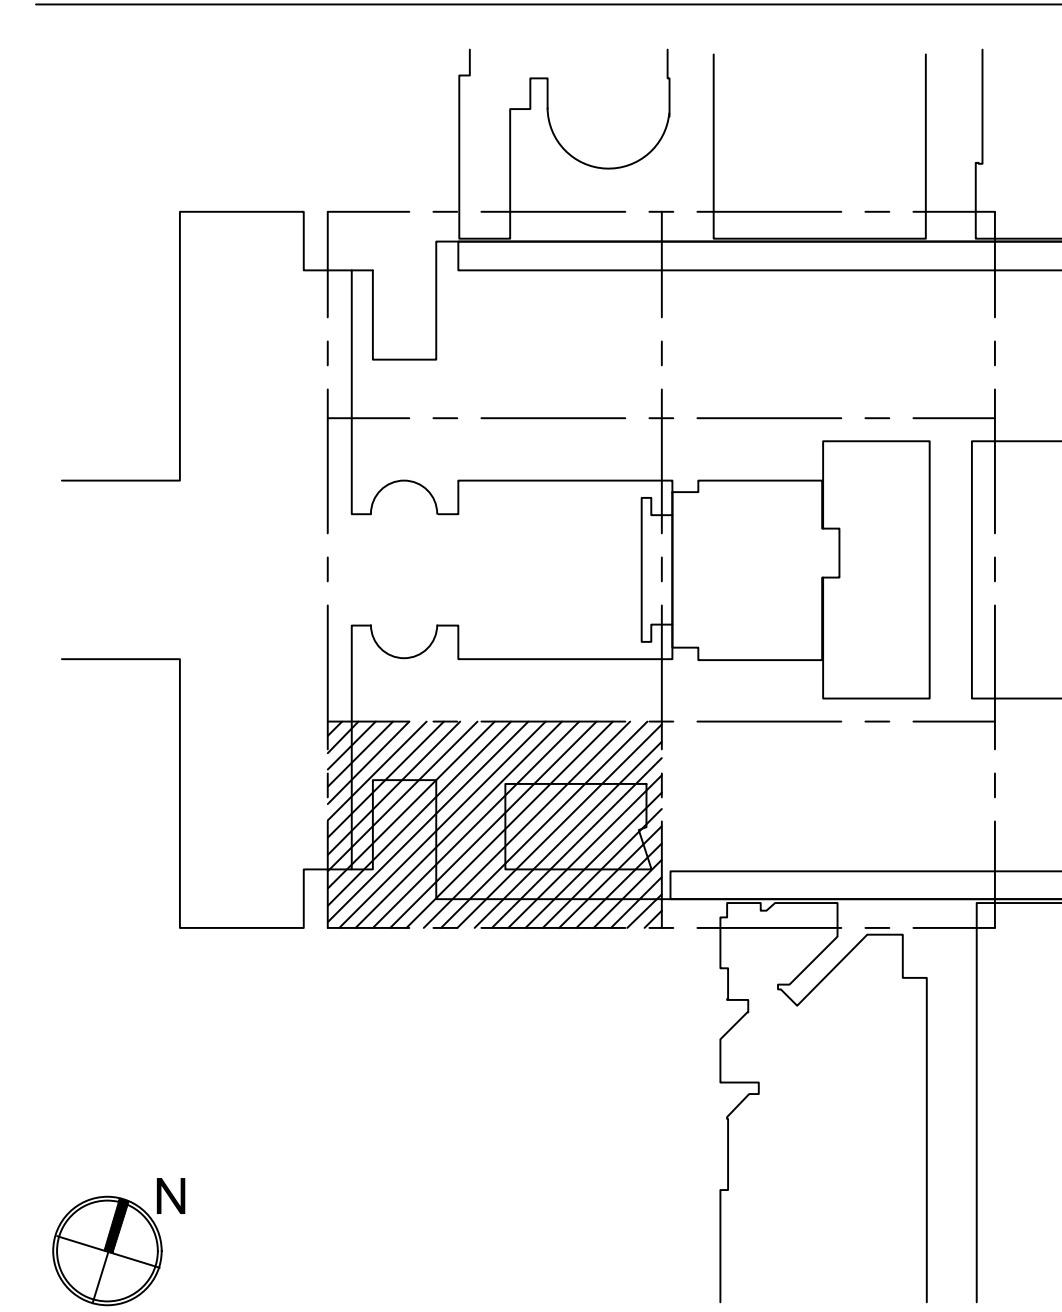

KEY PLAN

5	GROUP III AV BID DOCUMENTS	08.06.2017
2	BID DOCUMENTS	05.28.2014
1	DESIGN MANUAL PHASE SUBMISSION	04.01.2013

NO.	REVISIONS / SUBMISSIONS	DATE
-----	-------------------------	------

FX FOWLE
FX FOWLE ARCHITECTS, LLP | 22 WEST 10TH STREET | NEW YORK, NY 10011 | T 212.427.1700 | F 212.425.8716 | WWW.FX FOWLE.COM

MECHANICAL ENGINEERS:
DISMONE CONSULTING ENGINEERS
18 West 18th Street, 10th Floor, New York, New York 10011 212-532-2211

MECHANICAL, ELECTRICAL, PLUMBING, FIRE PROTECTION ENGINEER:
COLLADO ENGINEERING
2 Holland Avenue, White Plains, NY 10603 914-332-7658

THEATER PLANNING CONSULTANT:
FISHER DACHS ASSOCIATES
22 West 10th Street, 8th Floor, New York, NY 10011 212-691-3020

ACoustics & AUDIO VISUAL CONSULTANT:
CERAMI & ASSOCIATES
404 Fifth Avenue, New York, NY 10018 212-370-1776

LIGHTING CONSULTANT:
ILLUMINATION ARTS
650 Bloomfield Avenue, Suite 101, Bloomfield NJ 07003 973-771-1558

LANDSCAPE CONSULTANT:
W ARCHITECTURE & LANDSCAPE ARCHITECTURE, LLC
105 Fifth Avenue, Third Floor New York, NY 10010 P 212-951-3533 F 212-620-0758

Civil ENGINEER & LANDSCAPE:
LANGAN
21 Penn Plaza 360 West 31st Street 8th Floor New York, NY 10001 212-479-5400 212-479-5444 (fax)

ELEVATOR CONSULTANT:
VDA (VAN DEUSEN & ASSOCIATES)
Seven Penn Plaza, Suite 404 New York, NY 10001 Phone: 212-808-9090 Fax: 212-808-9099

IT CONSULTANT:
GRID ASSOCIATES, LLC
P.O. Box 1770 Hoboken, NJ 07030 T 946.722.0600 / F 946.722.0625

SUSTAINABILITY LEED:
YR&G
161 Bowery - 4th Floor, New York, NY 10002 T 917.677.8023 / F 917.677.8023

COST ESTIMATING CONSULTANT:
TOSCANO CLEMENTS TAYLOR, LLC
16 Oakwood Road Huntington, NY 11743 T 631.392.1400 / F 631.392.1399

C.I.T.L. PROJ. # 29402
SUNY PURCHASE COLLEGE
735 ANDERSON HILL ROAD | PURCHASE, NY 10577


DRAWING TITLE:
AUDIOVISUAL-FACILITY - ENTRY PAVILION CONCOURSE (BASEMENT LEVEL) RCP

Seal:	Drawn: AJC	Project No.: 20402 (SUCC) / 05018.L00 (FXP)
	Checked: BJM	Coord File:
	Reviewed: BJM	Drawing No.:
	Date:	

TA-202.0

V
U
T
S
R
Q
P
N
M
L
K
J
H
G
F
E
D
C
B
A


1 2 3 4 5 6 7 8 9 10 11 12 13 14 15 16 17 18 19 20

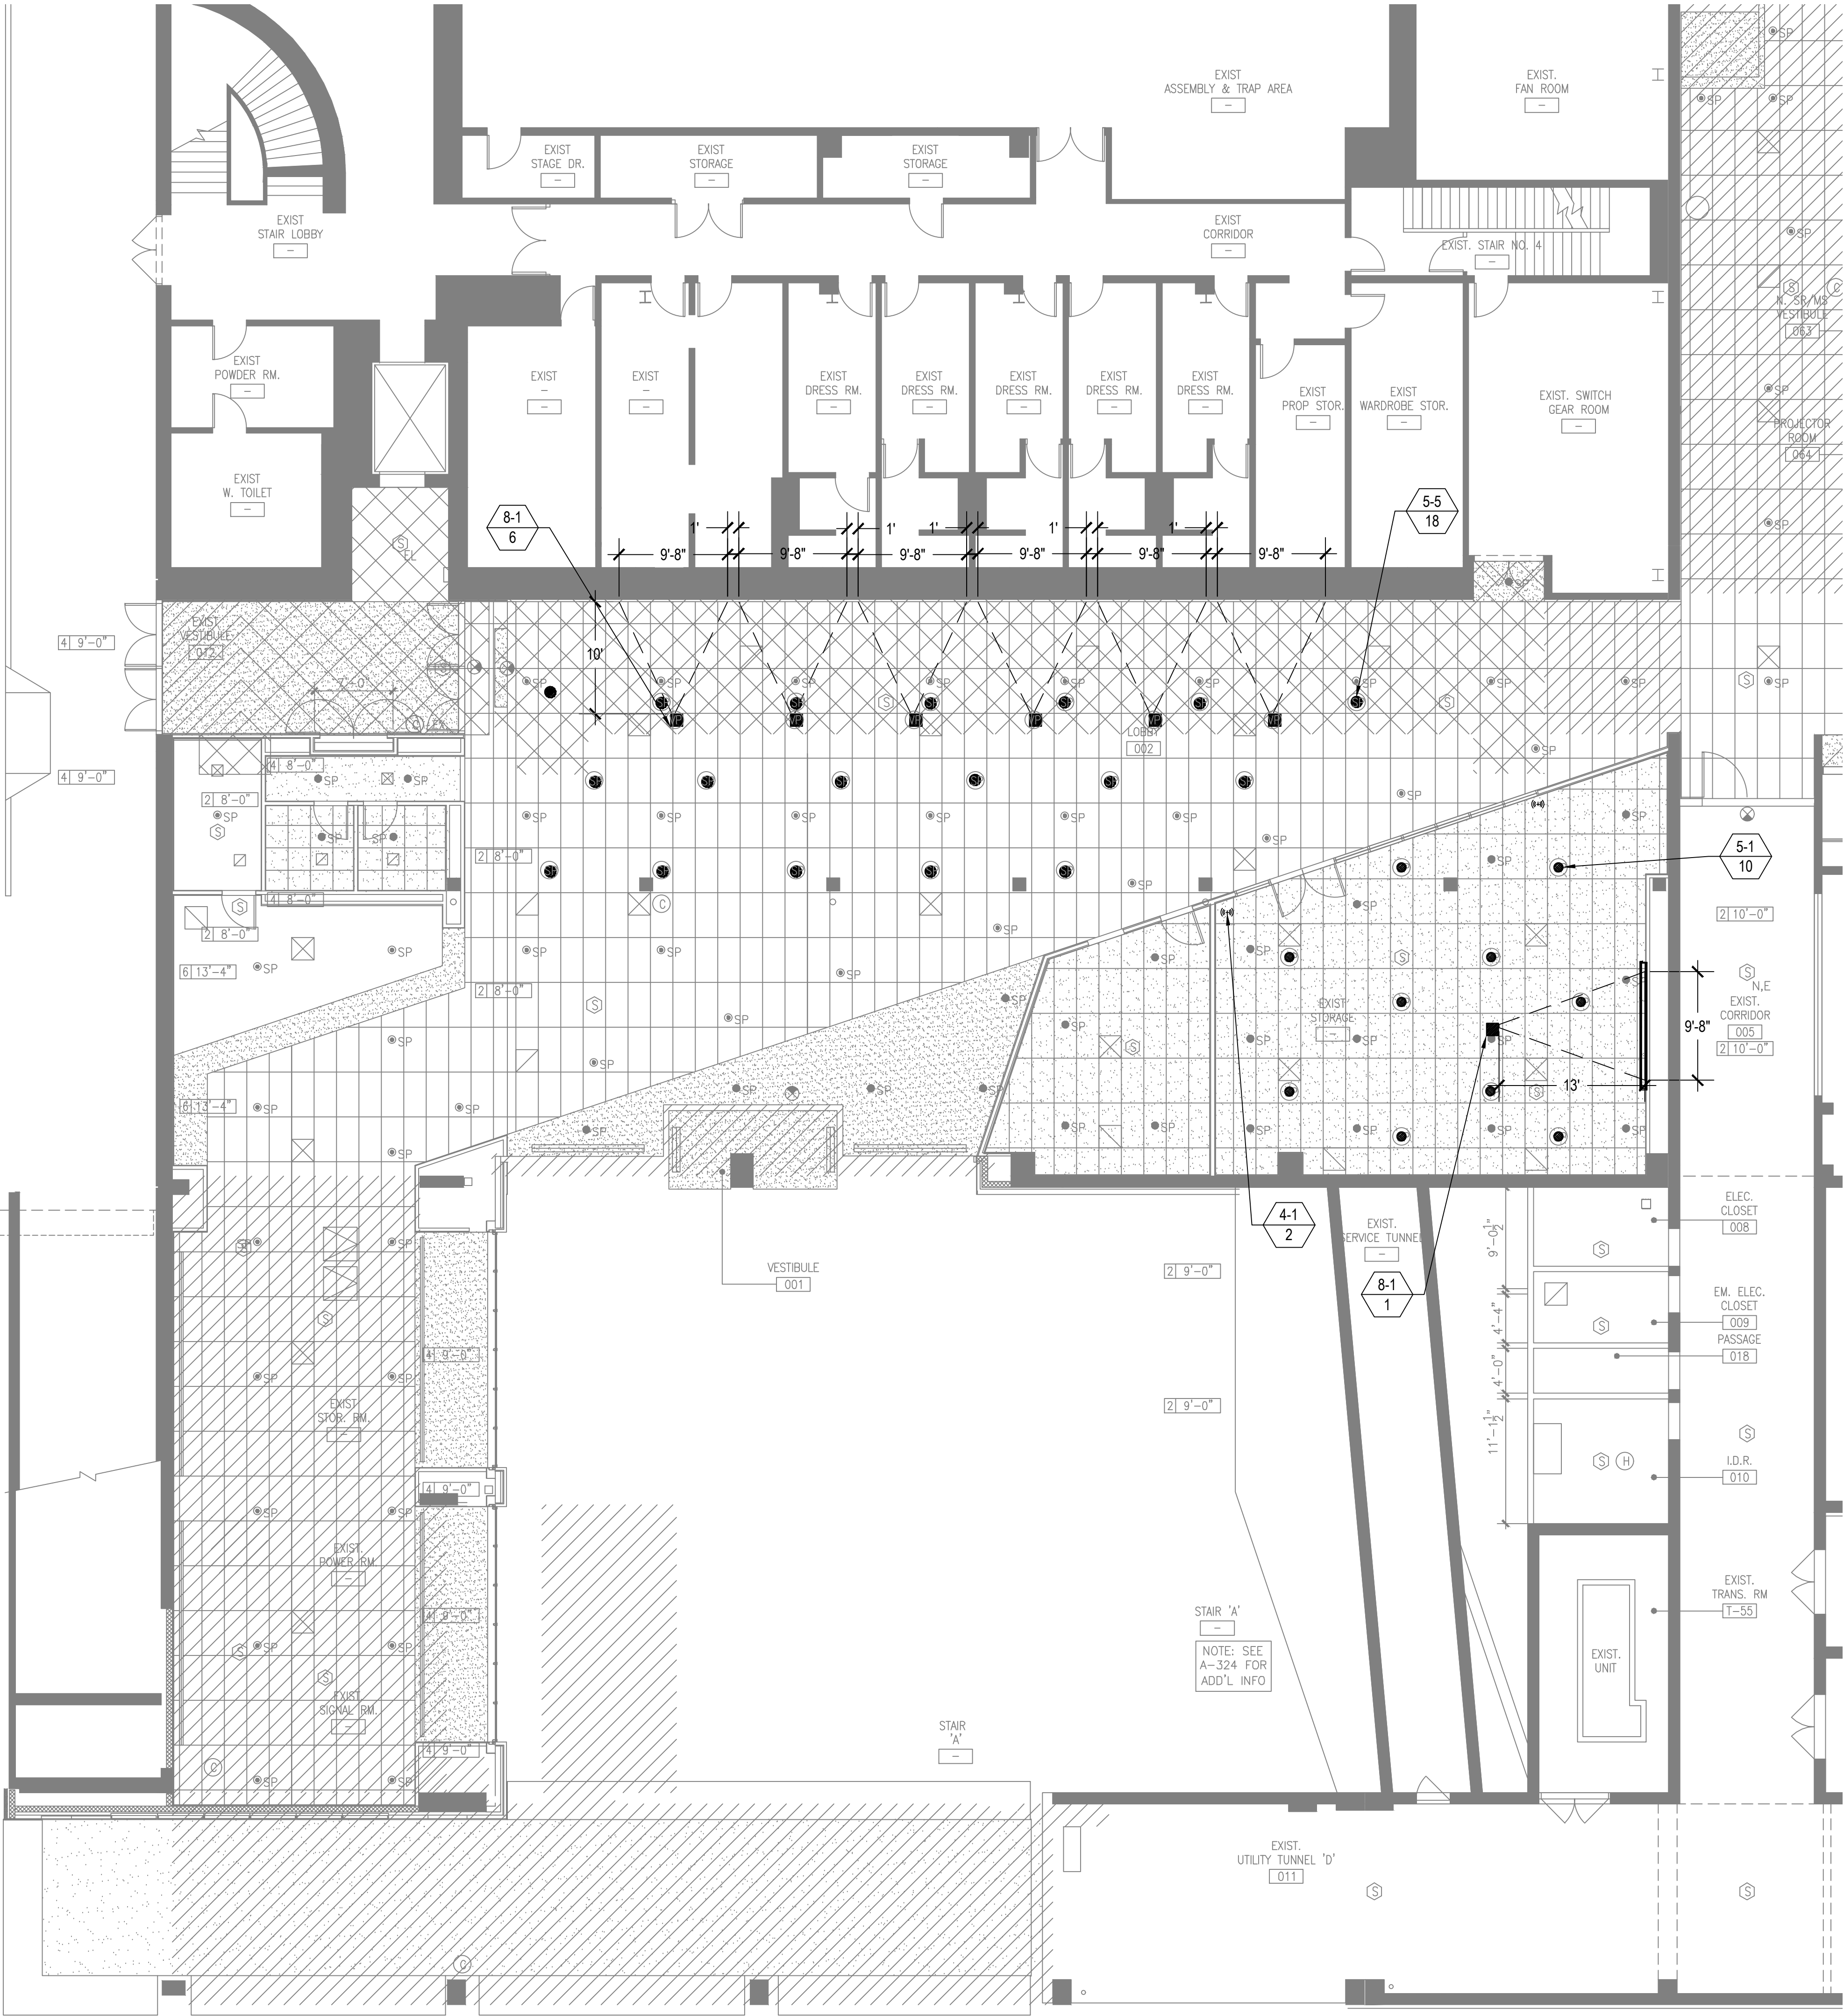

FACILITY KEYNOTE LEGEND

	EQUIPMENT RACKS: 1-1 Full Height
	CONNECTIVITY: 2-1 Floor Box 2-2 Wall Plate 2-3 Access Point at Ceiling Pipe Grid
	CONTROL/SCHEDULING: 3-1 Wall Mounted Controller 3-2 Volume Controller 3-3 Raise Lower Switch
	AUDIO INPUT: 4-1 Wireless Microphone Antenna
	AUDIO OUTPUT: 5-1 Ceiling Recessed Loudspeaker 5-2 Portable speaker Mounted on Pipe Grid 5-2A Portable Speaker Mounted on Catwalk 5-3 Portable Subwoofer Loudspeaker Mounted on Pipe Grid 5-4 Assistive Listening Emitter/Antenna 5-5 Ceiling Hanging Pendant Speaker
	VIDEO ORIGIN/SOURCE: 6-1 LOW LIGHT VIDEO CAMERA
	VIDEO DISPLAY (Type 1): 7-1 (70") Wall Mounted Flat Panel Display 7-2 (55") Wall Mounted Flat Panel Display 7-3 (55") Wall Mounted Digital Signage Display 7-4 (46") Wall Mounted Flat Panel Display
	VIDEO DISPLAY (Type 2): 8-1 Video Projector; Pole Mounted 8-2 Video Projector; Fixed at Projection Booth 8-3 Video Projector; OFE
	VIDEO DISPLAY (Type 3): 9-1 (50"Hx80"W) Ceiling Recessed Front Projection Screen 9-1A (50"Hx80"W) Wall Mounted Front Projection Screen 9-2 (144"Hx256"W) Ceiling Mounted Suspended Front Projection Screen. See TV and TR drawings for exact rigging details and locations. 9-3 120" x 213" Ceiling Recessed Front Projection Screen 9-4 (65" X 116) Ceiling Recessed Front Projection Screen 9-5 Painted projection surface 9-6 57.5" x 92" Ceiling Recessed Front Projection Screens 9-7 108" x 192" Ceiling Mounted Suspended Front Projection Screen. See TV and TR drawings for exact rigging details and locations.

MATERIAL KEYING LEGEND:

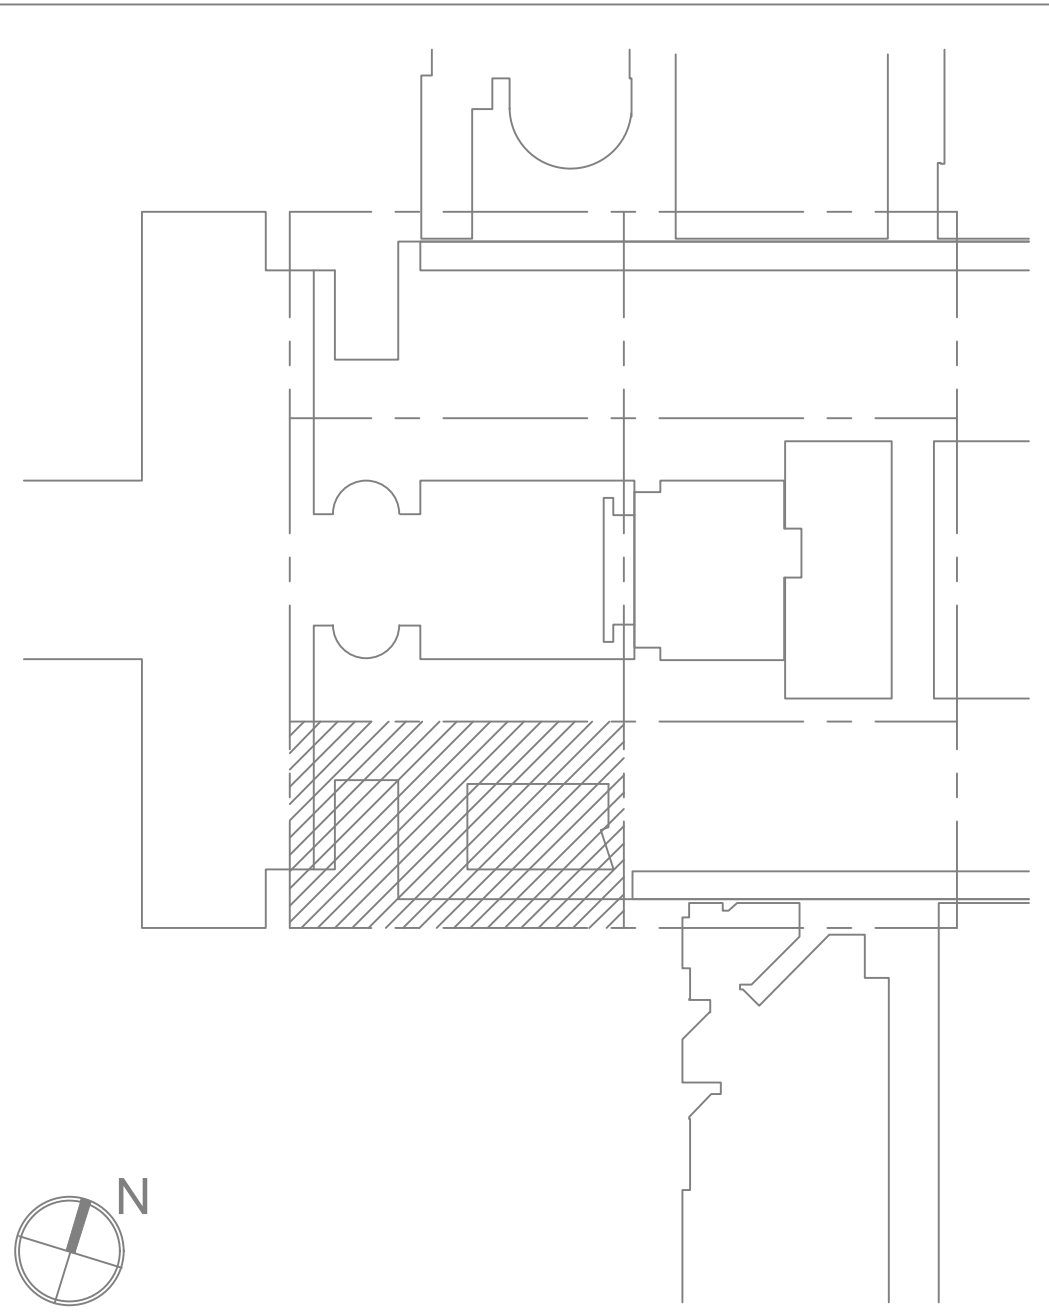

KEY PLAN

5	GROUP III AV BID DOCUMENTS	09.06.2017
2	DESIGN MANUAL PHASE SUBMISSION	04.01.2013
1	30% PRICING SET	03.07.2013

NO.	REVISIONS / SUBMISSIONS	DATE
-----	-------------------------	------

FX FOWLE
FX FOWLE ARCHITECTS, LLP | 22 WEST 10TH STREET | NEW YORK, NY 10011 | T 212.427.1700 | F 212.453.8716 | WWW.FX FOWLE.COM

MECHANICAL ENGINEERS:
DESMONE CONSULTING ENGINEERS
18 West 18th Street, 10th Floor, New York, New York 10011 212-532-2211

MECHANICAL, ELECTRICAL, PLUMBING, FIRE PROTECTION ENGINEER:
COLLADO ENGINEERING
2 Holland Avenue, White Plains, NY 10603 914-332-7658

THEATER PLANNING CONSULTANT:
FISHER DACHS ASSOCIATES
22 West 10th Street, 8th Floor, New York, NY 10011 212-691-3020

ACoustics & AUDIO VISUAL CONSULTANT:
CERAMI & ASSOCIATES
404 Fifth Avenue, New York, NY 10018 212-370-1776

LIGHTING CONSULTANT:
ILLUMINATION ARTS
600 Bloomfield Avenue, Suite 101, Bloomfield NJ 07003 973-771-1558

LANDSCAPE CONSULTANT:
W ARCHITECTURE & LANDSCAPE ARCHITECTURE, LLC
105 Fifth Avenue Third Floor New York, NY 10010 P 212-961-3533 F 212-623-0798

Civil ENGINEER & LANDSCAPE:
LANGAN
21 Penn Plaza 360 West 31st Street 8th Floor New York, NY 10001 212-479-5400 212-479-5444 (fax)

ELEVATOR CONSULTANT:
VDA (VAN DEUSEN & ASSOCIATES)
Seven Penn Plaza, Suite 404 New York, NY 10001 Phone: 212-808-9090 Fax: 212-808-9099

IT CONSULTANT:
GRID ASSOCIATES, LLC
P.O. Box 1770 Hoboken, NJ 07030 T 946.722.6600 / F 946.722.6625

SUSTAINABILITY LEED:
YR&G
161 Bowery - 4th Floor, New York, NY 10002 T 917.677.8023 / F 917.677.8023

COST ESTIMATING CONSULTANT:
TOSCANO CLEMENTS TAYLOR, LLC
16 Oakwood Road Huntington, NY 11743 T 631.392.1400 / F 631.392.1399


C.I.T.L. PROJ. # 29402
SUNY PURCHASE COLLEGE
735 ANDERSON HILL ROAD | PURCHASE, NY 10577

DRAWING TITLE:

AUDIOVISUAL-FACILITY - ENTRY PAVILION
CONCOURSE (BASEMENT LEVEL) RCP

Seal:	Drawn: AJC	Project No.: 29402 (SUCF) / 05018.L00 (FXF)
	Checked: BJM	Call File:
	Reviewed: BJM	Drawing No.:
	Date:	

TA202.0_AA

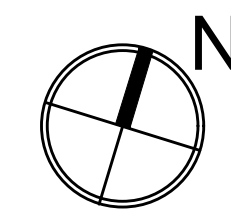

MATERIAL KEYING LEGEND:



Д У Д О В Л Д

F X F O W L E

FXFOWLE ARCHITECTS, LLP | 22 WEST 19TH STREET | NEW YORK, NY 10011 | T 212.627.1700 | F 212.463.8716 | WWW.FXFOWLE.CO

DESIMONE CONSULTING ENGINEERS
18 West 18th Street, 10th Floor, New York, New York 10011, 212-532-2211

MECHANICAL, ELECTRICAL, PLUMBING, FIRE PROTECTION ENGINEER:

COLLADO ENGINEERING
2 Holland Avenue, White Plains, NY 10603 914-332-7658

THEATER PLANNING CONSULTANT
FISHER DACHS ASSOCIATES

22 West 19th Street, 6th Floor, New York, NY 10011 212-691-3020

ACOUSTICS & AUDIO / VISUAL CONSULTANT
CERAMI & ASSOCIATES

LIGHTING CONSULTANT

ILLUMINATION ARTS
850 Bloomfield Avenue, Suite 101, Bloomfield NJ 07003 973-771-1558

LANDSCAPE CONSULTANT

W ARCHITECTURE & LANDSCAPE ARCHITECTURE, LLC
155 Fifth Avenue Third Floor New York, NY 10010 P 212-981-3533 F 212-620-0798

CIVIL ENGINEER & HAZMAT
LANGAN

21 Penn Plaza 360 West 31st Street 8th Floor New York, NY 10001 212.479.5400 212.479.5444 (fax)

ELEVATOR CONSULTANT
VDA (VAN DEUSEN & ASSOCIATES)

IT CONSULTANT

GRID ASSOCIATES, LLC
P.O. Box 1785 Hoboken, NJ 07030 T 646.722.6600 / F 646.722.6625

SUSTAINABILITY / LEED

161 Bowery - 4th Floor, New York, NY 10002 T 917.677.8023 / F 917.677.8023

COST ESTIMATING CONSULTANT
TOSCANO CLEMENTS TAYLOR, LLC

16 Oakwood Road Huntington, NY 11743 T 631.392.1400 / F 631.392.1399

C.I.T.L. PROJ. # 29402

SUNY PURCHASE COLLEGE
735 ANDERSON HILL ROAD PURCHASE, NY 10577

DRAWING TITLE:
AUDIOVISUAL-FACILITY - CITI. BUILDING

CONCOURSE (BASEMENT LEVEL) PLAN

Seal:	Design:	Project No.:
-------	---------	--------------

AJC	29402 (SUCF) / 09018.L00 (FXF)
-----	--------------------------------

Checked: **BJM** Cad File:

Reviewed:	Drawing No.:
BJM	


Date: TA-212.0









Scale:
1/8" = 1'-0"

© 2006 Blackwell Publishing Ltd, *Journal of Internal Medicine* 260: 101–108

TA-212.0

V
U
T
S
R
Q
P
N
M
L
K
J
H
G
F
E
D
C
B
A

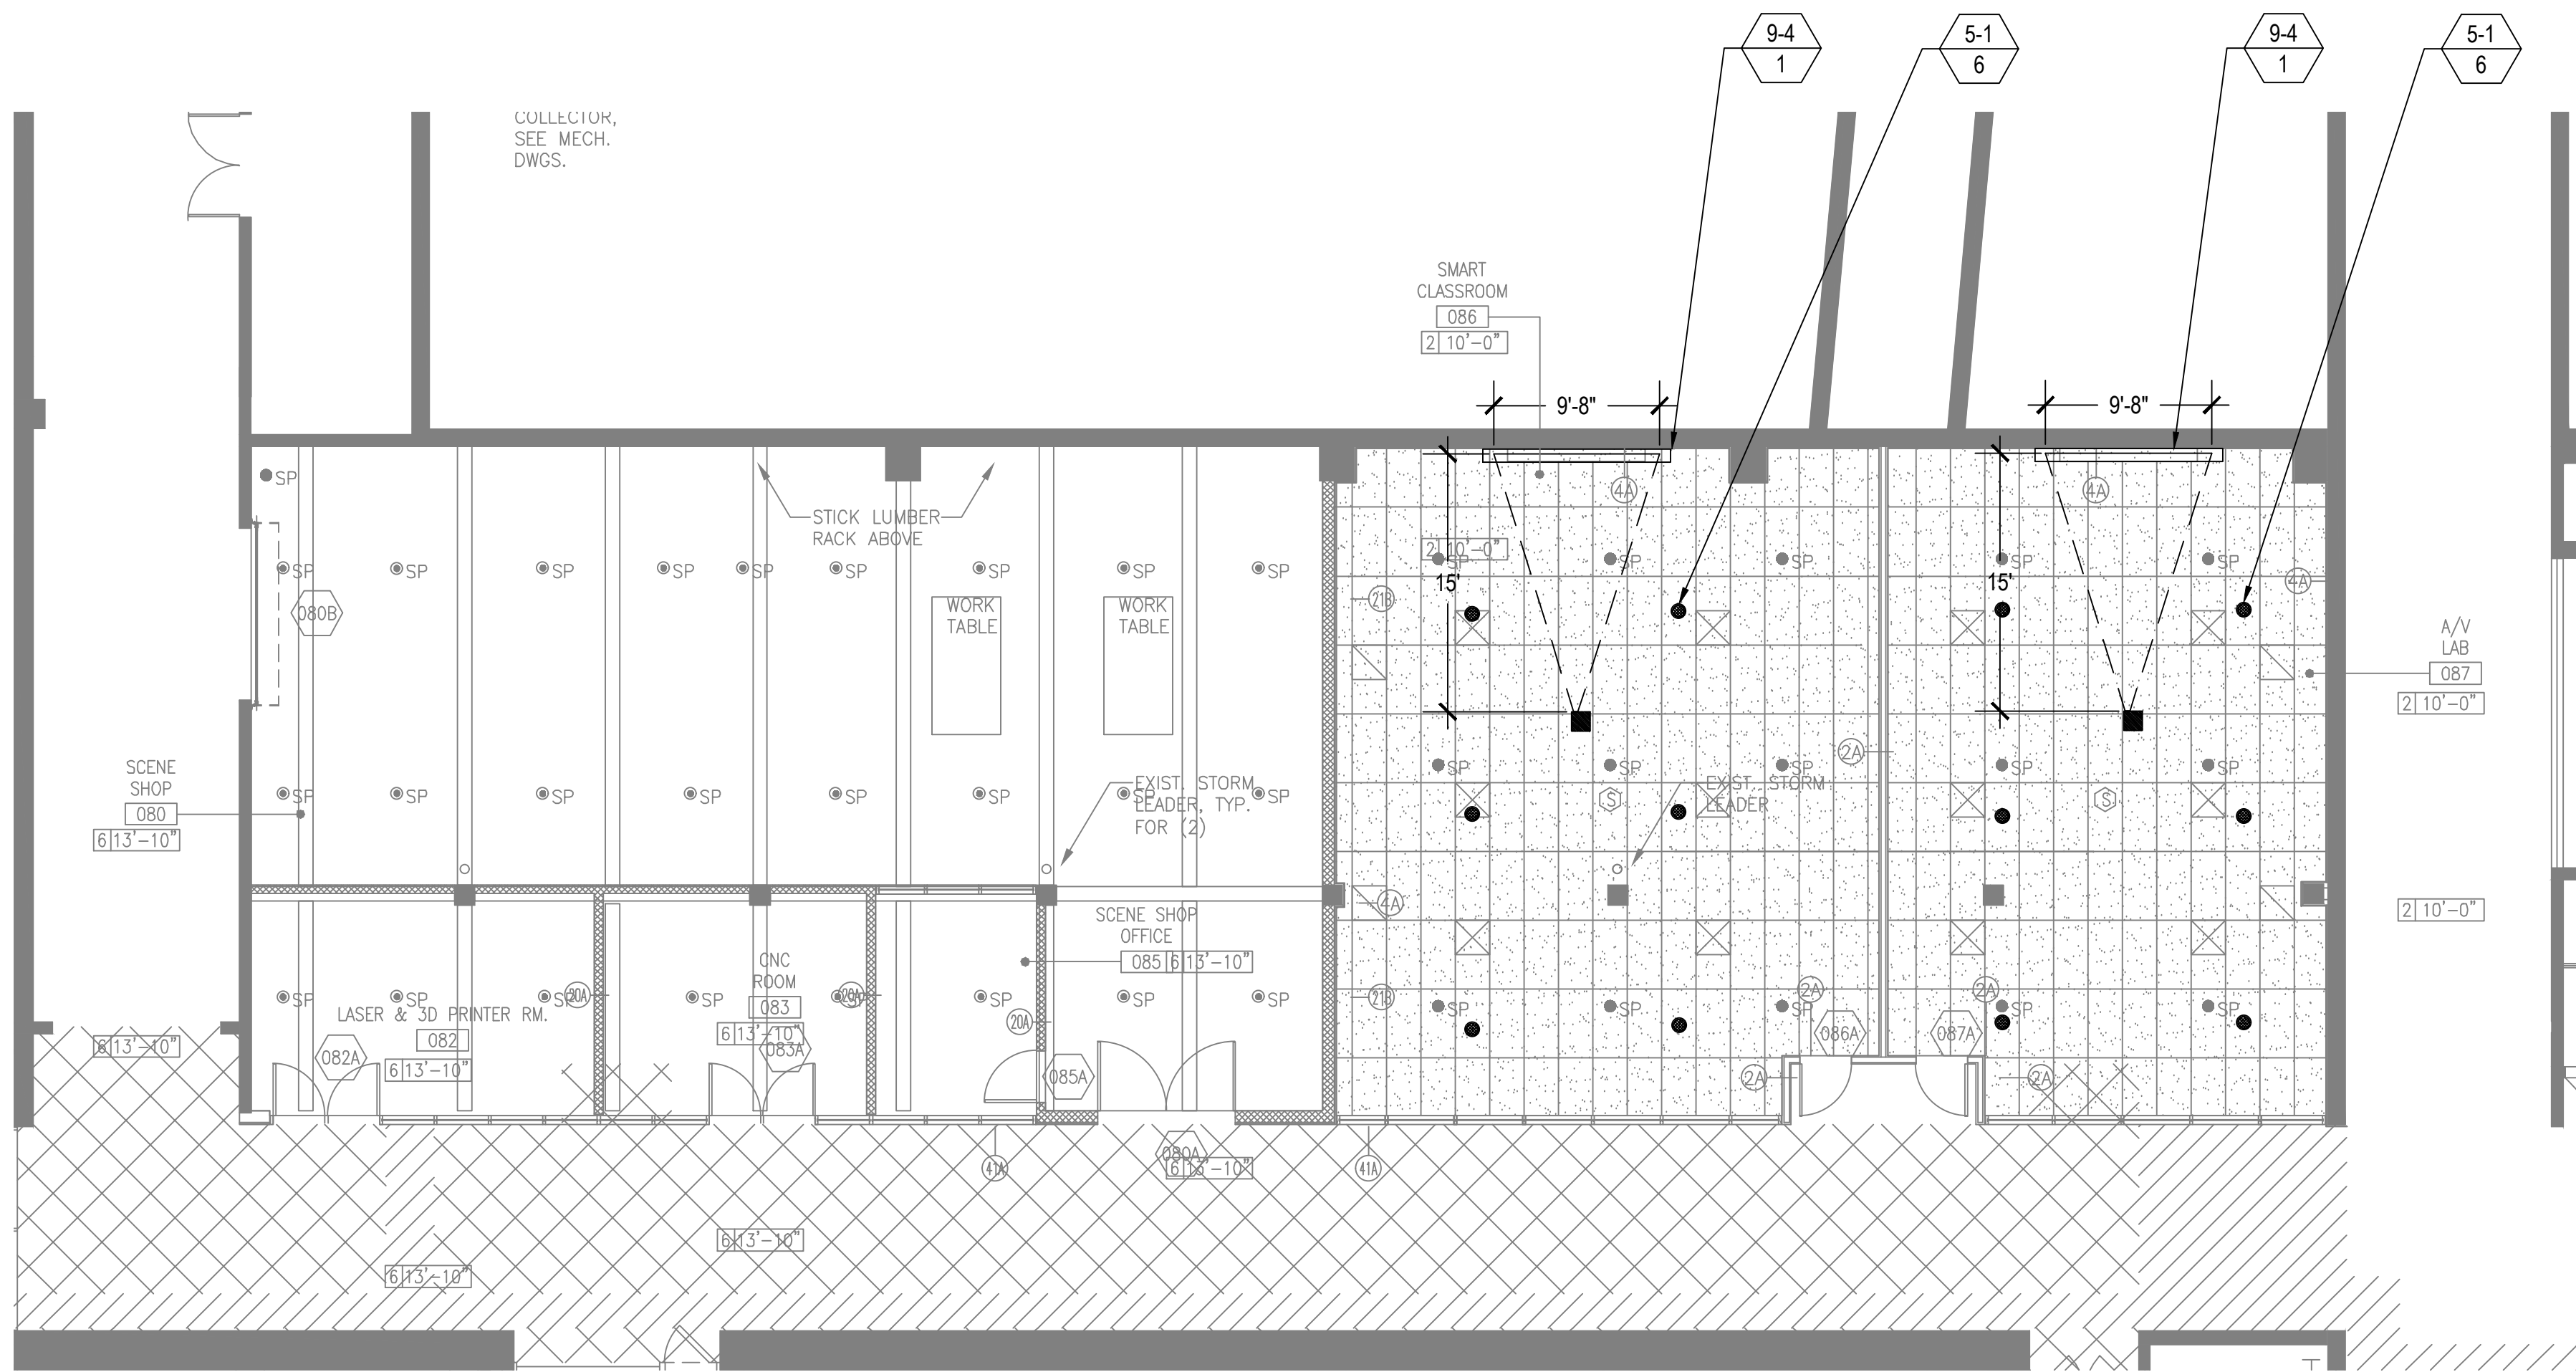

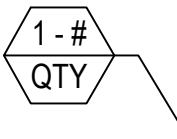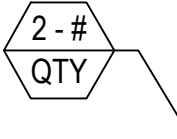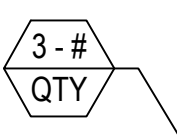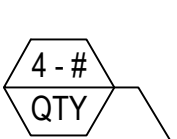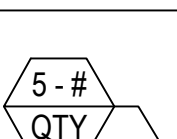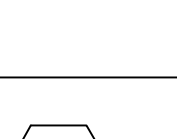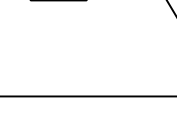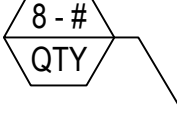FACILITY KEYNOTE LEGEND	
	EQUIPMENT RACKS: 1-1 Full Height
	CONNECTIVITY: 2-1 Floor Box 2-2 Wall Plate 2-3 Access Point at Ceiling Pipe Grid
	CONTROL/SCHEDULING: 3-1 Wall Mounted Controller 3-2 Volume Controller 3-3 Raise Lower Switch
	AUDIO INPUT: 4-1 Wireless Microphone Antenna
	AUDIO OUTPUT: 5-1 Ceiling Recessed Loudspeaker 5-2 Portable speaker Mounted on Pipe Grid 5-2A Portable Speaker Mounted on Catwalk 5-3 Portable Subwoofer Loudspeaker Mounted on Pipe Grid 5-4 Assistive Listening Emitter/Antenna 5-5 Ceiling Hanging Pendant Speaker
	VIDEO ORIGIN/SOURCE: 6-1 LOW LIGHT VIDEO CAMERA
	VIDEO DISPLAY (Type 1): 7-1 (70") Wall Mounted Flat Panel Display 7-2 (55") Wall Mounted Flat Panel Display 7-3 (55") Wall Mounted Digital Signage Display 7-4 (46") Wall Mounted Flat Panel Display
	VIDEO DISPLAY (Type 2): 8-1 Video Projector, Pole Mounted 8-2 Video Projector, Fixed at Projection Booth 8-3 Video Projector, OFE
	VIDEO DISPLAY (Type 3): 9-1 (50"Hx80"W) Ceiling Recessed Front Projection Screen 9-1A (50"Hx80"W) Wall Mounted Front Projection Screen 9-2 (144"Hx256"W) Ceiling Mounted Suspended Front Projection Screen. See TV and TR drawings for exact rigging details and locations. 9-3 120" x 213" Ceiling Recessed Front Projection Screen 9-4 (65" X 116) Ceiling Recessed Front Projection Screen 9-5 Painted projection surface 9-6 57.5" x 92" Ceiling Recessed Front Projection Screens 9-7 108" x 192" Ceiling Mounted Suspended Front Projection Screen. See TV and TR drawings for exact rigging details and locations.



KEY PLAN

5	GROUP III AV BID DOCUMENTS	09.06.2017
2	BID DOCUMENTS	05.28.2014
1	DESIGN MANUAL PHASE SUBMISSION	04.01.2013
NO.	REVISIONS / SUBMISSIONS	DATE

FX FOWLE
FXFOWLE ARCHITECTS, LLP | 22 WEST 18TH STREET | NEW YORK, NY 10011 | T 212.627.1700 | F 212.453.8716 | WWW.FXFWLE.COM

DISCIPLINARY ENGINEERS
DESIMONE CONSULTING ENGINEERS
18 West 18th Street, 10th Floor, New York, New York 10011 212-532-2211

MECHANICAL, ELECTRICAL, PLUMBING, FIRE PROTECTION ENGINEER
COLLADO ENGINEERING
2 Highland Avenue, White Plains, NY 10603 914-332-7658

THEATER PLANNING CONSULTANT
FISHER DACHS ASSOCIATES
22 West 126th Street, 8th Floor, New York, NY 10011 212-691-3020

ACQUISITION & AUDIO VISUAL CONSULTANT
CERAMI & ASSOCIATES
404 Fifth Avenue, New York, NY 10018 212-370-1776

LIGHTING CONSULTANT
ILLUMINATION ARTS
650 Bloomfield Avenue, Suite 101, Bloomfield NJ 07003 973-771-1558

LANDSCAPE CONSULTANT
W ARCHITECTURE & LANDSCAPE ARCHITECTURE, LLC
105 Fifth Avenue Third Floor New York, NY 10010 P 212-951-3533 F 212-622-0758

CIVIL ENGINEER & LANDMARK
LANGAN
21 Penn Plaza 360 West 31st Street 8th Floor New York, NY 10001 212-479-5400 212-479-5444 (fax)

ELEVATOR CONSULTANT
VDA (VAN DEUSEN & ASSOCIATES)
South Penn Plaza, Suite 404 New York, NY 10001 Phone: 212-808-9090 Fax: 212-808-9099

IT CONSULTANT
GRID ASSOCIATES, LLC
P.O. Box 1770 Hoboken, NJ 07030 T 946.722.0600 / F 946.722.0625

SUSTAINABILITY LEADER
YR&G
161 Bowery - 4th Floor, New York, NY 10002 T 917.677.8023 / F 917.677.8023


COST ESTIMATING CONSULTANT
TOSCANO CLEMENTS TAYLOR, LLC
16 Oakwood Road Huntington, NY 11743 T 631.392.1400 / F 631.392.1399

C.I.T.L. PROJ. # 29402
SUNY PURCHASE COLLEGE
735 ANDERSON HILL ROAD | PURCHASE, NY 10577

DRAWING TITLE:
AUDIOVISUAL-ADD ALTERNATE FACILITY
CONCOURSE (BASEMENT LEVEL) RCP

Seal:	Drawn: AJC	Project No.: 29402 (SUCF) / 09018.L00 (FXF)
	Checked: BJM	Cal File:
	Reviewed: BJM	Drawing No.:
	Date:	
		Scale: 1/8" = 1'-0"

TA212.0_AA

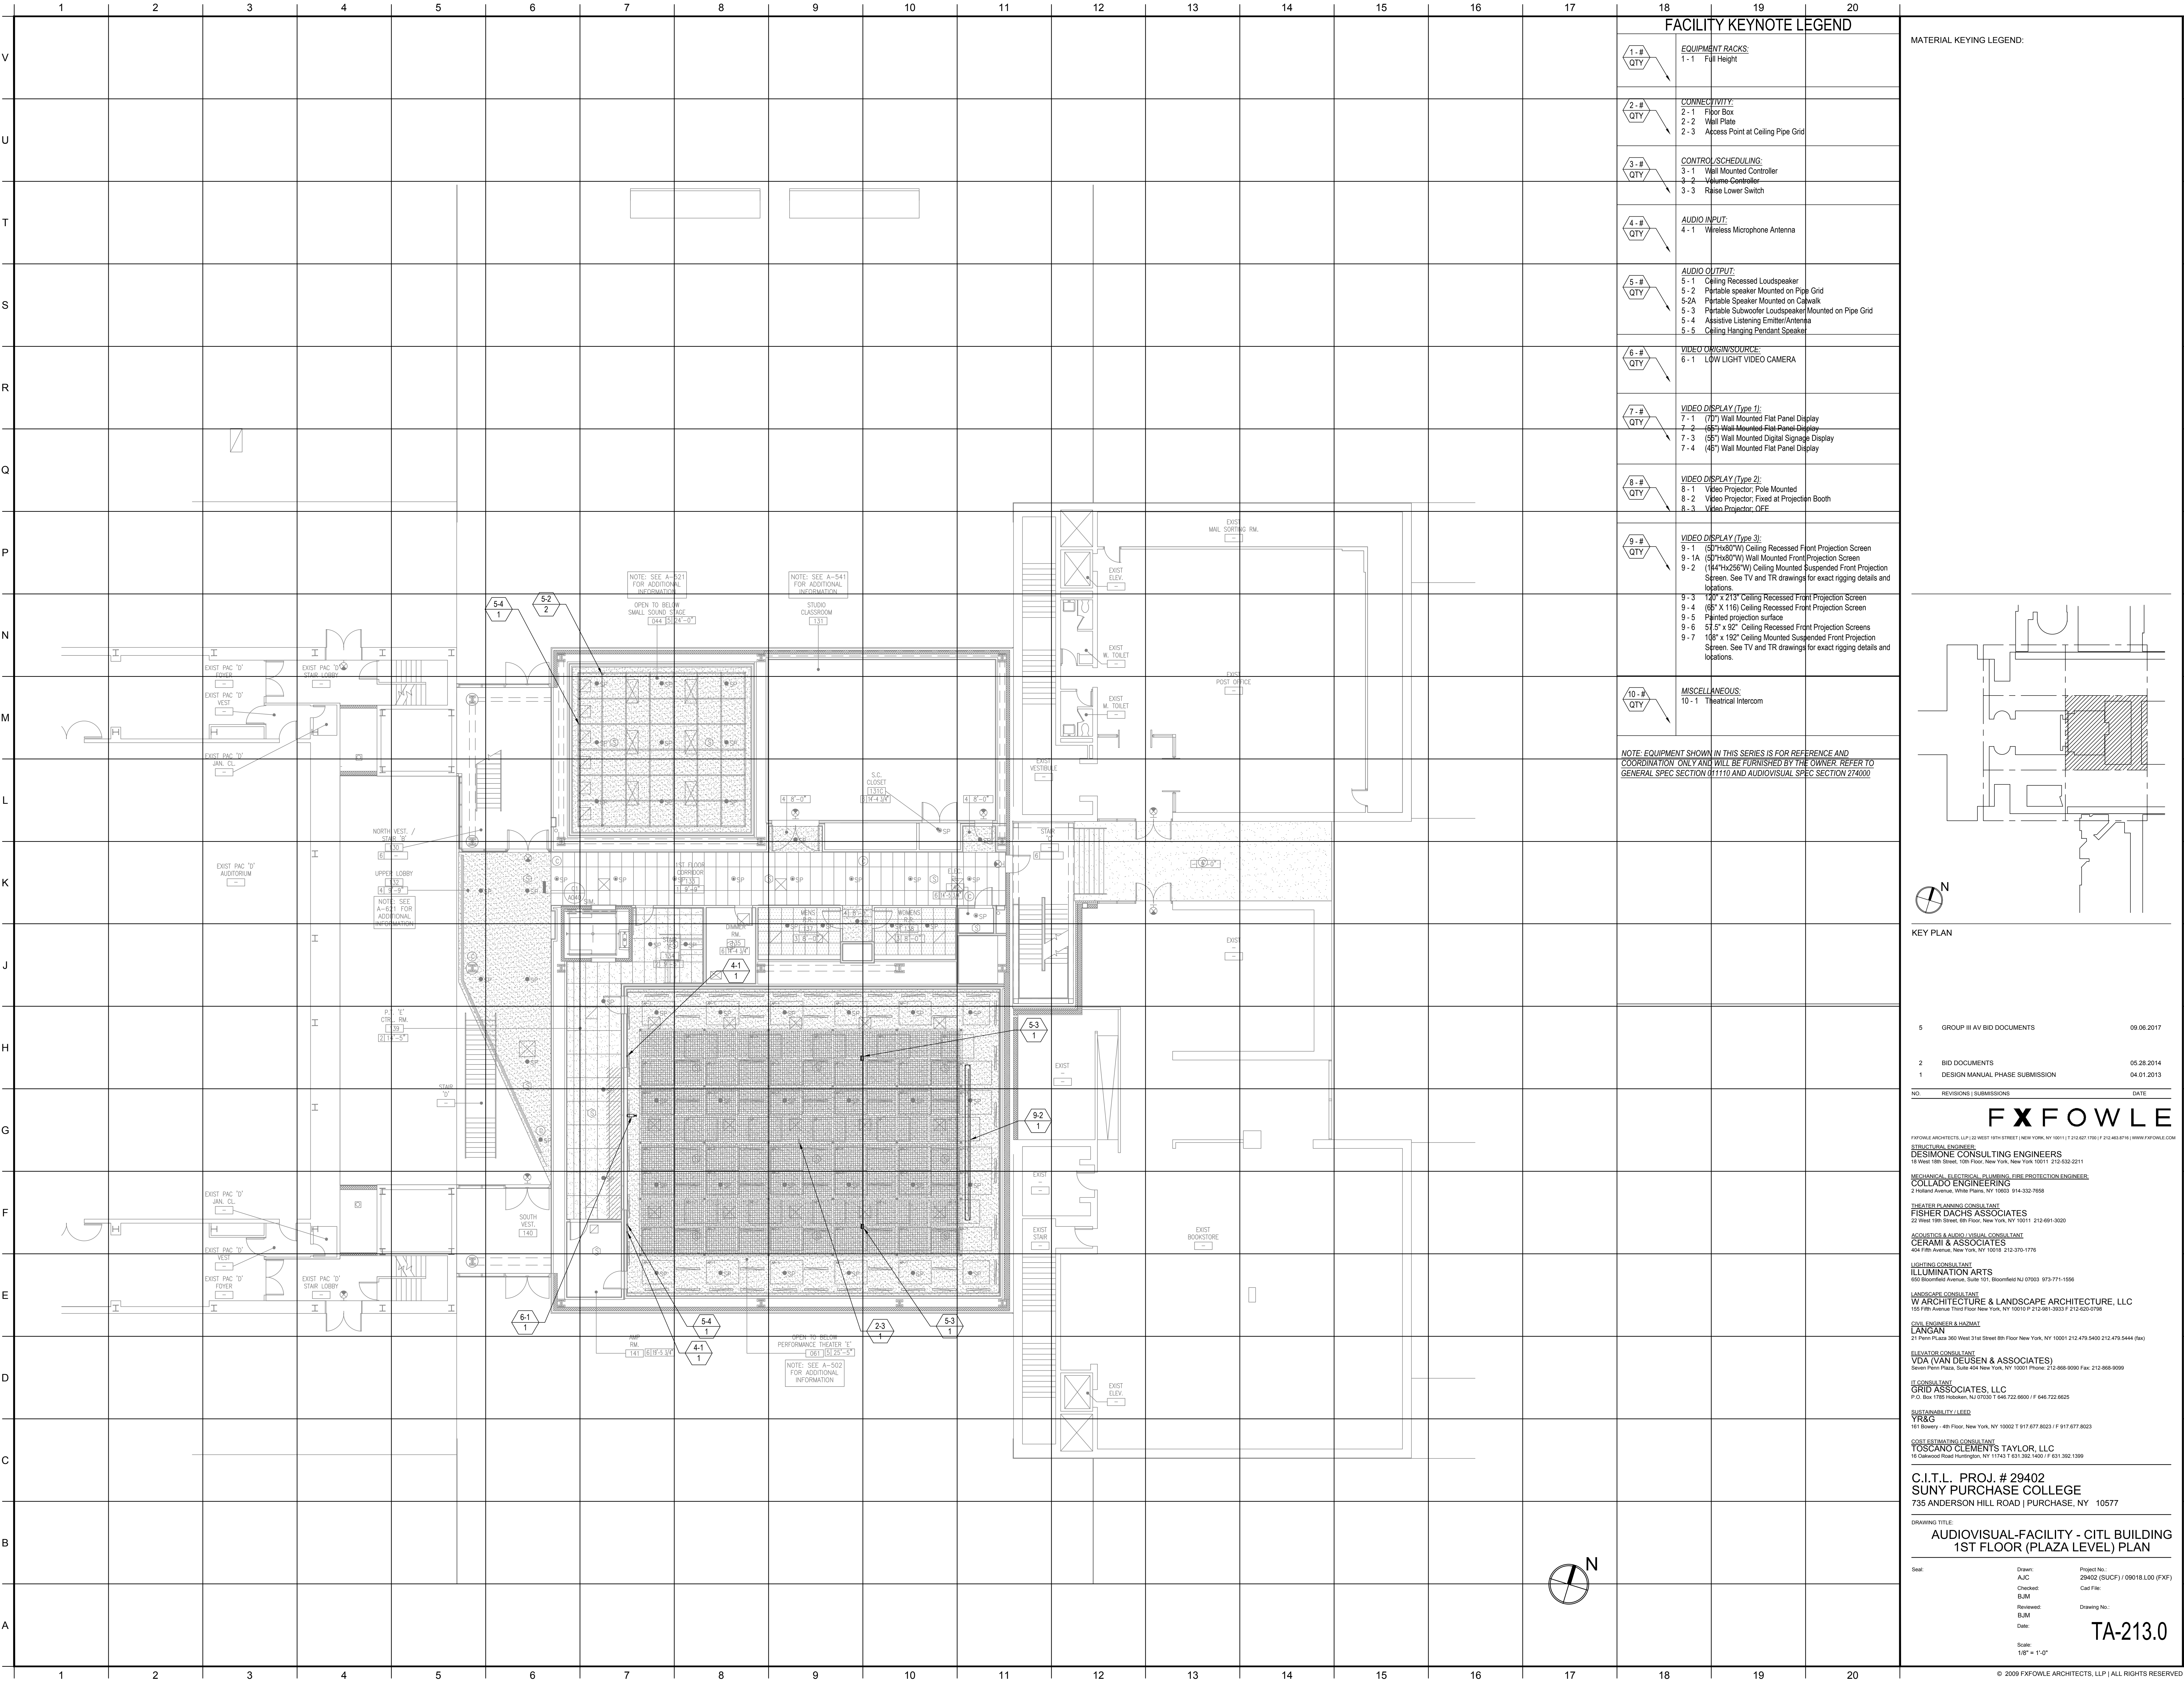

FACILITY KEYNOTE LEGEND		
	EQUIPMENT RACKS:	
	1-1	Full Height
	CONNECTIVITY:	
	2-1	Floor Box
	2-2	Wall Plate
	2-3	Access Point at Ceiling Pipe Grid
	CONTROL/SCHEDULING:	
	3-1	Wall Mounted Controller
	3-2	Volume Controller
	3-3	Raise Lower Switch
	AUDIO INPUT:	
	4-1	Wireless Microphone Antenna
	AUDIO OUTPUT:	
	5-1	Ceiling Recessed Loudspeaker
	5-2	Portable speaker Mounted on Pipe Grid
	5-2A	Portable Speaker Mounted on Catwalk
	5-3	Portable Subwoofer Loudspeaker Mounted on Pipe Grid
	5-4	Assistive Listening Emitter/Antenna
	5-5	Ceiling Hanging Pendant Speaker
	VIDEO ORIGIN/SOURCE:	
	6-1	LOW LIGHT VIDEO CAMERA
	VIDEO DISPLAY (Type 1):	
	7-1	(70") Wall Mounted Flat Panel Display
	7-2	(65") Wall Mounted Flat Panel Display
	7-3	(65") Wall Mounted Digital Signage Display
	7-4	(49") Wall Mounted Flat Panel Display
	VIDEO DISPLAY (Type 2):	
	8-1	Video Projector, Pole Mounted
	8-2	Video Projector, Fixed at Projection Booth
	8-3	Video Projector, OFF
	VIDEO DISPLAY (Type 3):	
	9-1	(37"Hx80"W) Ceiling Recessed Front Projection Screen
	9-1A	(50"Hx80"W) Wall Mounted Front Projection Screen
	9-2	(164"Hx256"W) Ceiling Mounted Suspended Front Projection Screen. See TV and TR drawings for exact rigging details and locations.
	9-3	120" x 213" Ceiling Recessed Front Projection Screen
	9-4	(65" X 116) Ceiling Recessed Front Projection Screen
	9-5	Printed projection surface
	9-6	57.5" x 92" Ceiling Recessed Front Projection Screens
	9-7	160" x 192" Ceiling Mounted Suspended Front Projection Screen. See TV and TR drawings for exact rigging details and locations.
	MISCELLANEOUS:	
	10-1	Theatrical Intercom

NOTE: EQUIPMENT SHOWN IN THIS SERIES IS FOR REFERENCE AND COORDINATION ONLY AND WILL BE FURNISHED BY THE OWNER. REFER TO GENERAL SPEC SECTION 011110 AND AUDIOVISUAL SPEC SECTION 274000

MATERIAL KEYING LEGEND:

KEY PLAN

5 GROUP III AV BID DOCUMENTS 09.06.2017

2 BID DOCUMENTS 05.28.2014

1 DESIGN MANUAL PHASE SUBMISSION 04.01.2013

NO. REVISIONS / SUBMISSIONS DATE

FX FOWLE

FX FOWLE ARCHITECTS, LLP | 22 WEST 10TH STREET | NEW YORK, NY 10011 | T 212.627.1700 | F 212.453.8716 | WWW.FX FOWLE.COM

DESIGN ENGINEERS:
DESMOND CONSULTING ENGINEERS
18 West 18th Street, 10th Floor, New York, New York 10011 | 212-532-5211

MECHANICAL, ELECTRICAL, PLUMBING, FIRE PROTECTION ENGINEER:
COLLADO ENGINEERING
2 Holmden Avenue, White Plains, NY 10603 | 914-332-7658

THEATER PLANNING CONSULTANT:
FISHER DACHS ASSOCIATES
22 West 10th Street, 8th Floor, New York, NY 10011 | 212-691-3020

ACQUISITION & AUDIO VISUAL CONSULTANT:
CERAMI & ASSOCIATES
404 Fifth Avenue, New York, NY 10018 | 212-370-1776

LIGHTING CONSULTANT:
ILLUMINATION ARTS
605 Boulevard Avenue, Suite 101, Bloomfield NJ 07003 | 973-771-1558

LANDSCAPE CONSULTANT:
W ARCHITECTURE & LANDSCAPE ARCHITECTURE, LLC
105 Fifth Avenue, Third Floor New York, NY 10010 | P 212.951.3533 / F 212.620-0758

CIVIL ENGINEER & LANDSCAPE ARCHITECT:
LANGAN
21 Penn Plaza 360 West 31st Street 8th Floor New York, NY 10001 212.479.5400 212.479.5444 (fax)

ELEVATOR CONSULTANT:
VDA (VAN DEUSEN & ASSOCIATES)
Seven Penn Plaza, Suite 404 New York, NY 10001 Phone: 212-608-9090 Fax: 212-608-9099

IT CONSULTANT:
GRID ASSOCIATES, LLC
P.O. Box 1770 Hicksville, NY 11743 T 516.722.6600 / F 516.722.6625

SUSTAINABILITY LEADER:
YR&G
161 Bowery - 4th Floor, New York, NY 10002 T 917.677.8023 / F 917.677.8023

GUEST ESTIMATING CONSULTANT:
TOSCANO CLEMENTS TAYLOR, LLC
16 Oakwood Road Huntington, NY 11743 T 631.392.1400 / F 631.392.1399

C.I.T.L. PROJ. # 29402
SUNY PURCHASE COLLEGE
735 ANDERSON HILL ROAD | PURCHASE, NY 10577

DRAWING TITLE:
AUDIOVISUAL-FACILITY - CITL BUILDING
1ST FLOOR (PLAZA LEVEL) PLAN

Seal:
AUC
Checked:
BJM
Reviewed:
BJM
Date:


Project No.:
29402 (SUCF) / 05018.L00 (FXP)
Cad File:

Drawing No.:

Scale:
1/8" = 1'-0"



TA-213.0

© 2009 FX FOWLE ARCHITECTS, LLP | ALL RIGHTS RESERVED

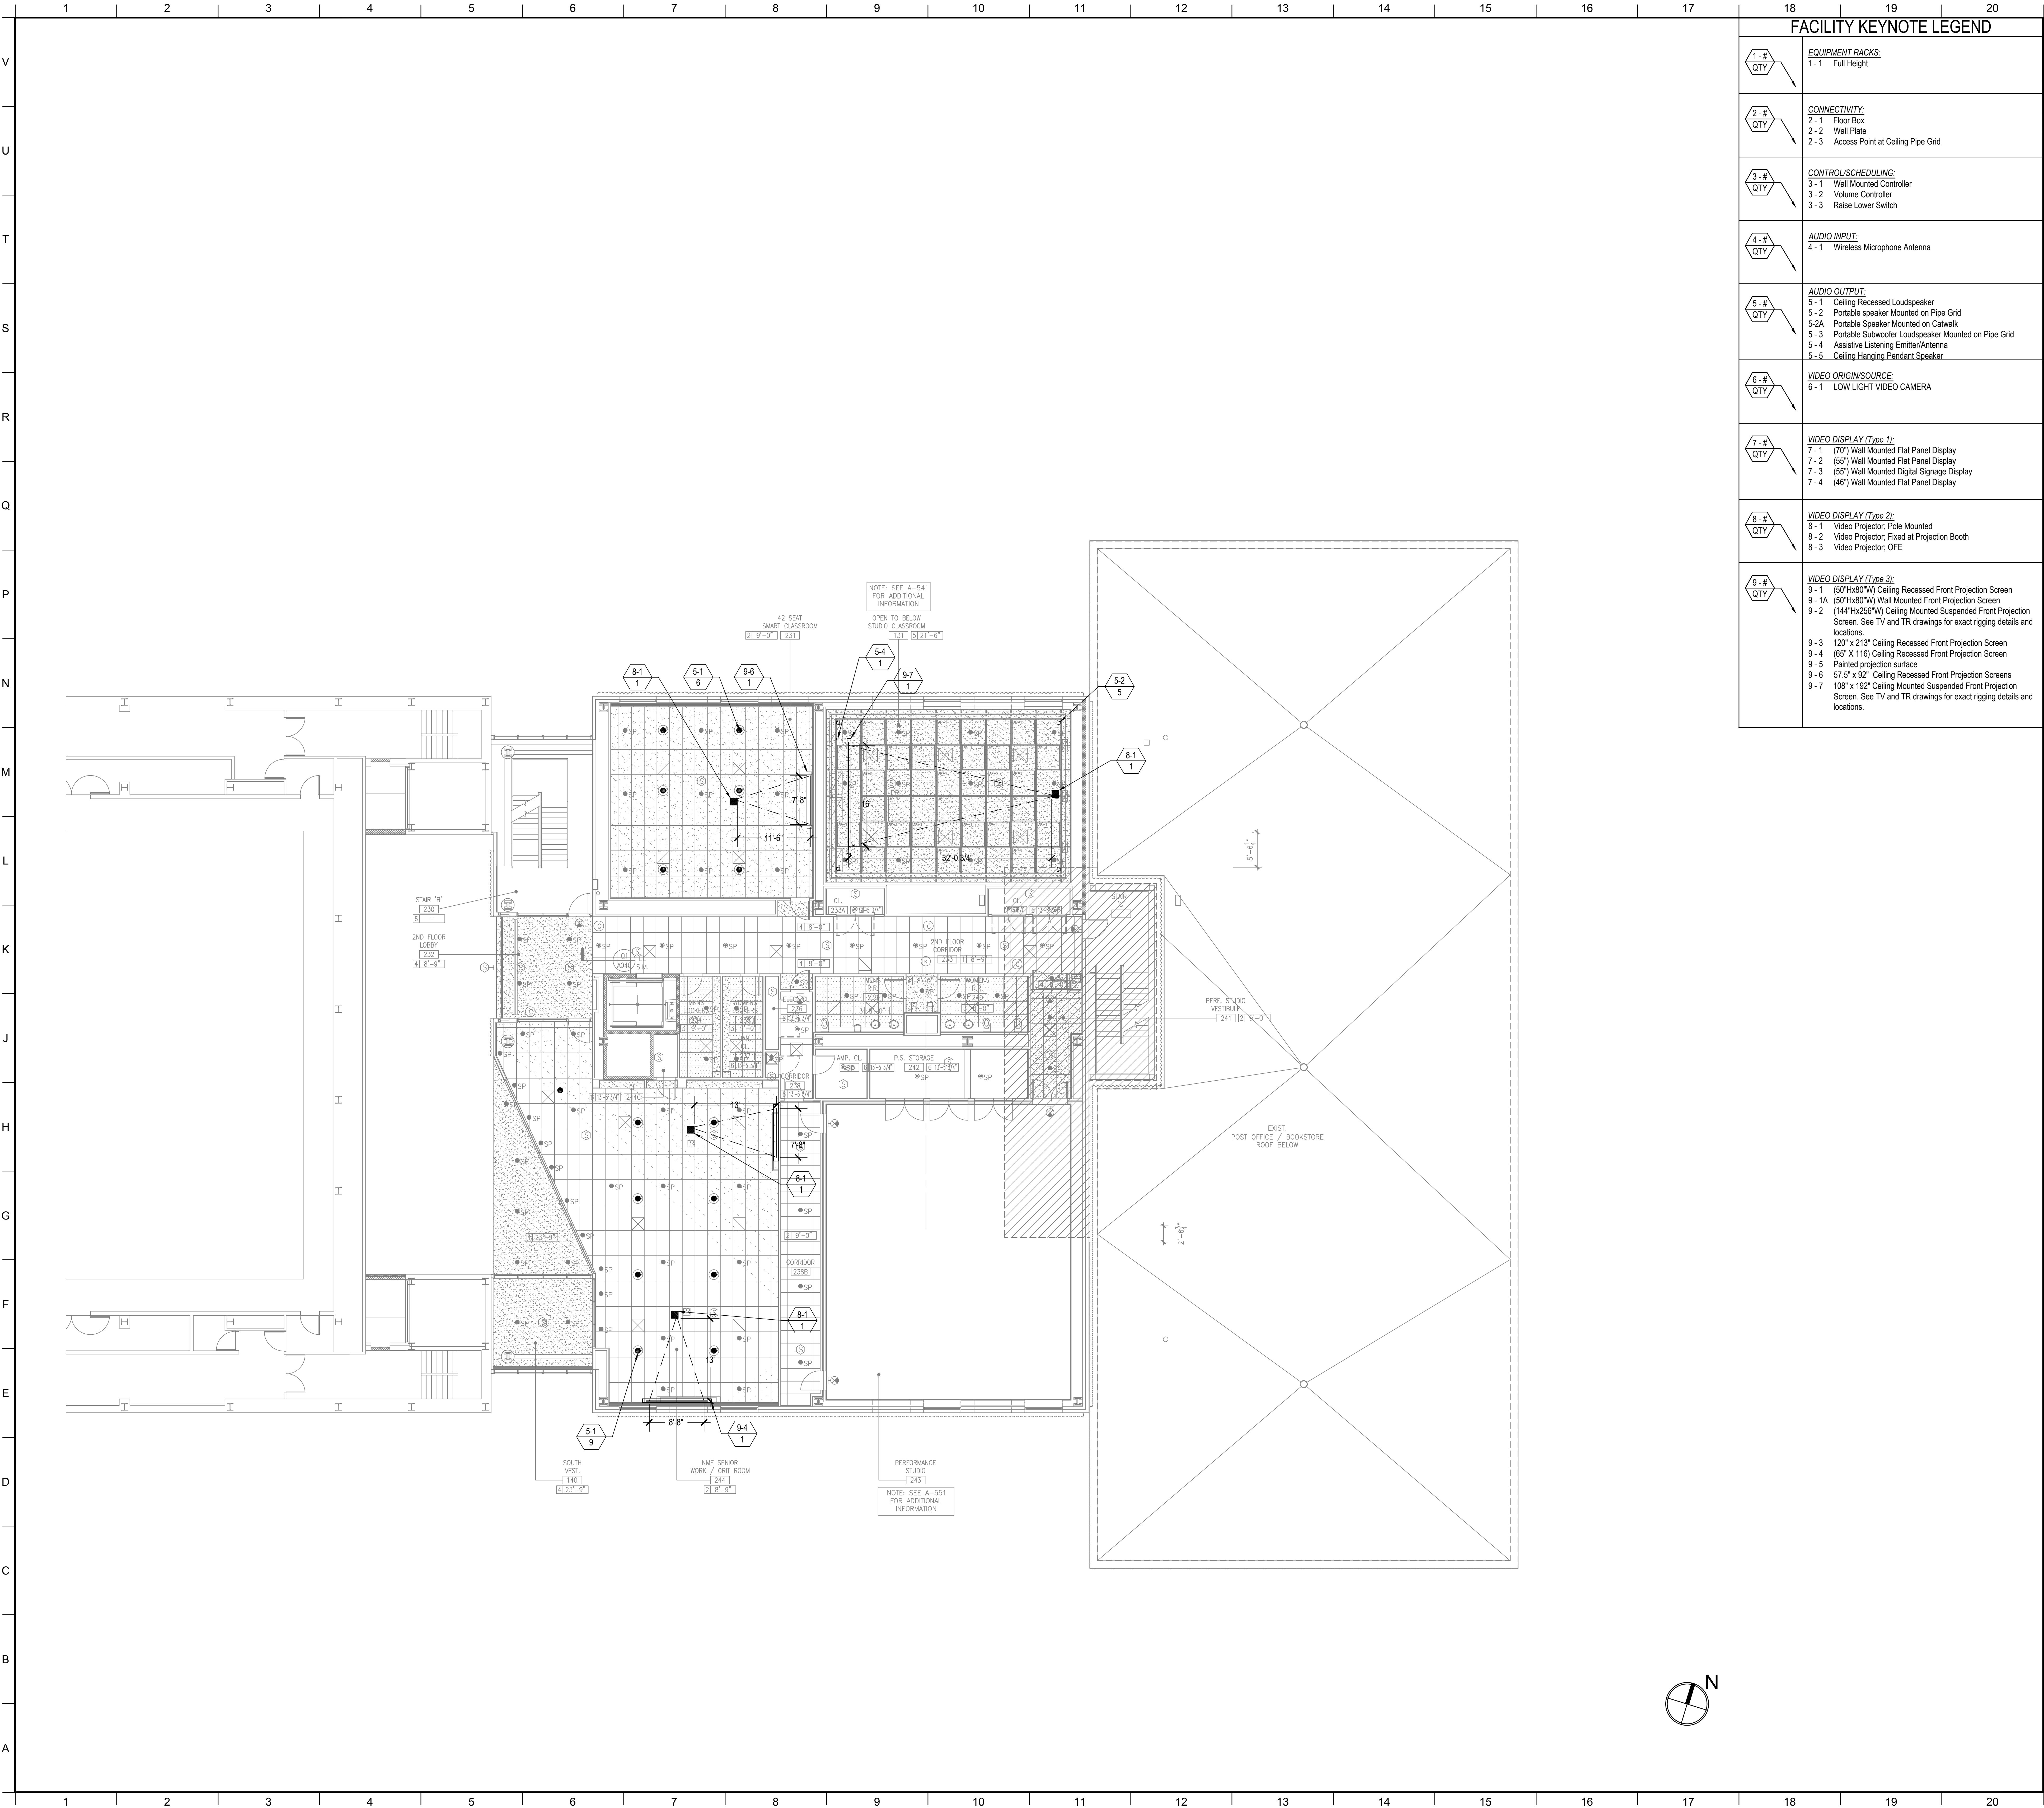

FACILITY KEYNOTE LEGEND	
	EQUIPMENT RACKS: 1-1 Full Height
	CONNECTIVITY: 2-1 Floor Box 2-2 Wall Plate 2-3 Access Point at Ceiling Pipe Grid
	CONTROL/SCHEDULING: 3-1 Wall Mounted Controller 3-2 Volume Controller 3-3 Raise Lower Switch
	AUDIO INPUT: 4-1 Wireless Microphone Antenna
	AUDIO OUTPUT: 5-1 Ceiling Recessed Loudspeaker 5-2 Portable speaker Mounted on Pipe Grid 5-2A Portable Speaker Mounted on Catwalk 5-3 Portable Subwoofer Loudspeaker Mounted on Pipe Grid 5-4 Assistive Listening Emitter/Antenna 5-5 Ceiling Hanging Pendant Speaker
	VIDEO ORIGIN/SOURCE: 6-1 LOW LIGHT VIDEO CAMERA
	VIDEO DISPLAY (Type 1): 7-1 (70") Wall Mounted Flat Panel Display 7-2 (55") Wall Mounted Flat Panel Display 7-3 (55") Wall Mounted Digital Signage Display 7-4 (46") Wall Mounted Flat Panel Display
	VIDEO DISPLAY (Type 2): 8-1 Video Projector, Pole Mounted 8-2 Video Projector, Fixed at Projection Booth 8-3 Video Projector, OFE
	VIDEO DISPLAY (Type 3): 9-1 (50"Hx80"W) Ceiling Recessed Front Projection Screen 9-1A (50"Hx80"W) Wall Mounted Front Projection Screen 9-2 (144"Hx256"W) Ceiling Mounted Suspended Front Projection Screen. See TV and TR drawings for exact rigging details and locations. 9-3 120" x 213" Ceiling Recessed Front Projection Screen 9-4 (65" X 116) Ceiling Recessed Front Projection Screen 9-5 Painted projection surface 9-6 57.5" x 92" Ceiling Recessed Front Projection Screens 9-7 108" x 192" Ceiling Mounted Suspended Front Projection Screen. See TV and TR drawings for exact rigging details and locations.

MATERIAL KEYING LEGEND:

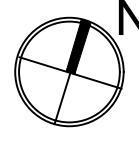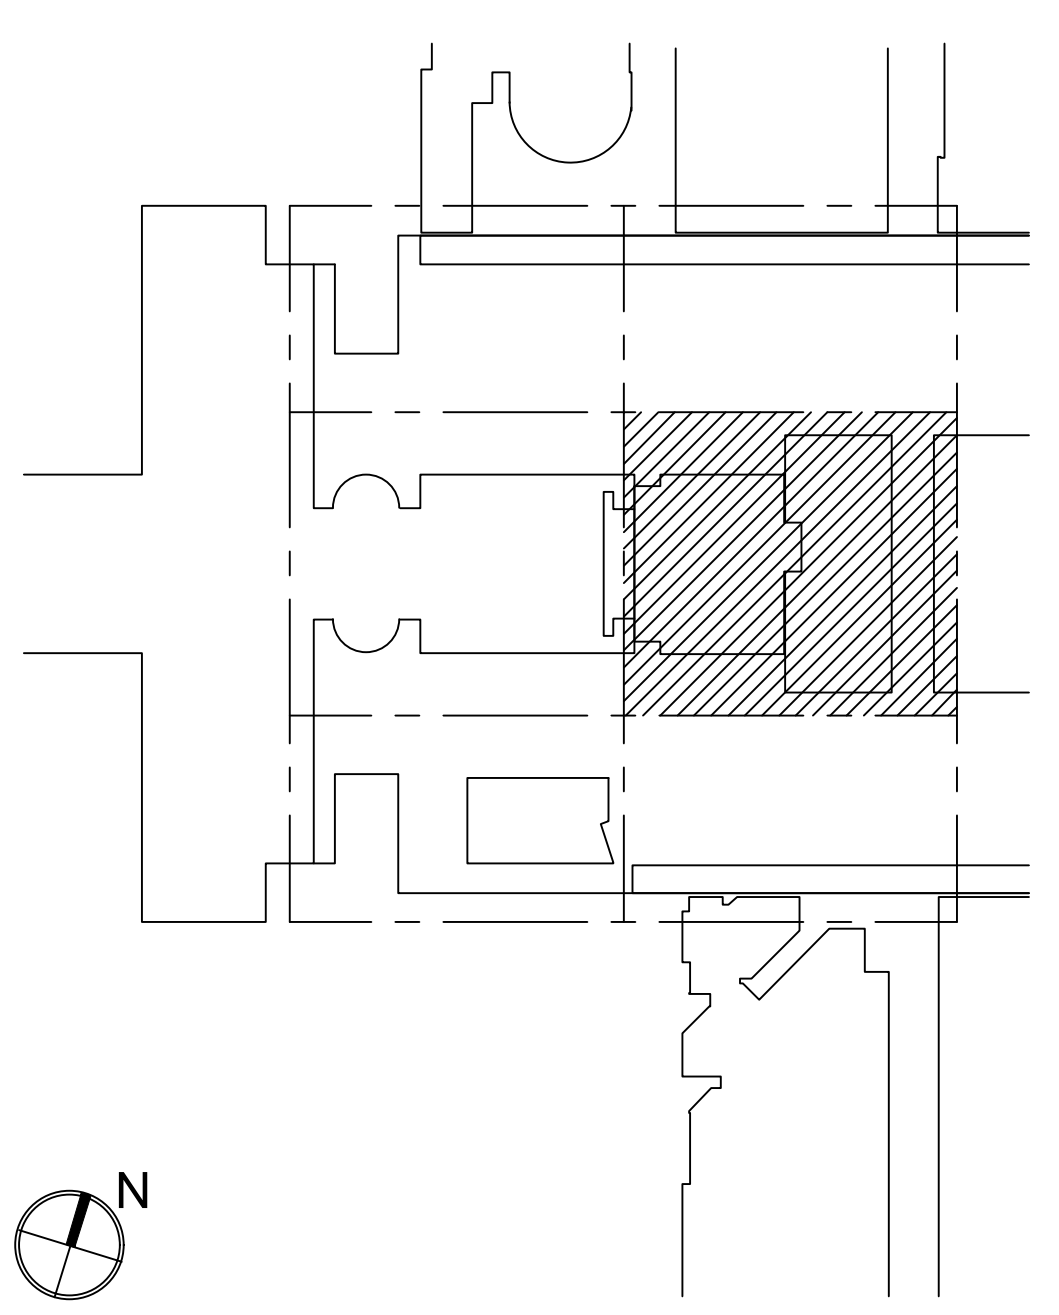

KEY PLAN

5	GROUP III AV BID DOCUMENTS	09.06.2017
2	BID DOCUMENTS	05.28.2014
1	DESIGN MANUAL PHASE SUBMISSION	04.01.2013

NO.	REVISIONS / SUBMISSIONS	DATE
-----	-------------------------	------

FX FOWLE
FX FOWLE ARCHITECTS, LLP | 22 WEST 10TH STREET | NEW YORK, NY 10011 | T 212.627.1700 | F 212.453.8716 | WWW.FX FOWLE.COM

DESIGN ENGINEERS:
DESIMONE CONSULTING ENGINEERS
18 West 18th Street, 10th Floor, New York, New York 10011 212-532-2211

MECHANICAL, ELECTRICAL, PLUMBING, FIRE PROTECTION ENGINEER:
COLLADO ENGINEERING
2 Holland Avenue, White Plains, NY 10603 914-332-7658

THEATER PLANNING CONSULTANT:
FISHER DACHS ASSOCIATES
22 West 10th Street, 8th Floor, New York, NY 10011 212-691-3020

ACoustics & AUDIO VISUAL CONSULTANT:
CERAM & ASSOCIATES
404 Fifth Avenue, New York, NY 10018 212-370-1776

LIGHTING CONSULTANT:
ILLUMINATION ARTS
650 Bloomfield Avenue, Suite 101, Bloomfield NJ 07003 973-771-1558

LANDSCAPE CONSULTANT:
W ARCHITECTURE & LANDSCAPE ARCHITECTURE, LLC
105 Fifth Avenue Third Floor New York, NY 10019 P 212-951-3533 F 212-620-0758

CREAT ENGINEER & HANALIT:
LANGAN
21 Penn Plaza 360 West 31st Street 8th Floor New York, NY 10001 212-479-5400 212-479-5444 (fax)

ELEVATOR CONSULTANT:
VDA (VAN DEUSEN & ASSOCIATES)
Seven Penn Plaza, Suite 404 New York, NY 10001 Phone: 212-808-9090 Fax: 212-808-9099

IT CONSULTANT:
GRID ASSOCIATES, LLC
P.O. Box 1700 Hoboken, NJ 07030 T 946.722.6600 / F 946.722.6625

SUSTAINABILITY LEED:
YR&G
161 Bowery - 4th Floor, New York, NY 10002 T 917.677.8023 / F 917.677.8023

COST ESTIMATING CONSULTANT:
TOSCANO CLEMENTS TAYLOR, LLC
16 Oakwood Road Huntington, NY 11743 T 631.392.1400 / F 631.392.1399


C.I.T.L. PROJ. # 29402
SUNY PURCHASE COLLEGE
735 ANDERSON HILL ROAD | PURCHASE, NY 10577


DRAWING TITLE:
AUDIOVISUAL-FACILITY - CITL BUILDING
2ND FLOOR (PLAZA +1 LEVEL) RCP

Set:	Drawn: AJC	Project No.: 29402 (SUCF) / 05018.L00 (FXP)
	Checked: BJM	Cal File:
	Reviewed: BJM	Drawing No.:
	Date:	

TA-214.0
Scale: 1/8" = 1'-0"

© 2009 FX FOWLE ARCHITECTS, LLP | ALL RIGHTS RESERVED

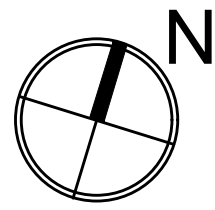


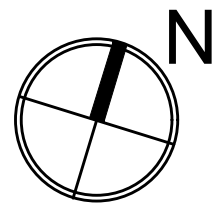



CEILING MOUNTED TELECOM DATA OUTLET BOX; QUANTITY AND TYPE OF CABLING AS PER PROJECT STANDARDS, UNLESS OTHERWISE INDICATED. REFER TO THE ARCHITECTURAL DRAWINGS FOR DIMENSIONED LOCATION.

10. THE METHOD OF INSTALLATION OF BOXES IN WALLS, AND THE METHOD OF PASSAGE OF CONDUITS AND WIREWAYS THROUGH ACOUSTICALLY SENSITIVE WALLS SHALL BE COORDINATED WITH THE ACOUSTICAL CONSULTANT.

TA-302.0

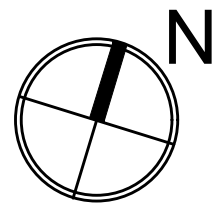

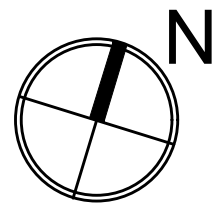

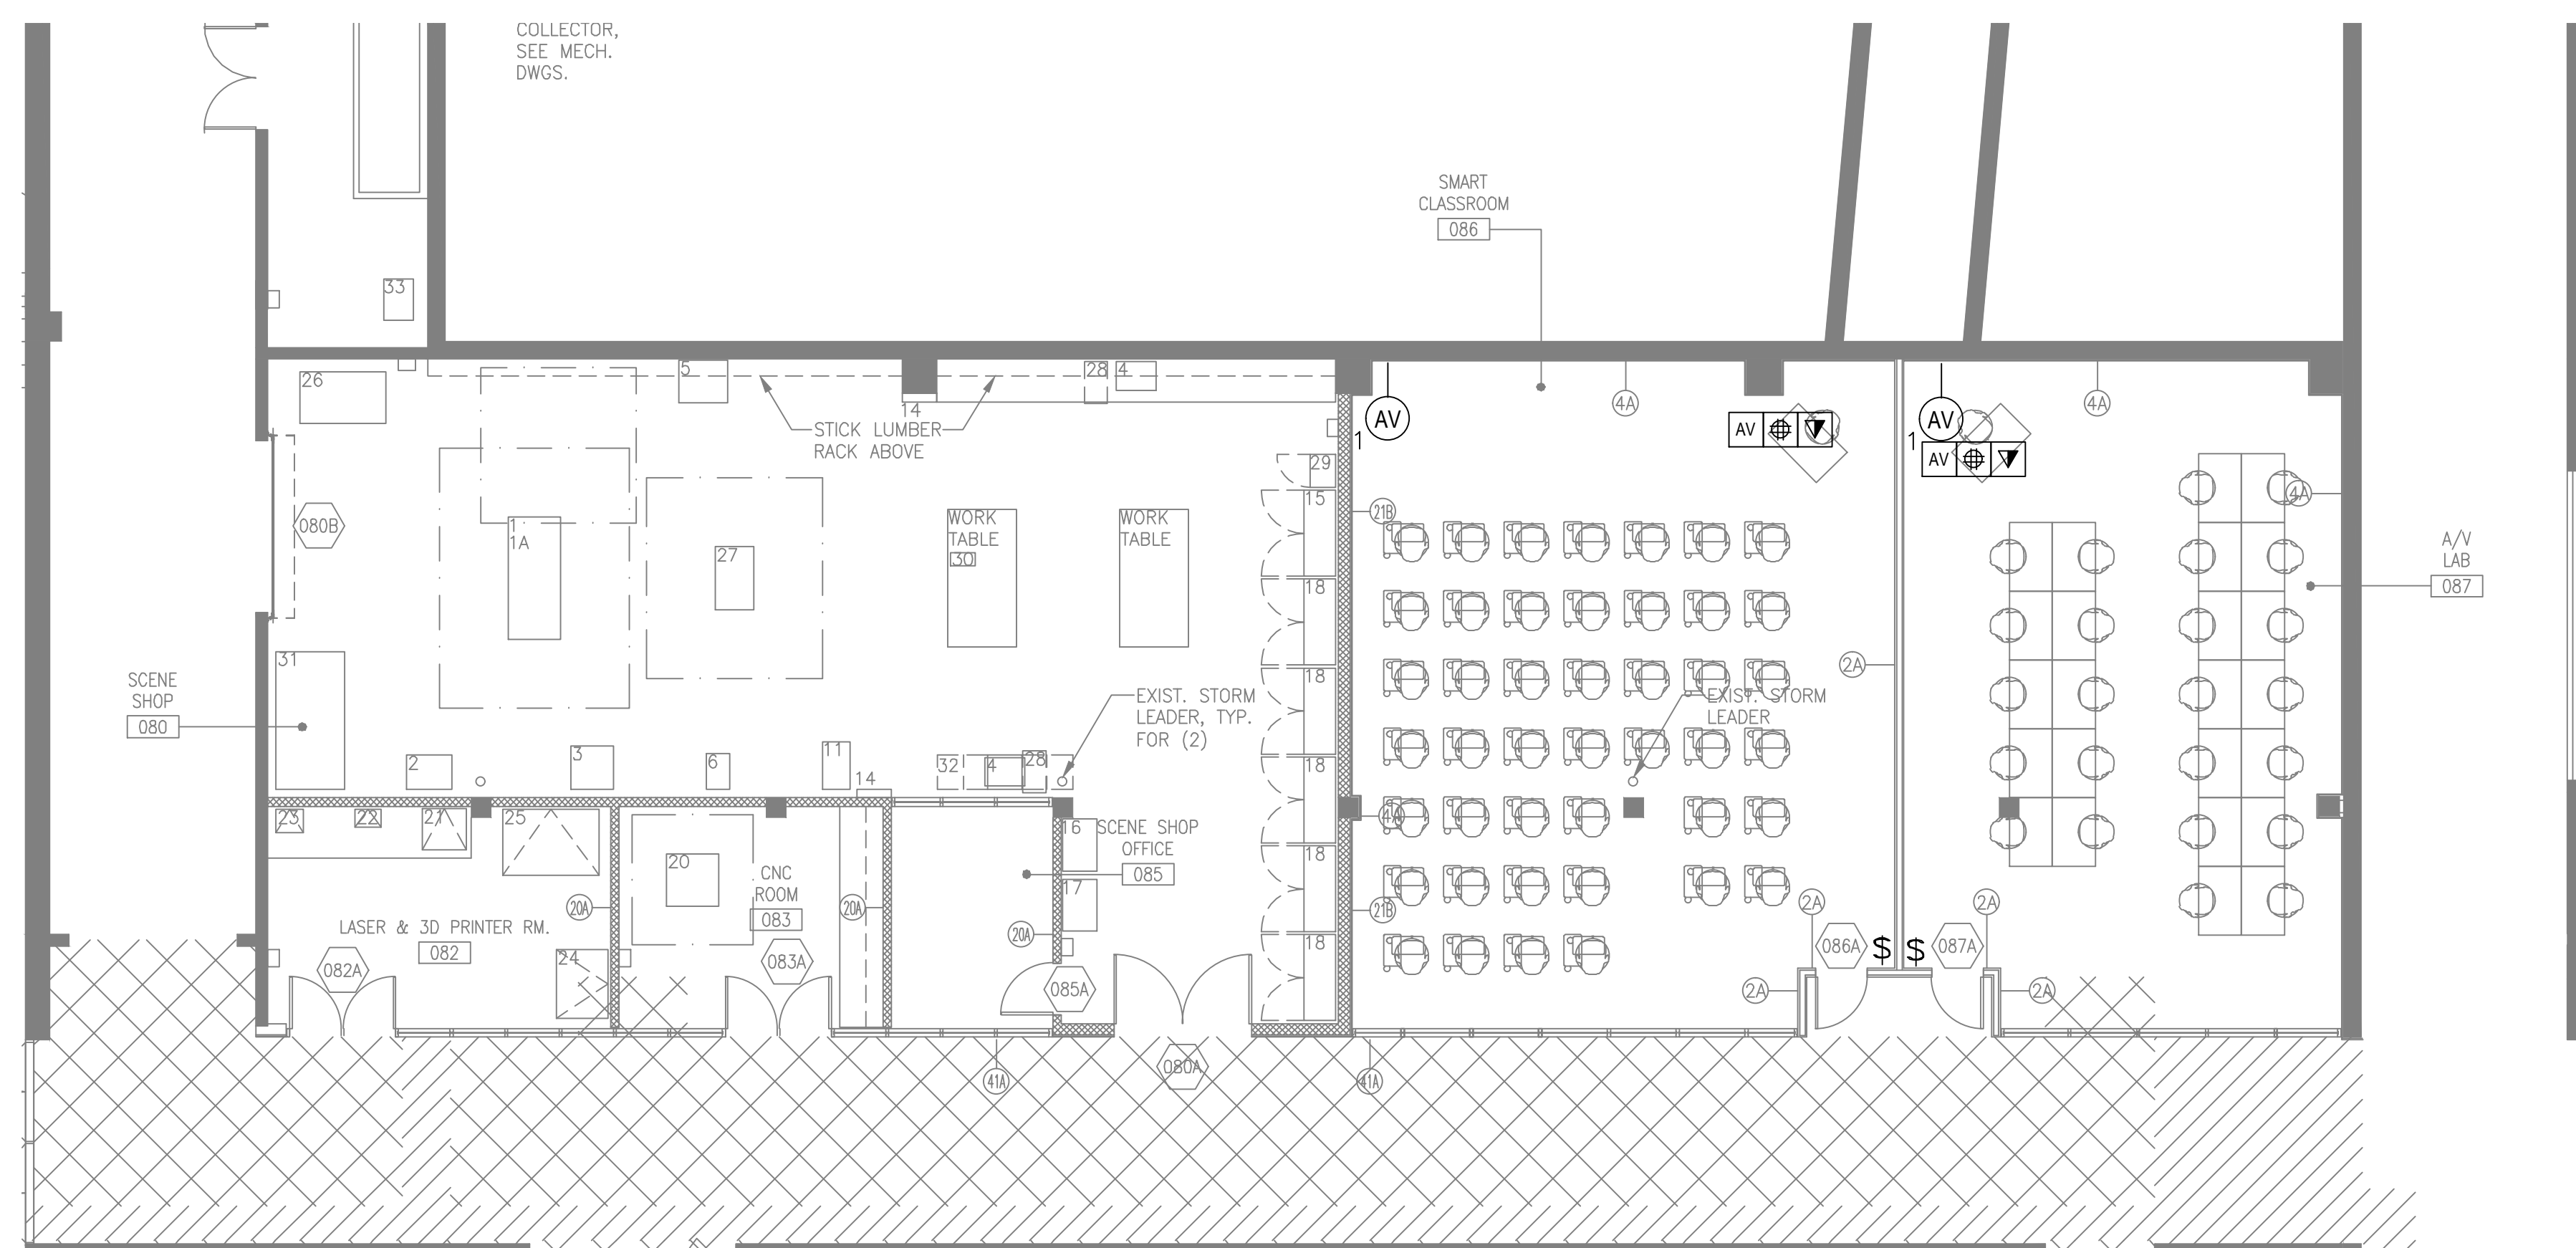


AUDIOVISUAL ELECTRICAL LEGEND


SYMBOL	DESCRIPTION
	MULTI-DISCIPLINE FLOOR BOX OR POKE-THRU, WITH HINGED COVER PLATE AND CARPET FLUSH, WITH DIVIDED COMPARTMENTS FOR SHARED ACCESS WITH VOICE, DATA AND 120VAC POWER. MOUNT FLUSH WITH FINISHED WALL TREATMENT. BEHIND DISPLAY, UNLESS OTHERWISE INDICATED. (4" DEEP MINIMUM) UNLESS OTHERWISE INDICATED. SEE AUDIOVISUAL DETAIL SHEETS.
	SCREW COVER JUNCTION BOX FOR AUDIOVISUAL CONDUIT TERMINATION. SIZE ACCORDINGLY. ALL CONDUITS TERMINATE AT THIS BOX UNLESS OTHERWISE INDICATED.
	MULTI-DISCIPLINE IN-WALL BOX, WITH DIVIDED COMPARTMENTS FOR SHARED ACCESS WITH VOICE, DATA AND 120VAC POWER. MOUNT FLUSH WITH FINISHED WALL TREATMENT. BEHIND DISPLAY, UNLESS OTHERWISE INDICATED. SEE AUDIOVISUAL DETAIL SHEETS.
	GANGABLE WALL BOX, 4-11/16" HIGH X 2-1/2" DEEP, FOR AUDIO/VIDEO RECEPTABLES. MOUNT FLUSH WITH FINISHED WALL TREATMENT, AT BASE BUILDING ELECTRICAL SWITCH HEIGHT UNLESS OTHERWISE INDICATED. SUBNUMBER INDICATES GANG #
	WALL BOX, HEIGHT AND WIDTH AS SPECIFIED, FOR AUDIO/VIDEO RECEPTABLES. MOUNT FLUSH WITH FINISHED WALL TREATMENT, AT BASE BUILDING ELECTRICAL SWITCH HEIGHT UNLESS OTHERWISE INDICATED.
	GANGABLE WALL BOX, 4-11/16" HIGH X 2-1/2" DEEP, FOR INTERCOM RECEPTABLES. MOUNT FLUSH WITH FINISHED WALL TREATMENT, AT BASE BUILDING ELECTRICAL SWITCH HEIGHT UNLESS OTHERWISE INDICATED. SUBNUMBER INDICATES GANG #
	GANGABLE WALL BOX, 4-11/16" HIGH X 2-1/2" DEEP, FOR WALL MOUNTED VOLUME CONTROLLER. MOUNT FLUSH WITH FINISHED WALL TREATMENT. COORDINATE HEIGHT WITH ARCHITECTURAL AND ADA REQUIREMENTS. SUBNUMBER INDICATES GANG #
	BACK BOX FOR WALL-MOUNTED AUDIOVISUAL CONTROL SYSTEM TOUCH PANEL. BACK BOX TO BE OBM BY MANUFACTURER. REFERENCED TO MODEL NUMBER. MOUNT FLUSH WITH FINISHED WALL TREATMENT. COORDINATE HEIGHT WITH ARCHITECTURAL AND ADA REQUIREMENTS.
	SINGLE-GANG WALL BOX, 4-11/16" HIGH X 2-1/2" DEEP, FOR MICROPHONE ANTENNA OR ASSISTIVE LISTENING ANTENNA. MOUNT FLUSH WITH FINISHED WALL TREATMENT, AT SPECIFIED HEIGHT. SUBNUMBER INDICATES GANG #
	SINGLE-GANG WALL BOX, 4-11/16" HIGH X 2-1/2" DEEP, WITH 1-1/4" CONDUIT KNOCKOUTS AND BLANK COVER PLATE, FOR PIPE MOUNTED SPEAKER OR SUBWOOFER. MOUNT ON PIPE GRID.
	WALL SWITCH FOR PROJECTION SCREEN, RAISE/STOP/LOWER, SUPPLIED WITH SCREEN. MOUNT FLUSH WITH FINISHED WALL TREATMENT, AT BASE BUILDING ELECTRICAL SWITCH HEIGHT UNLESS OTHERWISE INDICATED.
	POWER RECEPTACLE, DUPLEX, 120 VAC, 20 AMP, HOSPITAL GRADE ORANGE. MOUNT AT BASE BUILDING OUTLET HEIGHT, UNLESS OTHERWISE INDICATED.
	WALL-MOUNTED TELECOM VOICE/DATA OUTLET BOX. QUANTITY AND TYPE OF CABLEING AS PER PROJECT STANDARDS, UNLESS OTHERWISE NOTED. REFER TO THE ARCHITECTURAL DRAWINGS FOR DIMENSIONED LOCATION. MOUNT AT BASE BUILDING OUTLET HEIGHT, UNLESS OTHERWISE INDICATED.
	GANGABLE WALL BOX, 4-11/16" HIGH X 2-1/2" DEEP, WITH 1-1/4" CONDUIT KNOCKOUTS AND BLANK COVER PLATE, FOR AUDIOVISUAL CONNECTIVITY. MOUNT FLUSH WITH FINISHED CEILING TREATMENT. SUBNUMBER INDICATES NUMBER OF GANG.
	CEILING LOUDSPEAKER BACK BOX, GRILLE AND TILE BRIDGE. MOUNT FLUSH WITH FINISHED CEILING, AS SHOWN ON THE ARCHITECTURAL CEILING PLANS, UNLESS OTHERWISE INDICATED. CONFIRM THE INTEGRITY OF THE CEILING GRID SYSTEM WITH THE STRUCTURAL ENGINEER.
	PROJECTION SCREEN, PROJECTOR SLIT OR SHADE WITH LOW-VOLTAGE INTERFACE, SUPPLIED WITH DEVICE. MOUNT ABOVE FINISHED CEILING UNLESS OTHERWISE INDICATED. MAINTENANCE ACCESS BOX SHADE PROVIDED IN NON-ACCESSIBLE CEILINGS. PROVIDE UTILITY-GRADE 120VAC UNLESS OTHERWISE INDICATED.
	POWER RECEPTACLE, DUPLEX, 120 VAC, 20 AMP, HOSPITAL GRADE ORANGE, SEPARATE CIRCUIT. MOUNT FLUSH WITH FINISHED CEILING UNLESS OTHERWISE INDICATED.
	CEILING MOUNTED TELECOM DATA OUTLET BOX. QUANTITY AND TYPE OF CABLEING AS PER PROJECT STANDARDS, UNLESS OTHERWISE INDICATED. REFER TO THE ARCHITECTURAL DRAWINGS FOR DIMENSIONED LOCATION.

AUDIOVISUAL ELECTRICAL NOTES

1. **POWER AND DATA ON THE AV DRAWINGS ARE FOR REFERENCE ONLY!**
PLEASE REFER TO ELECTRICAL AND LOW VOLTAGE DRAWINGS FOR EXACT QUANTITIES AND LOCATIONS ASSOCIATED AV CONDUIT AND BOXES ON THE AV DRAWINGS ARE FOR DESIGN AND CONSTRUCTION ISSUE.
2. **WHERE EXACT DIMENSIONS ARE NOT CALLED FOR, THE SCALE OF THIS DRAWING IS SUFFICIENTLY ACCURATE FOR DETERMINING ROUGH LOCATION OF EQUIPMENT, JUNCTION BOXES, OUTLET BOXES, WIRELESS PANELS, ETC. WHERE EXACT DIMENSIONS ARE CALLED FOR, THE REFERENCE SURFACE SHALL BE THE FINAL FINISHED SURFACE INCLUDING ANY ACoustICAL TREATMENT. ROOM DIMENSIONS ON THIS DRAWING HAVE BEEN TAKEN FROM PRELIMINARY ARCHITECTURAL DRAWINGS.**
3. **POWER CONDUIT, POWER WIREWAYS AND POWER JUNCTION BOXES ARE TO BE REVIEWED BY THE ELECTRICAL ENGINEER FOR CODE COMPLIANCE.**
4. **EMPTY CONDUITS RUNS ON THIS DRAWING SHOW ONLY INTERCONNECTION BETWEEN THE TERMINATION POINTS. THE EXACT PATH OF CONDUIT ARE TO BE DETERMINED BY FIELD CONDITIONS.**
5. **ALL EMPTY CONDUIT ON THIS DRAWING TO BE "F" UNLESS OTHERWISE NOTED. ALL EMPTY CONDUIT SHALL BE DEBURRED, CLEANED, CAPPED, TAGGED AND FURNISHED WITH PULL WIRES.**
6. **THERE SHALL BE A MINIMUM OF ONE PULL BOX FOR EVERY 100 FEET OF STRAIGHT EMPTY CONDUIT AND A PULL BOX FOR MORE THAN TWO 90° BENDS IN A CONDUIT RUN.**
7. **POWER RECEPTACLES SHOWN ON THIS DRAWING ARE DEDICATED TO SPECIFIC AUDIOVISUAL AND TELEVISION EQUIPMENT. REFER TO ELECETS COVERED. THESE CIRCUITS WILL BE CONNECTED BY OTHERS DURING INSTALLATION OF THE AUDIOVISUAL SYSTEMS EQUIPMENT.**
8. **POWER BREAKER PANELS ARE SIZED AND SPECIFIED BY THE ELECTRICAL ENGINEER. REFER TO ELECTRICAL DRAWINGS. ALL CIRCUITS SHALL BE PROTECTED BY 120VAC, 20 AMP BREAKERS UNLESS OTHERWISE DETAILED.**
9. **WHERE POWER CIRCUITS ARE SHOWN TERMINATING IN JUNCTION BOXES WITHOUT RECEPTACLES, THE WIRES SHALL BE TAPED AND THE BOXES COVERED. THESE CIRCUITS WILL BE CONNECTED BY OTHERS DURING INSTALLATION OF THE AUDIOVISUAL SYSTEMS EQUIPMENT.**
10. **THE METHOD OF INSTALLATION OF BOXES IN WALLS, AND THE METHOD OF PASSAGE OF CONDUITS AND WIREWAYS THROUGH ACOUSTICALLY SENSITIVE WALLS SHALL BE COORDINATED WITH THE ACOUSTICAL CONSULTANT.**

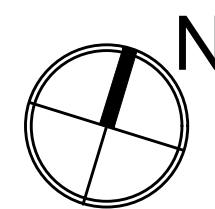

MATERIAL KEYING LEGEND:

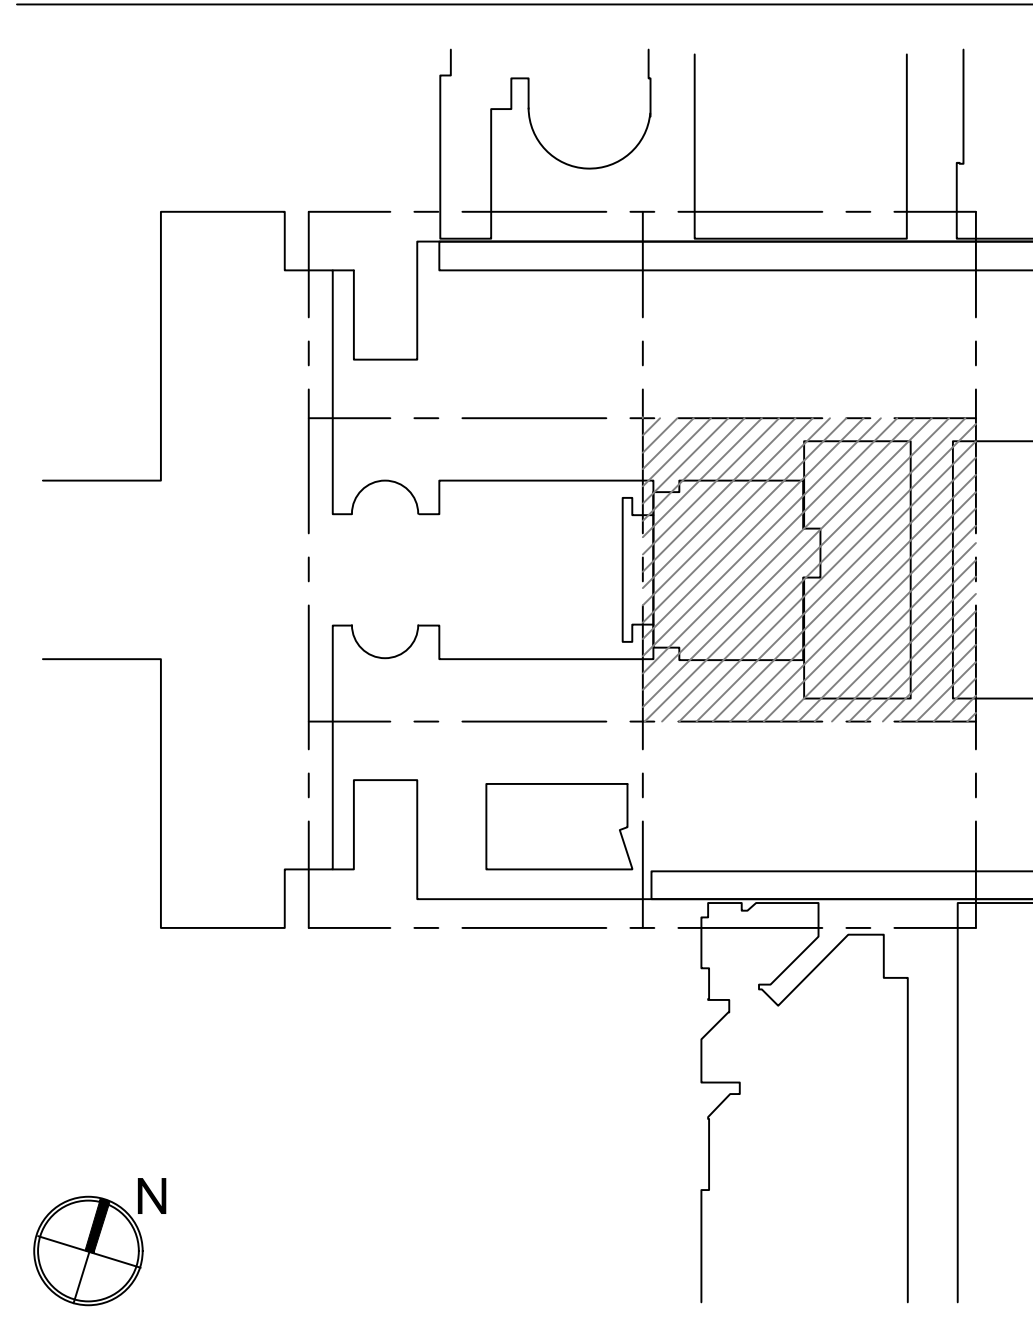

KEY PLAN

5	GROUP III AV BID DOCUMENTS	09/06/2017
2	BID DOCUMENTS	05/28/2014
1	DESIGN MANUAL PHASE SUBMISSION	04/01/2013

F X F O W L E

FXFOWLE ARCHITECTS, LLP | 22 WEST 19TH STREET | NEW YORK, NY 10011 | T 212.627.1700 | F 212.463.8716 | WWW.FXFOWLE.COM
STRUCTURAL ENGINEER
DESIMONE CONSULTING ENGINEERS
 18 West 18th Street, 10th Floor, New York, New York 10011 212-532-2211

MECHANICAL, ELECTRICAL, PLUMBING, FIRE PROTECTION ENGINEER
COLLADO ENGINEERING
 2 Holland Avenue, White Plains, NY 10603 914-332-7668

THEATER PLANNING CONSULTANT
FISHER DACHS ASSOCIATES
 22 West 19th Street, 6th Floor, New York, NY 10011 212-691-3020

ACOUSTICS & AUDIO / VISUAL CONSULTANT
CERAMI & ASSOCIATES
404 Fifth Avenue, New York, NY 10018 212-370-1771

LIGHTING CONSULTANT
ILLUMINATION ARTS
850 Bloomfield Avenue, Suite 101, Bloomfield NJ 07003 973-771-1550

LANDSCAPE CONSULTANT
W ARCHITECTURE & LANDSCAPE ARCHITECTURE, LLC
155 Fifth Avenue Third Floor New York, NY 10010 P 212-981-3933 F 212-620-0798

CIVIL ENGINEER & HAZMAT
LANGAN

ELEVATOR CONSULTANT
VDA (VAN DEUSEN & ASSOCIATES)
Seven Penn Plaza, Suite 404 New York, NY 10001 Phone: 212-868-9090 Fax: 212-868-9099

IT CONSULTANT
GRID ASSOCIATES, LLC
P.O. Box 1785 Hoboken, NJ 07030 T 646.722.6600 / F 646.722.6652


SUSTAINABILITY / LEED
YR&G
161 Broadway • 4th Floor, New York, NY 10002 T 917 677 8023 / F 917 677 8023


COST ESTIMATING CONSULTANT
TOSCANO CLEMENTS TAYLOR, LLC
16 Oakwood Road Huntington, NY 11743 T 631.382.1400 / F

C.I.T.L. PROJ. # 29402
SUNY PURCHASE COLLEGE
735 ANDERSON HILL ROAD | PURCHASE, NY 10577

DRAWING TITLE:
AUDIOVISUAL-ADD ALTERNATE ELECTRICAL
CONCOURSE (BASEMENT LEVEL) PLAN

Seat:	Drawn: AJJC	Project No.: 29402 (SUJCF) / 00018.L00 (FXI)
	Checked: BJJM	Cad File:
	Reviewed: BJJM	Drawing No.:
	Date:	TA312.0_A
	Scale: 1/8" = 1'-0"	

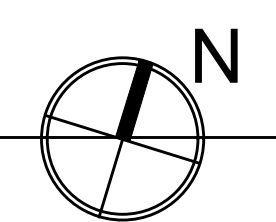

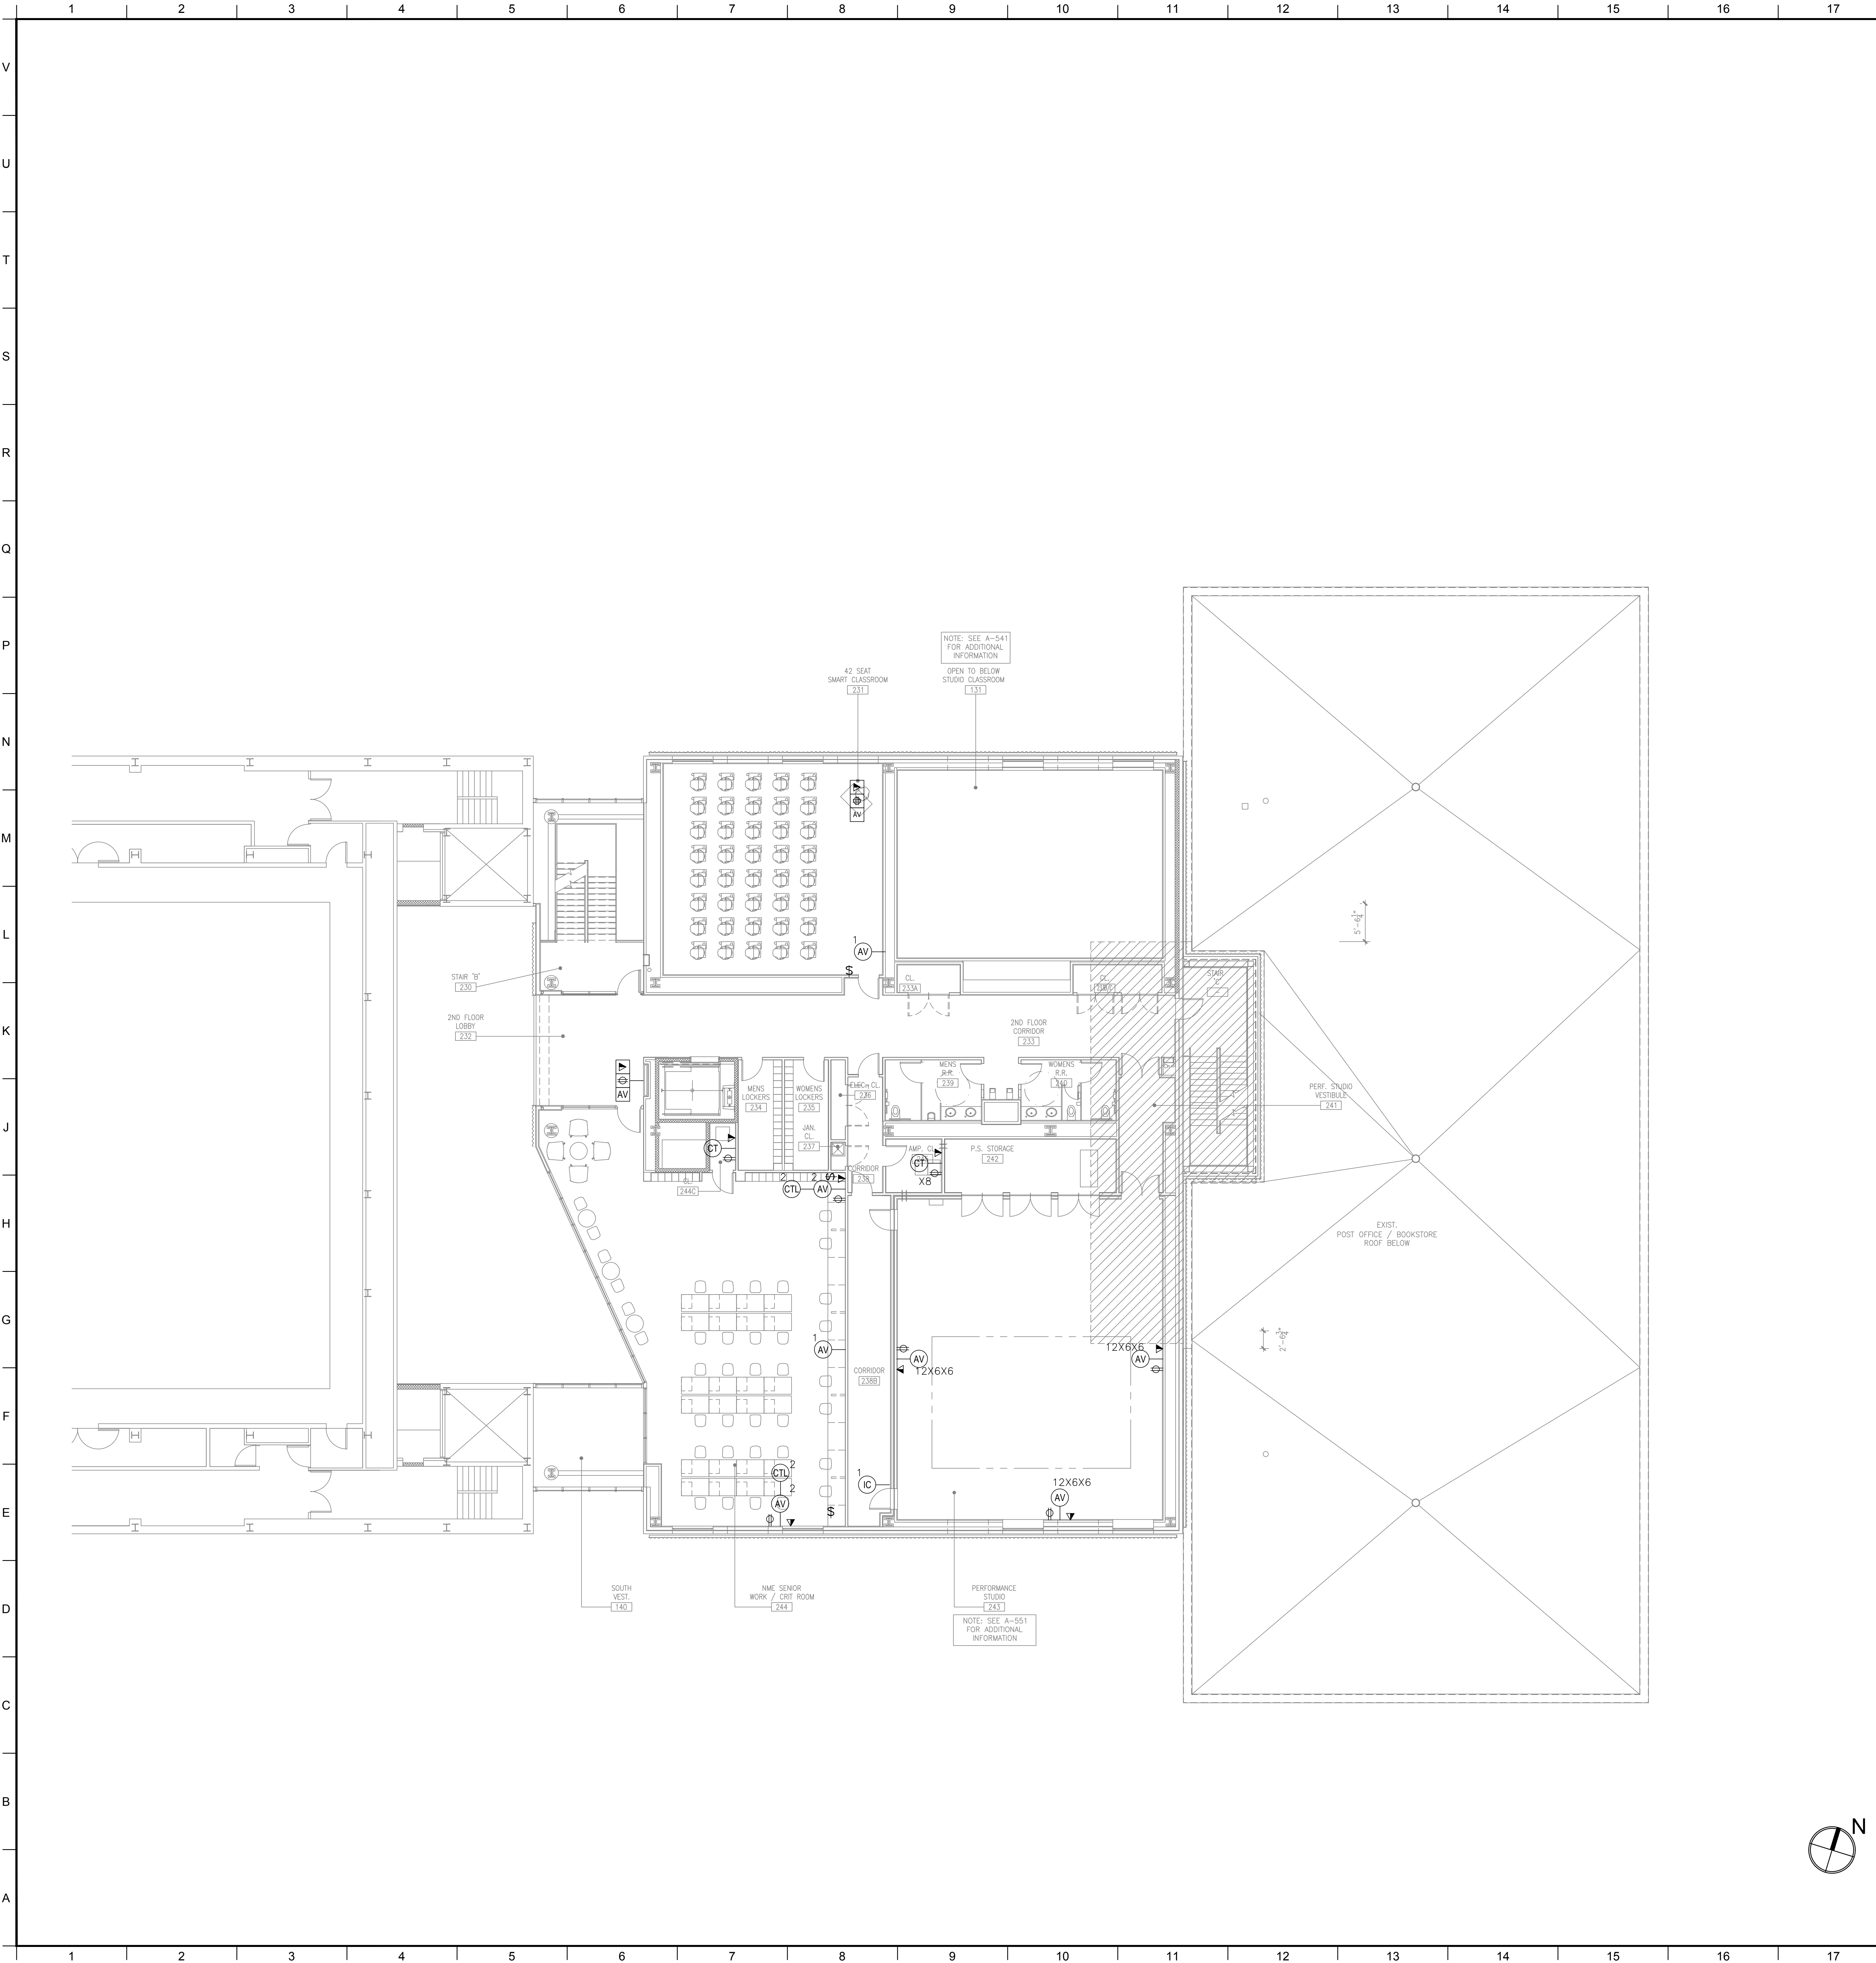


AUDIOVISUAL ELECTRICAL LEGEND

SYMBOL	DESCRIPTION
	MULTI-DISCIPLINE FLOOR BOX OR POKE-THRU, WITH HINGED COVER PLATE AND CARPET FLANGE, WITH DIVIDED COMPARTMENTS FOR SHARED ACCESS WITH VOICE, DATA AND 120VAC POWER. FLUSH MOUNT IN FLOOR UNLESS OTHERWISE INDICATED. (4" DEEP MINIMUM) UNLESS OTHERWISE INDICATED. SEE AUDIOVISUAL DETAIL SHEETS.
	SCREW COVER JUNCTION BOX FOR AUDIOVISUAL CONDUIT TERMINATION, SIZED ACCORDINGLY. ALL CONDUITS TERMINATE AT THIS BOX UNLESS OTHERWISE INDICATED.
	MULTI-DISCIPLINE IN-WALL BOX, WITH DIVIDED COMPARTMENTS FOR SHARED ACCESS WITH VOICE, DATA AND 120VAC POWER. MOUNT FLUSH WITH FINISHED WALL TREATMENT, BEHIND DISPLAY. UNLESS OTHERWISE INDICATED. SEE AUDIOVISUAL DETAIL SHEETS.
	GANGABLE WALL BOX, 4-11/16" HIGH X 2-1/2" DEEP, FOR AUDIO/VIDEO RECEPTACLES, MOUNT FLUSH WITH FINISHED WALL TREATMENT, AT BASE BUILDING ELECTRICAL SWITCH HEIGHT UNLESS OTHERWISE INDICATED. SUBNUMBER INDICATE GANG #
	WALL BOX, HEIGHT AND WIDTH AS SPECIFIED, FOR AUDIO/VIDEO RECEPTACLES, MOUNT FLUSH WITH FINISHED WALL TREATMENT, AT BASE BUILDING ELECTRICAL SWITCH HEIGHT UNLESS OTHERWISE INDICATED.
	GANGABLE WALL BOX, 4-11/16" HIGH X 2-1/2" DEEP, FOR INTERCOM RECEPTACLES, MOUNT FLUSH WITH FINISHED WALL TREATMENT, AT BASE BUILDING ELECTRICAL SWITCH HEIGHT UNLESS OTHERWISE INDICATED. SUBNUMBER INDICATES GANG #
	GANGABLE WALL BOX, 4-11/16" HIGH X 2-1/2" DEEP, FOR MOUNTED VOLUME CONTROLLER, MOUNT FLUSH WITH FINISHED WALL TREATMENT, COORDINATE HEIGHT WITH ARCHITECTURAL AND ADA REQUIREMENTS. SUBNUMBER INDICATES GANG #
	BACK BOX FOR WALL-MOUNTED AUDIOVISUAL CONTROL SYSTEM TOUCH PANEL. BACK BOX TO BE OEM BY MANUFACTURER, REFERENCED TO MODEL NUMBER, MOUNT FLUSH WITH FINISHED WALL TREATMENT, COORDINATE HEIGHT WITH ARCHITECTURAL AND ADA REQUIREMENTS.
	SINGLE-GANG WALL BOX, 4-11/16" HIGH X 2-1/2" DEEP, FOR MICROPHONE ANTENNA OR ASSISTIVE LISTENING ANTENNA, MOUNT FLUSH WITH FINISHED WALL TREATMENT, AT SPECIFIED HEIGHT. SUBNUMBER INDICATES GANG #
	SINGLE-GANG WALL BOX, 4-11/16" HIGH X 2-1/2" DEEP, WITH 1-1/4" CONDUIT KNOCKOUTS AND BLANK COVER PLATE, FOR PIPE MOUNTED SPEAKER OR SUBWOOFER, MOUNT ON PIPE GRID.
	WALL SWITCH FOR PROJECTION SCREEN, RAISE/STOP/LOWER, SUPPLIED WITH SCREEN. MOUNT FLUSH WITH FINISHED WALL TREATMENT, AT BASE BUILDING ELECTRICAL SWITCH HEIGHT UNLESS OTHERWISE INDICATED.
	POWER RECEPTACLE, DUPLEX, 120 VAC, 20 AMP, HOSPITAL GRADE ORANGE. MOUNT AT BASE BUILDING OUTLET HEIGHT, UNLESS OTHERWISE INDICATED.
	WALL-MOUNTED TELECOM VOICE/DATA OUTLET BOX, QUANTITY AND TYPE OF CABLING AS PER PROJECT STANDARDS, UNLESS OTHERWISE NOTED. REFER TO THE ARCHITECTURAL DRAWINGS FOR DIMENSIONED LOCATION, MOUNT AT BASE BUILDING OUTLET HEIGHT, UNLESS OTHERWISE INDICATED.
	GANGABLE WALL BOX, 4-11/16" HIGH X 2-1/2" DEEP, WITH 1-1/4" CONDUIT KNOCKOUTS AND BLANK COVER PLATE, FOR AUDIOVISUAL CONNECTIVITY, MOUNT FLUSH WITH FINISHED CEILING TREATMENT. SUBNUMBER INDICATES NUMBER OF GANG.
	CEILING LOUDSPEAKER BACK BOX, GRILLE AND TILE BRIDGE, MOUNT FLUSH WITH FINISHED CEILING, AS SHOWN ON THE ARCHITECTURAL CEILING PLANS, UNLESS OTHERWISE INDICATED. CONFIRM THE INTEGRITY OF THE CEILING GRID SYSTEM WITH THE STRUCTURAL ENGINEER.
	PROJECTION SCREEN, PROJECTOR LIFT OR SHADE WITH LOW-VOLTAGE INTERFACE, SUPPLIED WITH DEVICE. MOUNT ABOVE FINISHED CEILING UNLESS OTHERWISE INDICATED. MAINTENANCE ACCESS TO BOX SHALL BE PROVIDED IN NON-ACCESSIBLE CEILINGS. PROVIDE UTILITY-GRADE 120VAC UNLESS OTHERWISE INDICATED.
	POWER RECEPTACLE, DUPLEX, 120 VAC, 20 AMP, HOSPITAL GRADE ORANGE, SEPARATE CIRCUIT, MOUNT FLUSH WITH FINISHED CEILING UNLESS OTHERWISE INDICATED.
	CEILING MOUNTED TELECOM DATA OUTLET BOX, QUANTITY AND TYPE OF CABLING AS PER PROJECT STANDARDS, UNLESS OTHERWISE INDICATED, REFER TO THE ARCHITECTURAL DRAWINGS FOR DIMENSIONED LOCATION.

AUDIOVISUAL ELECTRICAL NOTES

- POWER AND DATA ON THE AV DRAWINGS ARE "FOR REFERENCE ONLY". PLEASE REFER TO ELECTRICAL AND LOW VOLTAGE DRAWINGS FOR EXACT QUANTITIES AND LOCATIONS. ASSOCIATED AV CONDUIT AND BOXES ON THE AV DRAWINGS ARE FOR DESIGN AND CONSTRUCTION ISSUE.
- WHERE EXACT DIMENSIONS ARE NOT CALLED FOR, THE SCALE OF THIS DRAWING IS SUFFICIENTLY ACCURATE FOR DETERMINING ROUGH LOCATION OF EQUIPMENT. JUNCTION BOXES, OUTLET BOXES, WIREWAYS, PANELS, ETC., WHERE EXACT DIMENSIONS ARE CALLED FOR, THE REFERENCE SURFACE SHALL BE THE FINAL FINISHED SURFACE INCLUDING ANY ACOUSTICAL TREATMENT. ROOM DIMENSIONS ON THIS DRAWING HAVE BEEN TAKEN FROM PRELIMINARY ARCHITECTURAL DRAWINGS.
- POWER CONDUIT, POWER WIREWAYS AND POWER JUNCTION BOXES ARE TO BE REVIEWED BY THE ELECTRICAL ENGINEER FOR CODE COMPLIANCE.
- EMPTY CONDUITS RUNS ON THIS DRAWING SHOW ONLY INTERCONNECTION BETWEEN THE TERMINATION POINTS. THE EXACT PATH OF CONDUIT ARE TO BE DETERMINED BY FIELD CONDITIONS.
- ALL EMPTY CONDUIT ON THIS DRAWING TO BE 1" UNLESS OTHERWISE NOTED. ALL EMPTY CONDUIT SHALL BE DEBURRED, CLEANED, CAPPED, TAGGED AND FURNISHED WITH PULL WIRES.
- THERE SHALL BE A MINIMUM OF ONE PULL BOX FOR EVERY 100 FEET OF STRAIGHT EMPTY CONDUIT AND A PULL BOX FOR MORE THAN TWO 90° BENDS IN A CONDUIT RUN.
- POWER RECEPTACLES SHOWN ON THIS DRAWING ARE DEDICATED TO SPECIFIC AUDIOVISUAL AND TELEVISION EQUIPMENT. REFER TO ELECTRICAL DRAWINGS FOR ADDITIONAL UTILITY POWER RECEPTACLES.
- POWER BREAKER PANELS ARE SIZED AND SPECIFIED BY THE ELECTRICAL ENGINEER. REFER TO ELECTRICAL DRAWINGS. ALL CIRCUITS SHALL BE PROTECTED BY 120VAC, 20 AMP BREAKERS UNLESS OTHERWISE DETAILED.
- WHERE POWER CIRCUITS ARE SHOWN TERMINATING IN JUNCTION BOXES WITHOUT RECEPTACLES, THE WIRES SHALL BE TAPED AND THE BOXES COVERED. THESE CIRCUITS WILL BE CONNECTED BY OTHERS DURING INSTALLATION OF THE AUDIOVISUAL SYSTEMS EQUIPMENT.
- THE METHOD OF INSTALLATION OF BOXES IN WALLS, AND THE METHOD OF PASSAGE OF CONDUITS AND WIREWAYS THROUGH ACOUSTICALLY SENSITIVE WALLS SHALL BE COORDINATED WITH THE ACOUSTICAL CONSULTANT.

MATERIAL KEYING LEGEND:

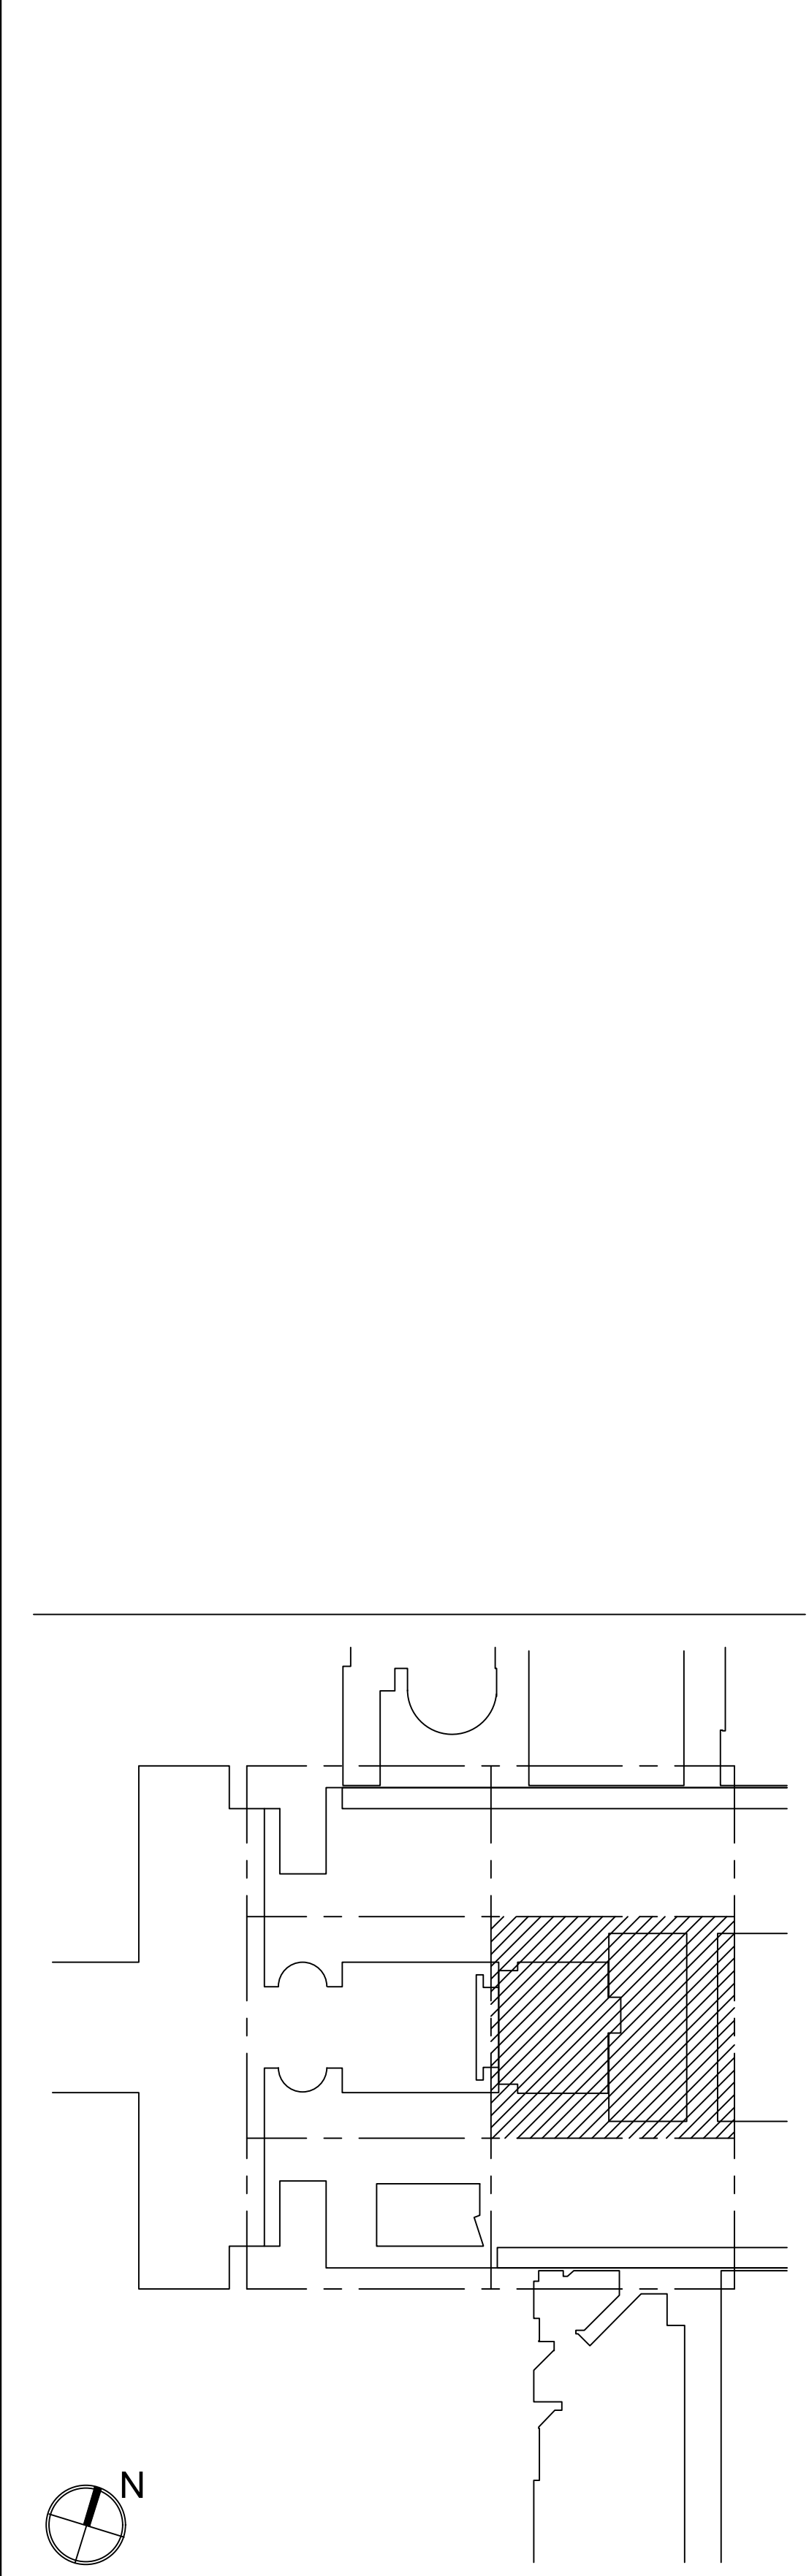

KEY PLAN

NO.	REVISIONS / SUBMISSIONS	DATE
5	GROUP III AV BID DOCUMENTS	08.06.2017
2	BID DOCUMENTS	05.28.2014
1	DESIGN MANUAL PHASE SUBMISSION	04.01.2013

FX FOWLE
FX FOWLE ARCHITECTS, LLP | 22 WEST 10TH STREET | NEW YORK, NY 10011 | T 212.421.1700 | F 212.452.8716 | WWW.FX FOWLE.COM

STRUCTURAL ENGINEERS:
DESIMONE CONSULTING ENGINEERS
18 West 18th Street, 10th Floor, New York, New York 10011 | 212-532-2211

MECHANICAL, ELECTRICAL, PLUMBING, FIRE PROTECTION ENGINEER:
COLLADO ENGINEERING
2 Holmdel Avenue, White Plains, NY 10603 | 914-332-7658

THEATER PLANNING CONSULTANT:
FISHER DACHS ASSOCIATES
22 West 10th Street, 8th Floor, New York, NY 10011 | 212-691-3020

ACOUSTICS & AUDIO VISUAL CONSULTANT:
CERAMI & ASSOCIATES
404 Fifth Avenue, New York, NY 10018 | 212-370-1776

LIGHTING CONSULTANT:
ILLUMINATION ARTS
650 Broadway Avenue, Suite 101, Bloomfield NJ 07003 | 973-771-1558

LANDSCAPE CONSULTANT:
W ARCHITECTURE & LANDSCAPE ARCHITECTURE, LLC
105 10th Avenue, Third Floor New York, NY 10010 | P 212-961-3533 / F 212-620-0758

DESIGN ENGINEER & ARCHITECT:
LANGAN
21 Penn Plaza 360 West 31st Street 8th Floor New York, NY 10001 | 212-476-5400 | 212-476-5444 (fax)

ELEVATOR CONSULTANT:
VDA (VAN DEUSEN & ASSOCIATES)
Seven Penn Plaza, Suite 404 New York, NY 10001 | Phone: 212-608-9090 Fax: 212-608-9099

IT CONSULTANT:
GRID ASSOCIATES, LLC
P.O. Box 1778 Hoboken, NJ 07030 | T 946.722.0600 / F 946.722.0625

SUSTAINABILITY LEADER:
YR&G
161 Bowery - 4th Floor, New York, NY 10002 | T 917.677.8023 / F 917.677.8023

GUEST ESTIMATING CONSULTANT:
TOSCANO CLEMENT'S TAYLOR, LLC
16 Oakwood Road Huntington, NY 11743 | T 631.392.1400 / F 631.392.1399

C.I.T.L. PROJ. # 29402
SUNY PURCHASE COLLEGE
735 ANDERSON HILL ROAD | PURCHASE, NY 10577


DRAWING TITLE:
AUDIOVISUAL-ELECTRICAL - CITL BUILDING
2ND FLOOR (PLAZA +1 LEVEL) PLAN

Seat:	Drawn: AJC	Project No.: 29402 (SUCF) / 05018.L00 (FXP)
	Checked: BJM	Cad File:
	Reviewed: BJM	Drawing No.:
	Date:	

Scale:
1/8" = 1'-0"

TA-314.0

© 2009 FX FOWLE ARCHITECTS, LLP | ALL RIGHTS RESERVED

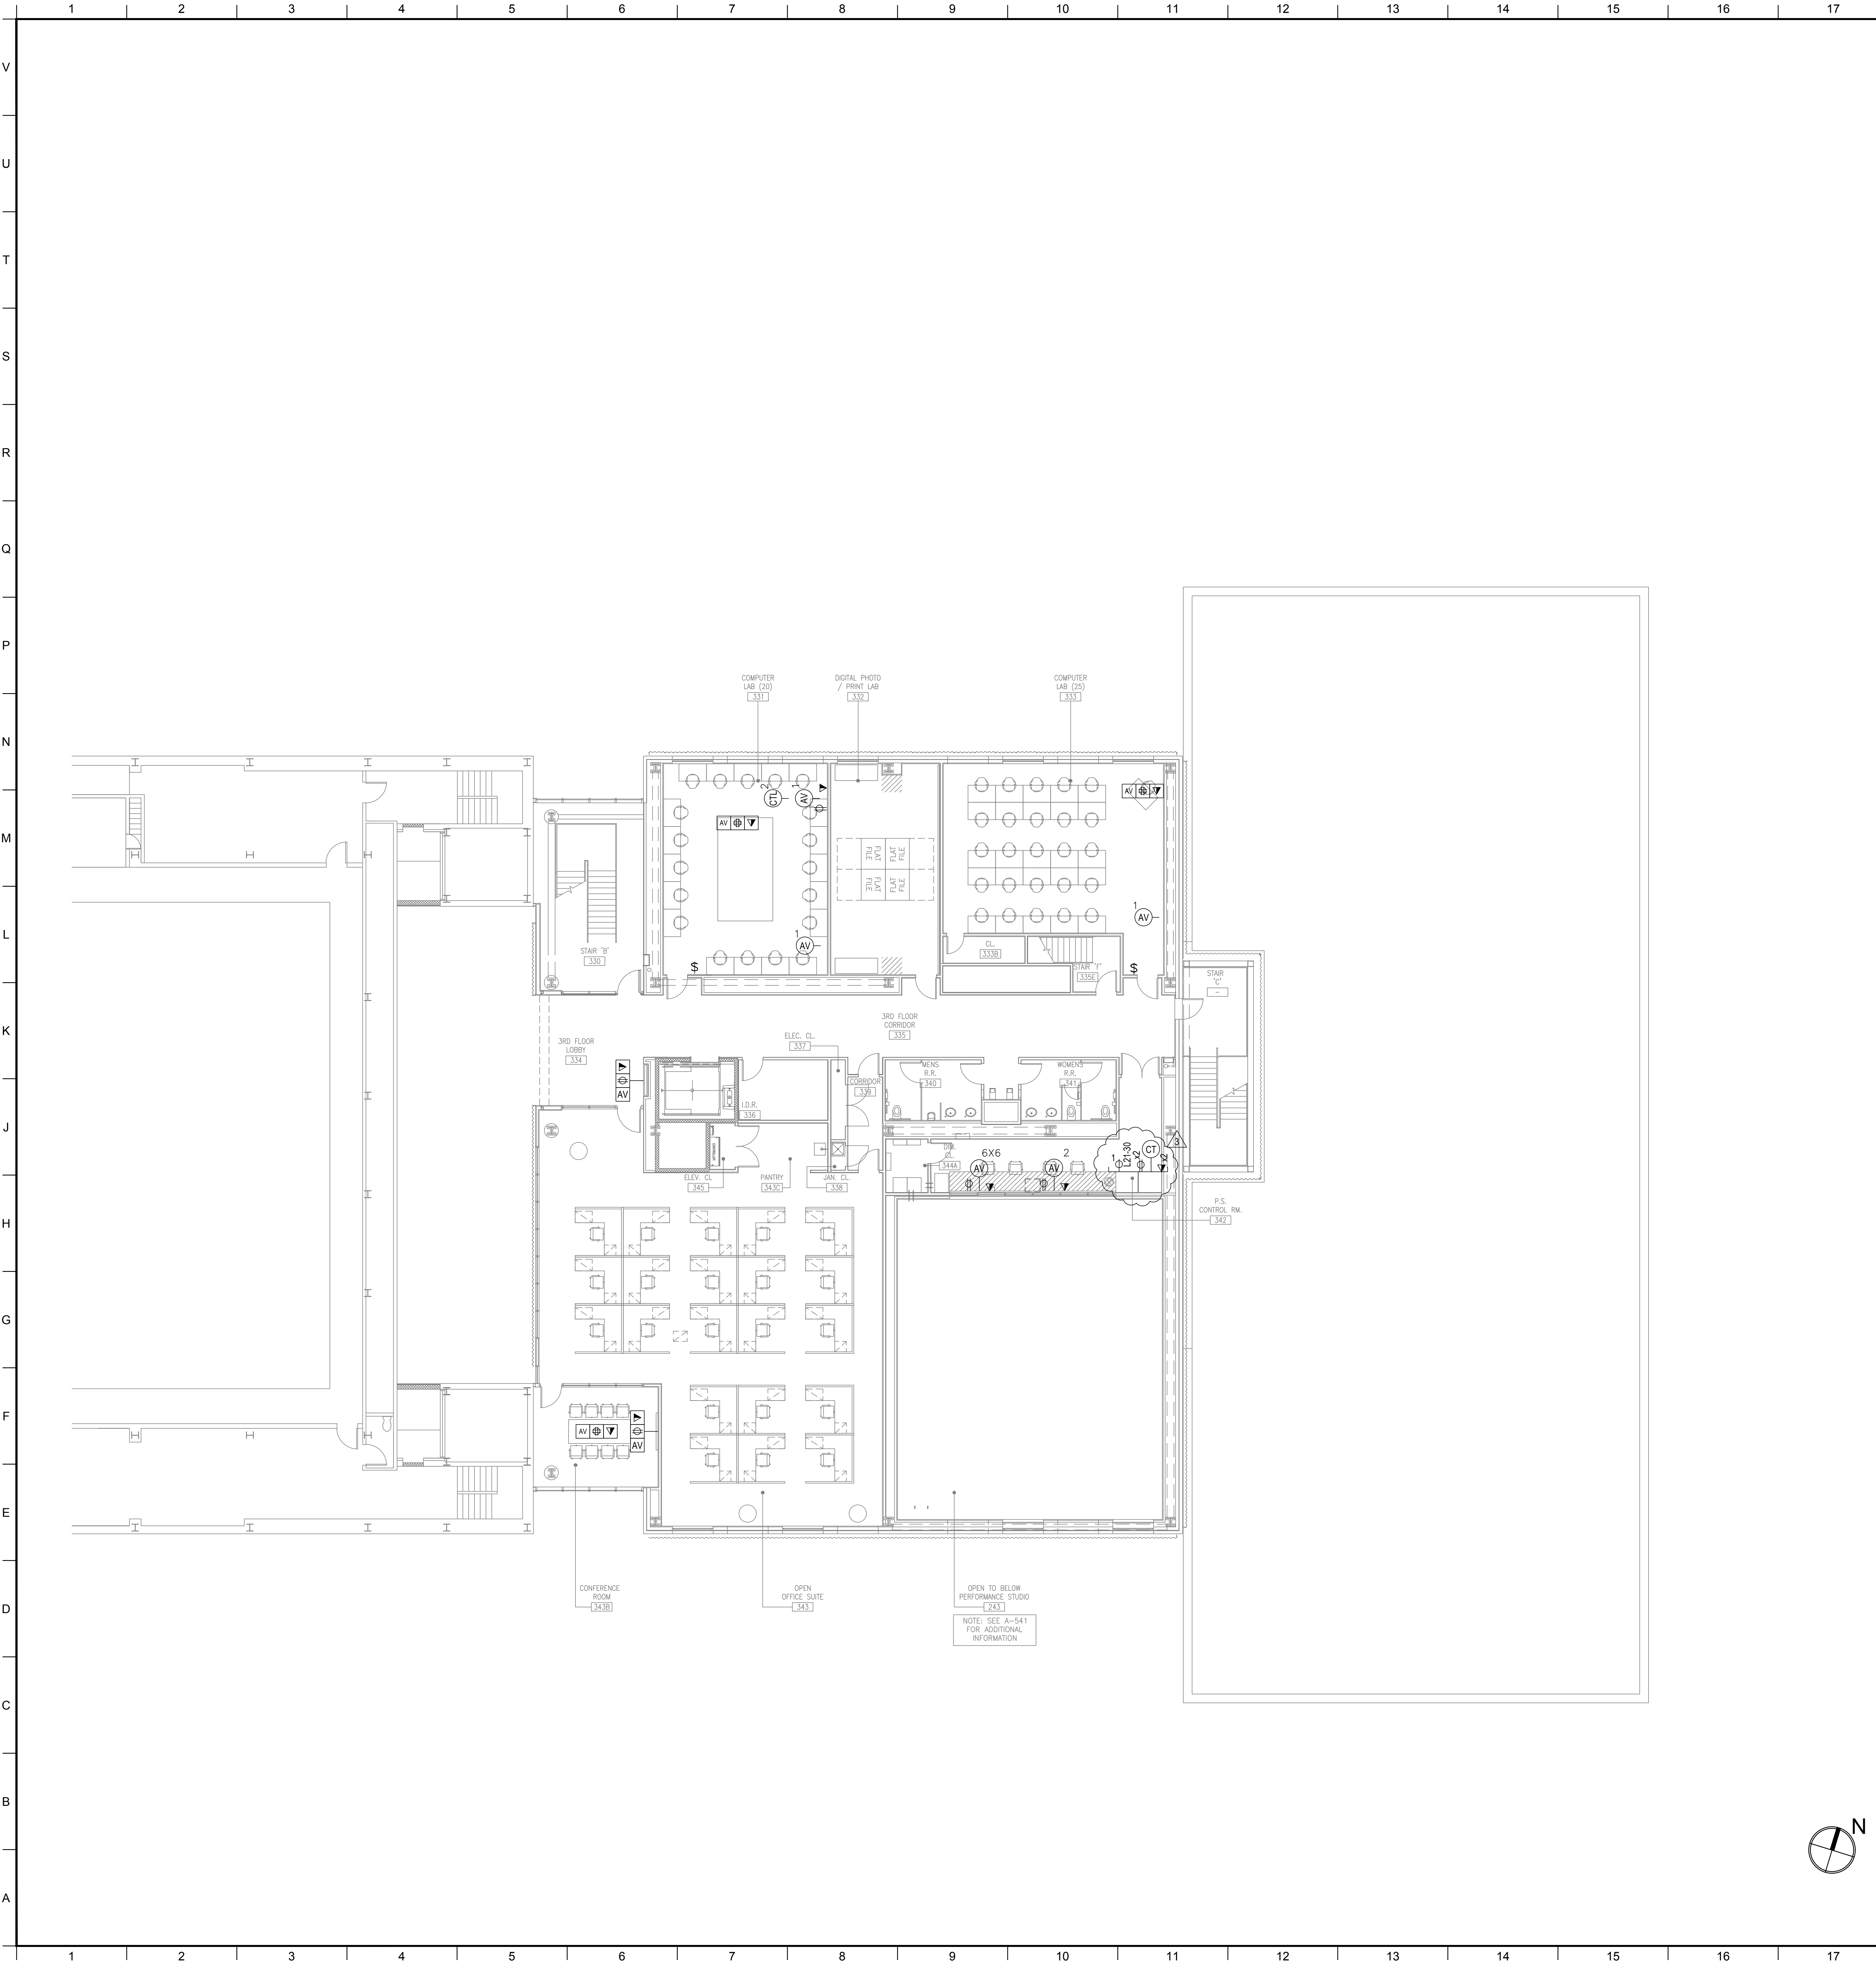

AUDIOVISUAL ELECTRICAL LEGEND

SYMBOL DESCRIPTION


-  MULTI-DISCIPLINE FLOOR BOX OR POKE-THRU, WITH HINGED COVER PLATE AND CARPET FLANGE, WITH DIVIDED COMPARTMENTS FOR SHARED ACCESS WITH VOICE, DATA AND 120VAC POWER. FLUSH MOUNT IN FLOOR UNLESS OTHERWISE INDICATED. (4" DEEP MINIMUM) UNLESS OTHERWISE INDICATED. SEE AUDIOVISUAL DETAIL SHEETS.
-  SCREW COVER JUNCTION BOX FOR AUDIOVISUAL CONDUIT TERMINATION, SIZED ACCORDINGLY. ALL CONDUITS TERMINATE AT THIS BOX UNLESS OTHERWISE INDICATED.
-  MULTI-DISCIPLINE IN-WALL BOX, WITH DIVIDED COMPARTMENTS FOR SHARED ACCESS WITH VOICE, DATA AND 120VAC POWER. MOUNT FLUSH WITH FINISHED WALL TREATMENT, BEHIND DISPLAY. UNLESS OTHERWISE INDICATED. SEE AUDIOVISUAL DETAIL SHEETS.
-  GANGABLE WALL BOX, 4-11/16" HIGH X 2-1/2" DEEP, FOR AUDIO/VIDEO RECEPTACLES, MOUNT FLUSH WITH FINISHED WALL TREATMENT. AT BASE BUILDING ELECTRICAL SWITCH HEIGHT UNLESS OTHERWISE INDICATED. SUBNUMBER INDICATE GANG #
-  WALL BOX, HEIGHT AND WIDTH AS SPECIFIED, FOR AUDIO/VIDEO RECEPTACLES, MOUNT FLUSH WITH FINISHED WALL TREATMENT, AT BASE BUILDING ELECTRICAL SWITCH HEIGHT UNLESS OTHERWISE INDICATED.
-  GANGABLE WALL BOX, 4-11/16" HIGH X 2-1/2" DEEP, FOR INTERROOM RECEPTACLES, MOUNT FLUSH WITH FINISHED WALL TREATMENT. AT BASE BUILDING ELECTRICAL SWITCH HEIGHT UNLESS OTHERWISE INDICATED. SUBNUMBER INDICATES GANG #
-  GANGABLE WALL BOX, 4-11/16" HIGH X 2-1/2" DEEP, FOR MOUNTED VOLUME CONTROLLER, MOUNT FLUSH WITH FINISHED WALL TREATMENT, COORDINATE HEIGHT WITH ARCHITECTURAL AND ADA REQUIREMENTS. SUBNUMBER INDICATES GANG #
-  BACK BOX FOR WALL-MOUNTED AUDIOVISUAL CONTROL SYSTEM TOUCH PANEL. BACK BOX TO BE OEM BY MANUFACTURER, REFERENCED TO MODEL NUMBER. MOUNT FLUSH WITH FINISHED WALL TREATMENT, COORDINATE HEIGHT WITH ARCHITECTURAL AND ADA REQUIREMENTS.
-  SINGLE-GANG WALL BOX, 4-11/16" HIGH X 2-1/2" DEEP, FOR MICROPHONE ANTENNA OR ASSISTIVE LISTENING ANTENNA, MOUNT FLUSH WITH FINISHED WALL TREATMENT, AT SPECIFIED HEIGHT. SUBNUMBER INDICATES GANG #
-  SINGLE-GANG WALL BOX, 4-11/16" HIGH X 2-1/2" DEEP, WITH 1-1/4" CONDUIT KNOCKOUTS AND BLANK COVER PLATE, FOR PIPE MOUNTED SPEAKER OR SUBWOOFER, MOUNT ON PIPE GRID.
-  WALL SWITCH FOR PROJECTION SCREEN, RAISE/STOP/LOWER, SUPPLIED WITH SCREEN. MOUNT FLUSH WITH FINISHED WALL TREATMENT, AT BASE BUILDING ELECTRICAL SWITCH HEIGHT UNLESS OTHERWISE INDICATED.
-  POWER RECEPTACLE, DUPLEX, 120 VAC, 20 AMP, HOSPITAL GRADE ORANGE. MOUNT AT BASE BUILDING OUTLET HEIGHT, UNLESS OTHERWISE INDICATED.
-  WALL-MOUNTED TELECOM VOICE/DATA OUTLET BOX, QUANTITY AND TYPE OF CABLING AS PER PROJECT STANDARDS, UNLESS OTHERWISE NOTED. REFER TO THE ARCHITECTURAL DRAWINGS FOR DIMENSIONED LOCATION, MOUNT AT BASE BUILDING OUTLET HEIGHT, UNLESS OTHERWISE INDICATED.

-  GANGABLE WALL BOX, 4-11/16" HIGH X 2-1/2" DEEP, WITH 1-1/4" CONDUIT KNOCKOUTS AND BLANK COVER PLATE, FOR AUDIOVISUAL CONNECTIVITY, MOUNT FLUSH WITH FINISHED CEILING TREATMENT. SUBNUMBER INDICATES NUMBER OF GANG.
-  CEILING LOUDSPEAKER BACK BOX, GRILLE AND TILE BRIDGE, MOUNT FLUSH WITH FINISHED CEILING, AS SHOWN ON THE ARCHITECTURAL CEILING PLANS, UNLESS OTHERWISE INDICATED. CONFIRM THE INTEGRITY OF THE CEILING GRID SYSTEM WITH THE STRUCTURAL ENGINEER.
-  PROJECTION SCREEN, PROJECTOR LIFT OR SHADE WITH LOW-VOLTAGE INTERFACE, SUPPLIED WITH DEVICE. MOUNT ABOVE FINISHED CEILING UNLESS OTHERWISE INDICATED. MAINTENANCE ACCESS TO BOX SHALL BE PROVIDED IN NON-ACCESSIBLE CEILINGS. PROVIDE UTILITY-GRADE 120VAC UNLESS OTHERWISE INDICATED.
-  POWER RECEPTACLE, DUPLEX, 120 VAC, 20 AMP, HOSPITAL GRADE ORANGE, SEPARATE CIRCUIT. MOUNT FLUSH WITH FINISHED CEILING UNLESS OTHERWISE INDICATED.
-  CEILING MOUNTED TELECOM DATA OUTLET BOX, QUANTITY AND TYPE OF CABLING AS PER PROJECT STANDARDS, UNLESS OTHERWISE INDICATED, REFER TO THE ARCHITECTURAL DRAWINGS FOR DIMENSIONED LOCATION.

AUDIOVISUAL ELECTRICAL NOTES

- POWER AND DATA ON THE AV DRAWINGS ARE "FOR REFERENCE ONLY". PLEASE REFER TO ELECTRICAL AND LOW VOLTAGE DRAWINGS FOR EXACT QUANTITIES AND LOCATIONS. ASSOCIATED AV CONDUIT AND BOXES ON THE AV DRAWINGS ARE FOR DESIGN AND CONSTRUCTION ISSUE.
- WHERE EXACT DIMENSIONS ARE NOT CALLED FOR, THE SCALE OF THIS DRAWING IS SUFFICIENTLY ACCURATE FOR DETERMINING ROUGH LOCATION OF EQUIPMENT, JUNCTION BOXES, OUTLET BOXES, WIREWAYS, PANELS, ETC. WHERE EXACT DIMENSIONS ARE CALLED FOR, THE REFERENCE SURFACE SHALL BE THE FINAL FINISHED SURFACE INCLUDING ANY ACOUSTICAL TREATMENT. ROOM DIMENSIONS ON THIS DRAWING HAVE BEEN TAKEN FROM PRELIMINARY ARCHITECTURAL DRAWINGS.
- POWER CONDUIT, POWER WIREWAYS AND POWER JUNCTION BOXES ARE TO BE REVIEWED BY THE ELECTRICAL ENGINEER FOR CODE COMPLIANCE.
- EMPTY CONDUITS RUNS ON THIS DRAWING SHOW ONLY INTERCONNECTION BETWEEN THE TERMINATION POINTS. THE EXACT PATH OF CONDUIT ARE TO BE DETERMINED BY FIELD CONDITIONS.
- ALL EMPTY CONDUIT ON THIS DRAWING TO BE 1" UNLESS OTHERWISE NOTED. ALL EMPTY CONDUIT SHALL BE DEBURRED, CLEANED, CAPPED, TAGGED AND FURNISHED WITH PULL WIRES.
- THERE SHALL BE A MINIMUM OF ONE PULL BOX FOR EVERY 100 FEET OF STRAIGHT EMPTY CONDUIT AND A PULL BOX FOR MORE THAN TWO 90° BENDS IN A CONDUIT RUN.
- POWER RECEPTACLES SHOWN ON THIS DRAWING ARE DEDICATED TO SPECIFIC AUDIOVISUAL AND TELEVISION EQUIPMENT. REFER TO ELECTRICAL DRAWINGS FOR ADDITIONAL UTILITY POWER RECEPTACLES.
- POWER BREAKER PANELS ARE SIZED AND SPECIFIED BY THE ELECTRICAL ENGINEER. REFER TO ELECTRICAL DRAWINGS. ALL CIRCUITS SHALL BE PROTECTED BY 120VAC, 20 AMP BREAKERS UNLESS OTHERWISE DETAILED.
- WHERE POWER CIRCUITS ARE SHOWN TERMINATING IN JUNCTION BOXES WITHOUT RECEPTACLES, THE WIRES SHALL BE TAPED AND THE BOXES COVERED. THESE CIRCUITS WILL BE CONNECTED BY OTHERS DURING INSTALLATION OF THE AUDIOVISUAL SYSTEMS EQUIPMENT.
- THE METHOD OF INSTALLATION OF BOXES IN WALLS, AND THE METHOD OF PASSAGE OF CONDUITS AND WIREWAYS THROUGH ACOUSTICALLY SENSITIVE WALLS SHALL BE COORDINATED WITH THE ACOUSTICAL CONSULTANT.

MATERIAL KEYING LEGEND:

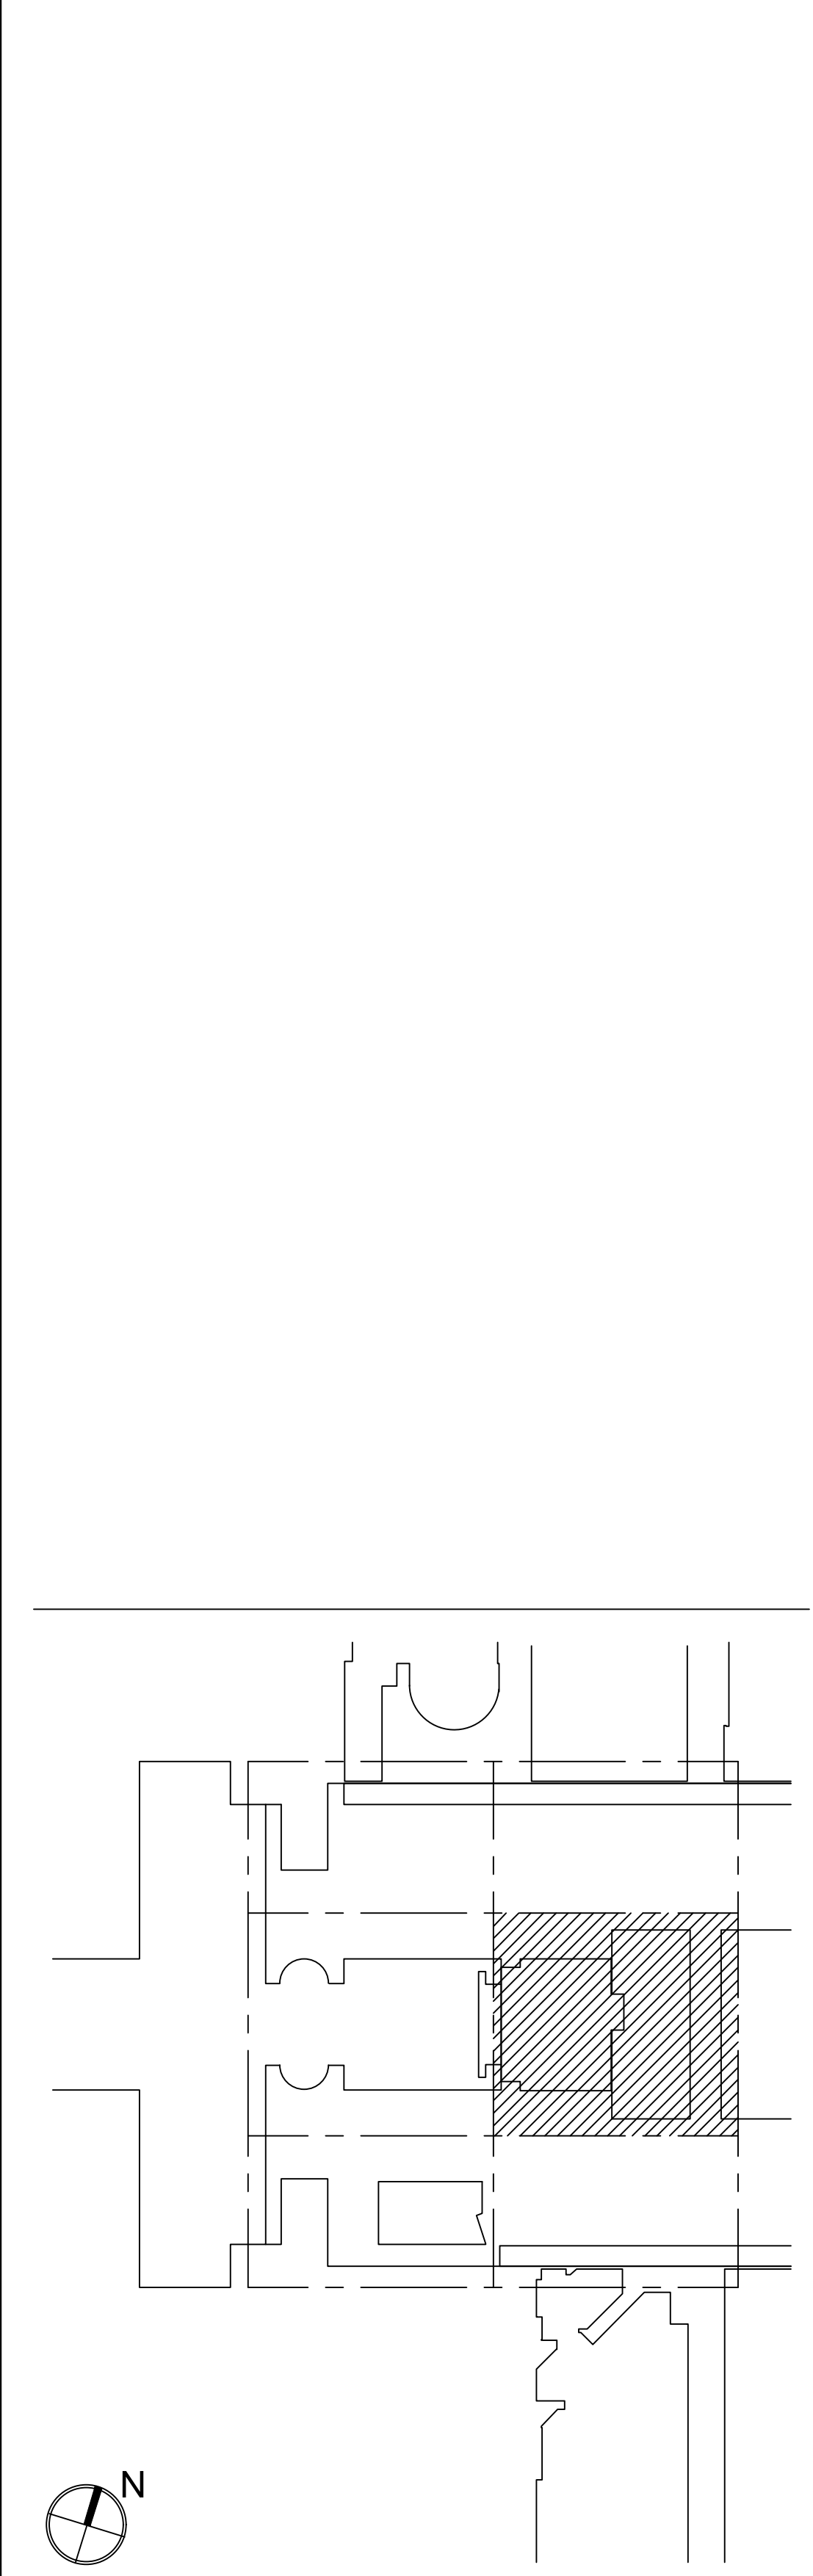

NO.	REVISIONS / SUBMISSIONS	DATE
5	GROUP III AV BID DOCUMENTS	08.06.2017
3	BULLETIN	08.23.2017
2	BID DOCUMENTS	05.28.2014
1	DESIGN MANUAL PHASE SUBMISSION	04.01.2013

FX FOWLE
FX FOWLE ARCHITECTS, LLP | 22 WEST 10TH STREET | NEW YORK, NY 10011 | T 212.427.1700 | F 212.453.8716 | WWW.FX FOWLE.COM

STRUCTURAL ENGINEERS:
DESIMONE CONSULTING ENGINEERS
18 West 18th Street, 10th Floor, New York, New York 10011 | 212-532-2211

MECHANICAL, ELECTRICAL, PLUMBING, FIRE PROTECTION ENGINEER:
COLLADO ENGINEERING
2 Holmden Avenue, White Plains, NY 10603 | 914-332-7658

THEATER PLANNING CONSULTANT:
FISHER DACHS ASSOCIATES
22 West 10th Street, 8th Floor, New York, NY 10011 | 212-691-3020

ACOUSTICS & AUDIO VISUAL CONSULTANT:
CERAMI & ASSOCIATES
404 Fifth Avenue, New York, NY 10018 | 212-370-1776

LIGHTING CONSULTANT:
ILLUMINATION ARTS
605 Broadfield Avenue, Suite 101, Bloomfield NJ 07003 | 973-771-1558

LANDSCAPE CONSULTANT:
W ARCHITECTURE & LANDSCAPE ARCHITECTURE, LLC
105 10th Avenue Third Floor New York, NY 10010 | P 212-961-3533 / F 212-620-0758

DOOR ENGINEER & HARDWARE:
LANGAN
21 Penn Plaza 360 West 31st Street 8th Floor New York, NY 10001 | 212-479-5400 | 212-479-5444 (fax)

ELEVATOR CONSULTANT:
VDA (VAN DEUSEN & ASSOCIATES)
Seven Penn Plaza, Suite 404 New York, NY 10001 | Phone: 212-608-9090 Fax: 212-608-9099

IT CONSULTANT:
GRID ASSOCIATES, LLC
P.O. Box 1778 Hoboken, NJ 07030 | T 946.722.9600 / F 946.722.9625

SUSTAINABILITY LEADER:
YR&G
161 Bowery - 4th Floor, New York, NY 10002 | T 917.677.8023 / F 917.677.8023

GUEST ESTIMATING CONSULTANT:
TOSCANO CLEMENT'S TAYLOR, LLC
16 Oakwood Road Huntington, NY 11743 | T 631.392.1400 / F 631.392.1399

C.I.T.L. PROJ. # 29402
SUNY PURCHASE COLLEGE
735 ANDERSON HILL ROAD | PURCHASE, NY 10577


DRAWING TITLE:
AUDIOVISUAL-ELECTRICAL - CITL BUILDING
3RD FLOOR (PLAZA +2 LEVEL) PLAN

Seal:	Drawn: AJC	Project No.: 29402 (SUCF) / 05018.L00 (FXP)
	Checked: BJM	Calc File:
	Reviewed: BJM	Drawing No.:
	Date:	


Scale:
1/8" = 1'-0"

TA-315.0

© 2009 FX FOWLE ARCHITECTS, LLP | ALL RIGHTS RESERVED

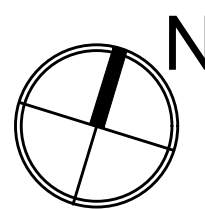

© 2008 EXFOWLE ARCHITECTS, LLP | ALL RIGHTS RESERVED

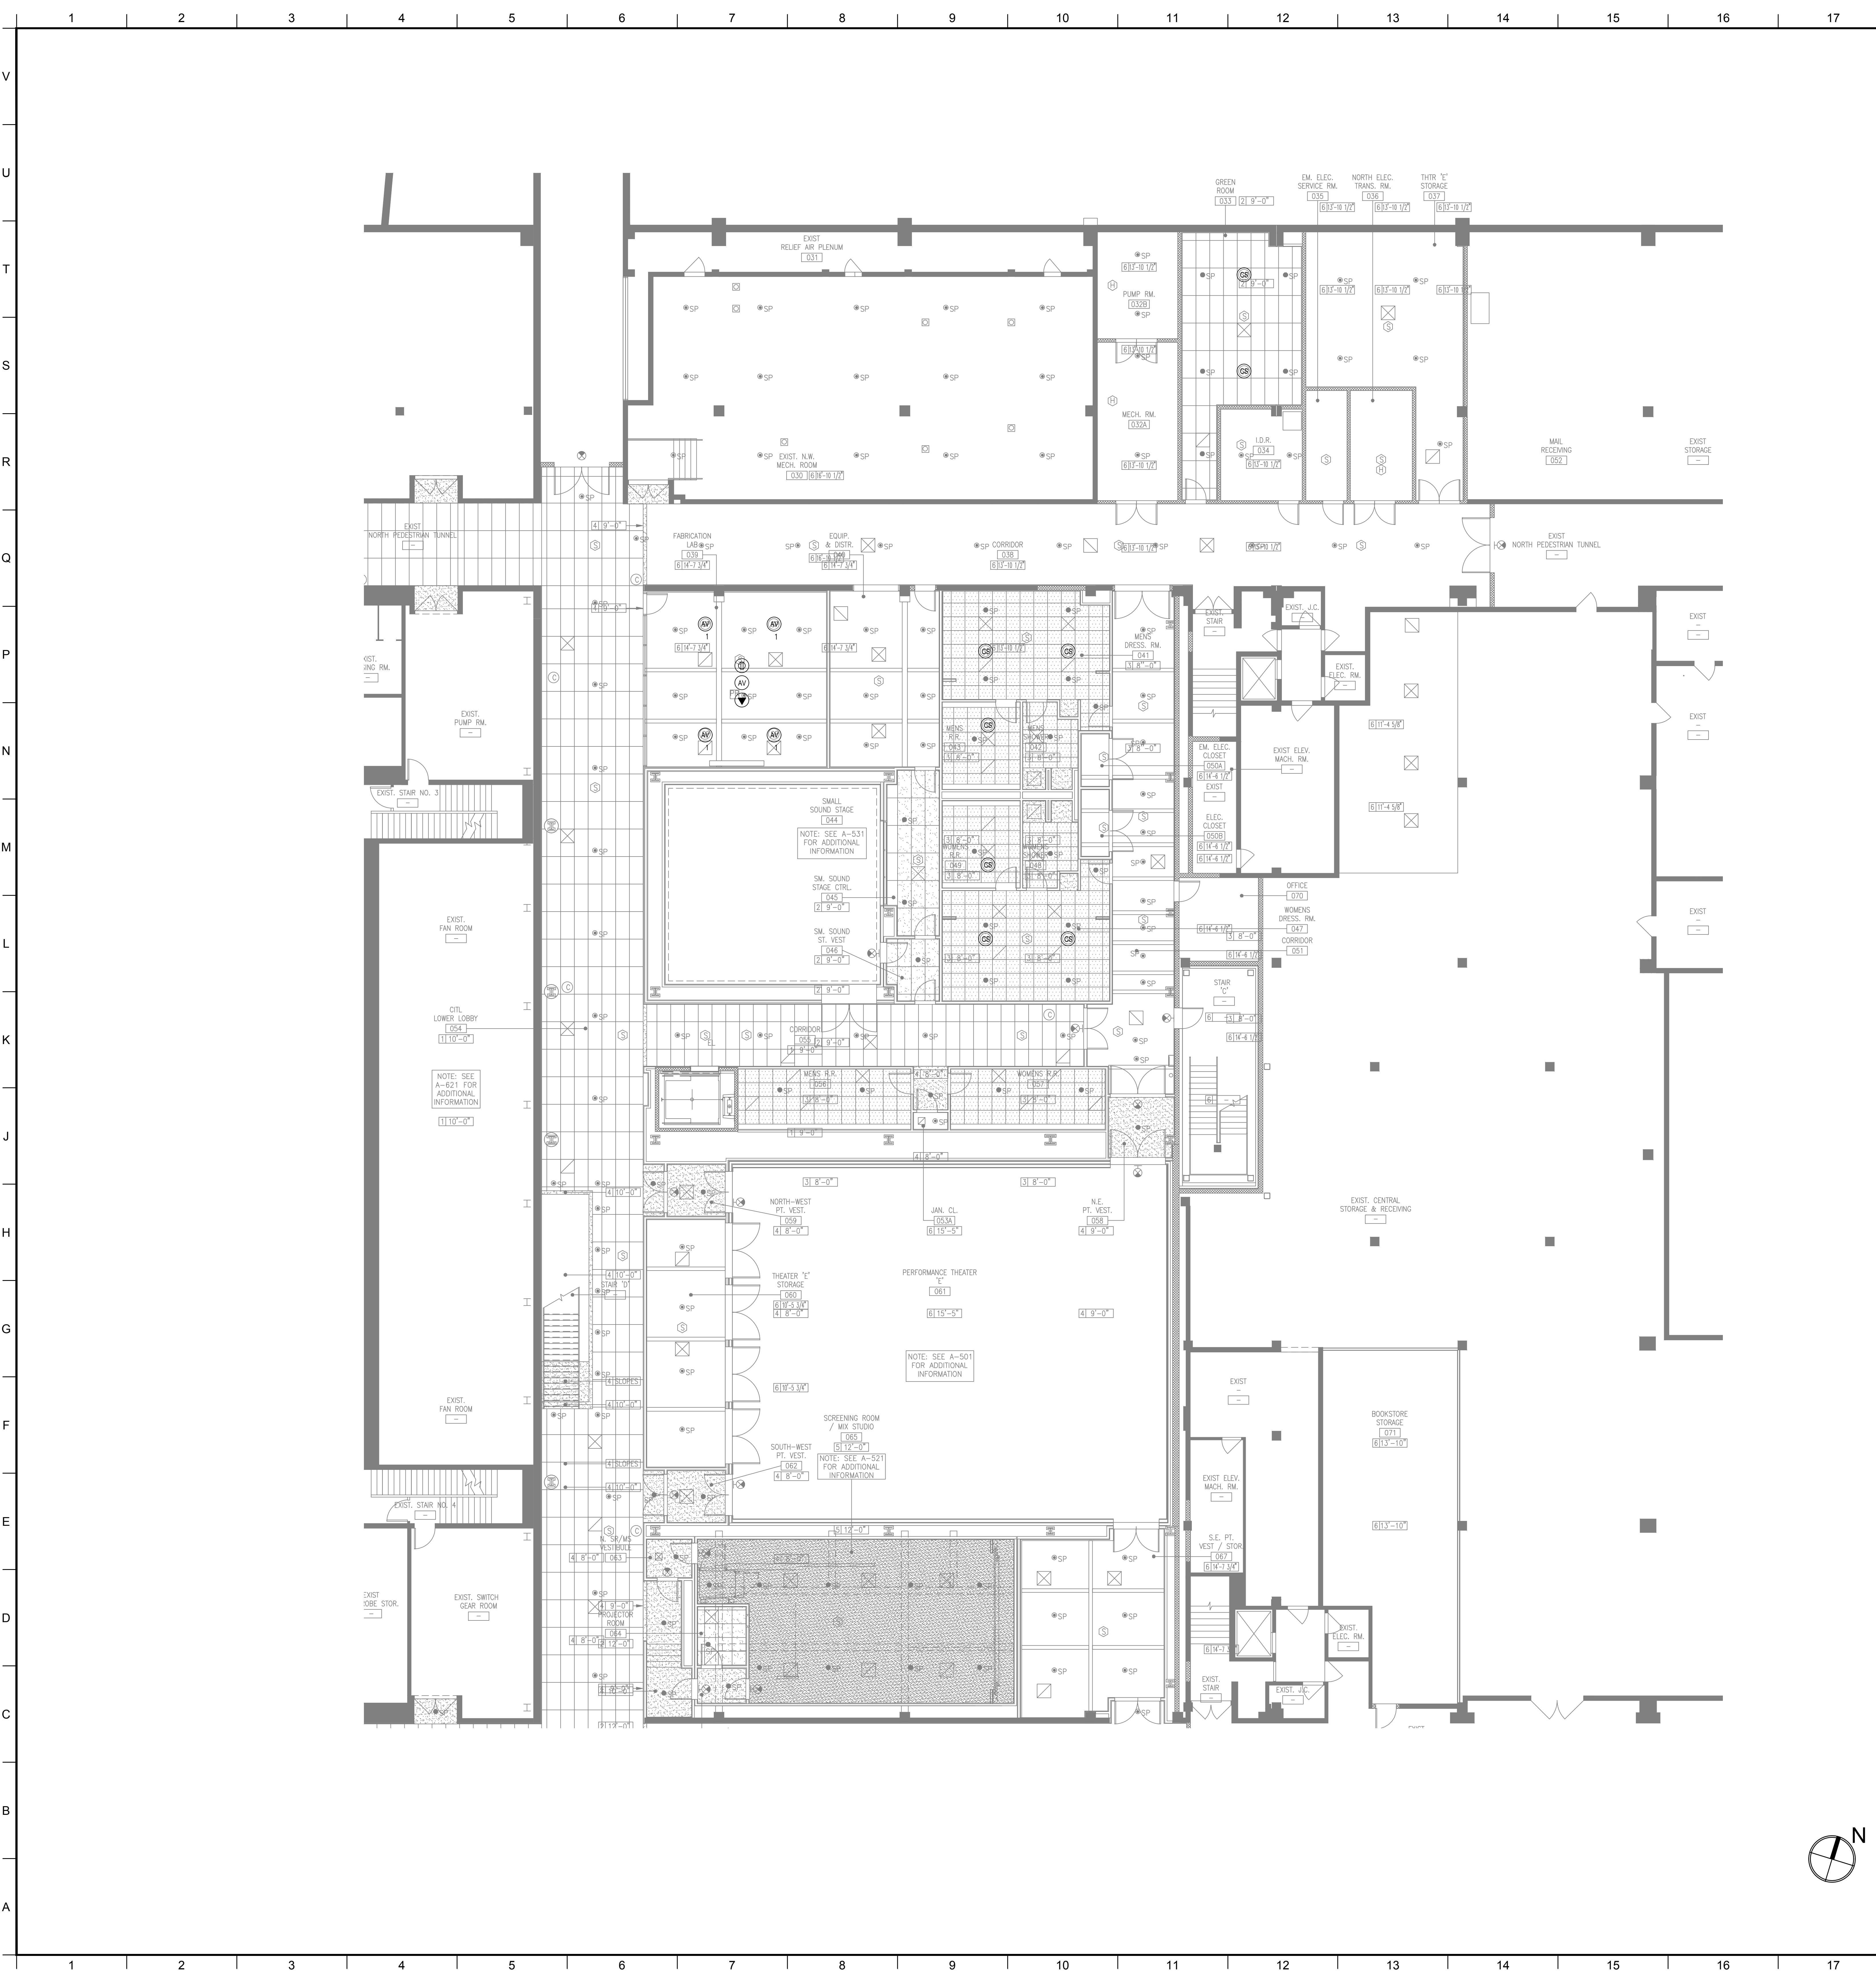


AUDIOVISUAL ELECTRICAL LEGEND

SYMBOL	DESCRIPTION
	MULTI-DISCIPLINE FLOOR BOX OR POKE-THRU, WITH HINGED COVER PLATE AND CARPET FLANGE, WITH DIVIDED COMPARTMENTS FOR SHARED ACCESS WITH VOICE, DATA AND 120VAC POWER. FLUSH MOUNT IN FLOOR UNLESS OTHERWISE INDICATED. (4\"/>
	MULTI-DISCIPLINE IN-WALL BOX, WITH DIVIDED COMPARTMENTS FOR SHARED ACCESS WITH VOICE, DATA AND 120VAC POWER. MOUNT FLUSH WITH FINISHED WALL TREATMENT, BEHIND DISPLAY, UNLESS OTHERWISE INDICATED. SEE AUDIOVISUAL DETAIL SHEETS.
	GANGABLE WALL BOX, 4-11/16\"/>
	WALL BOX, HEIGHT AND WIDTH AS SPECIFIED, FOR AUDIOVIDEO RECEPTACLES. MOUNT FLUSH WITH FINISHED WALL TREATMENT, AT BASE BUILDING ELECTRICAL SWITCH HEIGHT UNLESS OTHERWISE INDICATED.
	GANGABLE WALL BOX, 4-11/16\"/>
	GANGABLE WALL BOX, 4-11/16\"/>
	BACK BOX FOR WALL-MOUNTED AUDIOVISUAL CONTROL SYSTEM TOUCH PANEL. BACK BOX TO BE OEM BY MANUFACTURER, REFERENCED TO MODEL NUMBER. MOUNT FLUSH WITH FINISHED WALL TREATMENT; COORDINATE HEIGHT WITH ARCHITECTURAL AND ADA REQUIREMENTS.
	SINGLE-GANG WALL BOX, 4-11/16\"/>
	SINGLE-GANG WALL BOX, 4-11/16\"/>
	WALL SWITCH FOR PROJECTION SCREEN, RAISE/STOP/LOWER, SUPPLIED WITH SCREEN. MOUNT FLUSH WITH FINISHED WALL TREATMENT, AT BASE BUILDING ELECTRICAL SWITCH HEIGHT UNLESS OTHERWISE INDICATED.
	POWER RECEPTACLE, DUPLEX, 120 VAC, 20 AMP, HOSPITAL GRADE ORANGE. MOUNT AT BASE BUILDING OUTLET HEIGHT, UNLESS OTHERWISE INDICATED.
	WALL-MOUNTED TELECOM VOICE/DATA OUTLET BOX; QUANTITY AND TYPE OF CABLING AS PER PROJECT STANDARDS, UNLESS OTHERWISE NOTED. REFER TO THE ARCHITECTURAL DRAWINGS FOR DIMENSIONED LOCATION; MOUNT AT BASE BUILDING OUTLET HEIGHT, UNLESS OTHERWISE INDICATED.
	GANGABLE WALL BOX, 4-11/16\"/>
	CEILING LOUDSPEAKER BACK BOX, GRILLE AND TILE BRIDGE. MOUNT FLUSH WITH FINISHED CEILING, AS SHOWN ON THE ARCHITECTURAL CEILING PLANS, UNLESS OTHERWISE INDICATED. CONFIRM THE INTEGRITY OF THE CEILING GRID SYSTEM WITH THE STRUCTURAL ENGINEER.
	PROJECTION SCREEN, PROJECTOR LIFT OR SHADE WITH LOW-VOLTAGE INTERFACE, SUPPLIED WITH DEVICE. MOUNT ABOVE FINISHED CEILING UNLESS OTHERWISE INDICATED. MAINTENANCE ACCESS TO BOX SHALL BE PROVIDED IN NON-ACCESSIBLE CEILINGS. PROVIDE UTILITY-GRADE 120VAC UNLESS OTHERWISE INDICATED.
	POWER RECEPTACLE, DUPLEX, 120 VAC, 20 AMP, HOSPITAL GRADE ORANGE, SEPARATE CIRCUIT. MOUNT FLUSH WITH FINISHED CEILING UNLESS OTHERWISE INDICATED.
	CEILING MOUNTED TELECOM DATA OUTLET BOX; QUANTITY AND TYPE OF CABLING AS PER PROJECT STANDARDS, UNLESS OTHERWISE INDICATED. REFER TO THE ARCHITECTURAL DRAWINGS FOR DIMENSIONED LOCATION.

AUDIOVISUAL ELECTRICAL NOTES

- POWER AND DATA ON THE AV DRAWINGS ARE "FOR REFERENCE ONLY". PLEASE REFER TO ELECTRICAL AND LOW VOLTAGE DRAWINGS FOR EXACT QUANTITIES AND LOCATIONS. ASSOCIATED AV CONDUIT AND BOXES ON THE AV DRAWINGS ARE FOR DESIGN AND CONSTRUCTION ISSUE.
- WHERE EXACT DIMENSIONS ARE NOT CALLED FOR, THE SCALE OF THIS DRAWING IS SUFFICIENTLY ACCURATE FOR DETERMINING ROUGH LOCATION OF EQUIPMENT, JUNCTION BOXES, OUTLET BOXES, WIREWAYS, PANELS, ETC. WHERE EXACT DIMENSIONS ARE CALLED FOR, THE REFERENCE SURFACE SHALL BE THE FINAL FINISHED SURFACE INCLUDING ANY ACOUSTICAL TREATMENT. ROOM DIMENSIONS ON THIS DRAWING HAVE BEEN TAKEN FROM PRELIMINARY ARCHITECTURAL DRAWINGS.
- POWER CONDUIT, POWER WIREWAYS AND POWER JUNCTION BOXES ARE TO BE REVIEWED BY THE ELECTRICAL ENGINEER FOR CODE COMPLIANCE.
- EMPTY CONDUITS RUNS ON THIS DRAWING SHOW ONLY INTERCONNECTION BETWEEN THE TERMINATION POINTS. THE EXACT PATH OF CONDUIT ARE TO BE DETERMINED BY FIELD CONDITIONS.
- ALL EMPTY CONDUIT ON THIS DRAWING TO BE 1" UNLESS OTHERWISE NOTED. ALL EMPTY CONDUIT SHALL BE DEBURRED, CLEANED, CAPPED, TAGGED AND FURNISHED WITH PULL WIRES.
- THERE SHALL BE A MINIMUM OF ONE PULL BOX FOR EVERY 100 FEET OF STRAIGHT EMPTY CONDUIT AND A PULL BOX FOR MORE THAN TWO 90° BENDS IN A CONDUIT RUN.
- POWER RECEPTACLES SHOWN ON THIS DRAWING ARE DEDICATED TO SPECIFIC AUDIOVISUAL AND TELEVISION EQUIPMENT. REFER TO ELECTRICAL DRAWINGS FOR ADDITIONAL UTILITY POWER RECEPTACLES.
- POWER BREAKER PANELS ARE SIZED AND SPECIFIED BY THE ELECTRICAL ENGINEER. REFER TO ELECTRICAL DRAWINGS. ALL CIRCUITS SHALL BE PROTECTED BY 120VAC, 20 AMP BREAKERS UNLESS OTHERWISE DETAILED.
- WHERE POWER CIRCUITS ARE SHOWN TERMINATING IN JUNCTION BOXES WITHOUT RECEPTACLES, THE WIRES SHALL BE TAPED AND THE BOXES COVERED. THESE CIRCUITS WILL BE CONNECTED BY OTHERS DURING INSTALLATION OF THE AUDIOVISUAL SYSTEMS EQUIPMENT.
- THE METHOD OF INSTALLATION OF BOXES IN WALLS, AND THE METHOD OF PASSAGE OF CONDUITS AND WIREWAYS THROUGH ACOUSTICALLY SENSITIVE WALLS SHALL BE COORDINATED WITH THE ACOUSTICAL CONSULTANT.

MATERIAL KEYING LEGEND:

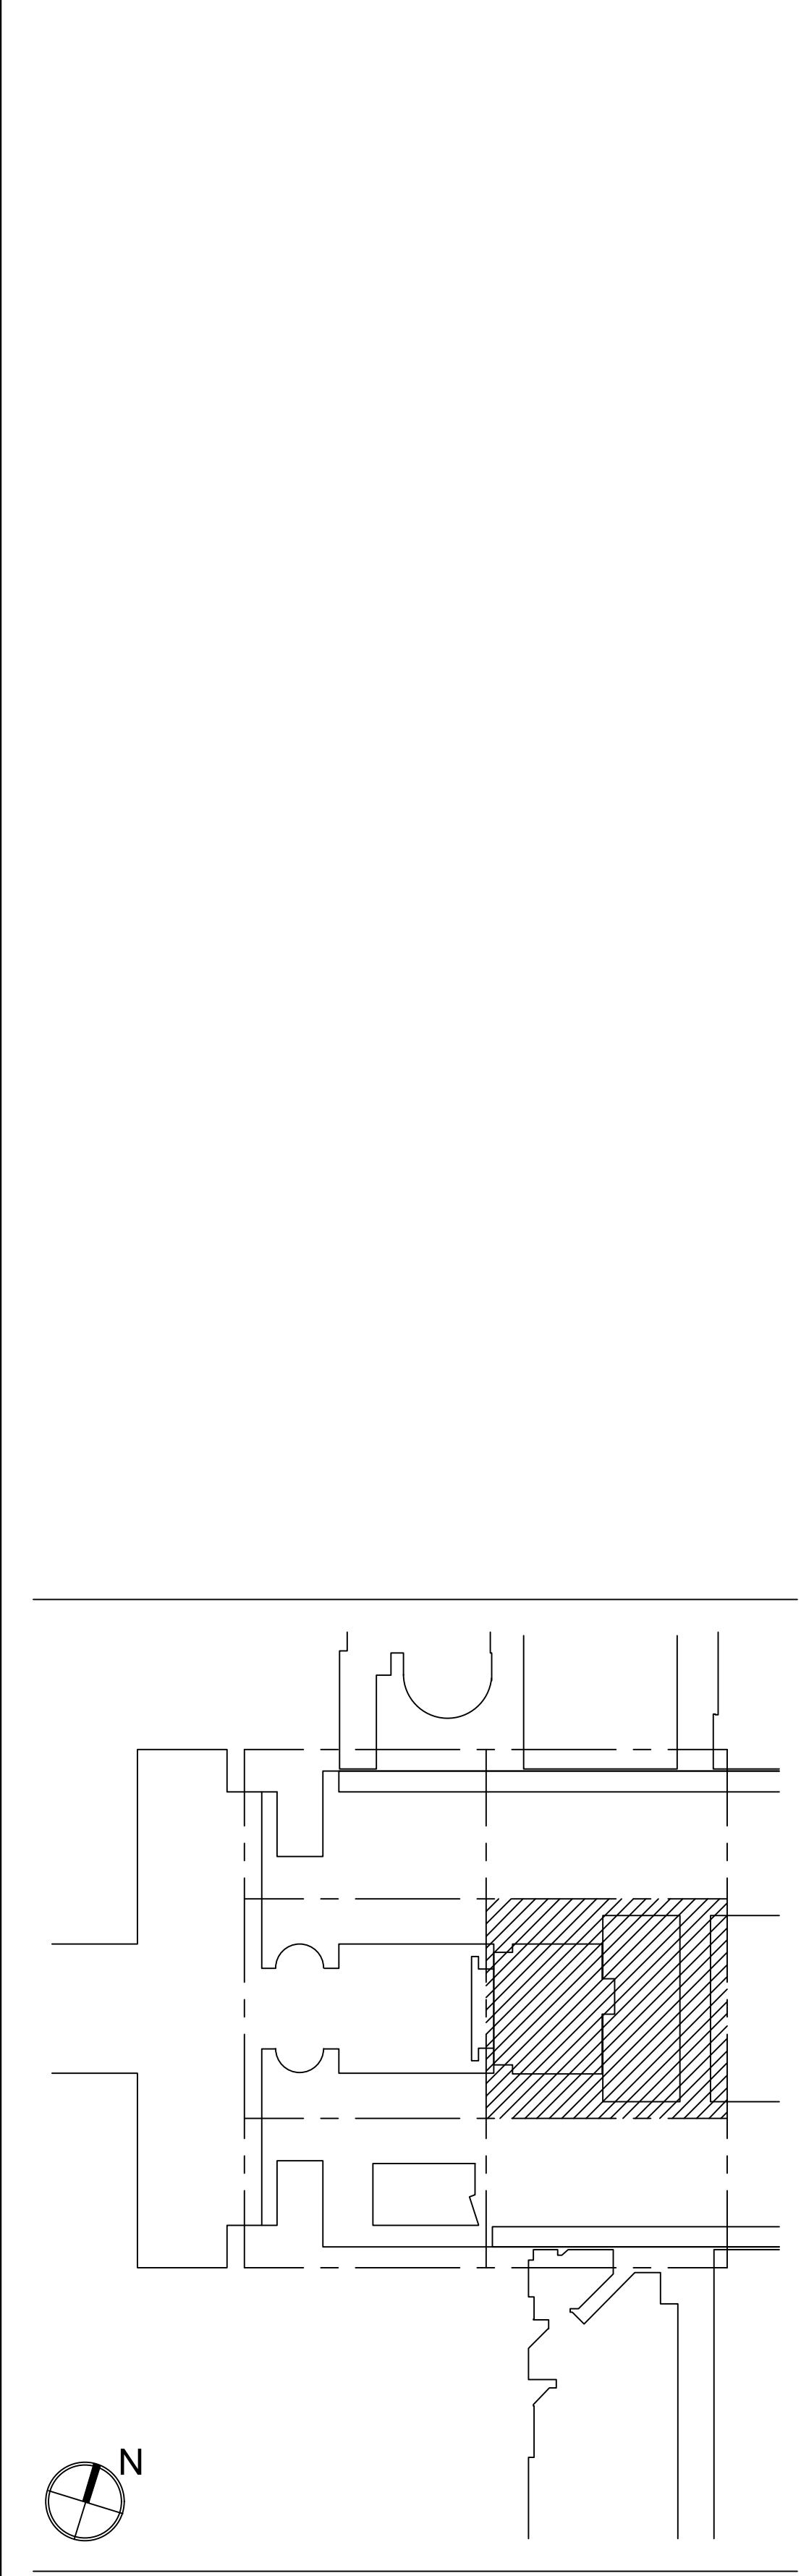

KEY PLAN

NO.	REVISIONS / SUBMISSIONS	DATE
5	GROUP III AV BID DOCUMENTS	08.06.2017
2	BID DOCUMENTS	05.28.2014
1	DESIGN MANUAL PHASE SUBMISSION	04.01.2013


FX FOWLE

FX FOWLE ARCHITECTS, LLP | 22 WEST 10TH STREET | NEW YORK, NY 10011 | T 212.427.1700 | F 212.443.8116 | WWW.FX FOWLE.COM
STRUCTURAL ENGINEERS:
DESIMONE CONSULTING ENGINEERS
18 West 18th Street, 10th Floor, New York, New York 10011 | 212-532-2211
MECHANICAL, ELECTRICAL, PLUMBING, FIRE PROTECTION ENGINEER:
COLLADO ENGINEERING
2 Holmdel Avenue, White Plains, NY 10603 | 914-332-7656
THEATER PLANNING CONSULTANT:
FISHER DACHS ASSOCIATES
22 West 10th Street, 8th Floor, New York, NY 10011 | 212-691-3020
ACoustics & AUDIO VISUAL CONSULTANT:
CERAMI & ASSOCIATES
404 Fifth Avenue, New York, NY 10018 | 212-370-1776
LIGHTING CONSULTANT:
ILLUMINATION ARTS
605 Broadway Avenue, Suite 101, Bloomfield NJ 07003 | 973-771-1556
LANDSCAPE CONSULTANT:
W ARCHITECTURE & LANDSCAPE ARCHITECTURE, LLC
105 10th Avenue Third Floor New York, NY 10010 P 212-961-3533 F 212-620-0258
CIVIL ENGINEER & LANDMART:
LANGAN
21 Penn Plaza 360 West 31st Street 8th Floor New York, NY 10001 212-476-5400 212-476-6444 (fax)
ELEVATOR CONSULTANT:
VDA (VAN DEUSEN & ASSOCIATES)
Seven Penn Plaza, Suite 404 New York, NY 10001 Phone: 212-868-9090 Fax: 212-868-9099
IT CONSULTANT:
GRID ASSOCIATES, LLC
P.O. Box 1705 Hoboken, NJ 07030 T 946-722-0600 / F 946-722-0625
SUSTAINABILITY LEADER:
YR&G
161 Bowery - 4th Floor, New York, NY 10002 T 917-677-8023 / F 917-677-8023
GUEST ESTIMATING CONSULTANT:
TOSCANO CLEMENTS TAYLOR, LLC
16 Oakwood Road Huntington, NY 11743 T 631-392-1400 / F 631-392-1399

C.I.T.L. PROJ. # 29402
SUNY PURCHASE COLLEGE
735 ANDERSON HILL ROAD | PURCHASE, NY 10577

AUDIOVISUAL-ELECTRICAL - CITL BUILDING CONCOURSE (BASEMENT LEVEL) PLAN

Seat:	Drawn: AJC	Project No.: 29402 (SUCC) / 05018.L00 (FXP)
	Checked: BJM	Coord File:
	Reviewed: BJM	Drawing No.:
	Date:	
	Scale: 1/8" = 1'-0"	

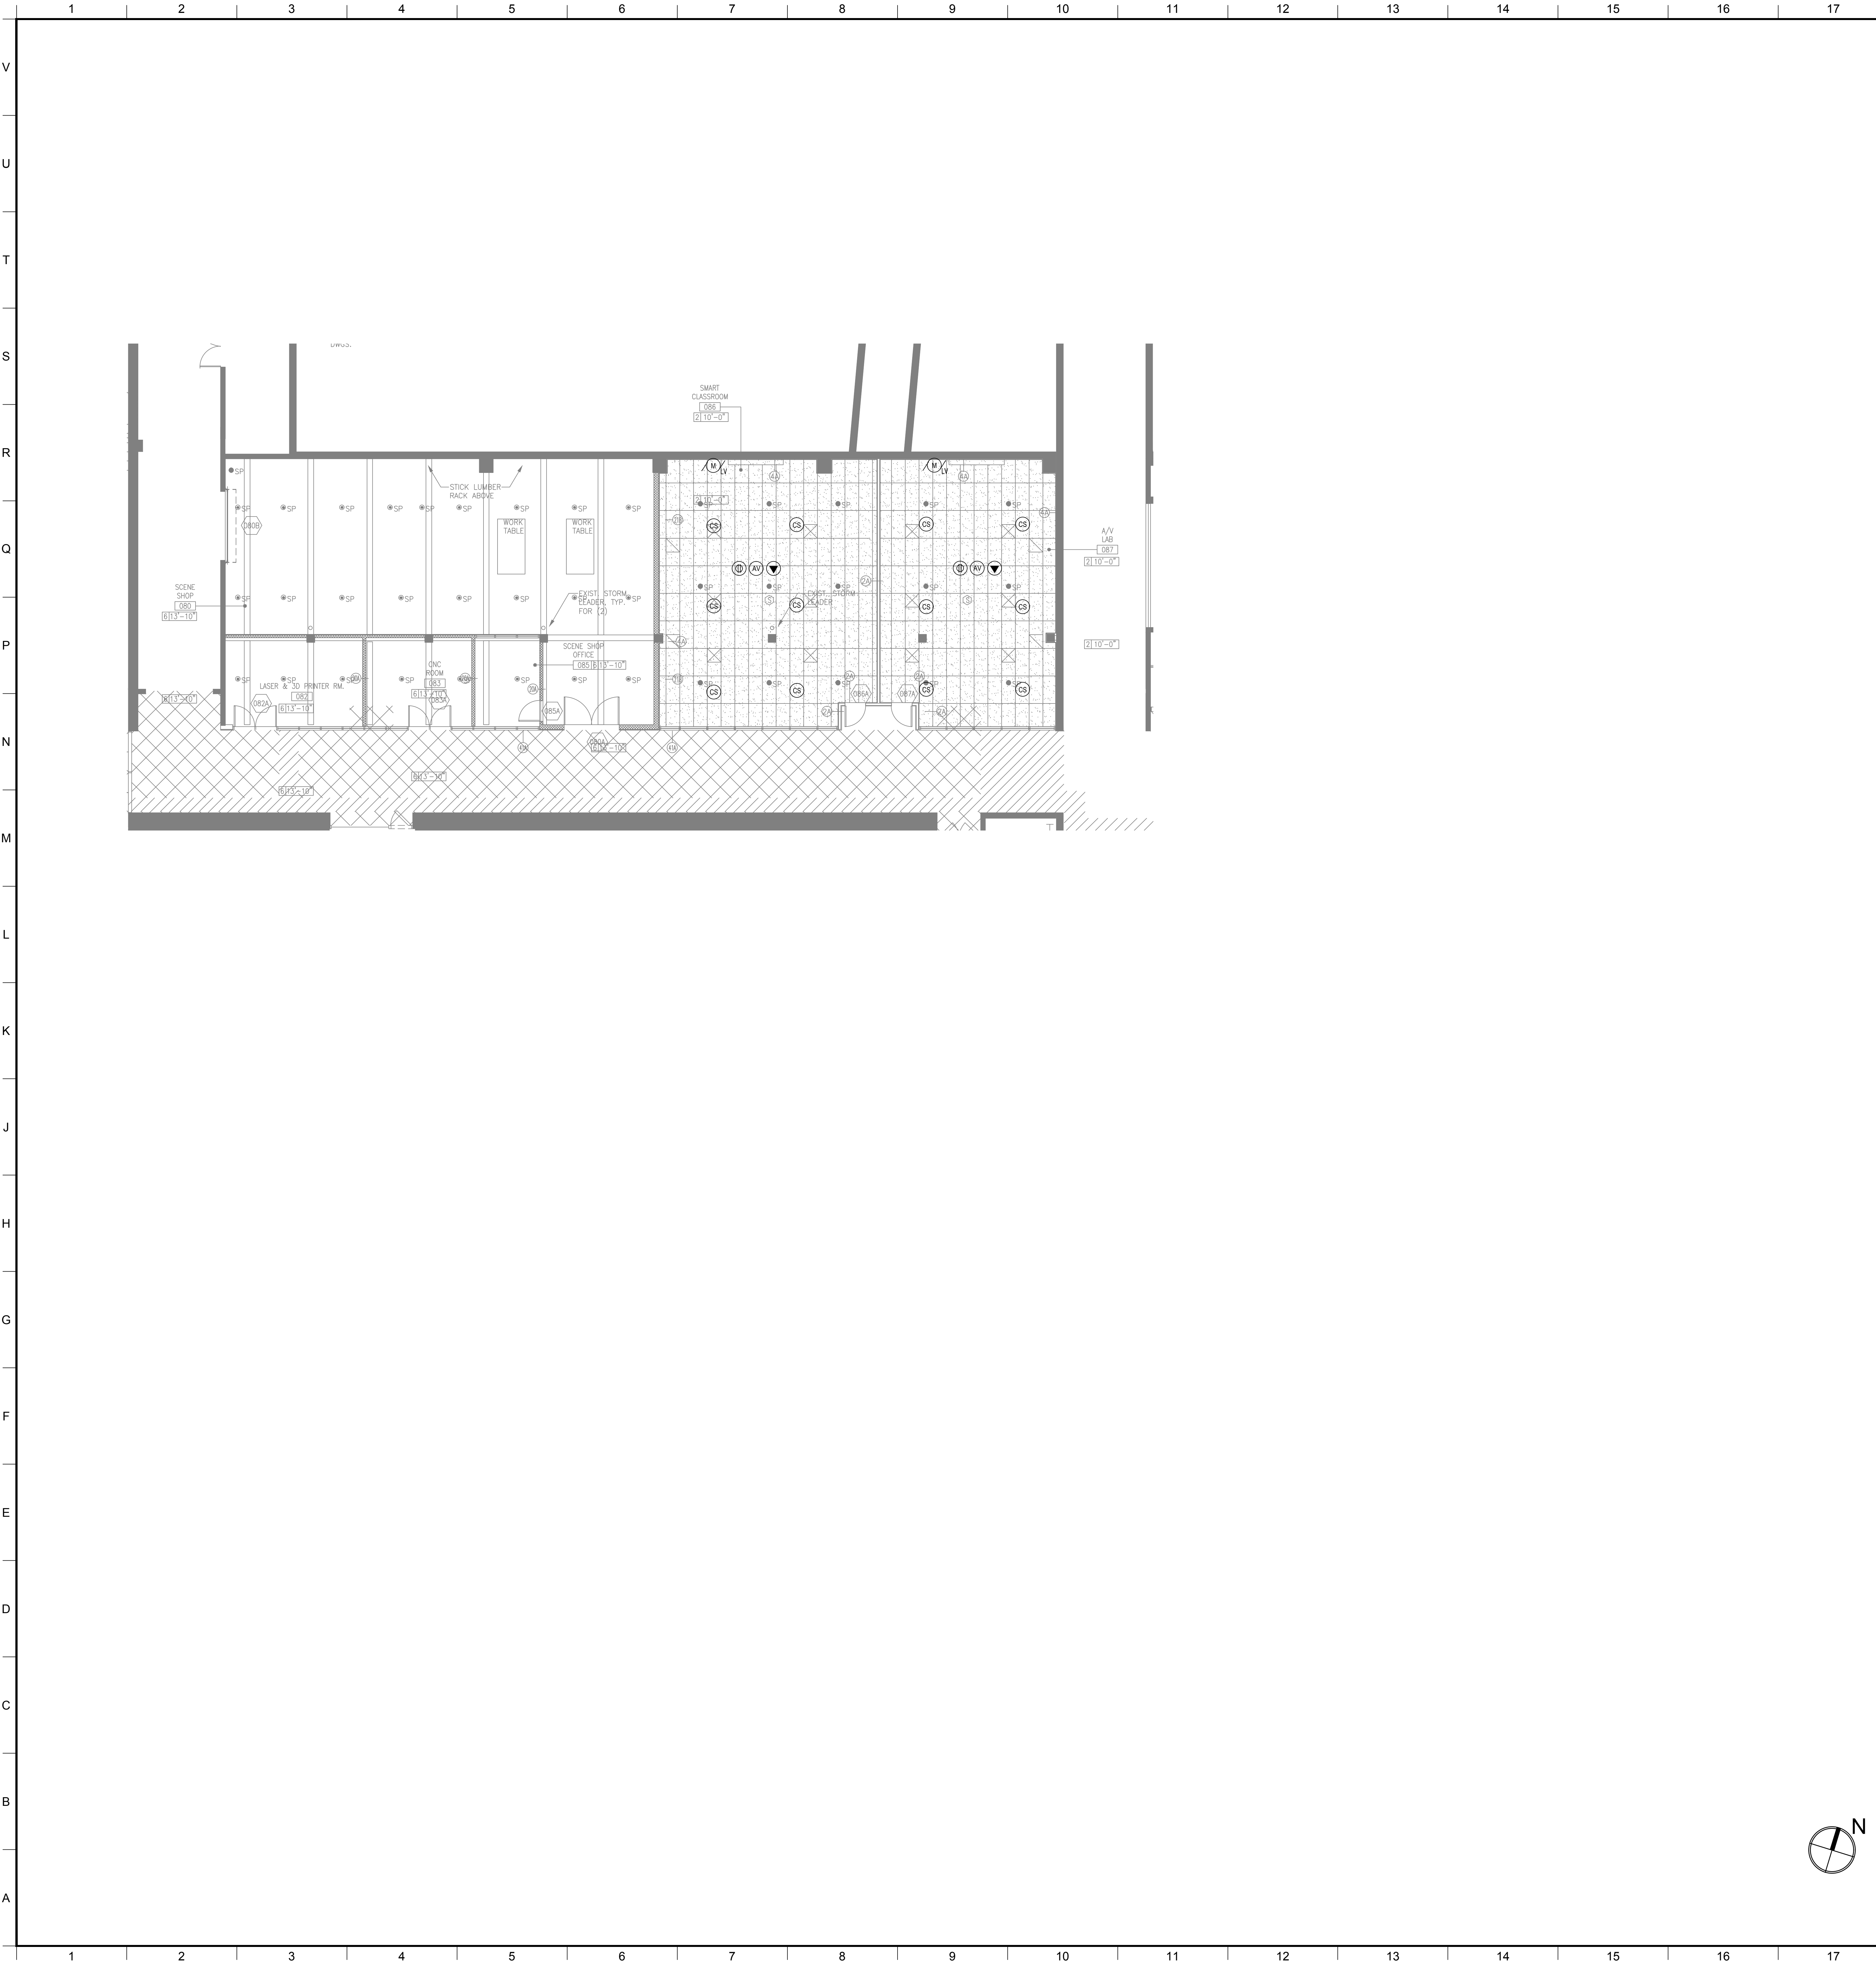

AUDIOVISUAL ELECTRICAL LEGEND


SYMBOL	DESCRIPTION
	MULTI-DISCIPLINE FLOOR BOX OR POKE-THRU, WITH HINGED COVER PLATE AND CARPET FLANGE, WITH DIVIDED COMPARTMENTS FOR SHARED ACCESS WITH VOICE, DATA AND 120VAC POWER. FLUSH MOUNT IN FLOOR UNLESS OTHERWISE INDICATED. (4" DEEP MINIMUM) UNLESS OTHERWISE INDICATED. SEE AUDIOVISUAL DETAIL SHEETS.
	SCREW COVER JUNCTION BOX FOR AUDIOVISUAL CONDUIT TERMINATION, SIZED ACCORDINGLY. ALL CONDUITS TERMINATE AT THIS BOX UNLESS OTHERWISE INDICATED.
	MULTI-DISCIPLINE IN-WALL BOX, WITH DIVIDED COMPARTMENTS FOR SHARED ACCESS WITH VOICE, DATA AND 120VAC POWER. MOUNT FLUSH WITH FINISHED WALL TREATMENT, BEHIND DISPLAY. UNLESS OTHERWISE INDICATED. SEE AUDIOVISUAL DETAIL SHEETS.
	GANGABLE WALL BOX, 4-11/16" HIGH X 2-1/2" DEEP, FOR AUDIOVIDEO RECEPTACLES. MOUNT FLUSH WITH FINISHED WALL TREATMENT. AT BASE BUILDING ELECTRICAL SWITCH HEIGHT UNLESS OTHERWISE INDICATED. SUBNUMBER INDICATE GANG #
	WALL BOX, HEIGHT AND WIDTH AS SPECIFIED, FOR AUDIOVIDEO RECEPTACLES. MOUNT FLUSH WITH FINISHED WALL TREATMENT. AT BASE BUILDING ELECTRICAL SWITCH HEIGHT UNLESS OTHERWISE INDICATED.
	GANGABLE WALL BOX, 4-11/16" HIGH X 2-1/2" DEEP, FOR INTERCOM RECEPTACLES. MOUNT FLUSH WITH FINISHED WALL TREATMENT. AT BASE BUILDING ELECTRICAL SWITCH HEIGHT UNLESS OTHERWISE INDICATED. SUBNUMBER INDICATES GANG #
	GANGABLE WALL BOX, 4-11/16" HIGH X 2-1/2" DEEP, FOR MOUNTED VOLUME CONTROLLER. MOUNT FLUSH WITH FINISHED WALL TREATMENT. COORDINATE HEIGHT WITH ARCHITECTURAL AND ADA REQUIREMENTS. SUBNUMBER INDICATES GANG #
	BACK BOX FOR WALL-MOUNTED AUDIOVISUAL CONTROL SYSTEM TOUCH PANEL. BACK BOX TO BE OEM BY MANUFACTURER, REFERENCED TO MODEL NUMBER. MOUNT FLUSH WITH FINISHED WALL TREATMENT. COORDINATE HEIGHT WITH ARCHITECTURAL AND ADA REQUIREMENTS.
	SINGLE-GANG WALL BOX, 4-11/16" HIGH X 2-1/2" DEEP, FOR MICROPHONE ANTENNA OR ASSISTIVE LISTENING ANTENNA. MOUNT FLUSH WITH FINISHED WALL TREATMENT. AT SPECIFIED HEIGHT. SUBNUMBER INDICATES GANG #
	SINGLE-GANG WALL BOX, 4-11/16" HIGH X 2-1/2" DEEP, WITH 1-1/4" CONDUIT KNOCKOUTS AND BLANK COVER PLATE, FOR PIPE MOUNTED SPEAKER OR SUBWOOFER. MOUNT ON PIPE GRID.
	WALL SWITCH FOR PROJECTION SCREEN, RAISE/STOP/LOWER, SUPPLIED WITH SCREEN. MOUNT FLUSH WITH FINISHED WALL TREATMENT. AT BASE BUILDING ELECTRICAL SWITCH HEIGHT UNLESS OTHERWISE INDICATED.
	POWER RECEPTACLE, DUPLEX, 120 VAC, 20 AMP, HOSPITAL GRADE ORANGE. MOUNT AT BASE BUILDING OUTLET HEIGHT, UNLESS OTHERWISE INDICATED.
	WALL-MOUNTED TELECOM VOICE/DATA OUTLET BOX. QUANTITY AND TYPE OF CABLING AS PER PROJECT STANDARDS, UNLESS OTHERWISE NOTED. REFER TO THE ARCHITECTURAL DRAWINGS FOR DIMENSIONED LOCATION. MOUNT AT BASE BUILDING OUTLET HEIGHT, UNLESS OTHERWISE INDICATED.

	GANGABLE WALL BOX, 4-11/16" HIGH X 2-1/2" DEEP, WITH 1-1/4" CONDUIT KNOCKOUTS AND BLANK COVER PLATE, FOR AUDIOVISUAL CONNECTIVITY. MOUNT FLUSH WITH FINISHED CEILING TREATMENT. SUBNUMBER INDICATES NUMBER OF GANG.
	CEILING LOUDSPEAKER BACK BOX, GRILLE AND TILE BRIDGE. MOUNT FLUSH WITH FINISHED CEILING, AS SHOWN ON THE ARCHITECTURAL CEILING PLANS, UNLESS OTHERWISE INDICATED. CONFIRM THE INTEGRITY OF THE CEILING GRID SYSTEM WITH THE STRUCTURAL ENGINEER.
	PROJECTION SCREEN, PROJECTOR LIFT OR SHADE WITH LOW-VOLTAGE INTERFACE, SUPPLIED WITH DEVICE. MOUNT ABOVE FINISHED CEILING UNLESS OTHERWISE INDICATED. MAINTENANCE ACCESS TO BOX SHALL BE PROVIDED IN NON-ACCESSIBLE CEILINGS. PROVIDE UTILITY-GRADE 120VAC UNLESS OTHERWISE INDICATED.
	POWER RECEPTACLE, DUPLEX, 120 VAC, 20 AMP, HOSPITAL GRADE ORANGE, SEPARATE CIRCUIT. MOUNT FLUSH WITH FINISHED CEILING UNLESS OTHERWISE INDICATED.
	CEILING MOUNTED TELECOM DATA OUTLET BOX. QUANTITY AND TYPE OF CABLING AS PER PROJECT STANDARDS, UNLESS OTHERWISE INDICATED. REFER TO THE ARCHITECTURAL DRAWINGS FOR DIMENSIONED LOCATION.

AUDIOVISUAL ELECTRICAL NOTES

- POWER AND DATA ON THE AV DRAWINGS ARE "FOR REFERENCE ONLY". PLEASE REFER TO ELECTRICAL AND LOW VOLTAGE DRAWINGS FOR EXACT QUANTITIES AND LOCATIONS. ASSOCIATED AV CONDUIT AND BOXES ON THE AV DRAWINGS ARE FOR DESIGN AND CONSTRUCTION ISSUE.
- WHERE EXACT DIMENSIONS ARE NOT CALLED FOR, THE SCALE OF THIS DRAWING IS SUFFICIENTLY ACCURATE FOR DETERMINING ROUGH LOCATION OF EQUIPMENT, JUNCTION BOXES, OUTLET BOXES, WIREWAYS, PANELS, ETC. WHERE EXACT DIMENSIONS ARE CALLED FOR, THE REFERENCE SURFACE SHALL BE THE FINAL FINISHED SURFACE INCLUDING ANY ACOUSTICAL TREATMENT. ROOM DIMENSIONS ON THIS DRAWING HAVE BEEN TAKEN FROM PRELIMINARY ARCHITECTURAL DRAWINGS.
- POWER CONDUIT, POWER WIREWAYS AND POWER JUNCTION BOXES ARE TO BE REVIEWED BY THE ELECTRICAL ENGINEER FOR CODE COMPLIANCE.
- EMPTY CONDUITS RUNS ON THIS DRAWING SHOW ONLY INTERCONNECTION BETWEEN THE TERMINATION POINTS. THE EXACT PATH OF CONDUIT ARE TO BE DETERMINED BY FIELD CONDITIONS.
- ALL EMPTY CONDUIT ON THIS DRAWING TO BE 1" UNLESS OTHERWISE NOTED. ALL EMPTY CONDUIT SHALL BE DEBURRED, CLEANED, CAPPED, TAGGED AND FURNISHED WITH PULL WIRES.
- THERE SHALL BE A MINIMUM OF ONE PULL BOX FOR EVERY 100 FEET OF STRAIGHT EMPTY CONDUIT AND A PULL BOX FOR MORE THAN TWO 90° BENDS IN A CONDUIT RUN.
- POWER RECEPTACLES SHOWN ON THIS DRAWING ARE DEDICATED TO SPECIFIC AUDIOVISUAL AND TELEVISION EQUIPMENT. REFER TO ELECTRICAL DRAWINGS FOR ADDITIONAL UTILITY POWER RECEPTACLES.
- POWER BREAKER PANELS ARE SIZED AND SPECIFIED BY THE ELECTRICAL ENGINEER. REFER TO ELECTRICAL DRAWINGS. ALL CIRCUITS SHALL BE PROTECTED BY 120VAC, 20 AMP BREAKERS UNLESS OTHERWISE DETAILED.
- WHERE POWER CIRCUITS ARE SHOWN TERMINATING IN JUNCTION BOXES WITHOUT RECEPTACLES, THE WIRES SHALL BE TAPED AND THE BOXES COVERED. THESE CIRCUITS WILL BE CONNECTED BY OTHERS DURING INSTALLATION OF THE AUDIOVISUAL SYSTEMS EQUIPMENT.
- THE METHOD OF INSTALLATION OF BOXES IN WALLS, AND THE METHOD OF PASSAGE OF CONDUITS AND WIREWAYS THROUGH ACOUSTICALLY SENSITIVE WALLS SHALL BE COORDINATED WITH THE ACOUSTICAL CONSULTANT.

MATERIAL KEYING LEGEND:

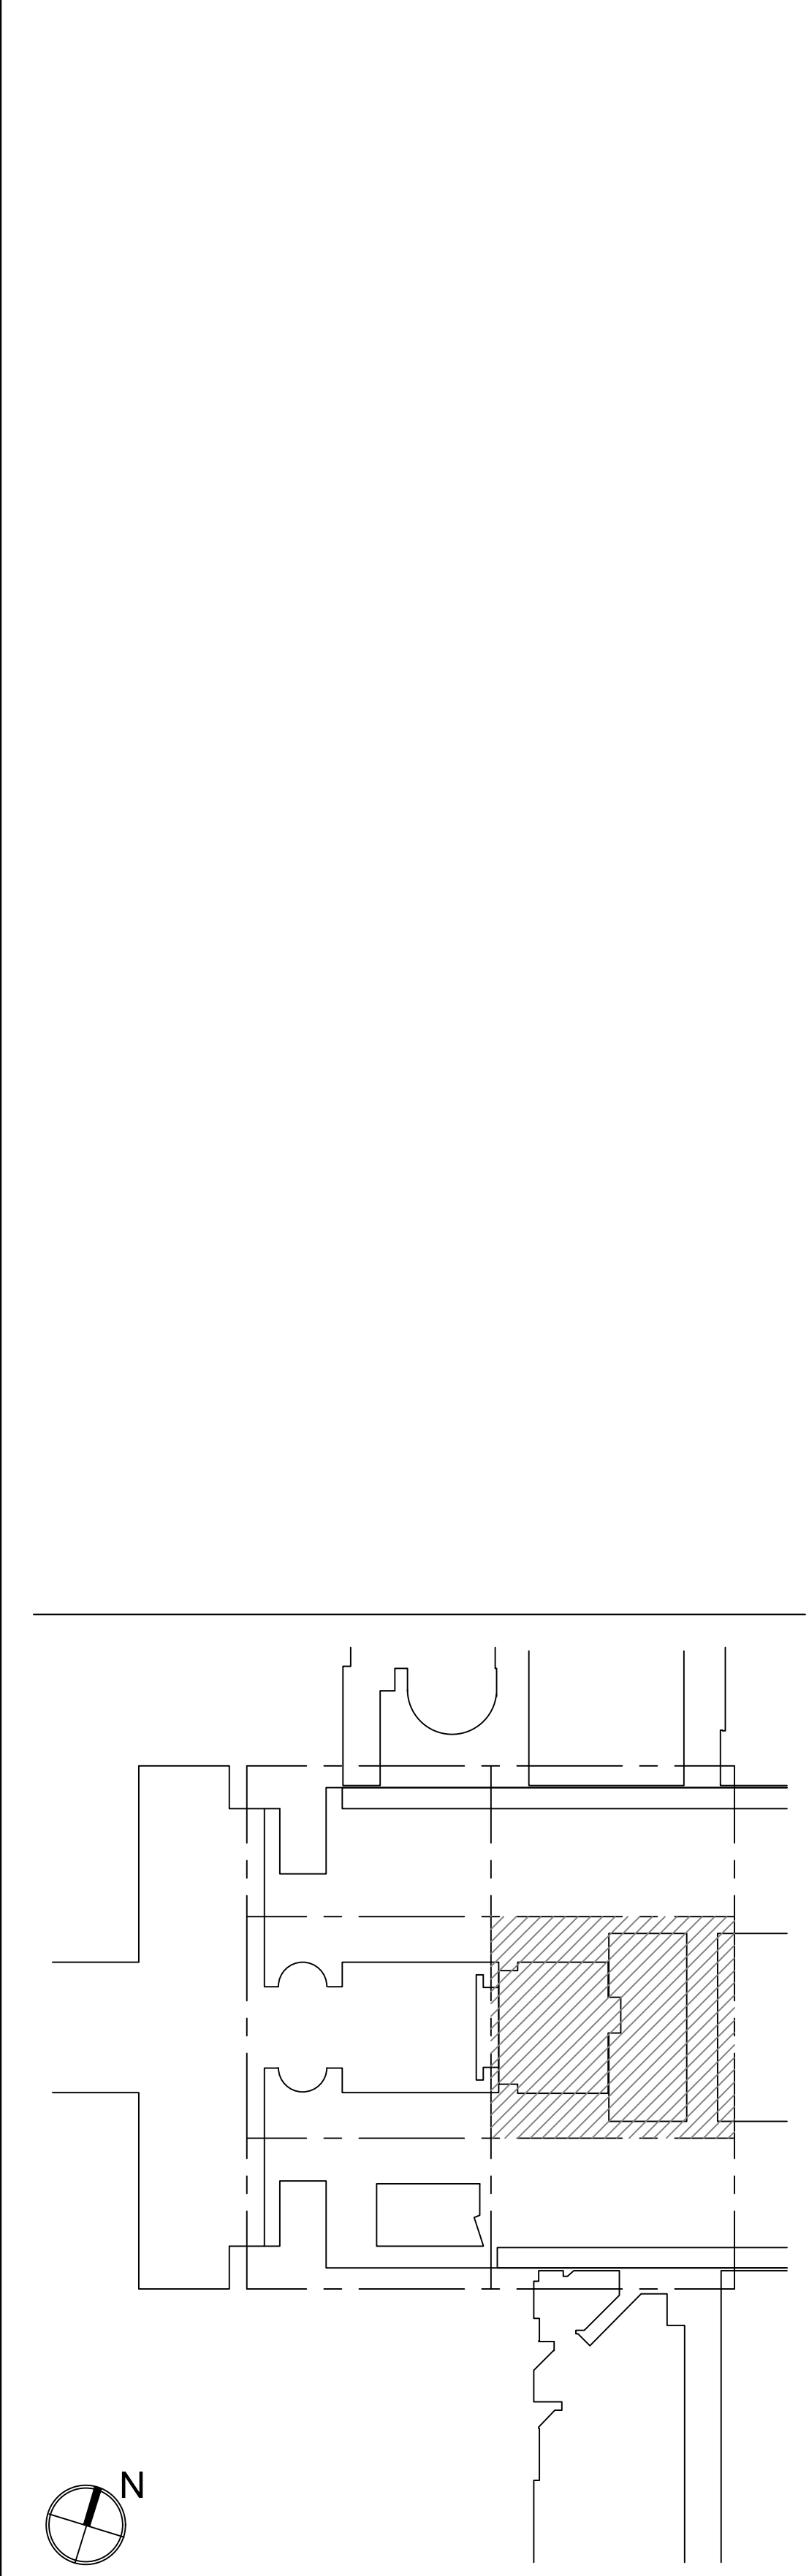

KEY PLAN

5	GROUP III AV BID DOCUMENTS	09.06.2017
2	BID DOCUMENTS	05.28.2014
1	DESIGN MANUAL PHASE SUBMISSION	04.01.2013

NO.	REVISIONS / SUBMISSIONS	DATE
-----	-------------------------	------

FX FOWLE
FX FOWLE ARCHITECTS, LLP | 22 WEST 10TH STREET | NEW YORK, NY 10011 | T 212.627.1700 | F 212.453.8716 | WWW.FX FOWLE.COM
STRUCTURAL ENGINEER:
DESIMONE CONSULTING ENGINEERS
18 West 18th Street, 10th Floor, New York, New York 10011 | 212-532-2211
MECHANICAL, ELECTRICAL, PLUMBING, FIRE PROTECTION ENGINEER:
COLLADO ENGINEERING
2 Holmden Avenue, White Plains, NY 10603 | 914-332-7656
THEATER PLANNING CONSULTANT:
FISHER DACHS ASSOCIATES
22 West 10th Street, 8th Floor, New York, NY 10011 | 212-691-3020
ACOUSTICS & AUDIO VISUAL CONSULTANT:
CERAMI & ASSOCIATES
404 Fifth Avenue, New York, NY 10018 | 212-370-1776
LIGHTING CONSULTANT:
ILLUMINATION ARTS
650 Bloomfield Avenue, Suite 101, Bloomfield NJ 07003 | 973-771-1556
LANDSCAPE CONSULTANT:
W ARCHITECTURE & LANDSCAPE ARCHITECTURE, LLC
105 Fifth Avenue Third Floor New York, NY 10010 P 212-961-3533 F 212-620-0756
DESIGN ENGINEER & LANDSCAPE ARCHITECT:
LANGAN
21 Penn Plaza 360 West 31st Street 8th Floor New York, NY 10001 212-479-5400 212-479-5444 (fax)
ELEVATOR CONSULTANT:
VDA (VAN DEUSEN & ASSOCIATES)
Seven Penn Plaza, Suite 404 New York, NY 10001 Phone: 212-808-9090 Fax: 212-808-9099
IT CONSULTANT:
GRID ASSOCIATES, LLC
P.O. Box 1703 Hoboken, NJ 07030 T 946.722.0600 / F 946.722.0625
SUSTAINABILITY LEADER:
YR&G
161 Bowery - 4th Floor, New York, NY 10002 T 917.677.8023 / F 917.677.8023
GUEST ESTIMATING CONSULTANT:
TOSCANO CLEMENTS TAYLOR, LLC
16 Oakwood Road Huntington, NY 11743 T 631.392.1400 / F 631.392.1399


C.I.T.L. PROJ. # 29402
SUNY PURCHASE COLLEGE
735 ANDERSON HILL ROAD | PURCHASE, NY 10577

DRAWING TITLE:
AUDIOVISUAL-ADD ALTERNATE ELECTRICAL CONCURSE (BASEMENT LEVEL) RCP

Seat:	Drawn: AJC	Project No.: 29402 (SUFC) / 09018.L00 (FXP)
	Checked: BJM	Calc File:
	Reviewed: BJM	Drawing No.:
	Date:	

Scale:
1/8" = 1'-0"

TA412.0_AA

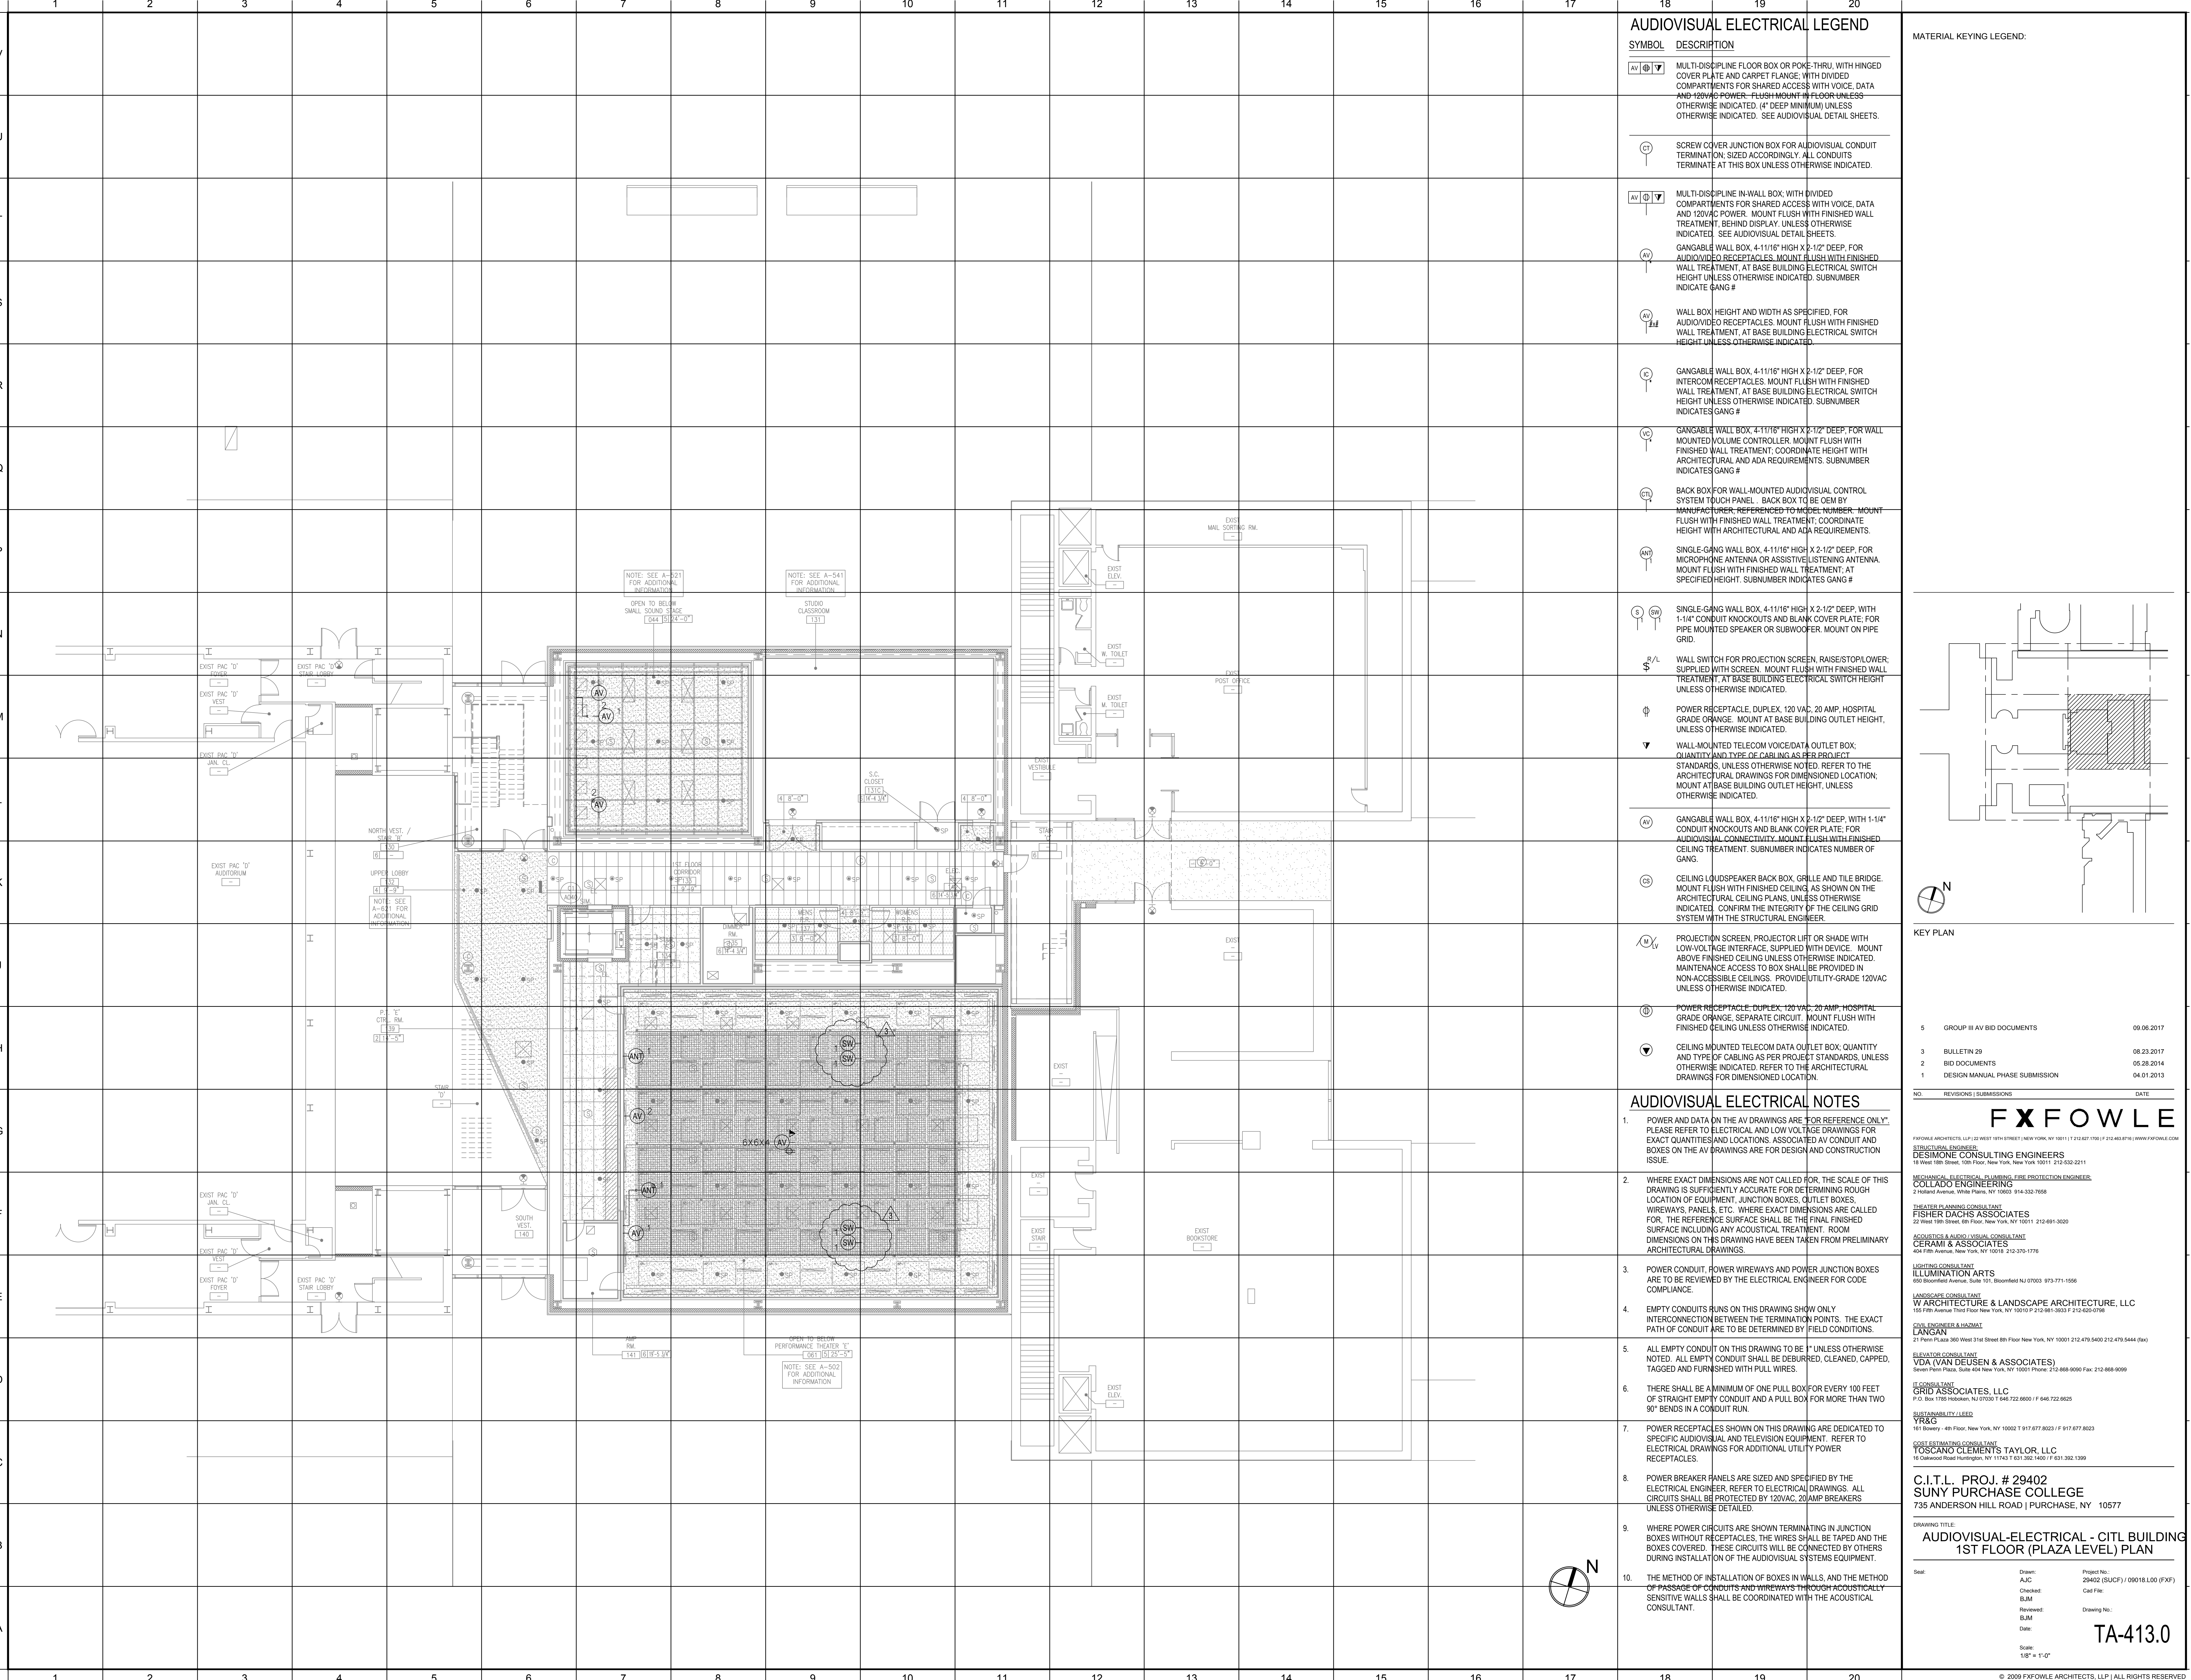

AUDIOVISUAL ELECTRICAL LEGEND

SYMBOL DESCRIPTION

- AV [Symbol] MULTI-DISCIPLINE FLOOR BOX OR POKE-THRU, WITH HINGED COVER PLATE AND CARPET FLANGE, WITH DIVIDED COMPARTMENTS FOR SHARED ACCESS WITH VOICE, DATA AND 120VAC POWER. FLUSH MOUNT IN FLOOR UNLESS OTHERWISE INDICATED. (4" DEEP MINIMUM) UNLESS OTHERWISE INDICATED. SEE AUDIOVISUAL DETAIL SHEETS.
- [Symbol] SCREW COVER JUNCTION BOX FOR AUDIOVISUAL CONDUIT TERMINATION, SIZED ACCORDINGLY. ALL CONDUITS TERMINATE AT THIS BOX UNLESS OTHERWISE INDICATED.
- AV [Symbol] MULTI-DISCIPLINE IN-WALL BOX, WITH DIVIDED COMPARTMENTS FOR SHARED ACCESS WITH VOICE, DATA AND 120VAC POWER. MOUNT FLUSH WITH FINISHED WALL TREATMENT, BEHIND DISPLAY, UNLESS OTHERWISE INDICATED. SEE AUDIOVISUAL DETAIL SHEETS.
- AV [Symbol] GANGABLE WALL BOX, 4-11/16" HIGH X 2-1/2" DEEP, FOR AUDIOVIDEORECEPTACLES, MOUNT FLUSH WITH FINISHED WALL TREATMENT, AT BASE BUILDING ELECTRICAL SWITCH HEIGHT UNLESS OTHERWISE INDICATED. SUBNUMBER INDICATE GANG #
- AV [Symbol] WALL BOX, HEIGHT AND WIDTH AS SPECIFIED, FOR AUDIOVIDEORECEPTACLES, MOUNT FLUSH WITH FINISHED WALL TREATMENT, AT BASE BUILDING ELECTRICAL SWITCH HEIGHT UNLESS OTHERWISE INDICATED.
- [Symbol] GANGABLE WALL BOX, 4-11/16" HIGH X 2-1/2" DEEP, FOR INTERROOM RECEPTACLES, MOUNT FLUSH WITH FINISHED WALL TREATMENT, AT BASE BUILDING ELECTRICAL SWITCH HEIGHT UNLESS OTHERWISE INDICATED. SUBNUMBER INDICATES GANG #
- [Symbol] GANGABLE WALL BOX, 4-11/16" HIGH X 2-1/2" DEEP, FOR WALL MOUNTED VOLUME CONTROLLER, MOUNT FLUSH WITH FINISHED WALL TREATMENT, COORDINATE HEIGHT WITH ARCHITECTURAL AND ADA REQUIREMENTS. SUBNUMBER INDICATES GANG #
- [Symbol] BACK BOX FOR WALL-MOUNTED AUDIOVISUAL CONTROL SYSTEM TOUCH PANEL. BACK BOX TO BE OEM BY MANUFACTURER, REFERENCED TO MODEL NUMBER. MOUNT FLUSH WITH FINISHED WALL TREATMENT, COORDINATE HEIGHT WITH ARCHITECTURAL AND ADA REQUIREMENTS.
- [Symbol] SINGLE GANG WALL BOX, 4-11/16" HIGH X 2-1/2" DEEP, FOR MICROPHONE ANTENNA OR ASSISTIVE LISTENING ANTENNA, MOUNT FLUSH WITH FINISHED WALL TREATMENT, AT SPECIFIED HEIGHT. SUBNUMBER INDICATES GANG #


- [Symbol] SINGLE GANG WALL BOX, 4-11/16" HIGH X 2-1/2" DEEP, WITH 1-1/4" CONDUIT KNOCKOUTS AND BLANK COVER PLATE, FOR PIPE MOUNTED SPEAKER OR SUBWOOFER, MOUNT ON PIPE GRID.
- [Symbol] WALL SWITCH FOR PROJECTION SCREEN, RAISE/STOP/LOWER, SUPPLIED WITH SCREEN, MOUNT FLUSH WITH FINISHED WALL TREATMENT, AT BASE BUILDING ELECTRICAL SWITCH HEIGHT UNLESS OTHERWISE INDICATED.
- [Symbol] POWER RECEPTACLE, DUPLEX, 120 VAC, 20 AMP, HOSPITAL GRADE ORANGE. MOUNT AT BASE BUILDING OUTLET HEIGHT, UNLESS OTHERWISE INDICATED.
- [Symbol] WALL-MOUNTED TELECOM VOICE/DATA OUTLET BOX, QUANTITY AND TYPE OF CABLING AS PER PROJECT STANDARDS, UNLESS OTHERWISE NOTED. REFER TO THE ARCHITECTURAL DRAWINGS FOR DIMENSIONED LOCATION, MOUNT AT BASE BUILDING OUTLET HEIGHT, UNLESS OTHERWISE INDICATED.

- AV [Symbol] GANGABLE WALL BOX, 4-11/16" HIGH X 2-1/2" DEEP, WITH 1-1/4" CONDUIT KNOCKOUTS AND BLANK COVER PLATE, FOR AUDIOVISUAL CONNECTIVITY, MOUNT FLUSH WITH FINISHED CEILING TREATMENT. SUBNUMBER INDICATES NUMBER OF GANG.
- [Symbol] CEILING LOUDSPEAKER BACK BOX, GRILLE AND TILE BRIDGE, MOUNT FLUSH WITH FINISHED CEILING, AS SHOWN ON THE ARCHITECTURAL CEILING PLANS, UNLESS OTHERWISE INDICATED. CONFIRM THE INTEGRITY OF THE CEILING GRID SYSTEM WITH THE STRUCTURAL ENGINEER.
- [Symbol] PROJECTION SCREEN, PROJECTOR LIFT OR SHADE WITH LOW-VOLTAGE INTERFACE, SUPPLIED WITH DEVICE. MOUNT ABOVE FINISHED CEILING UNLESS OTHERWISE INDICATED. MAINTENANCE ACCESS TO BOX SHALL BE PROVIDED IN NON-ACCESSIBLE CEILINGS. PROVIDE UTILITY-GRADE 120VAC UNLESS OTHERWISE INDICATED.
- [Symbol] POWER RECEPTACLE, DUPLEX, 120 VAC, 20 AMP, HOSPITAL GRADE ORANGE, SEPARATE CIRCUIT, MOUNT FLUSH WITH FINISHED CEILING UNLESS OTHERWISE INDICATED.
- [Symbol] CEILING MOUNTED TELECOM DATA OUTLET BOX, QUANTITY AND TYPE OF CABLING AS PER PROJECT STANDARDS, UNLESS OTHERWISE INDICATED. REFER TO THE ARCHITECTURAL DRAWINGS FOR DIMENSIONED LOCATION.

AUDIOVISUAL ELECTRICAL NOTES

1. POWER AND DATA ON THE AV DRAWINGS ARE "FOR REFERENCE ONLY." PLEASE REFER TO ELECTRICAL AND LOW VOLTAGE DRAWINGS FOR EXACT QUANTITIES AND LOCATIONS, ASSOCIATED AV CONDUIT AND BOXES ON THE AV DRAWINGS ARE FOR DESIGN AND CONSTRUCTION ISSUE.
2. WHERE EXACT DIMENSIONS ARE NOT CALLED FOR, THE SCALE OF THIS DRAWING IS SUFFICIENTLY ACCURATE FOR DETERMINING ROUGH LOCATION OF EQUIPMENT, JUNCTION BOXES, OUTLET BOXES, WIREWAYS, PANELS, ETC. WHERE EXACT DIMENSIONS ARE CALLED FOR, THE REFERENCE SURFACE SHALL BE THE FINAL FINISHED SURFACE INCLUDING ANY ACOUSTICAL TREATMENT. ROOM DIMENSIONS ON THIS DRAWING HAVE BEEN TAKEN FROM PRELIMINARY ARCHITECTURAL DRAWINGS.
3. POWER CONDUIT, POWER WIREWAYS AND POWER JUNCTION BOXES ARE TO BE REVIEWED BY THE ELECTRICAL ENGINEER FOR CODE COMPLIANCE.
4. EMPTY CONDUITS RUNS ON THIS DRAWING SHOW ONLY INTERCONNECTION BETWEEN THE TERMINATION POINTS. THE EXACT PATH OF CONDUIT ARE TO BE DETERMINED BY FIELD CONDITIONS.
5. ALL EMPTY CONDUIT ON THIS DRAWING TO BE 1" UNLESS OTHERWISE NOTED. ALL EMPTY CONDUIT SHALL BE DEBURRED, CLEANED, CAPPED, TAGGED AND FURNISHED WITH PULL WIRES.
6. THERE SHALL BE A MINIMUM OF ONE PULL BOX FOR EVERY 100 FEET OF STRAIGHT EMPTY CONDUIT AND A PULL BOX FOR MORE THAN TWO 90° BENDS IN A CONDUIT RUN.
7. POWER RECEPTACLES SHOWN ON THIS DRAWING ARE DEDICATED TO SPECIFIC AUDIOVISUAL AND TELEVISION EQUIPMENT. REFER TO ELECTRICAL DRAWINGS FOR ADDITIONAL UTILITY POWER RECEPTACLES.
8. POWER BREAKER PANELS ARE SIZED AND SPECIFIED BY THE ELECTRICAL ENGINEER. REFER TO ELECTRICAL DRAWINGS. ALL CIRCUITS SHALL BE PROTECTED BY 120VAC, 20 AMP BREAKERS UNLESS OTHERWISE DETAILED.
9. WHERE POWER CIRCUITS ARE SHOWN TERMINATING IN JUNCTION BOXES WITHOUT RECEPTACLES, THE WIRES SHALL BE TAPED AND THE BOXES COVERED. THESE CIRCUITS WILL BE CONNECTED BY OTHERS DURING INSTALLATION OF THE AUDIOVISUAL SYSTEMS EQUIPMENT.
10. THE METHOD OF INSTALLATION OF BOXES IN WALLS, AND THE METHOD OF PASSAGE OF CONDUITS AND WIREWAYS THROUGH ACOUSTICALLY SENSITIVE WALLS SHALL BE COORDINATED WITH THE ACOUSTICAL CONSULTANT.

MATERIAL KEYING LEGEND:

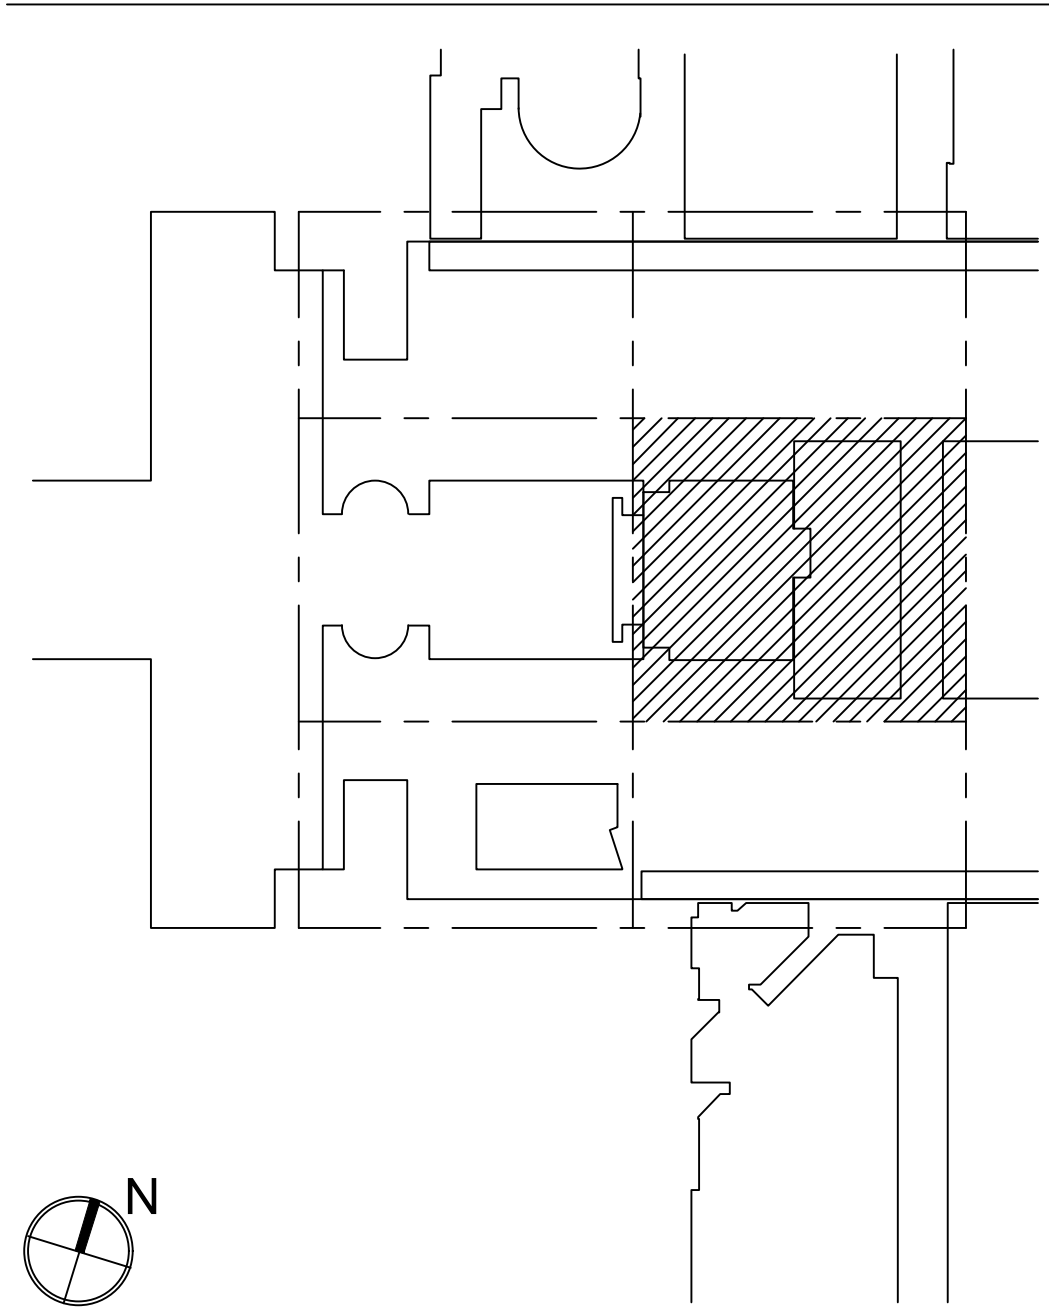

KEY PLAN

NO.	REVISIONS / SUBMISSIONS	DATE
5	GROUP III AV BID DOCUMENTS	08.06.2017
3	BULLETIN 29	08.23.2017
2	BID DOCUMENTS	05.28.2014
1	DESIGN MANUAL PHASE SUBMISSION	04.01.2013

FX FOWLE

FX FOWLE ARCHITECTS, LLP | 22 WEST 10TH STREET | NEW YORK, NY 10011 | T 212.627.1700 | F 212.463.8716 | WWW.FX FOWLE.COM

MECHANICAL, ELECTRICAL, PLUMBING, FIRE PROTECTION ENGINEER:
COLLADO ENGINEERING
2 Holmdel Avenue, White Plains, NY 10603 914-332-7656

THEATER PLANNING CONSULTANT:
FISHER DACHS ASSOCIATES
22 West 10th Street, 8th Floor, New York, NY 10011 212-691-3020

ACoustics & AUDIO VISUAL CONSULTANT:
CERAMI & ASSOCIATES
404 Fifth Avenue, New York, NY 10018 212-370-1776

LIGHTING CONSULTANT:
ILLUMINATION ARTS
605 Broadfield Avenue, Suite 101, Bloomfield NJ 07003 973-771-1556

LANDSCAPE CONSULTANT:
W ARCHITECTURE & LANDSCAPE ARCHITECTURE, LLC
105 Fifth Avenue Third Floor New York, NY 10019 P 212-961-3633 F 212-620-0258

Civil ENGINEER & LANDMANT:
LANGAN
21 Penn Plaza 360 West 31st Street 8th Floor New York, NY 10001 212-476-5400 212-476-6444 (fax)

ELEVATOR CONSULTANT:
VDA (VAN DEUSEN & ASSOCIATES)
Seven Penn Plaza, Suite 404 New York, NY 10001 Phone: 212-808-9090 Fax: 212-808-9099

IT CONSULTANT:
GRID ASSOCIATES, LLC
P.O. Box 1778 Hicksville, NY 11743 T 516-722-0600 / F 516-722-0625

SUSTAINABILITY LEADER:
YR&G
161 Bowery - 4th Floor, New York, NY 10002 T 917-677-8023 / F 917-677-8023


GUEST ESTIMATING CONSULTANT:
TOSCANO CLEMENTS TAYLOR, LLC
16 Oakwood Road Huntington, NY 11743 T 631-392-1600 / F 631-392-1399

C.I.T.L. PROJ. # 29402
SUNY PURCHASE COLLEGE
735 ANDERSON HILL ROAD | PURCHASE, NY 10577

DRAWING TITLE:
AUDIOVISUAL-ELECTRICAL - CITL BUILDING
1ST FLOOR (PLAZA LEVEL) PLAN

Seal:	Drawn: AUC	Project No.: 29402 (SUCF) / 05018.L00 (FXP)
	Checked: BJM	Card File:
	Reviewed: BJM	Drawing No.:
	Date:	
	Scale: 1/8" = 1'-0"	

TA-413.0

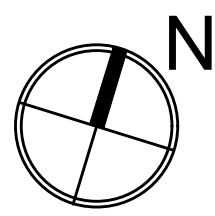

Date: TA 4140




AUDIOVISUAL ELECTRICAL LEGEND

SYMBOL	DESCRIPTION
	MULTI-DISCIPLINE FLOOR BOX OR POKE-THRU, WITH HINGED COVER PLATE AND CARPET FLANGE, WITH DIVIDED COMPARTMENTS FOR SHARED ACCESS WITH VOICE, DATA AND 120VAC POWER. FLUSH MOUNT IN FLOOR UNLESS OTHERWISE INDICATED. (4\"/>
	SCREW COVER JUNCTION BOX FOR AUDIOVISUAL CONDUIT TERMINATION. SIZED ACCORDINGLY. ALL CONDUITS TERMINATE AT THIS BOX UNLESS OTHERWISE INDICATED.
	MULTI-DISCIPLINE IN-WALL BOX, WITH DIVIDED COMPARTMENTS FOR SHARED ACCESS WITH VOICE, DATA AND 120VAC POWER. MOUNT FLUSH WITH FINISHED WALL TREATMENT, BEHIND DISPLAY. UNLESS OTHERWISE INDICATED. SEE AUDIOVISUAL DETAIL SHEETS.
	GANGABLE WALL BOX, 4-11/16\"/>
	WALL BOX, HEIGHT AND WIDTH AS SPECIFIED, FOR AUDIO/VIDEO RECEPTACLES. MOUNT FLUSH WITH FINISHED WALL TREATMENT, AT BASE BUILDING ELECTRICAL SWITCH HEIGHT UNLESS OTHERWISE INDICATED.
	GANGABLE WALL BOX, 4-11/16\"/>
	GANGABLE WALL BOX, 4-11/16\"/>
	BACK BOX FOR WALL-MOUNTED AUDIOVISUAL CONTROL SYSTEM TOUCH PANEL. BACK BOX TO BE OEM BY MANUFACTURER, REFERENCED TO MODEL NUMBER. MOUNT FLUSH WITH FINISHED WALL TREATMENT, COORDINATE HEIGHT WITH ARCHITECTURAL AND ADA REQUIREMENTS.
	SINGLE-GANG WALL BOX, 4-11/16\"/>
	SINGLE-GANG WALL BOX, 4-11/16\"/>
	WALL SWITCH FOR PROJECTION SCREEN, RAISE/STOP/LOWER, SUPPLIED WITH SCREEN. MOUNT FLUSH WITH FINISHED WALL TREATMENT, AT BASE BUILDING ELECTRICAL SWITCH HEIGHT UNLESS OTHERWISE INDICATED.
	POWER RECEPTACLE, DUPLEX, 120 VAC, 20 AMP, HOSPITAL GRADE ORANGE. MOUNT AT BASE BUILDING ELECTRICAL SWITCH HEIGHT UNLESS OTHERWISE INDICATED.
	WALL-MOUNTED TELECOM VOICE/DATA OUTLET BOX. QUANTITY AND TYPE OF CABLING AS PER PROJECT STANDARDS, UNLESS OTHERWISE NOTED. REFER TO THE ARCHITECTURAL DRAWINGS FOR DIMENSIONED LOCATION; MOUNT AT BASE BUILDING OUTLET HEIGHT, UNLESS OTHERWISE INDICATED.
	GANGABLE WALL BOX, 4-11/16\"/>
	CEILING LOUDSPEAKER BACK BOX, GRILLE AND TILE BRIDGE. MOUNT FLUSH WITH FINISHED CEILING, AS SHOWN ON THE ARCHITECTURAL CEILING PLANS, UNLESS OTHERWISE INDICATED. CONFIRM THE INTEGRITY OF THE CEILING GRID SYSTEM WITH THE STRUCTURAL ENGINEER.
	PROJECTION SCREEN, PROJECTOR LIFT OR SHADE WITH LOW-VOLTAGE INTERFACE, SUPPLIED WITH DEVICE. MOUNT ABOVE FINISHED CEILING UNLESS OTHERWISE INDICATED. MAINTENANCE ACCESS TO BOX SHALL BE PROVIDED IN NON-ACCESSIBLE CEILINGS. PROVIDE UTILITY-GRADE 120VAC UNLESS OTHERWISE INDICATED.
	POWER RECEPTACLE, DUPLEX, 120 VAC, 20 AMP, HOSPITAL GRADE ORANGE, SEPARATE CIRCUIT. MOUNT FLUSH WITH FINISHED CEILING UNLESS OTHERWISE INDICATED.
	CEILING MOUNTED TELECOM DATA OUTLET BOX; QUANTITY AND TYPE OF CABLING AS PER PROJECT STANDARDS, UNLESS OTHERWISE INDICATED. REFER TO THE ARCHITECTURAL DRAWINGS FOR DIMENSIONED LOCATION.

AUDIOVISUAL ELECTRICAL NOTES

- POWER AND DATA ON THE AV DRAWINGS ARE "FOR REFERENCE ONLY." PLEASE REFER TO ELECTRICAL AND LOW VOLTAGE DRAWINGS FOR EXACT QUANTITIES AND LOCATIONS. ASSOCIATED AV CONDUIT AND BOXES ON THE AV DRAWINGS ARE FOR DESIGN AND CONSTRUCTION ISSUE.
- WHERE EXACT DIMENSIONS ARE NOT CALLED FOR, THE SCALE OF THIS DRAWING IS SUFFICIENTLY ACCURATE FOR DETERMINING ROUGH LOCATION OF EQUIPMENT, JUNCTION BOXES, OUTLET BOXES, WIREWAYS, PANELS, ETC. WHERE EXACT DIMENSIONS ARE CALLED FOR, THE REFERENCE SURFACE SHALL BE THE FINAL FINISHED SURFACE INCLUDING ANY ACOUSTICAL TREATMENT. ROOM DIMENSIONS ON THIS DRAWING HAVE BEEN TAKEN FROM PRELIMINARY ARCHITECTURAL DRAWINGS.
- POWER CONDUIT, POWER WIREWAYS AND POWER JUNCTION BOXES ARE TO BE REVIEWED BY THE ELECTRICAL ENGINEER FOR CODE COMPLIANCE.
- EMPTY CONDUITS RUNS ON THIS DRAWING SHOW ONLY INTERCONNECTION BETWEEN THE TERMINATION POINTS. THE EXACT PATH OF CONDUIT ARE TO BE DETERMINED BY FIELD CONDITIONS.
- ALL EMPTY CONDUIT ON THIS DRAWING TO BE 1" UNLESS OTHERWISE NOTED. ALL EMPTY CONDUIT SHALL BE DEBURRED, CLEANED, CAPPED, TAGGED AND FURNISHED WITH PULL WIRES.
- THERE SHALL BE A MINIMUM OF ONE PULL BOX FOR EVERY 100 FEET OF STRAIGHT EMPTY CONDUIT AND A PULL BOX FOR MORE THAN TWO 90° BENDS IN A CONDUIT RUN.
- POWER RECEPTACLES SHOWN ON THIS DRAWING ARE DEDICATED TO SPECIFIC AUDIOVISUAL AND TELEVISION EQUIPMENT. REFER TO ELECTRICAL DRAWINGS FOR ADDITIONAL UTILITY POWER RECEPTACLES.
- POWER BREAKER PANELS ARE SIZED AND SPECIFIED BY THE ELECTRICAL ENGINEER. REFER TO ELECTRICAL DRAWINGS. ALL CIRCUITS SHALL BE PROTECTED BY 120VAC, 20 AMP BREAKERS UNLESS OTHERWISE DETAILED.
- WHERE POWER CIRCUITS ARE SHOWN TERMINATING IN JUNCTION BOXES WITHOUT RECEPTACLES, THE WIRES SHALL BE TAPED AND THE BOXES COVERED. THESE CIRCUITS WILL BE CONNECTED BY OTHERS DURING INSTALLATION OF THE AUDIOVISUAL SYSTEMS EQUIPMENT.
- THE METHOD OF INSTALLATION OF BOXES IN WALLS, AND THE METHOD OF PASSAGE OF CONDUITS AND WIREWAYS THROUGH ACOUSTICALLY SENSITIVE WALLS SHALL BE COORDINATED WITH THE ACOUSTICAL CONSULTANT.

MATERIAL KEYING LEGEND:

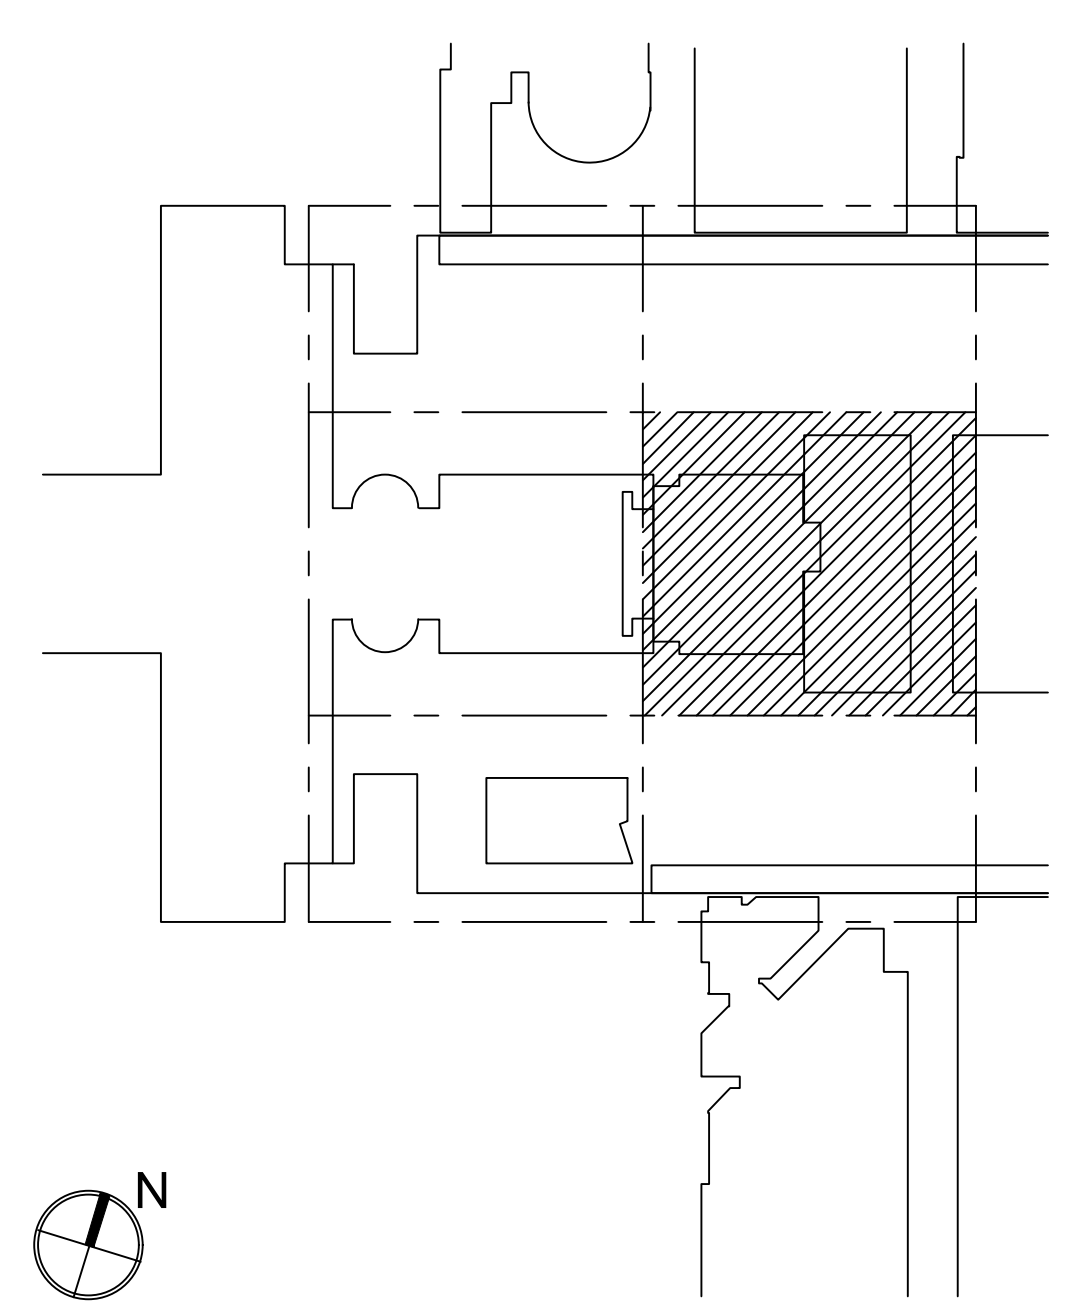

KEY PLAN

NO.	REVISIONS / SUBMISSIONS	DATE
5	GROUP III AV BID DOCUMENTS	08.06.2017
3	BULLETIN 29	08.23.2017
2	BID DOCUMENTS	05.28.2014
1	DESIGN MANUAL PHASE SUBMISSION	04.01.2014

FX FOWLE
FX FOWLE ARCHITECTS, LLP | 22 WEST 10TH STREET | NEW YORK, NY 10011 | T 212.427.1700 | F 212.453.8716 | WWW.FX FOWLE.COM

STRUCTURAL ENGINEERS:
DESIMONE CONSULTING ENGINEERS
18 West 18th Street, 10th Floor, New York, New York 10011 | 212-532-2211

MECHANICAL, ELECTRICAL, PLUMBING, FIRE PROTECTION ENGINEER:
COLLADO ENGINEERING
2 Holmdel Avenue, White Plains, NY 10603 | 914-332-7656

THEATER PLANNING CONSULTANT:
FISHER DACHS ASSOCIATES
22 West 18th Street, 8th Floor, New York, NY 10011 | 212-691-3020

ACoustics & Audio Visual Consultant:
CERAMI & ASSOCIATES
404 Fifth Avenue, New York, NY 10018 | 212-370-1776

LIGHTING CONSULTANT:
ILLUMINATION ARTS
605 Bloomfield Avenue, Suite 101, Bloomfield NJ 07003 | 973-771-1556

LANDSCAPE CONSULTANT:
W ARCHITECTURE & LANDSCAPE ARCHITECTURE, LLC
105 10th Avenue Third Floor New York, NY 10010 | P 212-961-3533 / F 212-620-0758

civil ENGINEER & LANDSCAPE ARCHITECT:
LANGAN
21 Penn Plaza 360 West 31st Street 8th Floor New York, NY 10001 | 212-476-5400 | 212-476-5444 (fax)

ELEVATOR CONSULTANT:
VDA (VAN DEUSEN & ASSOCIATES)
Seven Penn Plaza, Suite 404 New York, NY 10001 | Phone: 212-608-9090 Fax: 212-608-9099

IT CONSULTANT:
GRID ASSOCIATES, LLC
P.O. Box 1770 Hoboken, NJ 07030 | T 946.722.6600 / F 946.722.6625

SUSTAINABILITY LEADER:
YR&G
161 Bowery - 4th Floor, New York, NY 10002 | T 917.677.8023 / F 917.677.8023

GUEST ESTIMATING CONSULTANT:
TOSCANO CLEMENTS TAYLOR, LLC
16 Oakwood Road Huntington, NY 11743 | T 631.392.1400 / F 631.392.1399

C.I.T.L. PROJ. # 29402
SUNY PURCHASE COLLEGE
735 ANDERSON HILL ROAD | PURCHASE, NY 10577


DRAWING TITLE:
AUDIOVISUAL-ELECTRICAL - CITL BUILDING
3RD FLOOR (PLAZA +2 LEVEL) RCP

Seat:	Drawn: AJC	Project No.: 29402 (SUCF) / 05018.L00 (FXP)
	Checked: BJM	Calc File:
	Reviewed: BJM	Drawing No.:
	Date:	

Scale:
1/8" = 1'-0"

TA-415.0

© 2009 FX FOWLE ARCHITECTS, LLP | ALL RIGHTS RESERVED

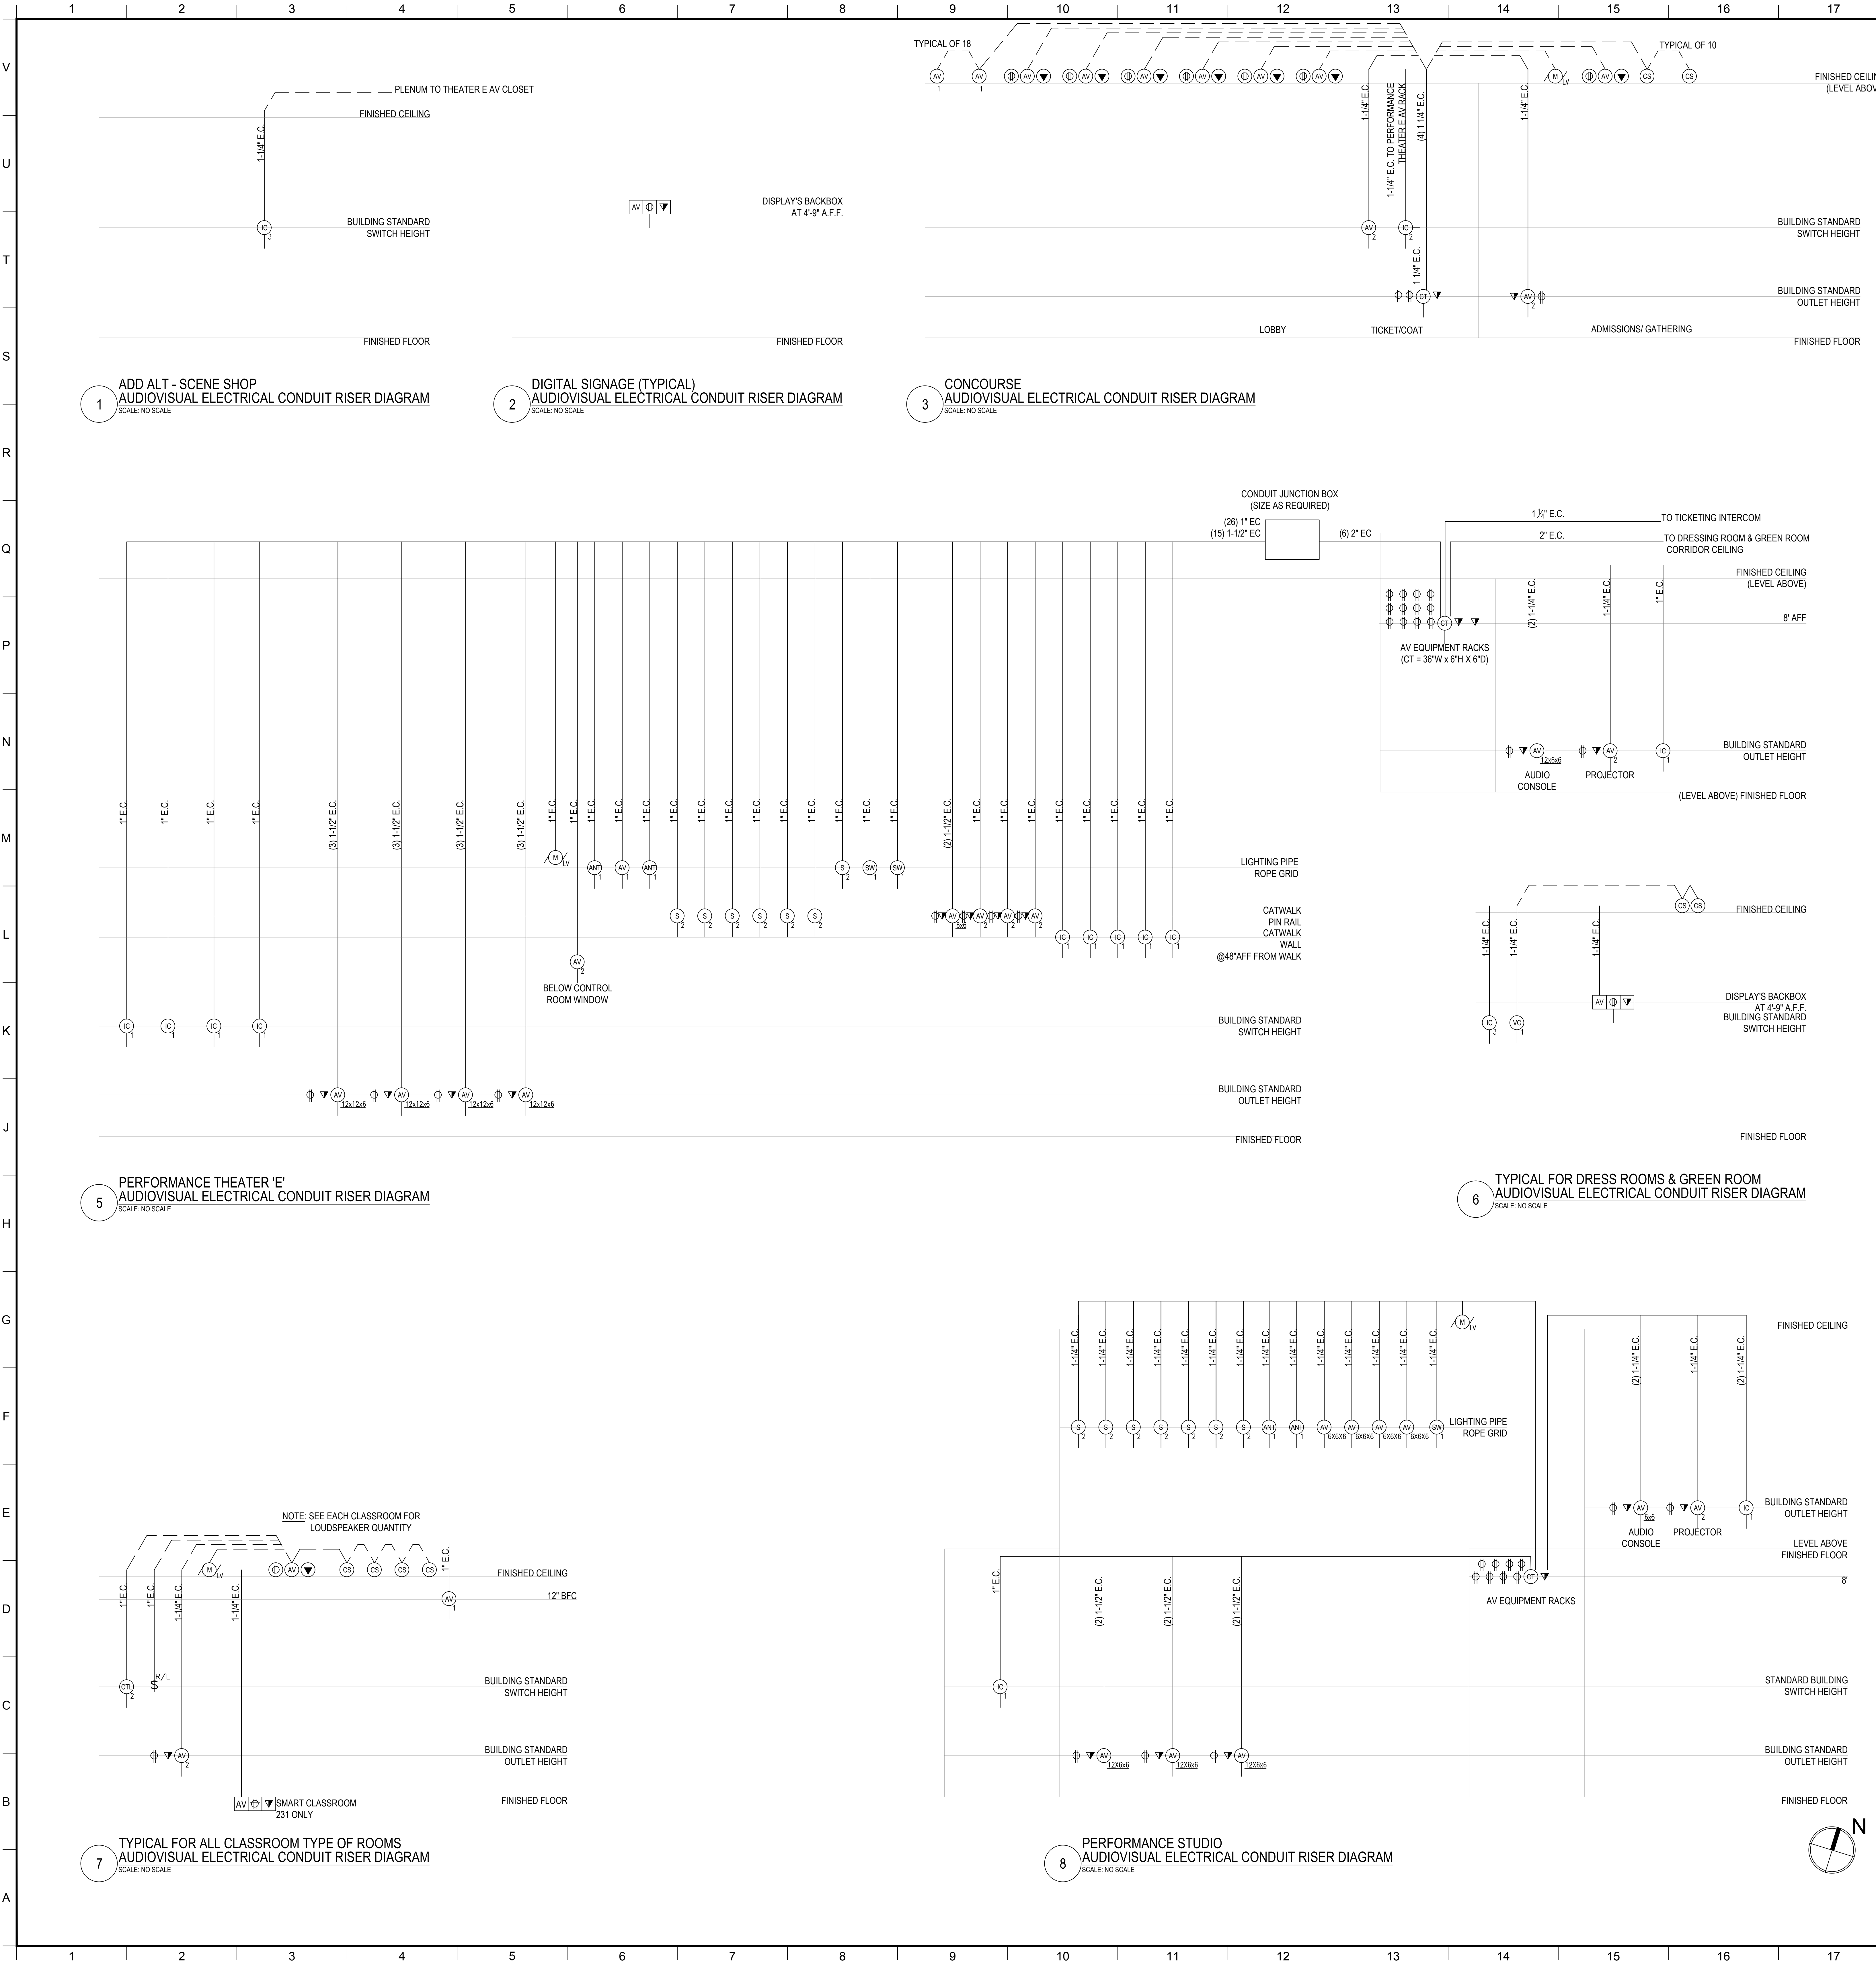


AUDIOVISUAL ELECTRICAL LEGEND

SYMBOL	DESCRIPTION
	MULTI-DISCIPLINE FLOOR BOX OR POKE-THRU, WITH HINGED COVER PLATE AND CARPET FLANGE, WITH DIVIDED COMPARTMENTS FOR SHARED ACCESS WITH VOICE, DATA AND 120VAC POWER. FLUSH MOUNT IN FLOOR UNLESS OTHERWISE INDICATED. (4" DEEP MINIMUM) UNLESS OTHERWISE INDICATED. SEE AUDIOVISUAL DETAIL SHEETS.
	SCREW COVER JUNCTION BOX FOR AUDIOVISUAL CONDUIT TERMINATION, SIZED ACCORDINGLY. ALL CONDUITS TERMINATE AT THIS BOX UNLESS OTHERWISE INDICATED.
	MULTI-DISCIPLINE IN-WALL BOX, WITH DIVIDED COMPARTMENTS FOR SHARED ACCESS WITH VOICE, DATA AND 120VAC POWER. MOUNT FLUSH WITH FINISHED WALL TREATMENT, BEHIND DISPLAY, UNLESS OTHERWISE INDICATED. SEE AUDIOVISUAL DETAIL SHEETS.
	GANGABLE WALL BOX, 4-11/16" HIGH X 2-1/2" DEEP, FOR AUDIO/VIDEO RECEPTACLES, MOUNT FLUSH WITH FINISHED WALL TREATMENT, AT BASE BUILDING ELECTRICAL SWITCH HEIGHT UNLESS OTHERWISE INDICATED. SUBNUMBER INDICATES GANG #
	WALL BOX, HEIGHT AND WIDTH AS SPECIFIED, FOR AUDIO/VIDEO RECEPTACLES, MOUNT FLUSH WITH FINISHED WALL TREATMENT, AT BASE BUILDING ELECTRICAL SWITCH HEIGHT UNLESS OTHERWISE INDICATED.
	GANGABLE WALL BOX, 4-11/16" HIGH X 2-1/2" DEEP, FOR INTERCOM RECEPTACLES, MOUNT FLUSH WITH FINISHED WALL TREATMENT, AT BASE BUILDING ELECTRICAL SWITCH HEIGHT UNLESS OTHERWISE INDICATED. SUBNUMBER INDICATES GANG #
	GANGABLE WALL BOX, 4-11/16" HIGH X 2-1/2" DEEP, FOR MOUNTED VOLUME CONTROLLER, MOUNT FLUSH WITH FINISHED WALL TREATMENT, COORDINATE HEIGHT WITH ARCHITECTURAL AND ADA REQUIREMENTS. SUBNUMBER INDICATES GANG #
	BACK BOX FOR WALL-MOUNTED AUDIOVISUAL CONTROL SYSTEM TOUCH PANEL. BACK BOX TO BE OEM BY MANUFACTURER, REFERENCED TO MODEL NUMBER, MOUNT FLUSH WITH FINISHED WALL TREATMENT, COORDINATE HEIGHT WITH ARCHITECTURAL AND ADA REQUIREMENTS.
	SINGLE-GANG WALL BOX, 4-11/16" HIGH X 2-1/2" DEEP, FOR MICROPHONE ANTENNA OR ASSISTIVE LISTENING ANTENNA, MOUNT FLUSH WITH FINISHED WALL TREATMENT, AT SPECIFIED HEIGHT. SUBNUMBER INDICATES GANG #
	SINGLE-GANG WALL BOX, 4-11/16" HIGH X 2-1/2" DEEP, WITH 1-1/4" CONDUIT KNOCKOUTS AND BLANK COVER PLATE, FOR PIPE MOUNTED SPEAKER OR SUBWOOFER, MOUNT ON PIPE GRID.
	WALL SWITCH FOR PROJECTION SCREEN, RAISE/STOP/LOWER, SUPPLIED WITH SCREEN. MOUNT FLUSH WITH FINISHED WALL TREATMENT, AT BASE BUILDING ELECTRICAL SWITCH HEIGHT UNLESS OTHERWISE INDICATED.
	POWER RECEPTACLE, DUPLEX, 120 VAC, 20 AMP, HOSPITAL GRADE ORANGE. MOUNT AT BASE BUILDING ELECTRICAL SWITCH HEIGHT UNLESS OTHERWISE INDICATED.
	WALL-MOUNTED TELECOM VOICE/DATA OUTLET BOX; QUANTITY AND TYPE OF CABLING AS PER PROJECT STANDARDS, UNLESS OTHERWISE NOTED. REFER TO THE ARCHITECTURAL DRAWINGS FOR DIMENSIONED LOCATION; MOUNT AT BASE BUILDING OUTLET HEIGHT, UNLESS OTHERWISE INDICATED.
	GANGABLE WALL BOX, 4-11/16" HIGH X 2-1/2" DEEP, WITH 1-1/4" CONDUIT KNOCKOUTS AND BLANK COVER PLATE, FOR AUDIOVISUAL CONNECTIVITY, MOUNT FLUSH WITH FINISHED CEILING TREATMENT. SUBNUMBER INDICATES NUMBER OF GANG.
	CEILING LOUDSPEAKER BACK BOX, GRILLE AND TILE BRIDGE, MOUNT FLUSH WITH FINISHED CEILING, AS SHOWN ON THE ARCHITECTURAL CEILING PLANS, UNLESS OTHERWISE INDICATED. CONFIRM THE INTEGRITY OF THE CEILING GRID SYSTEM WITH THE STRUCTURAL ENGINEER.
	PROJECTION SCREEN, PROJECTOR LIFT OR SHADE WITH LOW-VOLTAGE INTERFACE, SUPPLIED WITH DEVICE. MOUNT ABOVE FINISHED CEILING UNLESS OTHERWISE INDICATED. MAINTENANCE ACCESS TO BOX SHALL BE PROVIDED IN NON-ACCESSIBLE CEILINGS. PROVIDE UTILITY-GRADE 120VAC UNLESS OTHERWISE INDICATED.
	POWER RECEPTACLE, DUPLEX, 120 VAC, 20 AMP, HOSPITAL GRADE ORANGE, SEPARATE CIRCUIT, MOUNT FLUSH WITH FINISHED CEILING UNLESS OTHERWISE INDICATED.
	CEILING MOUNTED TELECOM DATA OUTLET BOX; QUANTITY AND TYPE OF CABLING AS PER PROJECT STANDARDS, UNLESS OTHERWISE INDICATED, REFER TO THE ARCHITECTURAL DRAWINGS FOR DIMENSIONED LOCATION.

AUDIOVISUAL ELECTRICAL NOTES

- POWER AND DATA ON THE AV DRAWINGS ARE "FOR REFERENCE ONLY". PLEASE REFER TO ELECTRICAL AND LOW VOLTAGE DRAWINGS FOR EXACT QUANTITIES AND LOCATIONS. ASSOCIATED AV CONDUIT AND BOXES ON THE AV DRAWINGS ARE FOR DESIGN AND CONSTRUCTION ISSUE.
- WHERE EXACT DIMENSIONS ARE NOT CALLED FOR, THE SCALE OF THIS DRAWING IS SUFFICIENTLY ACCURATE FOR DETERMINING ROUGH LOCATION OF EQUIPMENT, JUNCTION BOXES, OUTLET BOXES, WIREWAYS, PANELS, ETC. WHERE EXACT DIMENSIONS ARE CALLED FOR, THE REFERENCE SURFACE SHALL BE THE FINAL FINISHED SURFACE INCLUDING ANY ACOUSTICAL TREATMENT. ROOM DIMENSIONS ON THIS DRAWING HAVE BEEN TAKEN FROM PRELIMINARY ARCHITECTURAL DRAWINGS.
- POWER CONDUIT, POWER WIREWAYS AND POWER JUNCTION BOXES ARE TO BE REVIEWED BY THE ELECTRICAL ENGINEER FOR CODE COMPLIANCE.
- EMPTY CONDUITS RUNS ON THIS DRAWING SHOW ONLY INTERCONNECTION BETWEEN THE TERMINATION POINTS. THE EXACT PATH OF CONDUIT ARE TO BE DETERMINED BY FIELD CONDITIONS.
- ALL EMPTY CONDUIT ON THIS DRAWING TO BE 1" UNLESS OTHERWISE NOTED. ALL EMPTY CONDUIT SHALL BE DEBURRED, CLEANED, CAPPED, TAGGED AND FURNISHED WITH PULL WIRES.
- THERE SHALL BE A MINIMUM OF ONE PULL BOX FOR EVERY 100 FEET OF STRAIGHT EMPTY CONDUIT AND A PULL BOX FOR MORE THAN TWO 90° BENDS IN A CONDUIT RUN.
- POWER RECEPTACLES SHOWN ON THIS DRAWING ARE DEDICATED TO SPECIFIC AUDIOVISUAL AND TELEVISION EQUIPMENT. REFER TO ELECTRICAL DRAWINGS FOR ADDITIONAL UTILITY POWER RECEPTACLES.
- POWER BREAKER PANELS ARE SIZED AND SPECIFIED BY THE ELECTRICAL ENGINEER, REFER TO ELECTRICAL DRAWINGS. ALL CIRCUITS SHALL BE PROTECTED BY 120VAC, 20 AMP BREAKERS UNLESS OTHERWISE DETAILED.
- WHERE POWER CIRCUITS ARE SHOWN TERMINATING IN JUNCTION BOXES WITHOUT RECEPTACLES, THE WIRES SHALL BE TAPED AND THE BOXES COVERED. THESE CIRCUITS WILL BE CONNECTED BY OTHERS DURING INSTALLATION OF THE AUDIOVISUAL SYSTEMS EQUIPMENT.
- THE METHOD OF INSTALLATION OF BOXES IN WALLS, AND THE METHOD OF PASSAGE OF CONDUITS AND WIREWAYS THROUGH ACOUSTICALLY SENSITIVE WALLS SHALL BE COORDINATED WITH THE ACOUSTICAL CONSULTANT.

MATERIAL KEYING LEGEND:

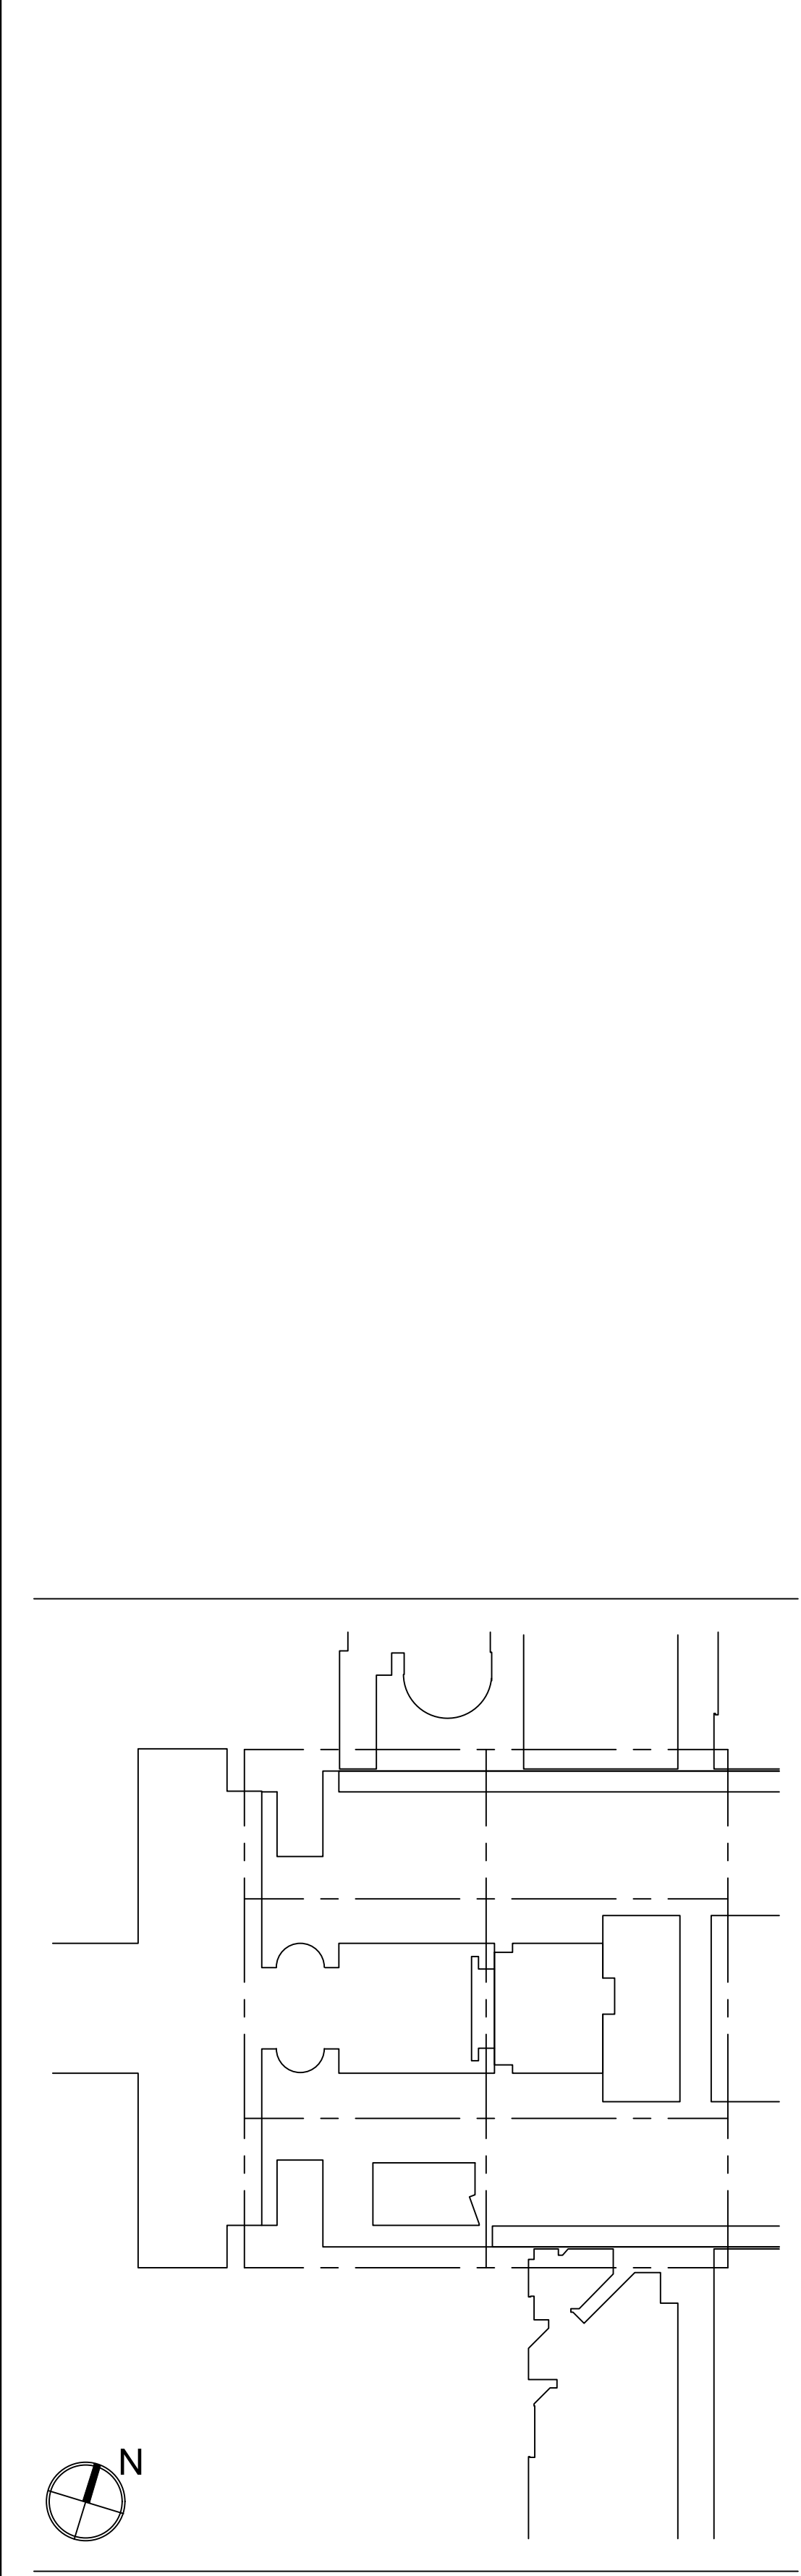

KEY PLAN

NO.	REVISIONS / SUBMISSIONS	DATE
5	GROUP III AV BID DOCUMENTS	08.06.2017
3	BID DOCUMENTS	05.28.2014
2	DESIGN MANUAL PHASE SUBMISSION	04.01.2013
1	30% PRICING SET	03.07.2013

NO. REVISIONS / SUBMISSIONS DATE

FXFOWLE

FXFOWLE ARCHITECTS, LLP | 22 WEST 10TH STREET (NEW YORK, NY 10011) | T 212.627.1700 | F 212.463.8716 | WWW.FXFOWLE.COM
STRUCTURAL ENGINEERS:
DESIMONE CONSULTING ENGINEERS
18 West 18th Street, 10th Floor, New York, New York 10011 | 212-532-2211

MECHANICAL, ELECTRICAL, PLUMBING, FIRE PROTECTION ENGINEER:
COLLADO ENGINEERING
2 Hickland Avenue, White Plains, NY 10603 | 914-332-7858

THEATER PLANNING CONSULTANT:
FISHER DACHS ASSOCIATES
22 West 10th Street, 8th Floor, New York, NY 10011 | 212-691-3020

ACoustics & AUDIO VISUAL CONSULTANT:
CERAM & ASSOCIATES
404 Fifth Avenue, New York, NY 10018 | 212-370-1776

LIGHTING CONSULTANT:
ILLUMINATION ARTS
600 Bloomfield Avenue, Suite 101, Bloomfield NJ 07003 | 973-771-1558

LANDSCAPE CONSULTANT:
W ARCHITECTURE & LANDSCAPE ARCHITECTURE, LLC
105 Fifth Avenue Third Floor New York, NY 10010 P 212-361-3533 F 212-620-0758

CRS, ENGINEER & ARCHITECT:
LANGAN
21 Penn Plaza 360 West 31st Street 8th Floor New York, NY 10001 212-479-5400 212-479-5444 (fax)

ELEVATOR CONSULTANT:
VDA (VAN DEUSEN & ASSOCIATES)
Seven Penn Plaza, Suite 404 New York, NY 10001 Phone: 212-608-9090 Fax: 212-608-9099

IT CONSULTANT:
GRID ASSOCIATES, LLC
P.O. Box 1708 Hightstown, NJ 08520 T 609.722.9800 / F 609.722.9825

SUSTAINABILITY LEED:
YR&G
161 Bowery - 4th Floor, New York, NY 10002 T 917.677.8023 / F 917.677.8023


GUEST ESTIMATING CONSULTANT:
TOSCANO CLEMENTE'S TAYLOR, LLC
16 Oakwood Road Huntington, NY 11743 T 631.352.1400 / F 631.352.1399

C.I.T.L. PROJ. # 29402
SUNY PURCHASE COLLEGE
735 ANDERSON HILL ROAD | PURCHASE, NY 10577

DRAWING TITLE: AUDIOVISUAL ELECTRICAL CONDUIT RISER DIAGRAMS

Set:	Drawn: AJC	Project No.: 29402 (SUCF) / 00018.L00 (FXF)
	Checked: BJM	Cad File:
	Reviewed: BJM	Drawing No.:
	Date:	Scale: 1/8" = 1'-0"

TA-501.0

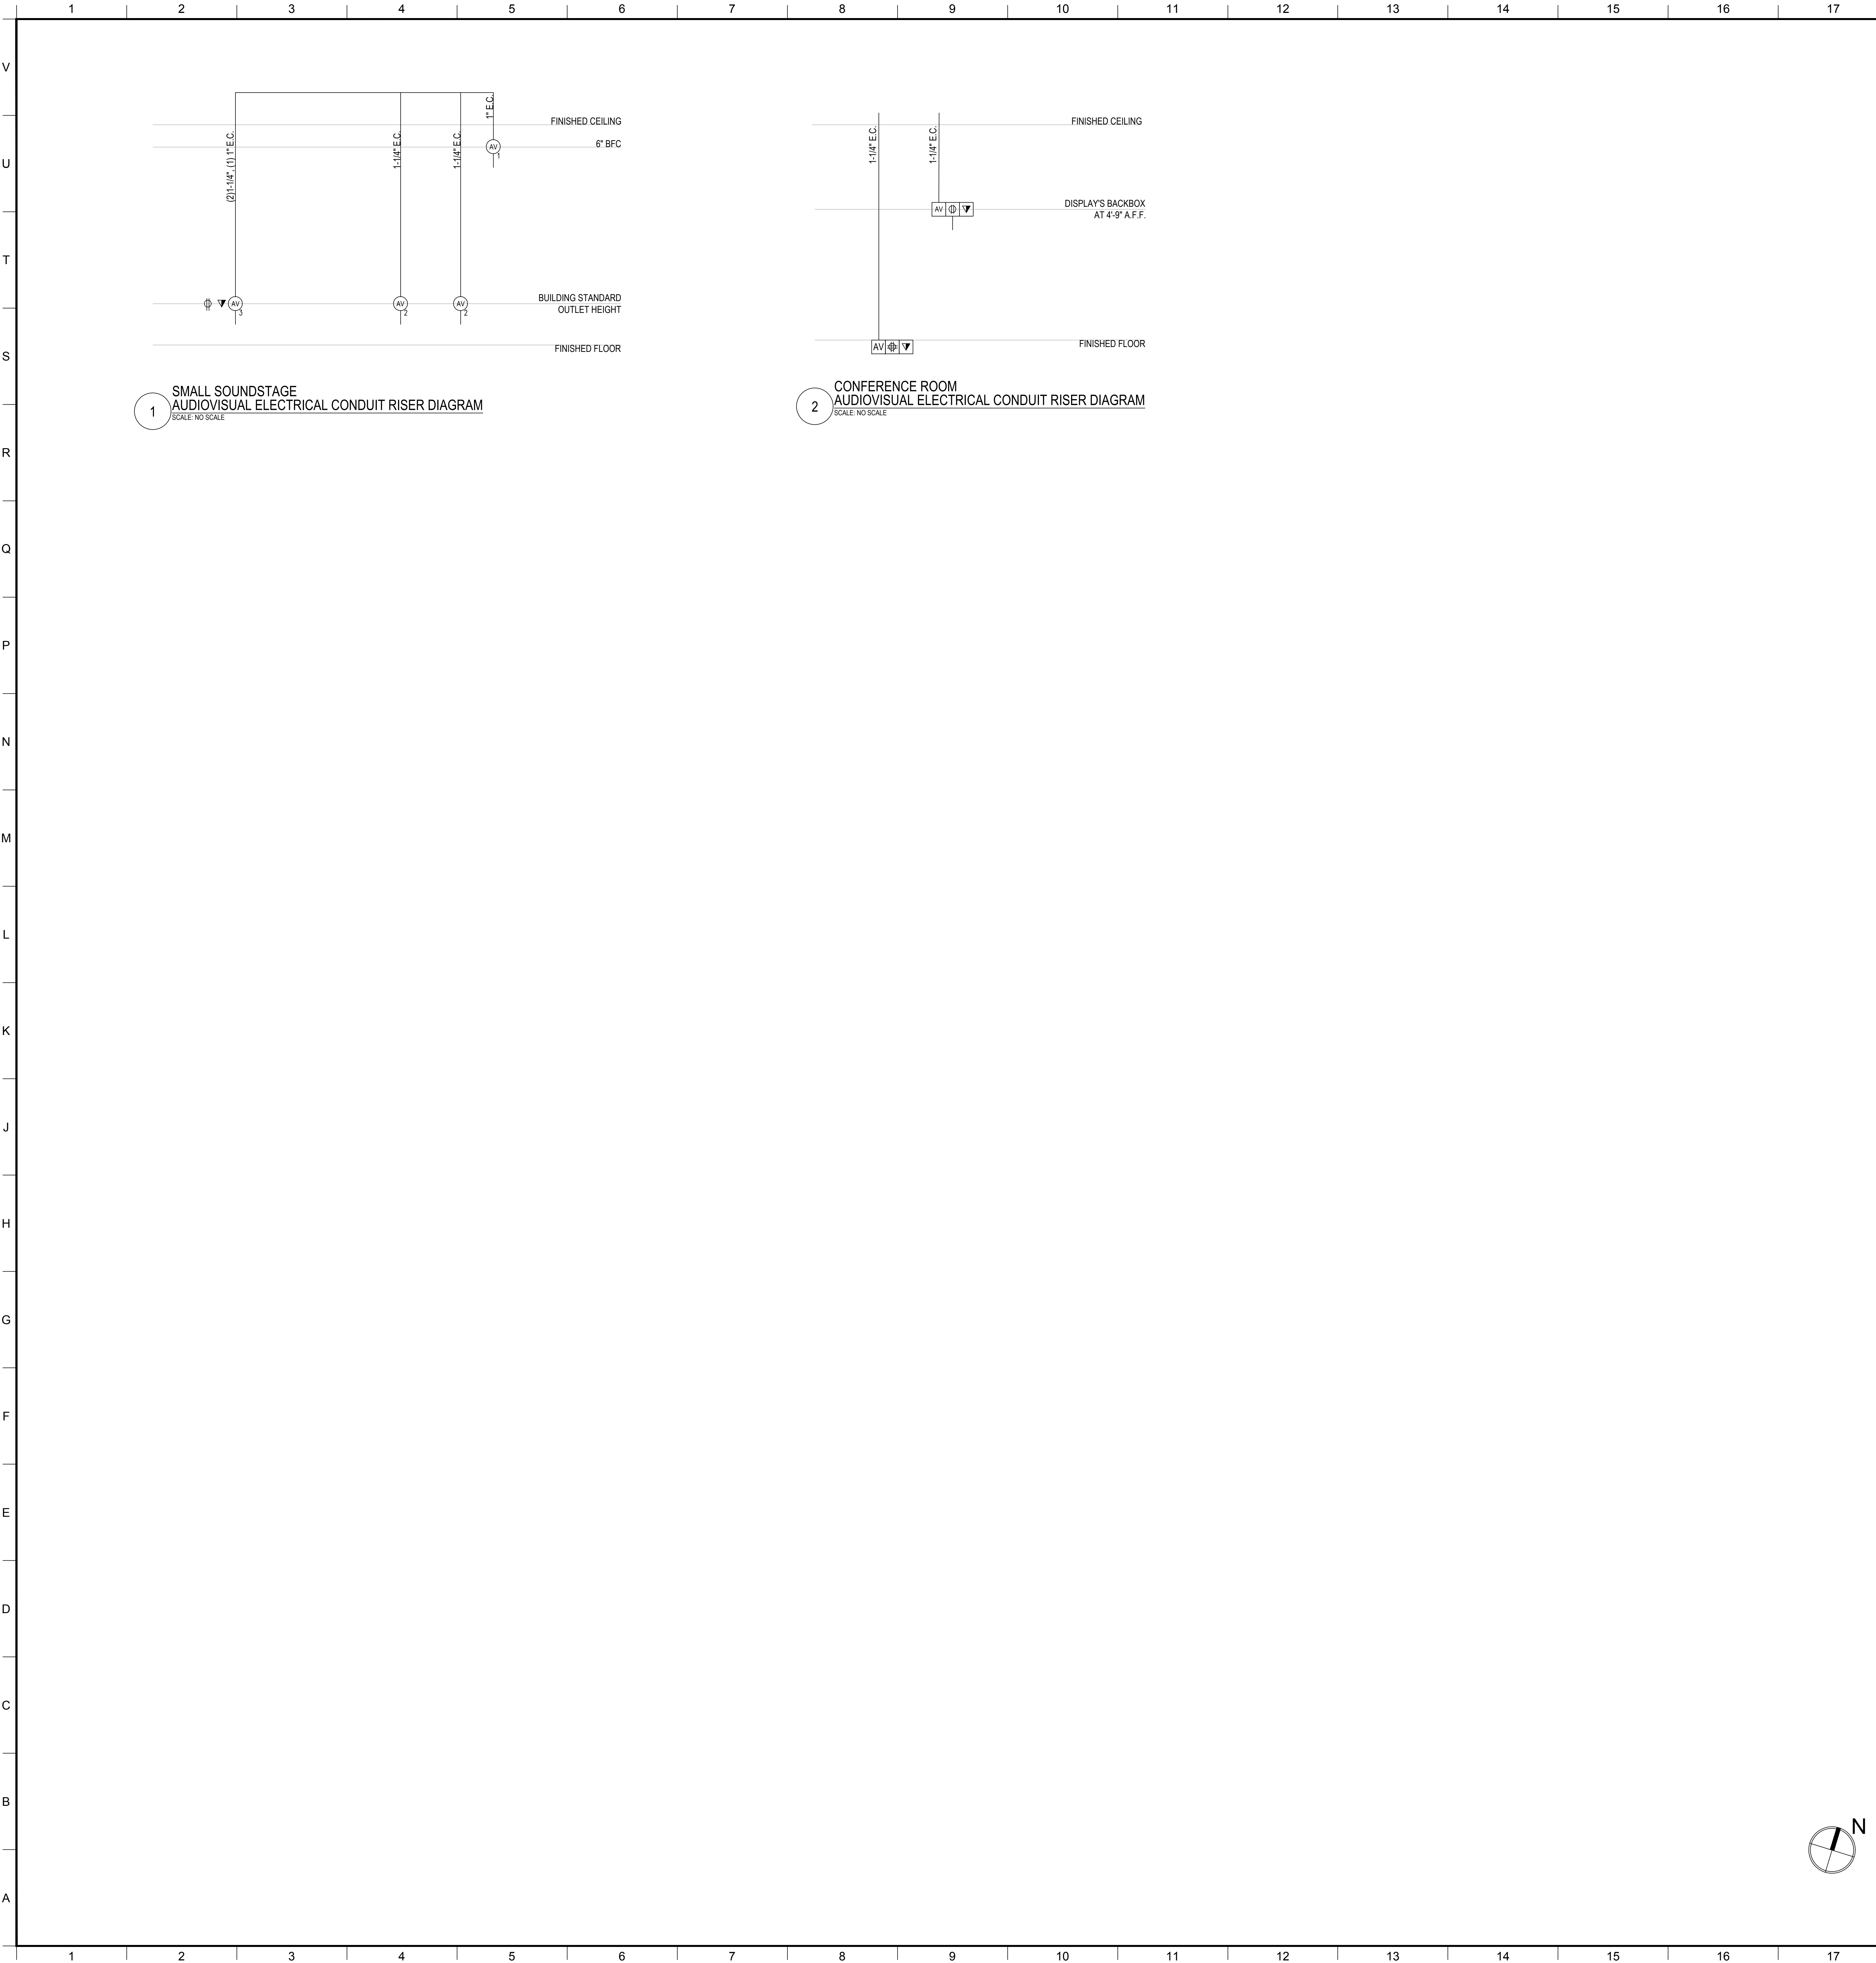

AUDIOVISUAL ELECTRICAL LEGEND


SYMBOL	DESCRIPTION
	MULTI-DISCIPLINE FLOOR BOX OR POKE-THRU, WITH HINGED COVER PLATE AND CARPET FLANGE, WITH DIVIDED COMPARTMENTS FOR SHARED ACCESS WITH VOICE, DATA AND 120VAC POWER. FLUSH MOUNT IN FLOOR UNLESS OTHERWISE INDICATED. (4\"/>
	SCREW COVER JUNCTION BOX FOR AUDIOVISUAL CONDUIT TERMINATION, SIZED ACCORDINGLY. ALL CONDUITS TERMINATE AT THIS BOX UNLESS OTHERWISE INDICATED.
	MULTI-DISCIPLINE IN-WALL BOX, WITH DIVIDED COMPARTMENTS FOR SHARED ACCESS WITH VOICE, DATA AND 120VAC POWER. MOUNT FLUSH WITH FINISHED WALL TREATMENT, BEHIND DISPLAY. UNLESS OTHERWISE INDICATED. SEE AUDIOVISUAL DETAIL SHEETS.
	GANGABLE WALL BOX, 4-11/16\"/>
	WALL BOX, HEIGHT AND WIDTH AS SPECIFIED, FOR AUDIO/VIDEO RECEPTACLES. MOUNT FLUSH WITH FINISHED WALL TREATMENT, AT BASE BUILDING ELECTRICAL SWITCH HEIGHT UNLESS OTHERWISE INDICATED.
	GANGABLE WALL BOX, 4-11/16\"/>
	GANGABLE WALL BOX, 4-11/16\"/>
	BACK BOX FOR WALL-MOUNTED AUDIOVISUAL CONTROL SYSTEM TOUCH PANEL. BACK BOX TO BE OEM BY MANUFACTURER, REFERENCED TO MODEL NUMBER. MOUNT FLUSH WITH FINISHED WALL TREATMENT; COORDINATE HEIGHT WITH ARCHITECTURAL AND ADA REQUIREMENTS. SUBNUMBER INDICATES GANG #
	SINGLE-GANG WALL BOX, 4-11/16\"/>
	SINGLE-GANG WALL BOX, 4-11/16\"/>
	WALL SWITCH FOR PROJECTION SCREEN, RAISE/STOP/LOWER; SUPPLIED WITH SCREEN. MOUNT FLUSH WITH FINISHED WALL TREATMENT, AT BASE BUILDING ELECTRICAL SWITCH HEIGHT UNLESS OTHERWISE INDICATED.
	POWER RECEPTACLE, DUPLEX, 120 VAC, 20 AMP, HOSPITAL GRADE ORANGE. MOUNT AT BASE BUILDING OUTLET HEIGHT, UNLESS OTHERWISE INDICATED.
	WALL-MOUNTED TELECOM VOICE/DATA OUTLET BOX; QUANTITY AND TYPE OF CABLING AS PER PROJECT STANDARDS, UNLESS OTHERWISE NOTED. REFER TO THE ARCHITECTURAL DRAWINGS FOR DIMENSIONED LOCATION; MOUNT AT BASE BUILDING OUTLET HEIGHT, UNLESS OTHERWISE INDICATED.

	GANGABLE WALL BOX, 4-11/16\"/>
	CEILING LOUDSPEAKER BACK BOX, GRILLE AND TILE BRIDGE. MOUNT FLUSH WITH FINISHED CEILING, AS SHOWN ON THE ARCHITECTURAL CEILING PLANS, UNLESS OTHERWISE INDICATED. CONFIRM THE INTEGRITY OF THE CEILING GRID SYSTEM WITH THE STRUCTURAL ENGINEER.
	PROJECTION SCREEN, PROJECTOR LIFT OR SHADE WITH LOW-VOLTAGE INTERFACE, SUPPLIED WITH DEVICE. MOUNT ABOVE FINISHED CEILING UNLESS OTHERWISE INDICATED. MAINTENANCE ACCESS TO BOX SHALL BE PROVIDED IN NON-ACCESSIBLE CEILINGS. PROVIDE UTILITY-GRADE 120VAC UNLESS OTHERWISE INDICATED.
	POWER RECEPTACLE, DUPLEX, 120 VAC, 20 AMP, HOSPITAL GRADE ORANGE, SEPARATE CIRCUIT. MOUNT FLUSH WITH FINISHED CEILING UNLESS OTHERWISE INDICATED.
	CEILING MOUNTED TELECOM DATA OUTLET BOX; QUANTITY AND TYPE OF CABLING AS PER PROJECT STANDARDS, UNLESS OTHERWISE INDICATED. REFER TO THE ARCHITECTURAL DRAWINGS FOR DIMENSIONED LOCATION.

AUDIOVISUAL ELECTRICAL NOTES

- POWER AND DATA ON THE AV DRAWINGS ARE "FOR REFERENCE ONLY". PLEASE REFER TO ELECTRICAL AND LOW VOLTAGE DRAWINGS FOR EXACT QUANTITIES AND LOCATIONS. ASSOCIATED AV CONDUIT AND BOXES ON THE AV DRAWINGS ARE FOR DESIGN AND CONSTRUCTION ISSUE.
- WHERE EXACT DIMENSIONS ARE NOT CALLED FOR, THE SCALE OF THIS DRAWING IS SUFFICIENTLY ACCURATE FOR DETERMINING ROUGH LOCATION OF EQUIPMENT, JUNCTION BOXES, OUTLET BOXES, WIREWAYS, PANELS, ETC. WHERE EXACT DIMENSIONS ARE CALLED FOR, THE REFERENCE SURFACE SHALL BE THE FINAL FINISHED SURFACE INCLUDING ANY ACOUSTICAL TREATMENT. ROOM DIMENSIONS ON THIS DRAWING HAVE BEEN TAKEN FROM PRELIMINARY ARCHITECTURAL DRAWINGS.
- POWER CONDUIT, POWER WIREWAYS AND POWER JUNCTION BOXES ARE TO BE REVIEWED BY THE ELECTRICAL ENGINEER FOR CODE COMPLIANCE.
- EMPTY CONDUITS RUNS ON THIS DRAWING SHOW ONLY INTERCONNECTION BETWEEN THE TERMINATION POINTS. THE EXACT PATH OF CONDUIT ARE TO BE DETERMINED BY FIELD CONDITIONS.
- ALL EMPTY CONDUIT ON THIS DRAWING TO BE 1" UNLESS OTHERWISE NOTED. ALL EMPTY CONDUIT SHALL BE DEBURRED, CLEANED, CAPPED, TAGGED AND FURNISHED WITH PULL WIRES.
- THERE SHALL BE A MINIMUM OF ONE PULL BOX FOR EVERY 100 FEET OF STRAIGHT EMPTY CONDUIT AND A PULL BOX FOR MORE THAN TWO 90° BENDS IN A CONDUIT RUN.
- POWER RECEPTACLES SHOWN ON THIS DRAWING ARE DEDICATED TO SPECIFIC AUDIOVISUAL AND TELEVISION EQUIPMENT. REFER TO ELECTRICAL DRAWINGS FOR ADDITIONAL UTILITY POWER RECEPTACLES.
- POWER BREAKER PANELS ARE SIZED AND SPECIFIED BY THE ELECTRICAL ENGINEER. REFER TO ELECTRICAL DRAWINGS. ALL CIRCUITS SHALL BE PROTECTED BY 120VAC, 20 AMP BREAKERS UNLESS OTHERWISE DETAILED.
- WHERE POWER CIRCUITS ARE SHOWN TERMINATING IN JUNCTION BOXES WITHOUT RECEPTACLES, THE WIRES SHALL BE TAPED AND THE BOXES COVERED. THESE CIRCUITS WILL BE CONNECTED BY OTHERS DURING INSTALLATION OF THE AUDIOVISUAL SYSTEMS EQUIPMENT.
- THE METHOD OF INSTALLATION OF BOXES IN WALLS, AND THE METHOD OF PASSAGE OF CONDUITS AND WIREWAYS THROUGH ACOUSTICALLY SENSITIVE WALLS SHALL BE COORDINATED WITH THE ACOUSTICAL CONSULTANT.

MATERIAL KEYING LEGEND:

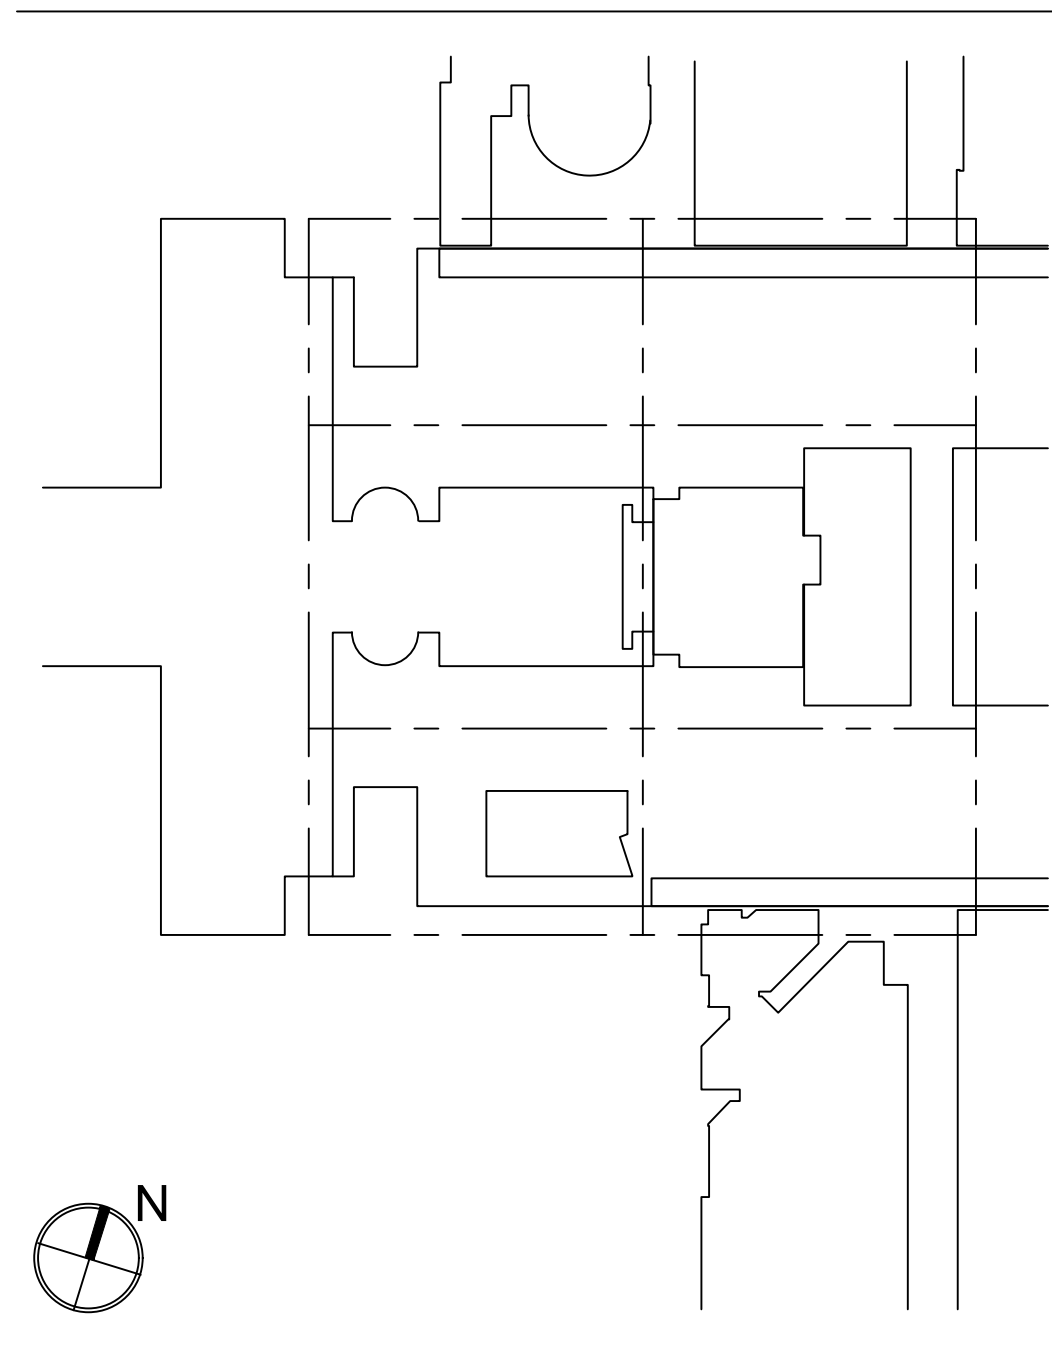

KEY PLAN

NO.	REVISIONS / SUBMISSIONS	DATE
5	GROUP III AV BID DOCUMENTS	08.06.2017
3	BID DOCUMENTS	05.28.2014
2	DESIGN MANUAL PHASE SUBMISSION	04.01.2013
1	30% PRICING SET	03.07.2013


FX FOWLE FXFOWLE ARCHITECTS, LLP 22 WEST 10TH STREET NEW YORK, NY 10011 T 212.427.1700 F 212.453.8716 WWW.FXFOLE.COM STRUCTURAL ENGINEER: DESIMONE CONSULTING ENGINEERS 18 West 18th Street, 10th Floor, New York, New York 10011 212-532-2211 MECHANICAL, ELECTRICAL, PLUMBING, FIRE PROTECTION ENGINEER: COLLADO ENGINEERING 2 Hickory Avenue, White Plains, NY 10603 914-332-7656 THEATER PLANNING CONSULTANT: FISHER DACHS ASSOCIATES 22 West 19th Street, 8th Floor, New York, NY 10011 212-691-3020 ACoustics & AUDIO VISUAL CONSULTANT: CERAMI & ASSOCIATES 404 Fifth Avenue, New York, NY 10018 212-370-1776 LIGHTING CONSULTANT: ILLUMINATION ARTS 650 Bloomfield Avenue, Suite 101, Bloomfield NJ 07003 973-771-1556 LANDSCAPE CONSULTANT: W ARCHITECTURE & LANDSCAPE ARCHITECTURE, LLC 105 Fifth Avenue Third Floor New York, NY 10010 P 212-961-3533 / F 212-620-0758 CIVIL ENGINEER & LANDMAST: LANGAN 21 Penn Plaza 360 West 31st Street 8th Floor New York, NY 10001 212-479-5400 212-479-5444 (fax) ELEVATOR CONSULTANT: VDA (VAN DEUSEN & ASSOCIATES) Seven Penn Plaza, Suite 404 New York, NY 10001 Phone: 212-608-9090 Fax: 212-608-9099 IT CONSULTANT: GRID ASSOCIATES, LLC P.O. Box 1703 Hoboken, NJ 07030 T 946.722.0600 / F 946.722.0625 SUSTAINABILITY LEAD: YR&G 161 Bowery - 4th Floor, New York, NY 10002 T 917.677.8023 / F 917.677.8023 GUEST ESTIMATING CONSULTANT: TOSCANO CLEMENTS TAYLOR, LLC 16 Oakwood Road Huntington, NY 11743 T 631.392.1400 / F 631.392.1399

C.I.T.L. PROJ. # 29402
SUNY PURCHASE COLLEGE
735 ANDERSON HILL ROAD | PURCHASE, NY 10577

DRAWING TITLE: AUDIOVISUAL ELECTRICAL CONDUIT RISER DIAGRAMS			
Seal:	Drawn: AJC	Project No.: 29402 (SUCF) / 05018.L00 (FXF)	
	Checked: BJM	Coord File:	
	Reviewed: BJM	Drawing No.:	
	Date:		
	Scale: 1/8" = 1'-0"		

TA-502.0

V
U
T
S
R
Q
P
N
M
L
K
J
H
G
F
E
D
C
B
A

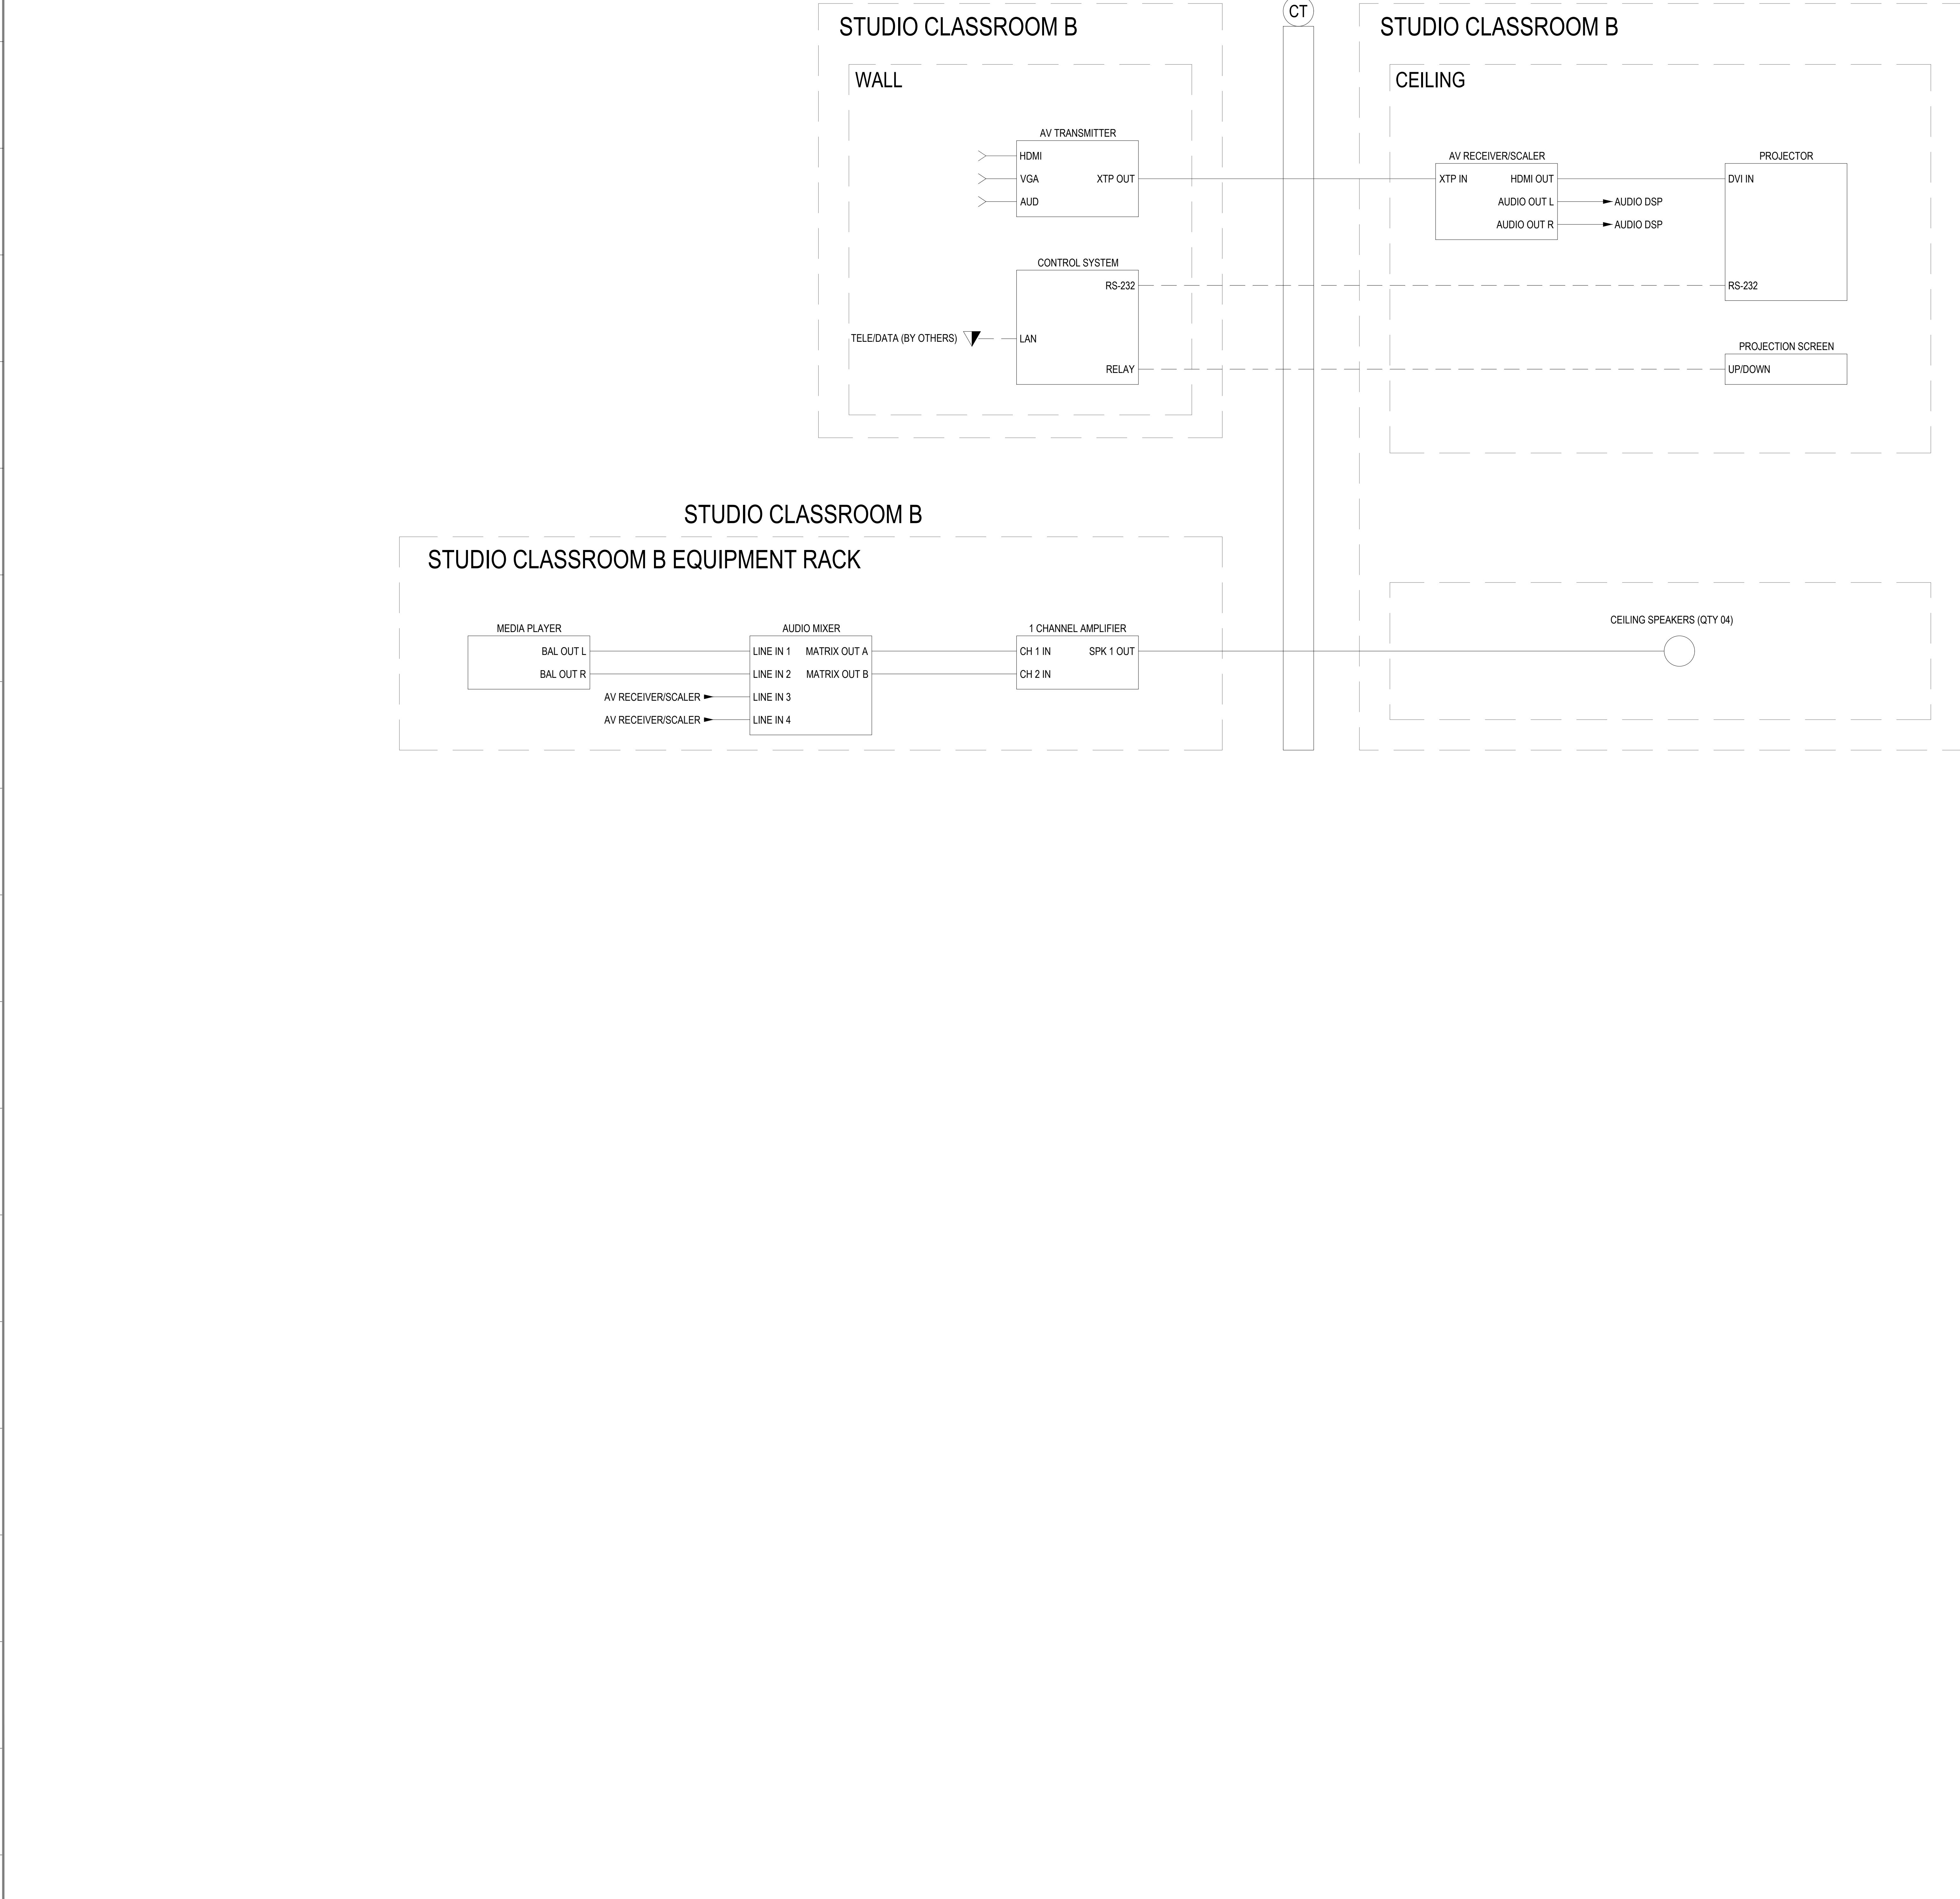

MATERIAL KEYING LEGEND:

5

NO.	REVISIONS / SUBMISSIONS	DATE
1	PRELIMINARY FLOWS	12/02/16

FX FOWLE

FX FOWLE ARCHITECTS, LLP | 22 WEST 10TH STREET | NEW YORK, NY 10011 | T 212.627.1700 | F 212.463.8716 | WWW.FX FOWLE.COM

STRUCTURAL ENGINEER:
DESIMONE CONSULTING ENGINEERS
15 West 18th Street, 10th Floor, New York, New York 10011 212-532-2211

MECHANICAL, ELECTRICAL, PLUMBING, FIRE PROTECTION ENGINEER:
COLLADO ENGINEERING
2 Holland Avenue, White Plains, NY 10603 914-332-7658

THEATER PLANNING CONSULTANT:
FISHER DACHS ASSOCIATES
22 West 12th Street, 8th Floor, New York, NY 10011 212-691-3020

ACOUSTICS & AUDIO / VISUAL CONSULTANT:
CERAMI & ASSOCIATES
404 Fifth Avenue, New York, NY 10018 212-370-1776

LIGHTING CONSULTANT:
ILLUMINATION ARTS
650 Bloomfield Avenue, Suite 101, Bloomfield NJ 07003 973-771-1556

LANDSCAPE CONSULTANT:
W ARCHITECTURE & LANDSCAPE ARCHITECTURE, LLC
150 Fifth Avenue, Third Floor, New York, NY 10010 | P 212-981-3833 | F 212-620-0706

CIVIL ENGINEER & HAZMAT:
LANGAN
21 Penn Plaza, 360 West 31st Street 8th Floor New York, NY 10001 212-479-5400 212-479-5444 (fax)

ELEVATOR CONSULTANT:
VDA (VAN DEUSEN & ASSOCIATES)
Seven Penn Plaza, Suite 404 New York, NY 10001 Phone: 212-868-0090 Fax: 212-868-0099

IT CONSULTANT:
GRID ASSOCIATES, LLC
P.O. Box 1782 Hoboken, NJ 07030 T 846.722.6600 / F 646.722.6625

SUSTAINABILITY / LEED:
YR&G
161 Bowery - 4th Floor, New York, NY 10002 T 917.677.8023 / F 917.677.8023

COST ESTIMATING CONSULTANT:
TOSCANO CLEMENTS TAYLOR, LLC
16 Oakwood Road Huntington, NY 11743 T 631.392.1400 / F 631.392.1399

C.I.T.L. PROJ. # 29402
SUNY PURCHASE COLLEGE
735 ANDERSON HILL ROAD | PURCHASE, NY 10577

DRAWING TITLE:


STUDIO CLASSROOM B AV SYSTEMS BLOCK DIAGRAMS

Seal:	Drawn:	Project No.:
		29402 (SUCF) / 09018.L00 (FXF)
	Checked:	Cad File:
	Reviewed:	Drawing No.:
	Date:	
	Scale:	
	NOT TO SCALE	

TA-08.01

© 2009 FX FOWLE ARCHITECTS, LLP | ALL RIGHTS RESERVED

V
U
T
S
R
Q
P
N
M
L
K
J
H
G
F
E
D
C
B
A

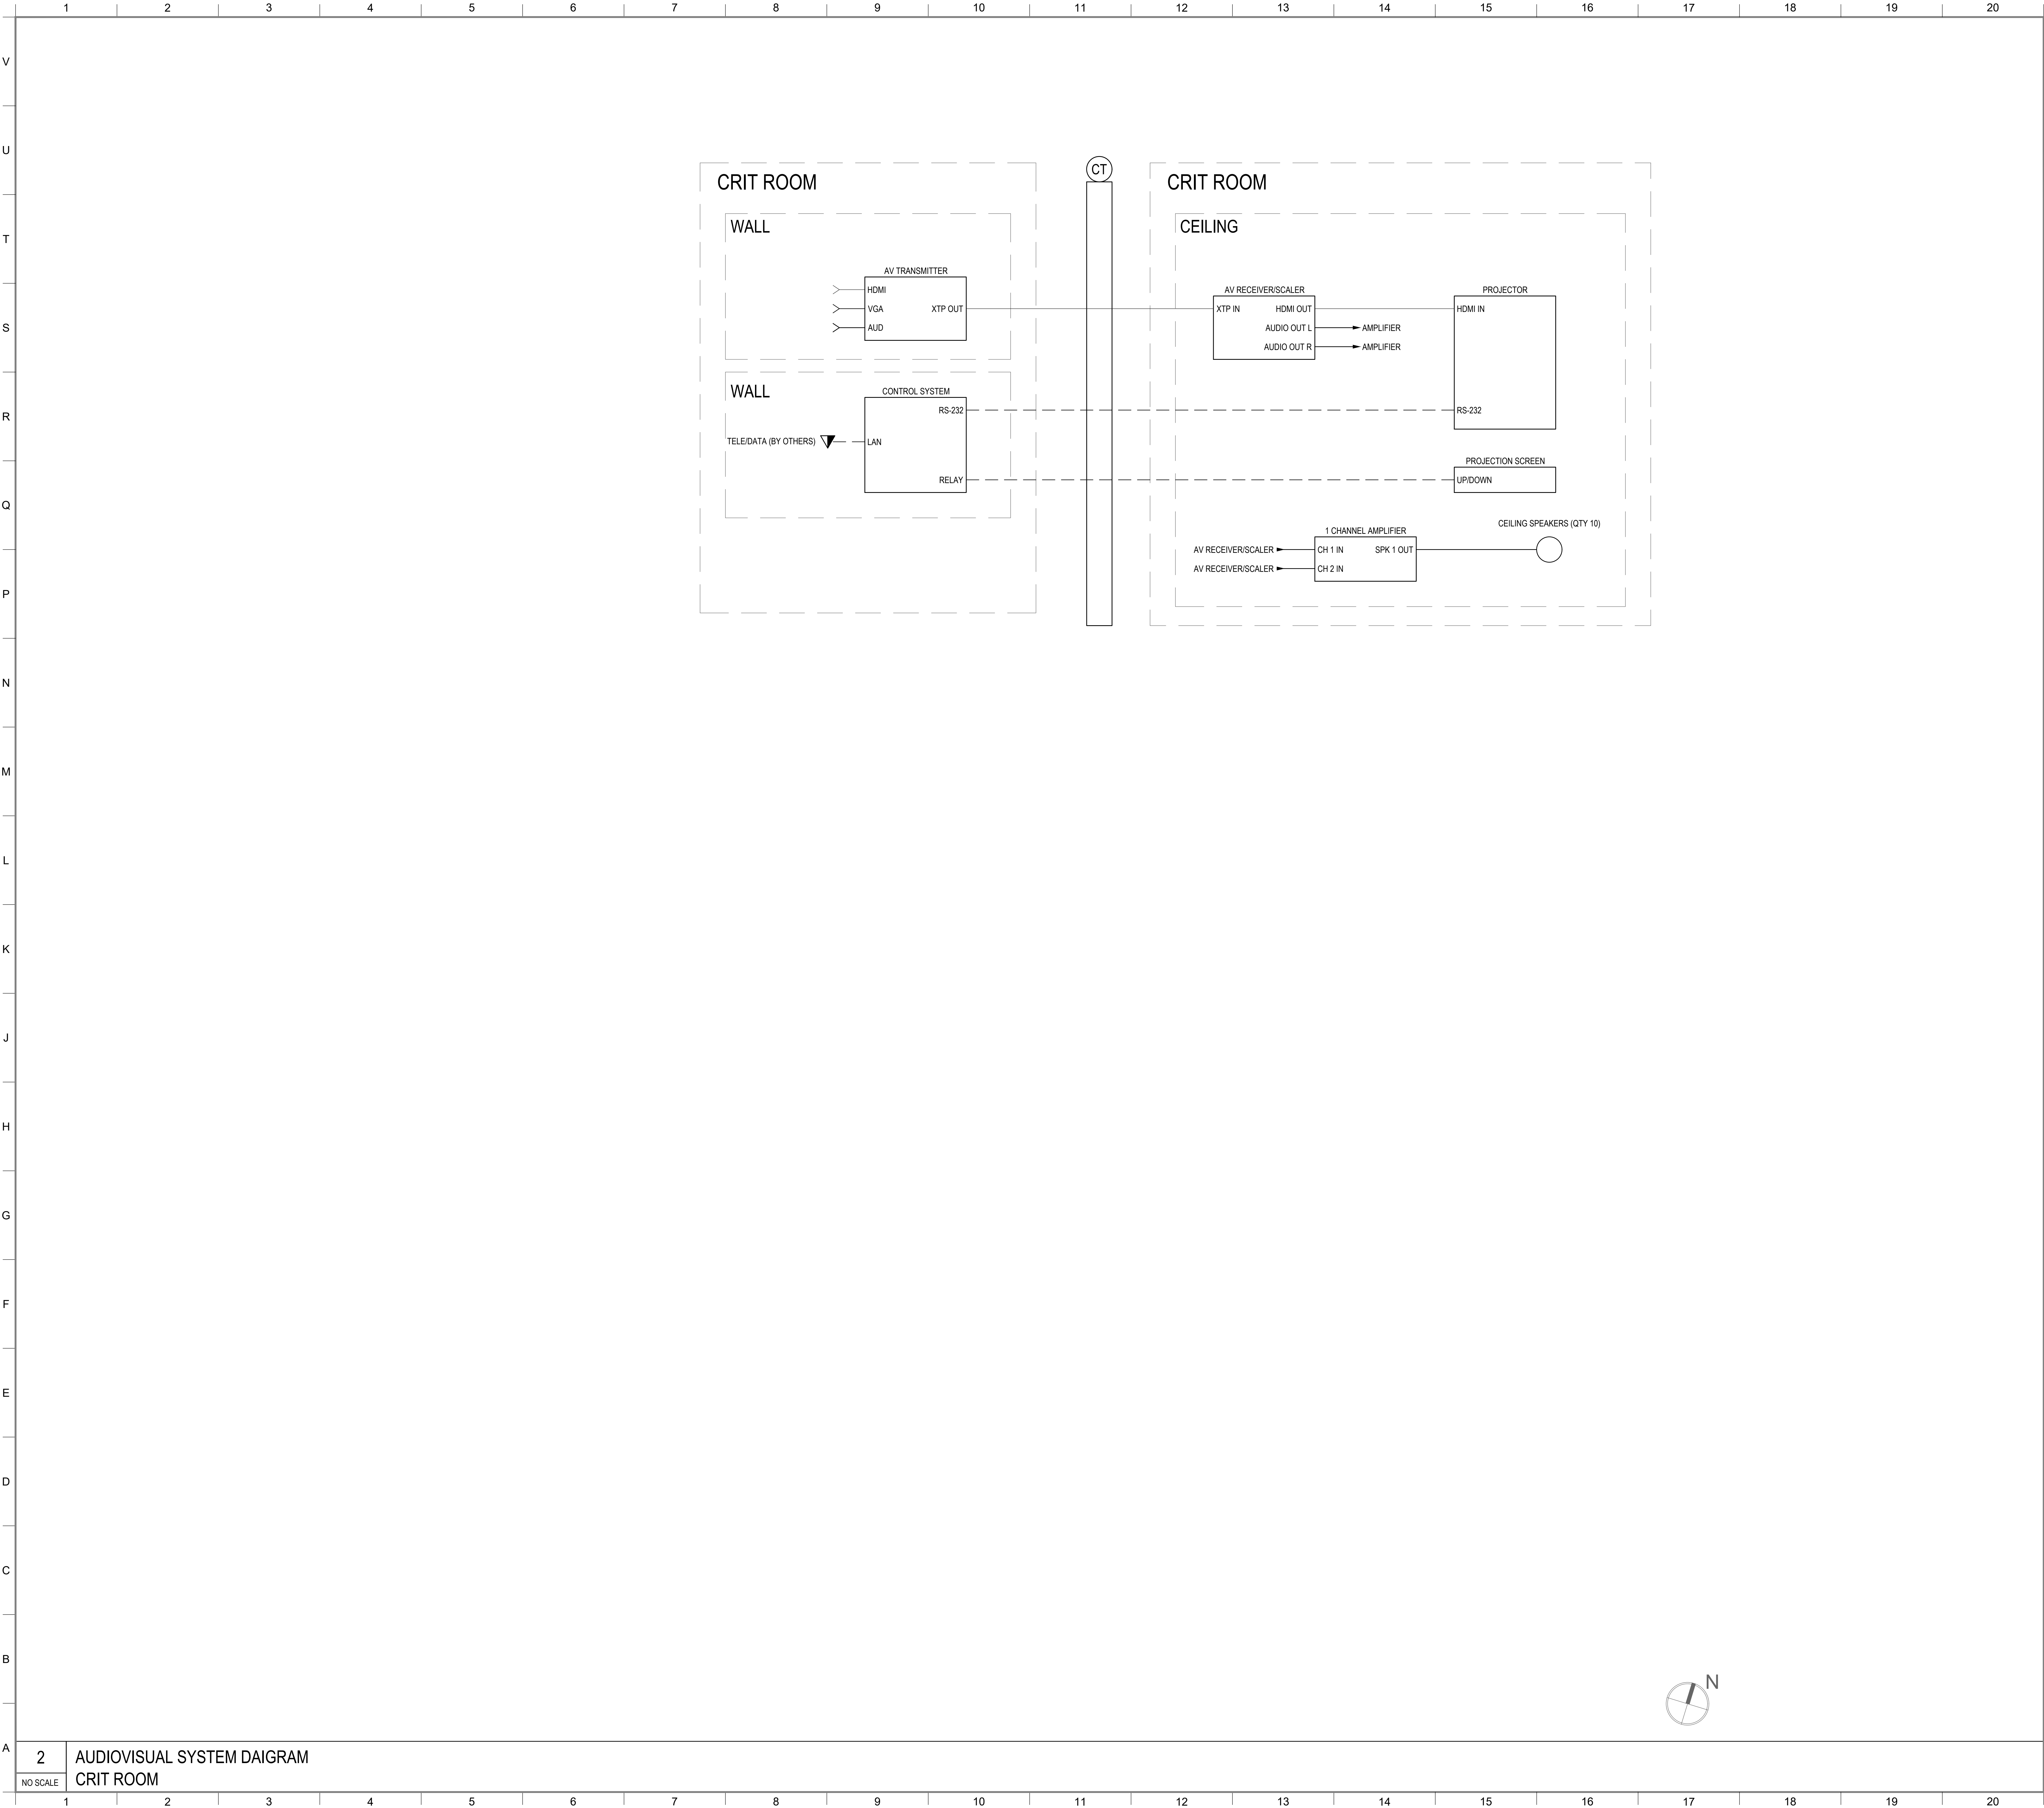

MATERIAL KEYING LEGEND:

KEY PLAN

5

5

GROUP III AV BID DOCUMENTS

09/06/17

1

PRELIMINARY FLOWS

12/02/16

NO.

REVISIONS | SUBMISSIONS

DATE

FXFOWLE

FXFOWLE ARCHITECTS, LLP | 22 WEST 10TH STREET | NEW YORK, NY 10011 | T 212.627.1700 | F 212.463.8716 | WWW.FXFOWLE.COM

STRUCTURAL ENGINEER

DESIMONE CONSULTING ENGINEERS

15 West 18th Street, 10th Floor, New York, New York 10011 | 212-632-3211

MECHANICAL, ELECTRICAL, PLUMBING, FIRE PROTECTION ENGINEER

COLLADO ENGINEERING

2 Holland Avenue, White Plains, NY 10603 | 914-332-7658

THEATER PLANNING CONSULTANT

FISHER DACHS ASSOCIATES

20 West 10th Street, 8th Floor, New York, NY 10011 | 212-691-3020

ACoustics & AUDIO / VISUAL CONSULTANT

CERAMI & ASSOCIATES

404 Fifth Avenue, New York, NY 10018 | 212-370-1776

LIGHTING CONSULTANT

ILLUMINATION ARTS

650 Bloomfield Avenue, Suite 101, Bloomfield NJ 07003 | 973-771-1556

LANDSCAPE CONSULTANT

W ARCHITECTURE & LANDSCAPE ARCHITECTURE, LLC

103 Fifth Avenue, Third Floor New York, NY 10010 | P 212-961-3533 | F 212-620-0758

CIVIL ENGINEER & HAZMAT

LANGAN

21 Penn Plaza 360 West 31st Street 8th Floor New York, NY 10001 212-478-5400 212-478-5444 (fax)

ELEVATOR CONSULTANT

VDA (VAN DEUSEN & ASSOCIATES)

Seven Penn Plaza, Suite 404 New York, NY 10001 Phone: 212-688-9090 Fax: 212-688-9099

IT CONSULTANT

GRID ASSOCIATES, LLC

P.O. Box 1703 Hoboken, NJ 07030 | T 948.722.9600 | F 948.722.9625

SUSTAINABILITY / LEED

YR&G

161 Bowery - 4th Floor, New York, NY 10002 T 917.677.8023 / F 917.677.8023

COST ESTIMATING CONSULTANT

TOSCANO CLEMENTS TAYLOR, LLC

16 Oakwood Road Huntington, NY 11743 | T 631.392.1400 / F 631.392.1399

C.I.T.L. PROJ. # 29402

SUNY PURCHASE COLLEGE

735 ANDERSON HILL ROAD | PURCHASE, NY 10577

DRAWING TITLE:

CRIT ROOM AV SYSTEMS BLOCK DIAGRAMS

Seal:

Drawn:

Project No.:

29402 (SUCF) / 09018.L00 (FXF)

Checked:

Cad File:

Reviewed:

Drawing No.:


Date:

Scale:

NOT TO SCALE

TA-08.02

© 2009 FXFOWLE ARCHITECTS, LLP | ALL RIGHTS RESERVED

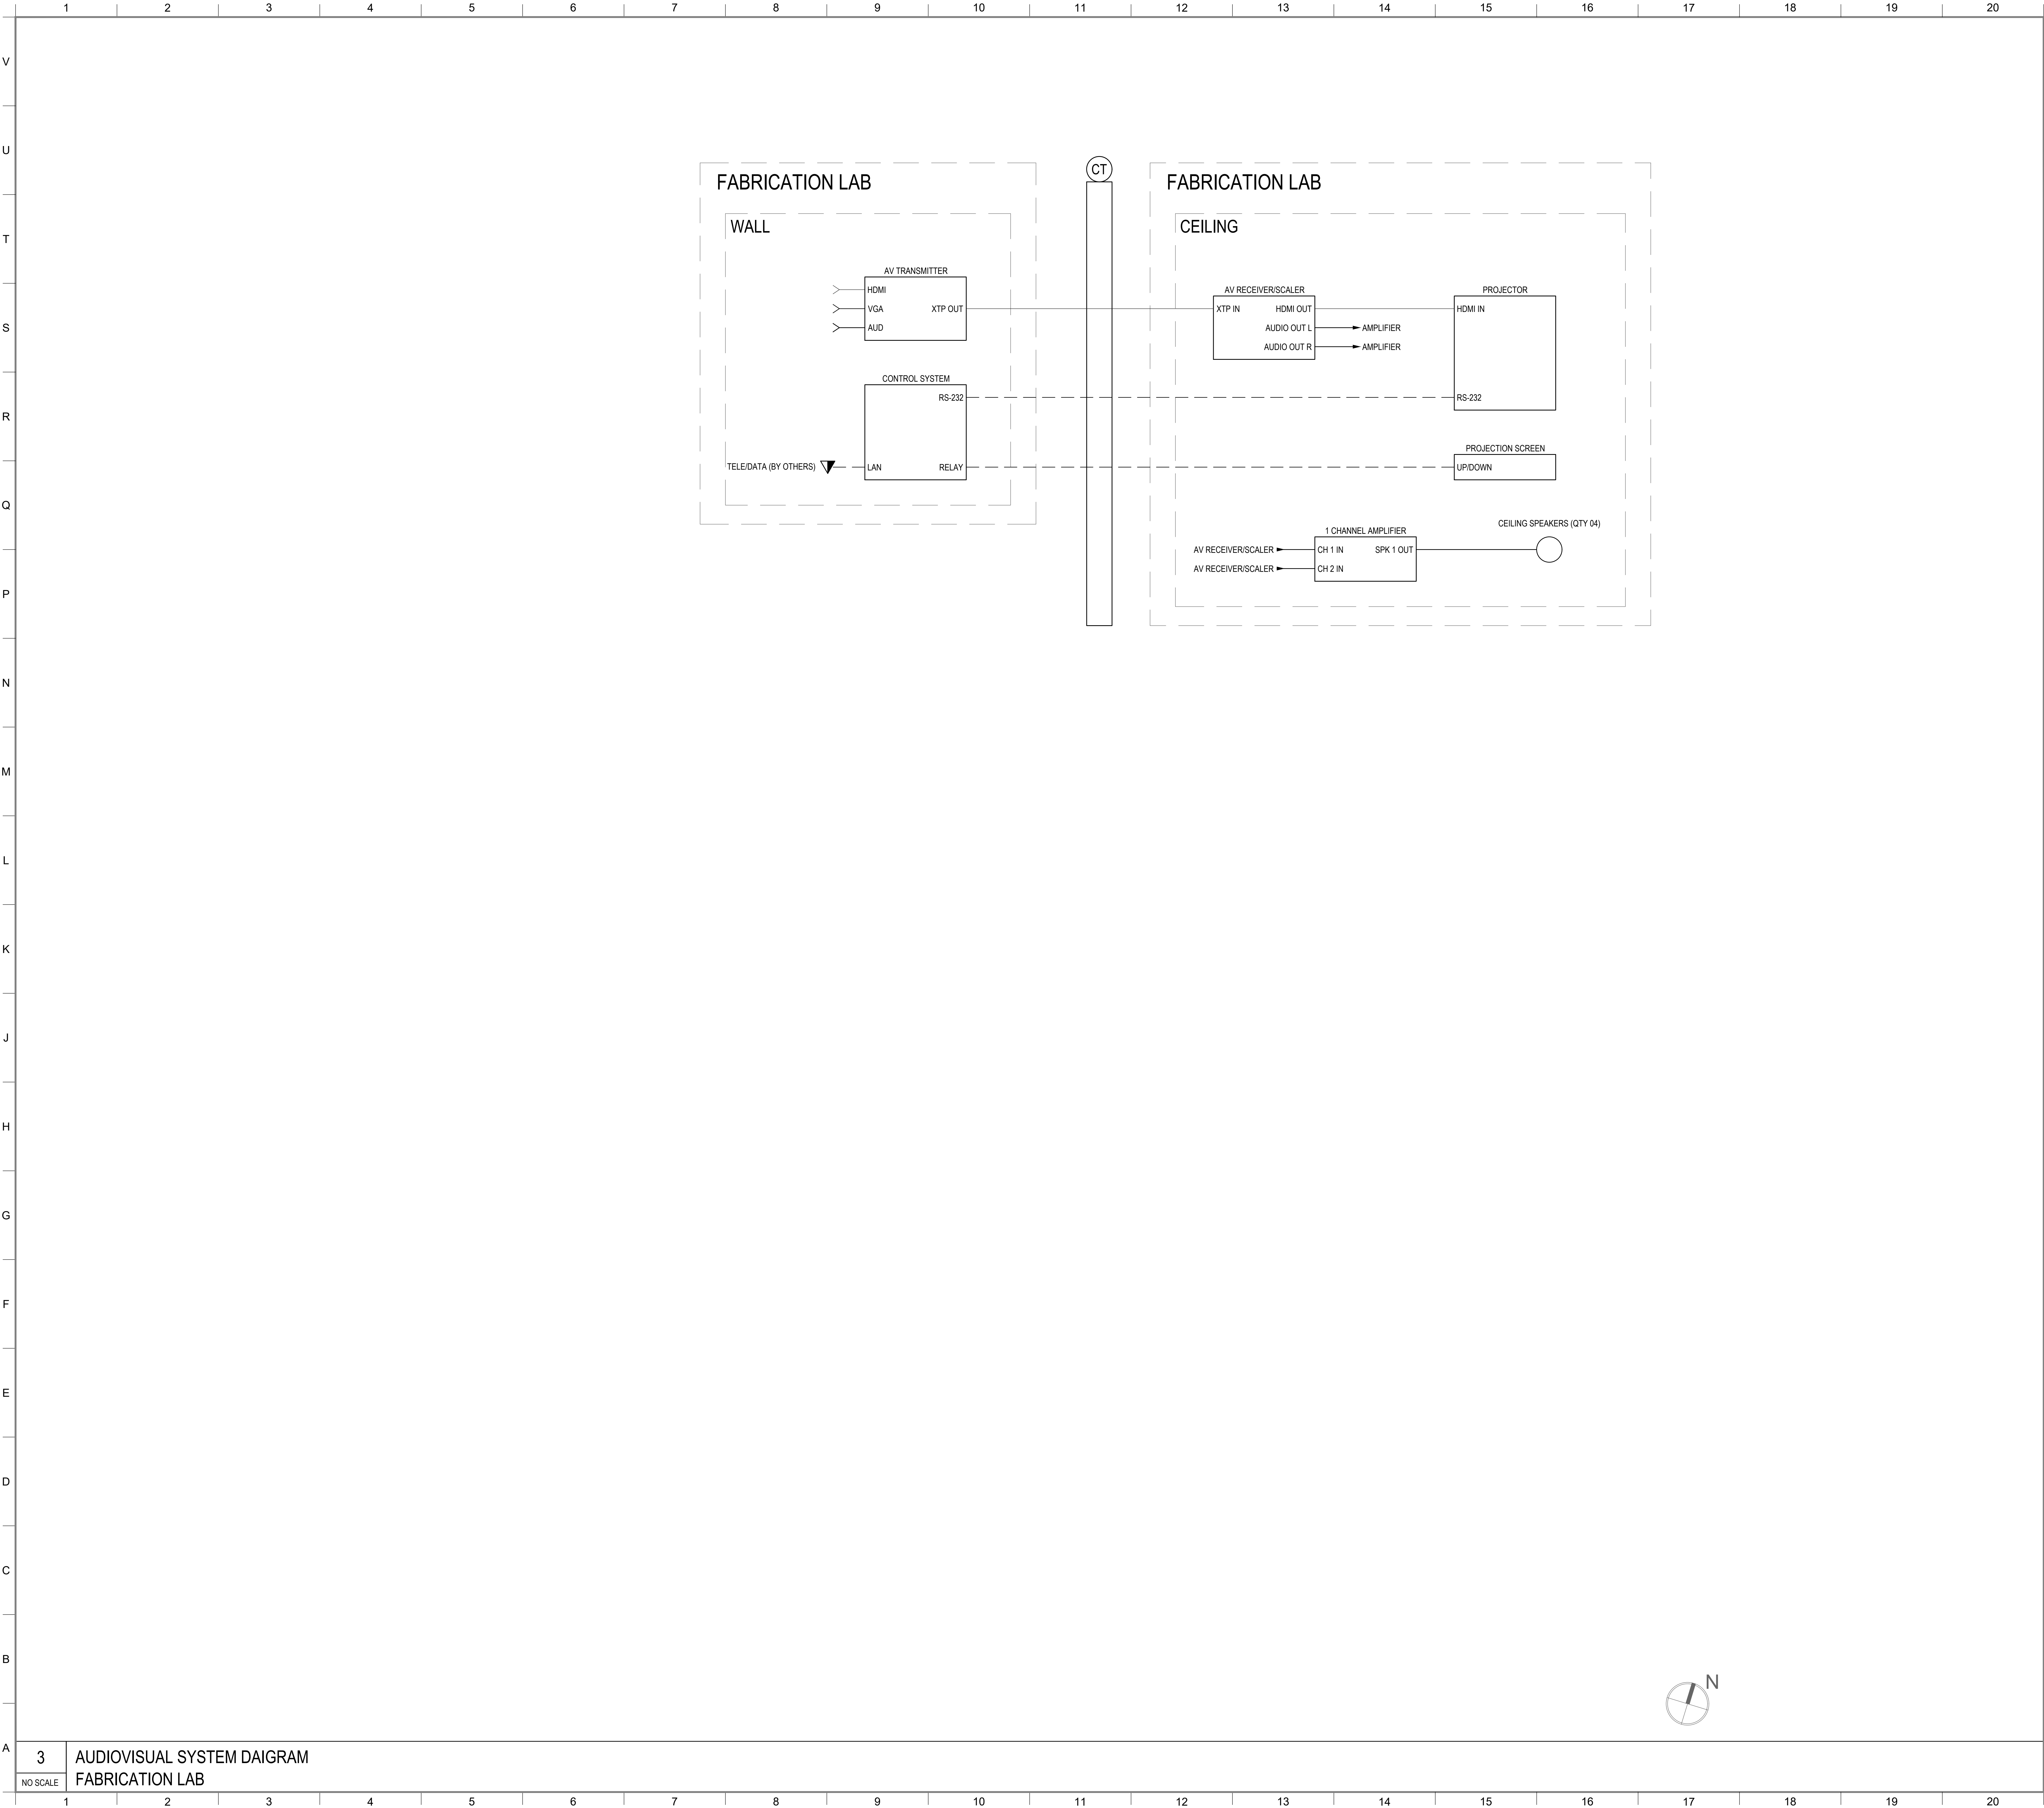

MATERIAL KEYING LEGEND:

KEY PLAN

5

5

GROUP III AV BID DOCUMENTS

09/06/17

1

PRELIMINARY FLOWS

12/02/16

NO.

REVISIONS | SUBMISSIONS

DATE

FXFOWLE

FXFOWLE ARCHITECTS, LLP | 22 WEST 10TH STREET | NEW YORK, NY 10011 | T 212.627.1700 | F 212.463.8716 | WWW.FXFOWLE.COM

STRUCTURAL ENGINEER

DESIMONE CONSULTING ENGINEERS

15 West 18th Street, 10th Floor, New York, New York 10011 | 212-632-9211

MECHANICAL, ELECTRICAL, PLUMBING, FIRE PROTECTION ENGINEER

COLLADO ENGINEERING

2 Holland Avenue, White Plains, NY 10603 | 914-332-7658

THEATER PLANNING CONSULTANT

FISHER DACHS ASSOCIATES

20 West 10th Street, 8th Floor, New York, NY 10011 | 212-691-3020

ACoustics & AUDIO / VISUAL CONSULTANT

CERAMI & ASSOCIATES

404 Fifth Avenue, New York, NY 10018 | 212-370-1776

LIGHTING CONSULTANT

ILLUMINATION ARTS

650 Bloomfield Avenue, Suite 101, Bloomfield NJ 07003 | 973-771-1556

LANDSCAPE CONSULTANT

W ARCHITECTURE & LANDSCAPE ARCHITECTURE, LLC

103 Fifth Avenue, Third Floor New York, NY 10010 | P 212-961-3633 | F 212-620-0758

CIVIL ENGINEER & HAZMAT

LANGAN

21 Penn Plaza 360 West 31st Street 8th Floor New York, NY 10001 212-478-5400 212-478-5444 (fax)

ELEVATOR CONSULTANT

VDA (VAN DEUSEN & ASSOCIATES)

Seven Penn Plaza, Suite 404 New York, NY 10001 Phone: 212-668-9090 Fax: 212-668-9099

IT CONSULTANT

GRID ASSOCIATES, LLC

P.O. Box 1705 Hoboken, NJ 07030 | T 946.722.9600 | F 946.722.9625

SUSTAINABILITY / LEED

YR&G

161 Bowery - 4th Floor, New York, NY 10002 T 917.677.8023 / F 917.677.8023

COST ESTIMATING CONSULTANT

TOSCANO CLEMENTS TAYLOR, LLC

16 Oakwood Road Huntington, NY 11743 | T 631.392.1400 / F 631.392.1399

C.I.T.L. PROJ. # 29402

SUNY PURCHASE COLLEGE

735 ANDERSON HILL ROAD | PURCHASE, NY 10577

DRAWING TITLE:

FABRICATION LAB AV SYSTEMS BLOCK DIAGRAMS

Seal:

Drawn:

Project No.:

Checked:

29402 (SUCF) / 09018.L00 (FXF)

Cad File:

Reviewed:

Drawing No.:


Date:

Scale:

NOT TO SCALE

TA-08.03

© 2009 FXFOWLE ARCHITECTS, LLP | ALL RIGHTS RESERVED

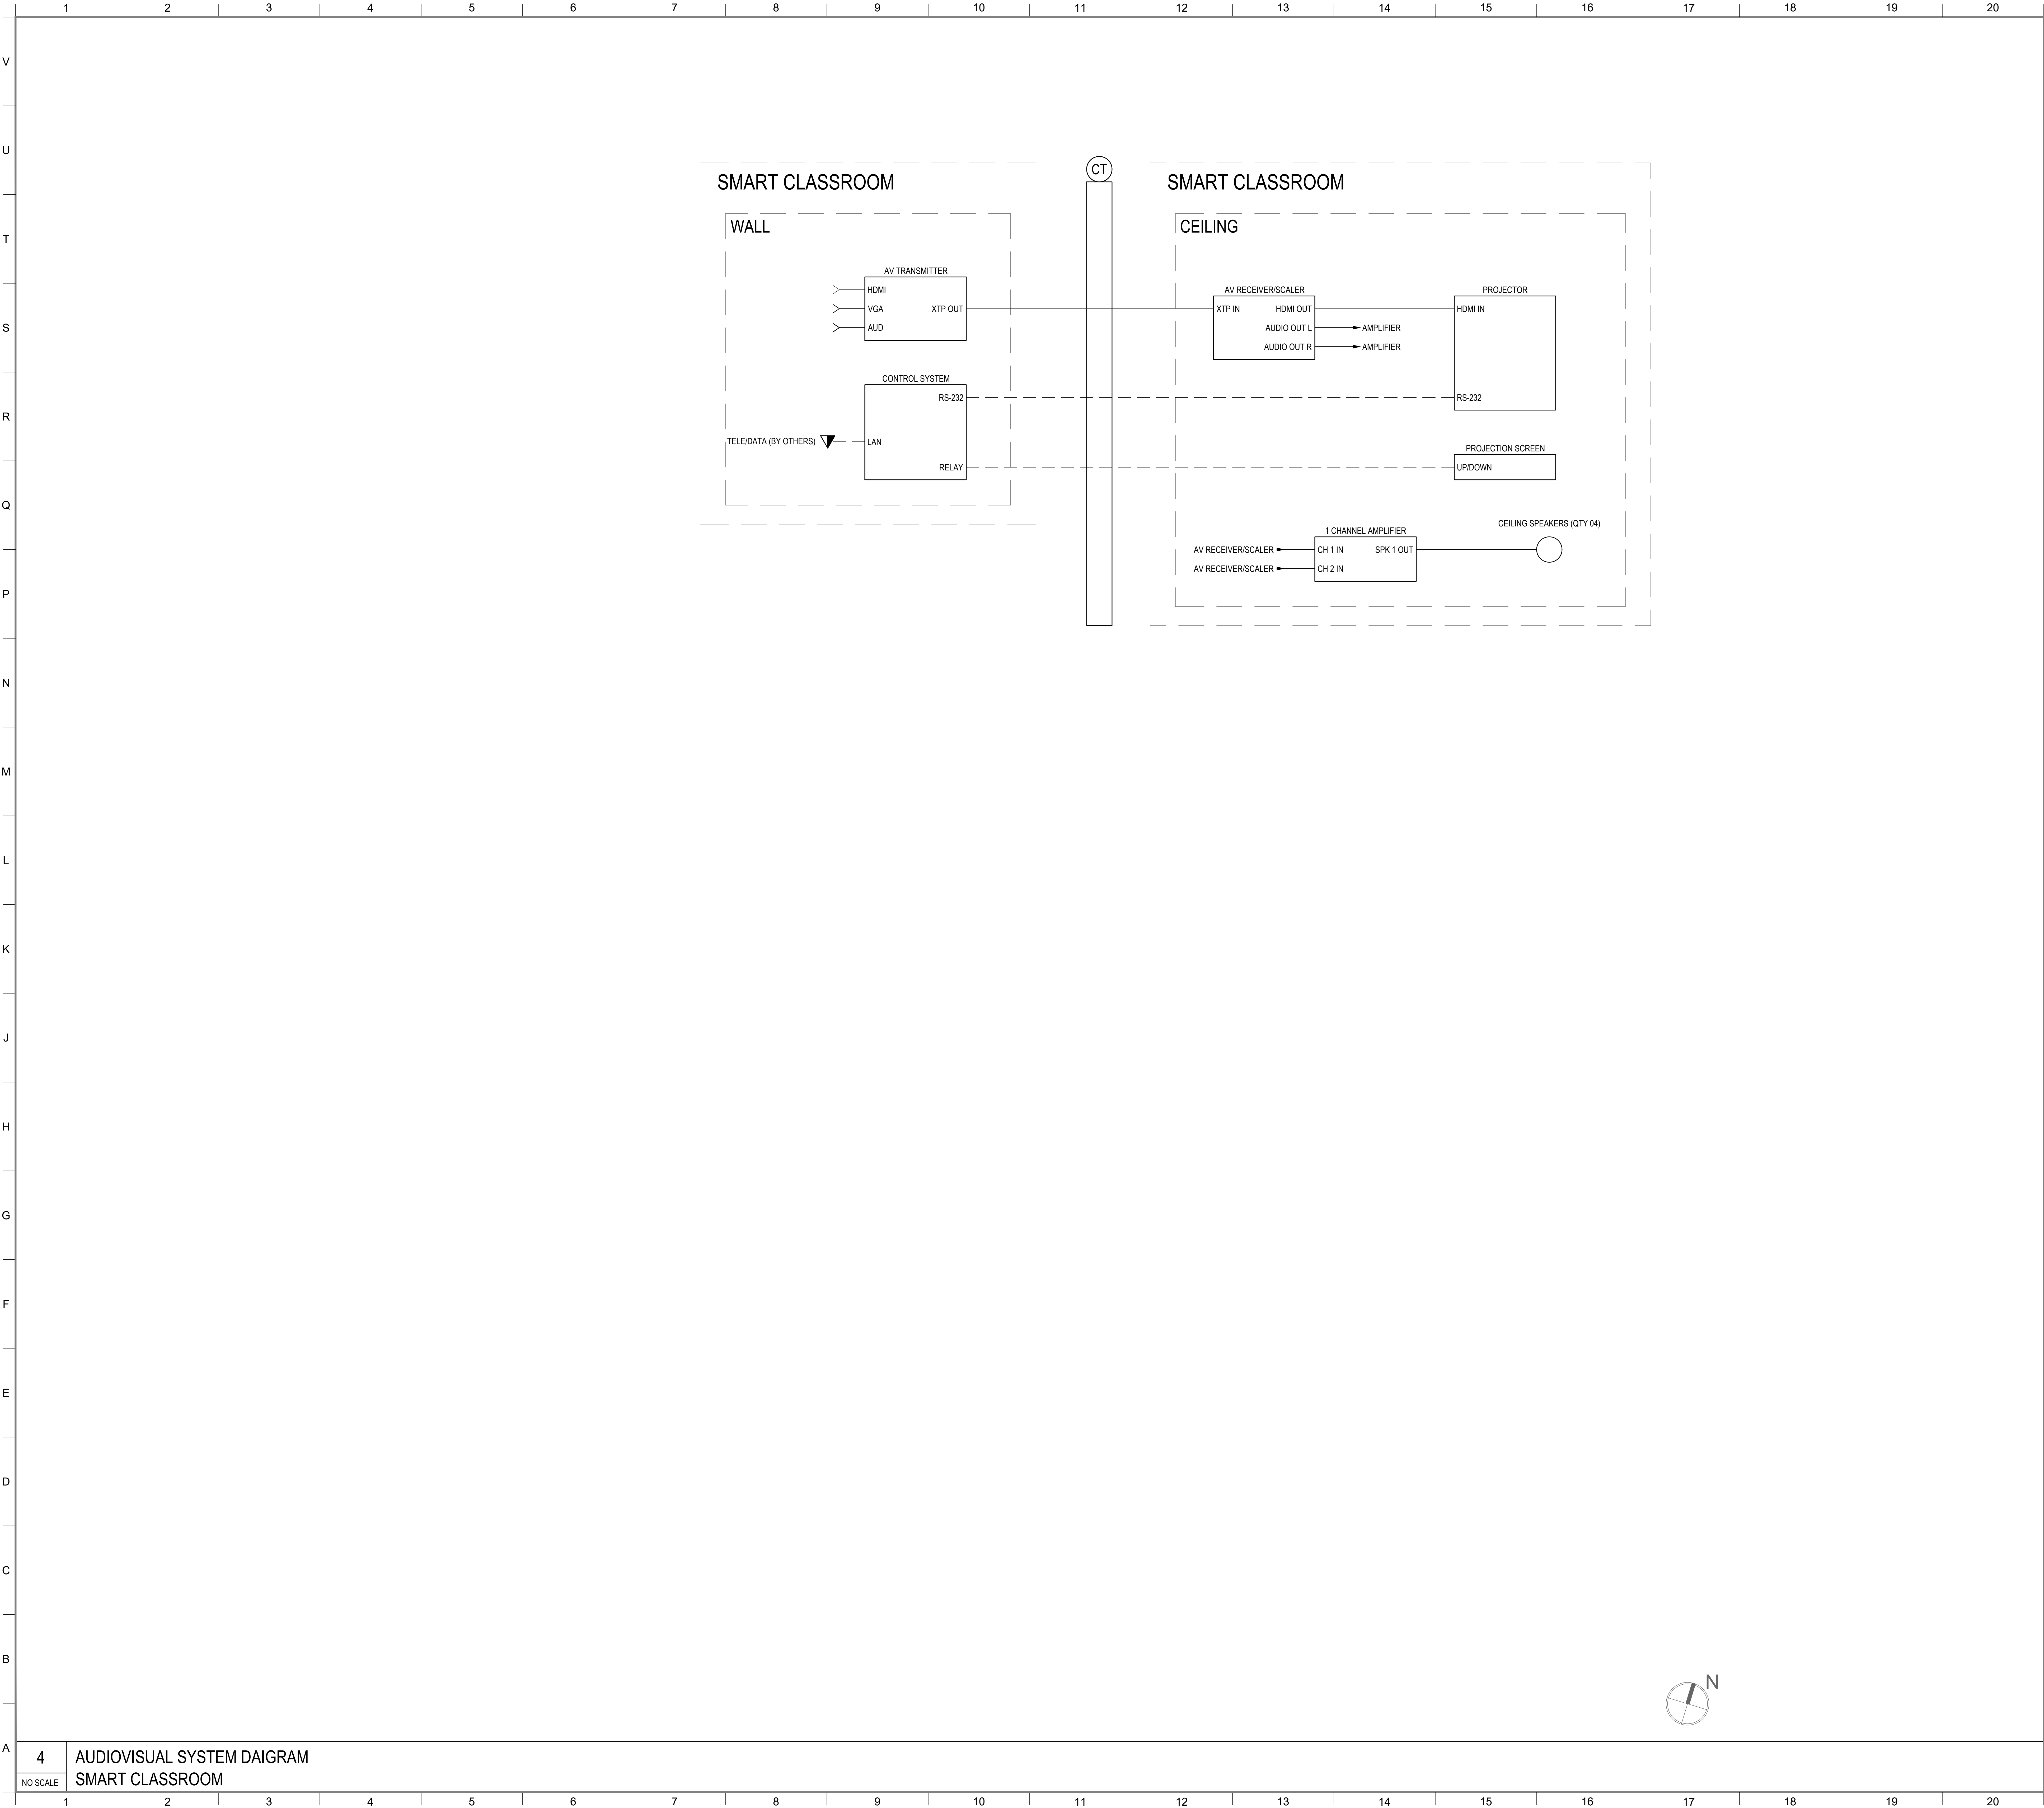

MATERIAL KEYING LEGEND:

KEY PLAN

5

5

GROUP III AV BID DOCUMENTS

09/06/17

1

PRELIMINARY FLOWS

12/02/16

NO.

REVISIONS / SUBMISSIONS

DATE

FX FOWLE

FX FOWLE ARCHITECTS, LLP | 22 WEST 10TH STREET | NEW YORK, NY 10011 | T 212.427.1700 | F 212.453.8716 | WWW.FX FOWLE.COM

STRUCTURAL ENGINEER

DESIMONE CONSULTING ENGINEERS

15 West 18th Street, 10th Floor, New York, New York 10011 | 212-632-3211

MECHANICAL, ELECTRICAL, PLUMBING, FIRE PROTECTION ENGINEER

COLLADO ENGINEERING

2 Holland Avenue, White Plains, NY 10603 | 914-332-7658

THEATER PLANNING CONSULTANT

FISHER DACHS ASSOCIATES

20 West 10th Street, 8th Floor, New York, NY 10011 | 212-691-3020

ACoustics & AUDIO / VISUAL CONSULTANT

CERAMI & ASSOCIATES

404 Fifth Avenue, New York, NY 10018 | 212-370-1776

LIGHTING CONSULTANT

ILLUMINATION ARTS

650 Bloomfield Avenue, Suite 101, Bloomfield NJ 07003 | 973-771-1556

LANDSCAPE CONSULTANT

W ARCHITECTURE & LANDSCAPE ARCHITECTURE, LLC

103 Fifth Avenue, Third Floor New York, NY 10010 | P 212-661-3533 | F 212-620-0758

CIVIL ENGINEER & HAZMAT

LANGAN

21 Penn Plaza 360 West 31st Street 8th Floor New York, NY 10001 | 212-478-5400 | 212-478-5444 (fax)

ELEVATOR CONSULTANT

VDA (VAN DEUSEN & ASSOCIATES)

Seven Penn Plaza, Suite 404 New York, NY 10001 | Phone: 212-688-9090 | Fax: 212-688-9099

IT CONSULTANT

GRID ASSOCIATES, LLC

P.O. Box 1705 Hoboken, NJ 07030 | T 948.722.9600 | F 948.722.9625

SUSTAINABILITY / LEED

YR&G

161 Bowery - 4th Floor, New York, NY 10002 | T 917.677.8023 | F 917.677.8023

COST ESTIMATING CONSULTANT

TOSCANO CLEMENTS TAYLOR, LLC

16 Oakwood Road Huntington, NY 11743 | T 631.392.1400 | F 631.392.1399

C.I.T.L. PROJ. # 29402

SUNY PURCHASE COLLEGE

735 ANDERSON HILL ROAD | PURCHASE, NY 10577

DRAWING TITLE:

SMART CLASSROOM AV SYSTEMS BLOCK DIAGRAMS

Seal:

Drawn:

Project No.:

Checked:

29402 (SUCF) / 09018.L00 (FXF)

Cost File:

Reviewed:

Drawing No.:


Date:

Scale:

NOT TO SCALE

TA-08.04

© 2009 FX FOWLE ARCHITECTS, LLP | ALL RIGHTS RESERVED

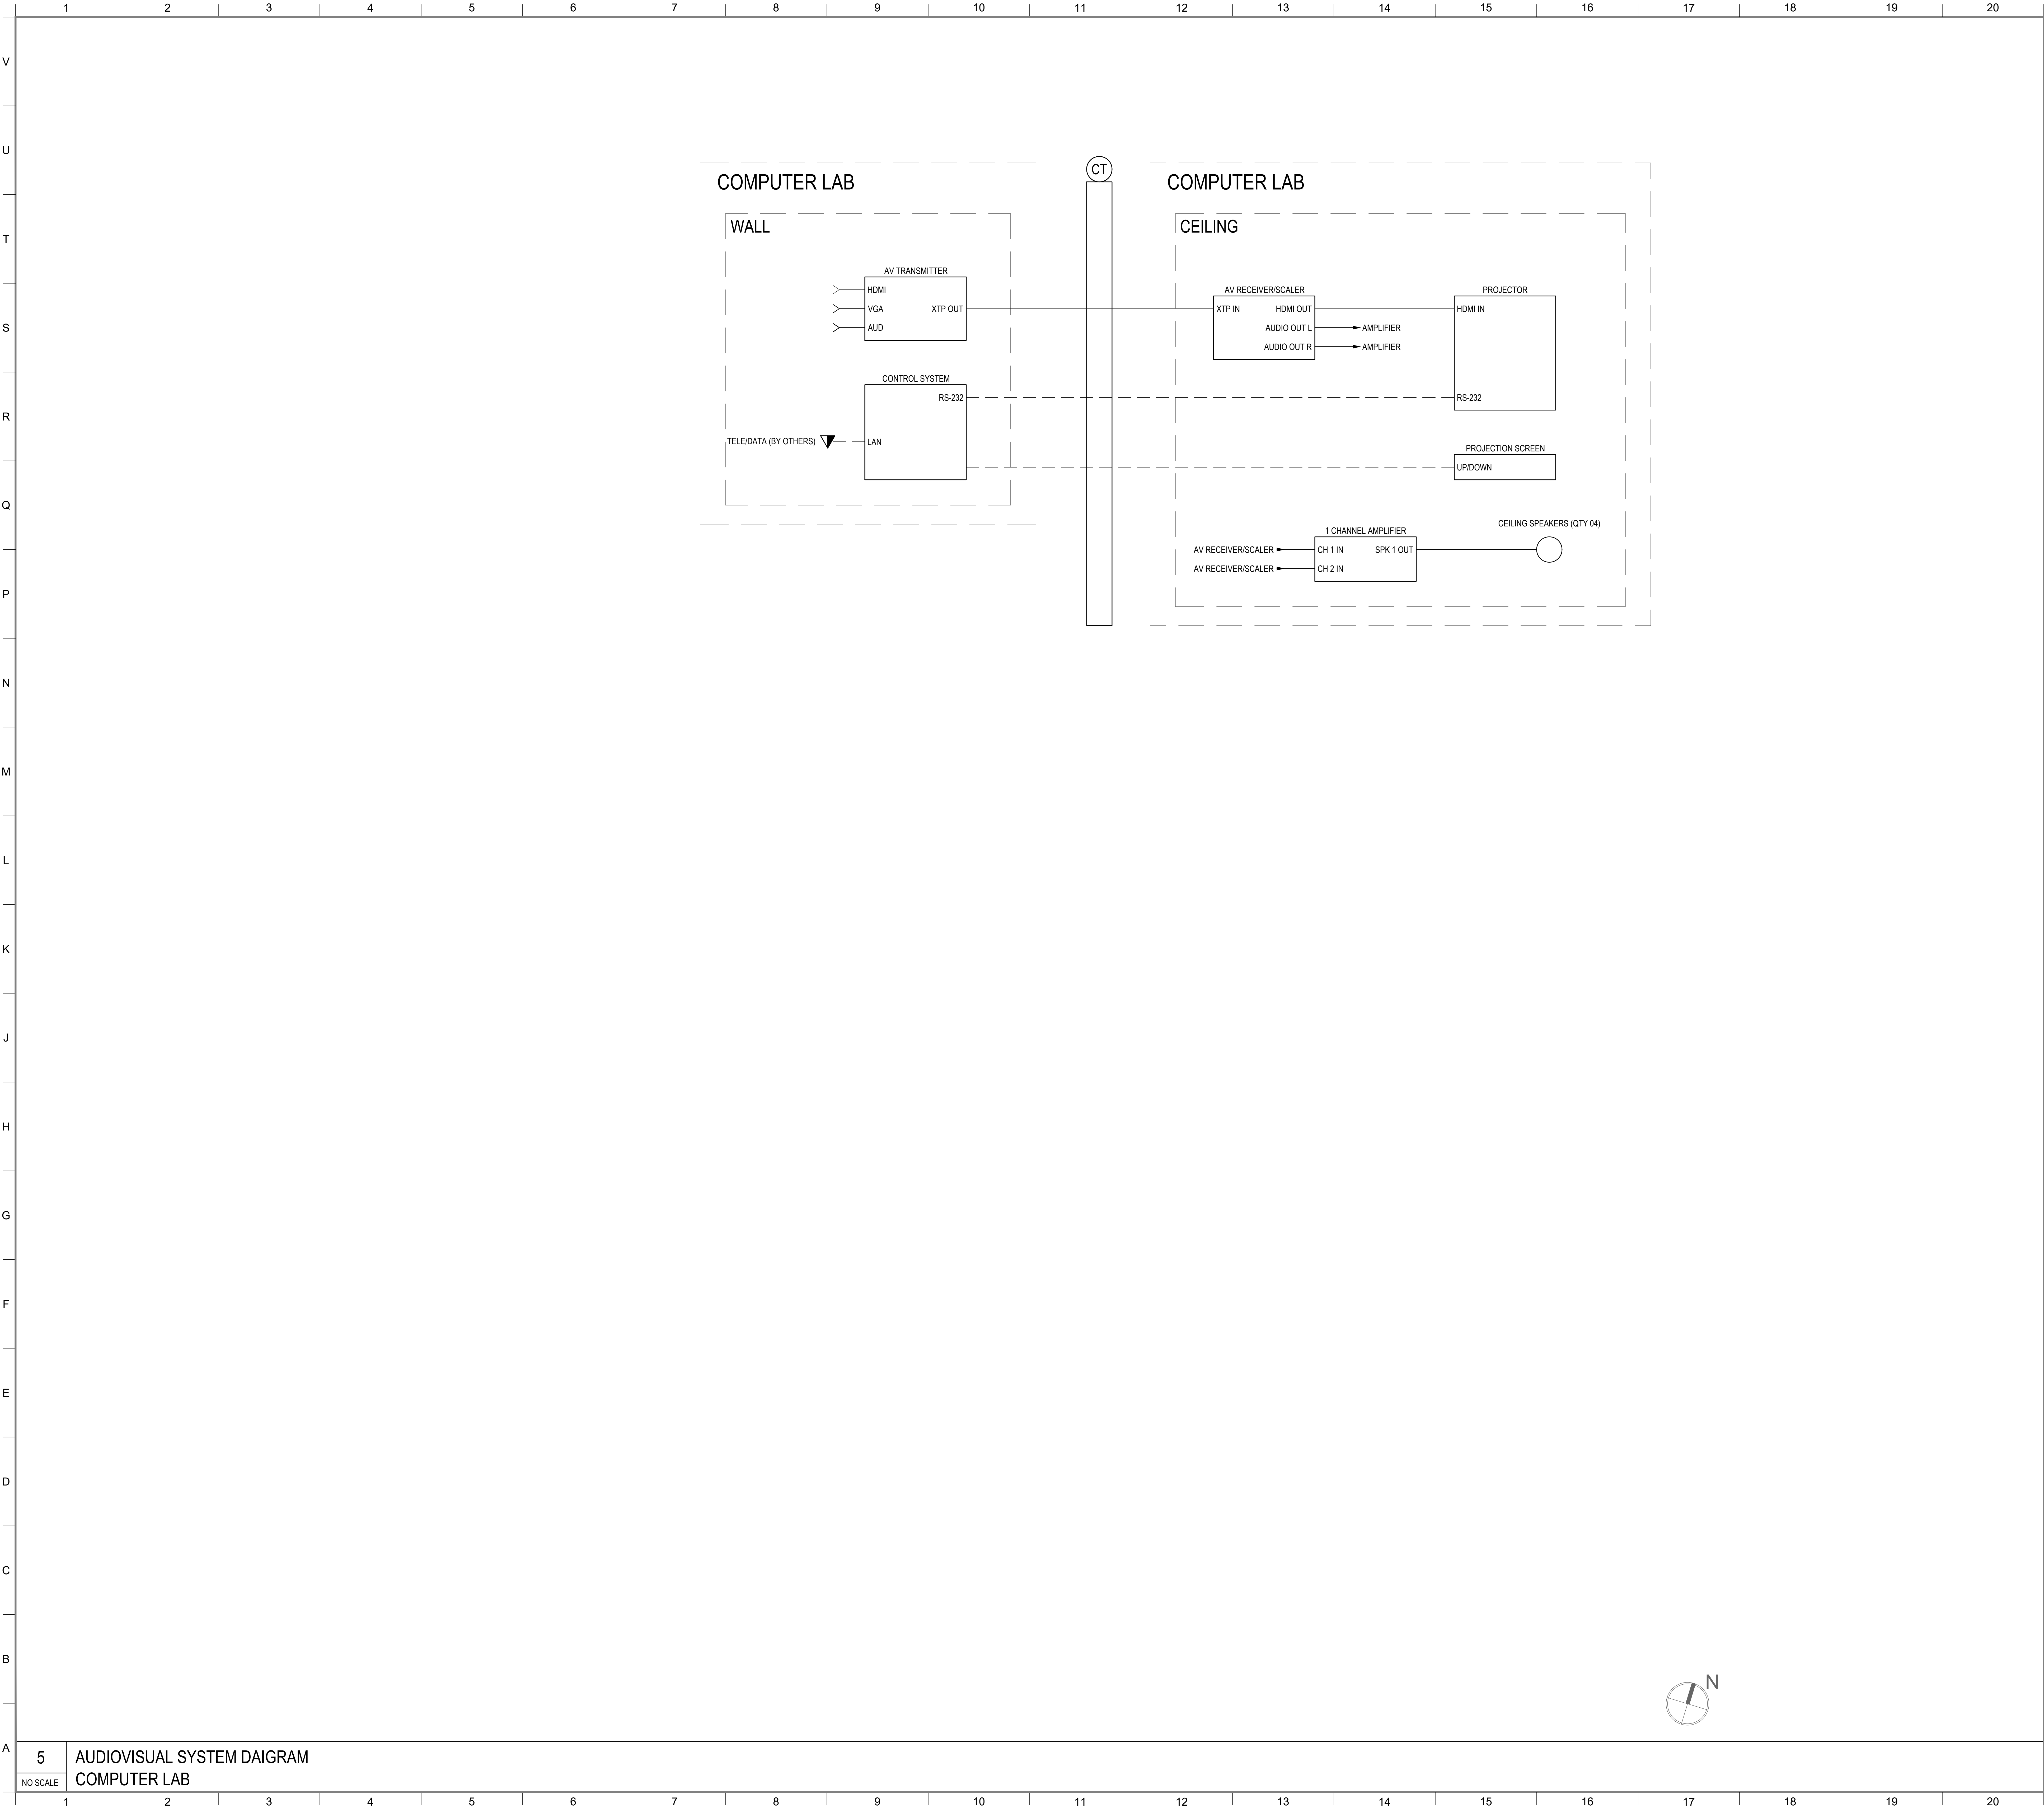

MATERIAL KEYING LEGEND:

N

KEY PLAN

5

5

GROUP III AV BID DOCUMENTS

09/06/17

1

PRELIMINARY FLOWS

12/02/16

NO.	REVISIONS / SUBMISSIONS	DATE
-----	-------------------------	------

FX FOWLE

FXFOWLE ARCHITECTS, LLP 122 WEST 10TH STREET | NEW YORK, NY 10011 | T 212.627.1700 | F 212.463.8716 | WWW.FX FOWLE.COM

STRUCTURAL ENGINEER

DESIMONE CONSULTING ENGINEERS

15 West 18th Street, 10th Floor, New York, New York 10011 212-632-9211

MECHANICAL, ELECTRICAL, PLUMBING, FIRE PROTECTION ENGINEER

COLLADO ENGINEERING

2 Holland Avenue, White Plains, NY 10603 914-332-7658

THEATER PLANNING CONSULTANT

FISHER DACHS ASSOCIATES

20 West 10th Street, 8th Floor, New York, NY 10011 212-691-3020

ACoustics & AUDIO / VISUAL CONSULTANT

CERAMI & ASSOCIATES

404 Fifth Avenue, New York, NY 10018 212-370-1776

LIGHTING CONSULTANT

ILLUMINATION ARTS

650 Bloomfield Avenue, Suite 101, Bloomfield NJ 07003 973-771-1556

LANDSCAPE CONSULTANT

W ARCHITECTURE & LANDSCAPE ARCHITECTURE, LLC

103 Fifth Avenue Third Floor New York, NY 10010 P 212-661-3633 F 212-620-0758

CIVIL ENGINEER & HAZMAT

LANGAN

21 Penn Plaza 360 West 31st Street 8th Floor New York, NY 10001 212-478-5400 212-478-5444 (fax)

ELEVATOR CONSULTANT

VDA (VAN DEUSEN & ASSOCIATES)

Seven Penn Plaza, Suite 404 New York, NY 10001 Phone 212-668-9090 Fax: 212-668-9099

IT CONSULTANT

GRID ASSOCIATES, LLC

P.O. Box 1700 Hoboken, NJ 07030 T 946.722.6600 / F 946.722.6625

SUSTAINABILITY / LEED

YR&G

161 Bowery - 4th Floor, New York, NY 10002 T 917.677.8023 / F 917.677.8023

COST ESTIMATING CONSULTANT

TOSCANO CLEMENTS TAYLOR, LLC

16 Oakwood Road Huntington, NY 11743 T 631.392.1400 / F 631.392.1399

C.I.T.L. PROJ. # 29402

SUNY PURCHASE COLLEGE

735 ANDERSON HILL ROAD | PURCHASE, NY 10577


DRAWING TITLE:

COMPUTER LAB AV SYSTEMS BLOCK DIAGRAMS

Seal:	Drawn:	Project No.:
		29402 (SUCF) / 09018.L00 (FXF)
	Checked:	Cad File:
	Reviewed:	Drawing No.:
	Date:	
	Scale:	
	NOT TO SCALE	

TA-08.05

© 2009 FXFOWLE ARCHITECTS, LLP | ALL RIGHTS RESERVED

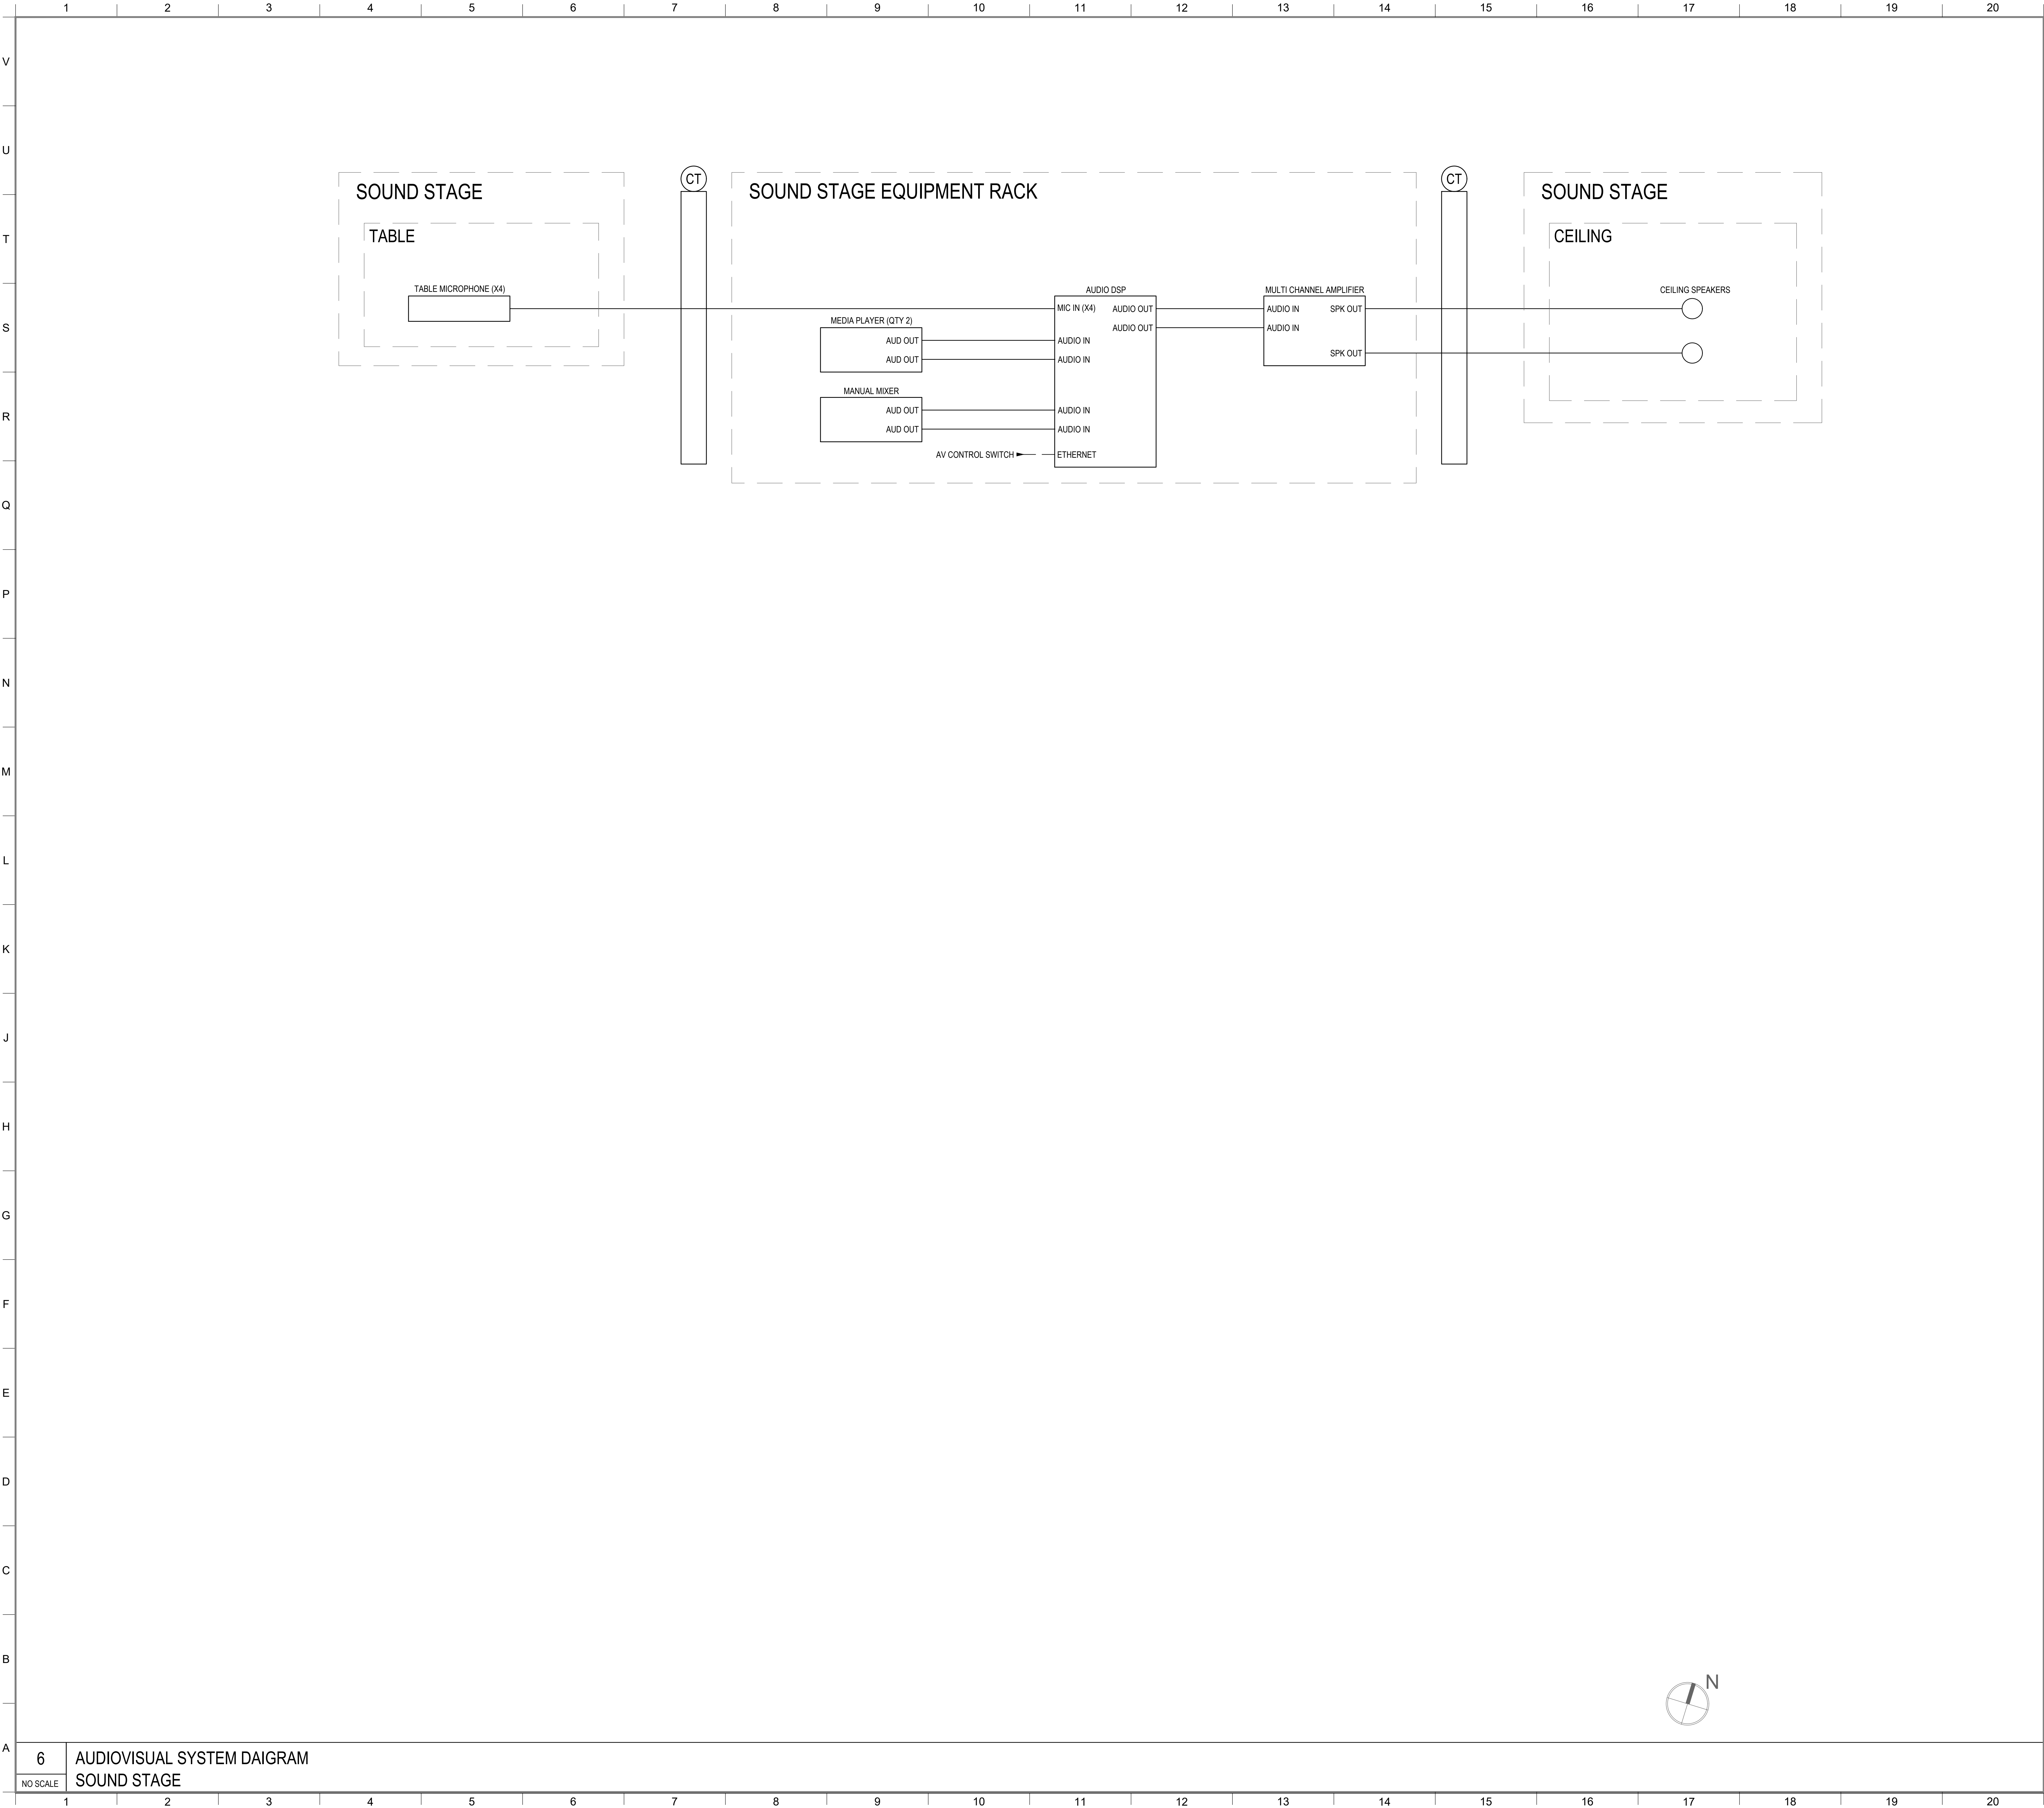

MATERIAL KEYING LEGEND:

5

5

GROUP III AV BID DOCUMENTS

09/06/17

1

PRELIMINARY FLOWS

12/02/16

NO.

REVISIONS | SUBMISSIONS

DATE

FX FOWLE

FX FOWLE ARCHITECTS, LLP 122 WEST 10TH STREET | NEW YORK, NY 10011 | T 212.627.1700 | F 212.463.8716 | WWW.FX FOWLE.COM

STRUCTURAL ENGINEER

DESIMONE CONSULTING ENGINEERS

15 West 18th Street, 10th Floor, New York, New York 10011 | 212-632-9211

MECHANICAL, ELECTRICAL, PLUMBING, FIRE PROTECTION ENGINEER

COLLADO ENGINEERING

2 Holland Avenue, White Plains, NY 10603 | 914-332-7658

THEATER PLANNING CONSULTANT

FISHER DACHS ASSOCIATES

20 West 10th Street, 8th Floor, New York, NY 10011 | 212-691-3020

ACoustics & AUDIO / VISUAL CONSULTANT

CERAMI & ASSOCIATES

404 Fifth Avenue, New York, NY 10018 | 212-370-1776

LIGHTING CONSULTANT

ILLUMINATION ARTS

650 Bloomfield Avenue, Suite 101, Bloomfield NJ 07003 | 973-771-1556

LANDSCAPE CONSULTANT

W ARCHITECTURE & LANDSCAPE ARCHITECTURE, LLC

103 Fifth Avenue Third Floor New York, NY 10010 | P 212-961-3633 | F 212-620-0198

CIVIL ENGINEER & HAZMAT

LANGAN

21 Penn Plaza 360 West 31st Street 8th Floor New York, NY 10001 212-478-5400 212-478-5444 (fax)

ELEVATOR CONSULTANT

VDA (VAN DEUSEN & ASSOCIATES)

Seven Penn Plaza, Suite 404 New York, NY 10001 Phone 212-468-9090 Fax: 212-468-9099

IT CONSULTANT

GRID ASSOCIATES, LLC

P.O. Box 1705 Hoboken, NJ 07030 | T 948.722.9600 | F 948.722.9625

SUSTAINABILITY / LEED

YR&G

161 Bowery - 4th Floor, New York, NY 10002 T 917.677.8023 / F 917.677.8023

COST ESTIMATING CONSULTANT

TOSCANO CLEMENTS TAYLOR, LLC

16 Oakwood Road Huntington, NY 11743 | T 631.392.1400 / F 631.392.1399

C.I.T.L. PROJ. # 29402

SUNY PURCHASE COLLEGE

735 ANDERSON HILL ROAD | PURCHASE, NY 10577

DRAWING TITLE:

SOUND STAGE AV SYSTEMS BLOCK DIAGRAMS

Seal:

Drawn:

Project No.:

Checked:

29402 (SUCF) / 09018.L00 (FXF)

Cad File:

Reviewed:

Drawing No.:

Date:

Scale:

NOT TO SCALE

TA-08.06


© 2009 FXFOWLE ARCHITECTS, LLP | ALL RIGHTS RESERVED

6

AUDIOVISUAL SYSTEM DAIGRAM

NO SCALE

SOUND STAGE

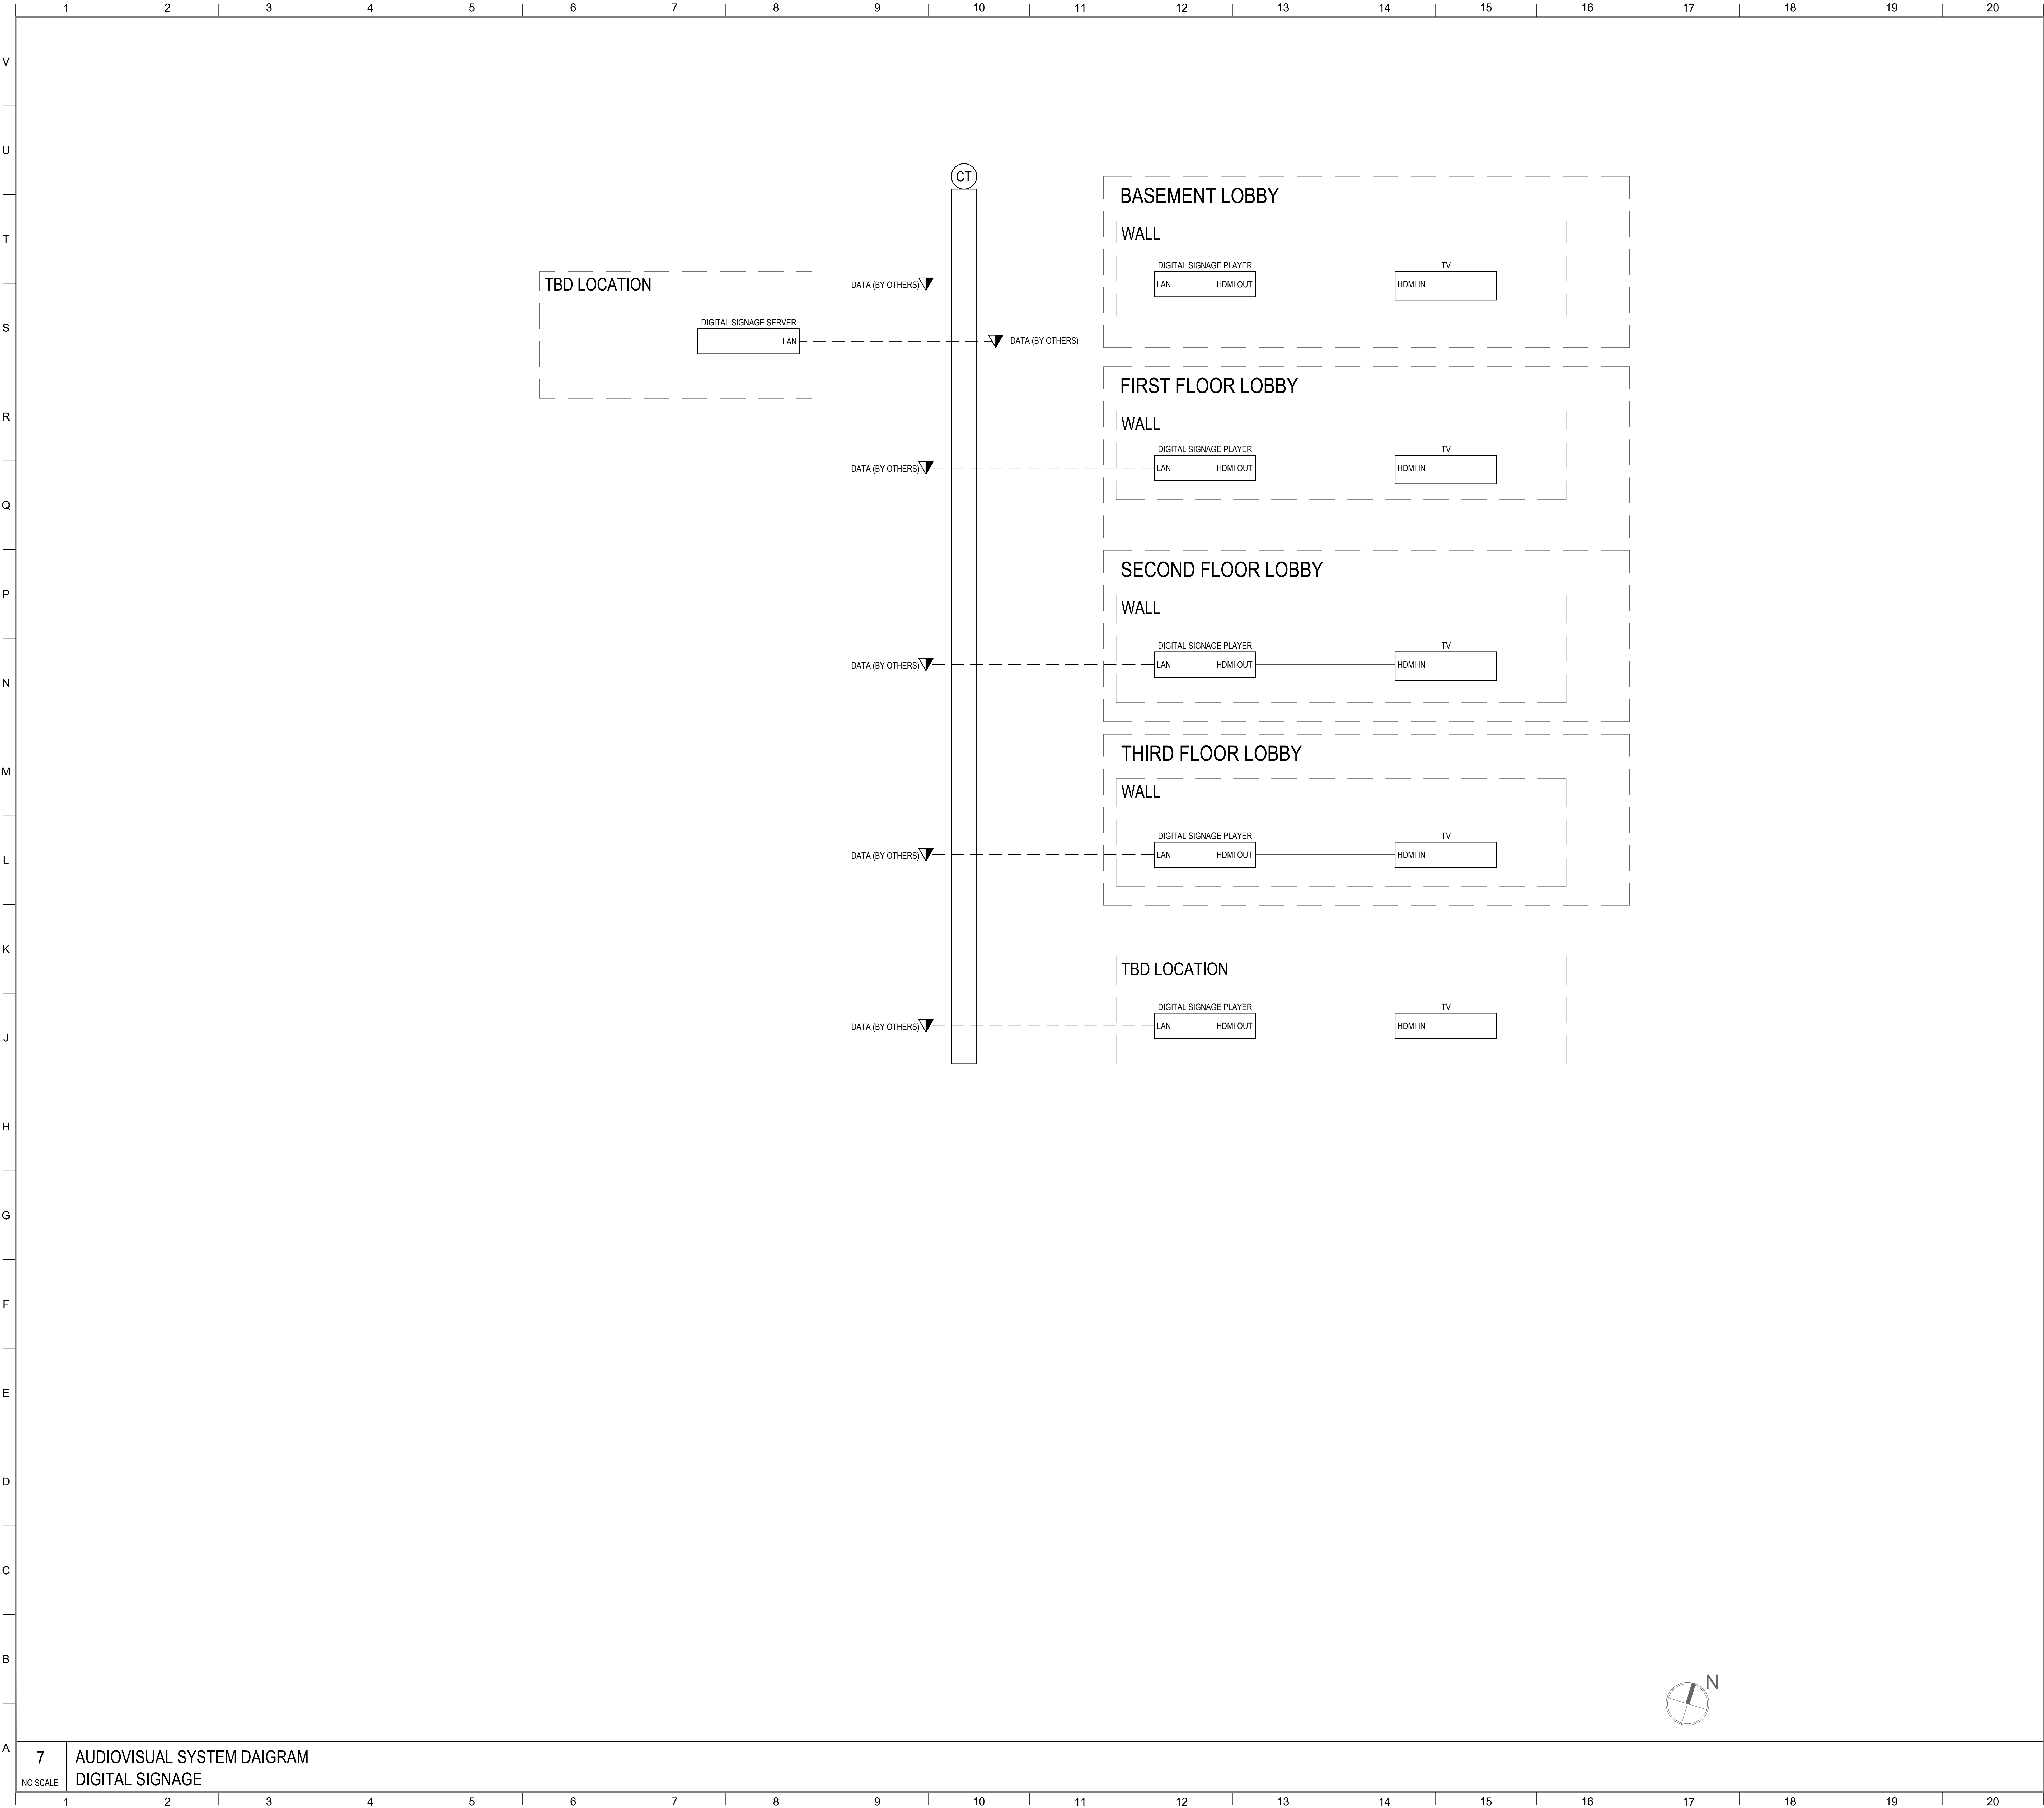

MATERIAL KEYING LEGEND:

KEY PLAN

5

5

GROUP III AV BID DOCUMENTS

09/06/17

1

PRELIMINARY FLOWS

12/02/16

NO.	REVISIONS SUBMISSIONS	DATE
-----	-------------------------	------

FX FOWLE

FX FOWLE ARCHITECTS, LLP 122 WEST 109TH STREET | NEW YORK, NY 10011 | T 212.627.1700 | F 212.463.8716 | WWW.FX FOWLE.COM

STRUCTURAL ENGINEER

DESIMONE CONSULTING ENGINEERS

15 West 18th Street, 10th Floor, New York, New York 10011 | 212-632-9211

MECHANICAL, ELECTRICAL, PLUMBING, FIRE PROTECTION ENGINEER

COLLADO ENGINEERING

2 Holland Avenue, White Plains, NY 10603 | 914-332-7658

THEATER PLANNING CONSULTANT

FISHER DACHS ASSOCIATES

20 West 109th Street, 8th Floor, New York, NY 10011 | 212-691-3020

ACoustics & AUDIO / VISUAL CONSULTANT

CERAMI & ASSOCIATES

404 5th Avenue, New York, NY 10018 | 212-370-1776

LIGHTING CONSULTANT

ILLUMINATION ARTS

650 Bloomfield Avenue, Suite 101, Bloomfield NJ 07003 | 973-771-1556

LANDSCAPE CONSULTANT

W ARCHITECTURE & LANDSCAPE ARCHITECTURE, LLC

100 5th Avenue, Third Floor New York, NY 10010 | P 212-961-3533 | F 212-620-0758

CIVIL ENGINEER & HAZMAT

LANGAN

21 Penn Plaza 360 West 31st Street 8th Floor New York, NY 10001 212-478-5400 212-478-5444 (fax)

ELEVATOR CONSULTANT

VDA (VAN DEUSEN & ASSOCIATES)

Seven Penn Plaza, Suite 404 New York, NY 10001 Phone: 212-668-9090 Fax: 212-668-9099

IT CONSULTANT

GRID ASSOCIATES, LLC

P.O. Box 1700 Hoboken, NJ 07030 | T 948.722.9600 | F 948.722.9625

SUSTAINABILITY / LEED

YR&G

161 Bowery - 4th Floor, New York, NY 10002 T 917.677.8023 / F 917.677.8023

COST ESTIMATING CONSULTANT

TOSCANO CLEMENTS TAYLOR, LLC

16 Oakwood Road Huntington, NY 11743 T 631.392.1400 / F 631.392.1399

C.I.T.L. PROJ. # 29402

SUNY PURCHASE COLLEGE

735 ANDERSON HILL ROAD | PURCHASE, NY 10577


DRAWING TITLE:

DIGITAL SIGNAGE AV SYSTEMS BLOCK DIAGRAMS

Seal:	Drawn:	Project No.:
		29402 (SUCF) / 09018.L00 (FXF)
	Checked:	Cad File:
	Reviewed:	Drawing No.:
	Date:	
	Scale:	
		NOT TO SCALE

TA-08.07

© 2009 FXFOWLE ARCHITECTS, LLP | ALL RIGHTS RESERVED

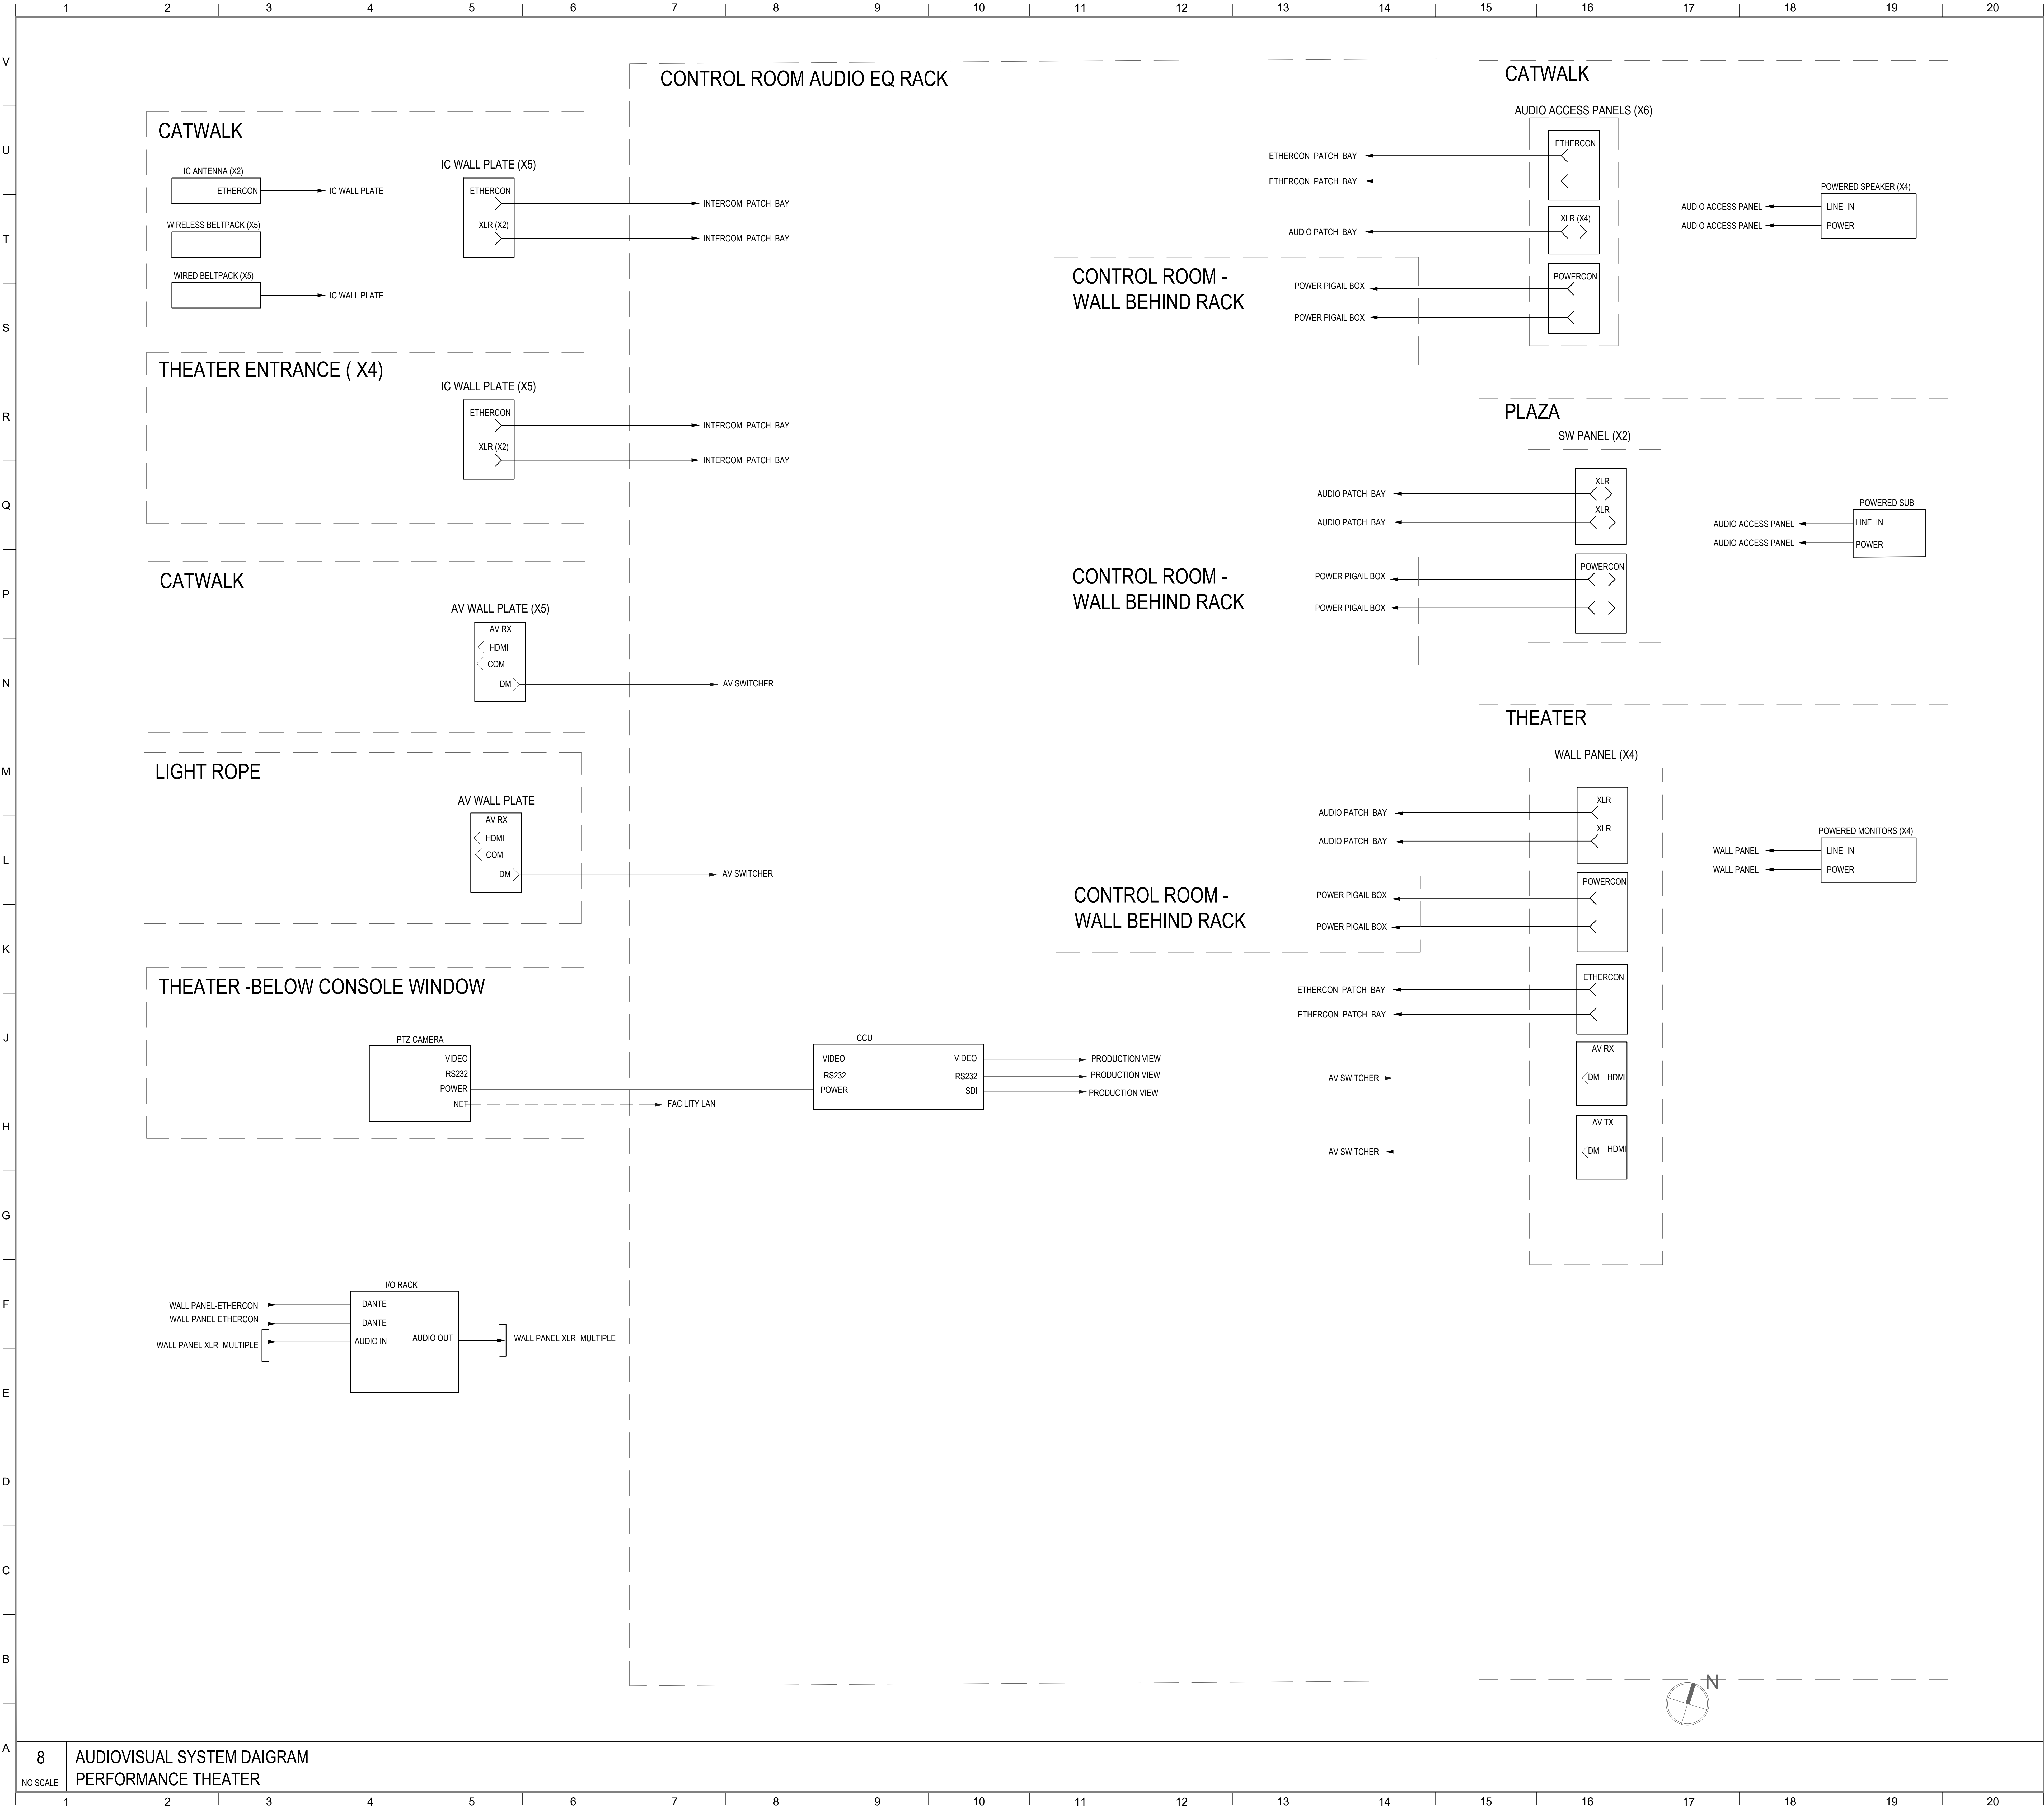

MATERIAL KEYING LEGEND:

5

5	GROUP III AV BID DOCUMENTS	09/06/17
1	PRELIMINARY FLOWS	12/02/16

NO.	REVISIONS / SUBMISSIONS	DATE

FX FOWLE

FX FOWLE ARCHITECTS, LLP | 22 WEST 10TH STREET | NEW YORK, NY 10011 | T 212.627.1700 | F 212.463.8716 | WWW.FX FOWLE.COM

STRUCTURAL ENGINEER:
DESIMONE CONSULTING ENGINEERS
15 West 18th Street, 10th Floor, New York, New York 10011 | 212-632-3211

MECHANICAL, ELECTRICAL, PLUMBING, FIRE PROTECTION ENGINEER:
COLLADO ENGINEERING
2 Holland Avenue, White Plains, NY 10603 | 914-332-7658

THEATER PLANNING CONSULTANT:
FISHER DACHS ASSOCIATES
20 West 10th Street, 8th Floor, New York, NY 10011 | 212-691-3020

ACQUISITION & AUDIO / VISUAL CONSULTANT:
CERAMI & ASSOCIATES
404 Fifth Avenue, New York, NY 10018 | 212-370-1776

LIGHTING CONSULTANT:
ILLUMINATION ARTS
650 Bloomfield Avenue, Suite 101, Bloomfield NJ 07003 | 973-771-1556

LANDSCAPE CONSULTANT:
W ARCHITECTURE & LANDSCAPE ARCHITECTURE, LLC
100 Fifth Avenue, Third Floor, New York, NY 10010 | P 212-661-3633 | F 212-620-0758

CIVIL ENGINEER & HAZMAT:
LANGAN
21 Penn Plaza, 360 West 31st Street, 8th Floor, New York, NY 10001 | 212-478-5400 | 212-478-5444 (fax)

ELEVATOR CONSULTANT:
VDA (VAN DEUSEN & ASSOCIATES)
Seven Penn Plaza, Suite 404, New York, NY 10001 | Phone: 212-668-9090 | Fax: 212-668-9099

IT CONSULTANT:
GRID ASSOCIATES, LLC
P.O. Box 1700, Hoboken, NJ 07030 | T 948.722.9600 | F 948.722.9625

SUSTAINABILITY / LEED:
YR&G
161 Bowery - 4th Floor, New York, NY 10002 | T 917.677.8023 | F 917.677.8023

COST ESTIMATING CONSULTANT:
TOSCANO CLEMENTS TAYLOR, LLC
16 Oakwood Road, Huntington, NY 11743 | T 631.392.1400 / F 631.392.1399

C.I.T.L. PROJ. # 29402
SUNY PURCHASE COLLEGE
735 ANDERSON HILL ROAD | PURCHASE, NY 10577


DRAWING TITLE:
PERFORMANCE THEATER AV SYSTEMS BLOCK DIAGRAMS

Seal:	Drawn:	Project No.:
		29402 (SUCF) / 09018.L00 (FXP)
	Checked:	Cad File:
	Reviewed:	Drawing No.:
	Date:	
	Scale:	
	NOT TO SCALE	

TA-08.08

© 2009 FX FOWLE ARCHITECTS, LLP | ALL RIGHTS RESERVED



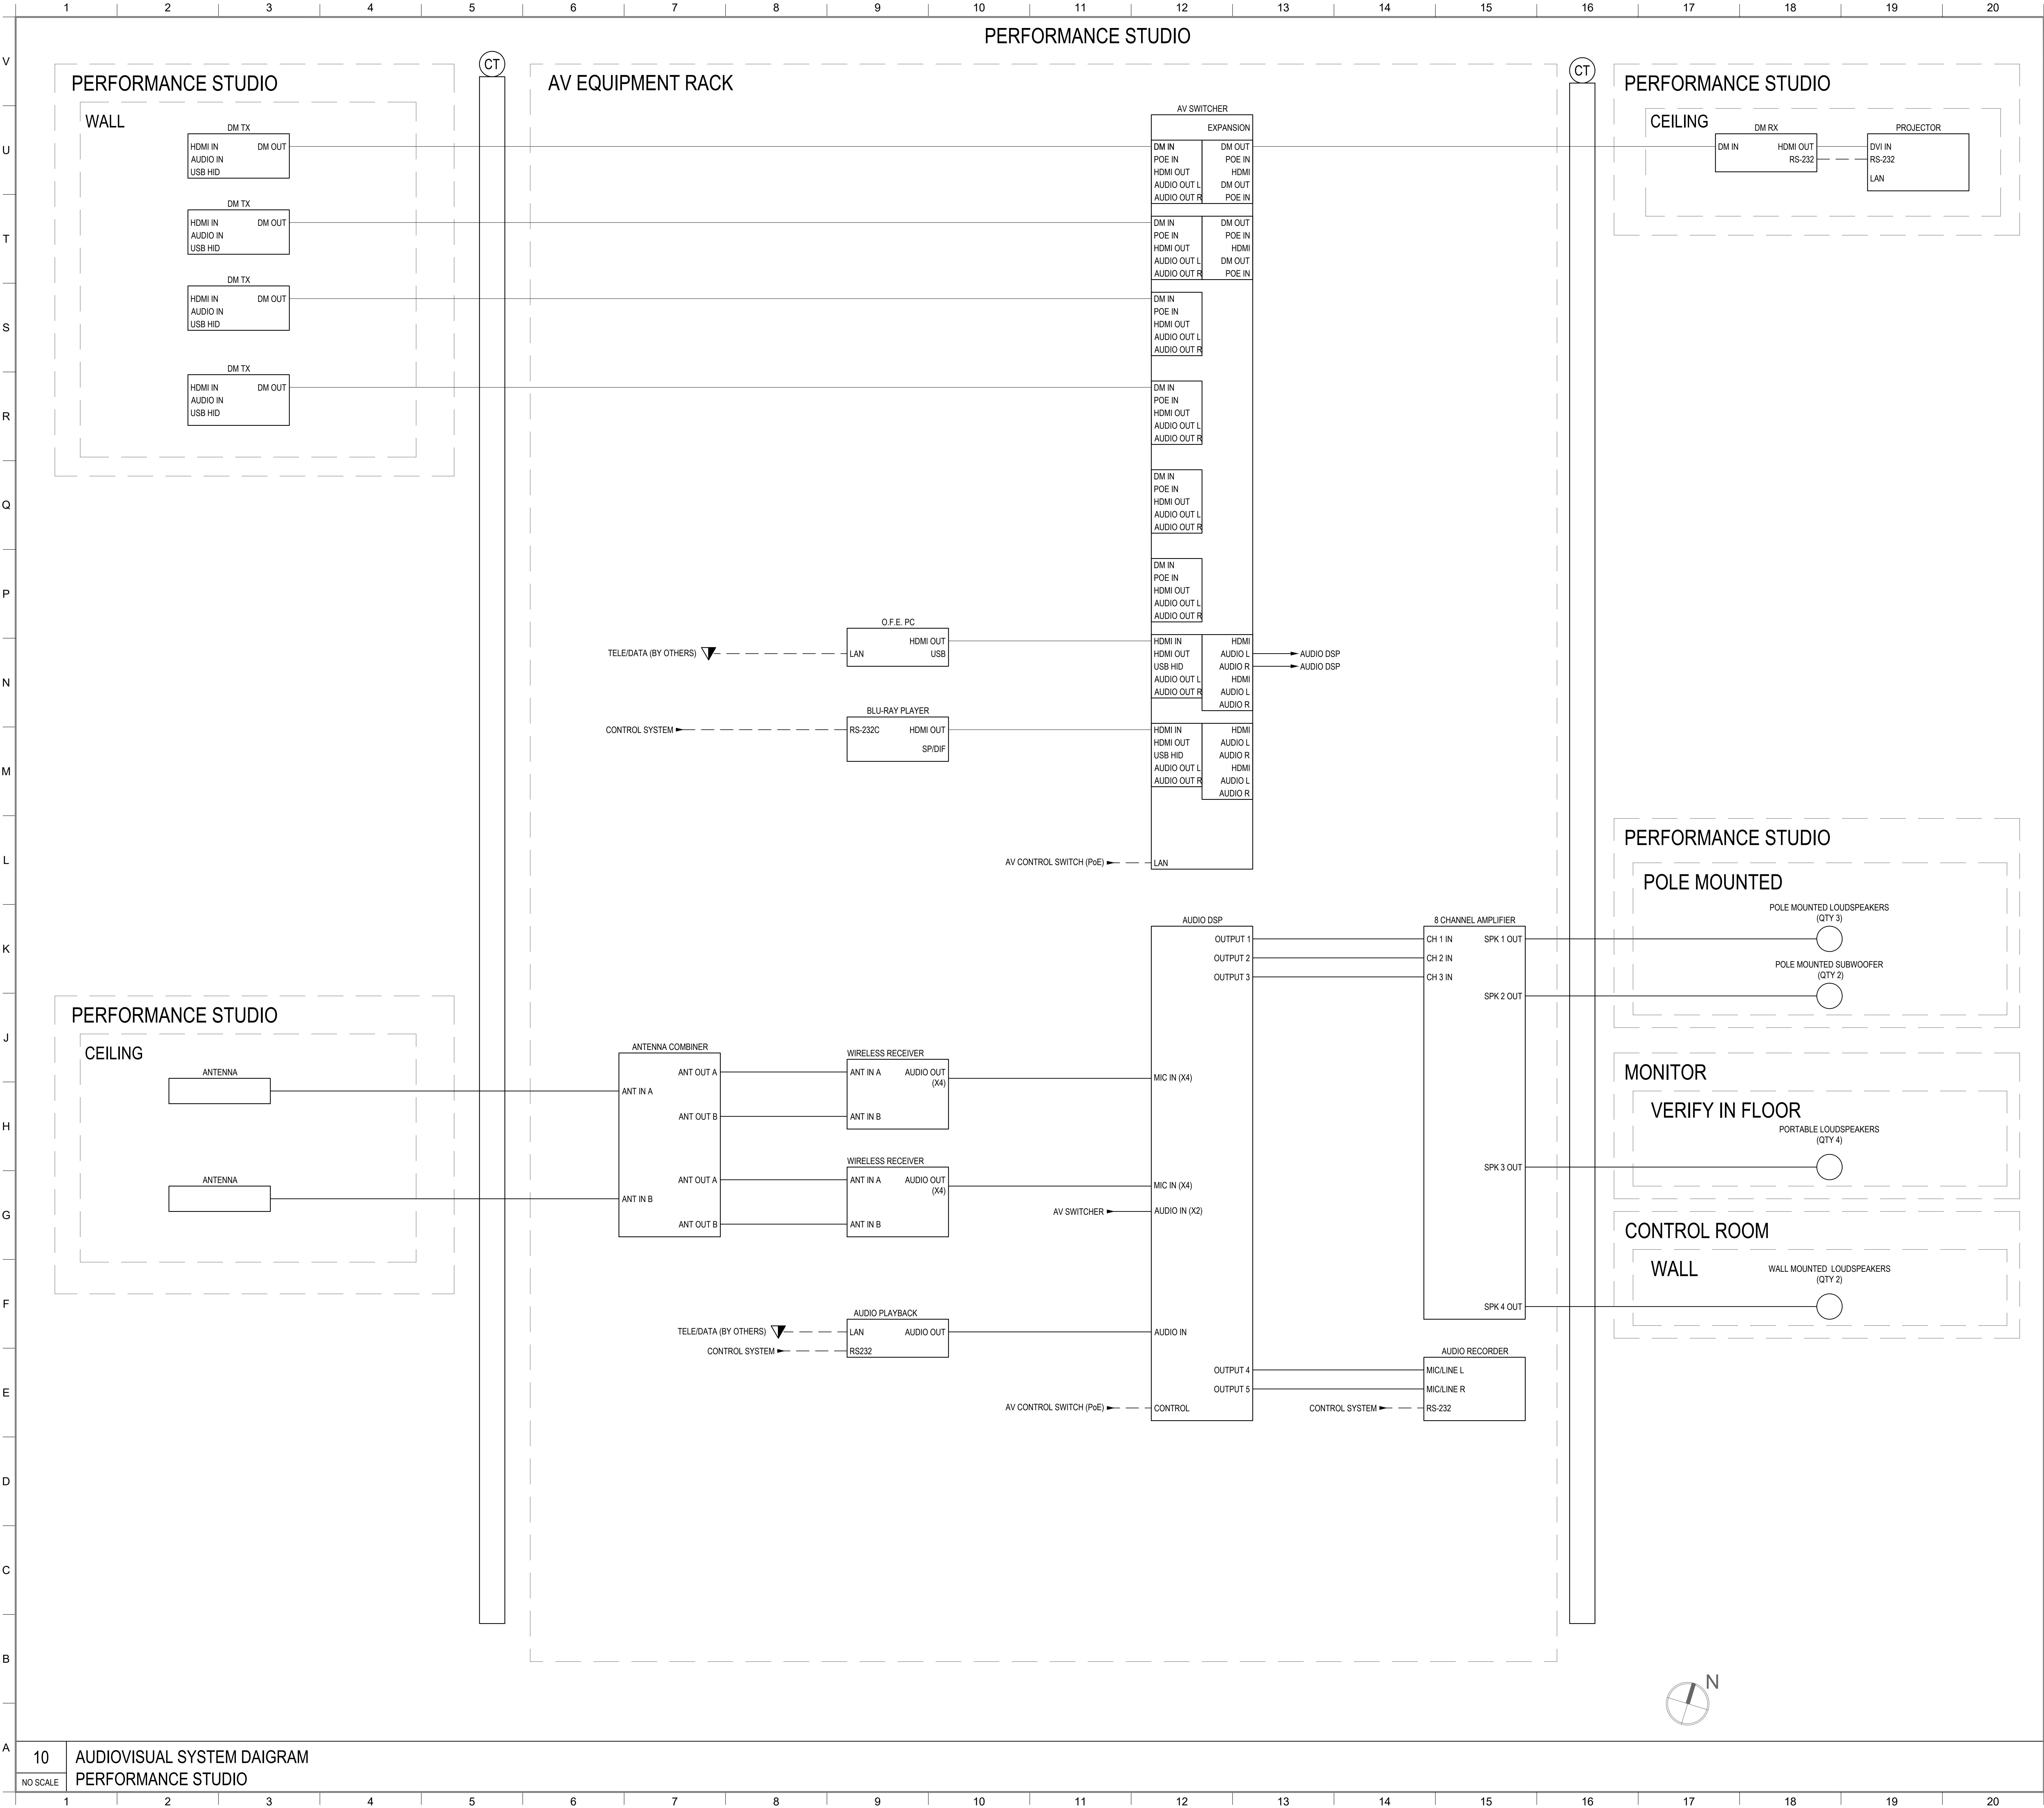

MATERIAL KEYING LEGEND:

KEY PLAN

5

5
1

GROUP III AV BID DOCUMENTS
PRELIMINARY FLOWS

09/06/17
12/02/16

NO. REVISIONS | SUBMISSIONS DATE

FX FOWLE

FXFOWLE ARCHITECTS, LLP | 22 WEST 19TH STREET | NEW YORK, NY 10011 | T 212-627-1700 | F 212-483-8718 | WWW.FXFWOLE.COM

STRUCTURAL ENGINEER:
DESIMONE CONSULTING ENGINEERS
15 West 18th Street, 10th Floor, New York, New York 10011 212-632-9211

MECHANICAL, ELECTRICAL, PLUMBING, FIRE PROTECTION ENGINEER:
COLLADO ENGINEERING
2 Holland Avenue, White Plains, NY 10603 914-332-7658

THEATER PLANNING CONSULTANT:
FISHER DACHS ASSOCIATES
22 West 19th Street, 8th Floor, New York, NY 10011 212-691-9029

ACQUISITION & AUDIO / VISUAL CONSULTANT:
CERAMI & ASSOCIATES
404 5th Avenue, New York, NY 10018 212-370-1776

LIGHTING CONSULTANT:
ILLUMINATION ARTS
650 Bloomfield Avenue, Suite 101, Bloomfield NJ 07003 973-771-1556

LANDSCAPE CONSULTANT:
W ARCHITECTURE & LANDSCAPE ARCHITECTURE, LLC
103 5th Avenue, Third Floor, New York, NY 10010 P 212-661-3533 F 212-624-9758

CIVIL ENGINEER & HAZMAT:
LANGAN
21 Penn Plaza, Suite 360 West 31st Street 8th Floor New York, NY 10001 212-479-5400 212-479-5444 (fax)

ELEVATOR CONSULTANT:
VDA (VAN DEUSEN & ASSOCIATES)
Seven Penn Plaza, Suite 404 New York, NY 10001 Phone 212-668-9090 Fax: 212-668-9099

IT CONSULTANT:
GRID ASSOCIATES, LLC
P.O. Box 1785 Hoboken, NJ 07030 T 848.722.8600 / F 848.722.8625

SUSTAINABILITY / LEED:
YR&G
161 Bowery - 4th Floor, New York, NY 10002 T 917.677.8023 / F 917.677.8023

COST ESTIMATING CONSULTANT:
TOSCANO CLEMENTS TAYLOR, LLC
16 Oakwood Road Huntington, NY 11743 T 631.392.1450 / F 631.392.1399

C.I.T.L. PROJ. # 29402
SUNY PURCHASE COLLEGE
735 ANDERSON HILL ROAD | PURCHASE, NY 10577

DRAWING TITLE:
PERFORMANCE STUDIO AV SYSTEMS BLOCK DIAGRAMS

Seal: Drawn: Project No.:
29402 (SUCF) / 09018.L00 (FXF)
Checked: Coord File:
Reviewed: Drawing No.:
Date:
Scale:
NOT TO SCALE

TA-08.10

© 2009 FXFOWLE ARCHITECTS, LLP | ALL RIGHTS RESERVED



