

 
PURCHASE COLLEGE
735 ANDERSON HILL ROAD
PURCHASE, NY 10577

LU ENGINEERS
CIVIL ENGINEERING
50 LAKEFRONT BLVD. SUITE 212
ROCHESTER, NY 14202
P: 716.849.0982
www.luengineers.com

ATLANTIC TESTING LABORATORIES
GEOTECHNICAL ENGINEERING
 251 UPPER NORTH ROAD
 HIGHLAND, NY 12528
 P: 845.691.6098
www.atlantictesting.com

[illegible]

STATE OF NEW YORK LIC. NO. 001147-1
BID DOCUMENTS



SCALE:	NTS
DATE:	07.06.2018
DRAWN BY:	HG
CHECKED BY:	KG
APPROVED BY:	

AA PROJECT #:	150024
---------------	--------

PROJECT PHASE:	BID DOCUMENTS
-----------------------	---------------

DRAWING TITLE:

LC-100

SHEET:



**THE PERFORMING
ARTS CENTER**

WEST LAWN

PHASE II NOT IN CONTRACT

SHEETS
LM-101
LG-101
LP-101



SHEETS
LM-102*
LG-102*
LP-102*

SHEET LIST

CL-100	COVER SHEET
C-001	SURVEY NORTH
C-002*	SURVEY SOUTH
C-101	EROSION & SEDIMENTATION CONTROL NORTH
C-102*	EROSION & SEDIMENTATION CONTROL SOUTH
C-111	DEMOLITION PLAN NORTH
C-112*	DEMOLITION PLAN SOUTH
C-201	GENERAL PLAN NORTH
C-202*	GENERAL PLAN SOUTH
C-401	DRAINAGE ENLARGEMENT PLANS NORTH
C-402*	DRAINAGE ENLARGEMENT PLANS SOUTH
C-501	DRAINAGE DETAILS N1
C-502	DRAINAGE DETAILS N2
C-503	DRAINAGE DETAILS N3
C-504*	DRAINAGE DETAILS S1
C-505*	DRAINAGE DETAILS S2
C-506*	DRAINAGE DETAILS S3
C-508*	DRAINAGE STRUCTURE AT S3
LM-100	MISCELLANEOUS DETAILS AND DRAINAGE STRUCTURES AT S4
LM-101	MATERIALS PLAN NORTH
LM-102*	MATERIALS PLAN SOUTH
LG-101	GRADING PLAN NORTH
LG-102*	GRADING PLAN SOUTH
LP-101	PLANTING PLAN NORTH
LP-102*	PLANTING PLAN SOUTH
LM-301	SITE SECTIONS
LM-302	SITE SECTIONS
LP-501	LANDSCAPE DETAILS

ABBREVIATIONS FOR L-SERIES DRAWINGS

[illegible]


TH	telephone
TH	thickness
TOL	tolerance
TC	top of curb
TS	top of steps
TSR	top of slab
TW	top wall
TRD	trend
TYP	typical
UN	unless otherwise noted
VAR	varies
VERT	vertical
VC	vertical curve
W	west
WHS	wheel stop
W	"width, wgs"
W/	with
W/O	without
WWM	woven wire mesh
WHF	welded wire fabric
SYMBOLS	
@	align at
+	feet, minutes
+	inches
°	degrees
Δ	centerline
Δ	central
Δ	deflection angle
°	per centimeter
±	plus or minus
#	pound, number

GENERAL NOTES

1. REVIEW CONTRACT DOCUMENTS AND FIELD CONDITIONS BEFORE STARTING EACH PORTION OF THE WORK. REPORT ERRORS, OMISSIONS, OR INCONSISTENCIES PROMPTLY TO LANDSCAPE ARCHITECT.
2. CONTACT UTILITY COMPANIES AS REQUIRED BY STATE AND LOCAL REGULATIONS BEFORE DIGGING TO LOCATE AND MARK EXISTING UTILITIES.
3. EXERCISE CARE IN OPERATIONS TO PROTECT EXISTING UNDERGROUND UTILITIES.
4. BASE SURVEY INFORMATION WAS SUPPLIED BY MJ ENGINEERING AND LAND SURVEYING, P.C.
5. THESE CONTRACT DOCUMENTS MAKE NO REPRESENTATIONS AS TO THE MEANS AND METHODS OF CONSTRUCTION.

*PHASE II, NOT IN CONTRACT


DRAWING FILE PATH: Z:\PROJECTS\50384 ANDROPOGON ASSOCIATES, LTD\50384-01 GREEN INFRASTRUCTURE-SUNY PURCHASE\CADD\CD\ N&S GEN PLANDWG
DATE MODIFIED: 7/18/2018

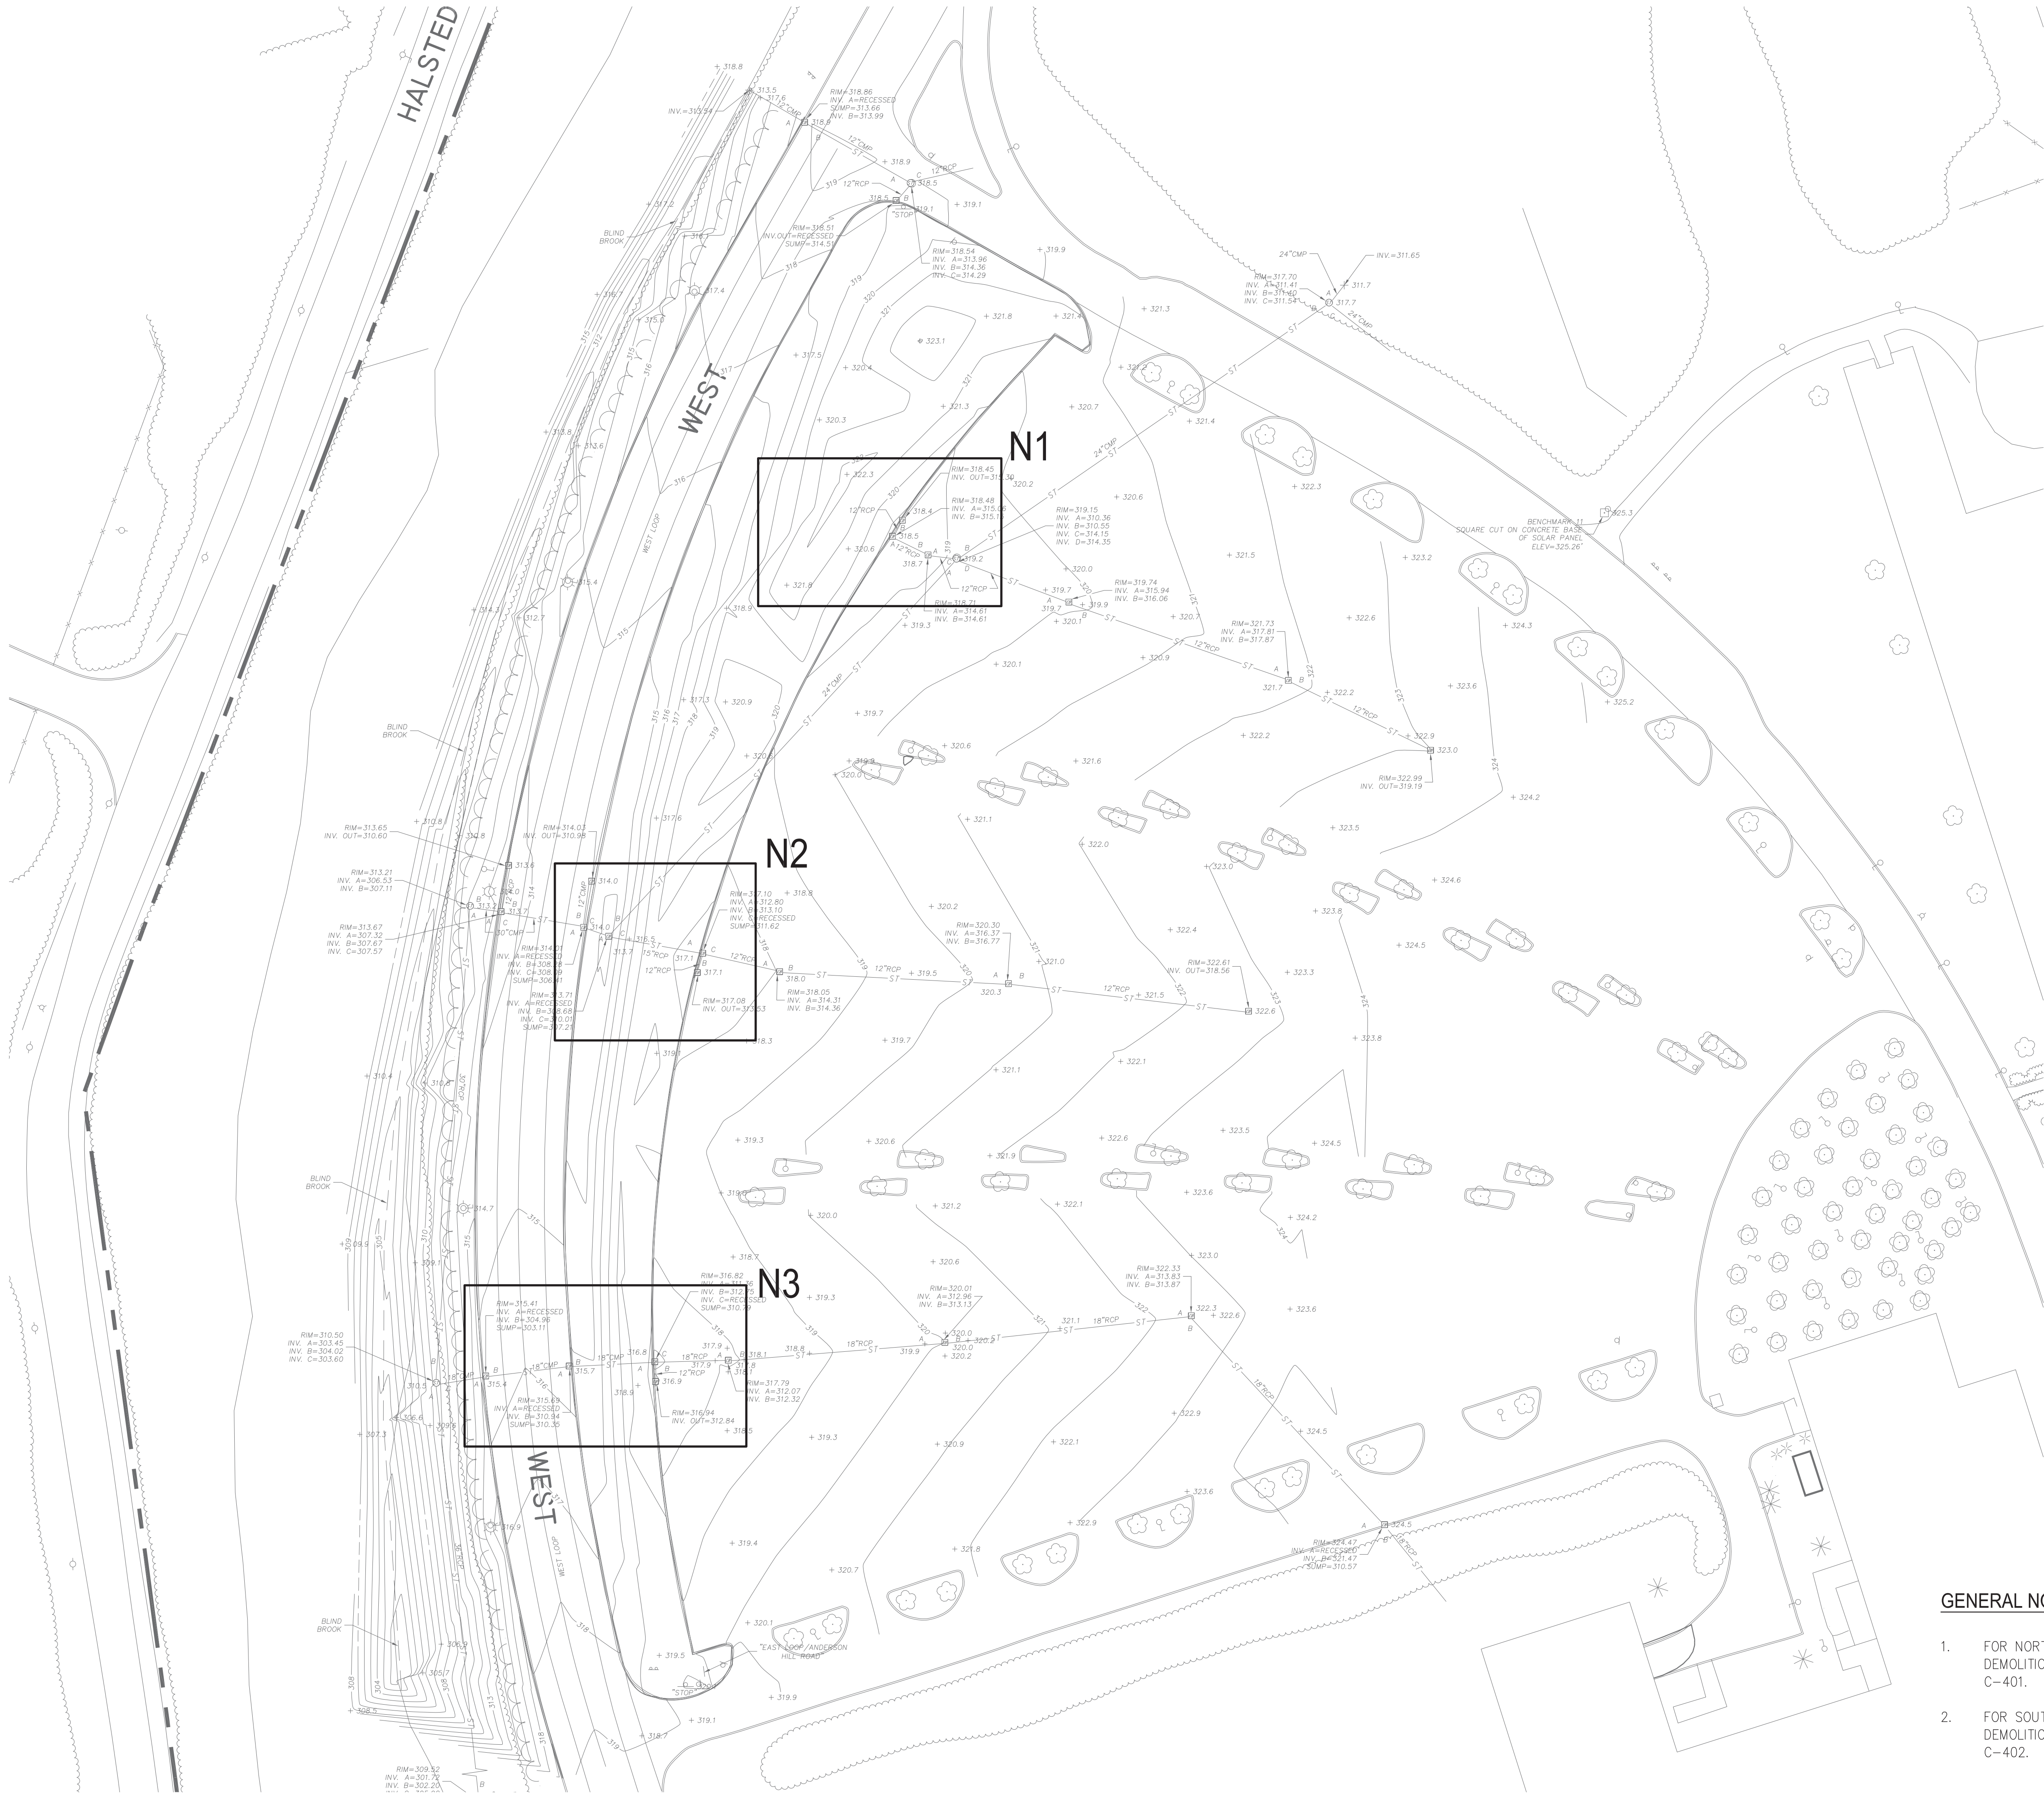

GENERAL NORTH LOT PLAN
SCALE: 1" = 40'-0"

GENERAL NOTES:

 - FOR NORTH LOT DETAILS N1, N2, AND N3 SEE DEMOLITION PLAN C-111 AND PROPOSED PLAN C-401.
- FOR SOUTH LOT DETAILS S1, S2, AND S3 SEE DEMOLITION PLAN C-112 AND PROPOSED PLAN C-402.



ANDROPOGON
ASSOCIATES, LTD
10 SHURS LANE
PHILADELPHIA, PA 19127
T: 215.487.0700
F: 215.483.7520
W: www.andropogon.com

PURCHASE COLLEGE
GREEN
INFRASTRUCTURE

PURCHASE COLLEGE
735 ANDERSON HILL ROAD
PURCHASE, NY 10577

LU ENGINEERS
CIVIL ENGINEERING
50 LAKEFRONT BLVD. SUITE 212
BUFFALO, NY 14202
P: 716.849.0982
www.luengineers.com

ATLANTIC TESTING LABORATORIES
GEOTECHNICAL ENGINEERING
251 UPPER NORTH ROAD
HIGHLAND, NY 12528
P: 845.691.6098
www.atlantictesting.com

REV. DATE DESCRIPTION

REV.	DATE	DESCRIPTION



SCALE:	AS SHOWN
DATE:	07.06.2018
DRAWN BY:	PMB
CHECKED BY:	TJN
APPROVED BY:	KDW

AA PROJECT #:	150024
PROJECT PHASE:	100% CONTRACT DOCUMENTS


DRAWING TITLE:

SURVEY - NORTH

SHEET:

C-001

DRAWING FILE PATH: Z:\PROJECTS\50384 ANDROPOGON ASSOCIATES, LTD\50384-01 GREEN INFRASTRUCTURE-SUNY PURCHASE\ADD\CD DESIGN\50384-01_NAS GEN PLANDWG
DATE MODIFIED: 7/18/2018

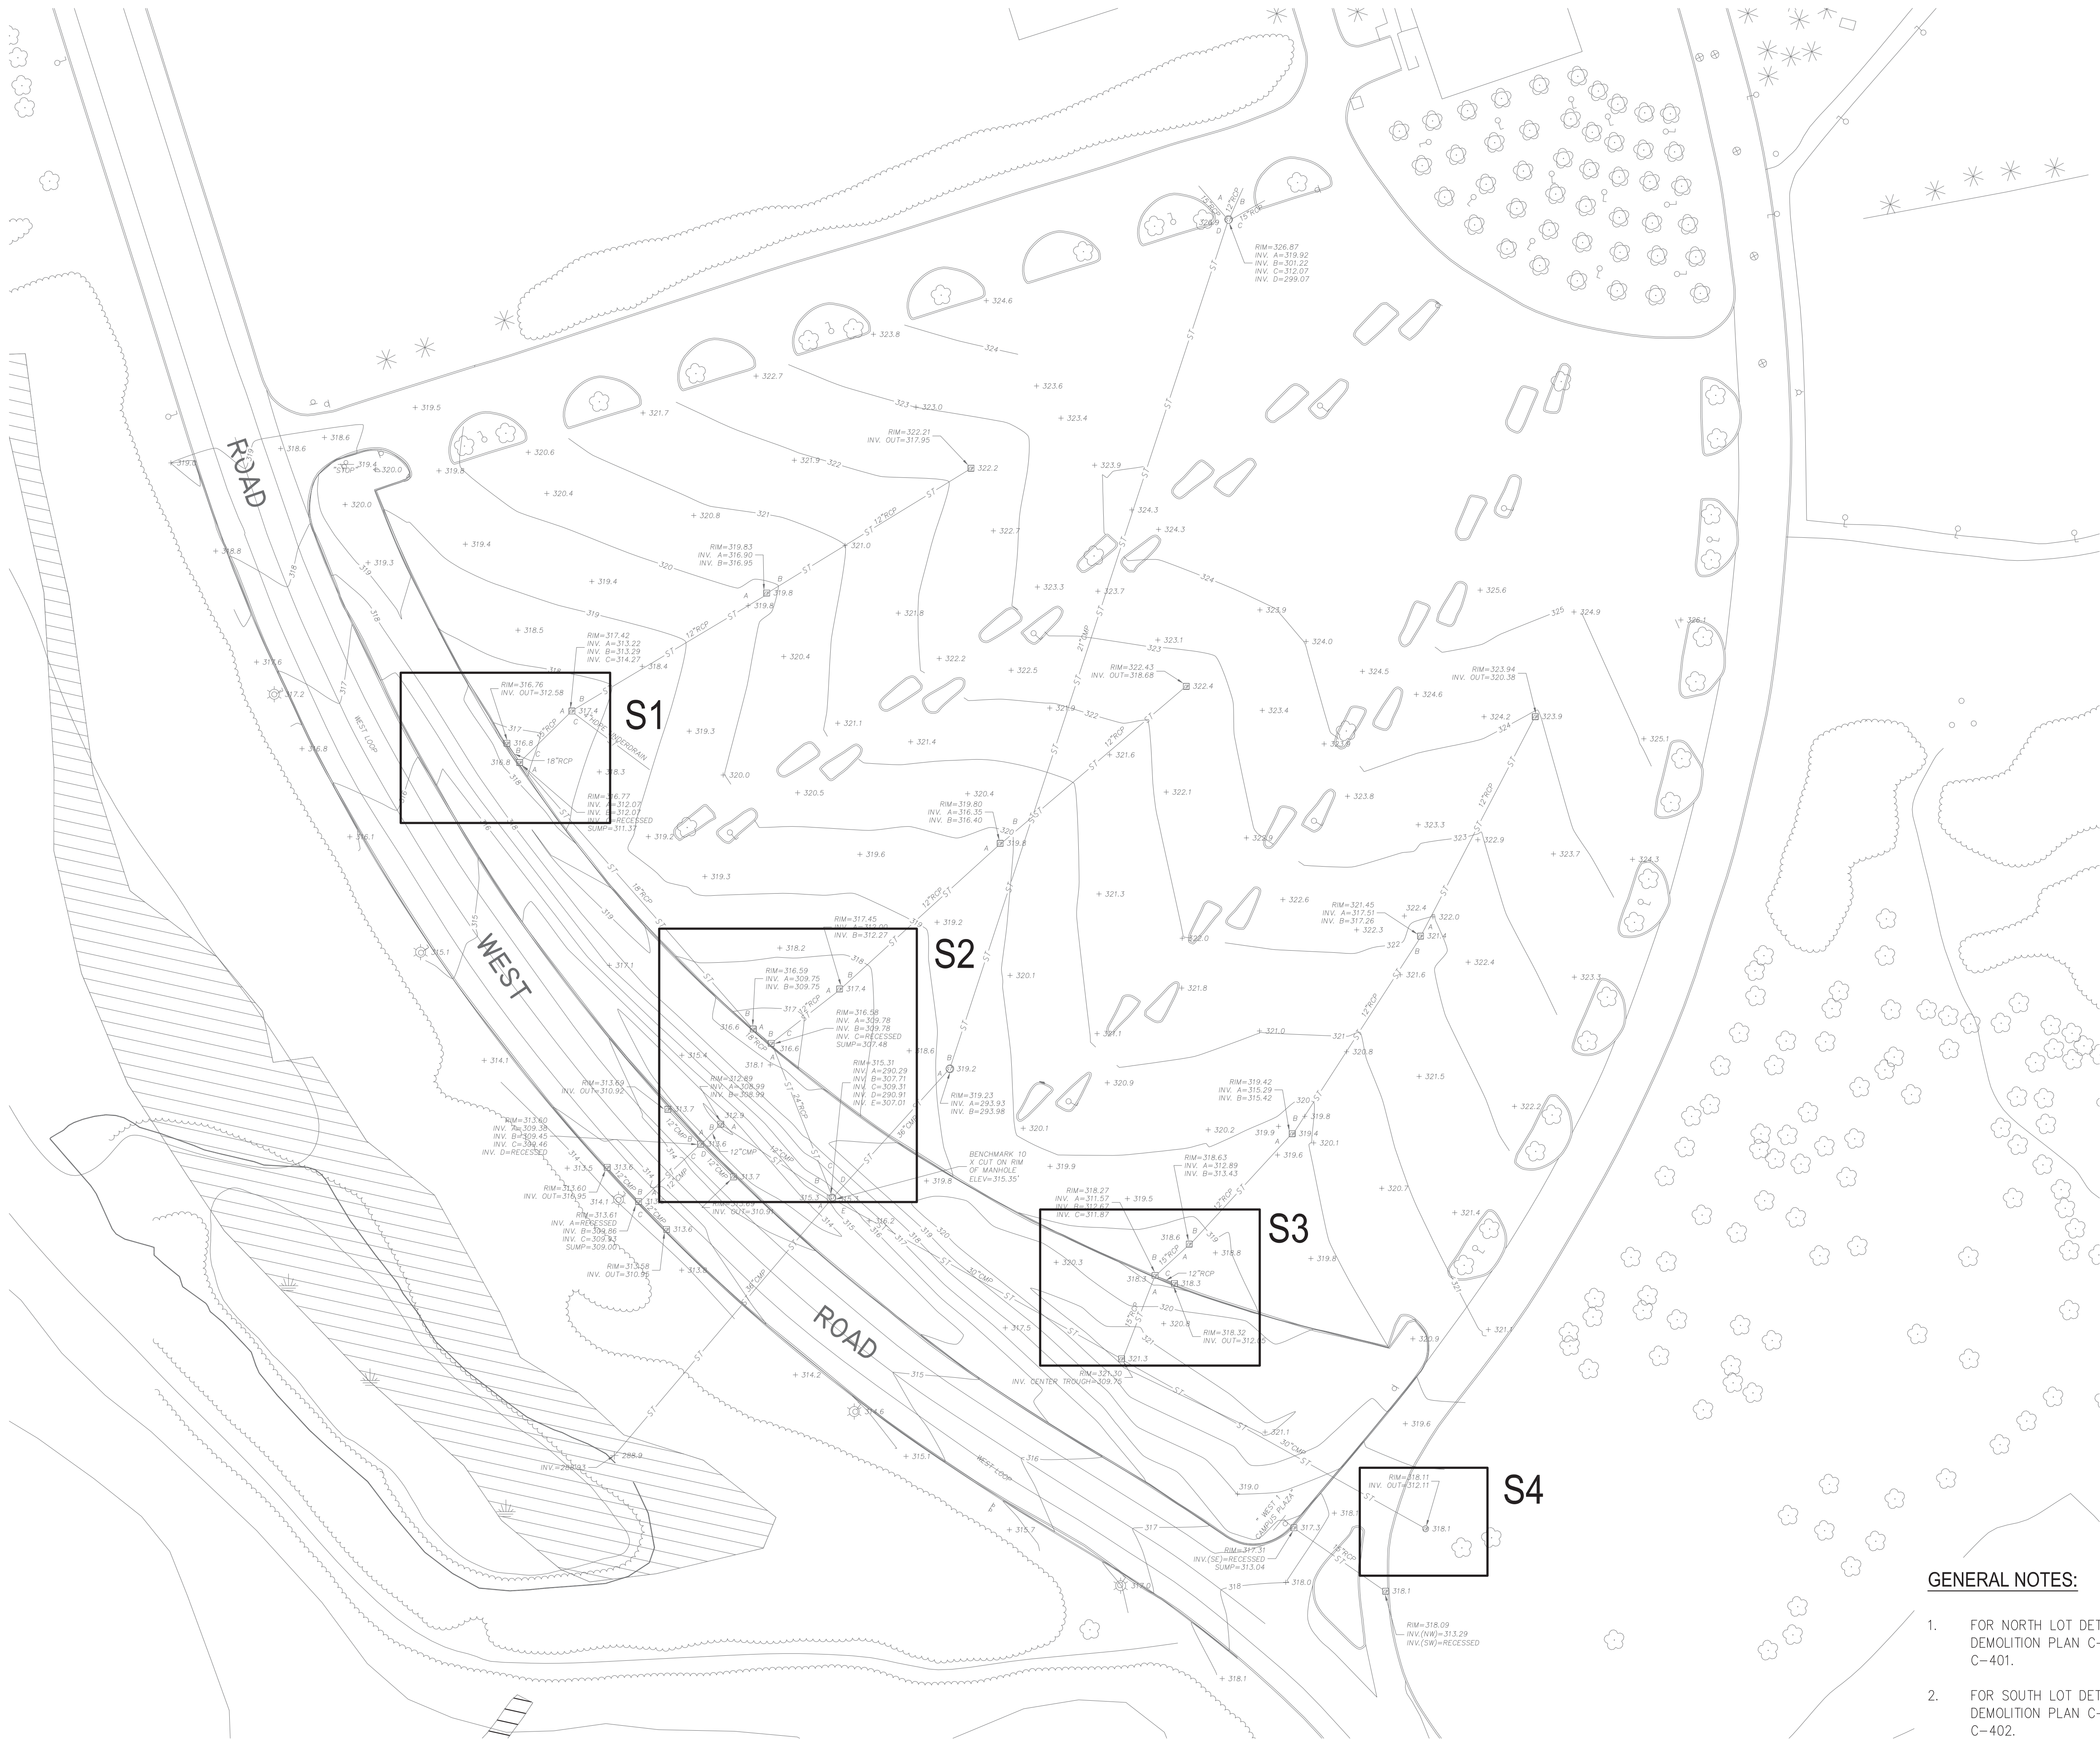

GENERAL SOUTH LOT PLAN
SCALE: 1" = 40'-0"

GENERAL NOTES:

- FOR NORTH LOT DETAILS N1, N2, AND N3 SEE DEMOLITION PLAN C-111 AND PROPOSED PLAN C-401.
- FOR SOUTH LOT DETAILS S1, S2, AND S3 SEE DEMOLITION PLAN C-112 AND PROPOSED PLAN C-402.

0 10' 20' 40' 80'
SCALE: 1" = 40'-0"



ANDROPOGON
ASSOCIATES, LTD
10 SHURS LANE
PHILADELPHIA, PA 19127
T: 215.487.0700
F: 215.483.7520
W: www.andropogon.com

PURCHASE COLLEGE
GREEN
INFRASTRUCTURE

PURCHASE COLLEGE
735 ANDERSON HILL ROAD
PURCHASE, NY 10577

LU ENGINEERS
CIVIL ENGINEERING
50 LAKEFRONT BLVD. SUITE 212
BUFFALO, NY 14202
P: 716.849.0982
www.luengineers.com

ATLANTIC TESTING LABORATORIES
GEOTECHNICAL ENGINEERING
251 UPPER NORTH ROAD
HIGHLAND, NY 12528
P: 845.691.6098
www.atlantictesting.com

REV. DATE DESCRIPTION



SCALE:	AS SHOWN
DATE:	07.06.2018
DRAWN BY:	PMB
CHECKED BY:	TJN
APPROVED BY:	KDW

AA PROJECT #:	150024
PROJECT PHASE:	100% CONTRACT DOCUMENTS

DRAWING TITLE:

SURVEY - SOUTH

SHEET:

C-002

PURCHASE COLLEGE
735 ANDERSON HILL ROAD
PURCHASE, NY 10577

ATLANTIC TESTING LABORATORIES
GEOTECHNICAL ENGINEERING
251 UPPER NORTH ROAD
HIGHLAND, NY 12528
P: 845.691.6098
www.atlantictesting.com


[illegible]

SCALE:	AS SHOWN
DATE:	07.06.2018
DRAWN BY:	PMB
CHECKED BY:	TJN
APPROVED BY:	KDW

AA PROJECT #:	150024
PROJECT PHASE:	100% CONTRACT DOCUMENTS


ESC PLAN-NORTH

C-101

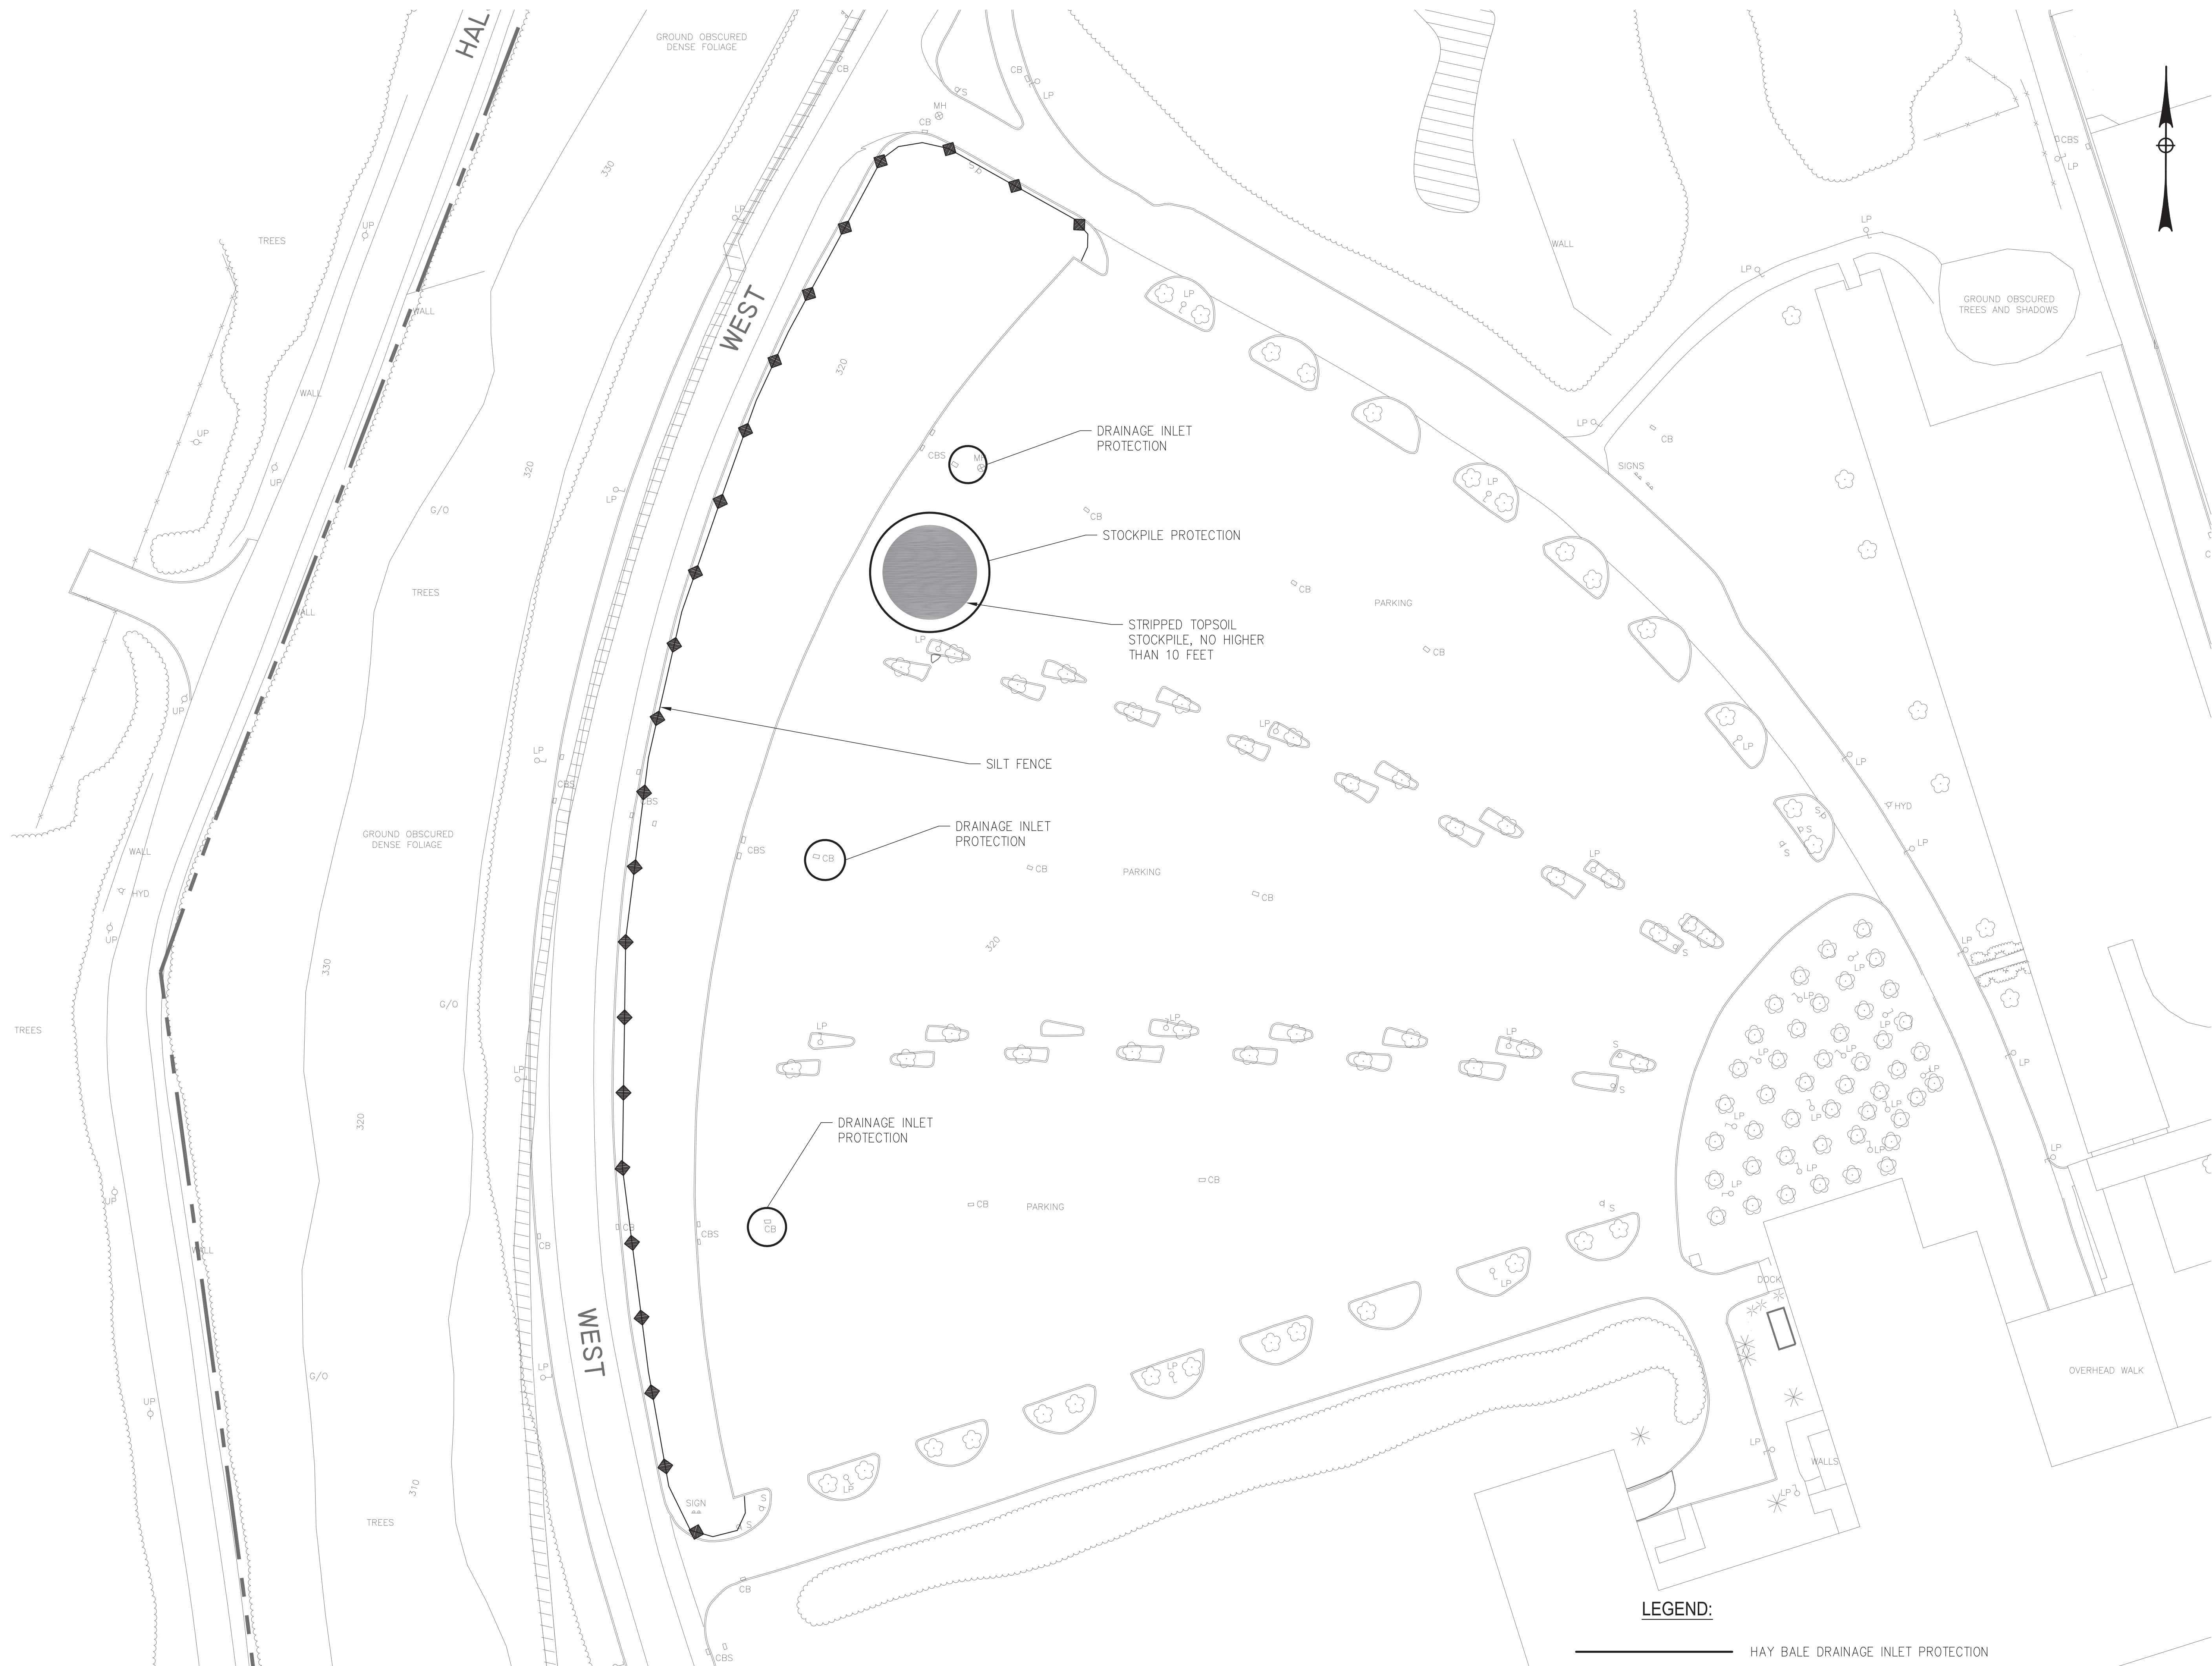

SCALE: 1" = 40'-0"

 
 HAY BALE DRAINAGE INLET PROTECTION
 SILT FENCE CONFORMING TO REQUIREMENTS
 OF NYSDEC APPROVED SILT FENCE




SCALE: 1" = 40'-0"

DRAWING FILE PATH: Z:\PROJECTS\50384 ANDROPOGON ASSOCIATES, LTD\50384-01 GREEN INFRASTRUCTURE-SUNNY PURCHASE\CADD\CD DESIGN\50384-01_N&S ERO&SED PLAN.DWG
DATE MODIFIED: 7/18/2018

DRAWING FILE PATH: Z:\PROJECTS\50384 ANDROPOGON ASSOCIATES, LTD\50384-01 GREEN INFRASTRUCTURE-SUNY PURCHASE\CADD\CD DESIGN\50384-01_NAS ERO&SED PLAN.DWG
DATE MODIFIED: 7/18/2018

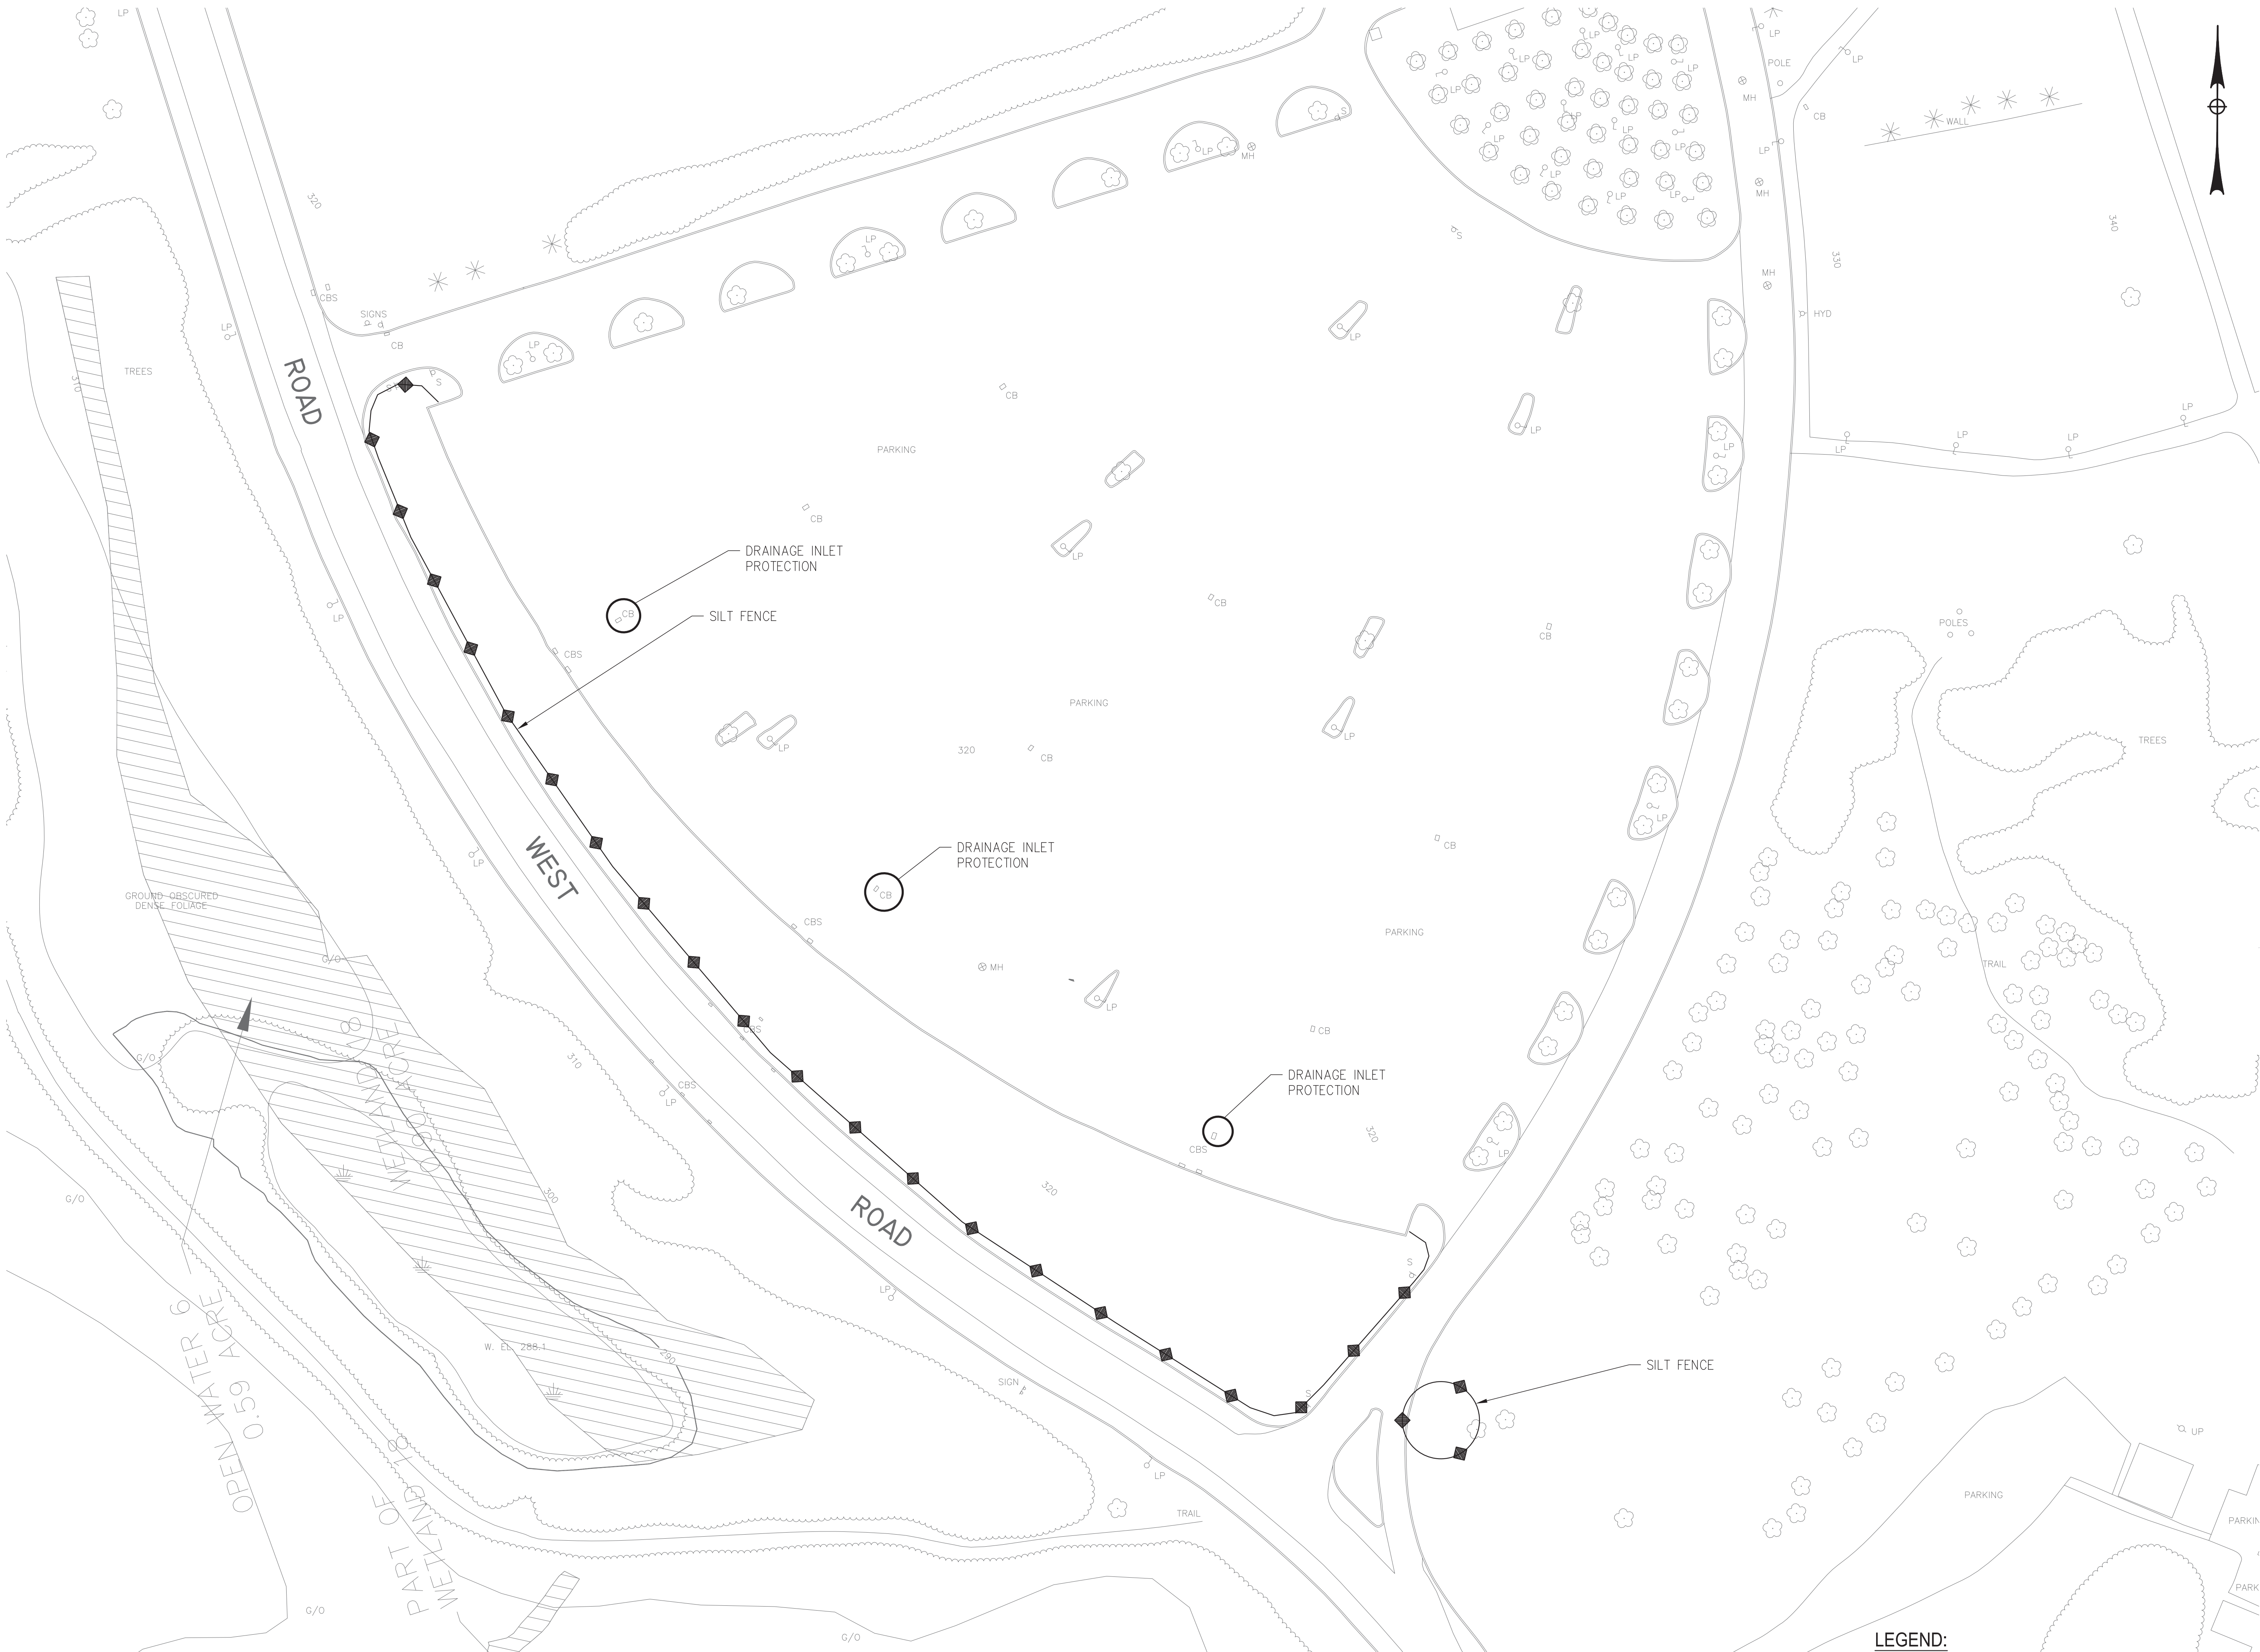

 EROSION AND SEDIMENT CONTROL PLAN - SOUTH END
SCALE: 1" = 40'-0"



- LEGEND:**
- HAY BALE DRAINAGE INLET PROTECTION
 - SILT FENCE CONFORMING TO REQUIREMENTS OF NYSDEC APPROVED SILT FENCE



ANDROPOGON
ASSOCIATES, LTD
10 SHURS LANE
PHILADELPHIA, PA 19127
T: 215.487.0700
F: 215.483.7520
W: www.andropogon.com

PURCHASE COLLEGE GREEN INFRASTRUCTURE

PURCHASE COLLEGE
735 ANDERSON HILL ROAD
PURCHASE, NY 10577

LU ENGINEERS
CIVIL ENGINEERING
50 LAKEFRONT BLVD. SUITE 212
BUFFALO, NY 14202
P: 716.849.0982
www.luengineers.com

ATLANTIC TESTING LABORATORIES
GEOTECHNICAL ENGINEERING
251 UPPER NORTH ROAD
HIGHLAND, NY 12528
P: 845.691.6098
www.atlantictesting.com

REV.	DATE	DESCRIPTION
------	------	-------------



SCALE:	AS SHOWN
DATE:	07.06.2018
DRAWN BY:	PMB
CHECKED BY:	TJN
APPROVED BY:	KDW

AA PROJECT #:	150024
PROJECT PHASE:	100% CONTRACT DOCUMENTS


DRAWING TITLE:

ESC PLAN-SOUTH


SHEET:

C-102


DRAWING FILE PATH: Z:\PROJECTS\50384 ANDROPOGON ASSOCIATES, LTD\50384-01 GREEN INFRASTRUCTURE-SUNY PURCHASE\CADD\CD DESIGN\50384-01_NAS DEMO PLAN.DWG
DATE MODIFIED: 7/18/2018

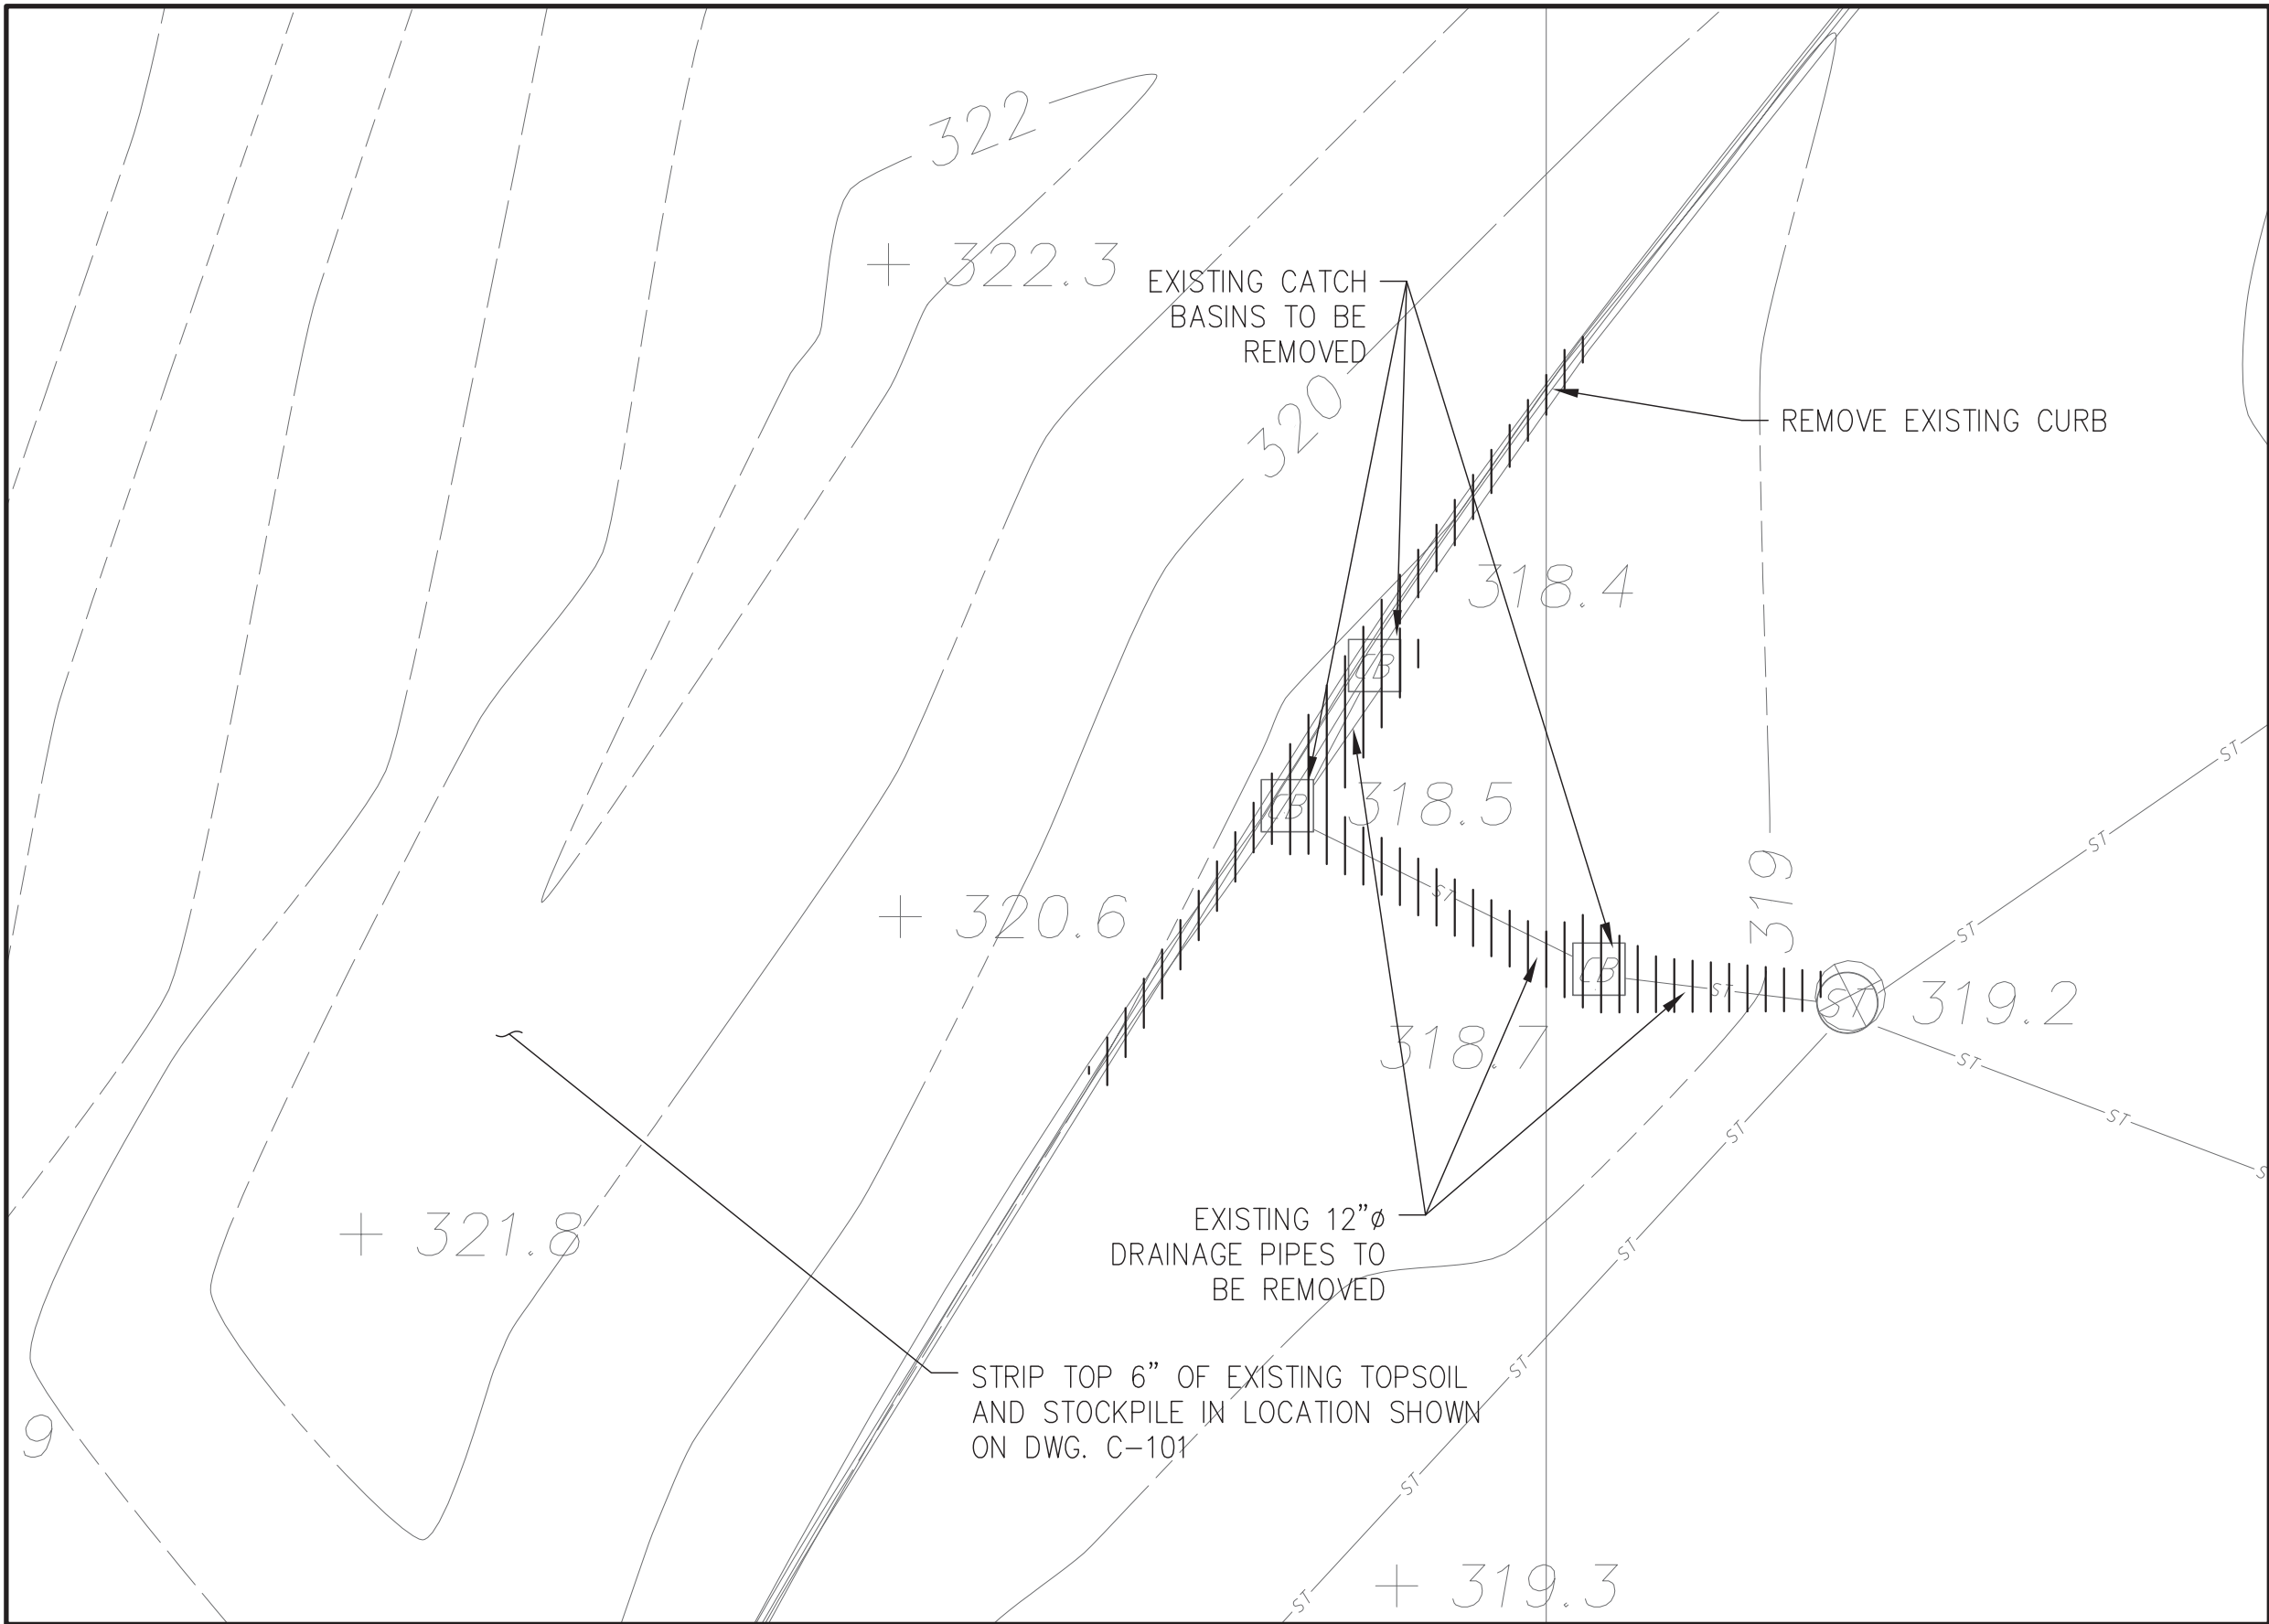

N1 PLAN
SCALE: 1" = 10'-0"

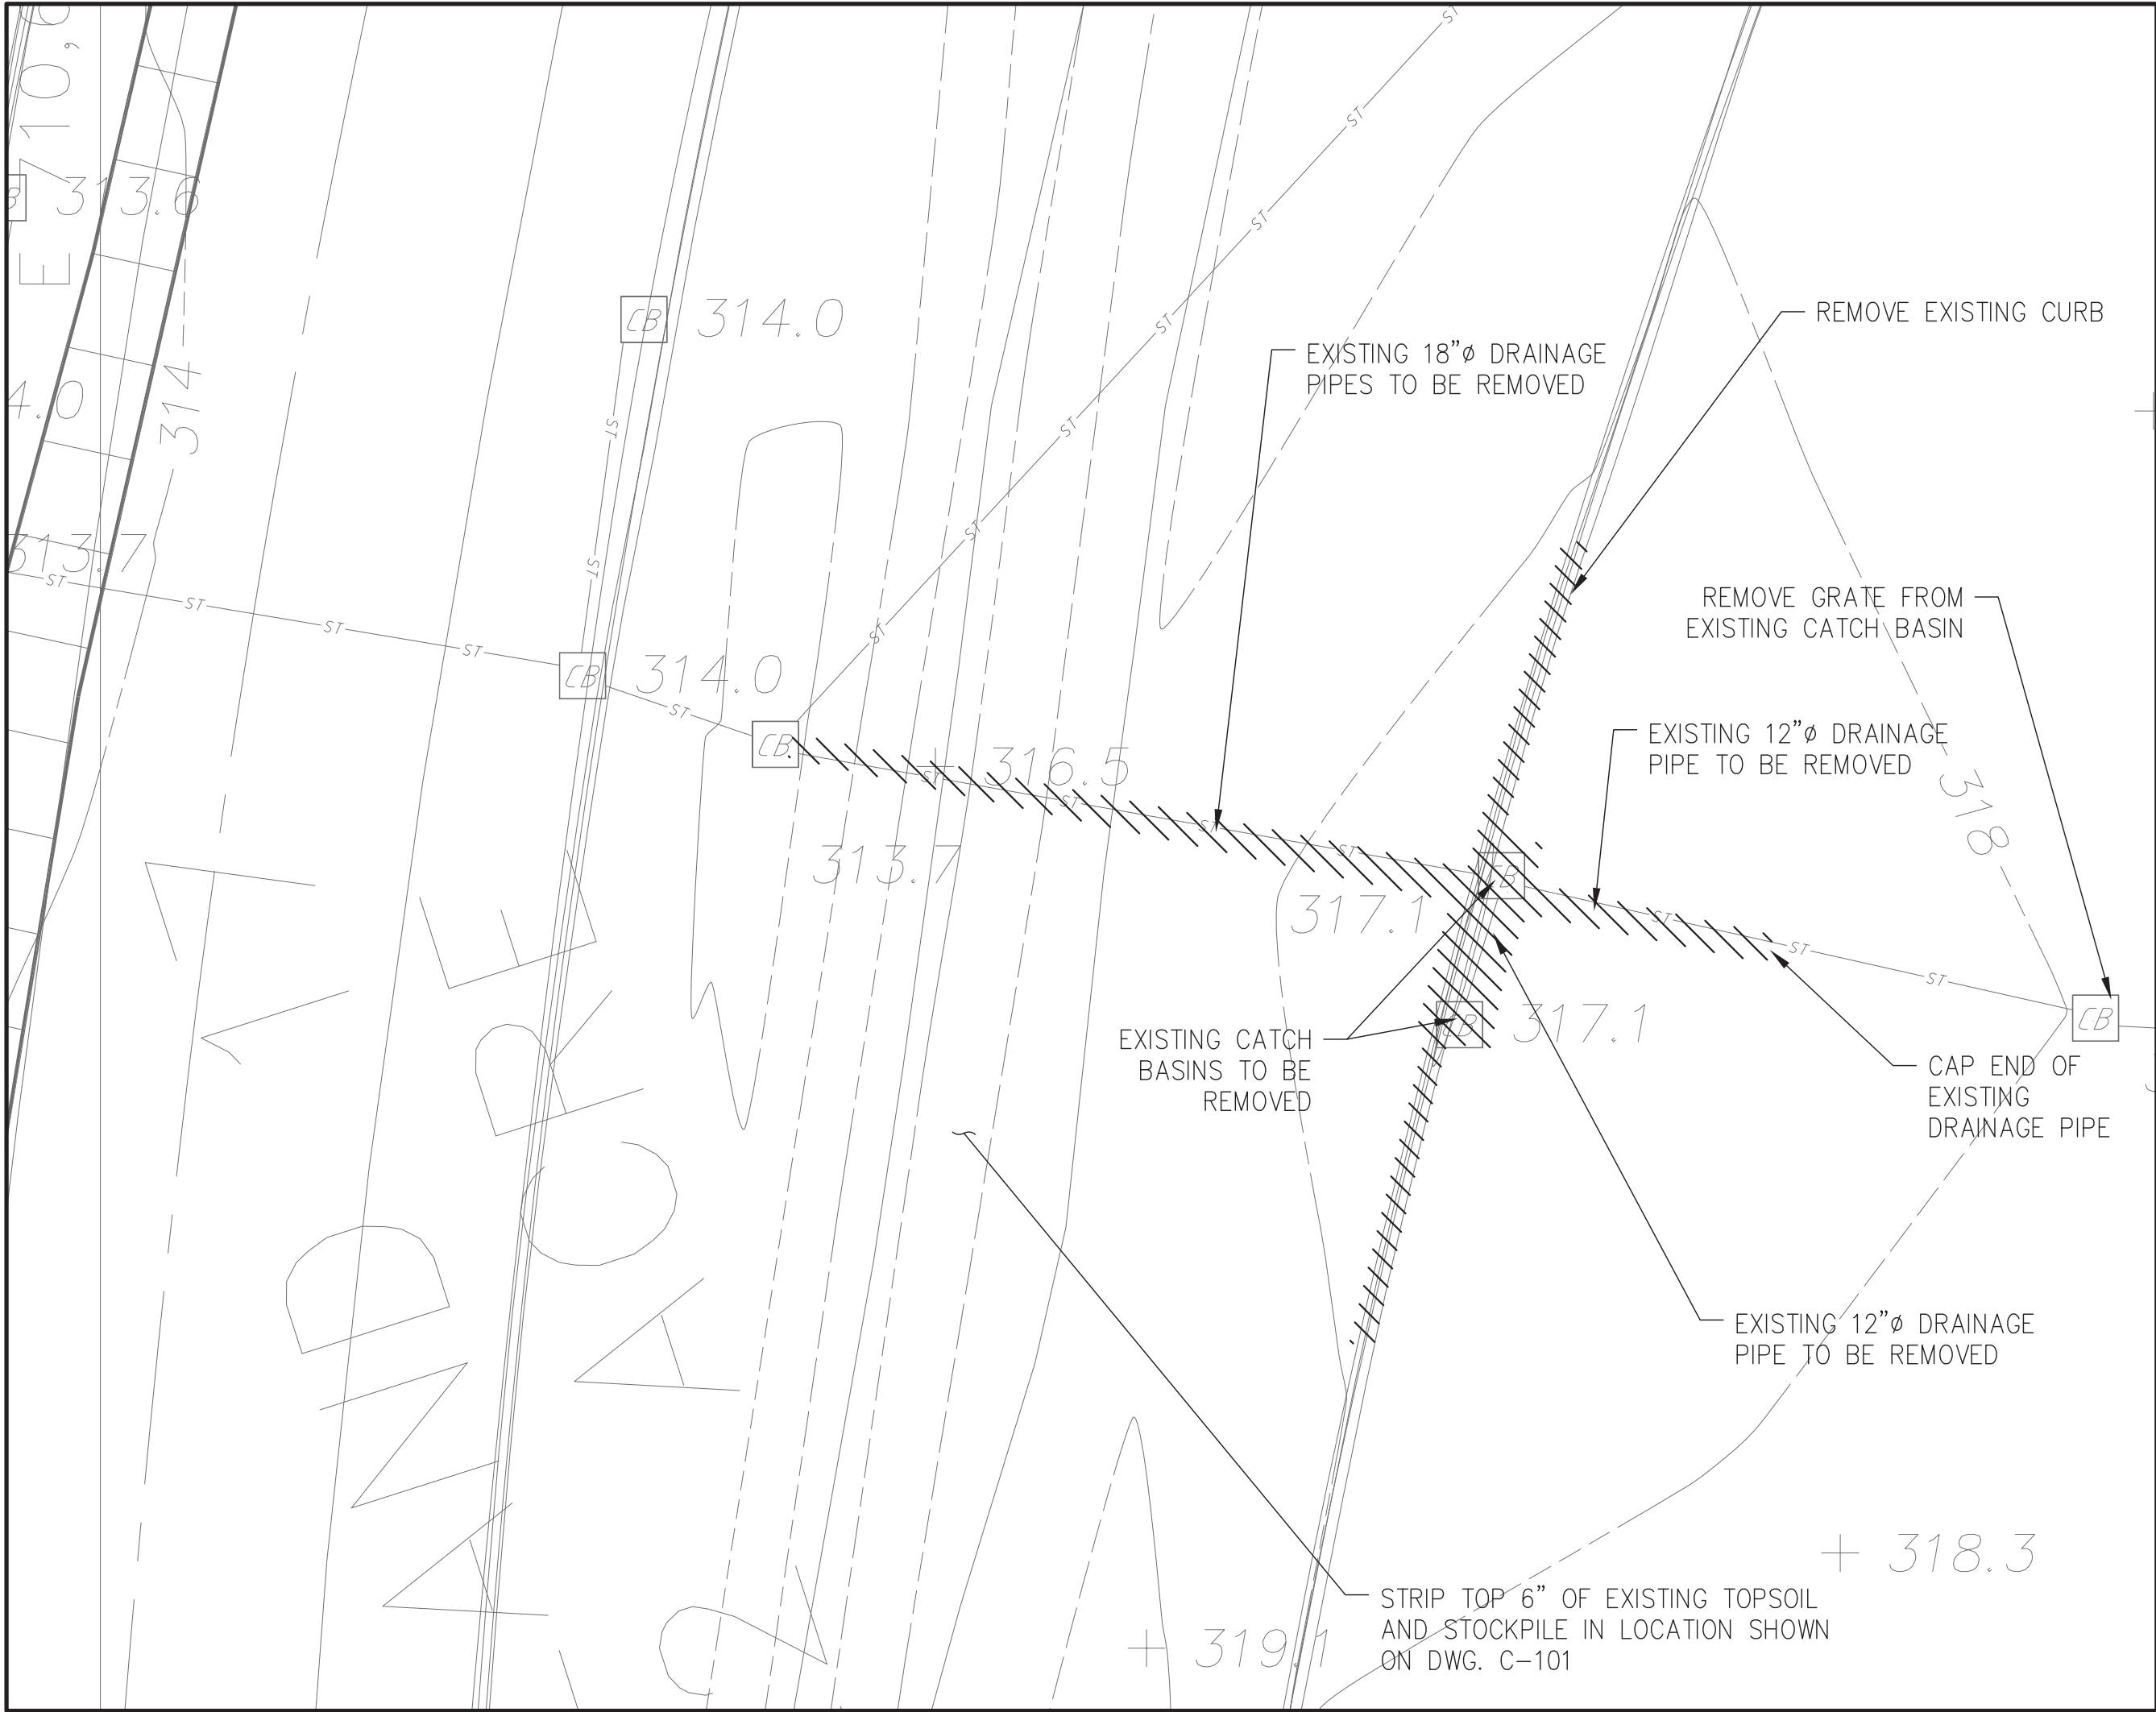

N2 PLAN
SCALE: 1" = 10'-0"

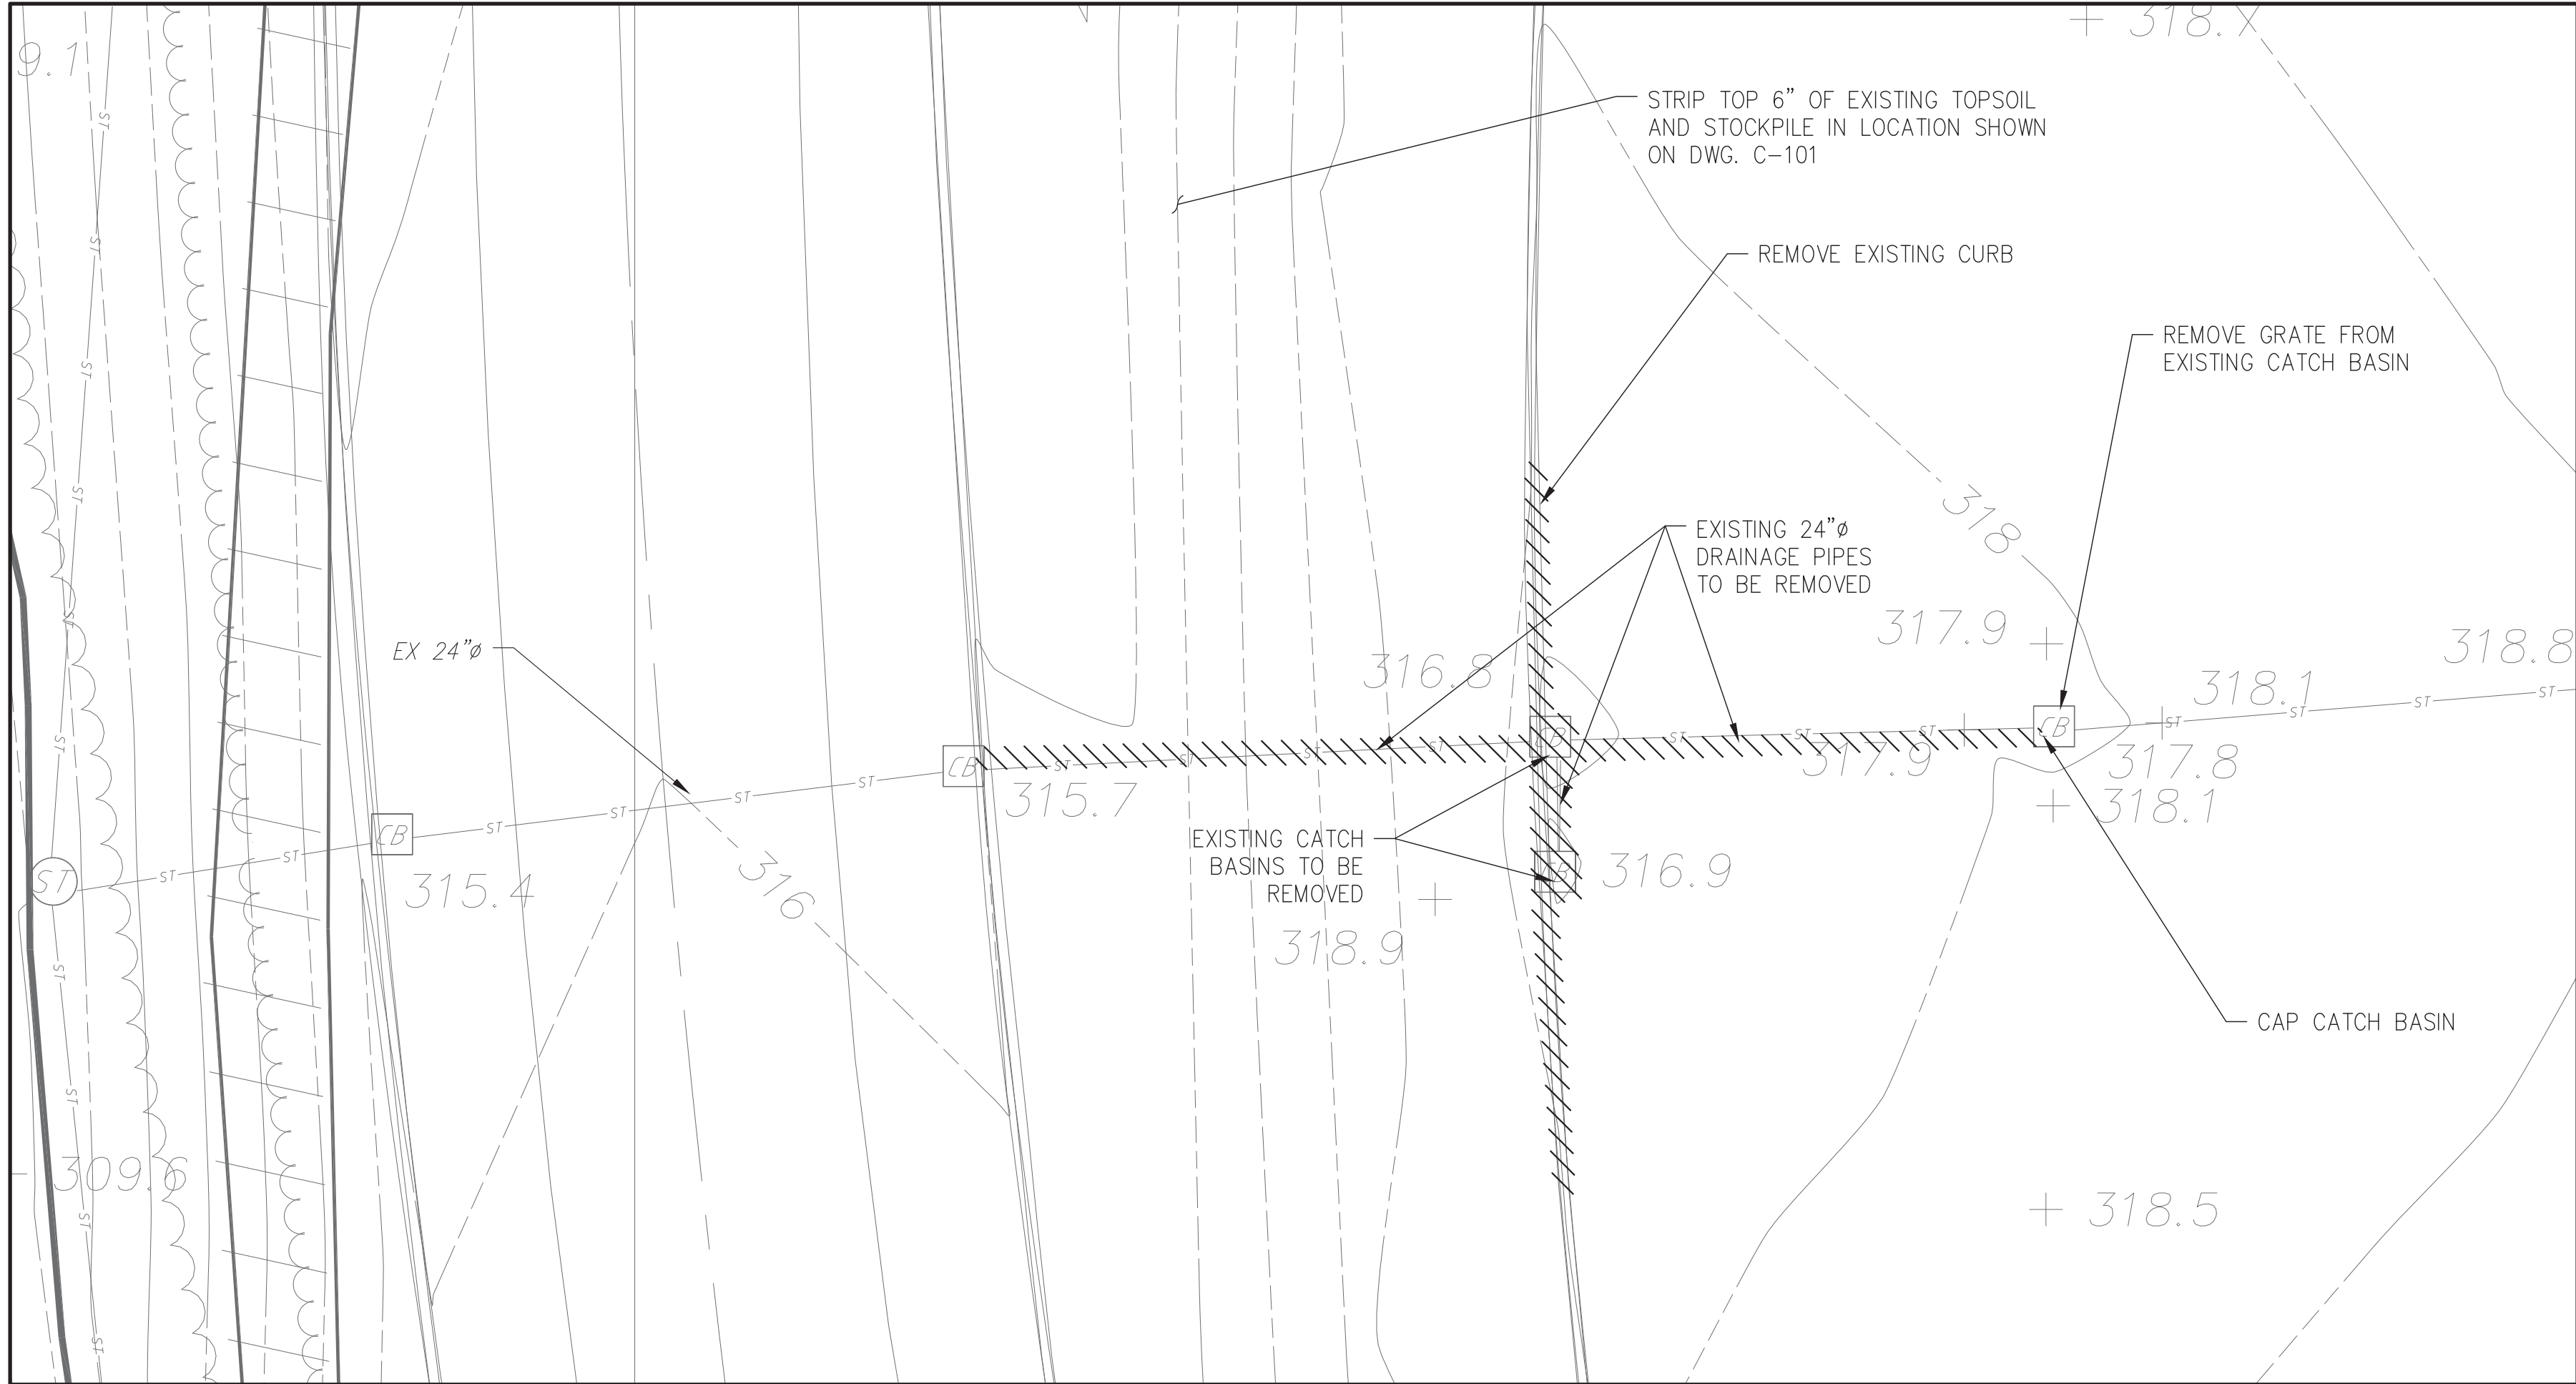

N3 PLAN
SCALE: 1" = 10'-0"

0 2.5 5 10 20
SCALE: 1" = 10'-0"



ANDROPOGON
ASSOCIATES, LTD
10 SHURS LANE
PHILADELPHIA, PA 19127
T: 215.487.0700
P: 215.483.7520
W: www.andropogon.com

PURCHASE COLLEGE GREEN INFRASTRUCTURE

PURCHASE COLLEGE
735 ANDERSON HILL ROAD
PURCHASE, NY 10577

LU ENGINEERS
CIVIL ENGINEERING
50 LAKEFRONT BLVD. SUITE 212
BUFFALO, NY 14202
P: 716.849.0982
www.luengineers.com

ATLANTIC TESTING LABORATORIES
GEOTECHNICAL ENGINEERING
251 UPPER NORTH ROAD
HIGHLAND, NY 12528
P: 845.691.6098
www.atlantictesting.com

REV.	DATE	DESCRIPTION
------	------	-------------

REV.	DATE	DESCRIPTION



SCALE:	AS SHOWN
DATE:	07.06.2018
DRAWN BY:	PMB
CHECKED BY:	TJN
APPROVED BY:	KDW

AA PROJECT #:	150024
PROJECT PHASE:	100% CONTRACT DOCUMENTS


DRAWING TITLE:

DEMO PLAN - NORTH


SHEET:

C-111


DRAWING FILE PATH: Z:\PROJECTS\50384 ANDROPOGON ASSOCIATES, LTD\50384-01 GREEN INFRASTRUCTURE-SUNY PURCHASE\CAD\CDD DESIGN\50384-01_NAS DEMO PLAN.DWG
DATE MODIFIED: 7/18/2018

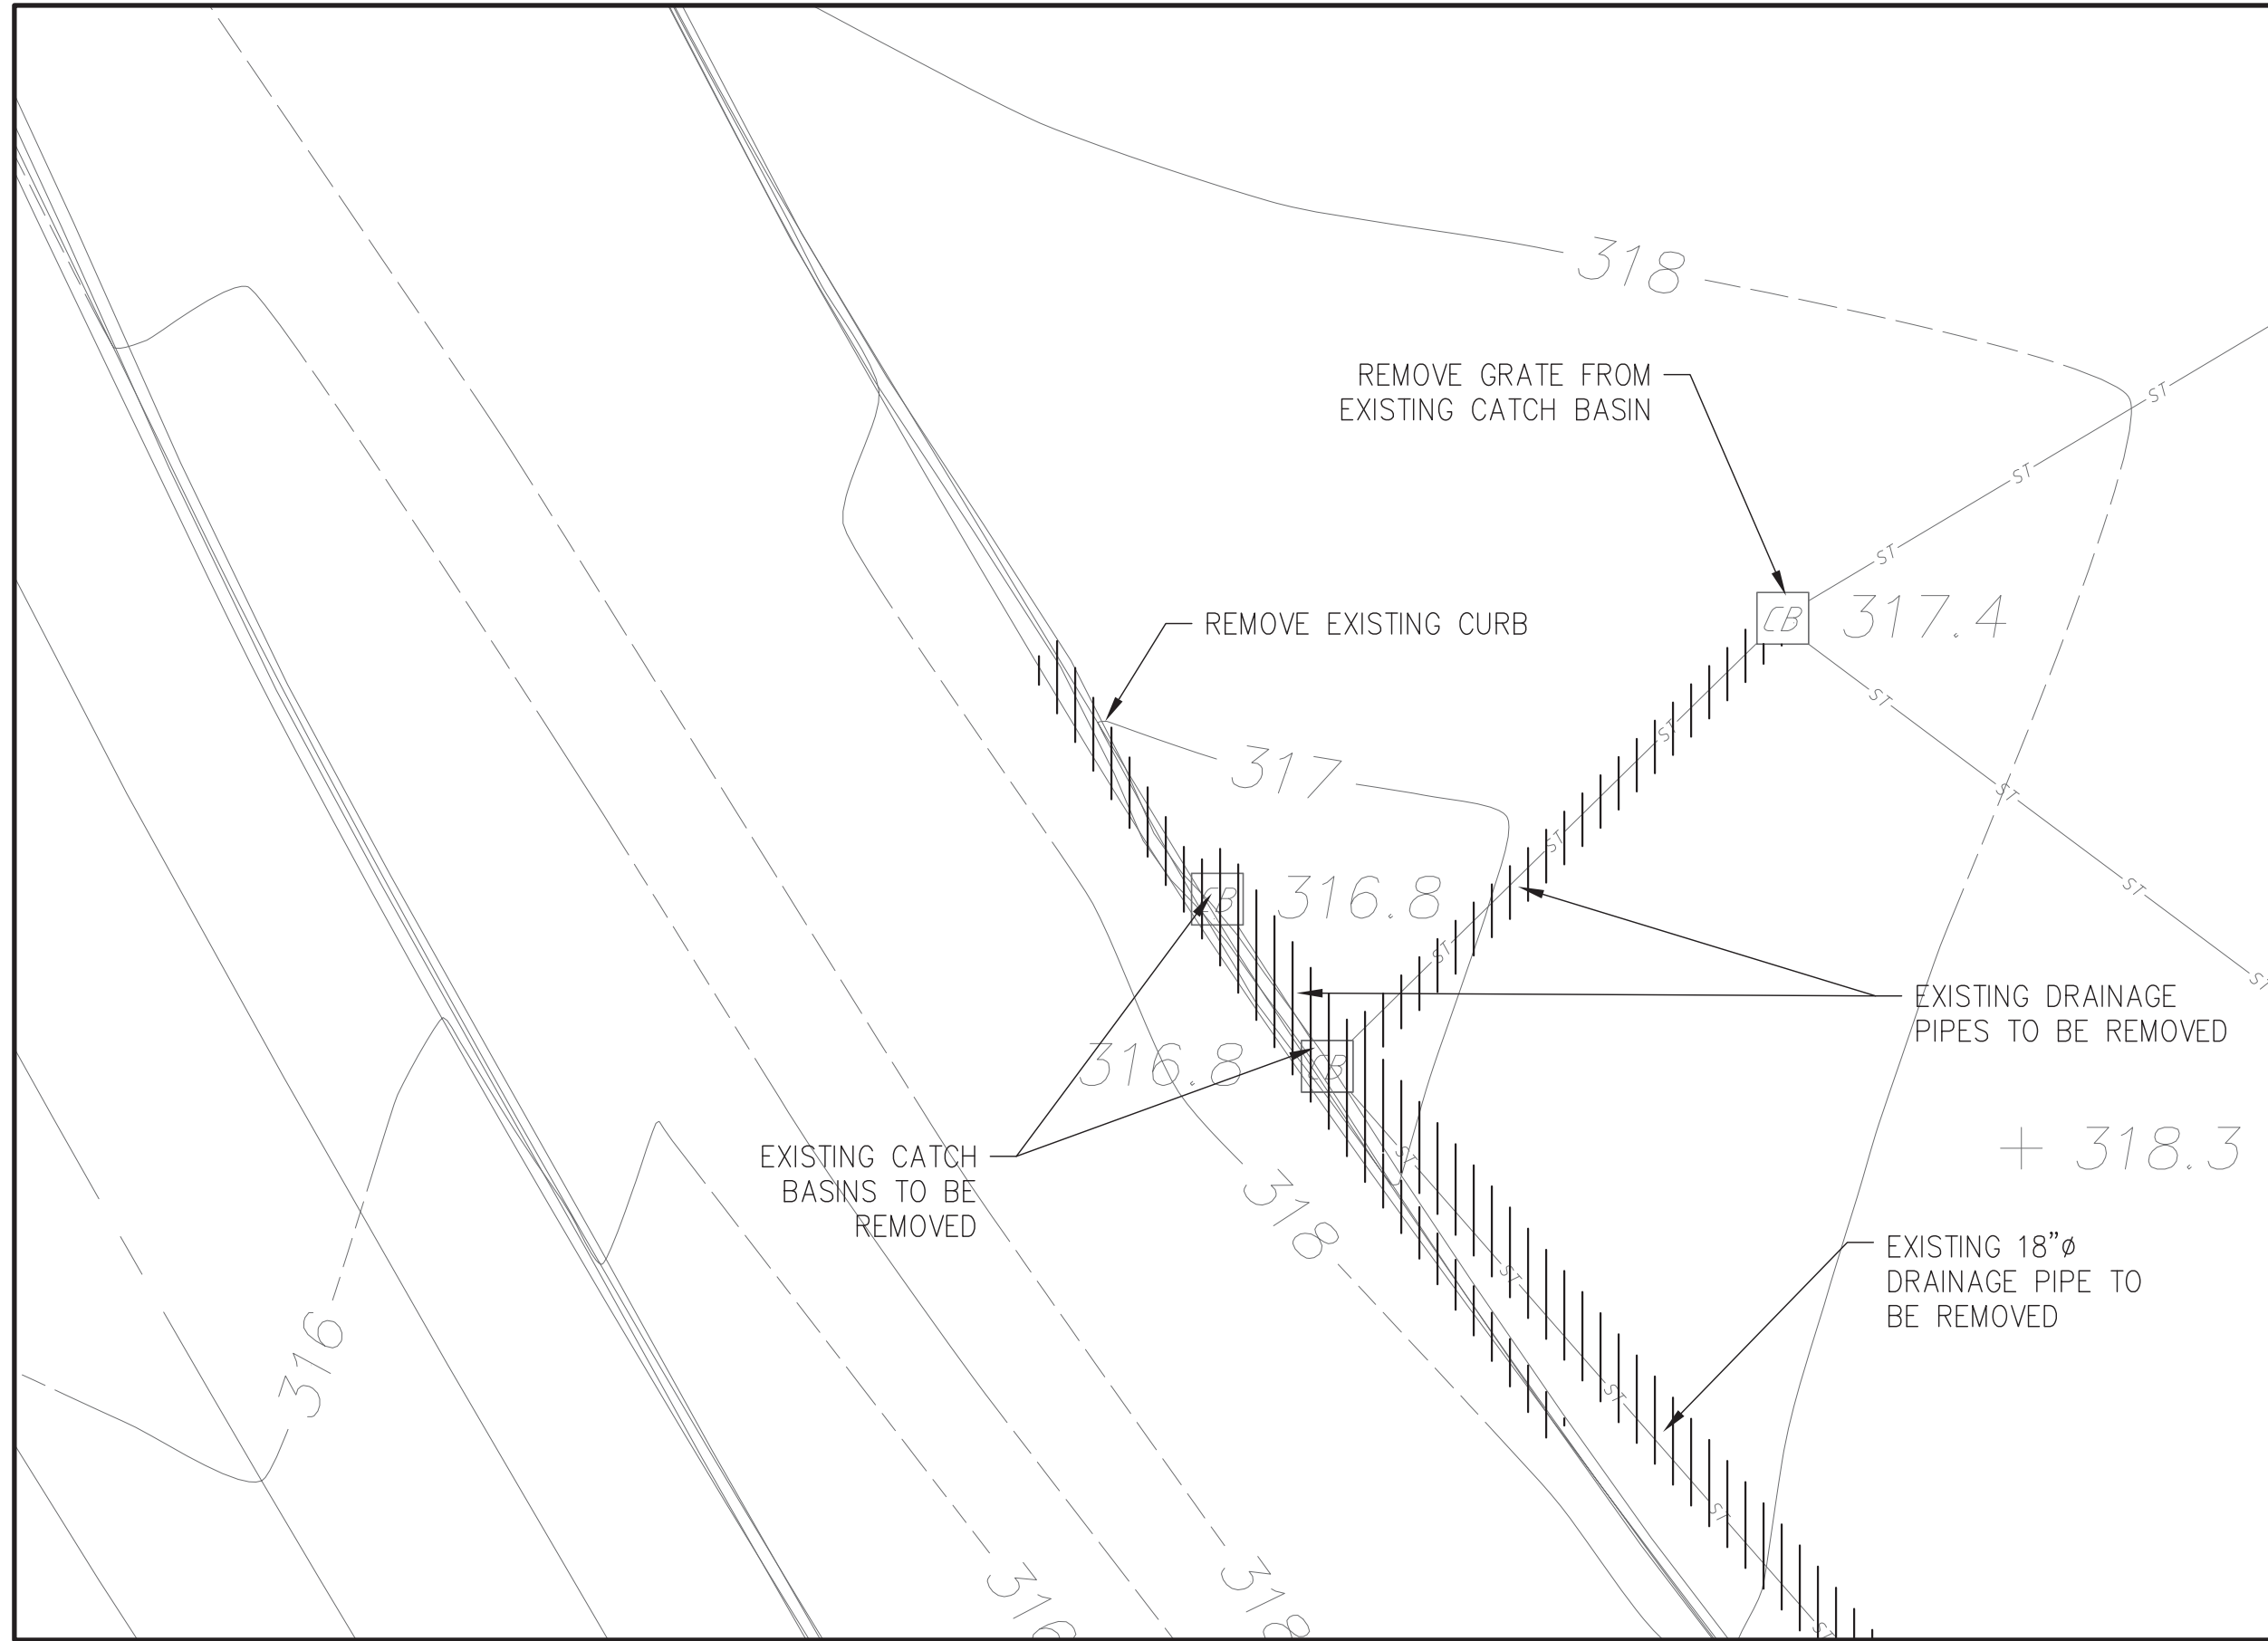


S1 PLAN
SCALE: 1" = 10'-0"

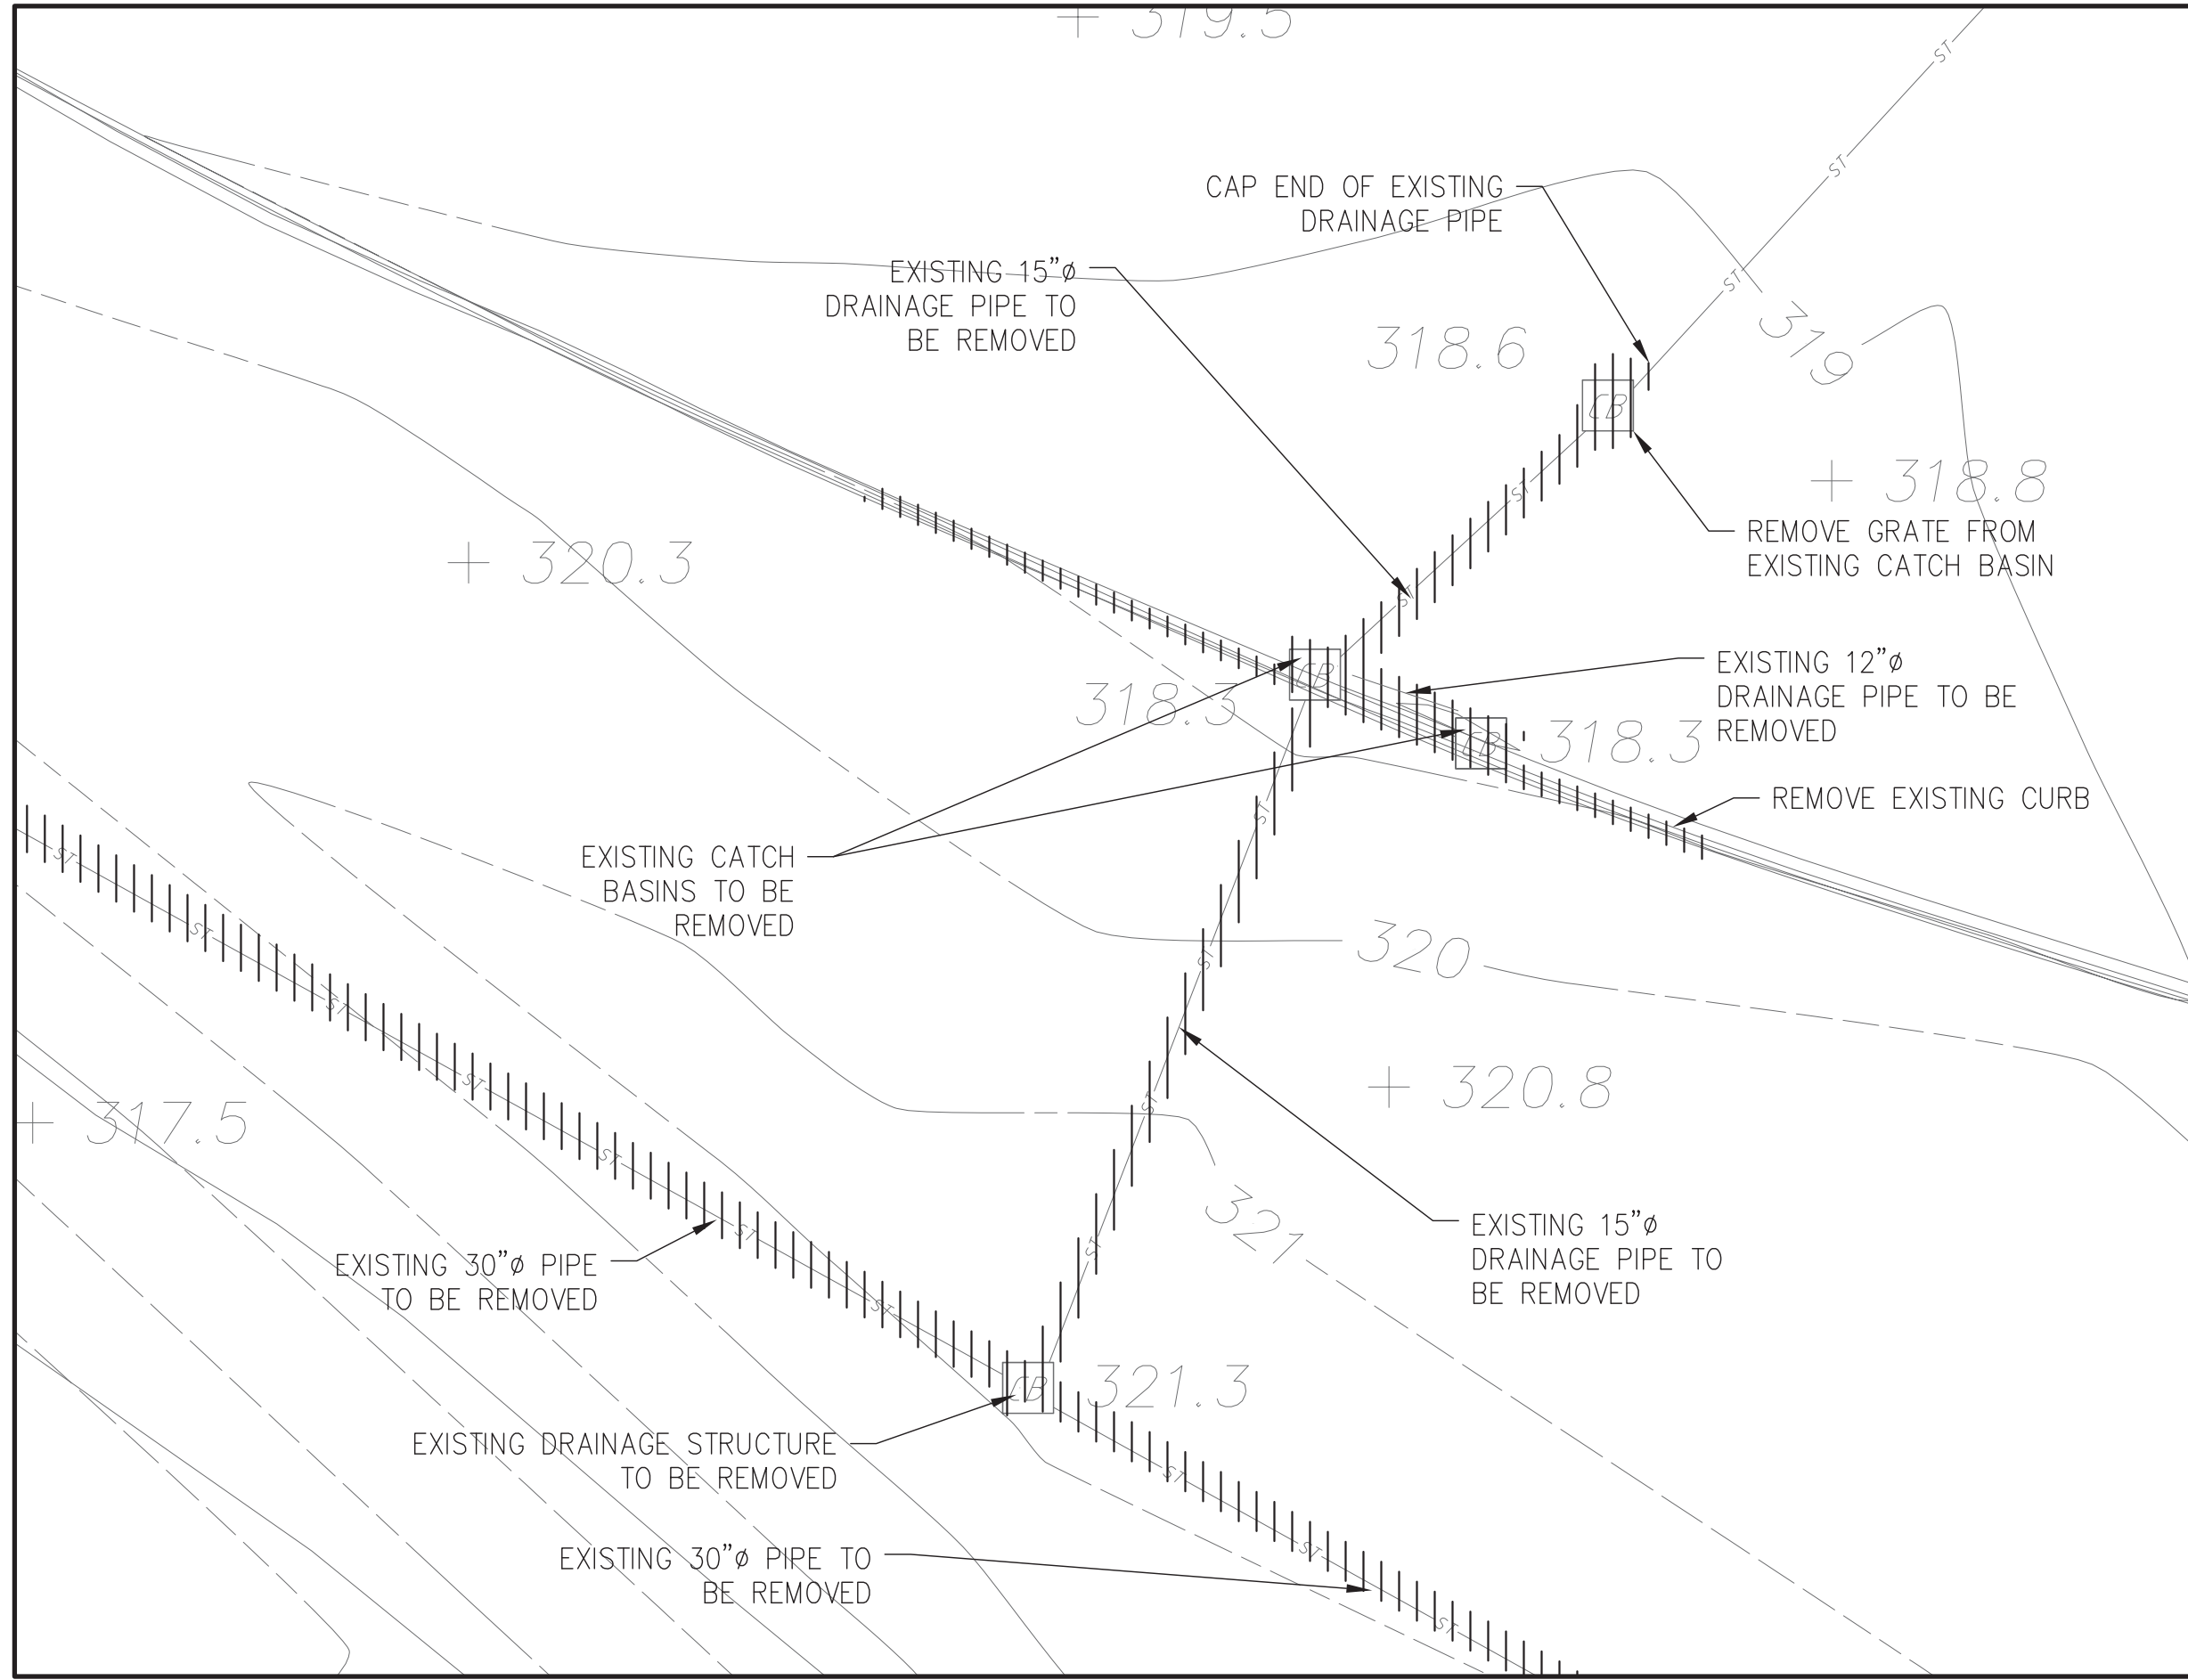


S3 PLAN
SCALE: 1" = 10'-0"

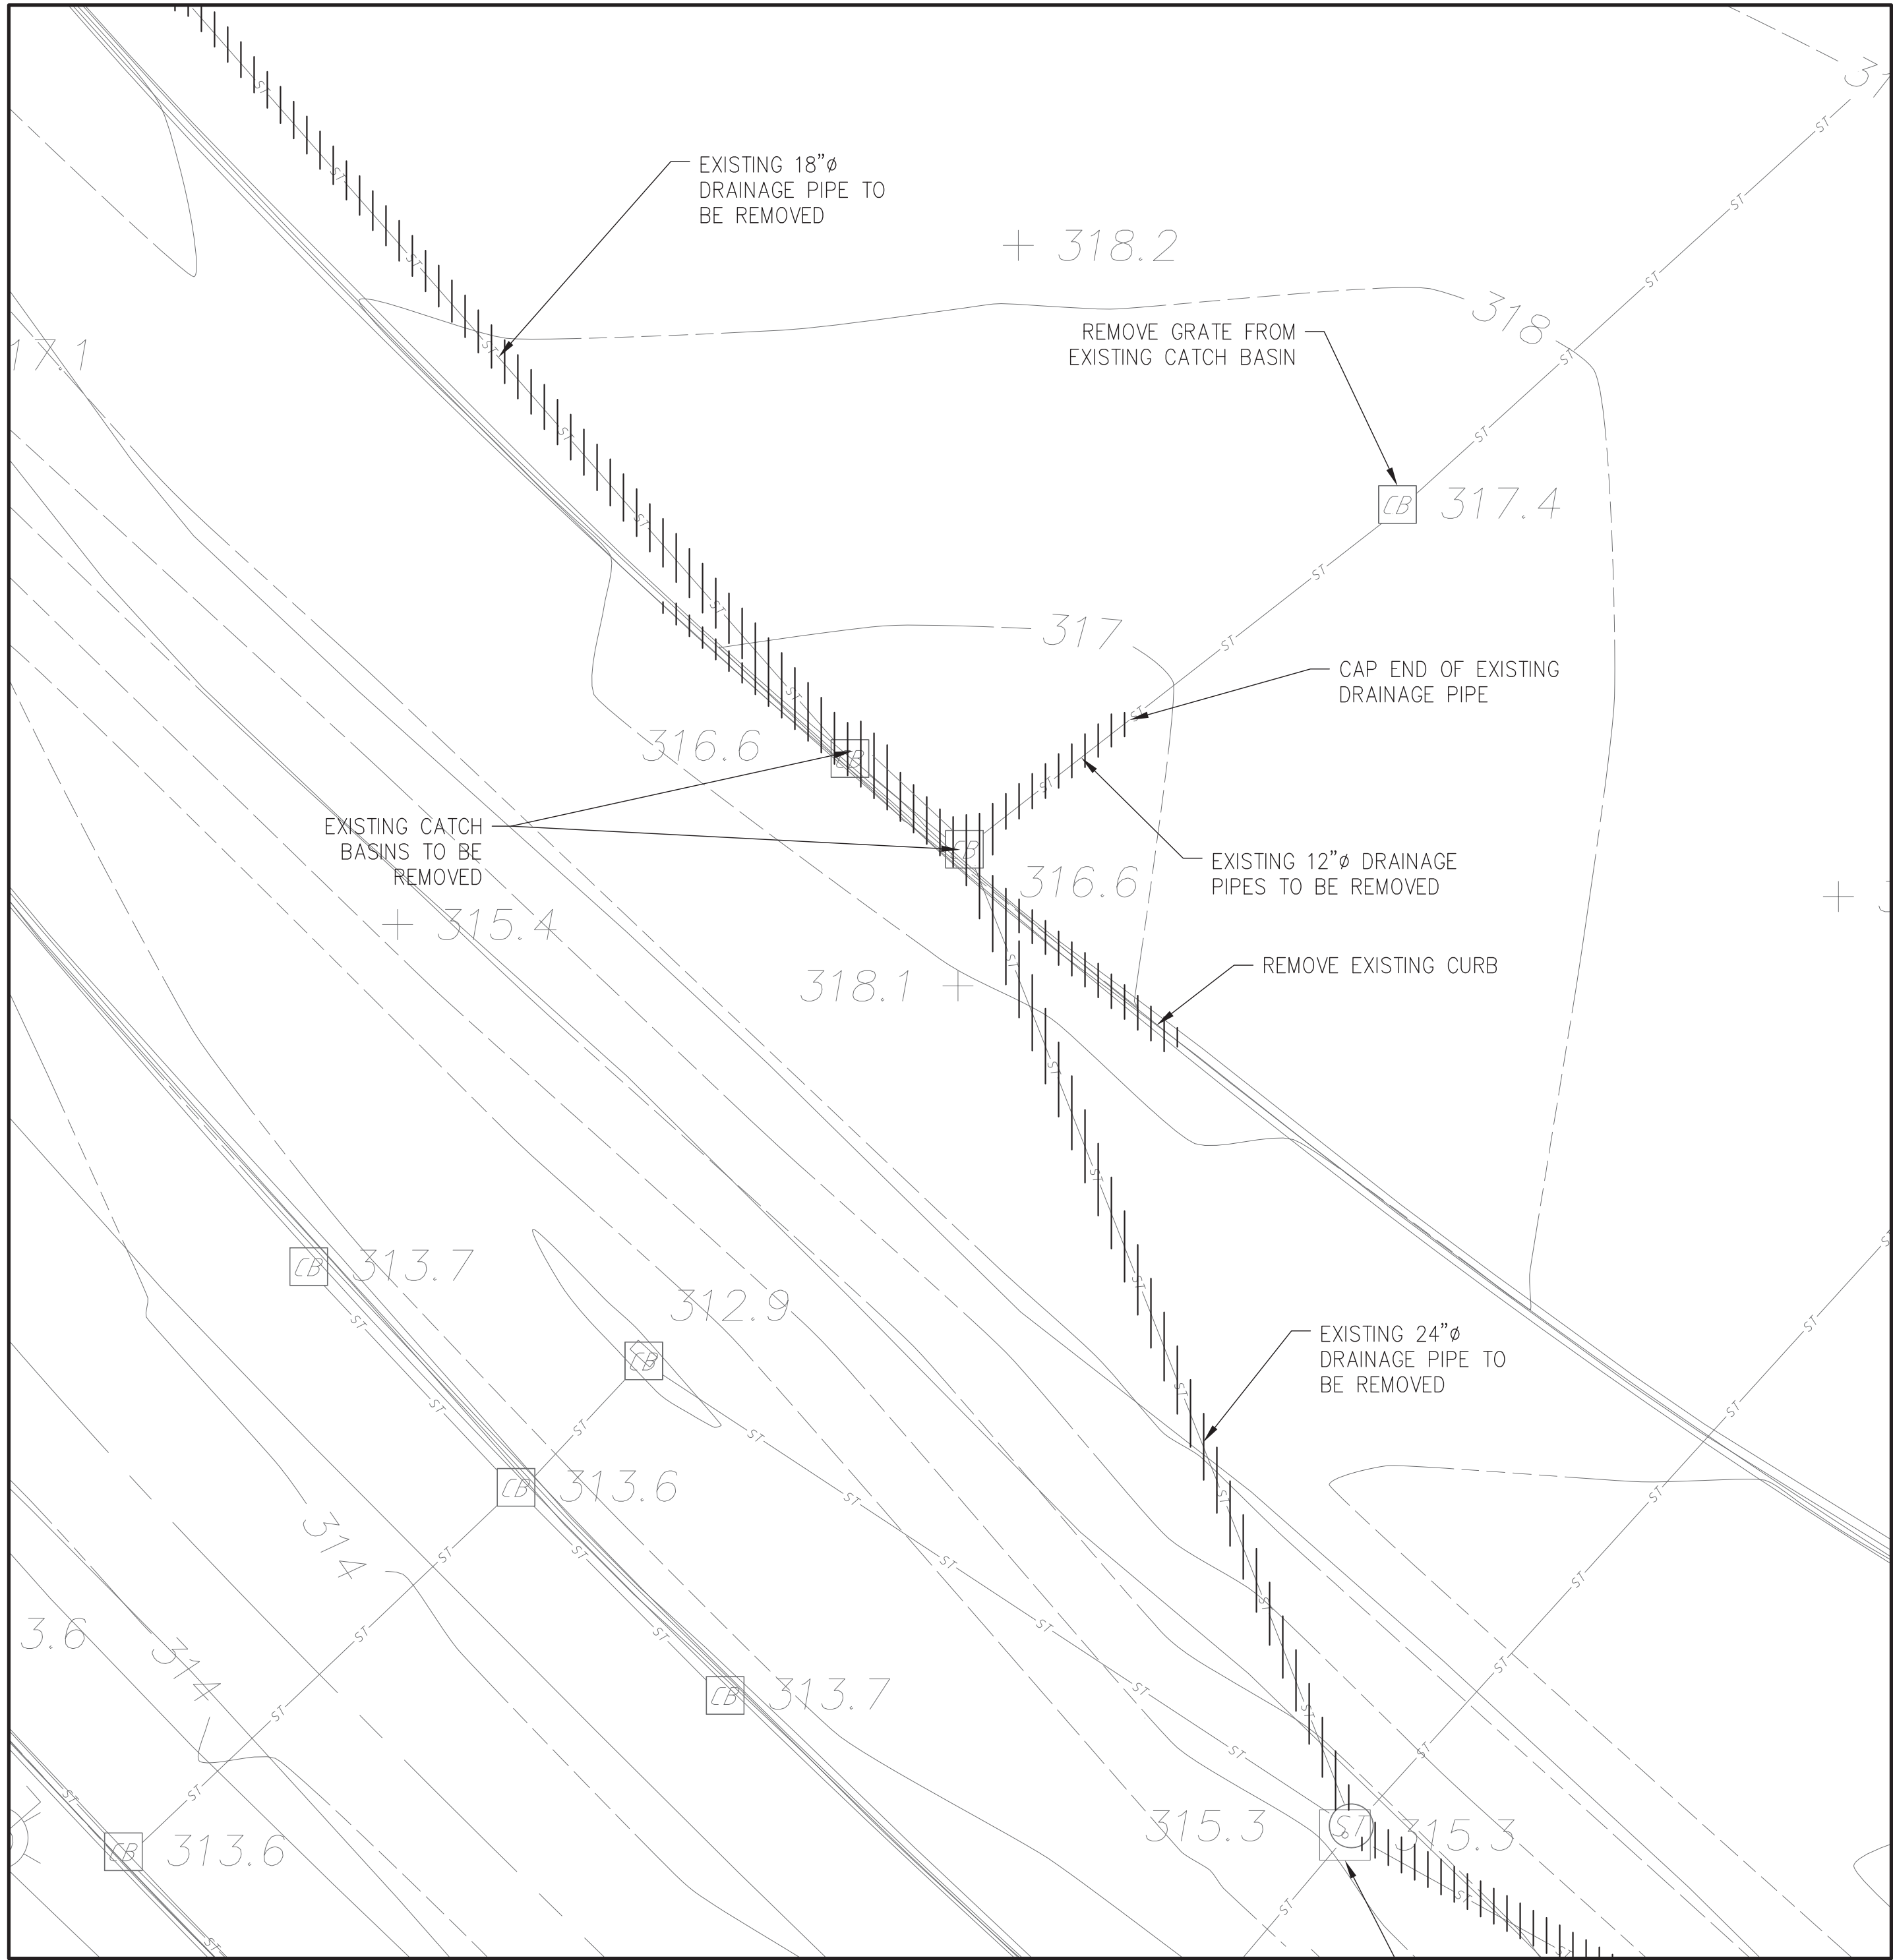

S2 PLAN
SCALE: 1" = 10'-0"

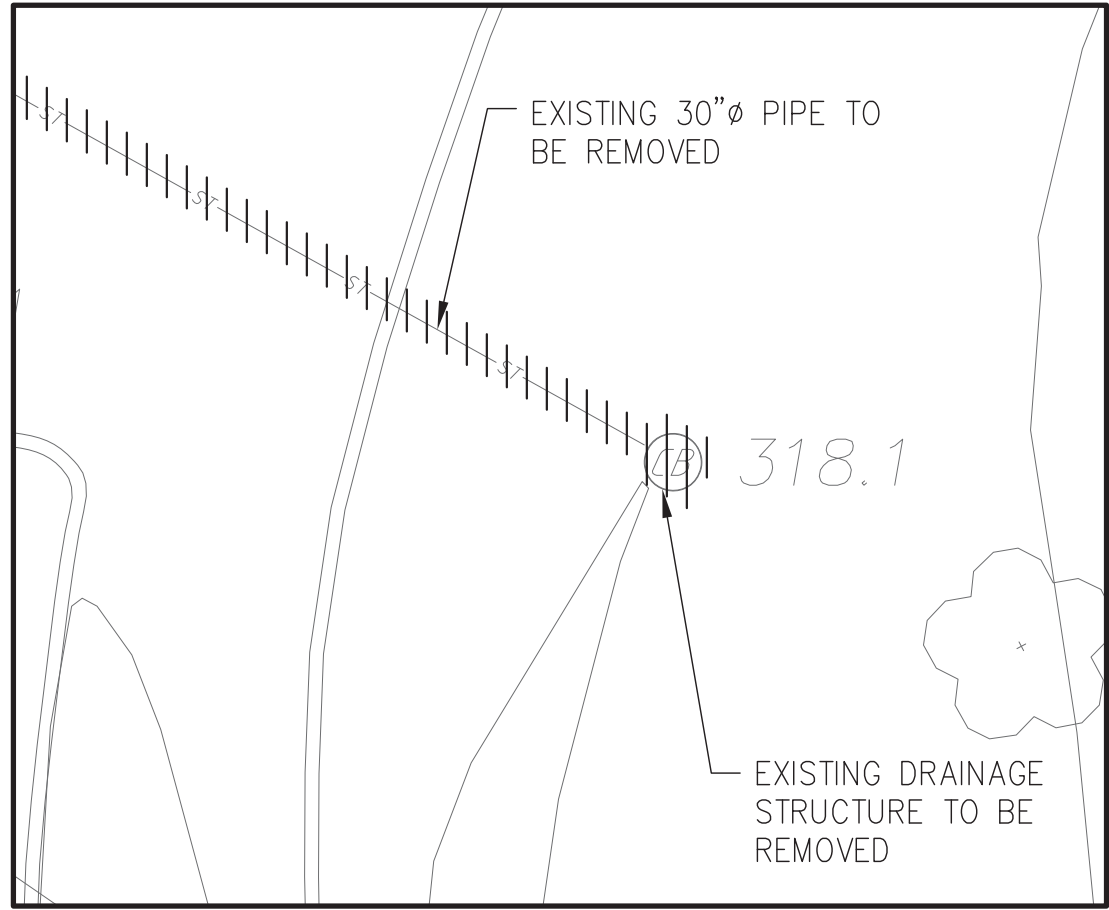

S4 PLAN
SCALE: 1" = 10'-0"

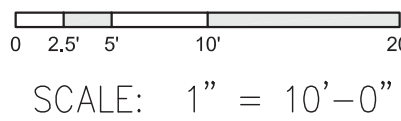

ANDROPOGON
ASSOCIATES, LTD
10 SHURS LANE
PHILADELPHIA, PA 19127
T: 215.487.0700
F: 215.483.7520
W: www.andropogon.com

PURCHASE COLLEGE GREEN INFRASTRUCTURE

PURCHASE COLLEGE
735 ANDERSON HILL ROAD
PURCHASE, NY 10577

LU ENGINEERS
CIVIL ENGINEERING
50 LAKEFRONT BLVD. SUITE 212
BUFFALO, NY 14202
P: 716.849.0982
www.luengineers.com

ATLANTIC TESTING LABORATORIES
GEOTECHNICAL ENGINEERING
251 UPPER NORTH ROAD
HIGHLAND, NY 12528
P: 845.691.6098
www.atlantictesting.com

REV.	DATE	DESCRIPTION



SCALE:	AS SHOWN
DATE:	07.06.2018
DRAWN BY:	PMB
CHECKED BY:	TJN
APPROVED BY:	KDW

AA PROJECT #:	150024
PROJECT PHASE:	100% CONTRACT DOCUMENTS


DRAWING TITLE:

DEMO PLAN - SOUTH

SHEET:

C-112

DRAWING FILE PATH: Z:\PROJECTS\50384 ANDROPOGON ASSOCIATES, LTD\50384-01 GREEN INFRASTRUCTURE-SUNY PURCHASE\CAD\CD DESIGN\50384-01_N&S PROP PLAN.DWG
DATE MODIFIED: 7/18/2018

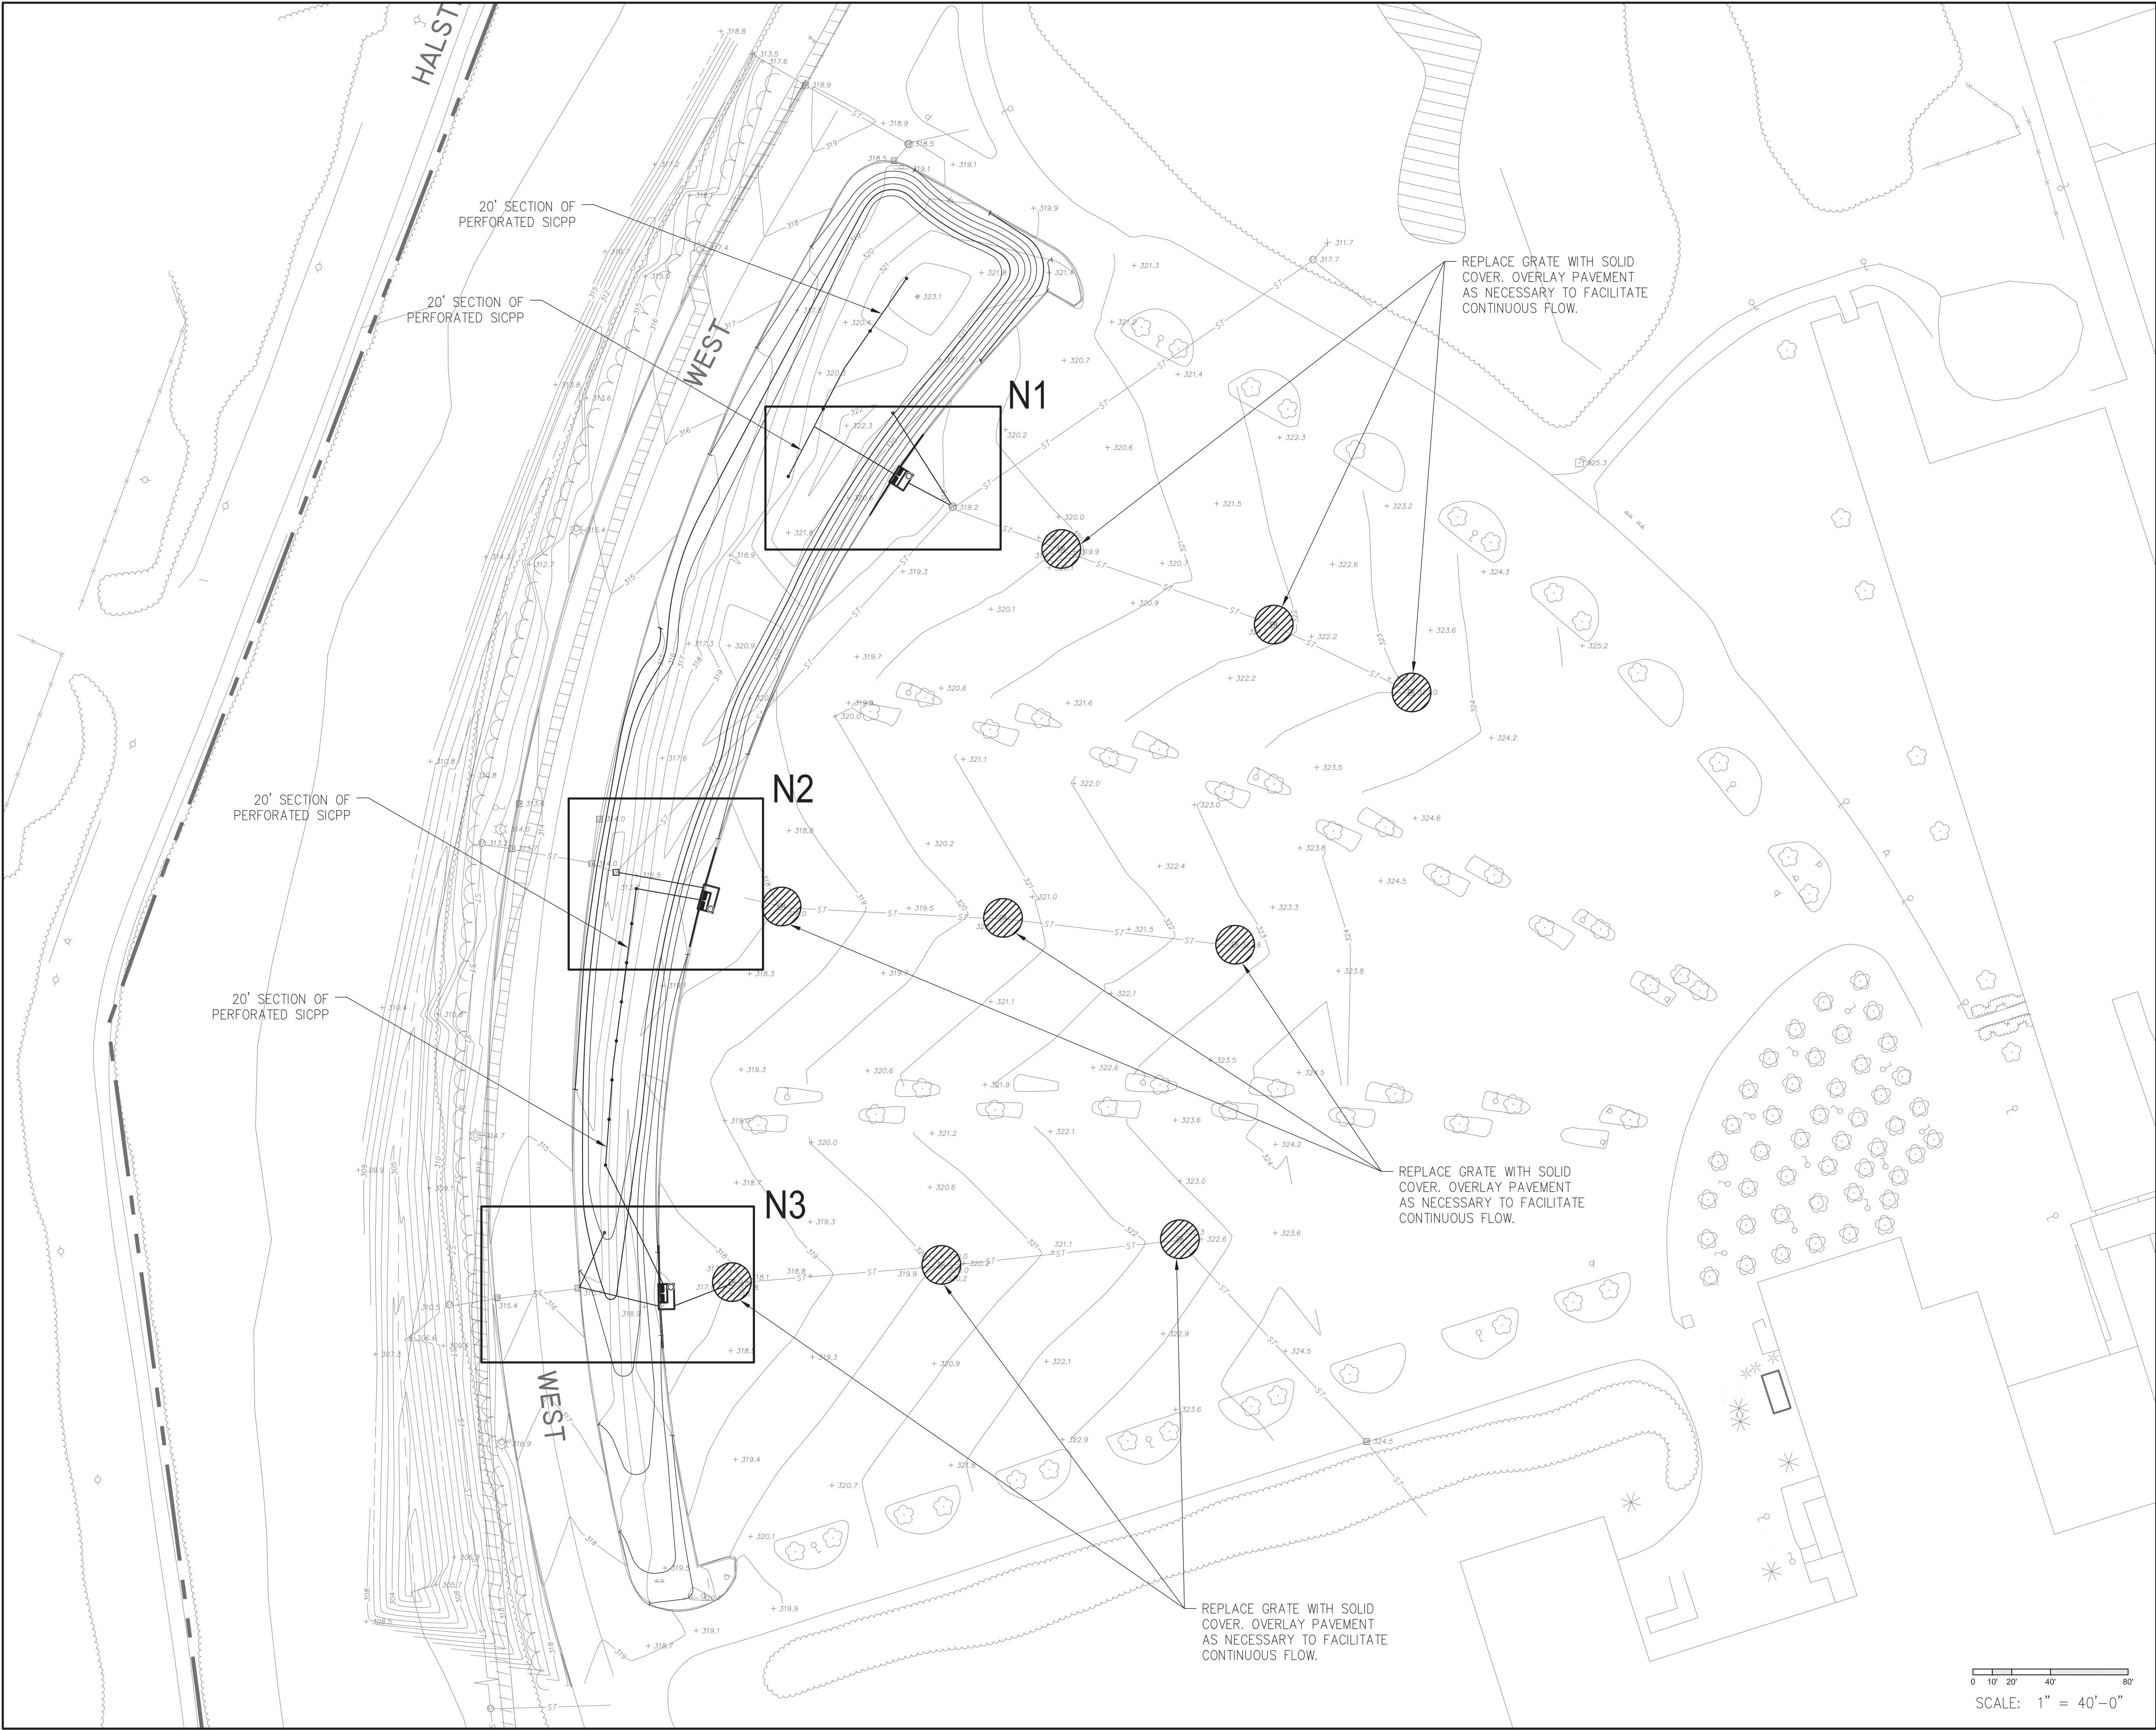

PROPOSED NORTH LOT PLAN
SCALE: 1" = 40'-0"



ANDROPOGON
ASSOCIATES, LTD
10 SHURS LANE
PHILADELPHIA, PA 19127
T: 215.487.0700
F: 215.483.7520
W: www.andropogon.com

PURCHASE COLLEGE GREEN INFRASTRUCTURE

PURCHASE COLLEGE
735 ANDERSON HILL ROAD
PURCHASE, NY 10577

LU ENGINEERS
CIVIL ENGINEERING
50 LAKEFRONT BLVD. SUITE 212
BUFFALO, NY 14202
P: 716.849.0982
www.luengineers.com

ATLANTIC TESTING LABORATORIES
GEOTECHNICAL ENGINEERING
251 UPPER NORTH ROAD
HIGHLAND, NY 12528
P: 845.691.6098
www.atlantictesting.com

REV.	DATE	DESCRIPTION
------	------	-------------



SCALE:	AS SHOWN
DATE:	07.06.2018
DRAWN BY:	PMB
CHECKED BY:	TJN
APPROVED BY:	KDW

AA PROJECT #:	150024
PROJECT PHASE:	100% CONTRACT DOCUMENTS


DRAWING TITLE:

GEN PLAN - NORTH

SHEET:

C-201

DRAWING FILE PATH: Z:\PROJECTS\50384 ANDROPOGON ASSOCIATES, LTD\50384-01 GREEN INFRASTRUCTURE-SUNY PURCHASE\CADD\CD DESIGN\50384-01_NAS PROP PLAN.DWG
DATE MODIFIED: 7/18/2018

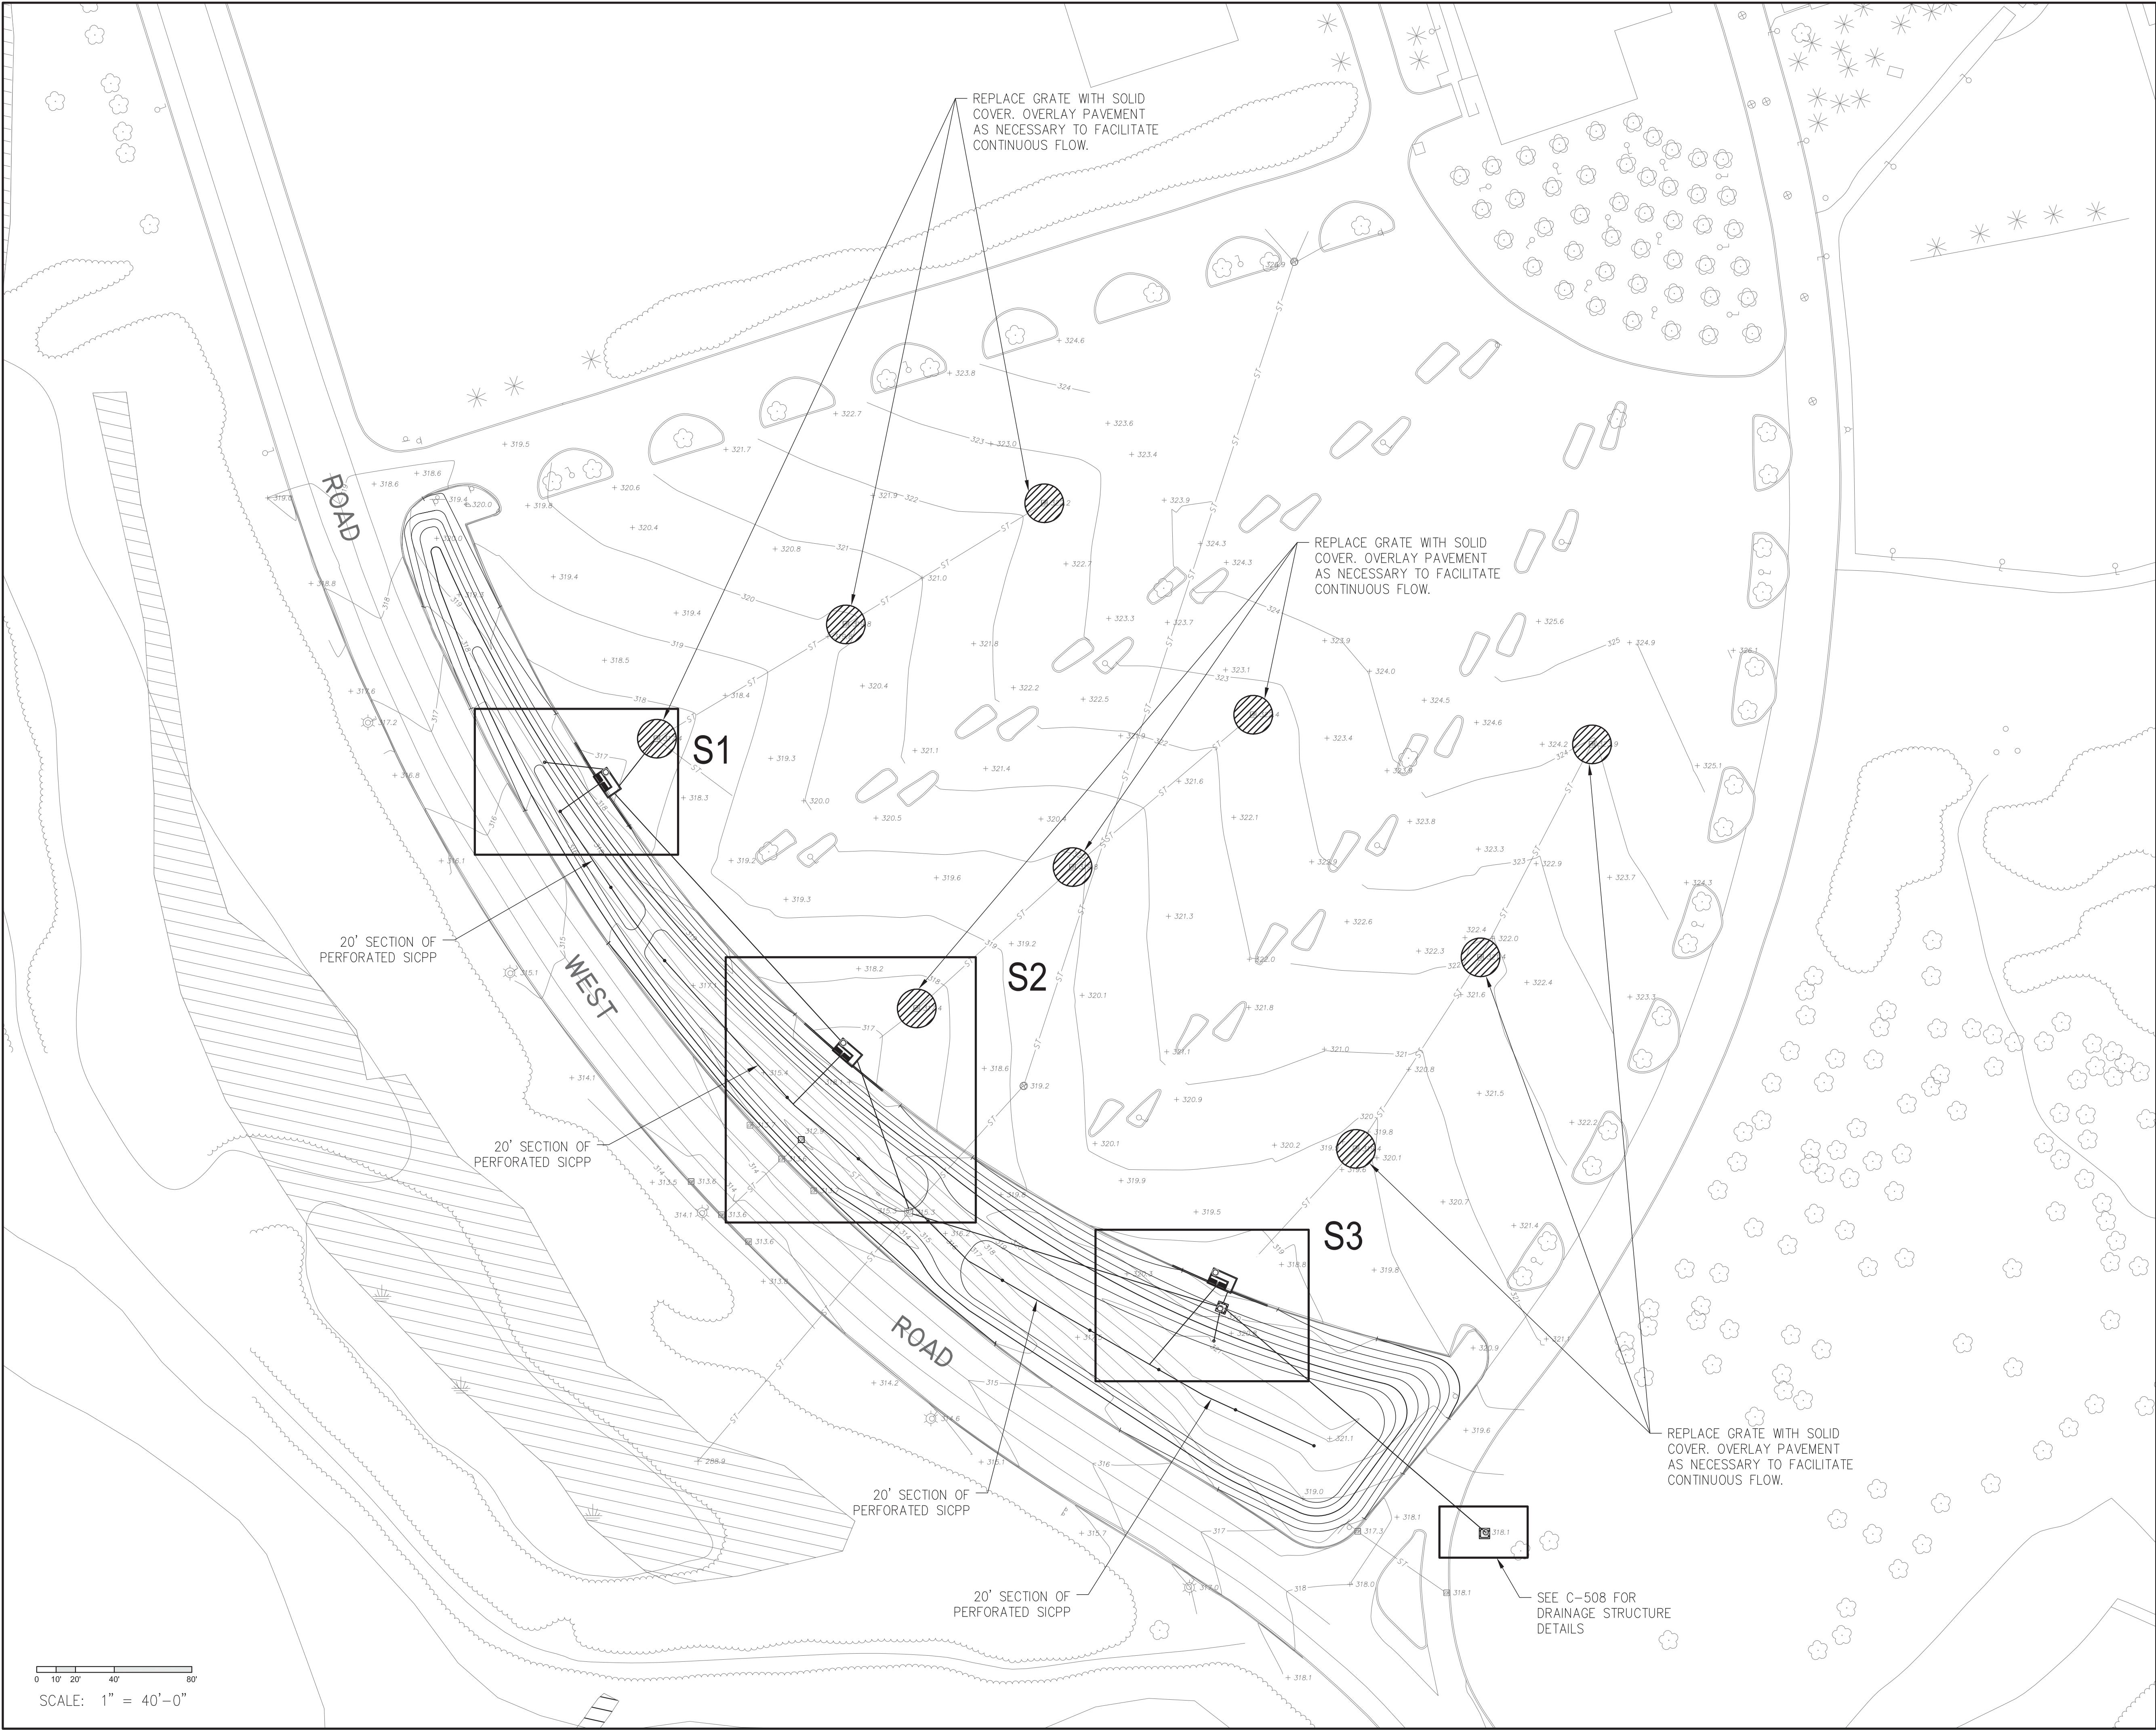

PROPOSED SOUTH LOT PLAN
SCALE: 1" = 40'-0"



ANDROPOGON
ASSOCIATES, LTD
10 SHURS LANE
PHILADELPHIA, PA 19127
T: 215.487.0700
P: 215.483.7520
W: www.andropogon.com

PURCHASE COLLEGE GREEN INFRASTRUCTURE

PURCHASE COLLEGE
735 ANDERSON HILL ROAD
PURCHASE, NY 10577

LU ENGINEERS
CIVIL ENGINEERING
50 LAKEFRONT BLVD. SUITE 212
BUFFALO, NY 14202
P: 716.849.0982
www.luengineers.com

ATLANTIC TESTING LABORATORIES
GEOTECHNICAL ENGINEERING
251 UPPER NORTH ROAD
HIGHLAND, NY 12528
P: 845.691.6098
www.atlantictesting.com

REV.	DATE	DESCRIPTION



SCALE:	AS SHOWN
DATE:	07.06.2018
DRAWN BY:	PMB
CHECKED BY:	TJN
APPROVED BY:	KDW

AA PROJECT #:	150024
PROJECT PHASE:	100% CONTRACT DOCUMENTS


DRAWING TITLE:

GEN PLAN - SOUTH


SHEET:

C-202


DRAWING FILE PATH: Z:\PROJECTS\50384 ANDROPOGON ASSOCIATES, LTD\50384-01 GREEN INFRASTRUCTURE-SUNY PURCHASE\CADD\CD DESIGN\50384-01_NAS PROP PLAN.DWG
DATE MODIFIED: 7/18/2018

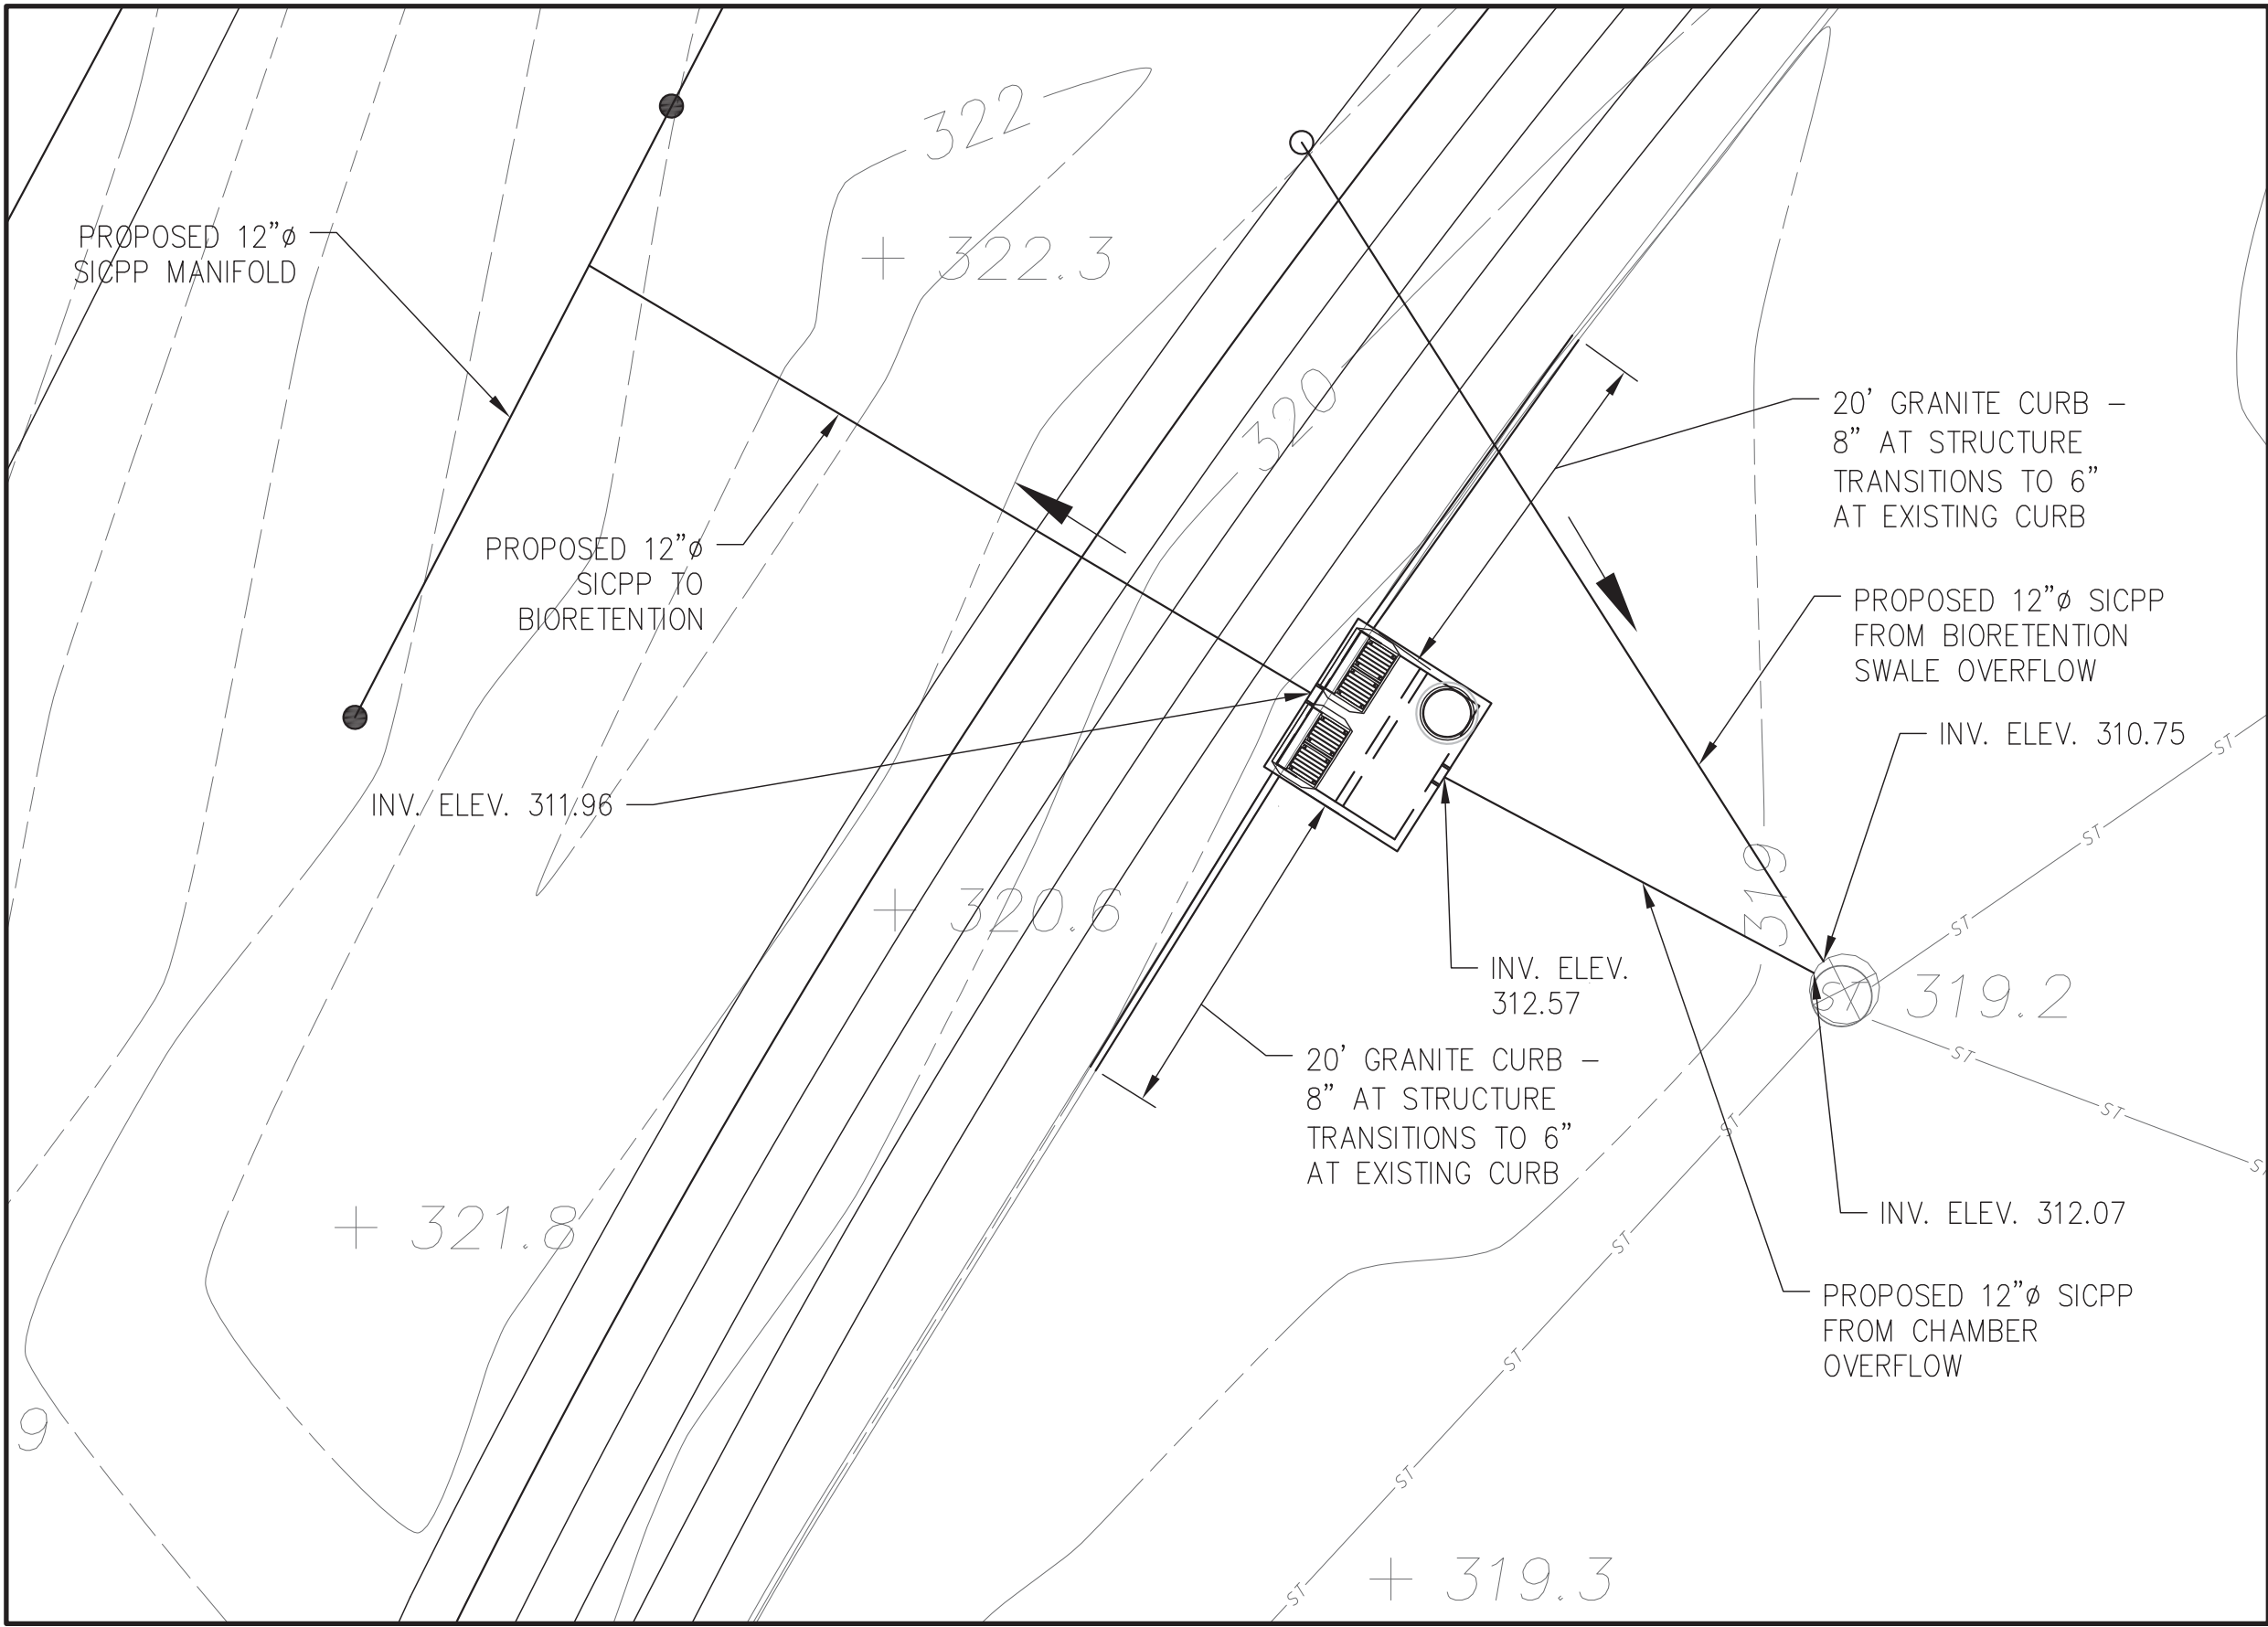


N1 PLAN
SCALE: 1" = 10'-0"

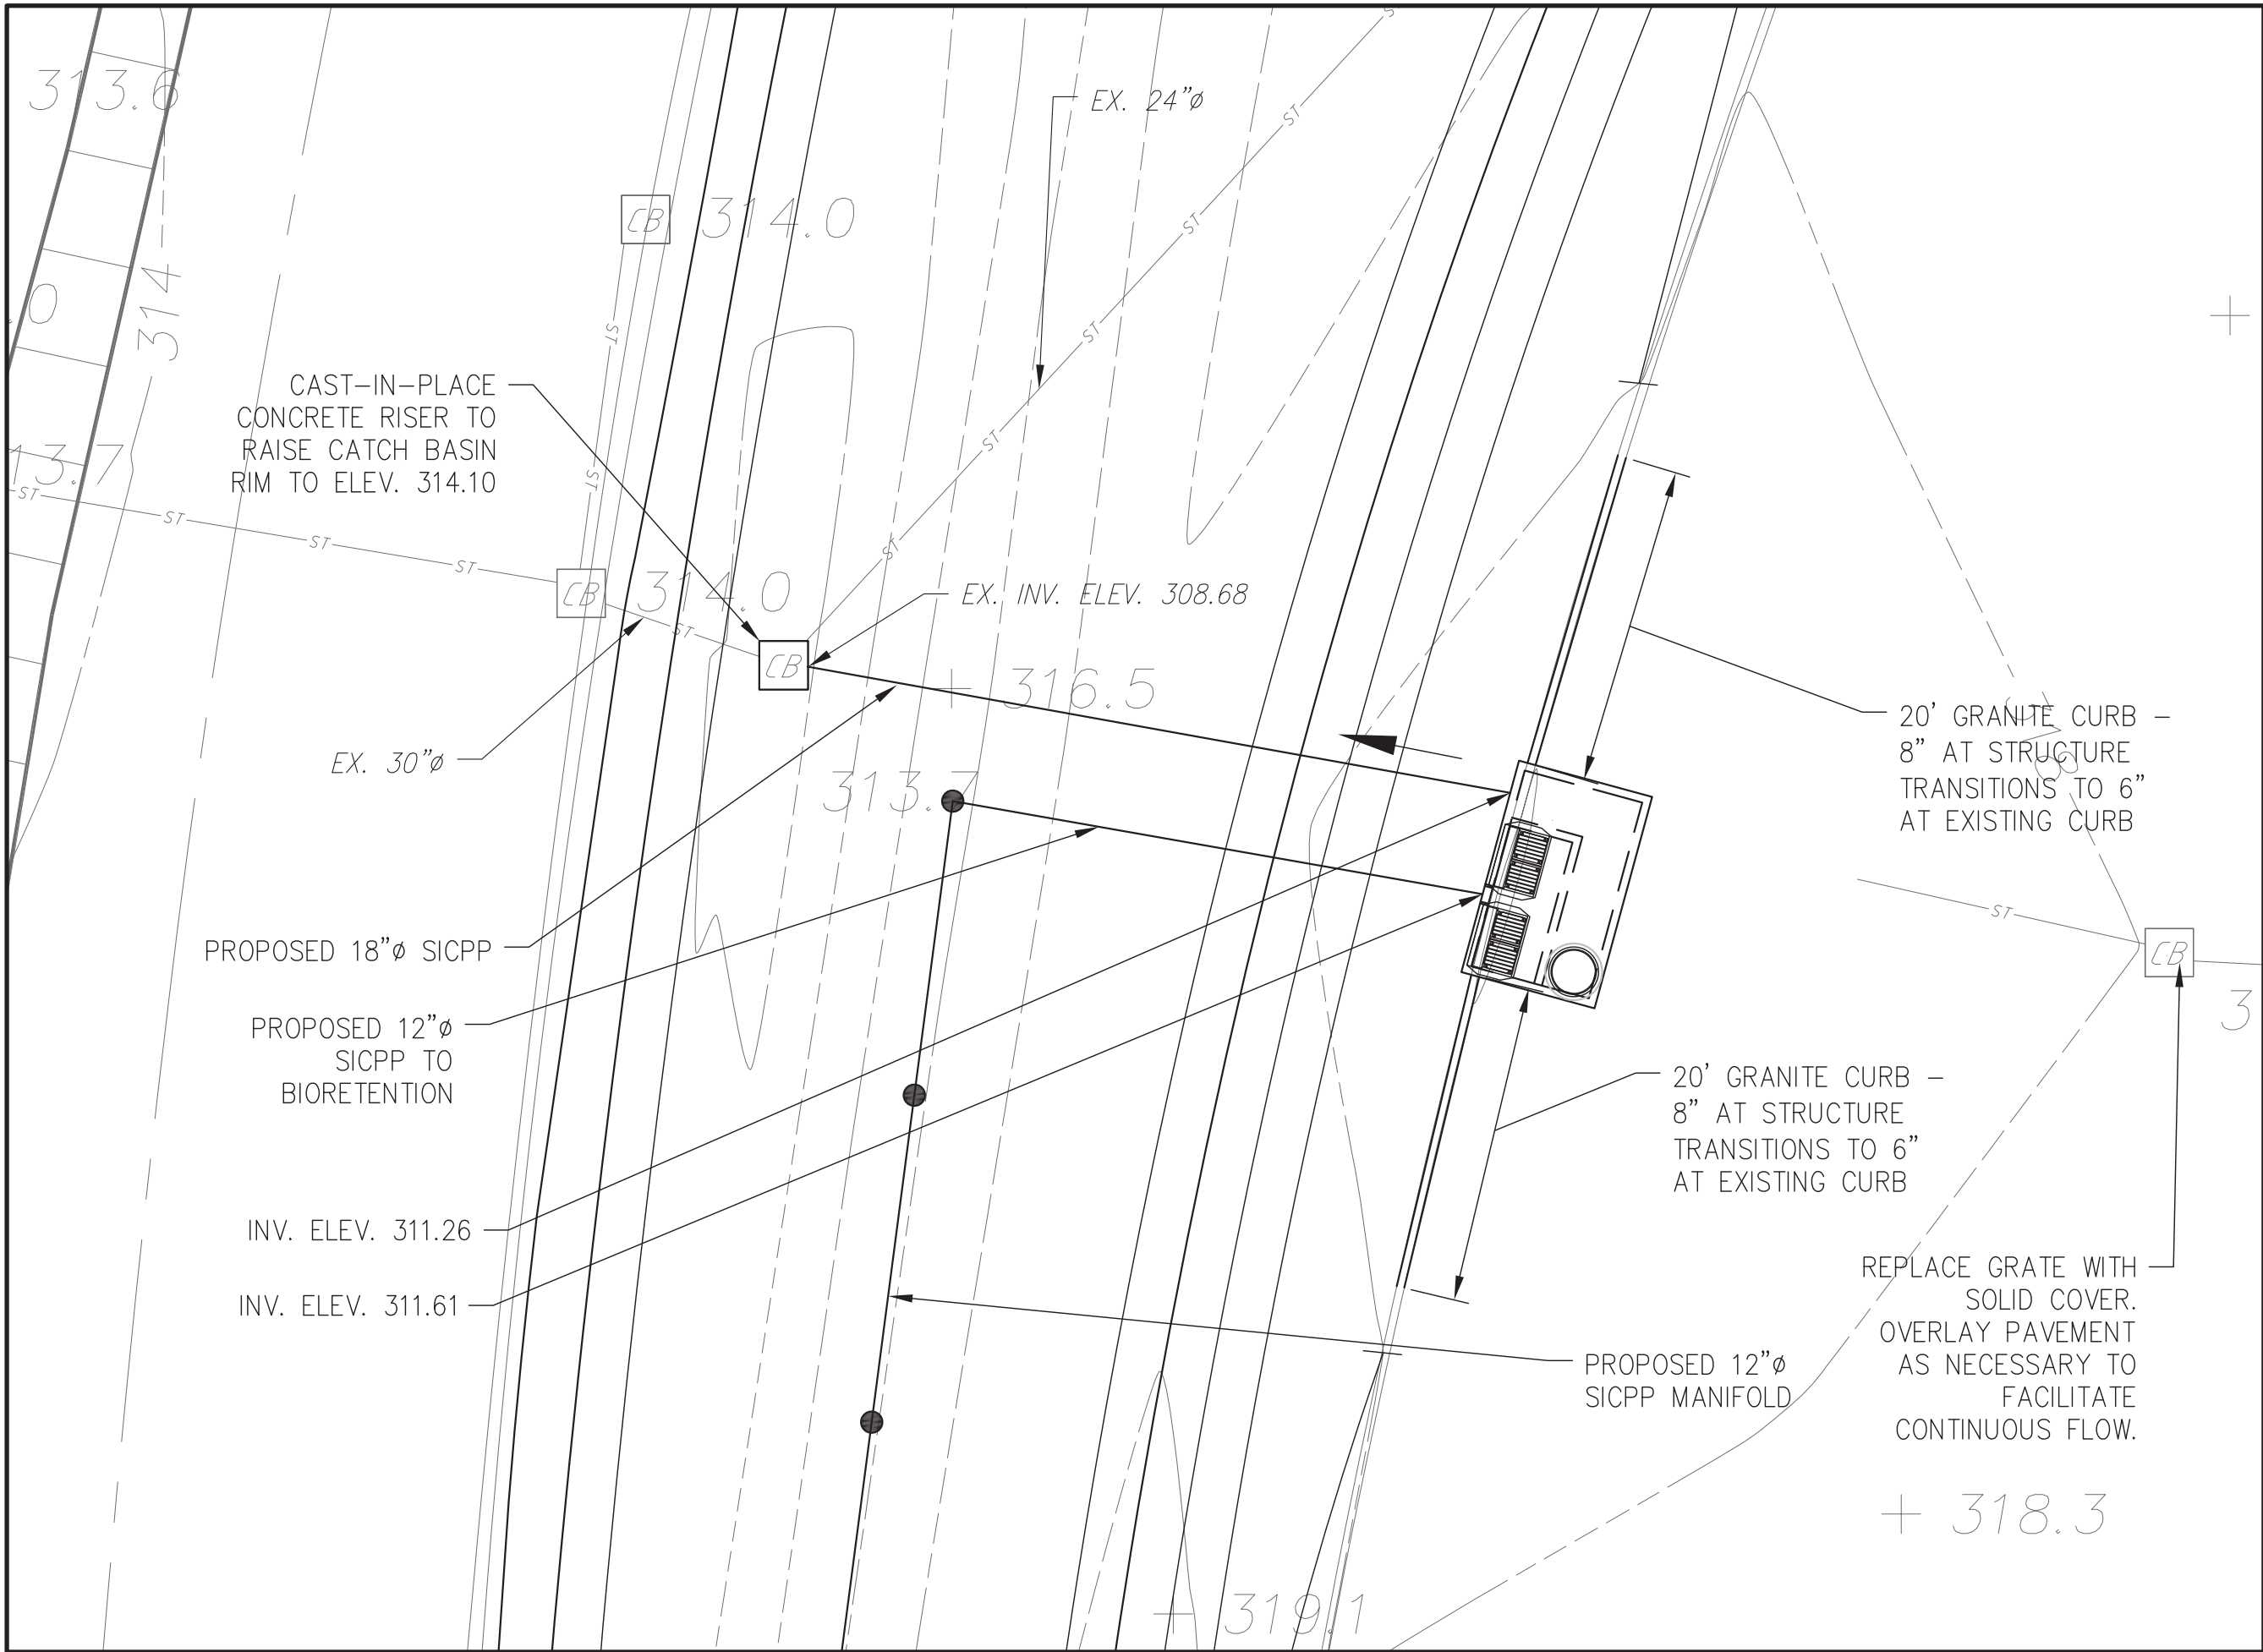


N2 PLAN
SCALE: 1" = 10'-0"

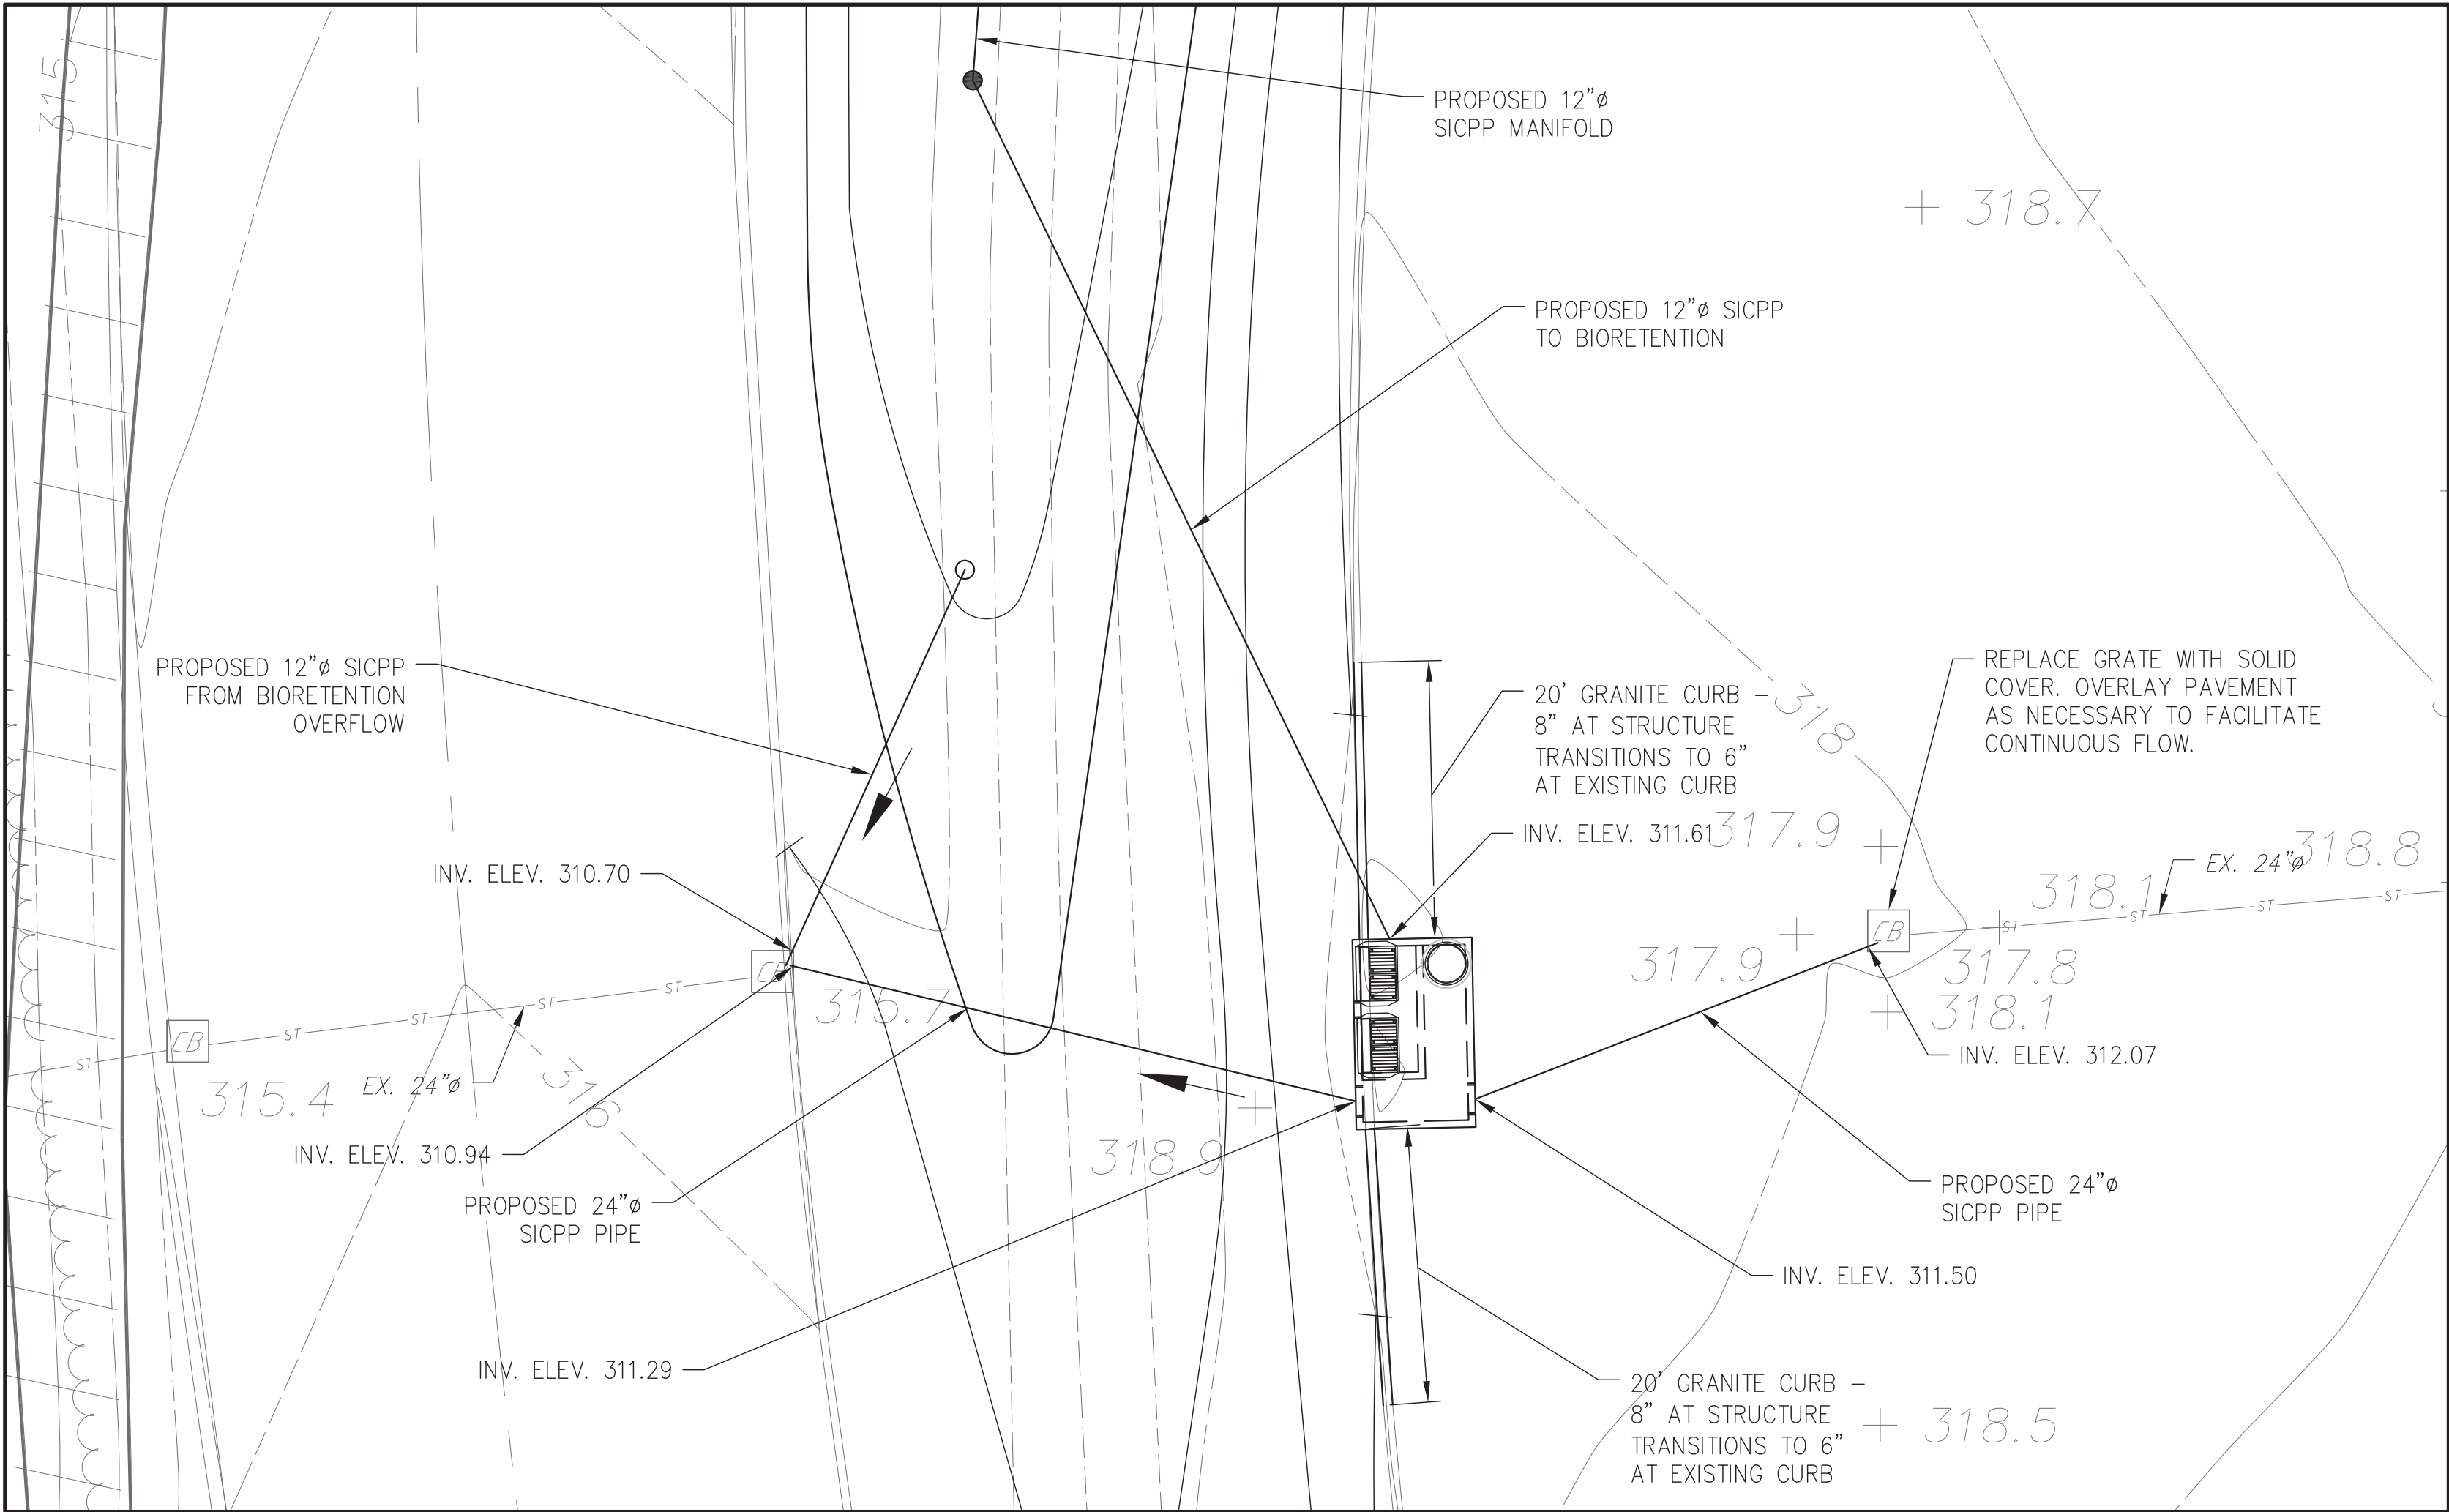

N3 PLAN
SCALE: 1" = 10'-0"

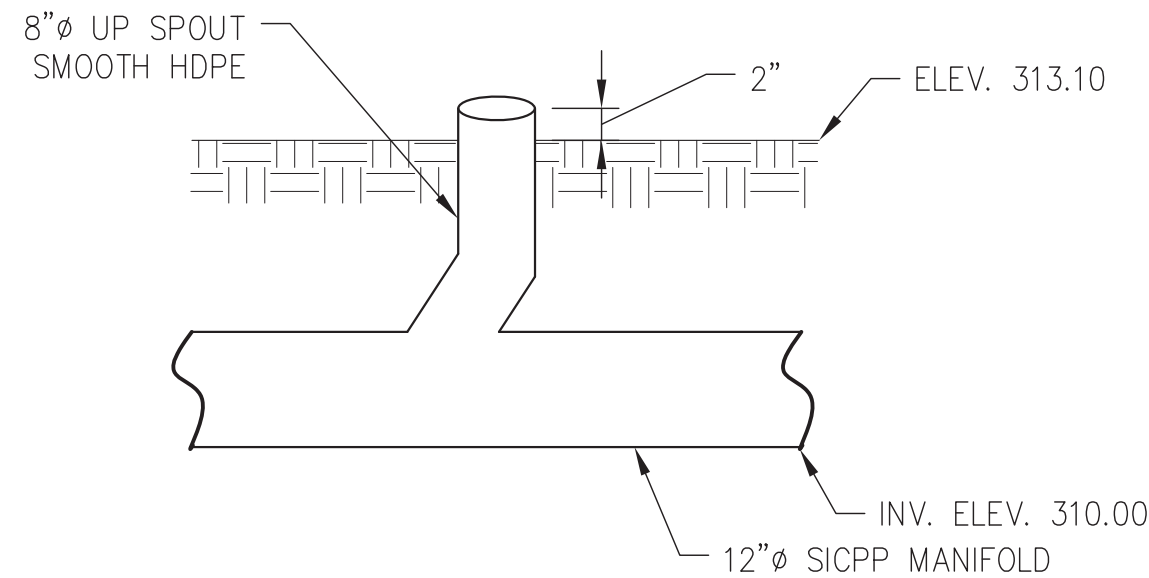

8" Ø UP SPOUT DETAIL
NOT TO SCALE

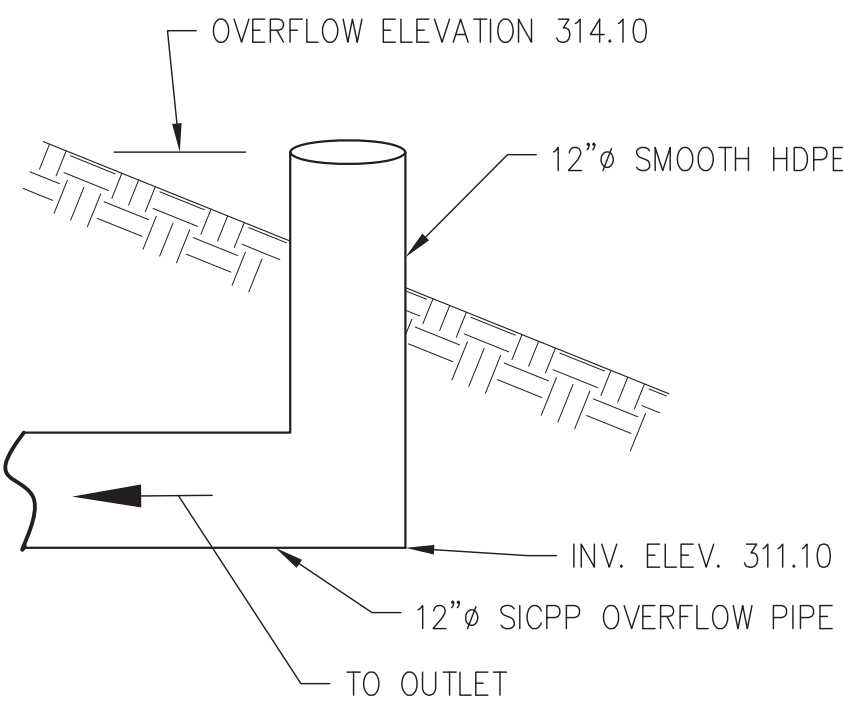

12" Ø BIORETENTION OVERFLOW DETAIL
NOT TO SCALE

NOTES:

- FOR CHAMBER DETAILS SEE SHEETS C-501, C-502, AND C-503.

LEGEND:

- 8" UP SPOUT
- 12" BIORETENTION OVERFLOW

0 2.5 5 10 20
SCALE: 1" = 10'-0"



ANDROPOGON
ASSOCIATES, LTD
10 SHURS LANE
PHILADELPHIA, PA 19127
T: 215.487.0700
F: 215.483.7520
W: www.andropogon.com

PURCHASE COLLEGE
GREEN
INFRASTRUCTURE

PURCHASE COLLEGE
735 ANDERSON HILL ROAD
PURCHASE, NY 10577

LU ENGINEERS
CIVIL ENGINEERING
50 LAKEFRONT BLVD. SUITE 212
BUFFALO, NY 14202
P: 716.849.0982
www.luengineers.com

ATLANTIC TESTING LABORATORIES
GEOTECHNICAL ENGINEERING
251 UPPER NORTH ROAD
HIGHLAND, NY 12528
P: 845.691.6098
www.atlantictesting.com

REV. DATE DESCRIPTION



SCALE:	AS SHOWN
DATE:	07.06.2018
DRAWN BY:	PMB
CHECKED BY:	TJN
APPROVED BY:	KDW

AA PROJECT #:	150024
PROJECT PHASE:	100% CONTRACT DOCUMENTS


DRAWING TITLE:

DRAINAGE ENLARGEMENT
PLAN - NORTH


SHEET:

C-401


DRAWING FILE PATH: Z:\PROJECTS\50384 ANDROPOGON ASSOCIATES, LTD\50384-01 GREEN INFRASTRUCTURE-SUNY PURCHASE\CAD\DWG CADD\50384-01_N&S PROP PLAN.DWG
DATE MODIFIED: 7/18/2018

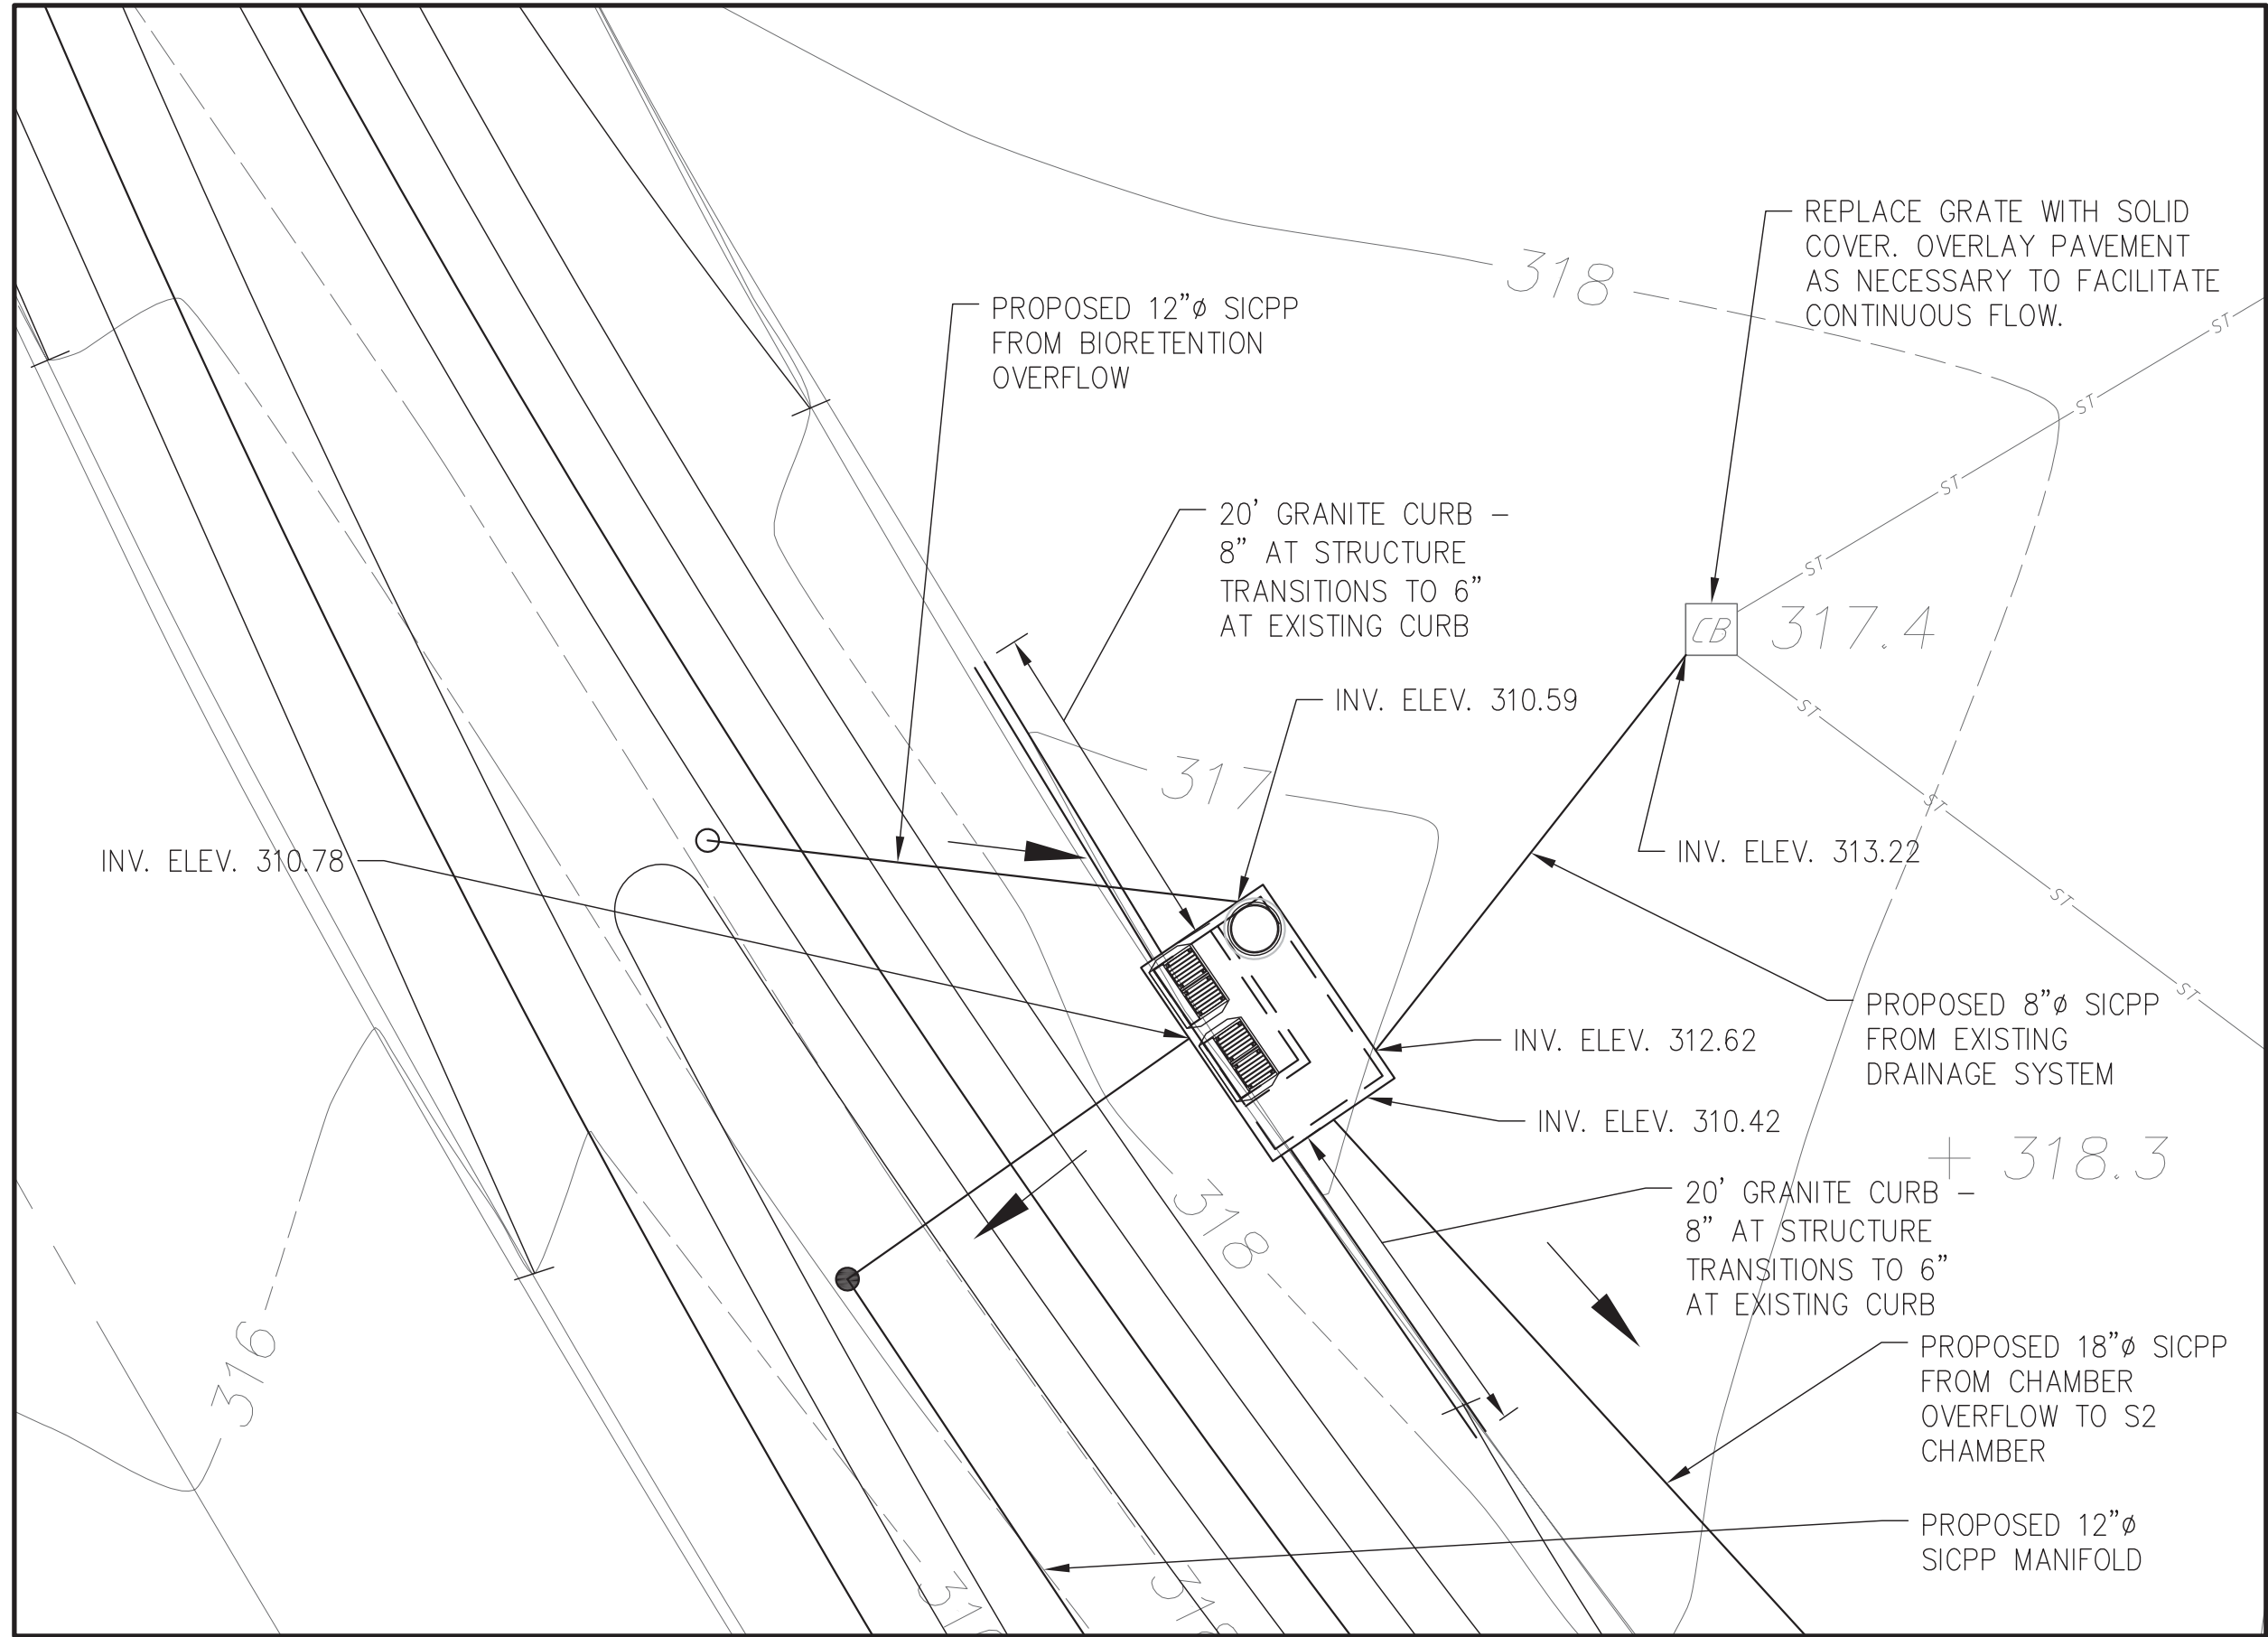


S1 PLAN
SCALE: 1" = 10'-0"

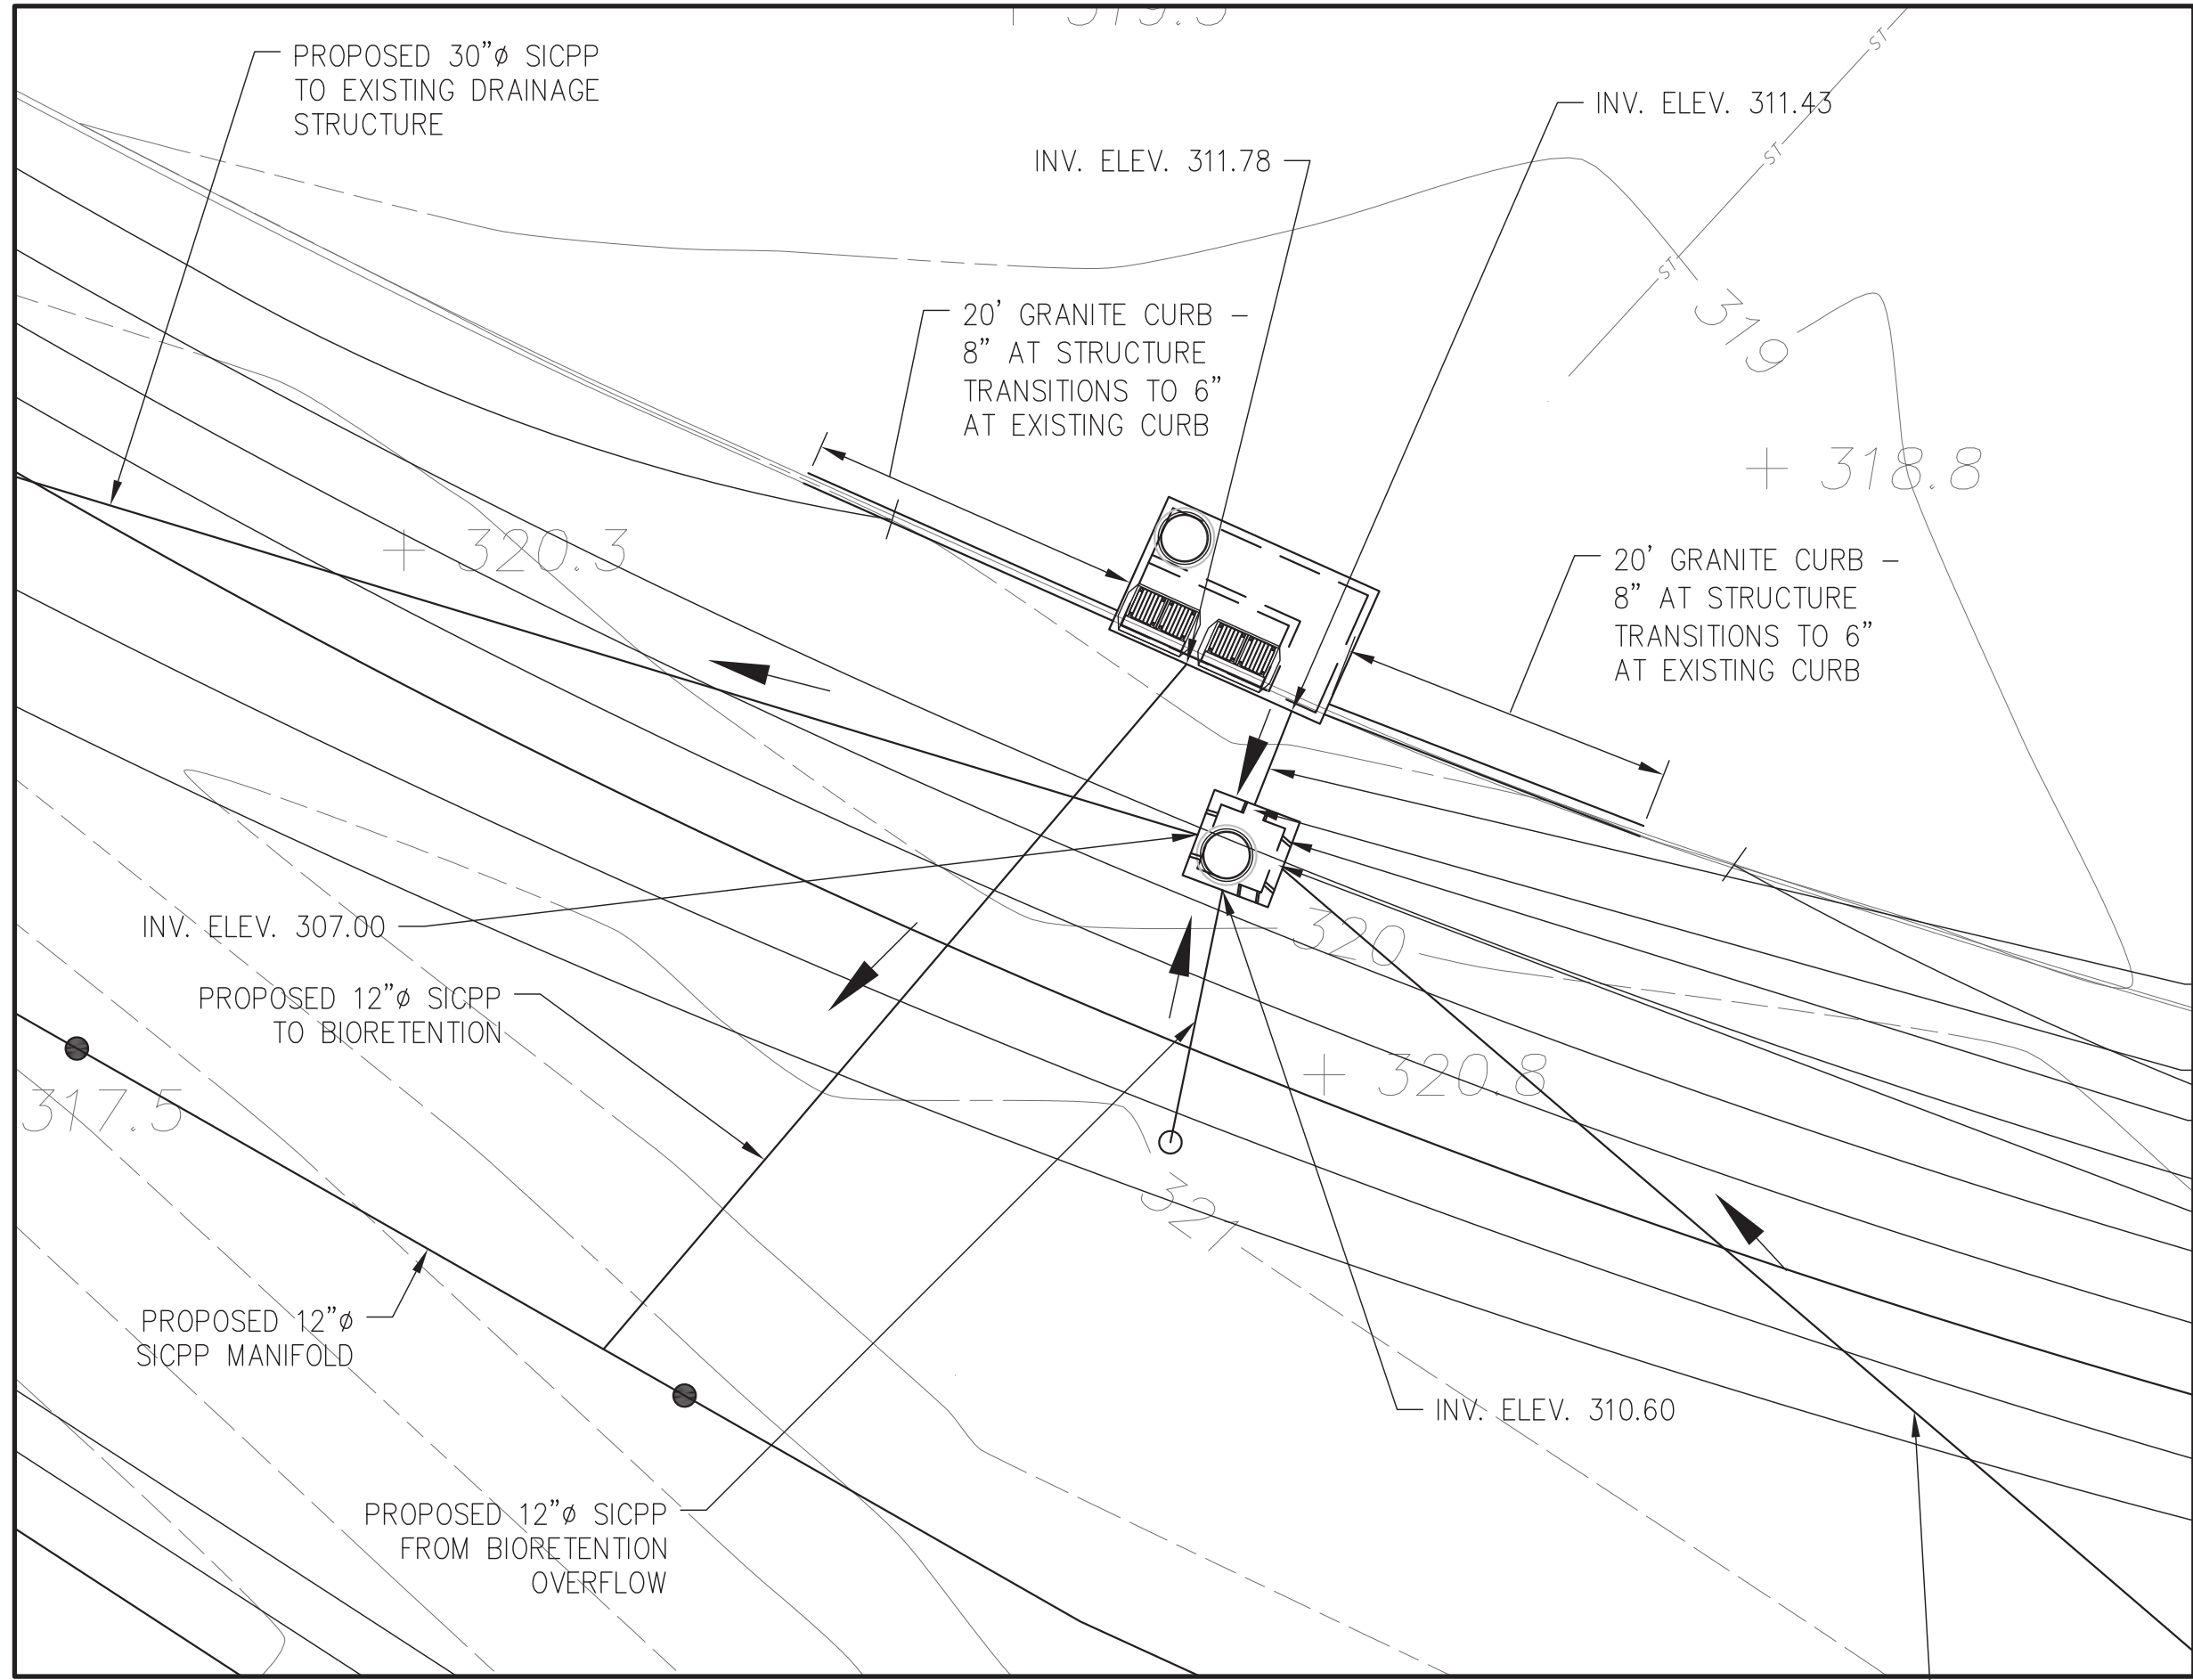

S3 PLAN
SCALE: 1" = 10'-0"

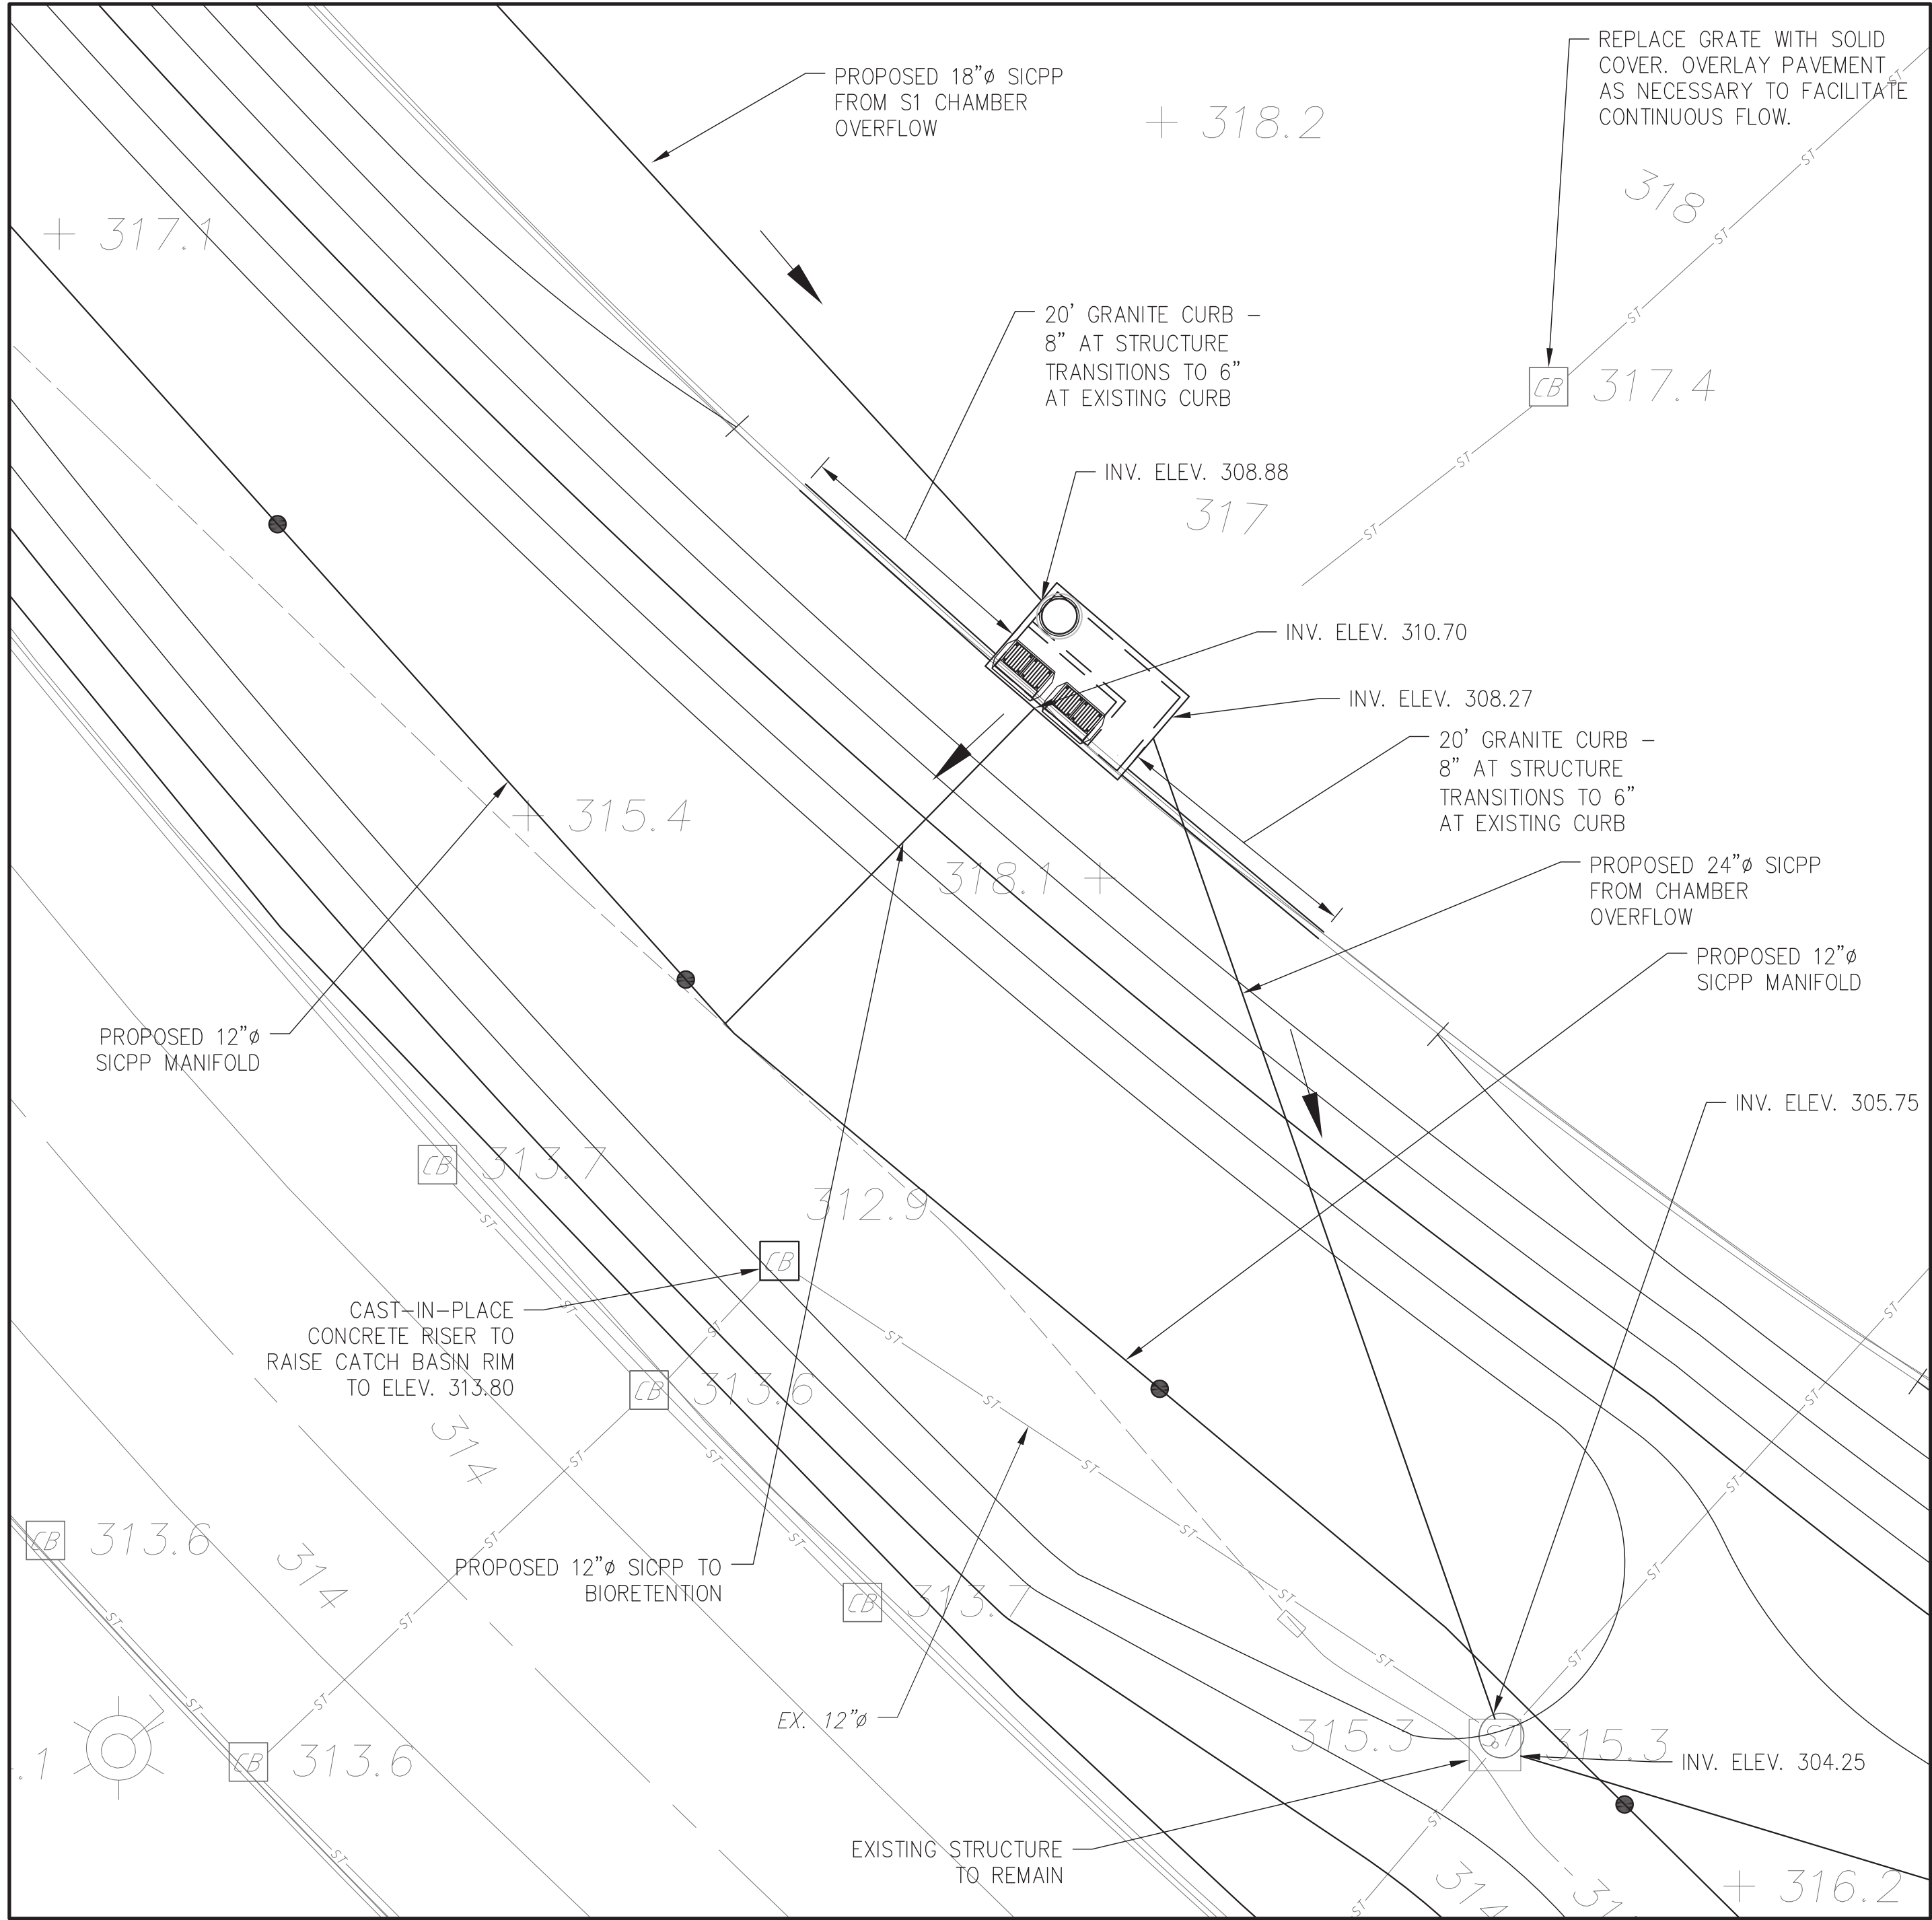


S2 PLAN
SCALE: 1" = 10'-0"

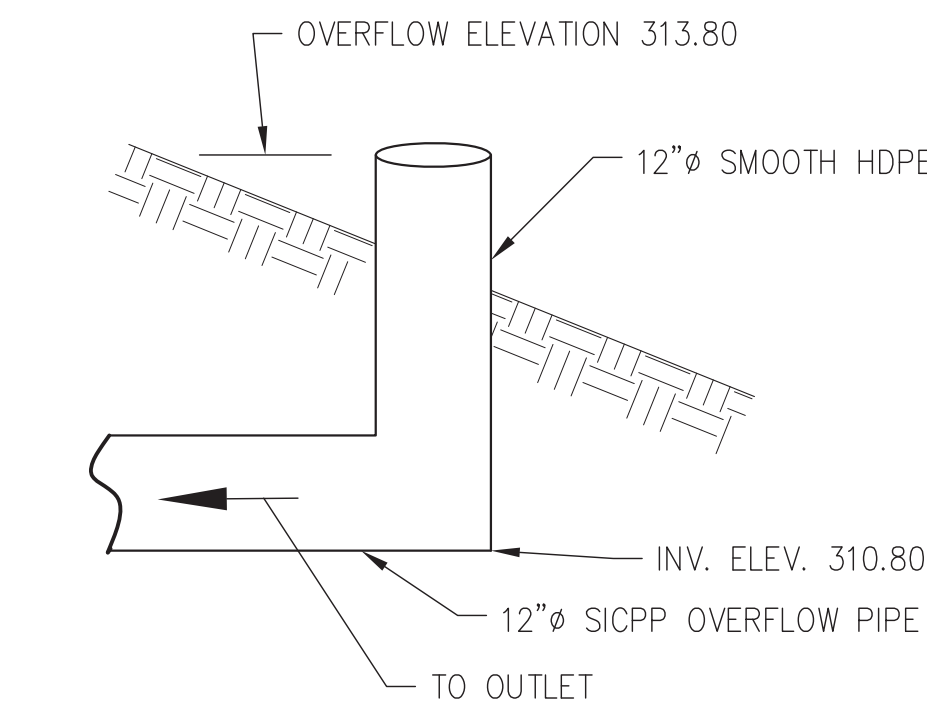

12" Ø BIORETENTION OVERFLOW DETAIL
NOT TO SCALE

- LEGEND:
- 8" UP SPOUT
 - 12" BIORETENTION OVERFLOW

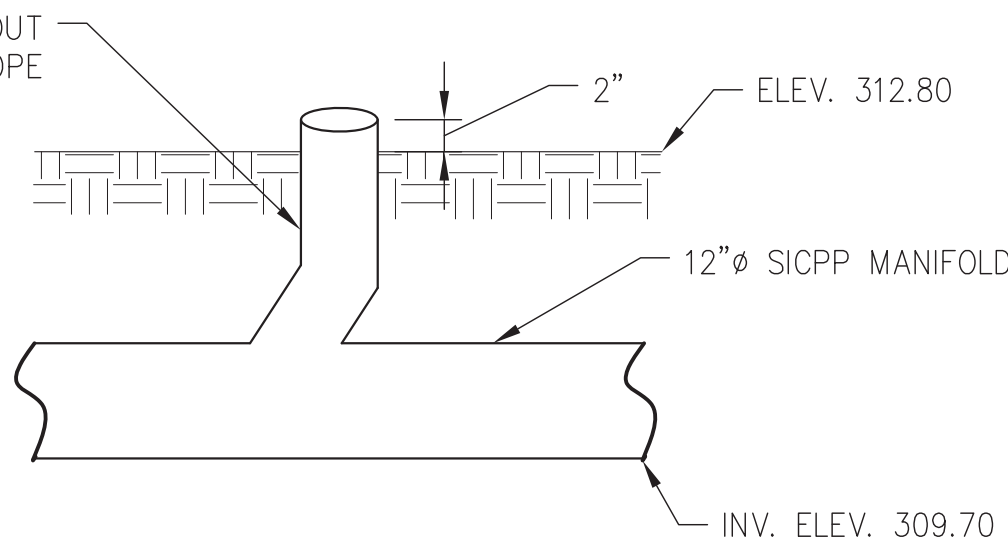

8" Ø UP SPOUT DETAIL
NOT TO SCALE

- NOTES:
- FOR CHAMBER AND DRAINAGE STRUCTURE DETAILS SEE SHEETS C-504, C-505, C-506, C-507 AND C-508.

SCALE: 1" = 10'-0"



ANDROPOGON
ASSOCIATES, LTD
10 SHURS LANE
PHILADELPHIA, PA 19127
T: 215.487.0700
F: 215.483.7520
W: www.andropogon.com

PURCHASE COLLEGE GREEN INFRASTRUCTURE

PURCHASE COLLEGE
735 ANDERSON HILL ROAD
PURCHASE, NY 10577

LU ENGINEERS
CIVIL ENGINEERING
50 LAKEFRONT BLVD. SUITE 212
BUFFALO, NY 14202
P: 716.849.0982
www.luengineers.com

ATLANTIC TESTING LABORATORIES
GEOTECHNICAL ENGINEERING
251 UPPER NORTH ROAD
HIGHLAND, NY 12528
P: 845.691.6098
www.atlantictesting.com

REV.	DATE	DESCRIPTION
------	------	-------------

REV.	DATE	DESCRIPTION



SCALE:	AS SHOWN
DATE:	07.06.2018
DRAWN BY:	PMB
CHECKED BY:	TJN
APPROVED BY:	KDW


AA PROJECT #: 150024
PROJECT PHASE: 100% CONTRACT DOCUMENTS

DRAWING TITLE:


**DRAINAGE ENLARGEMENT
PLAN - SOUTH**

SHEET:


C-402

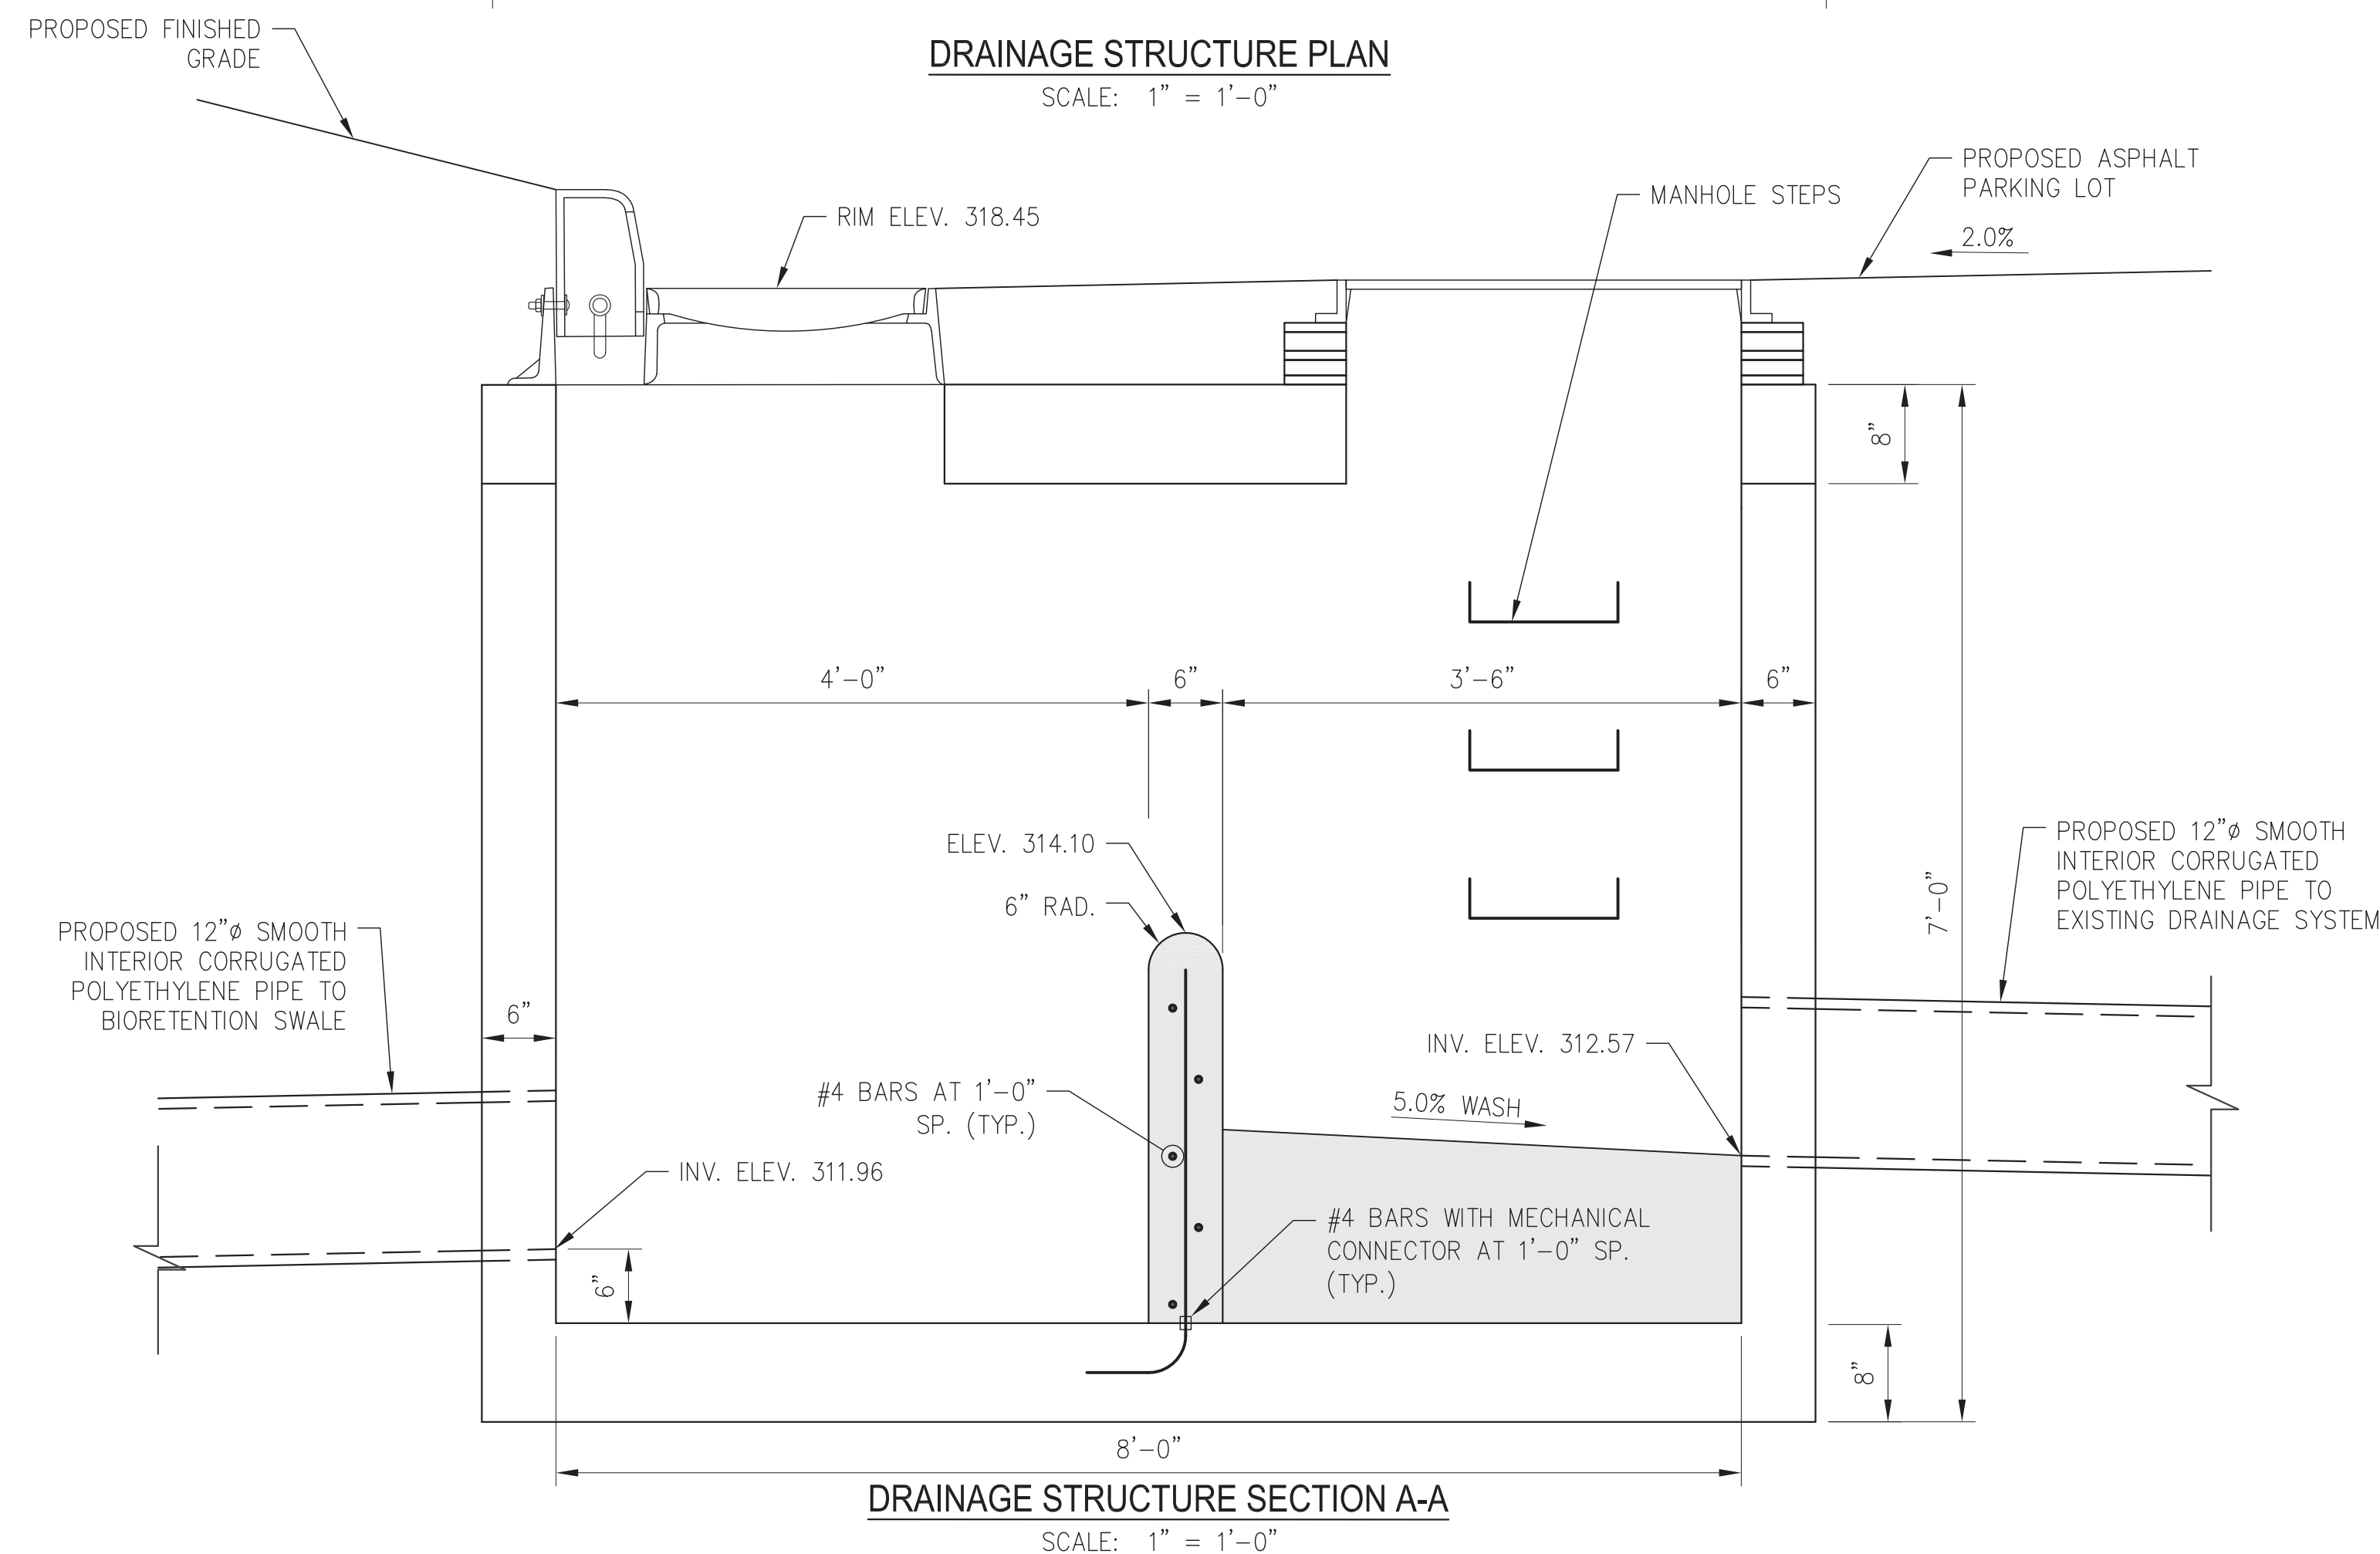

 
1. PROPOSED GRATE AND CURB INLET SHALL BE NEENAH FOUNDRY COMBINATION INLET R-3287-15 OR EQUAL.




DRAWING FILE PATH: Z:\PROJECTS\50384 ANDROPOGON ASSOCIATES, LTD\50384-01 GREEN INFRASTRUCTURE-SUNY PURCHASE\ACADD\CD DESIGN\50384-01_DET-1.DWG
DATE MODIFIED: 7/18/2018

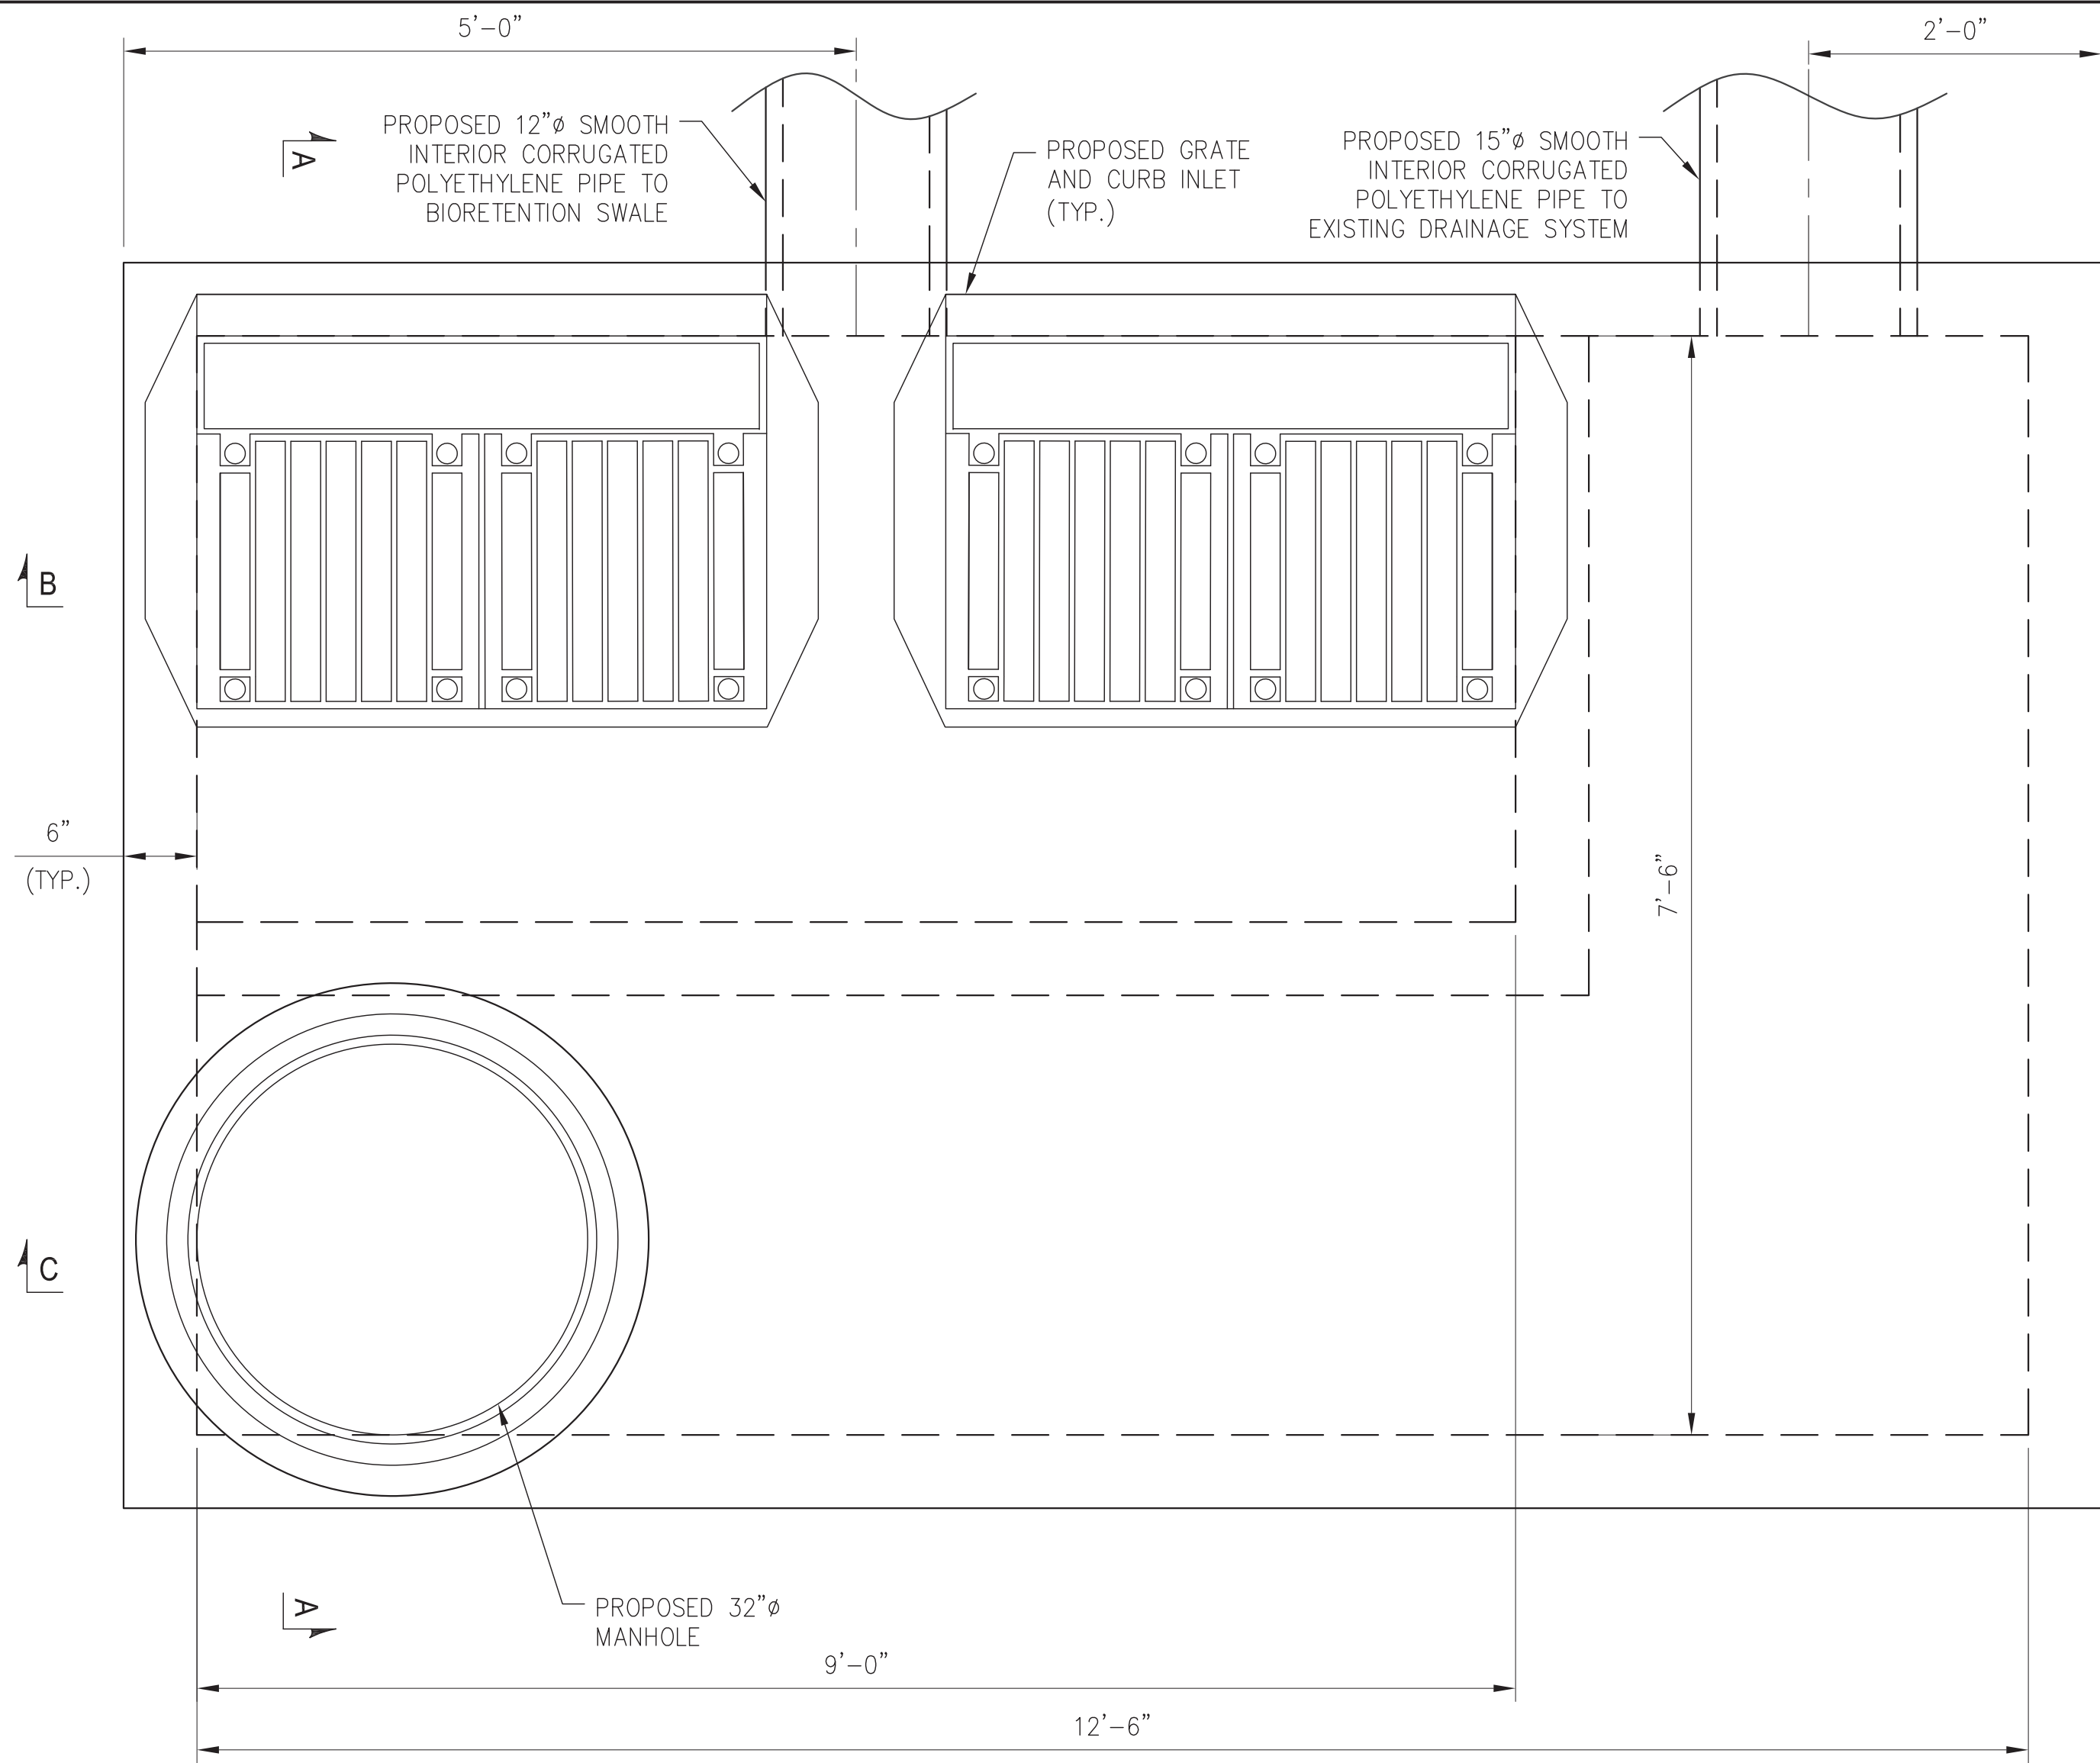


DRAINAGE STRUCTURE PLAN
SCALE: 1" = 1'-0"

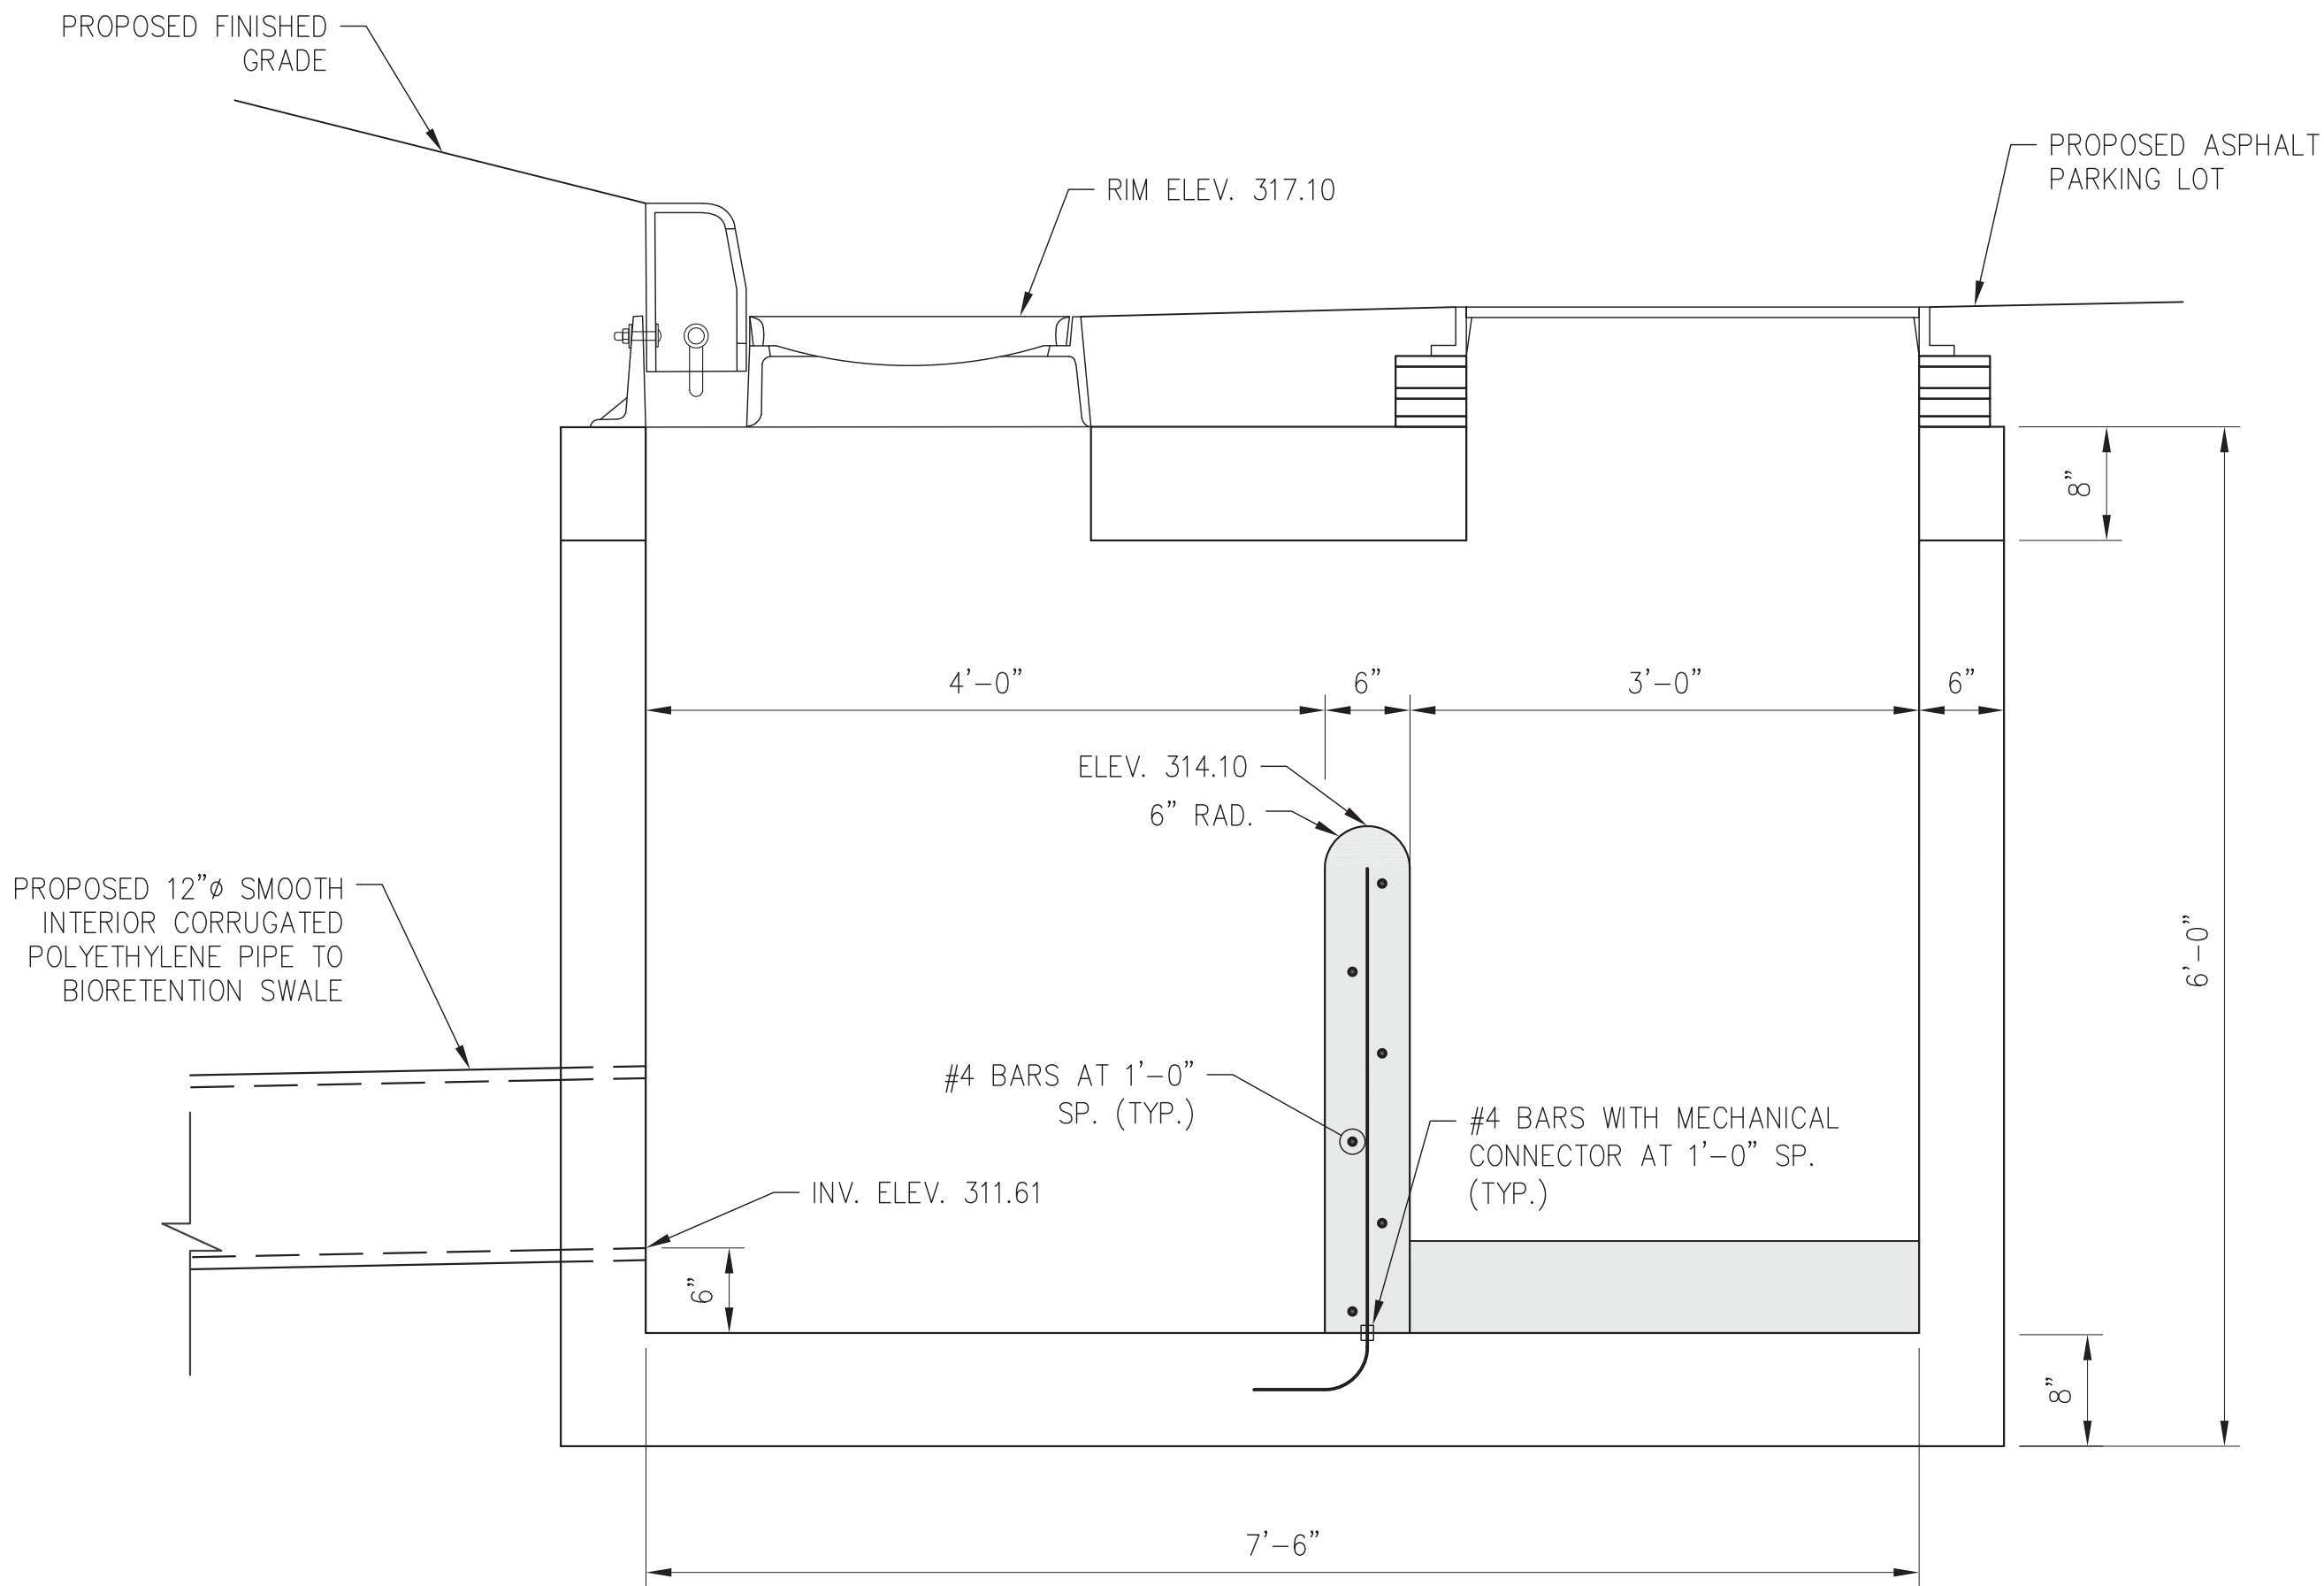

DRAINAGE STRUCTURE SECTION A-A
SCALE: 1" = 1'-0"

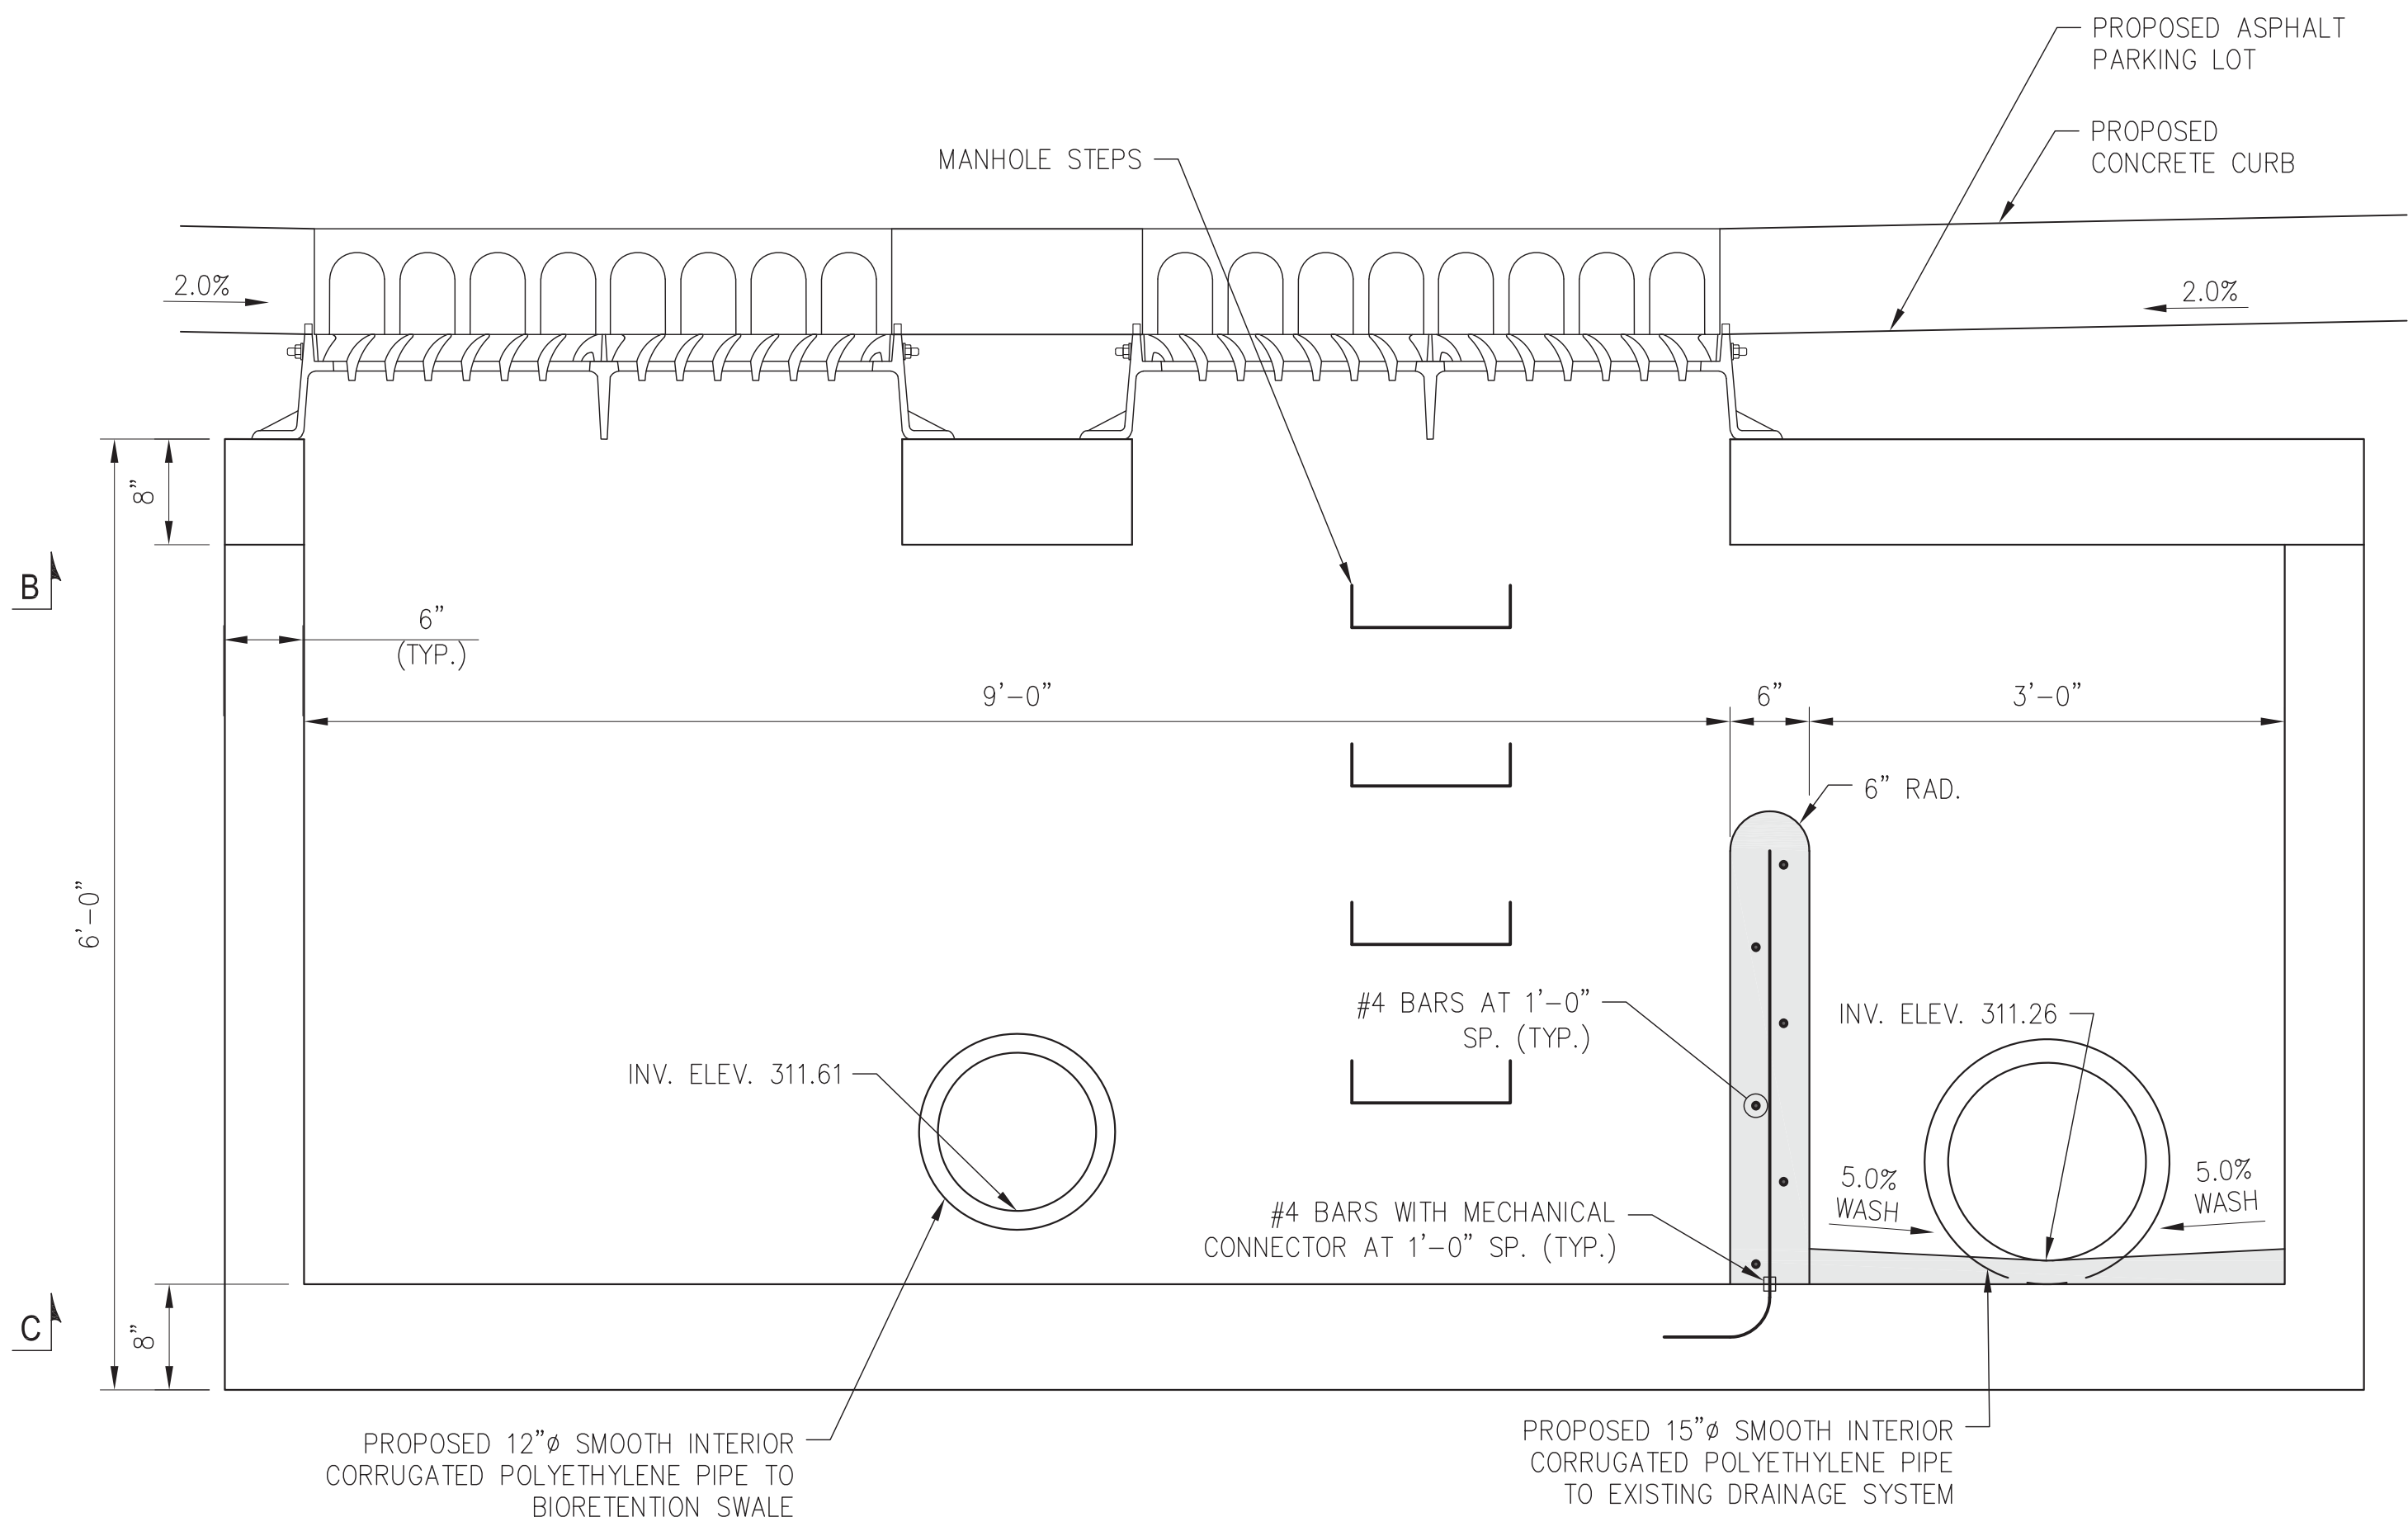


DRAINAGE STRUCTURE SECTION B-B
SCALE: 1" = 1'-0"

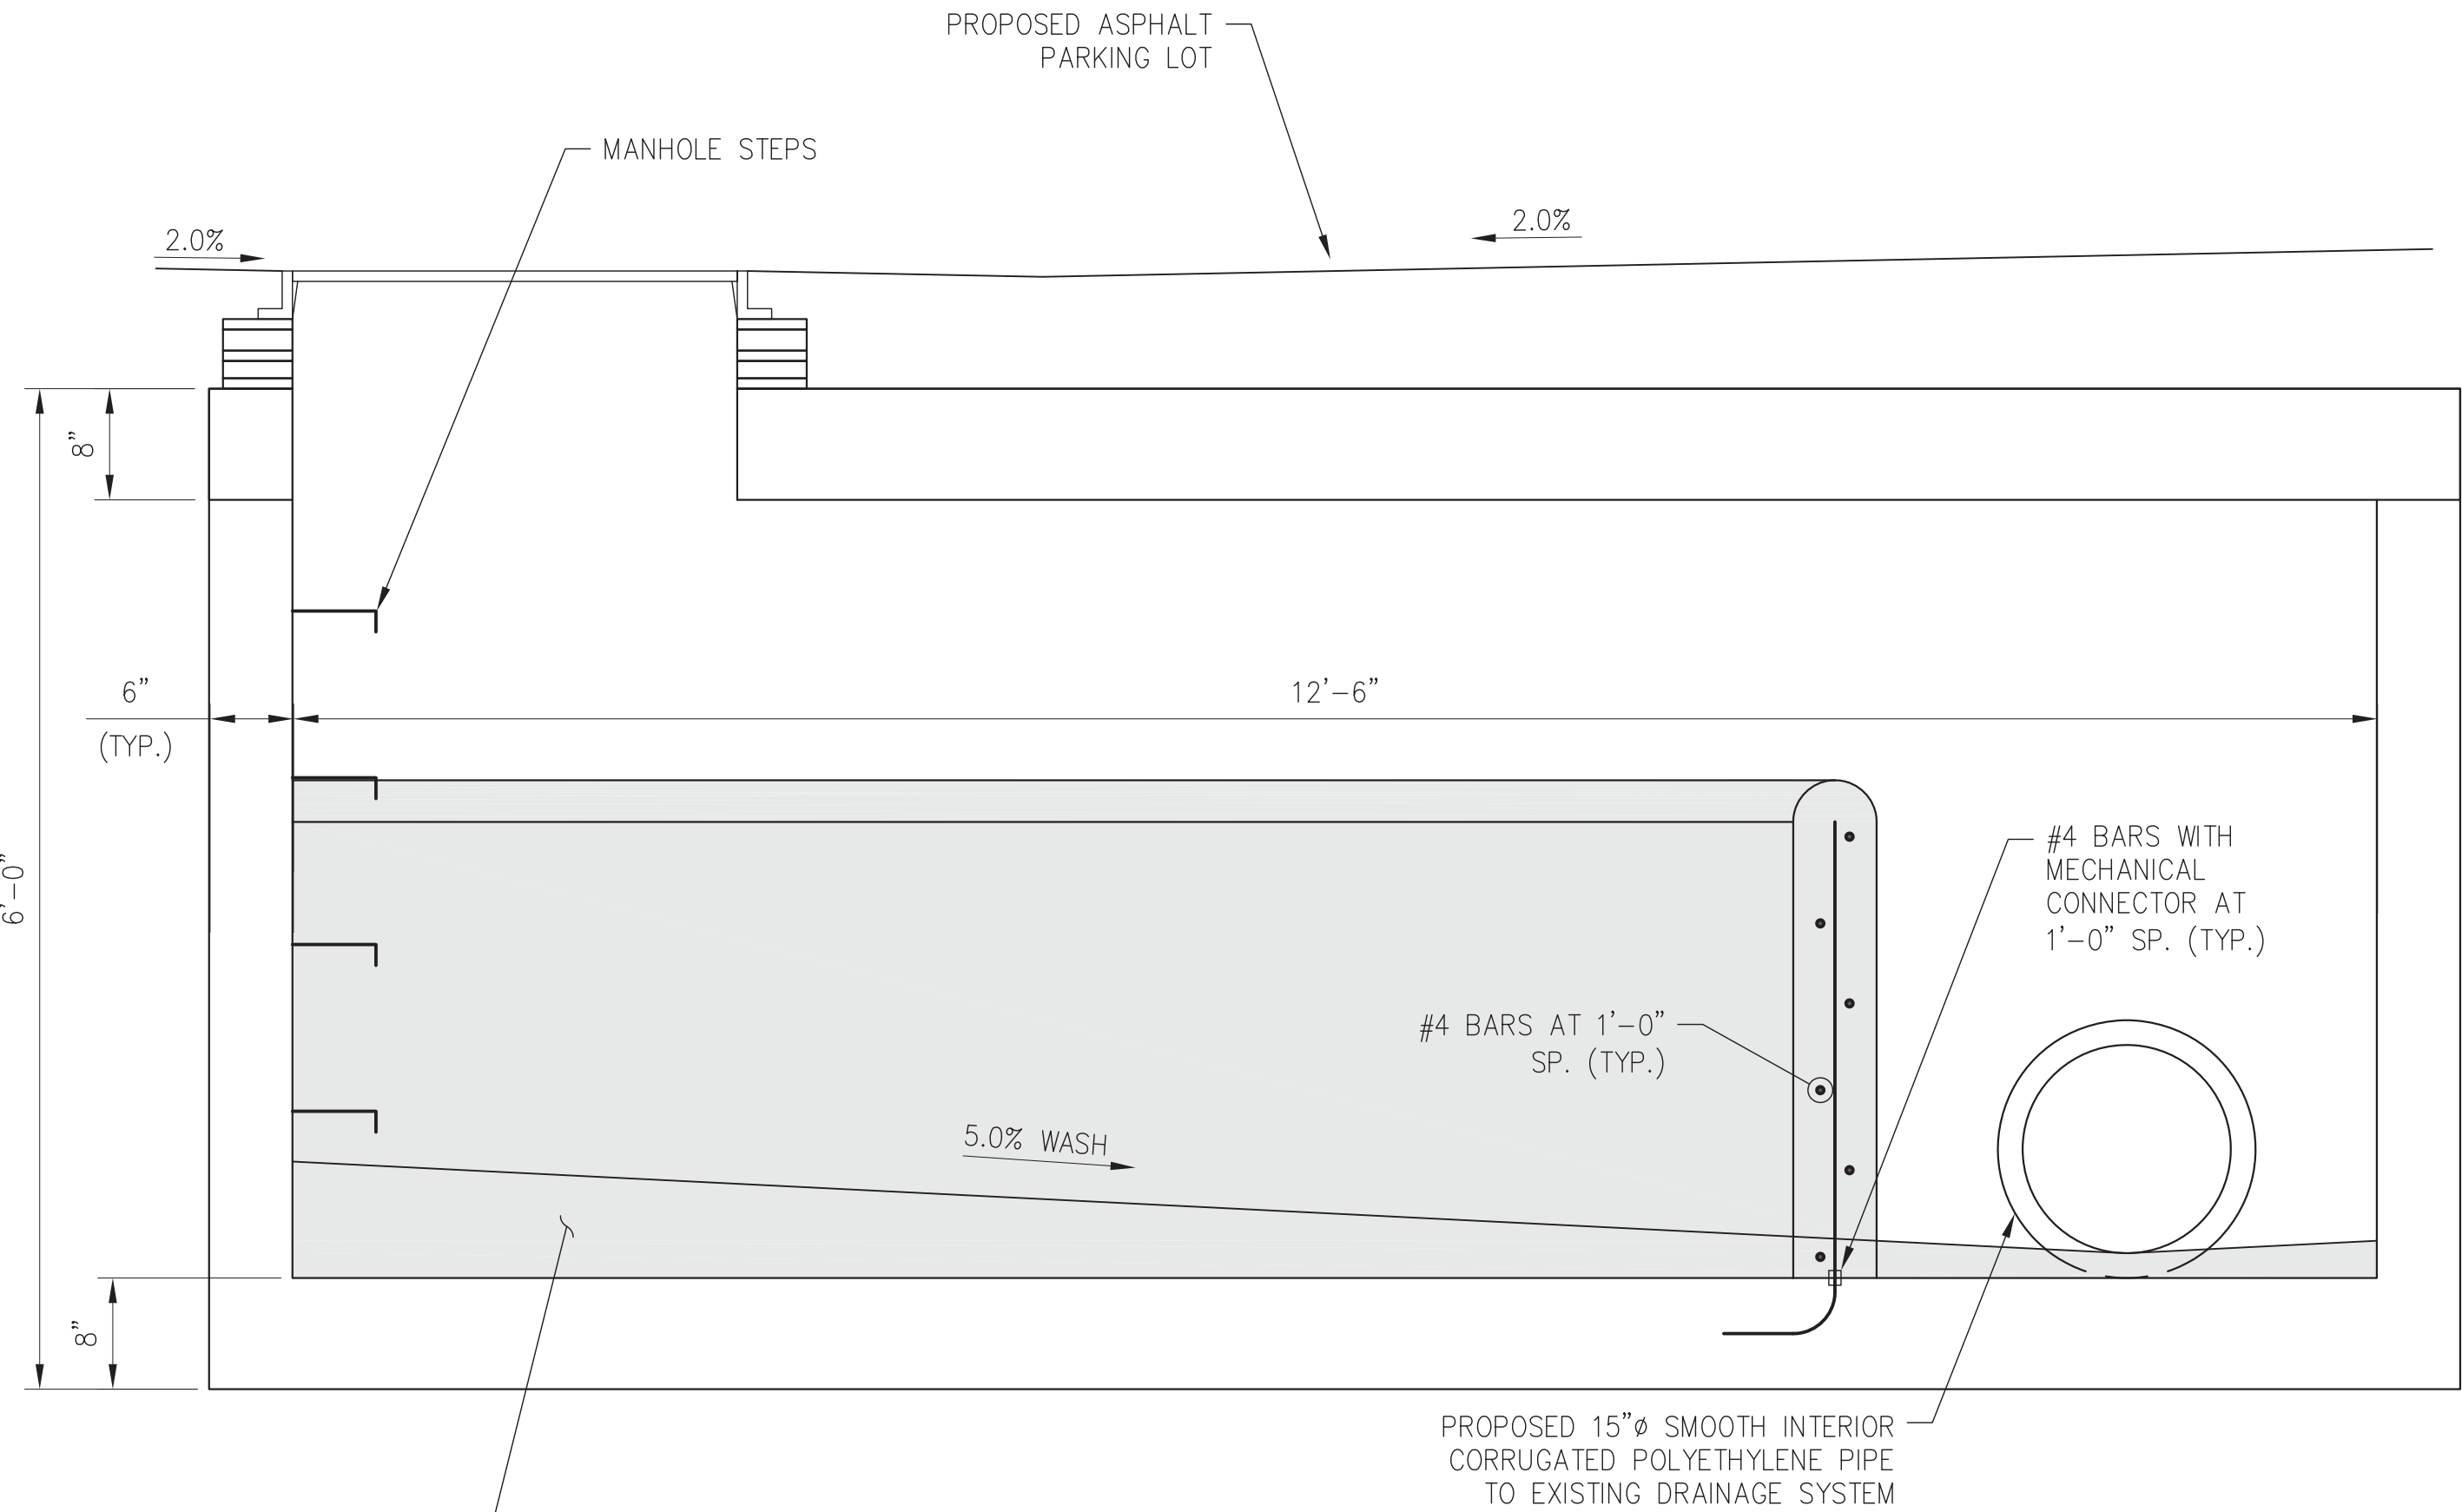

DRAINAGE STRUCTURE SECTION C-C
SCALE: 1" = 1'-0"

NOTES:

 1. PROPOSED GRATE AND CURB INLET SHALL BE NEENAH FOUNDRY COMBINATION INLET R-3287-15 OR EQUAL.



ANDROPOGON ASSOCIATES, LTD
10 SHURS LANE
PHILADELPHIA, PA 19127
T: 215.487.0700
F: 215.483.7520
W: www.andropogon.com

PURCHASE COLLEGE GREEN INFRASTRUCTURE

PURCHASE COLLEGE
735 ANDERSON HILL ROAD
PURCHASE, NY 10577

LU ENGINEERS CIVIL ENGINEERING
50 LAKEFRONT BLVD. SUITE 212
BUFFALO, NY 14202
P: 716.849.0982
www.luengineers.com

ATLANTIC TESTING LABORATORIES GEOTECHNICAL ENGINEERING
251 UPPER NORTH ROAD
HIGHLAND, NY 12528
P: 845.691.6098
www.atlantictesting.com

REV. DATE DESCRIPTION



SCALE:	AS SHOWN
DATE:	07.06.2018
DRAWN BY:	PMB
CHECKED BY:	TJN
APPROVED BY:	KDW

AA PROJECT #:	150024
PROJECT PHASE:	100% CONTRACT DOCUMENTS

DRAWING TITLE:
DRAINAGE DETAILS N2

SHEET:

C-502

PURCHASE COLLEGE
735 ANDERSON HILL ROAD
PURCHASE, NY 10577


LU ENGINEERS
CIVIL ENGINEERING
50 LAKEFRONT BLVD. SUITE 212
BUFFALO, NY 14202
P: 716.849.0982
www.luengineers.com

ATLANTIC TESTING LABORATORIES
GEOTECHNICAL ENGINEERING
 251 UPPER NORTH ROAD
 HIGHLAND, NY 12528
 P: 845.691.6098
www.atlantictesting.com

A circular professional engineer seal for the State of New York. The outer ring contains the text "STATE OF NEW YORK" at the top and "LICENSED PROFESSIONAL ENGINEER" at the bottom, separated by two stars. Inside the ring, the name "KIRK D. WILSON" is written in an arc. Below the name is the New York State coat of arms. At the bottom of the seal, the license number "No. 074928" is printed. The seal is stamped in blue ink on a white background.


AA PROJECT #:	150024
PROJECT PHASE:	100% CONTRACT DOCUMENTS

C-503

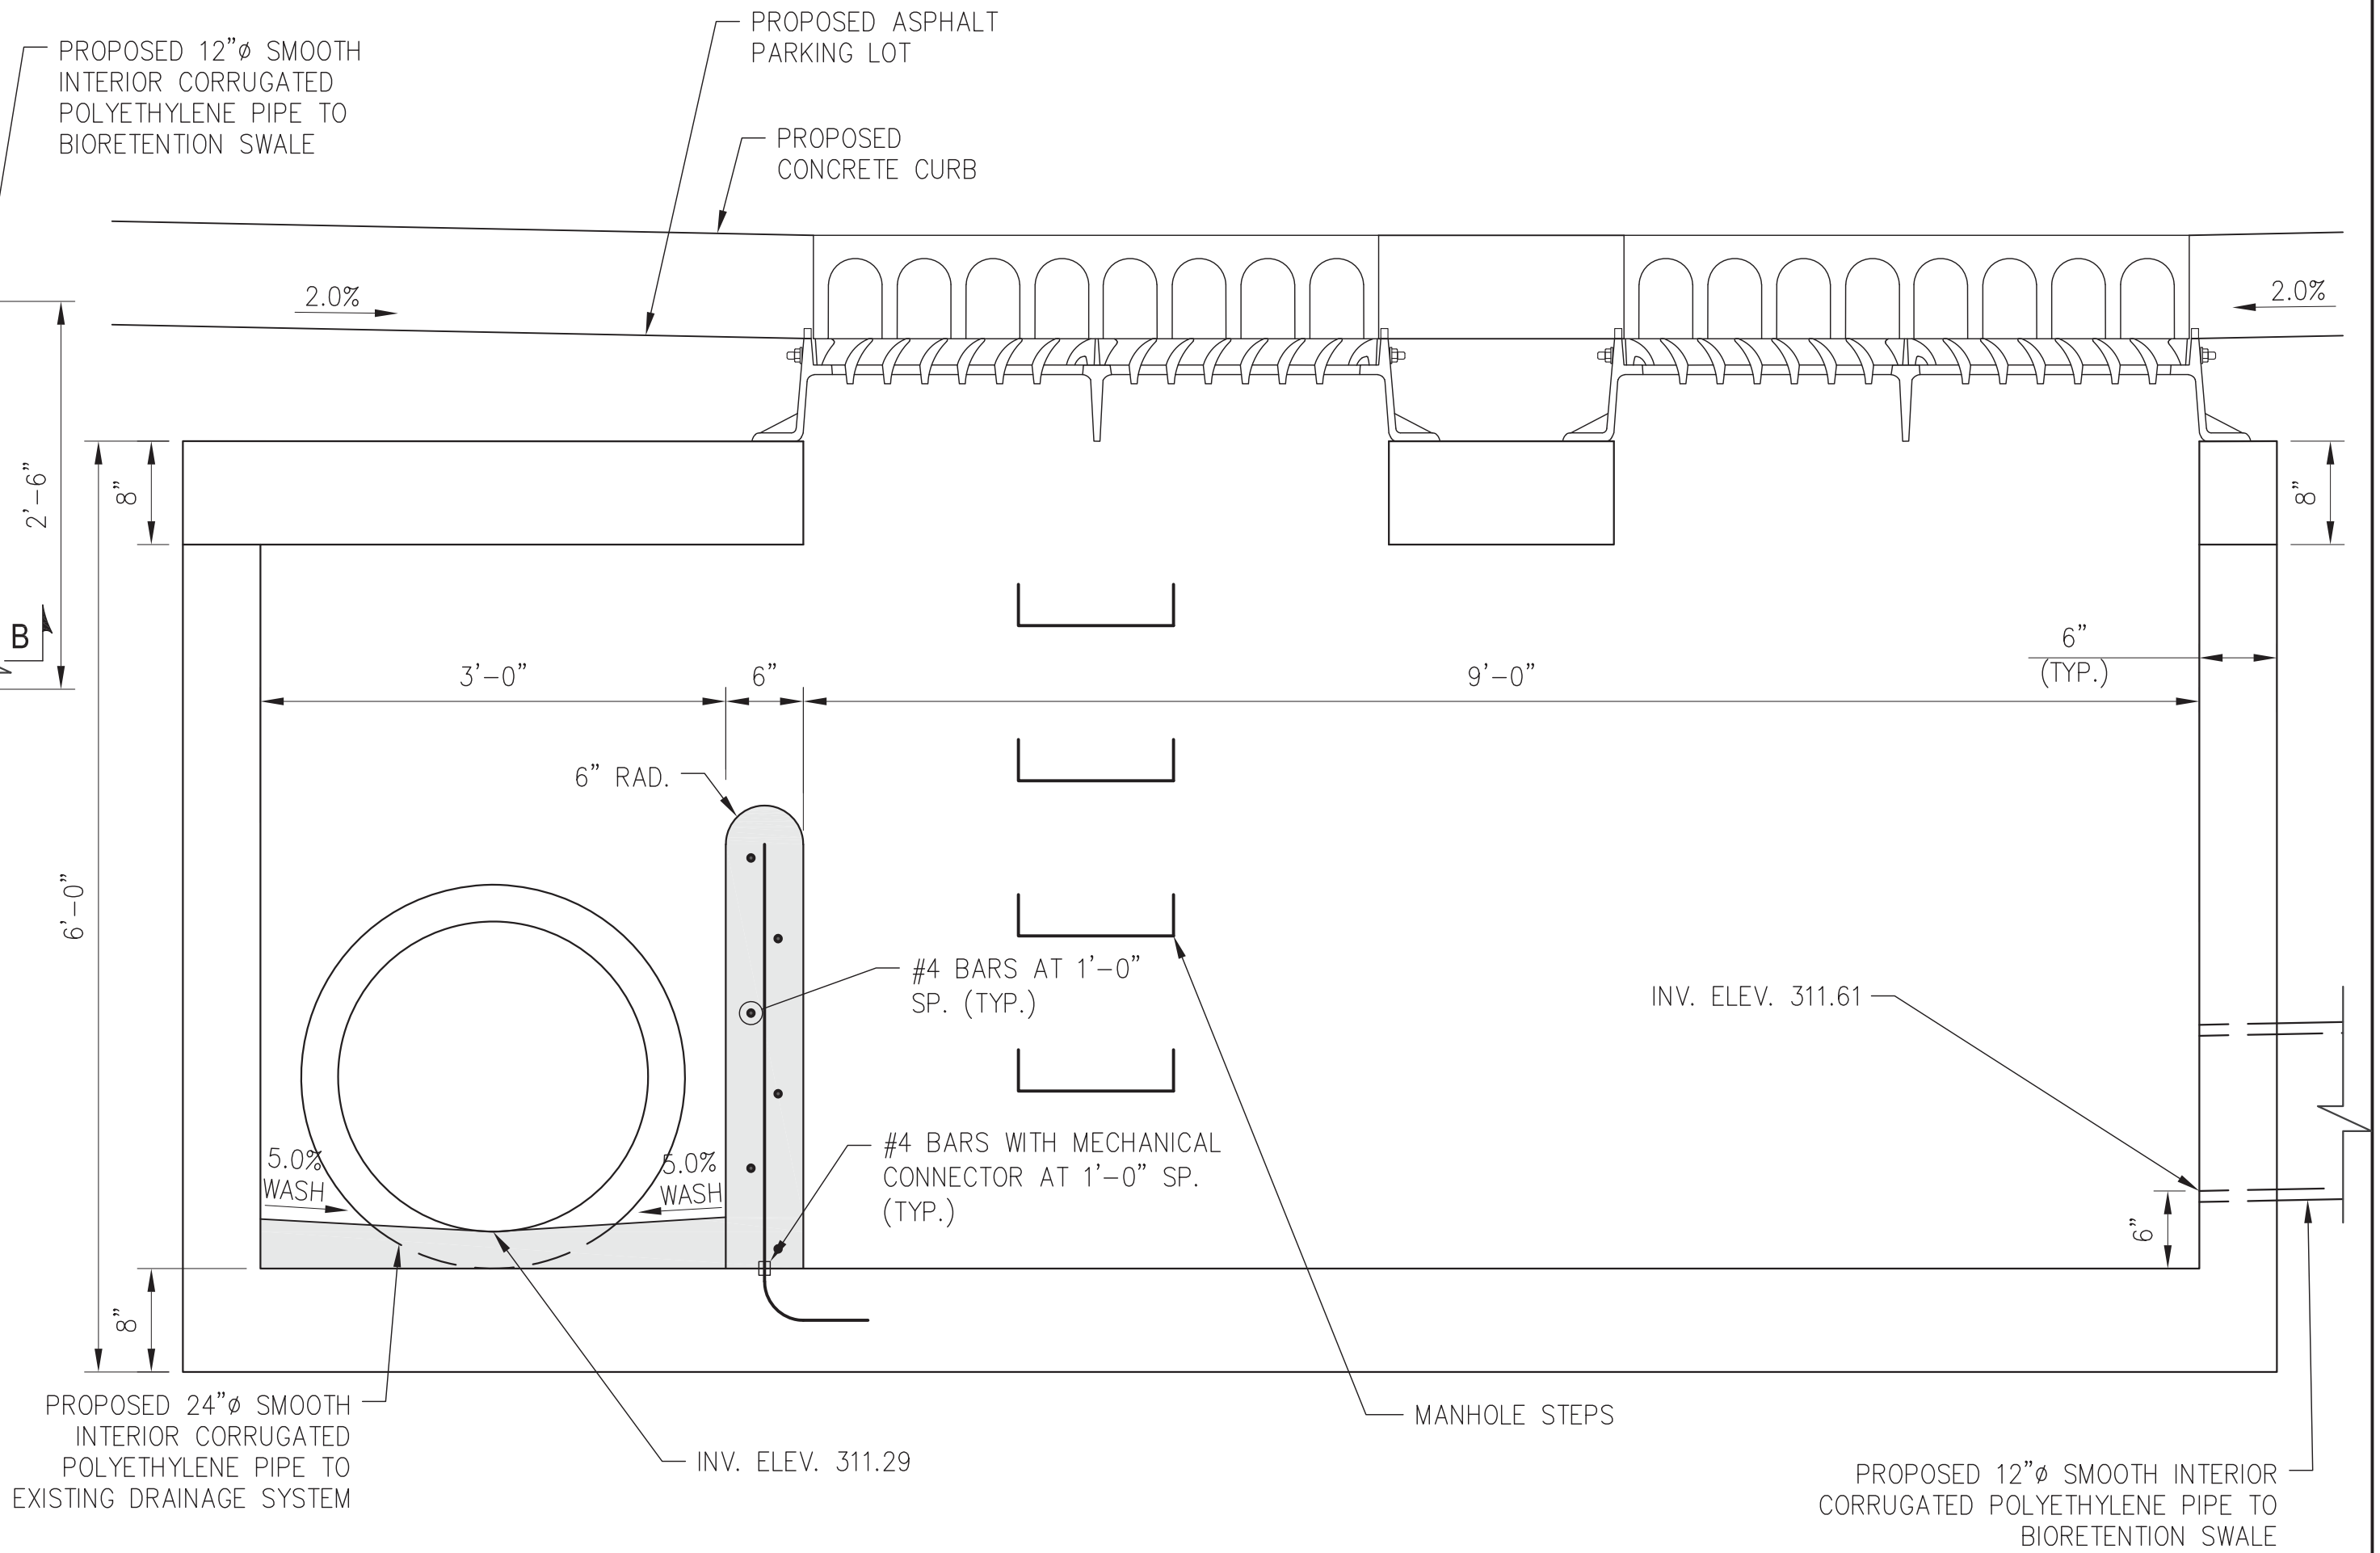

DRAINAGE STRUCTURE PLAN

SCALE: 1" = 1'-0"

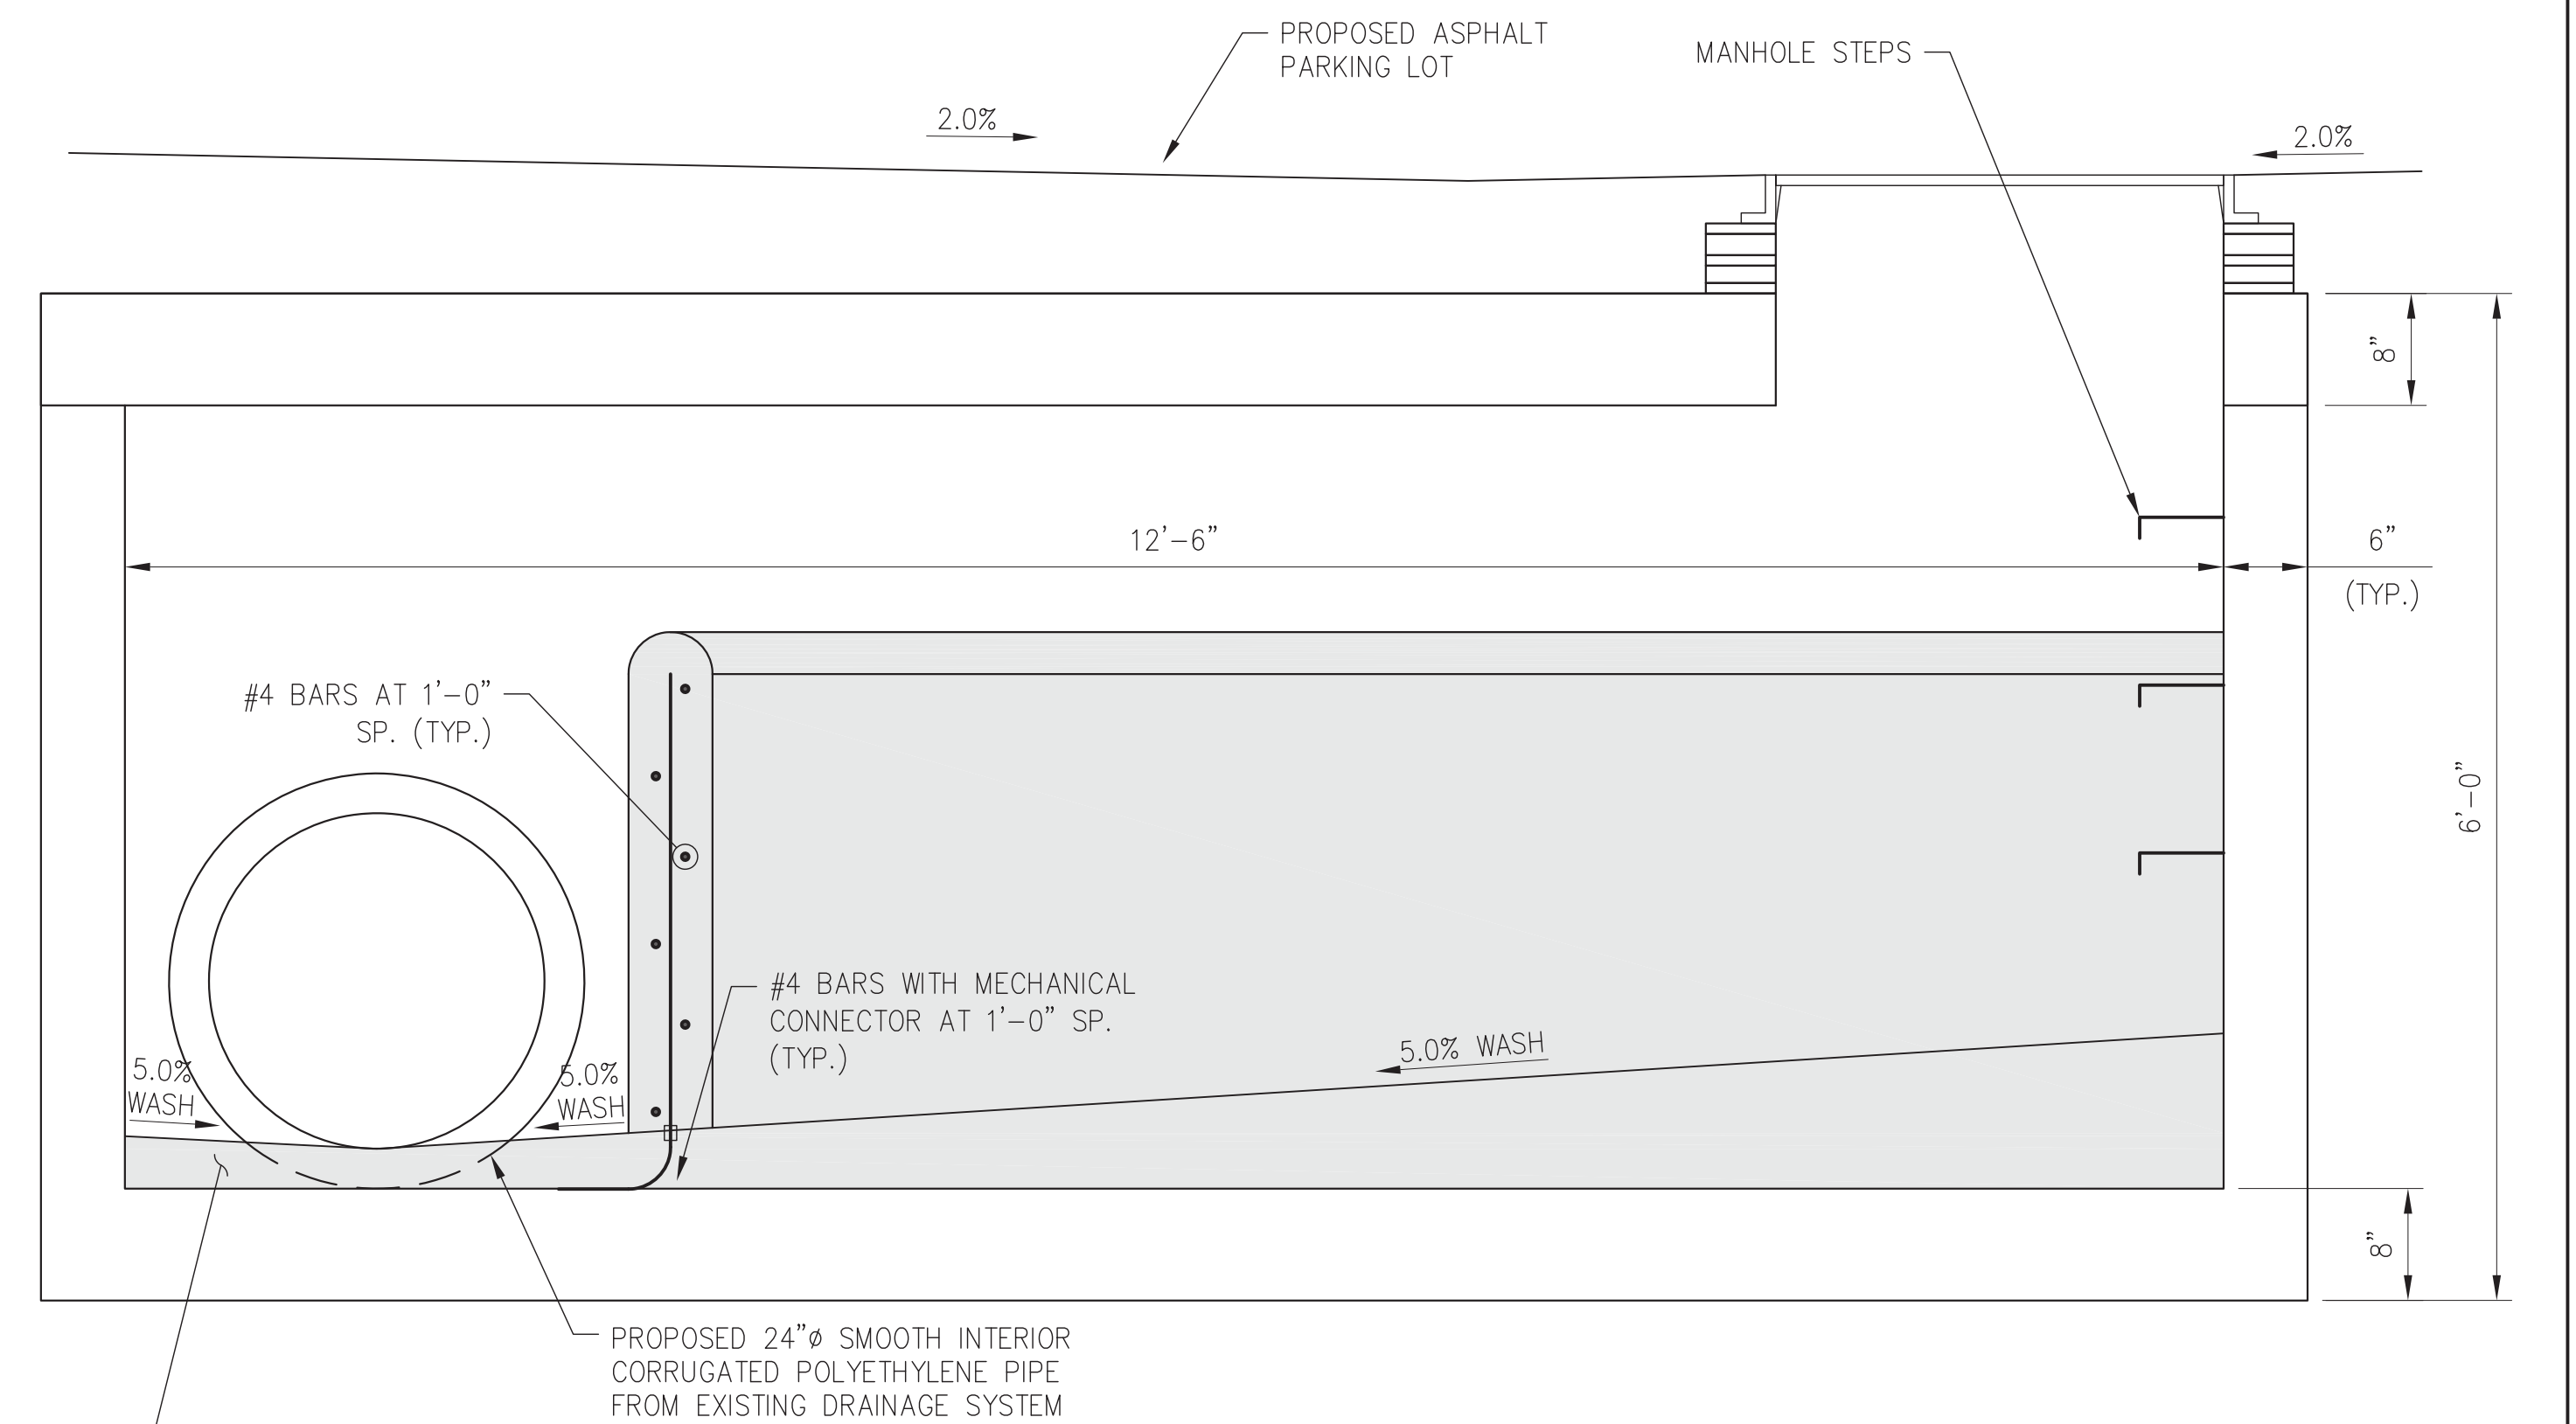

DRAINAGE STRUCTURE SECTION A-A
SCALE: 1" = 1'-0"

1. PROPOSED GRATE AND CURB INLET SHALL BE NEENAH FOUNDRY COMBINATION INLET R-3287-15 OR EQUAL.

PURCHASE COLLEGE
735 ANDERSON HILL ROAD
PURCHASE, NY 10577

LU ENGINEERS
CIVIL ENGINEERING
50 LAKEFRONT BLVD. SUITE 212
BUFFALO, NY 14202
P: 716.849.0982
www.luengineers.com





ATLANTIC TESTING LABORATORIES
GEOTECHNICAL ENGINEERING
 251 UPPER NORTH ROAD
 HIGHLAND, NY 12528
 P: 845.691.6098
www.atlantictesting.com

AA PROJECT #:	150024
PROJECT PHASE:	100% CONTRACT DOCUMENTS

DRAINAGE DETAILS


S1

 C-504

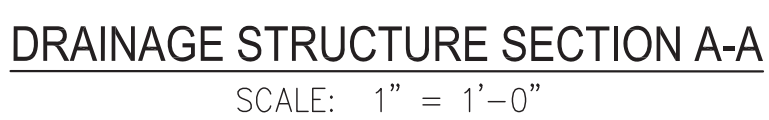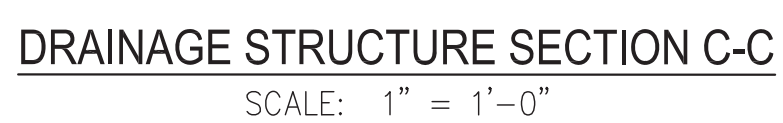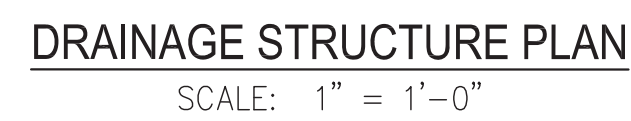


1. PROPOSED GRATE AND CURB INLET SHALL BE NEENAH FOUNDRY COMBINATION INLET R-3287-15 OR EQUAL.

DRAWING FILE PATH: Z:\PROJECTS\50384 ANDROPOGON ASSOCIATES, LTD\50384-01 GREEN INFRASTRUCTURE-SUNY PURCHASE\ACADD\CD DESIGN\50384-01_DET-1.DWG
DATE MODIFIED: 7/18/2018

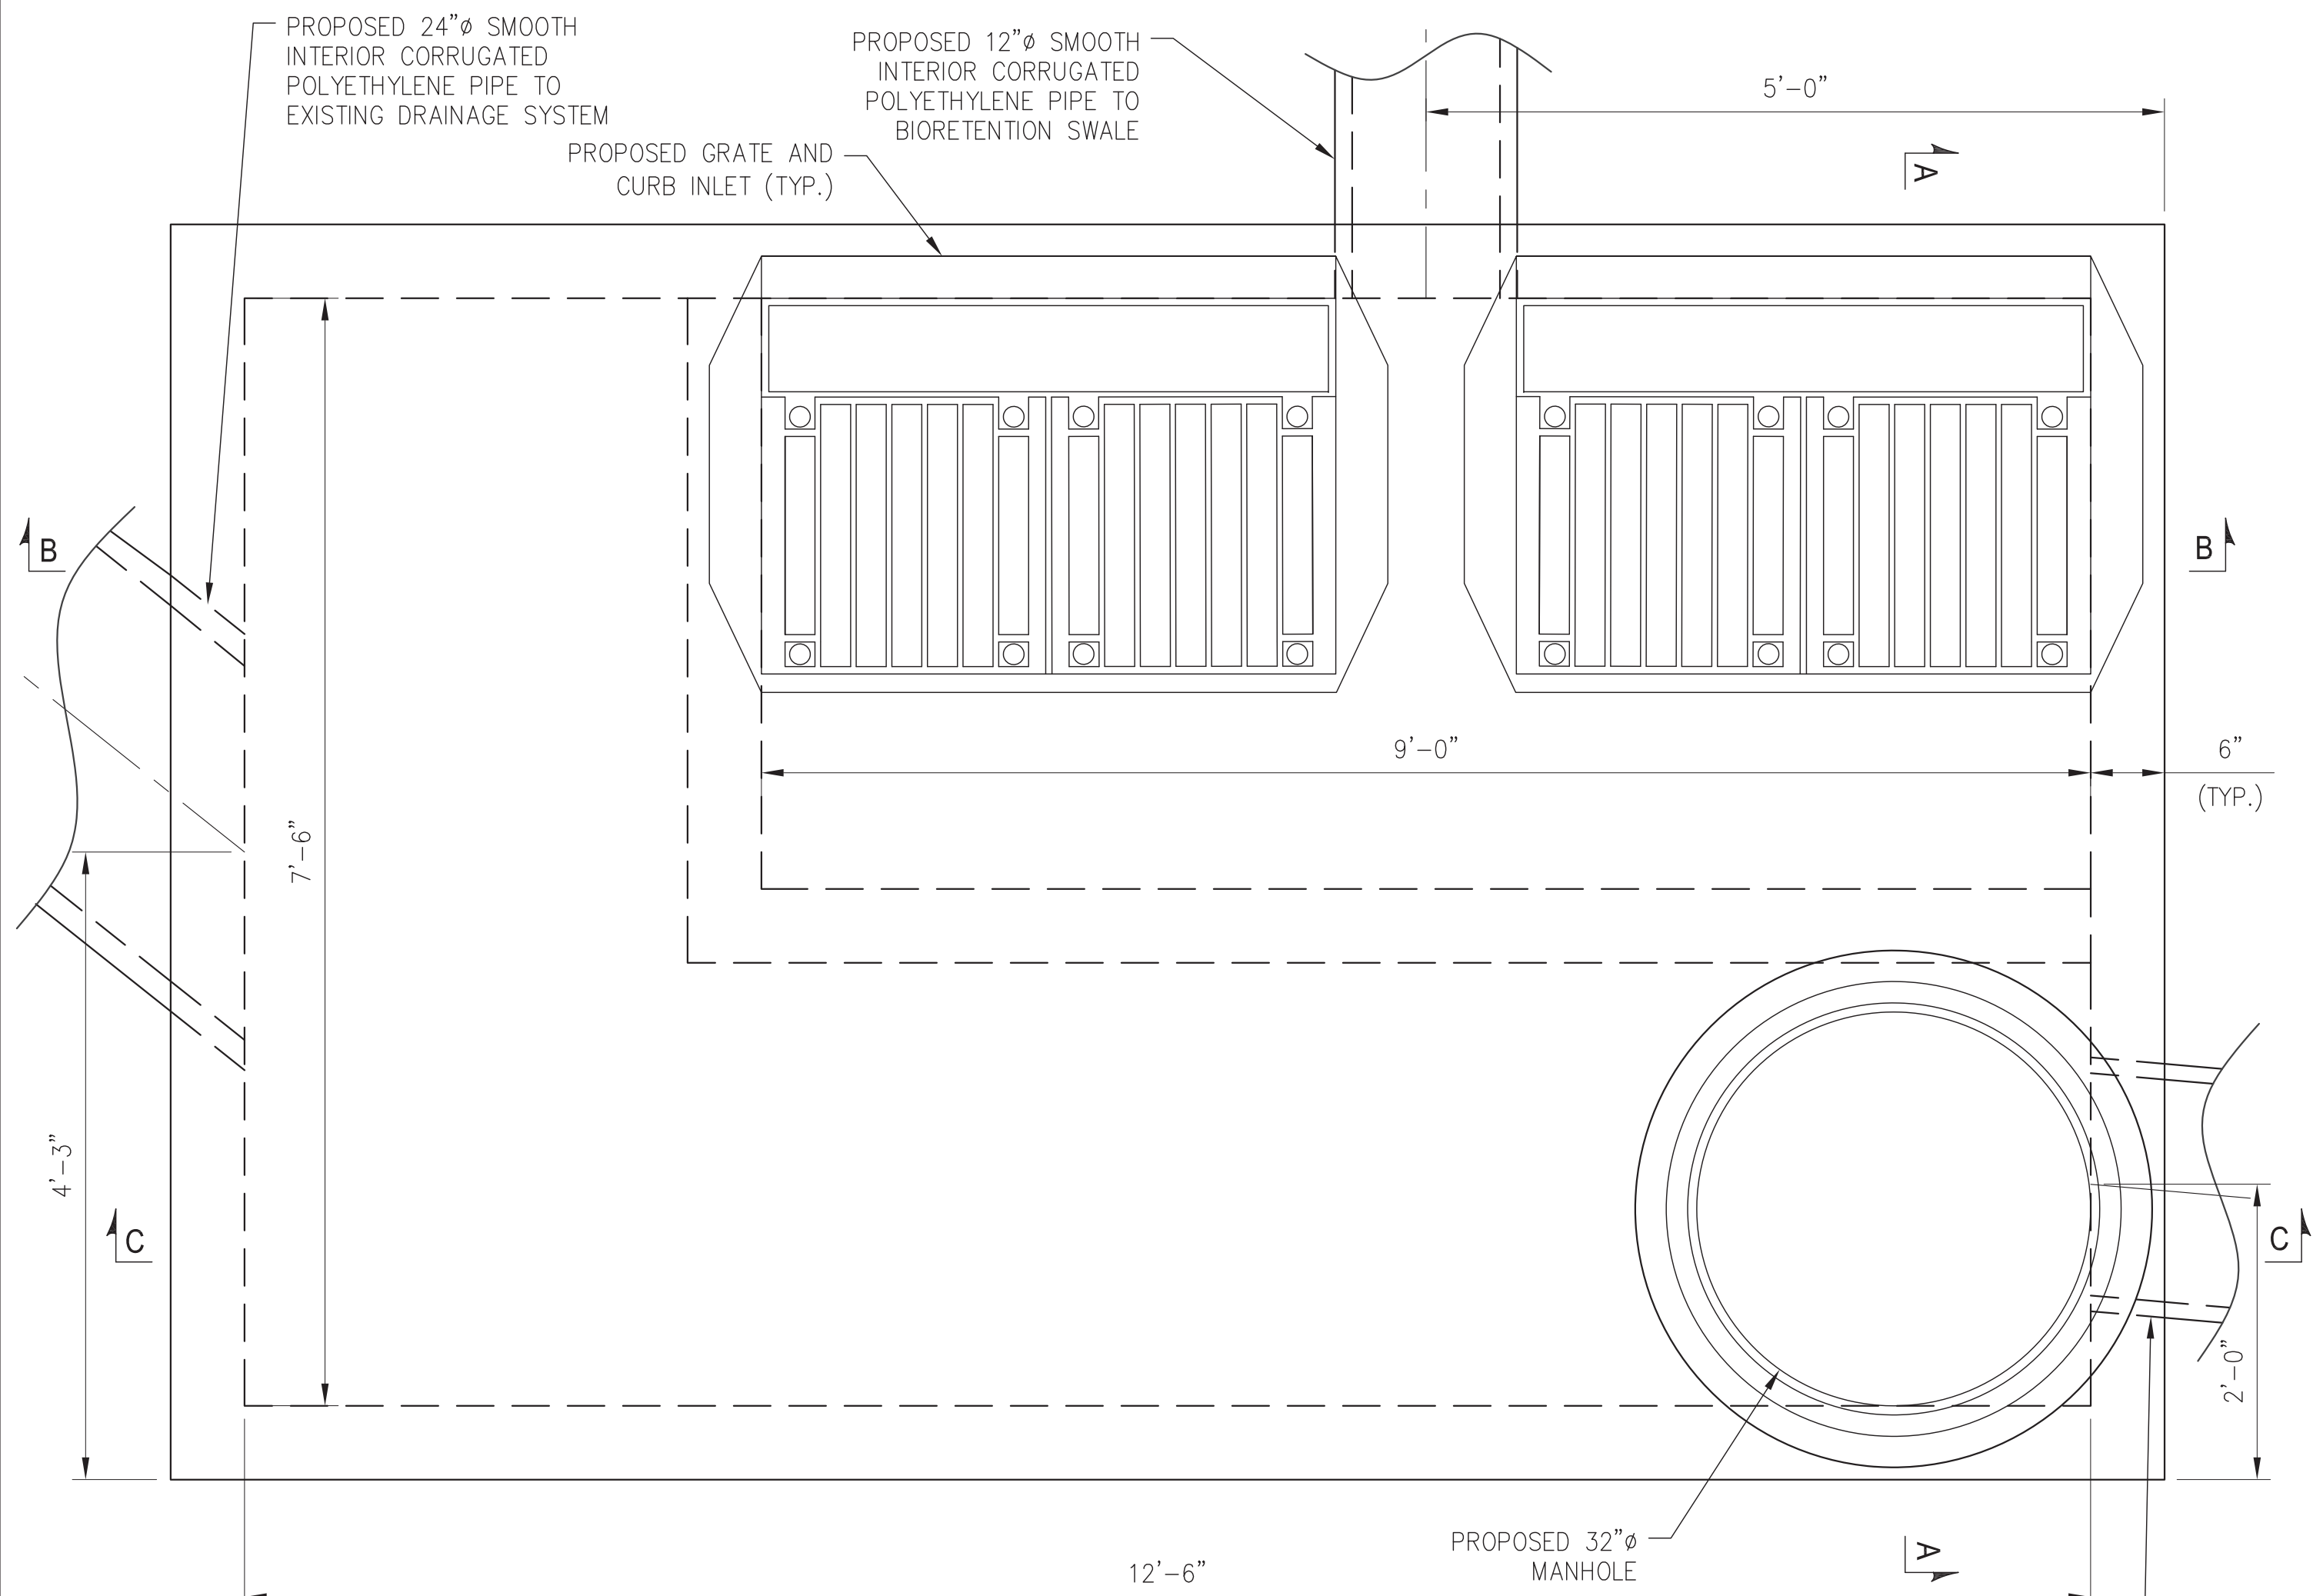


DRAINAGE STRUCTURE PLAN

SCALE: 1" = 1'-0"

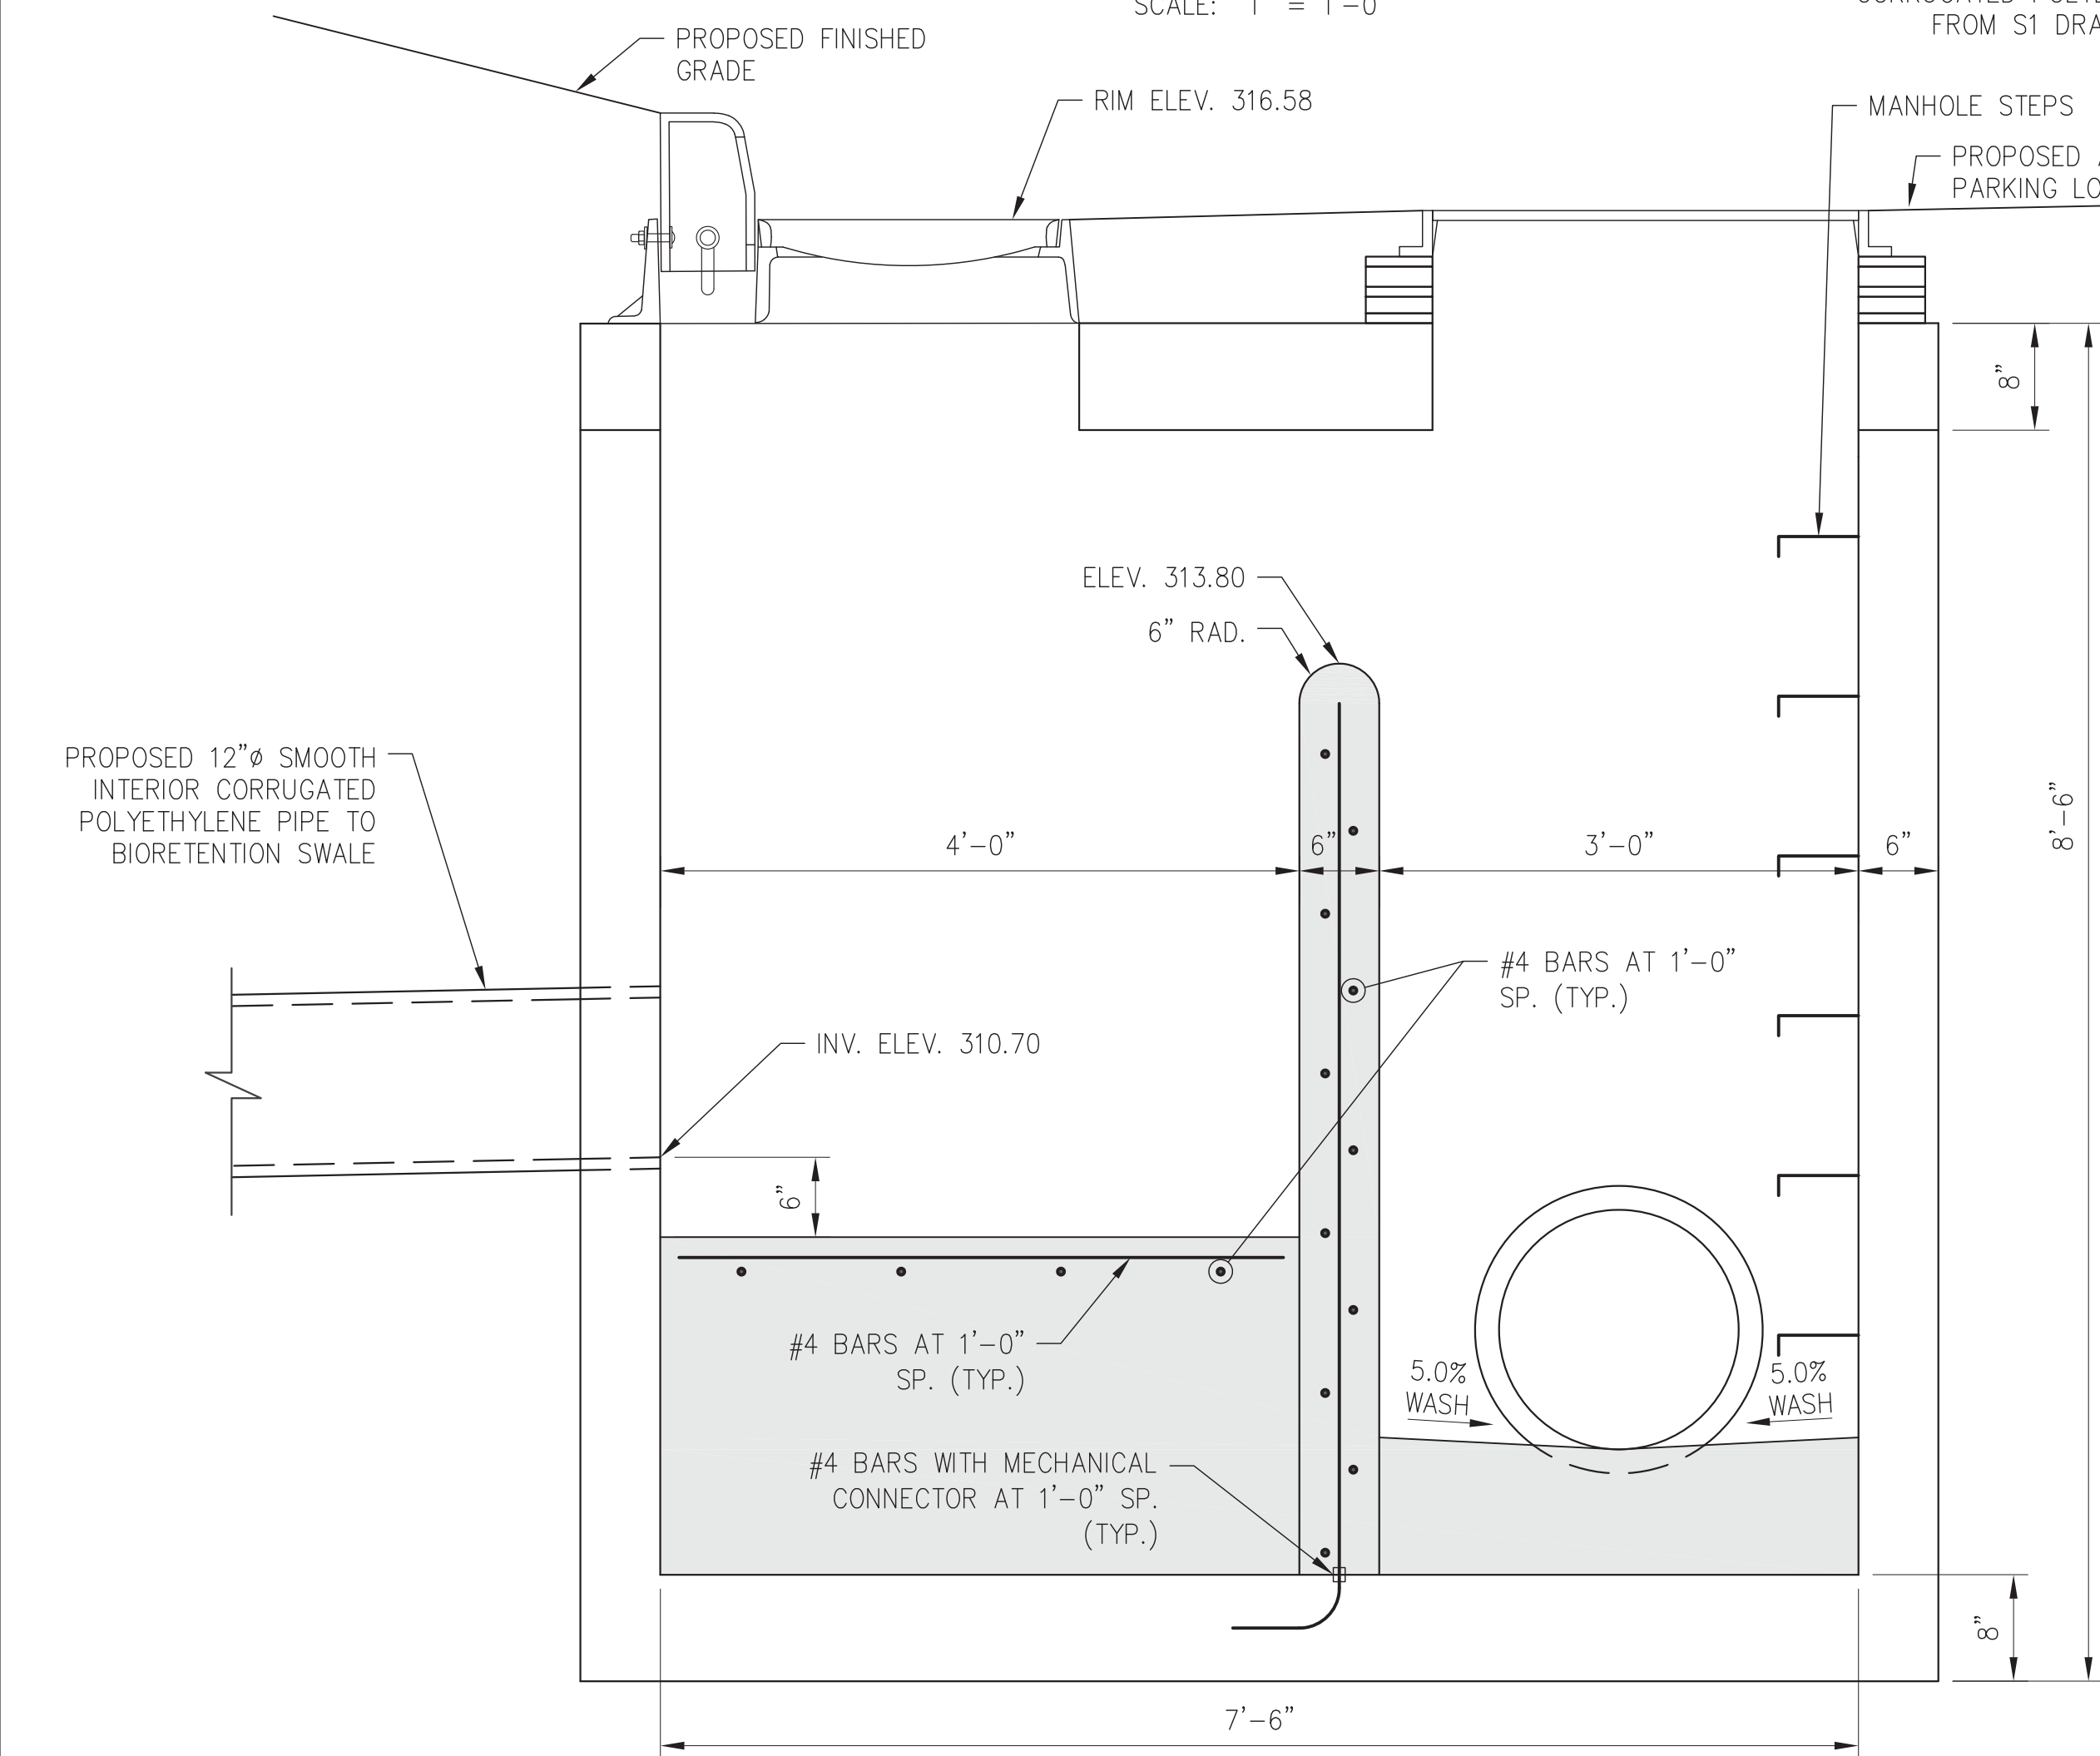


DRAINAGE STRUCTURE SECTION A-A

SCALE: 1" = 1'-0"

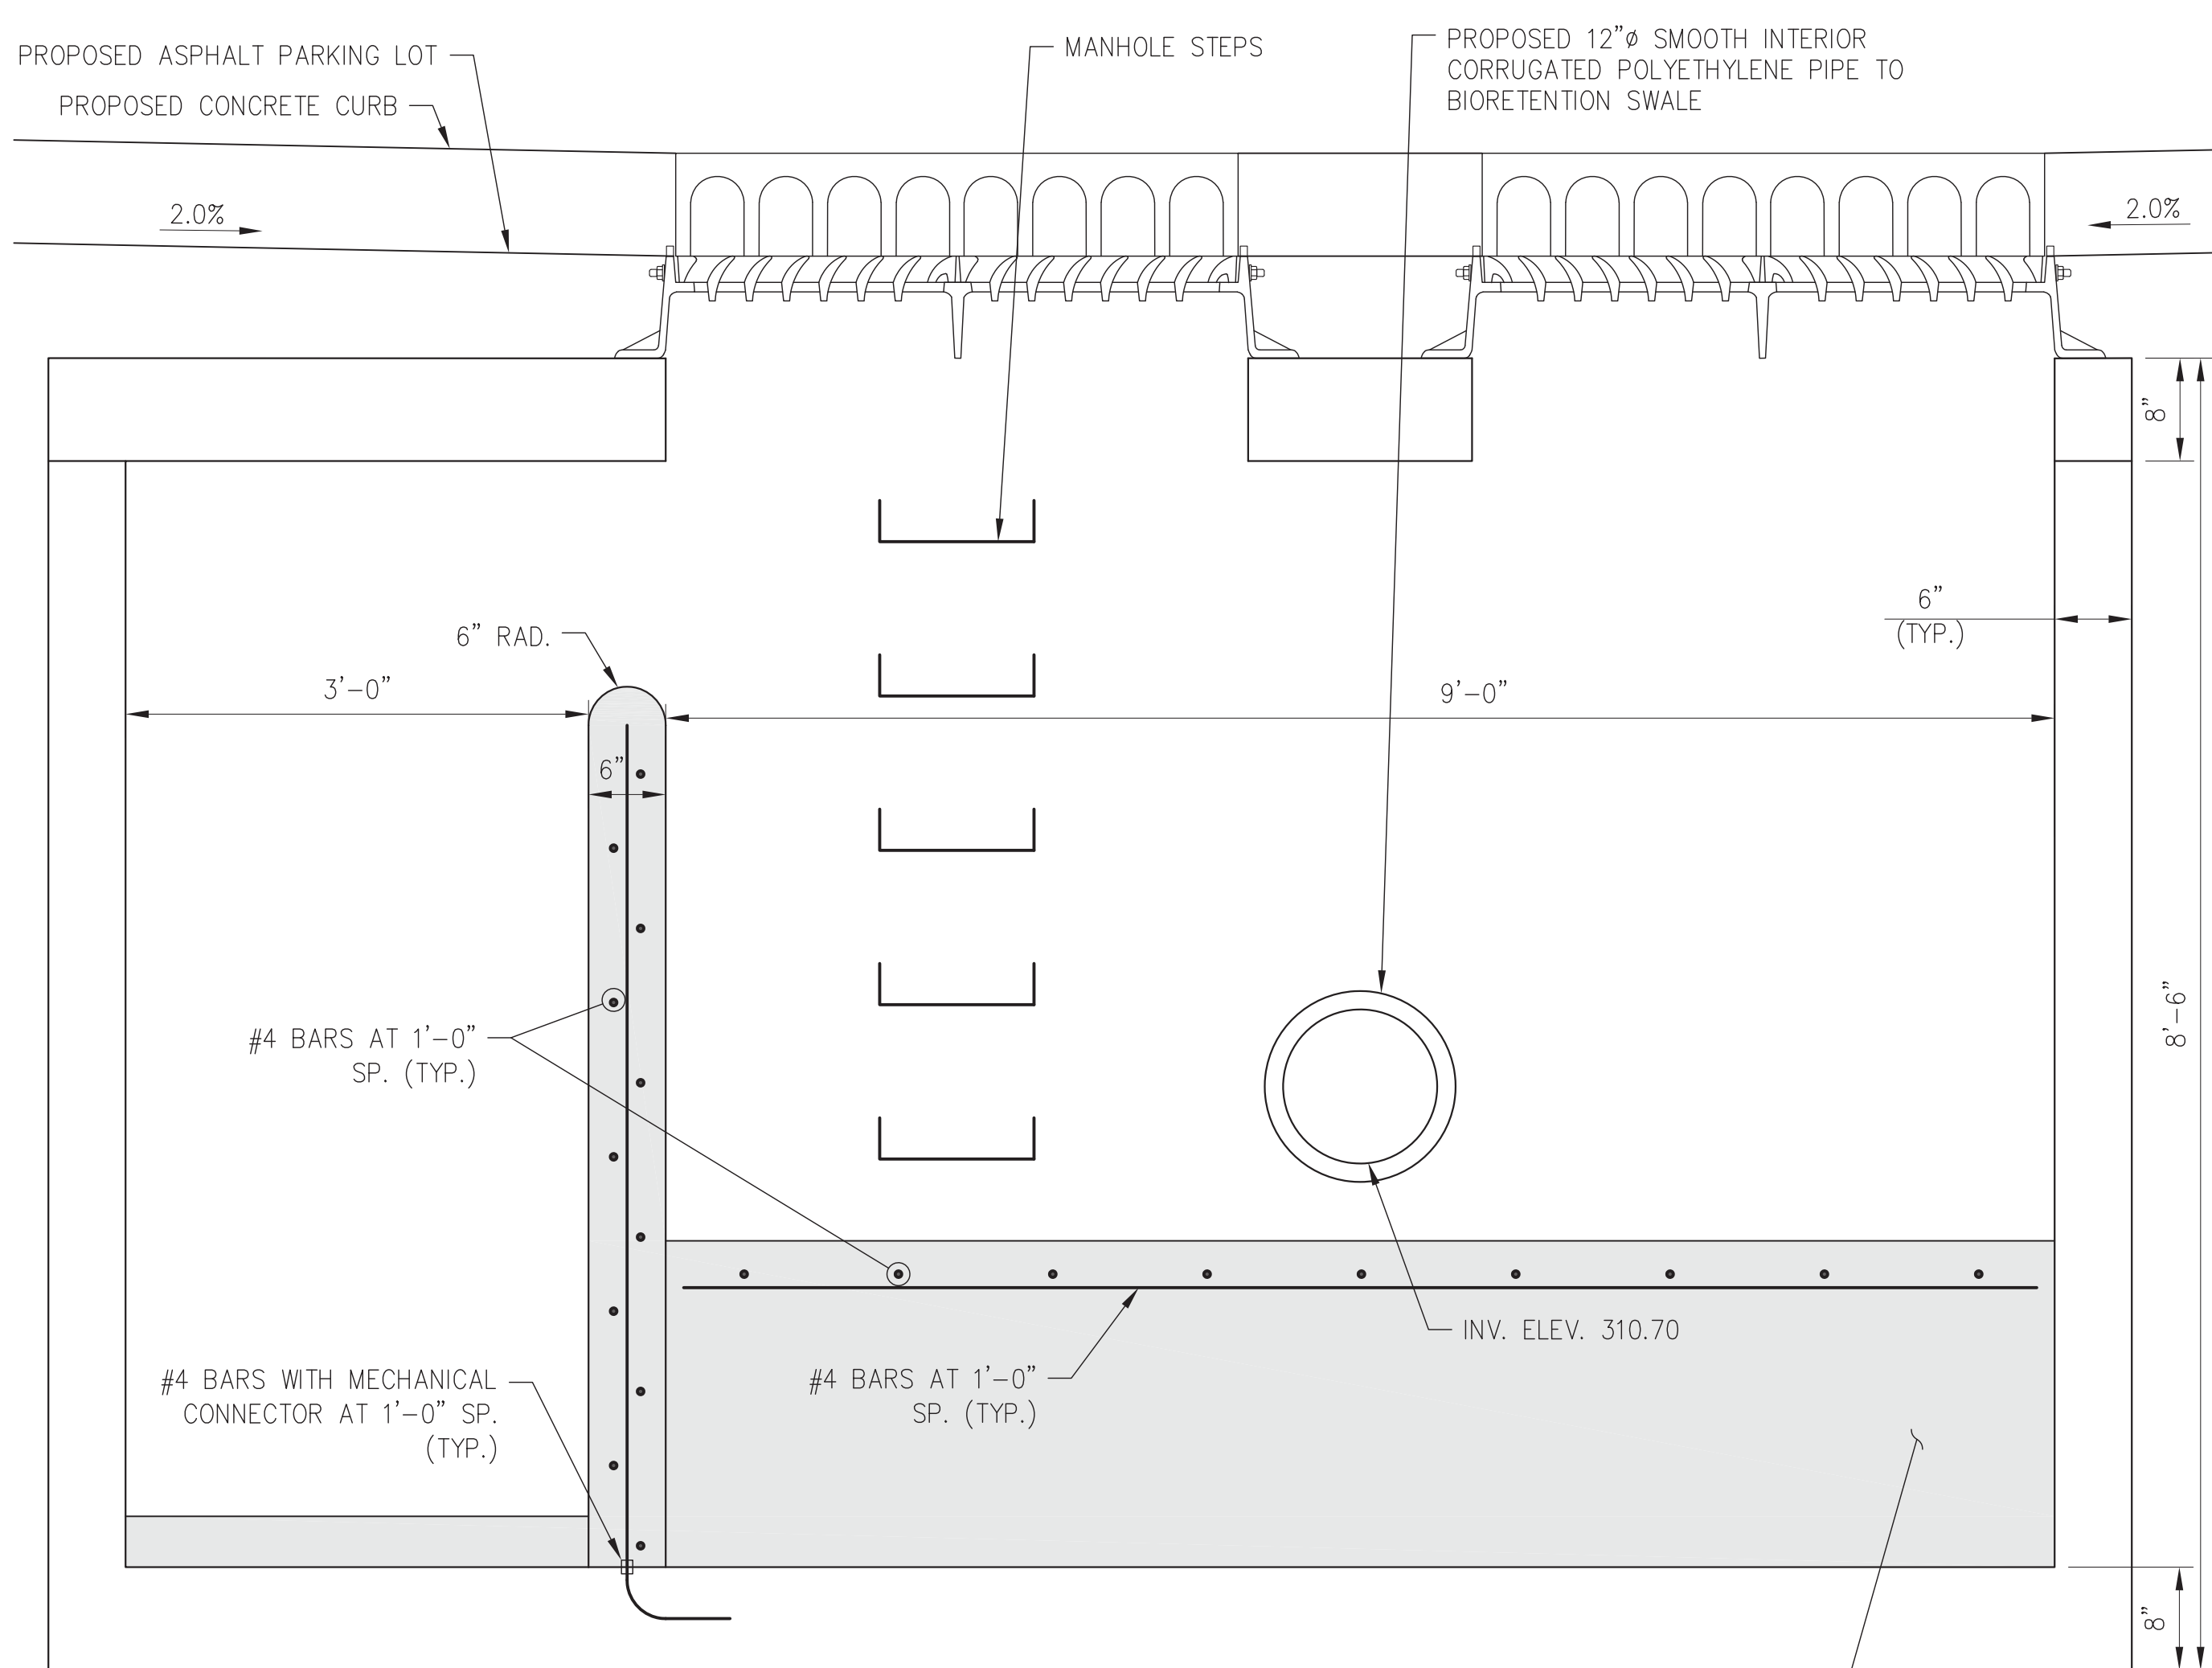


DRAINAGE STRUCTURE SECTION B-B

SCALE: 1" = 1'-0"

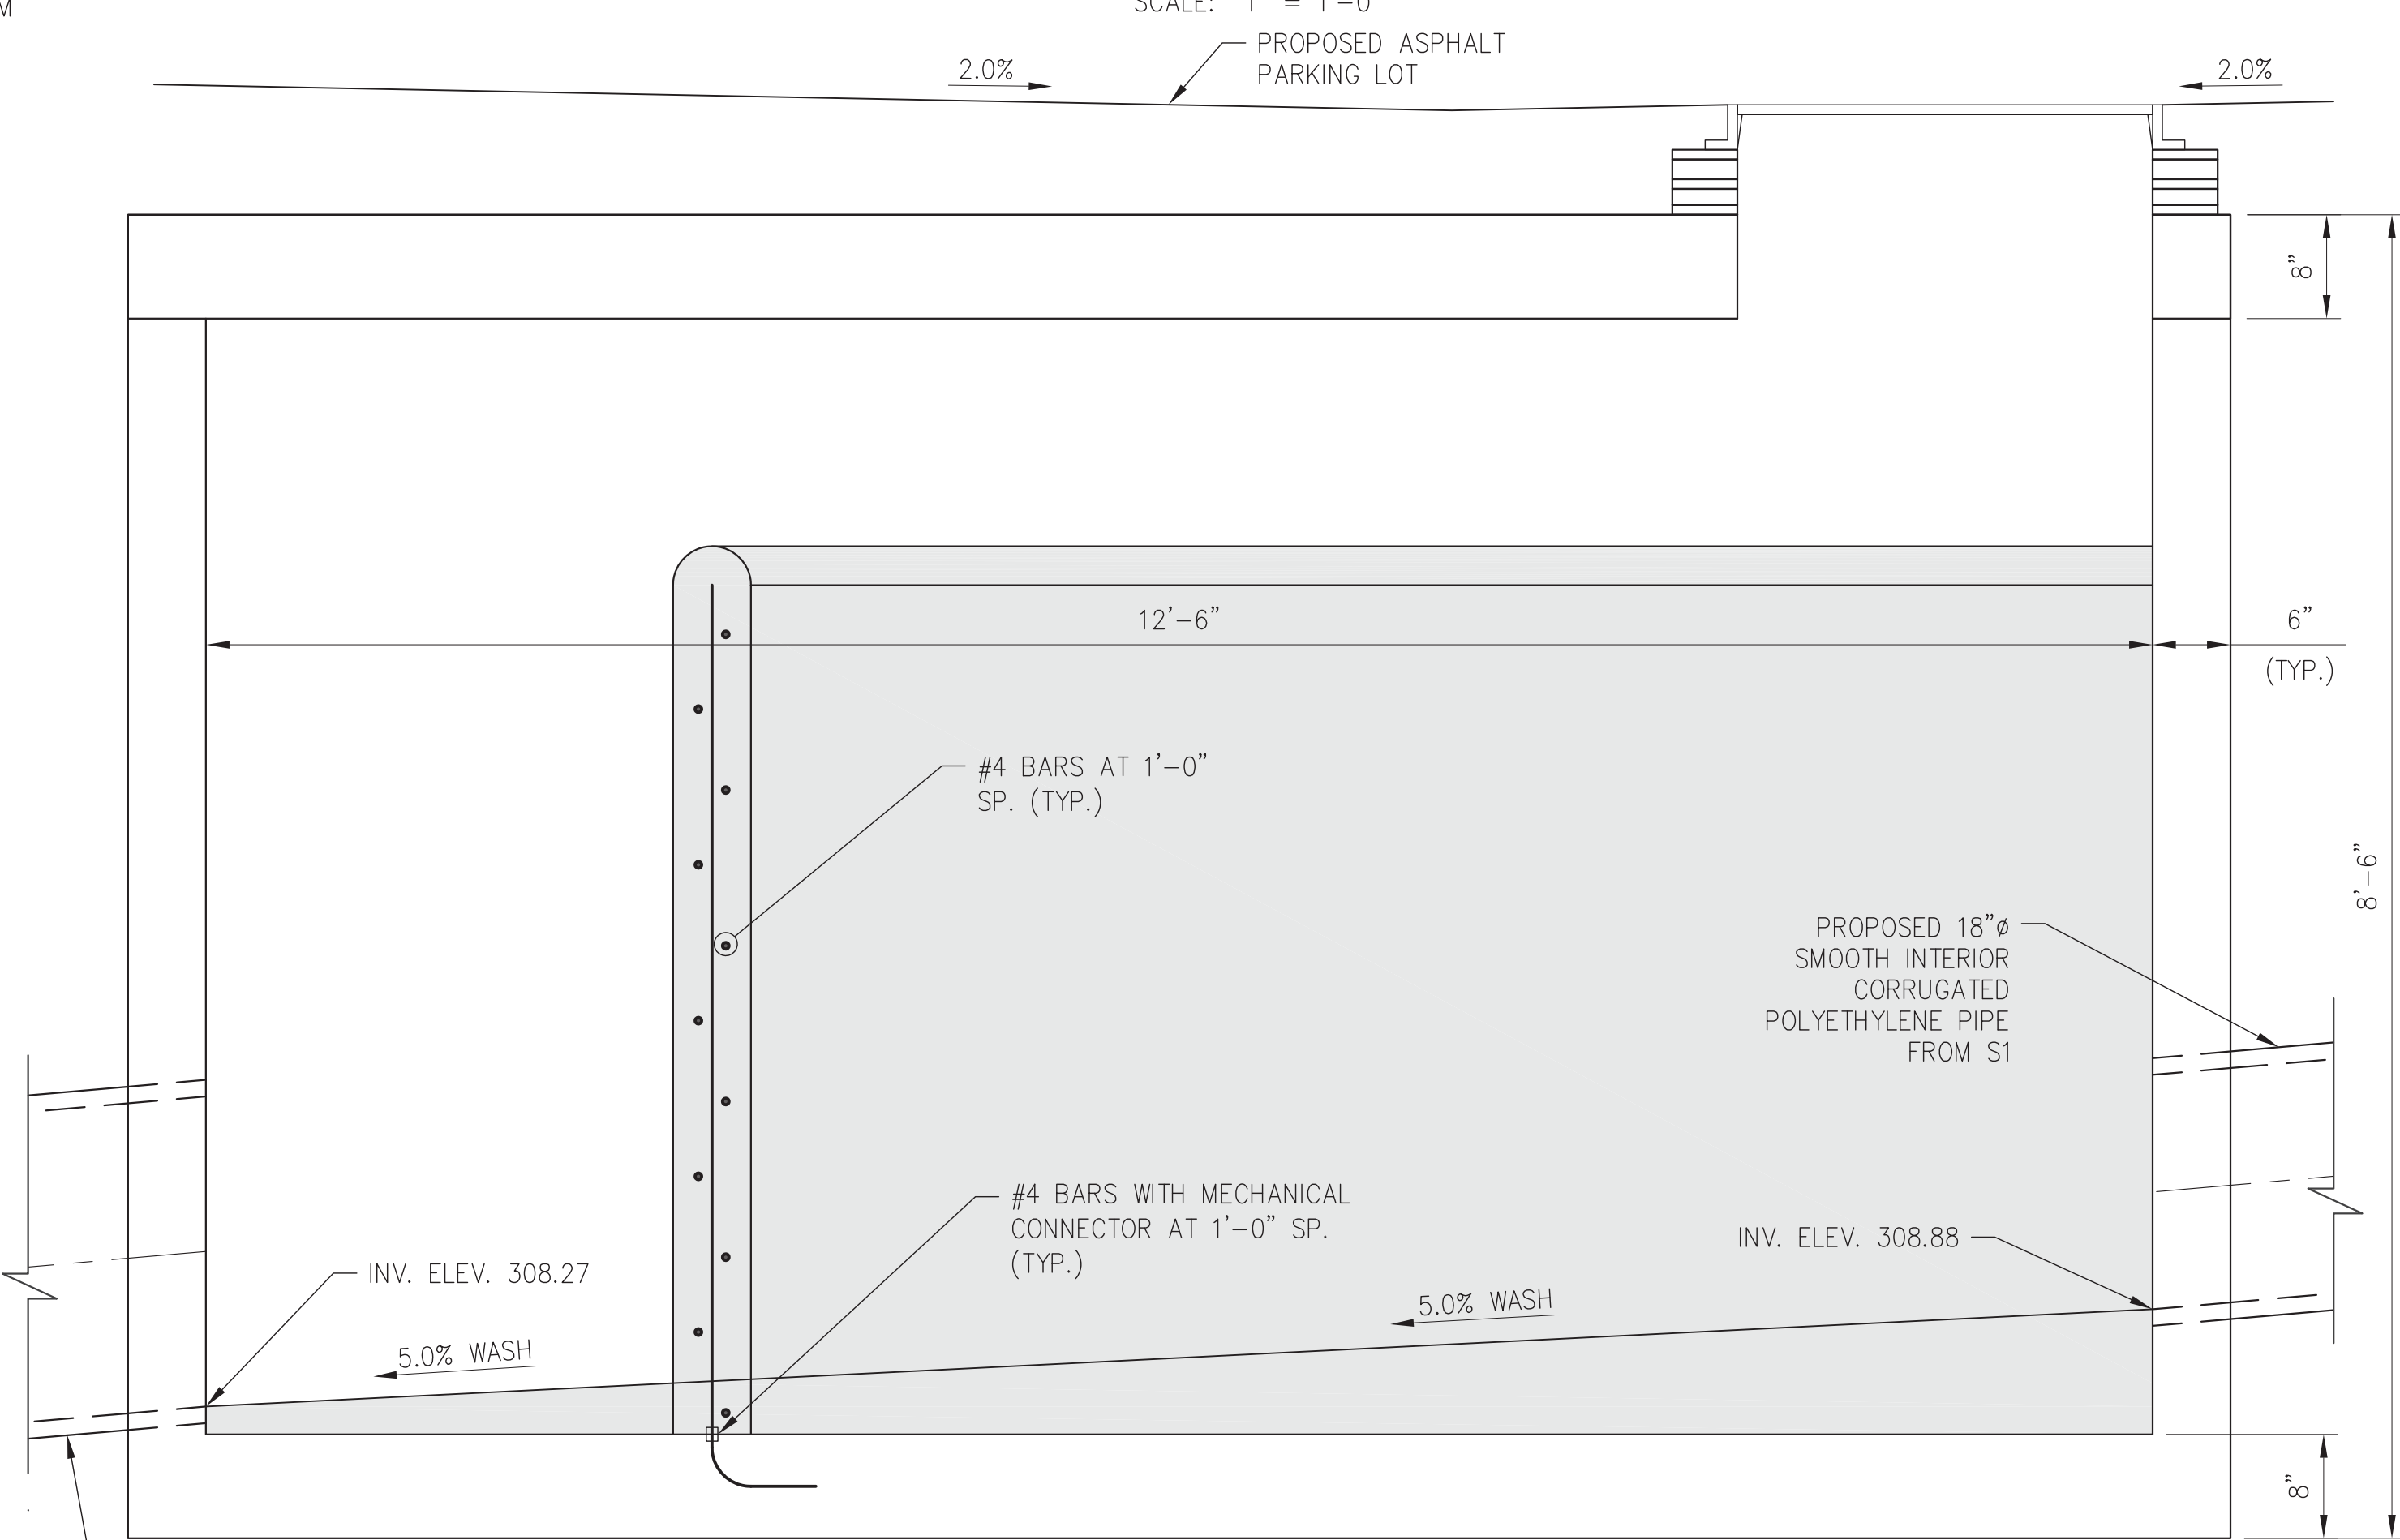

DRAINAGE STRUCTURE SECTION C-C

 SCALE: 1" = 1'-0"



NOTES:

1. PROPOSED GRATE AND CURB INLET SHALL BE NEENAH FOUNDRY COMBINATION INLET R-3287-15 OR EQUAL.



ANDROPOGON ASSOCIATES, LTD
10 SHURS LANE
PHILADELPHIA, PA 19127
T: 215.487.0700
F: 215.483.7520
W: www.andropogon.com

PURCHASE COLLEGE GREEN INFRASTRUCTURE

PURCHASE COLLEGE
735 ANDERSON HILL ROAD
PURCHASE, NY 10577

LU ENGINEERS
CIVIL ENGINEERING
50 LAKEFRONT BLVD. SUITE 212
BUFFALO, NY 14202
P: 716.849.0982
www.luengineers.com

ATLANTIC TESTING LABORATORIES
GEOTECHNICAL ENGINEERING
251 UPPER NORTH ROAD
HIGHLAND, NY 12528
P: 845.691.6098
www.atlantictesting.com

REV. DATE DESCRIPTION

REV.	DATE	DESCRIPTION



SCALE:	AS SHOWN
DATE:	07.06.2018
DRAWN BY:	PMB
CHECKED BY:	TJN
APPROVED BY:	KDW

AA PROJECT #:	150024
PROJECT PHASE:	100% CONTRACT DOCUMENTS

DRAWING TITLE:
DRAINAGE DETAILS
S2

SHEET:

C-505

PURCHASE COLLEGE
735 ANDERSON HILL ROAD
PURCHASE, NY 10577





ATLANTIC TESTING LABORATORIES
GEOTECHNICAL ENGINEERING
 251 UPPER NORTH ROAD
 HIGHLAND, NY 12528
 P: 845.691.6098
www.atlantictesting.com

AA PROJECT #:	150024
PROJECT PHASE:	100% CONTRACT DOCUMENTS

DRAINAGE DETAILS


S3

    C-506




1. PROPOSED GRATE AND CURB INLET SHALL BE NEENAH FOUNDRY COMBINATION INLET R-3287-15 OR EQUAL.


DRAWING FILE PATH: Z:\PROJECTS\50384 ANDROPOGON ASSOCIATES, LTD\50384-01 GREEN INFRASTRUCTURE-SUNY PURCHASE\ADDICD DESIGN\50384-01_DET-1.DWG
DATE MODIFIED: 7/18/2018

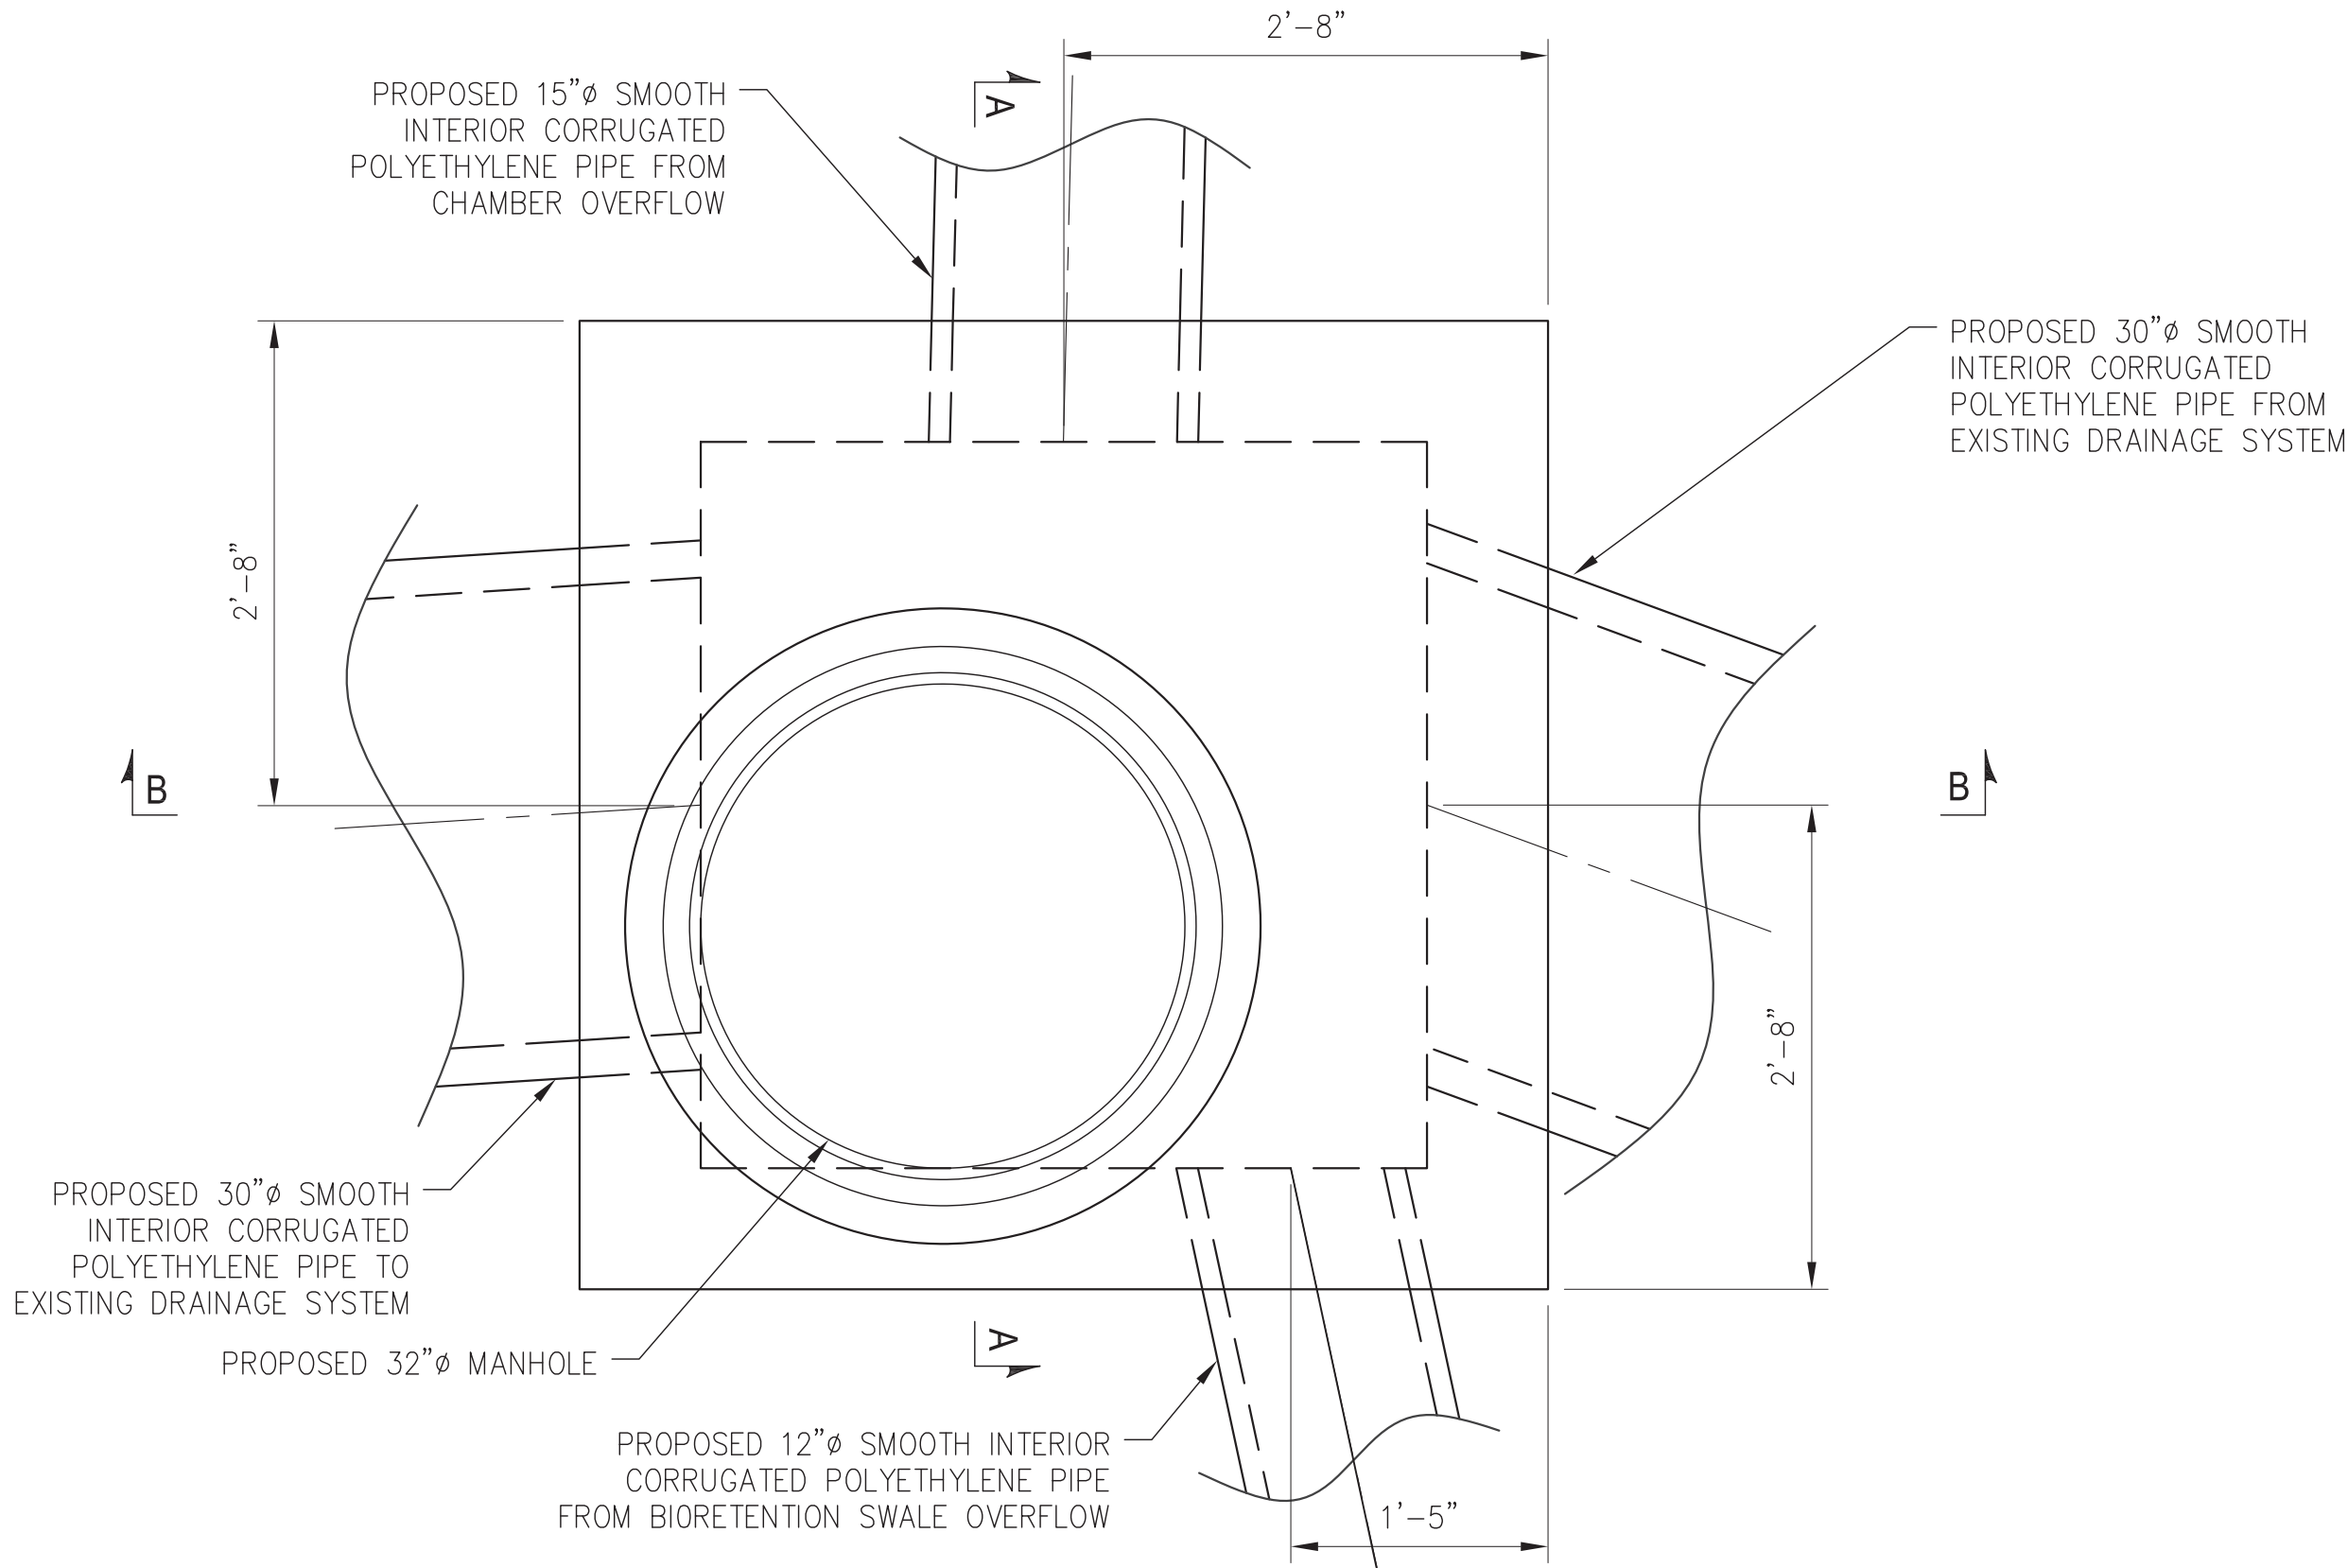


DRAINAGE STRUCTURE PLAN
SCALE: 1" = 1'-0"

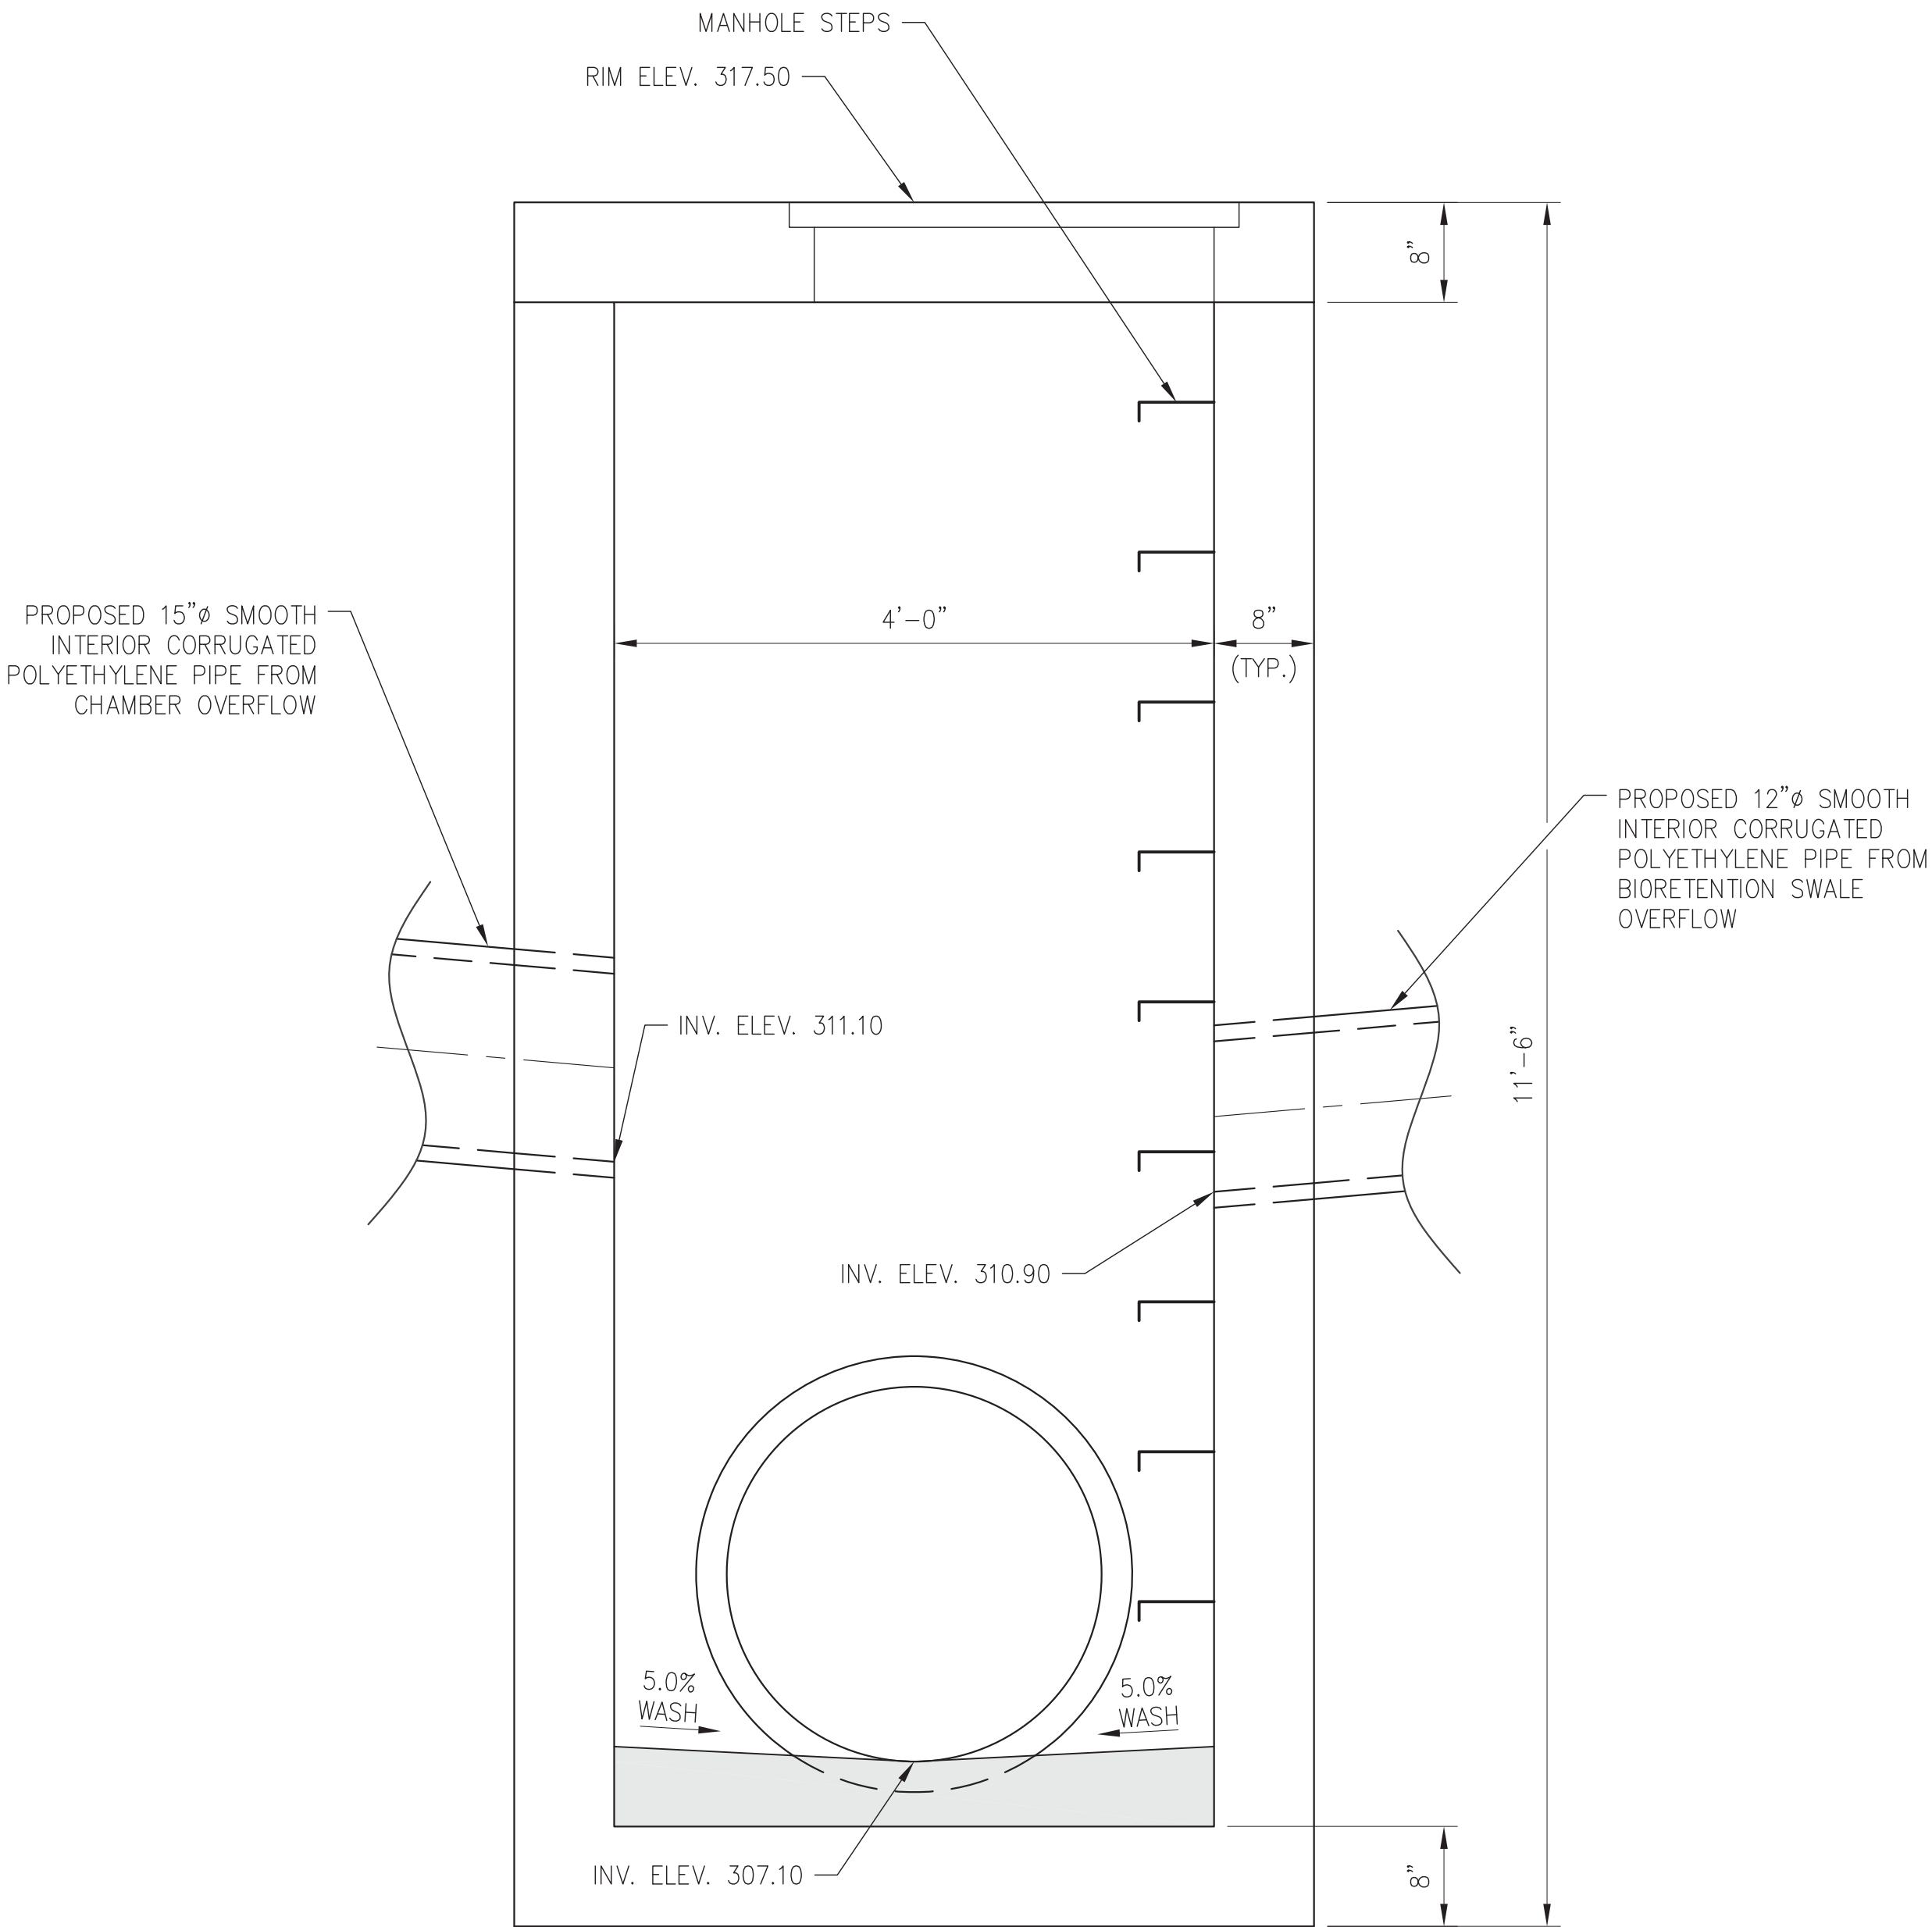

DRAINAGE STRUCTURE SECTION A-A
SCALE: 1" = 1'-0"

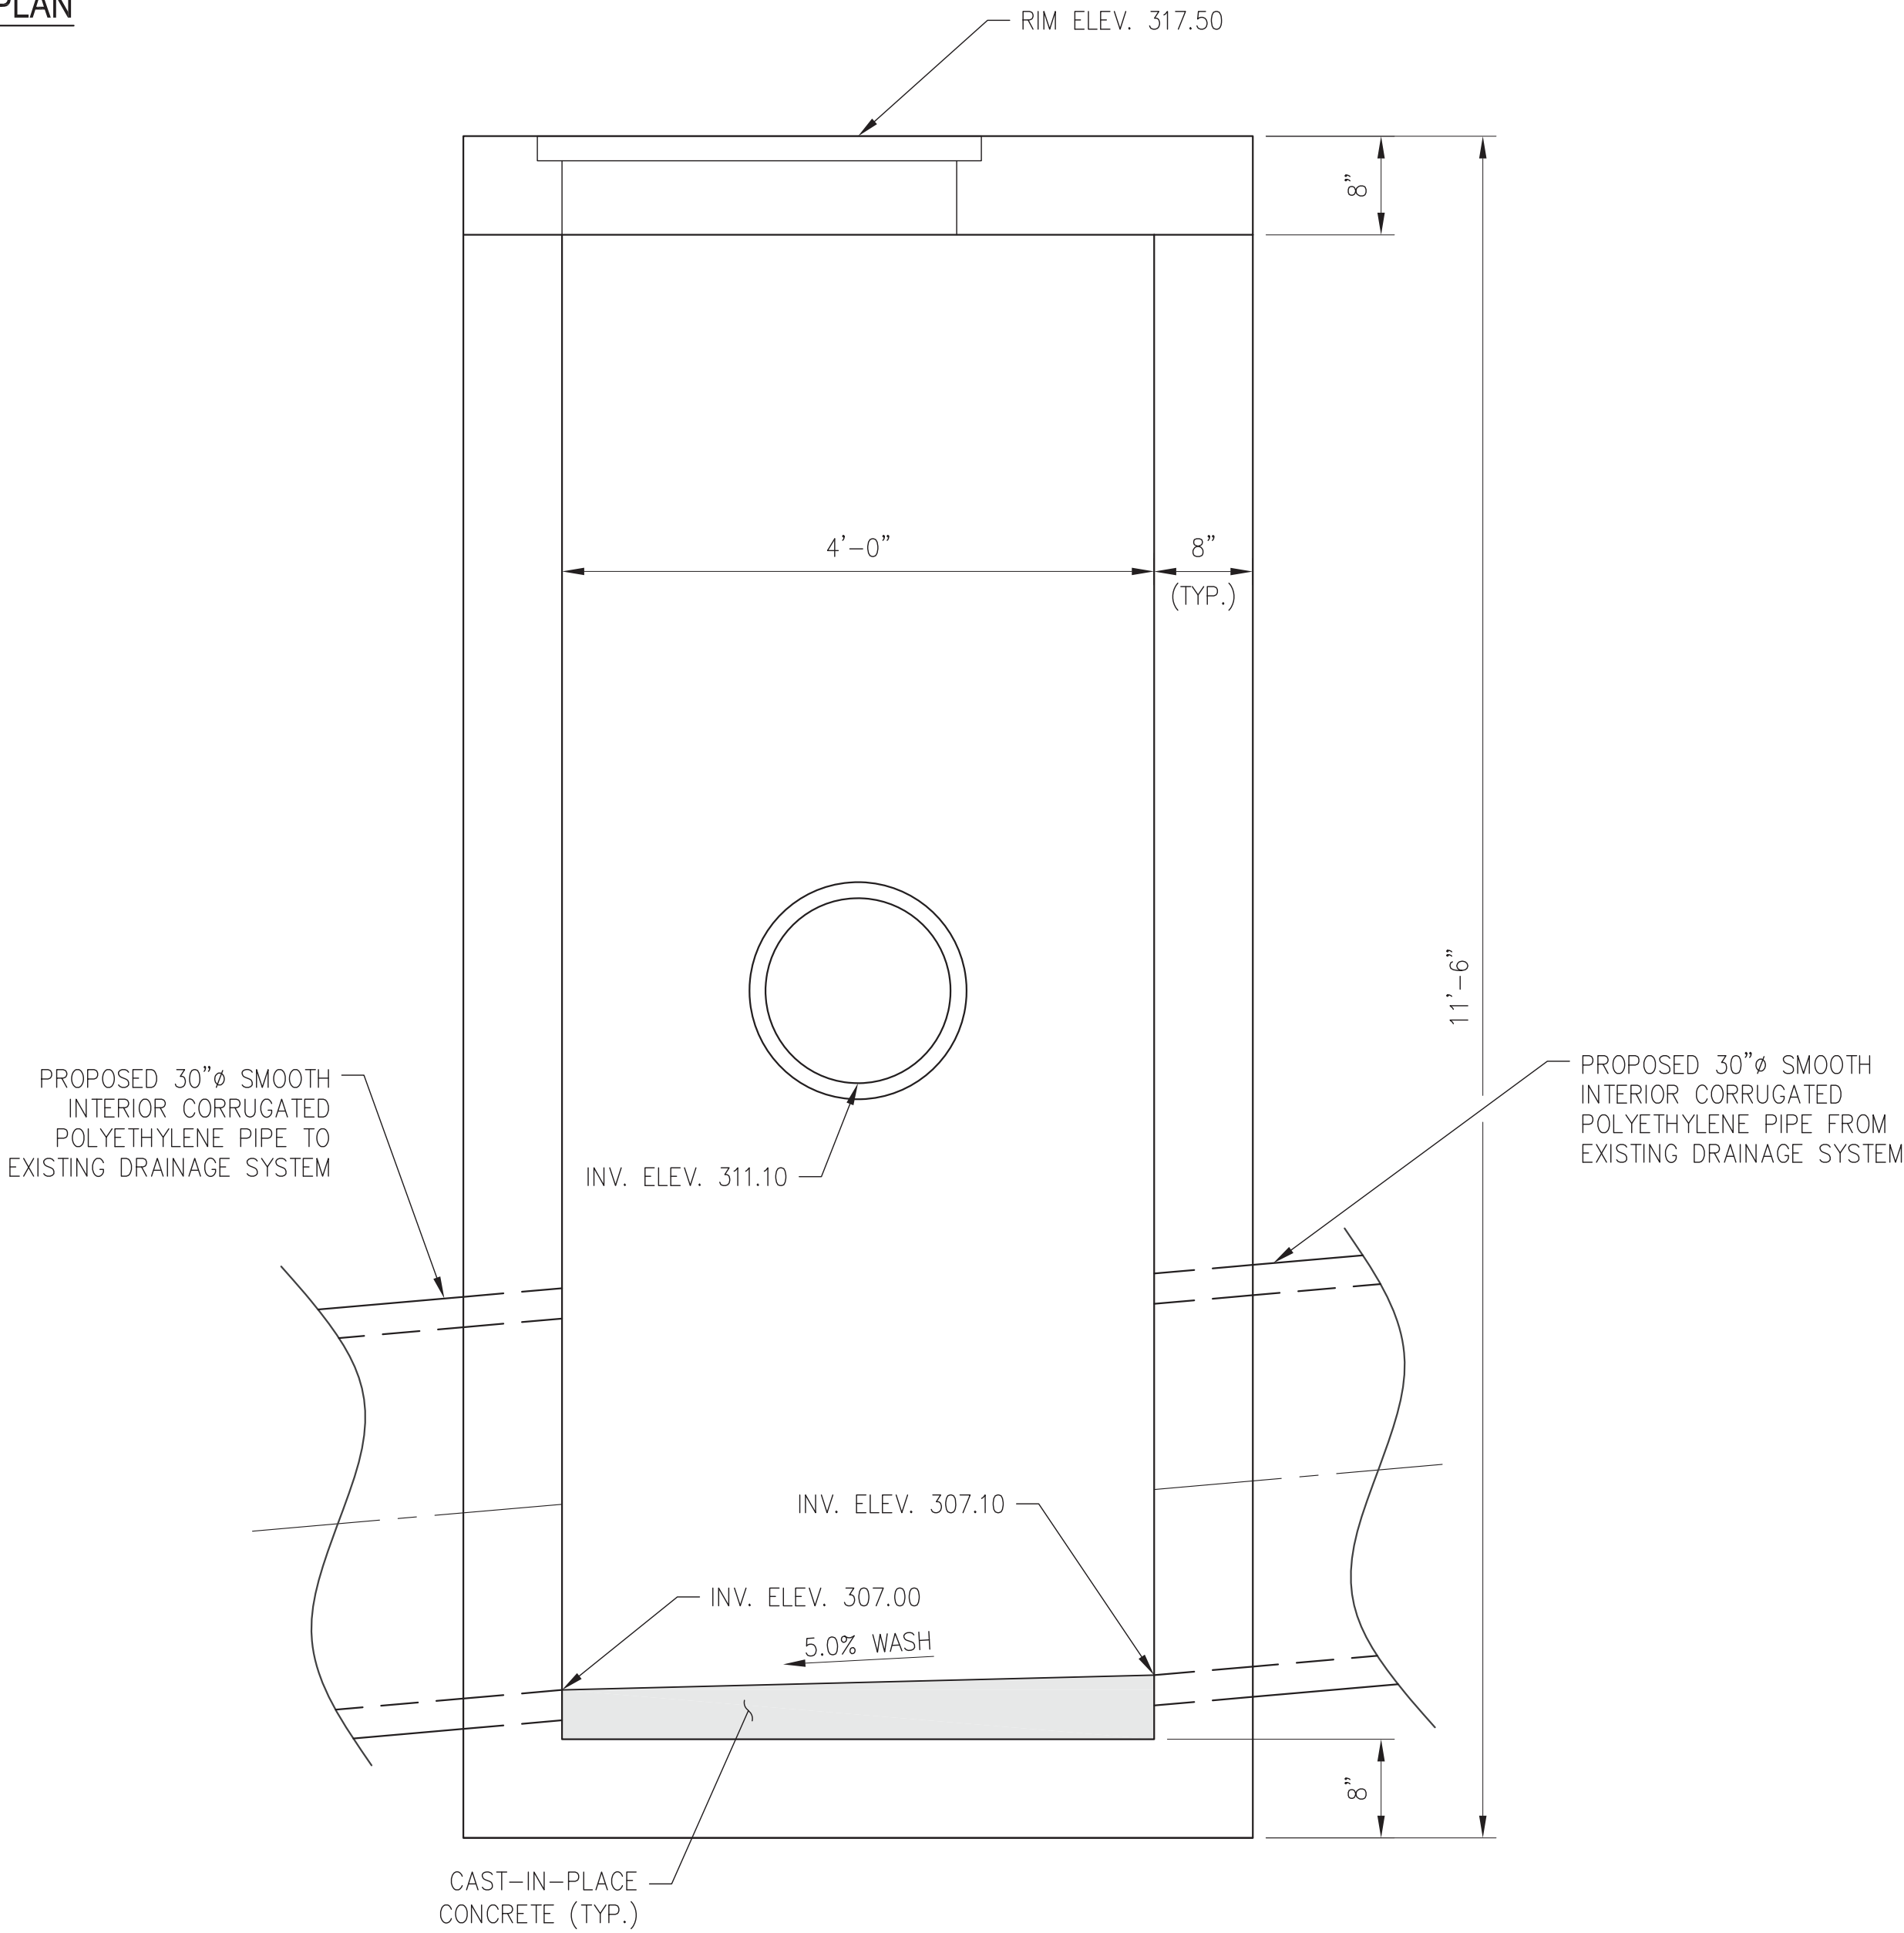

 DRAINAGE STRUCTURE SECTION B-B
SCALE: 1" = 1'-0"



ANDROPOGON ASSOCIATES, LTD
10 SHURS LANE
PHILADELPHIA, PA 19127
T: 215.487.0700
F: 215.483.7520
W: www.andropogon.com

PURCHASE COLLEGE GREEN INFRASTRUCTURE

PURCHASE COLLEGE
735 ANDERSON HILL ROAD
PURCHASE, NY 10577

LU ENGINEERS
CIVIL ENGINEERING
50 LAKEFRONT BLVD. SUITE 212
BUFFALO, NY 14202
P: 716.849.0982
www.luengineers.com

ATLANTIC TESTING LABORATORIES
GEOTECHNICAL ENGINEERING
251 UPPER NORTH ROAD
HIGHLAND, NY 12528
P: 845.691.6098
www.atlantictesting.com

REV.	DATE	DESCRIPTION
------	------	-------------



SCALE:	AS SHOWN
DATE:	07.06.2018
DRAWN BY:	PMB
CHECKED BY:	TJN
APPROVED BY:	KDW

AA PROJECT #:	150024
PROJECT PHASE:	100% CONTRACT DOCUMENTS

DRAWING TITLE:

DRAINAGE STRUCTURE AT S3

SHEET:

C-507

PURCHASE COLLEGE
735 ANDERSON HILL ROAD
PURCHASE, NY 10577





LU ENGINEERS
CIVIL ENGINEERING
50 LAKEFRONT BLVD. SUITE 212
BUFFALO, NY 14202
P: 716.849.0982
www.luengineers.com

ATLANTIC TESTING LABORATORIES
GEOTECHNICAL ENGINEERING
 251 UPPER NORTH ROAD
 HIGHLAND, NY 12528
 P: 845.691.6098
www.atlantictesting.com


AA PROJECT #:	150024
PROJECT PHASE:	100% CONTRACT DOCUMENTS

SHEET:

 C-508

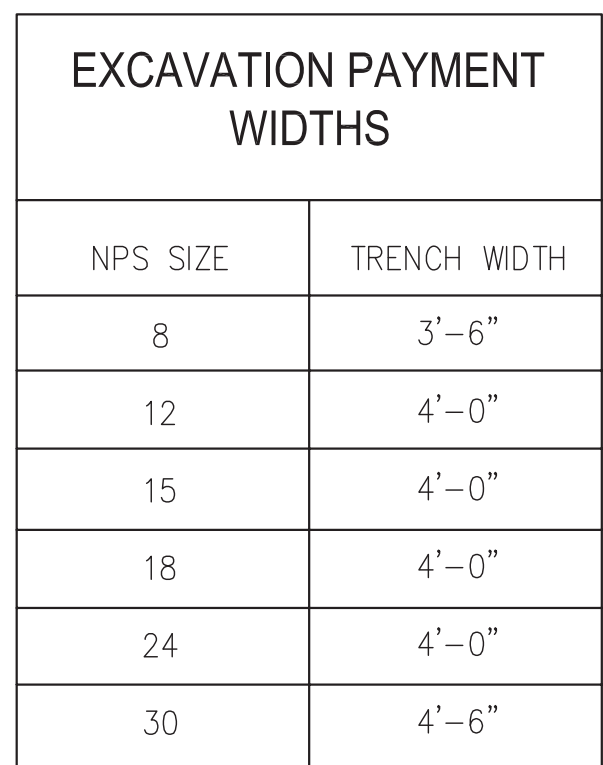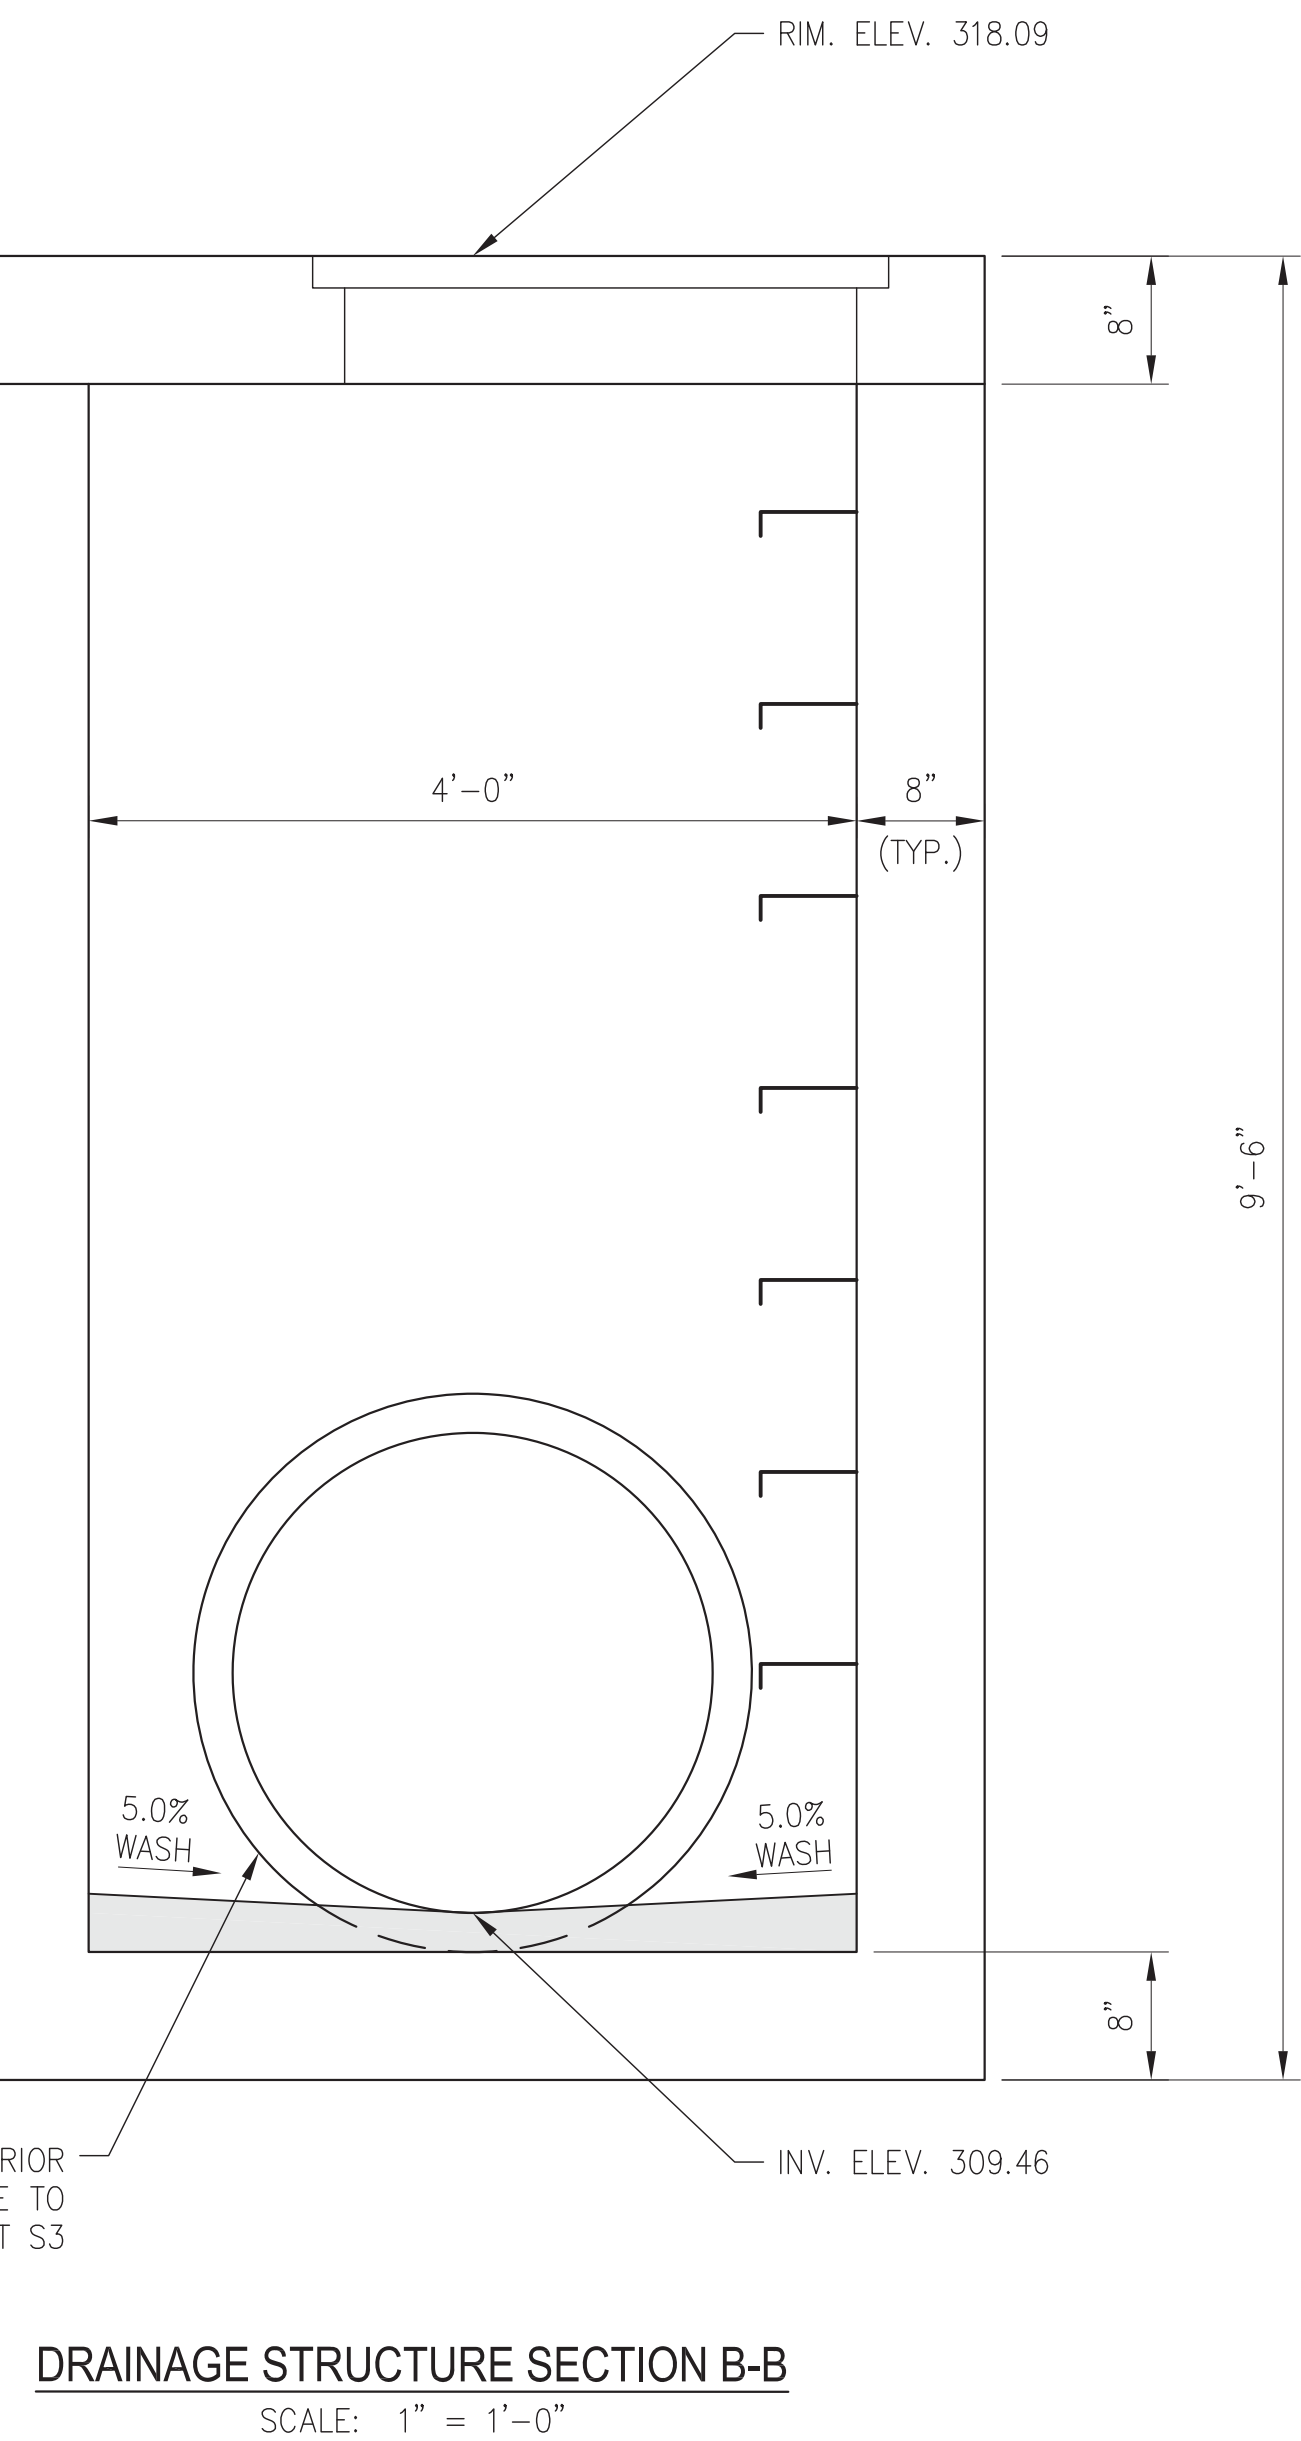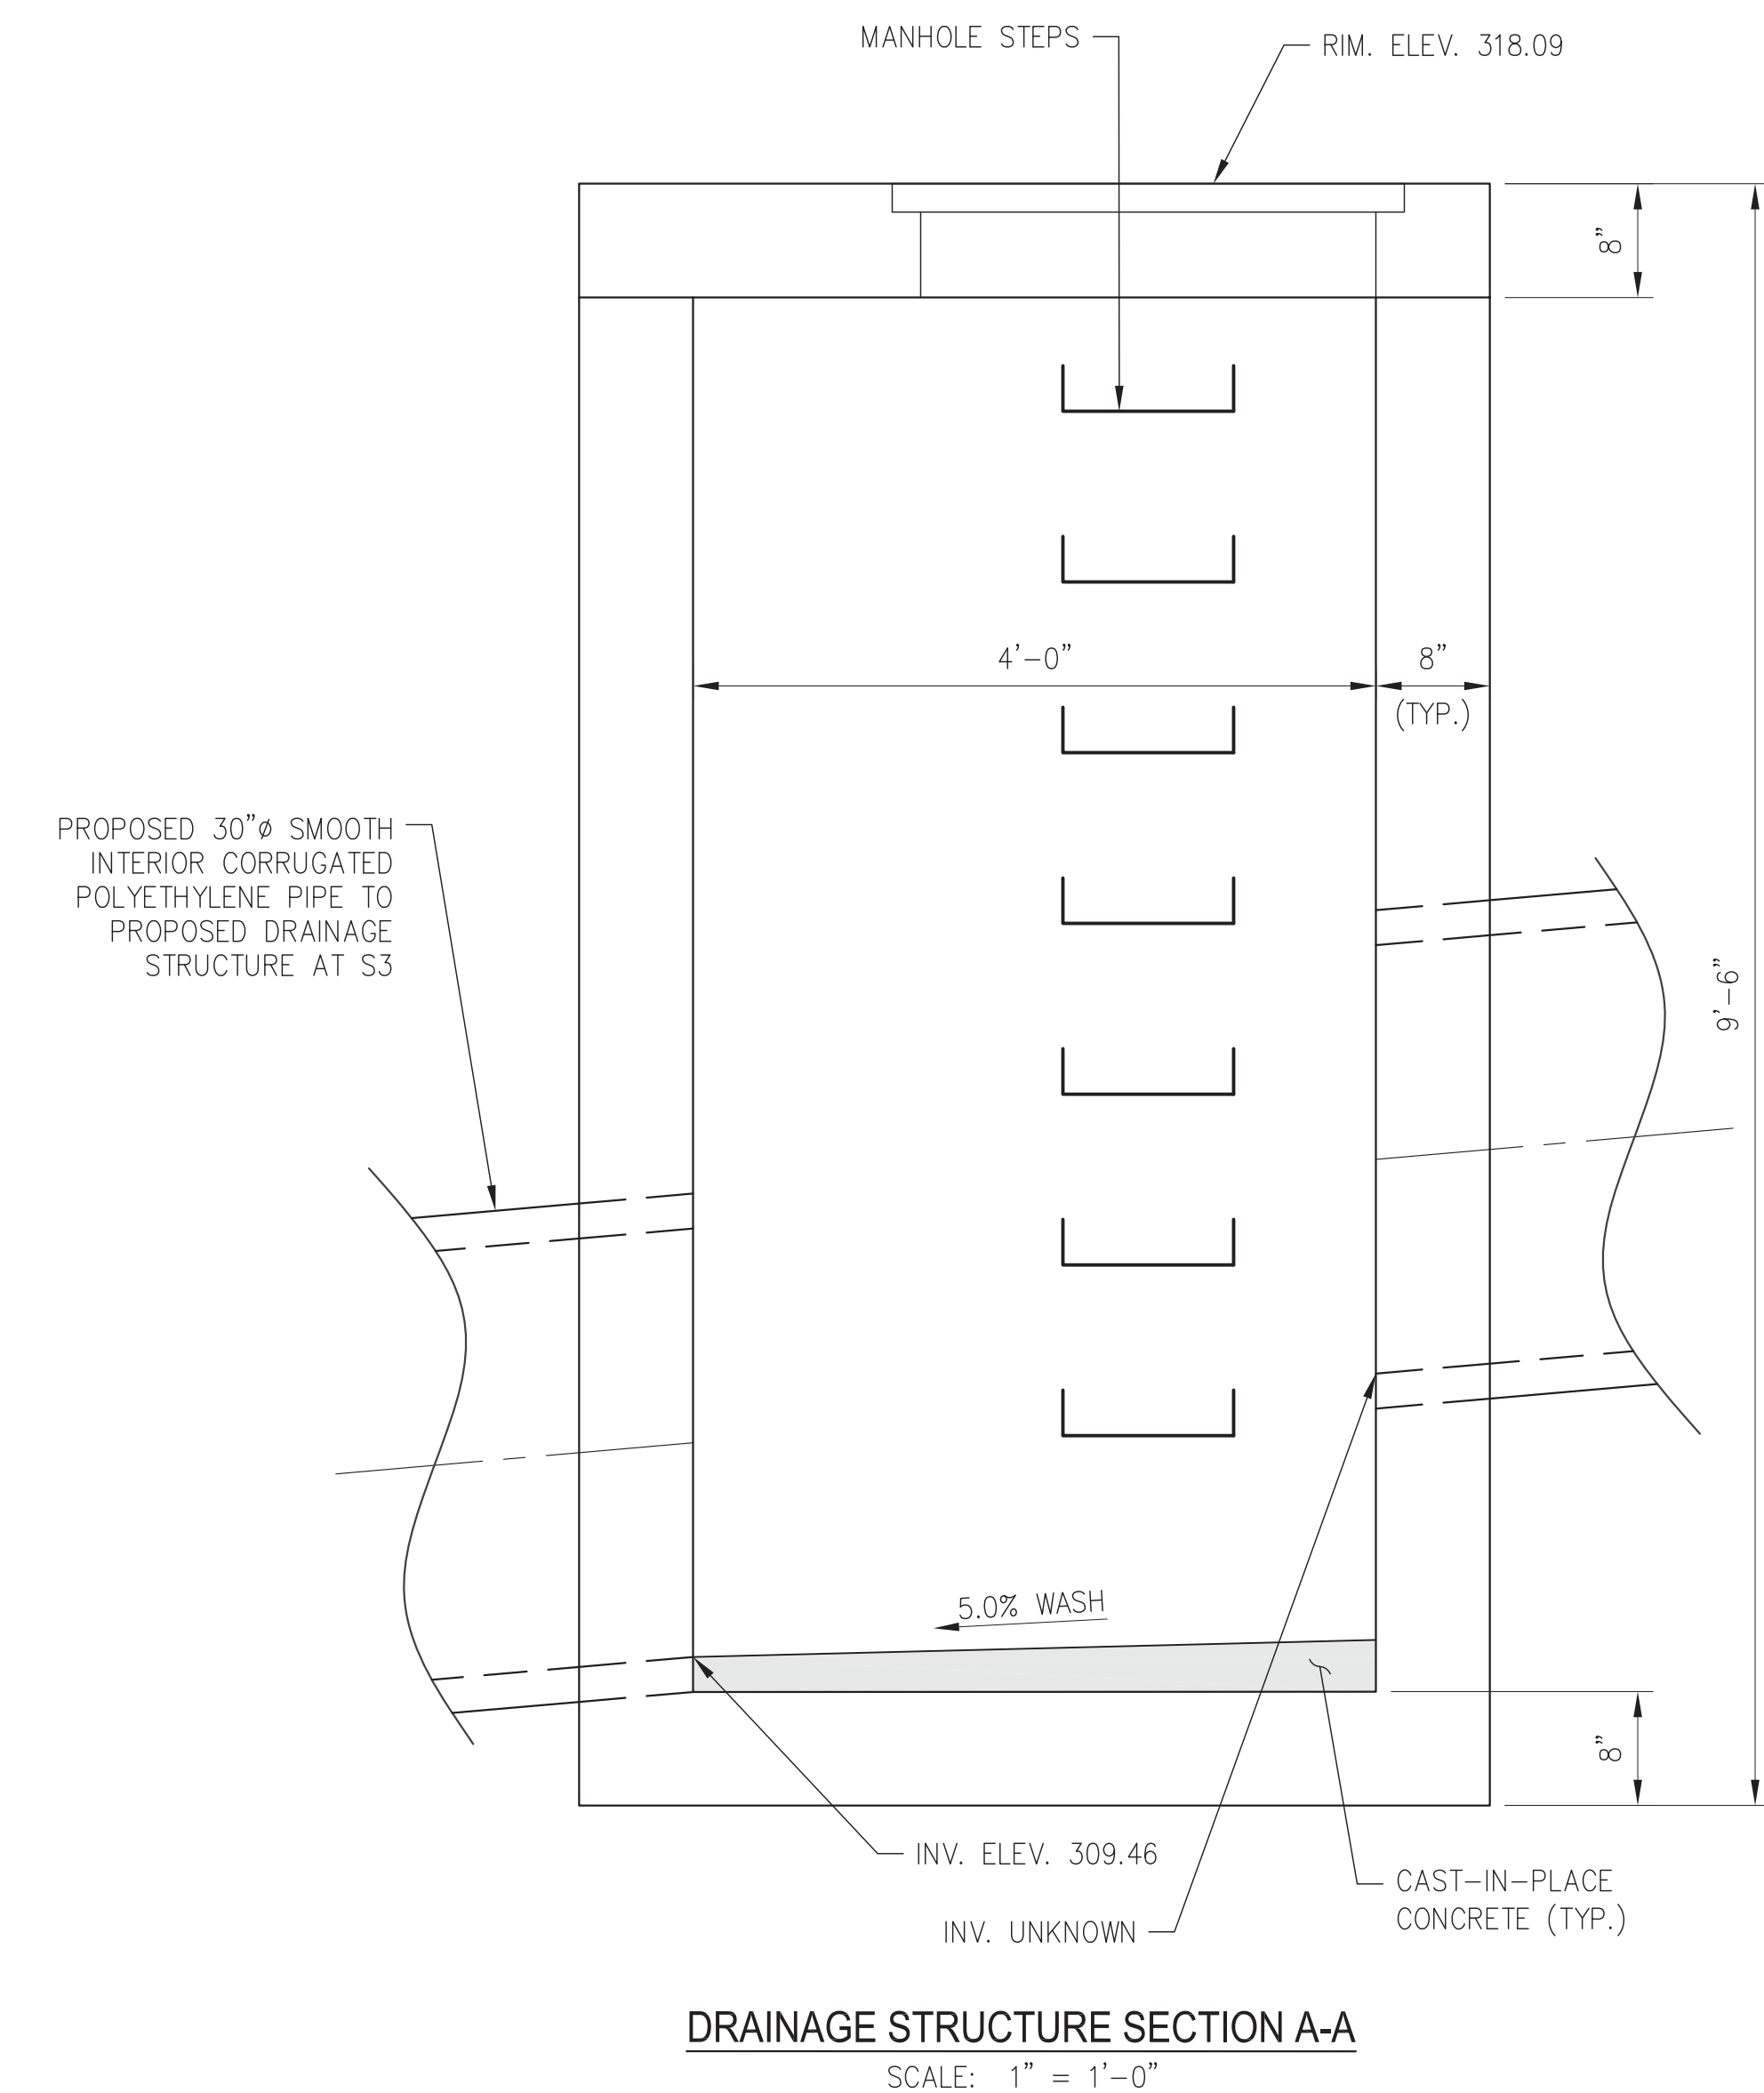

DRAWING FILE PATH: P:\150024-SUNNIFR\DRAWINGS\DRAWING SETS\PILOT\LM-100-150024.DWG
DATE MODIFIED: 6/13/2018

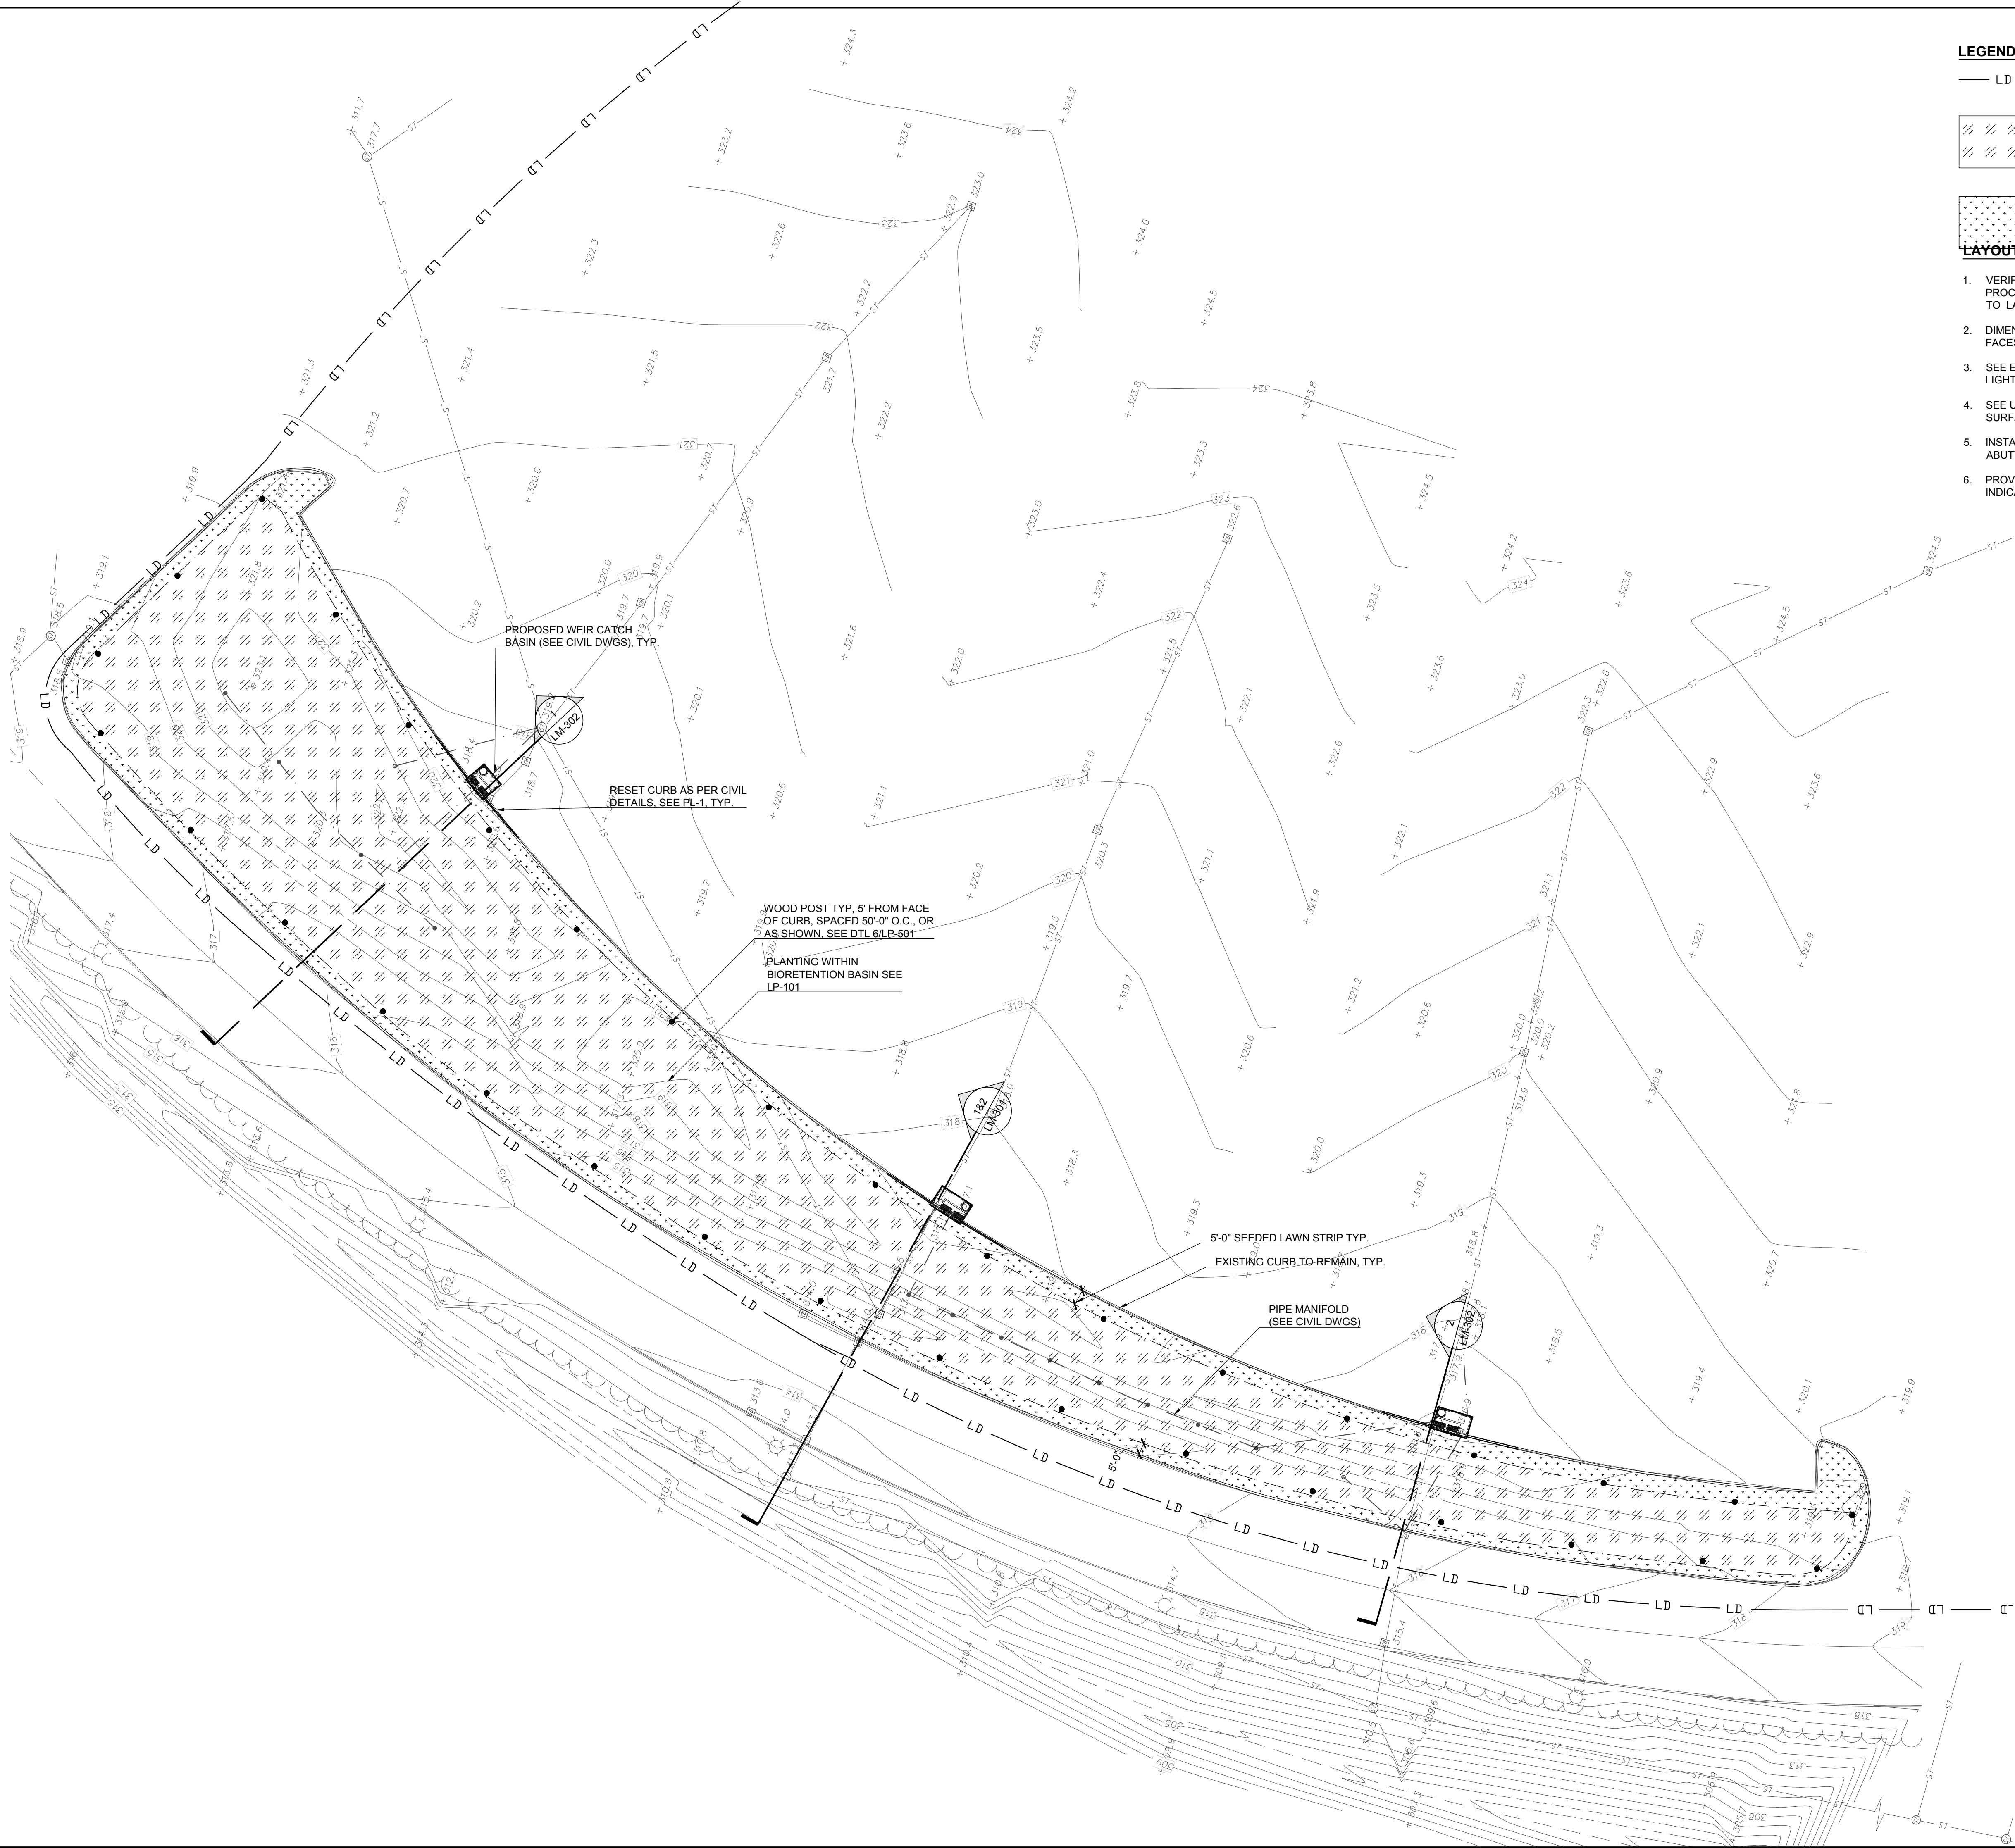

LEGEND

LD LIMIT OF WORK

PLANTING WITHIN BIORETENTION BASIN

TURF SEED MIX

LAYOUT NOTES

1. VERIFY DIMENSIONS AND ACCEPT CONDITIONS BEFORE PROCEEDING WITH ANY WORK. REPORT DISCREPANCIES TO LANDSCAPE ARCHITECT.
2. DIMENSIONS TO CURBS AND WALLS ARE TO EXPOSED FACES UNLESS NOTED OTHERWISE.
3. SEE ELECTRICAL DRAWINGS FOR LAYOUT OF SITE LIGHTING.
4. SEE UTILITY DRAWINGS FOR TRENCH BACKFILLING AND SURFACE REPAIRS NOT SHOWN ON THIS DRAWING.
5. INSTALL ISOLATION JOINTS IN CONCRETE PAVING ABUTTING CURBS, STEPS AND OTHER FIXED OBJECTS.
6. PROVIDE SLOPES ON PAVEMENT SURFACES AS INDICATED ON GRADING PLANS.

ndropogon

ANDROPOGON ASSOCIATES, LTD
10 SHURS LANE
PHILADELPHIA, PA 19127
T: 215.487.0700
F: 215.483.7520
W: www.andropogon.com

PURCHASE COLLEGE GREEN INFRASTRUCTURE

PURCHASE COLLEGE
735 ANDERSON HILL ROAD
PURCHASE, NY 10577


LU ENGINEERS
CIVIL ENGINEERING
50 LAKEFRONT BLVD. SUITE 212
ROCHESTER, NY 14202
P: 716.849.0982
www.luengineers.com

ATLANTIC TESTING LABORATORIES
GEOTECHNICAL ENGINEERING
251 UPPER NORTH ROAD
HIGHLAND, NY 12528
P: 845.691.6098
www.atlantictesting.com

REV.	DATE	DESCRIPTION



 STATE OF NEW YORK LIC. NO. 001147-1
BID DOCUMENTS



SCALE:	1:30
DATE:	07.06.2018
DRAWN BY:	HG
CHECKED BY:	KG
APPROVED BY:	

AA PROJECT #:	150024
PROJECT PHASE:	BID DOCUMENTS
DRAWING TITLE:	

LAYOUT & MATERIALS

SHEET:

LM-101

 
 
PURCHASE COLLEGE
735 ANDERSON HILL ROAD
PURCHASE, NY 10577

LU ENGINEERS
CIVIL ENGINEERING
50 LAKEFRONT BLVD. SUITE 212
ROCHESTER, NY 14202
P: 716.849.0982
www.luengineers.com

ATLANTIC TESTING LABORATORIES
GEOTECHNICAL ENGINEERING
 251 UPPER NORTH ROAD
 HIGHLAND, NY 12528
 P: 845.691.6098
www.atlantictesting.com

[illegible]

STATE OF NEW YORK LIC. NO. 001147-1
BID DOCUMENTS



SCALE:	1:30
DATE:	07.06.2018
DRAWN BY:	HG
CHECKED BY:	KG
APPROVED BY:	


AA PROJECT #:	150024
PROJECT PHASE:	BID DOCUMENTS


DRAWING TITLE:

LAYOUT & MATERIALS

SHEET:

LM-102

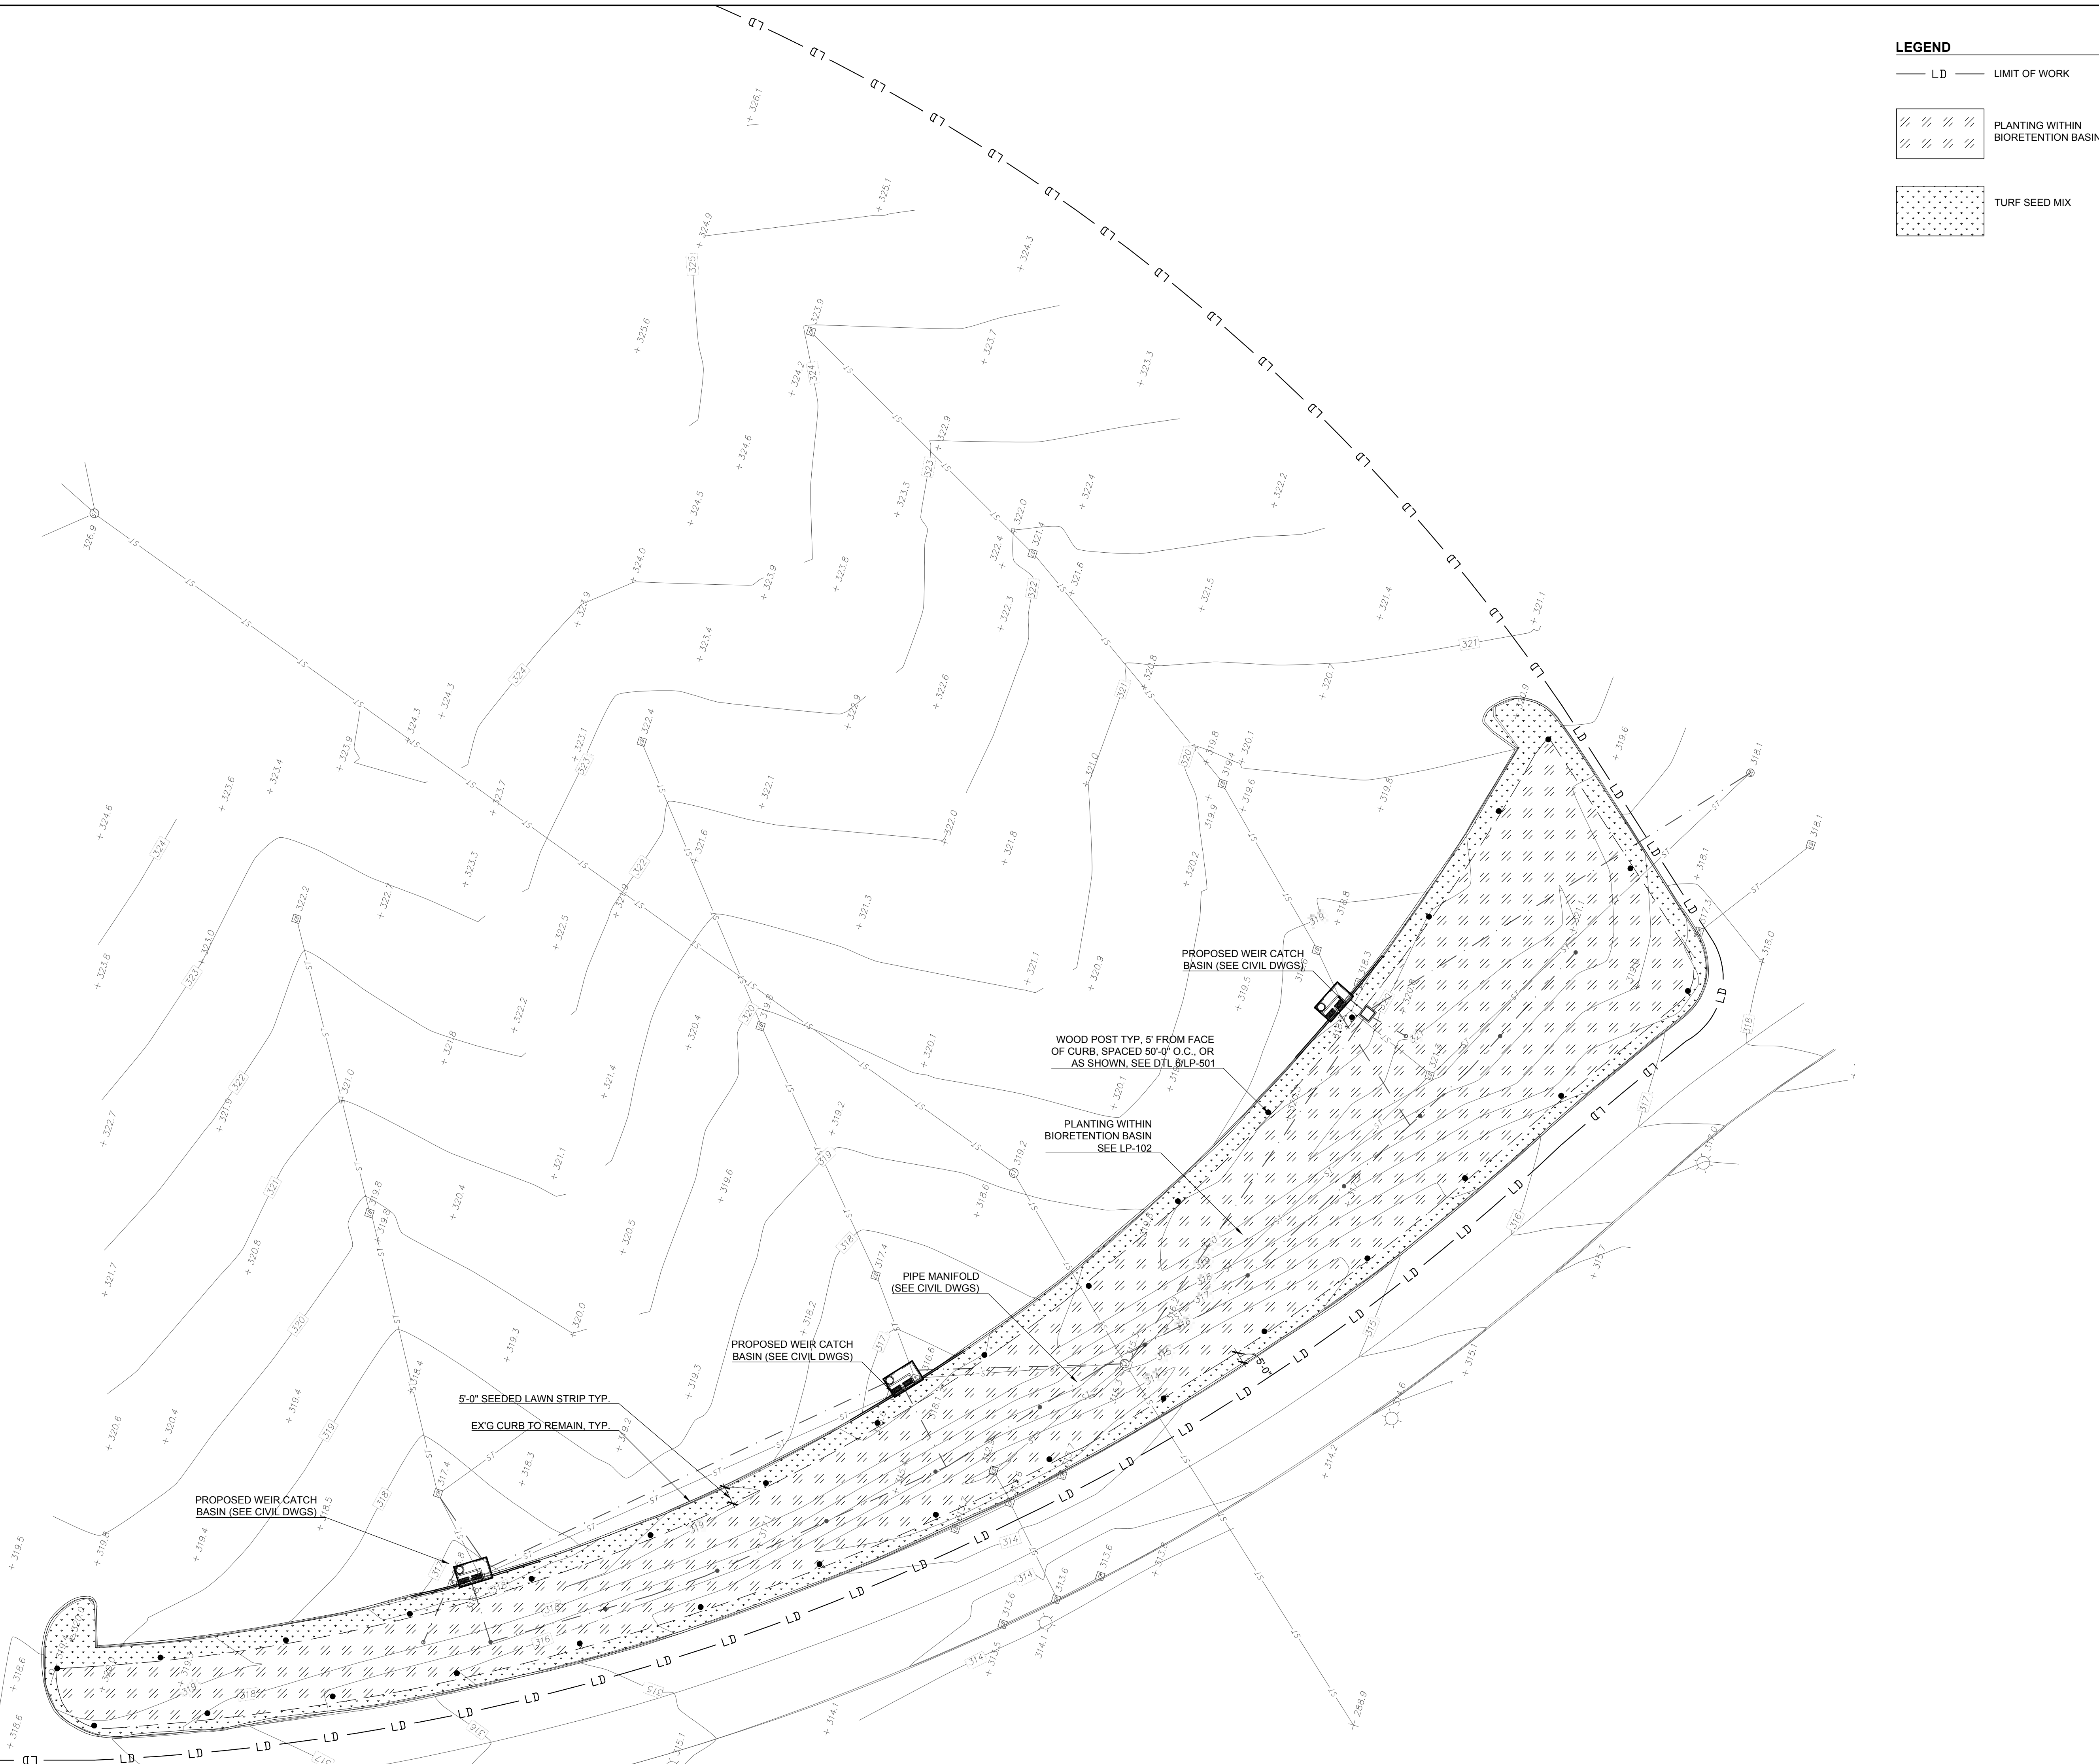

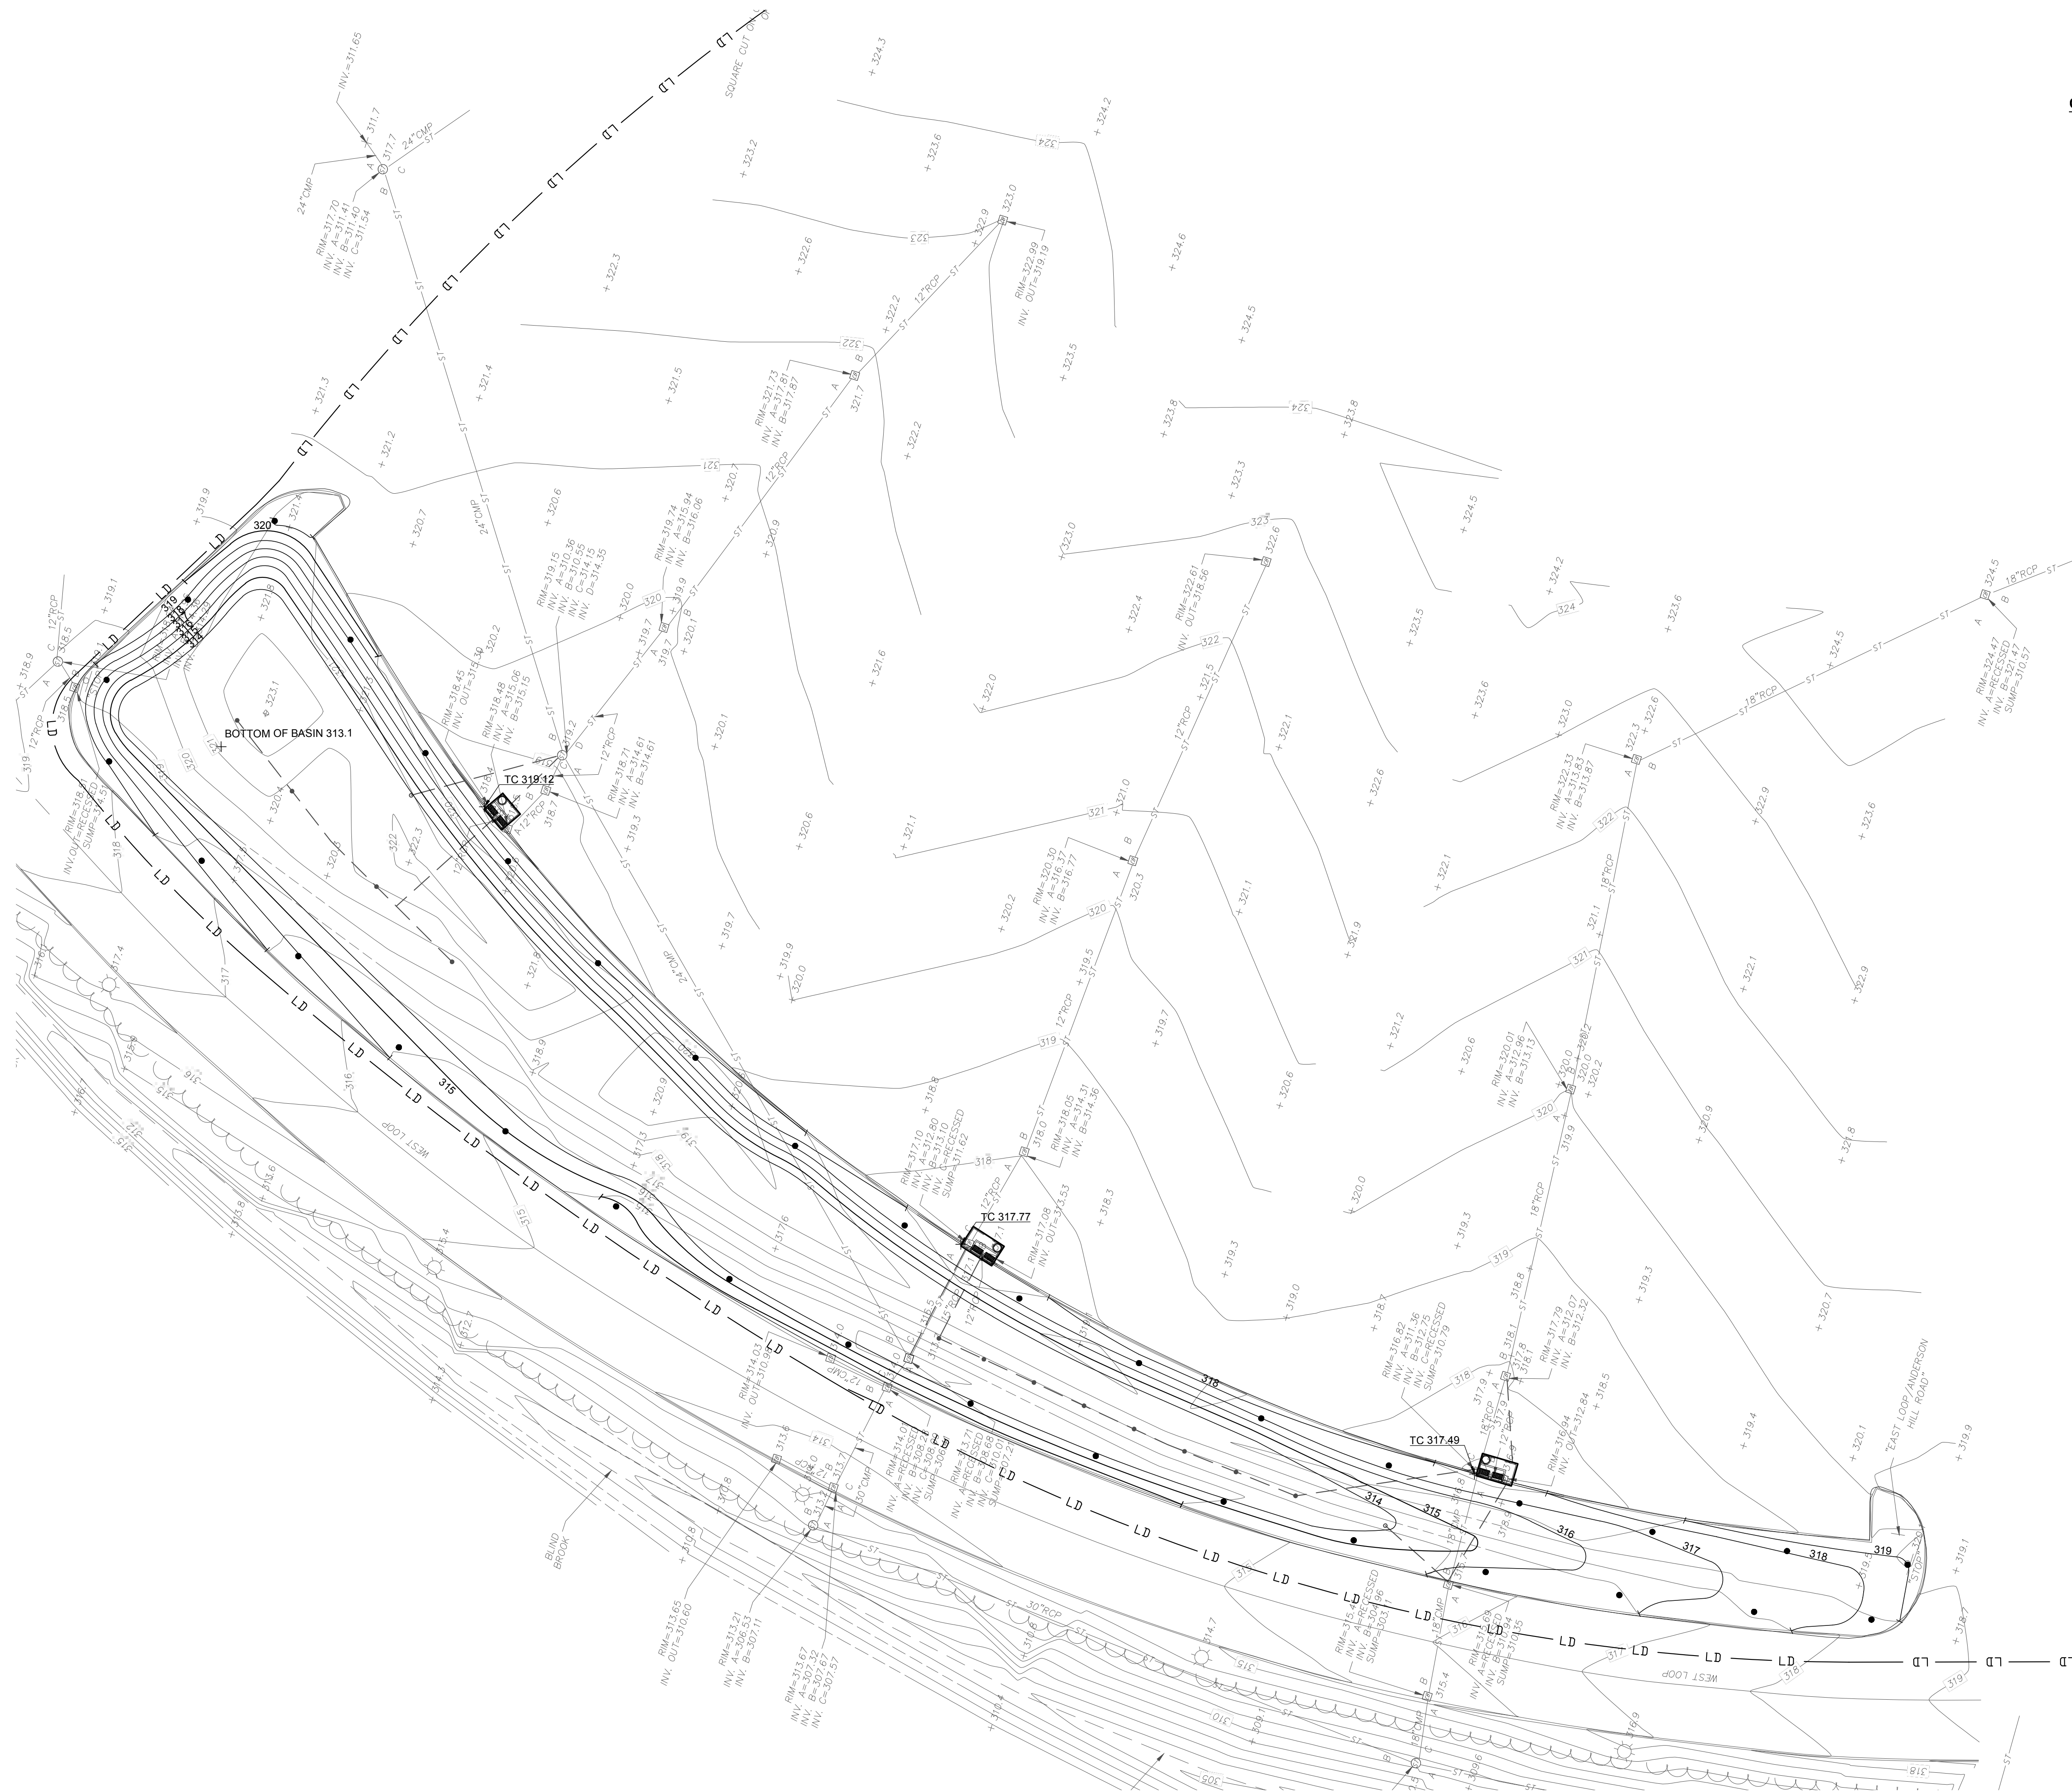

GRADING NOTES

1. ROUND BREAKS IN GRADE WITH 5 FEET MINIMUM ROUNDING.
2. MEET ELEVATIONS OF EXISTING SURFACES FLUSH.
3. ADJUST EXISTING MANHOLE AND CATCH BASIN RIMS AND VALVE COVERS TO NEW FINISH GRADE.
4. SEE UTILITY DRAWINGS FOR TRENCH BACK FILLING NOT SHOWN ON THIS DRAWING.
5. COORDINATE STORM DRAINAGE STRUCTURES WITH CIVIL DRAWINGS.
6. SLOPE GRADES TO DIRECT WATER AWAY FROM BUILDINGS, ACROSS PAVEMENT SURFACES, TOWARDS DRAINAGE DEVICES, AND TO PREVENT PONDING, EXCEPT WHERE INDICATED OTHERWISE ON DRAWINGS.



**ANDROPOGON
ASSOCIATES, LTD**
10 SHURS LANE
PHILADELPHIA, PA 19127
T: 215.487.0700
F: 215.483.7520
W: www.andropogon.com

PURCHASE COLLEGE GREEN INFRASTRUCTURE

 
 
PURCHASE COLLEGE
735 ANDERSON HILL ROAD
PURCHASE, NY 10577

LU ENGINEERS
CIVIL ENGINEERING
50 LAKEFRONT BLVD. SUITE 212
ROCHESTER, NY 14202
P: 716.849.0982
www.luengineers.com

ATLANTIC TESTING LABORATORIES
GEOTECHNICAL ENGINEERING
 251 UPPER NORTH ROAD
 HIGHLAND, NY 12528
 P: 845.691.6098
www.atlantictesting.com

[illegible]

STATE OF NEW YORK LIC. NO. 001147-1
BID DOCUMENTS



SCALE:	1:30
DATE:	07.06.2018
DRAWN BY:	HG
CHECKED BY:	KG
APPROVED BY:	

AA PROJECT #:	150024
PROJECT PHASE:	BID DOCUMENTS

DRAWING TITLE:

GRADING PLAN

SHEET:

 
LG-101



PURCHASE COLLEGE
735 ANDERSON HILL ROAD
PURCHASE, NY 10577

LU ENGINEERS
CIVIL ENGINEERING
50 LAKEFRONT BLVD. SUITE 212
ROCHESTER, NY 14202
P: 716.849.0982
www.luengineers.com

ATLANTIC TESTING LABORATORIES
GEOTECHNICAL ENGINEERING
 251 UPPER NORTH ROAD
 HIGHLAND, NY 12528
 P: 845.691.6098
www.atlantictesting.com



AA PROJECT #:	150024
PROJECT PHASE:	BID DOCUMENTS

DRAWING TITLE:

SHEET:

LG-102



1. ROUND BREAKS IN GRADE WITH 5 FEET MINIMUM ROUNDING.
2. MEET ELEVATIONS OF EXISTING SURFACES FLUSH.
3. ADJUST EXISTING MANHOLE AND CATCH BASIN RIMS AND VALVE COVERS TO NEW FINISH GRADE.
4. SEE UTILITY DRAWINGS FOR TRENCH BACK FILLING NOT SHOWN ON THIS DRAWING.
5. COORDINATE STORM DRAINAGE STRUCTURES WITH CIVIL DRAWINGS.
6. SLOPE GRADES TO DIRECT WATER AWAY FROM BUILDINGS, ACROSS PAVEMENT SURFACES, TOWARDS DRAINAGE DEVICES, AND TO PREVENT PONDING, EXCEPT WHERE INDICATED OTHERWISE ON DRAWINGS.




Canopy & Understory Trees

Shrubs / Herbaceous Perennials

Native Grasses

Seed Mixes

Type	total area (SF)
Turf seed mix	8,850


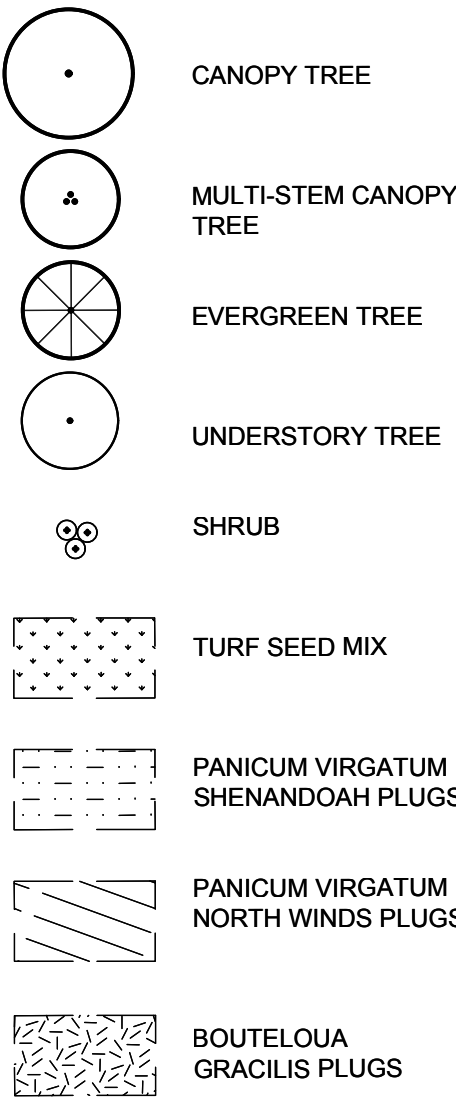
PLANTING LEGEND:

**ANDROPOGON
ASSOCIATES, LTD**
10 SHURS LANE
PHILADELPHIA, PA 19127
T: 215.487.0700
F: 215.483.7520
W: www.andropogon.com

PURCHASE COLLEGE
735 ANDERSON HILL ROAD
PURCHASE, NY 10577

LU ENGINEERS
CIVIL ENGINEERING
50 LAKEFRONT BLVD. SUITE 212
ROCHESTER, NY 14202
P: 716.849.0982
www.luengineers.com

  ATLANTIC TESTING LABORATORIES
GEOTECHNICAL ENGINEERING
 251 UPPER NORTH ROAD
 HIGHLAND, NY 12528
 P: 845.691.6098
www.atlantictesting.com

[illegible]

AA PROJECT #:	150024
PROJECT PHASE:	BID DOCUMENTS

DRAWING TITLE:

SHEET:

LP-101

PLANT SCHEDULE

Canopy & Understory Trees				
KEY	QTY	BOTANICAL NAME	COMMON NAME	SIZE
BN	12	Betula nigra	River Birch	14'-16' ht.
CF	20	Cornus Florida rubra	Flowering Dogwood	2.5" caliper
CO	3	Carya ovata	Shagbark Hickory	2.5" caliper
PR	3	Pinus rigida	Pitch Pine	2.5" caliper
QA	7	Quercus alba	White Oak	2.5" caliper
QC	6	Quercus coccinea	Scarlet Oak	2.5" caliper
Total	51			

Shrubs / Herbaceous Perennials				
KEY	QTY	BOTANICAL NAME	COMMON NAME	SIZE
AA	37	Aronia arbutifolia 'brilliantissima'	Chokeberry	1 ga
AH	119	Amsonia hubrichtii	Threadleaf bluestar	1 ga
CS	91	Cornus sericea	Red-twigged Dogwood	1 ga
DS	117	Diervilla sessifolia	Bush Honeysuckle	1 ga
FG	166	Fothergilla gardenii	Dwarf Fothergilla	1 ga
HV	13	Hamamelis vernalis 'Arnold's Promise'	Witch Hazel	1 ga
Total	543			

Native Grasses				
KEY	QTY	BOTANICAL NAME	COMMON NAME	SIZE
	14095	Panicum virgatum 'Shenandoah'	Shenandoah switchgrass	18" O.C.
	1590	Panicum virgatum 'North Wind'	North Wind switchgrass	18" O.C.
	1655	Bouteloua gracilis 'Blonde Ambition'	Blue grama	18" O.C.
Total	17340			

Seed Mixes	
Type	total area (SF)
Turf seed mix	8,632

PLANTING LEGEND:

- CANOPY TREE
- MULTI-STEM CANOPY TREE
- EVERGREEN TREE
- UNDERSTORY TREE
- SHRUB
- TURF SEED MIX
- PANICUM VIRGATUM SHENANDOAH PLUGS
- PANICUM VIRGATUM NORTH WINDS PLUGS
- BOUTELOUA GRACILIS PLUGS



ANDROPOGON ASSOCIATES, LTD
10 SHURS LANE
PHILADELPHIA, PA 19127
T: 215.487.0700
F: 215.483.7520
W: www.andropogon.com

PURCHASE COLLEGE GREEN INFRASTRUCTURE

PURCHASE COLLEGE
735 ANDERSON HILL ROAD
PURCHASE, NY 10577

 
LU ENGINEERS
CIVIL ENGINEERING
50 LAKEFRONT BLVD. SUITE 212
ROCHESTER, NY 14202
P: 716.849.0982
www.luengineers.com

ATLANTIC TESTING LABORATORIES
GEOTECHNICAL ENGINEERING
251 UPPER NORTH ROAD
HIGHLAND, NY 12528
P: 845.691.6098
www.atlantictesting.com

REV. DATE DESCRIPTION



STATE OF NEW YORK LIC. NO. 001147-1
BID DOCUMENTS



SCALE:	1:30
DATE:	07.06.2018
DRAWN BY:	HG
CHECKED BY:	KG
APPROVED BY:	

AA PROJECT #:

150024

PROJECT PHASE:

BID DOCUMENTS

DRAWING TITLE:

PLANTING PLAN

SHEET:

LP-102

DRAWING FILE PATH: P:\150024-SUNNIFR\DRAWINGS\DRAWING SETS\LOT-LP-100-150024.DWG
DATE MODIFIED: 6/22/2018



PURCHASE COLLEGE
735 ANDERSON HILL ROAD
PURCHASE, NY 10577

LU ENGINEERS
CIVIL ENGINEERING
50 LAKEFRONT BLVD. SUITE 212
ROCHESTER, NY 14202
P: 716.849.0982
www.luengineers.com

ATLANTIC TESTING LABORATORIES
GEOTECHNICAL ENGINEERING
 251 UPPER NORTH ROAD
 HIGHLAND, NY 12528
 P: 845.691.6098
www.atlantictesting.com

STATE OF NEW YORK LIC. NO. 001147-1
BID DOCUMENTS

AA PROJECT #:	150024
PROJECT PHASE:	BID DOCUMENTS

DRAWING TITLE:


SHEET:

LM-301




DRAWING FILE PATH: P:\150024-SUNINFRA\DRAWINGS\DRAWING SETS\PLOT\LM-300-150024.DWG
DATE MODIFIED: 6/27/2018

DRAWING FILE PATH: P:\150024-SUNINFRA\DRAWINGS\DRAWING SETS\PILOT\LM-300-150024.DWG
DATE MODIFIED: 6/27/2018

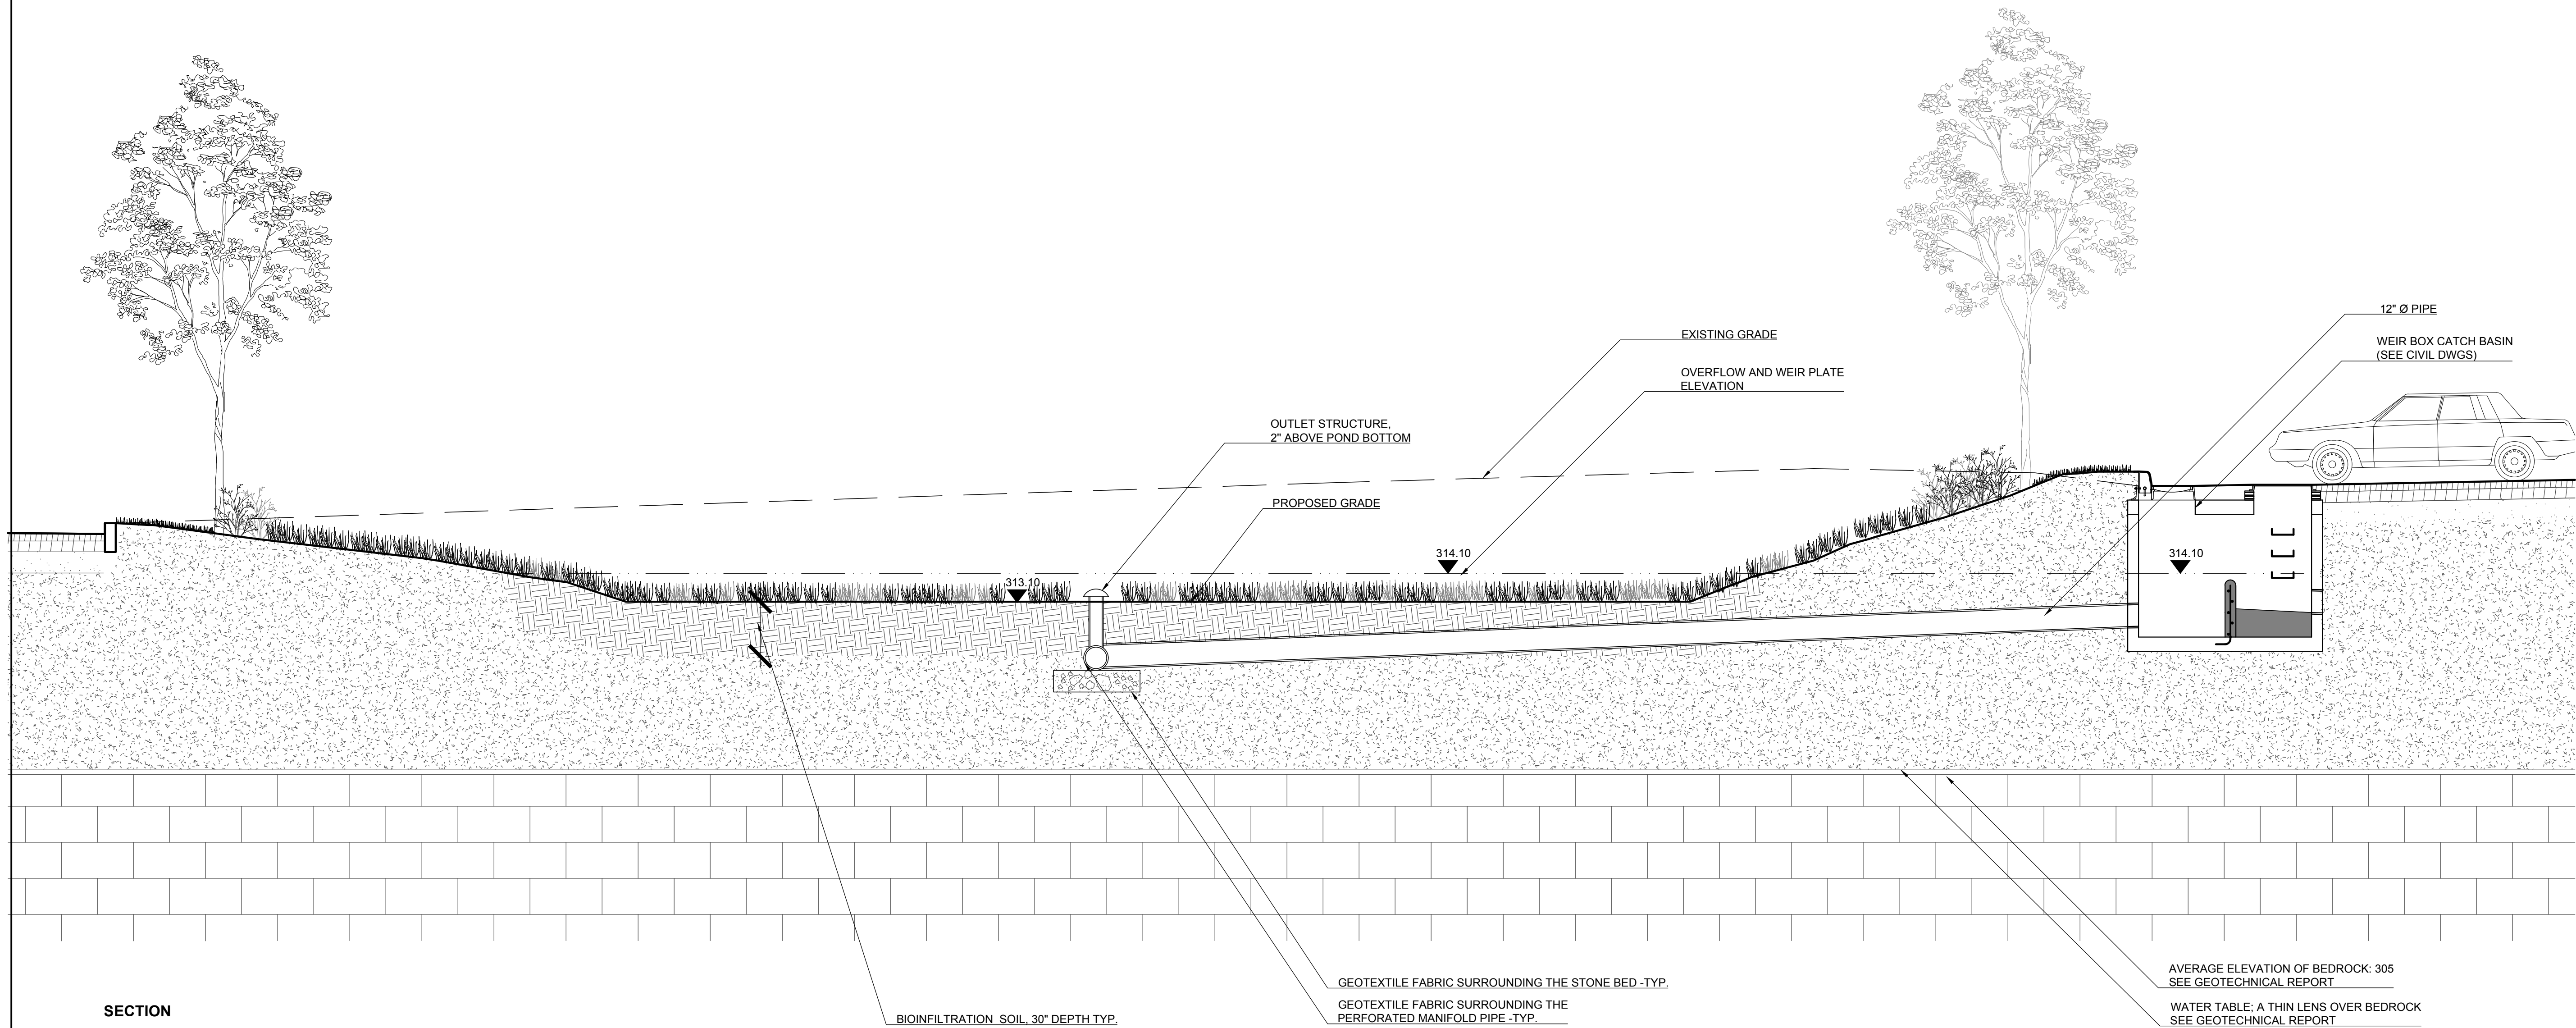

SECTION
1
LM-302
1/4"=1'-0"
INFILTRATING BIORETENTION BASIN N1

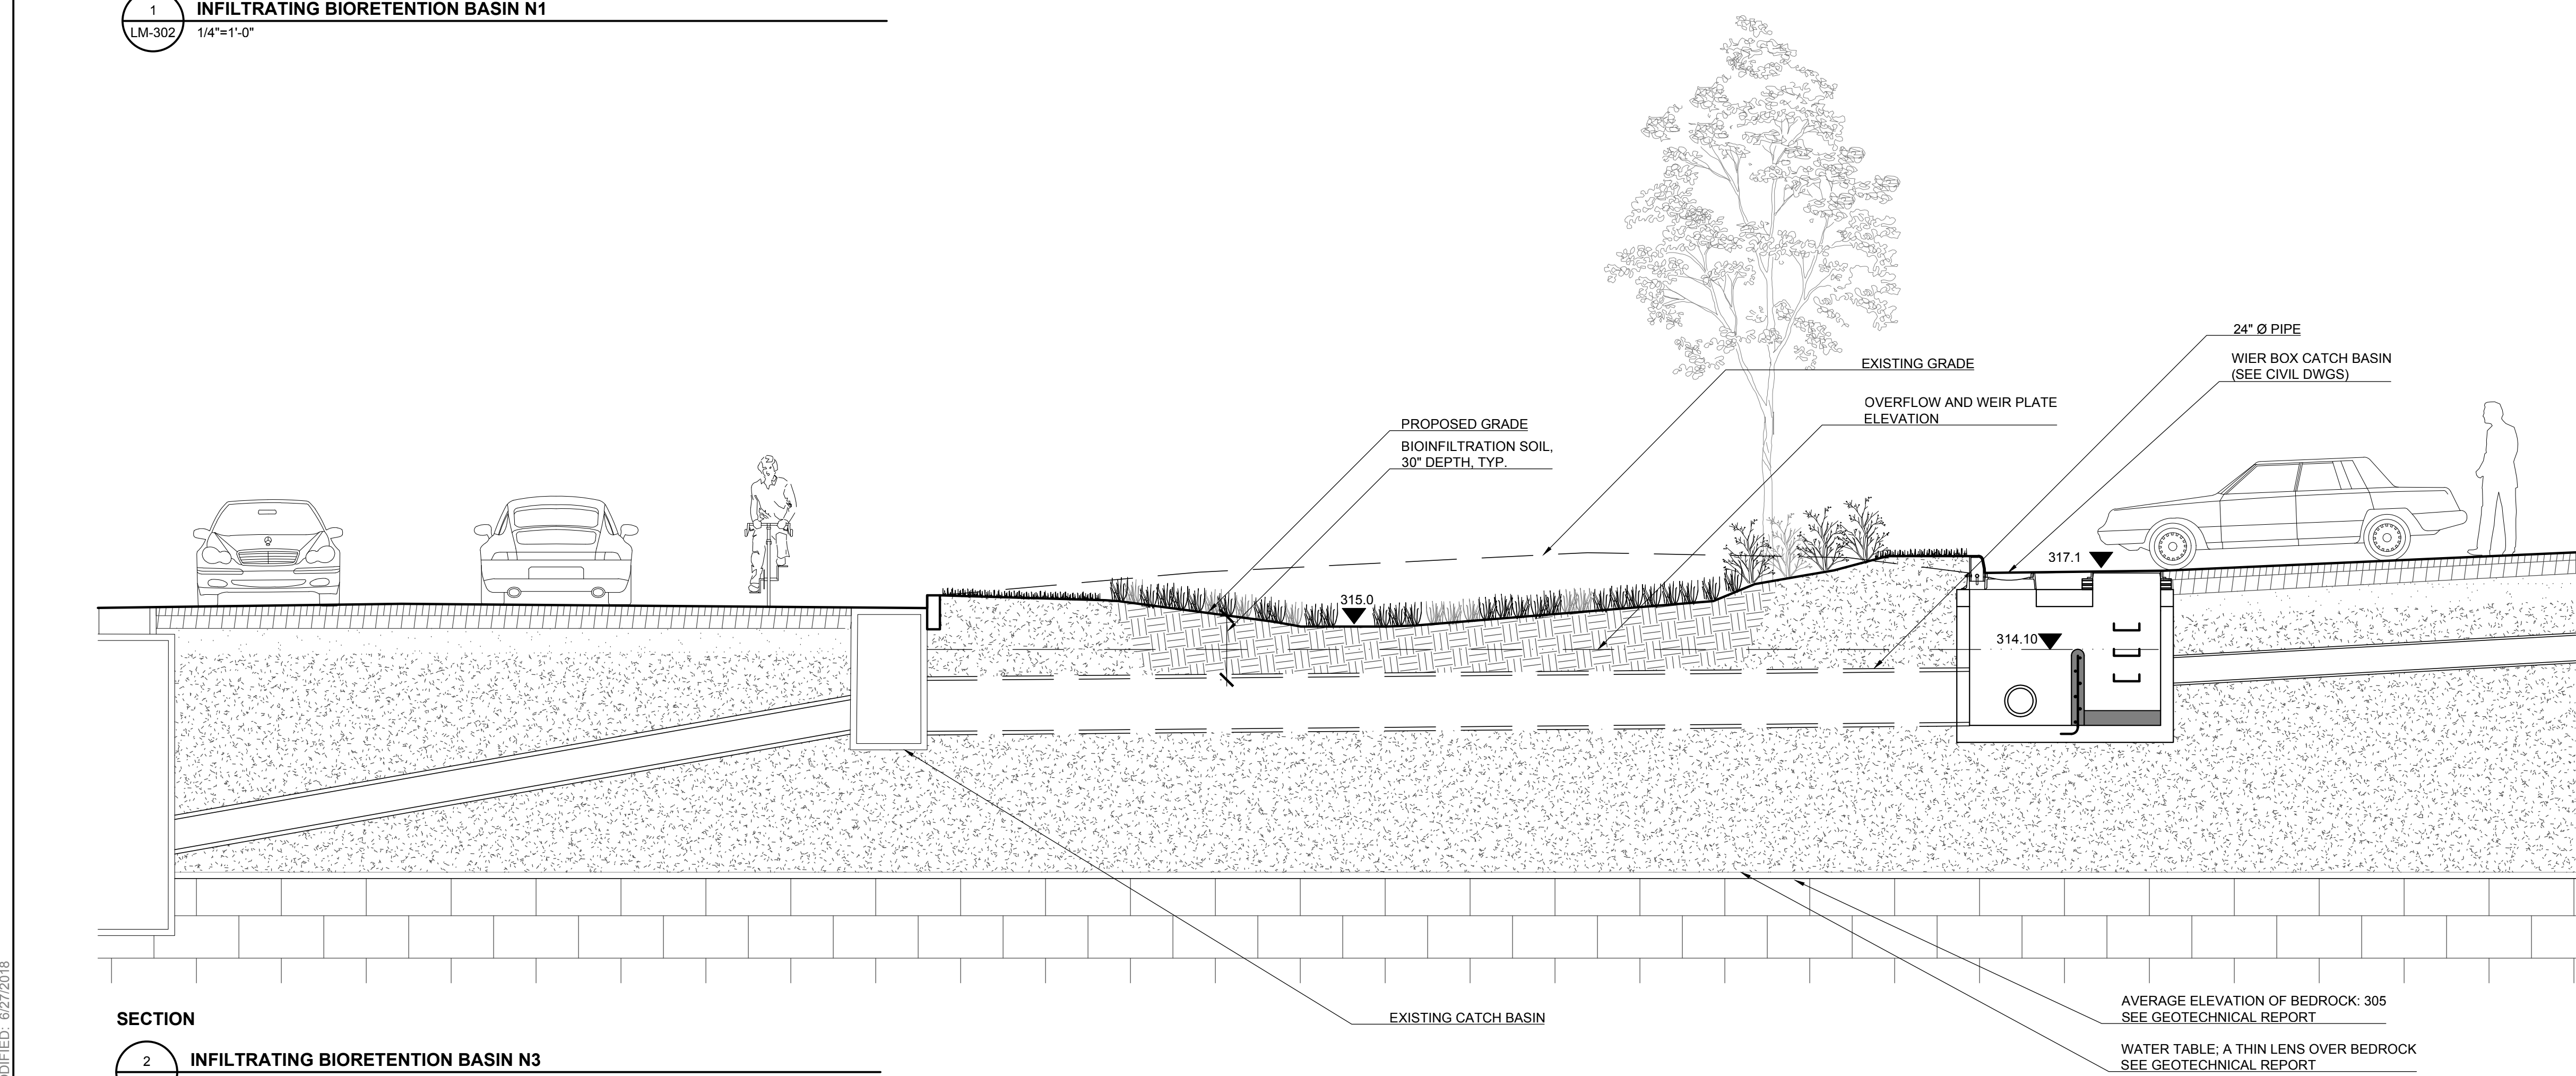

SECTION
2
LM-302
1/4"=1'-0"
INFILTRATING BIORETENTION BASIN N3



ANDROPOGON
ASSOCIATES, LTD
10 SHURS LANE
PHILADELPHIA, PA 19127
T: 215.487.0700
F: 215.483.7520
W: www.andropogon.com

PURCHASE COLLEGE GREEN INFRASTRUCTURE

PURCHASE COLLEGE
735 ANDERSON HILL ROAD
PURCHASE, NY 10577

LU ENGINEERS
CIVIL ENGINEERING
50 LAKEFRONT BLVD, SUITE 212
ROCHESTER, NY 14202
P: 716.849.0982
www.luengineers.com

ATLANTIC TESTING LABORATORIES
GEOTECHNICAL ENGINEERING
251 UPPER NORTH ROAD
HIGHLAND, NY 12528
P: 845.691.6098
www.atlantictesting.com

REV.	DATE	DESCRIPTION



STATE OF NEW YORK LIC. NO. 001147-1
BID DOCUMENTS

SCALE:	1/4" = 1'-0"
DATE:	07.06.2018
DRAWN BY:	HG
CHECKED BY:	KG
APPROVED BY:	

AA PROJECT #:	150024
PROJECT PHASE:	BID DOCUMENTS


DRAWING TITLE:

SITE SECTIONS

SHEET:


LM-302

DRAWING FILE PATH: P:\150024-SUNNIFR\DRAWINGS\DRAWING SETS\PILOT\LL-500-150024.DWG
DATE MODIFIED: 6/22/2018

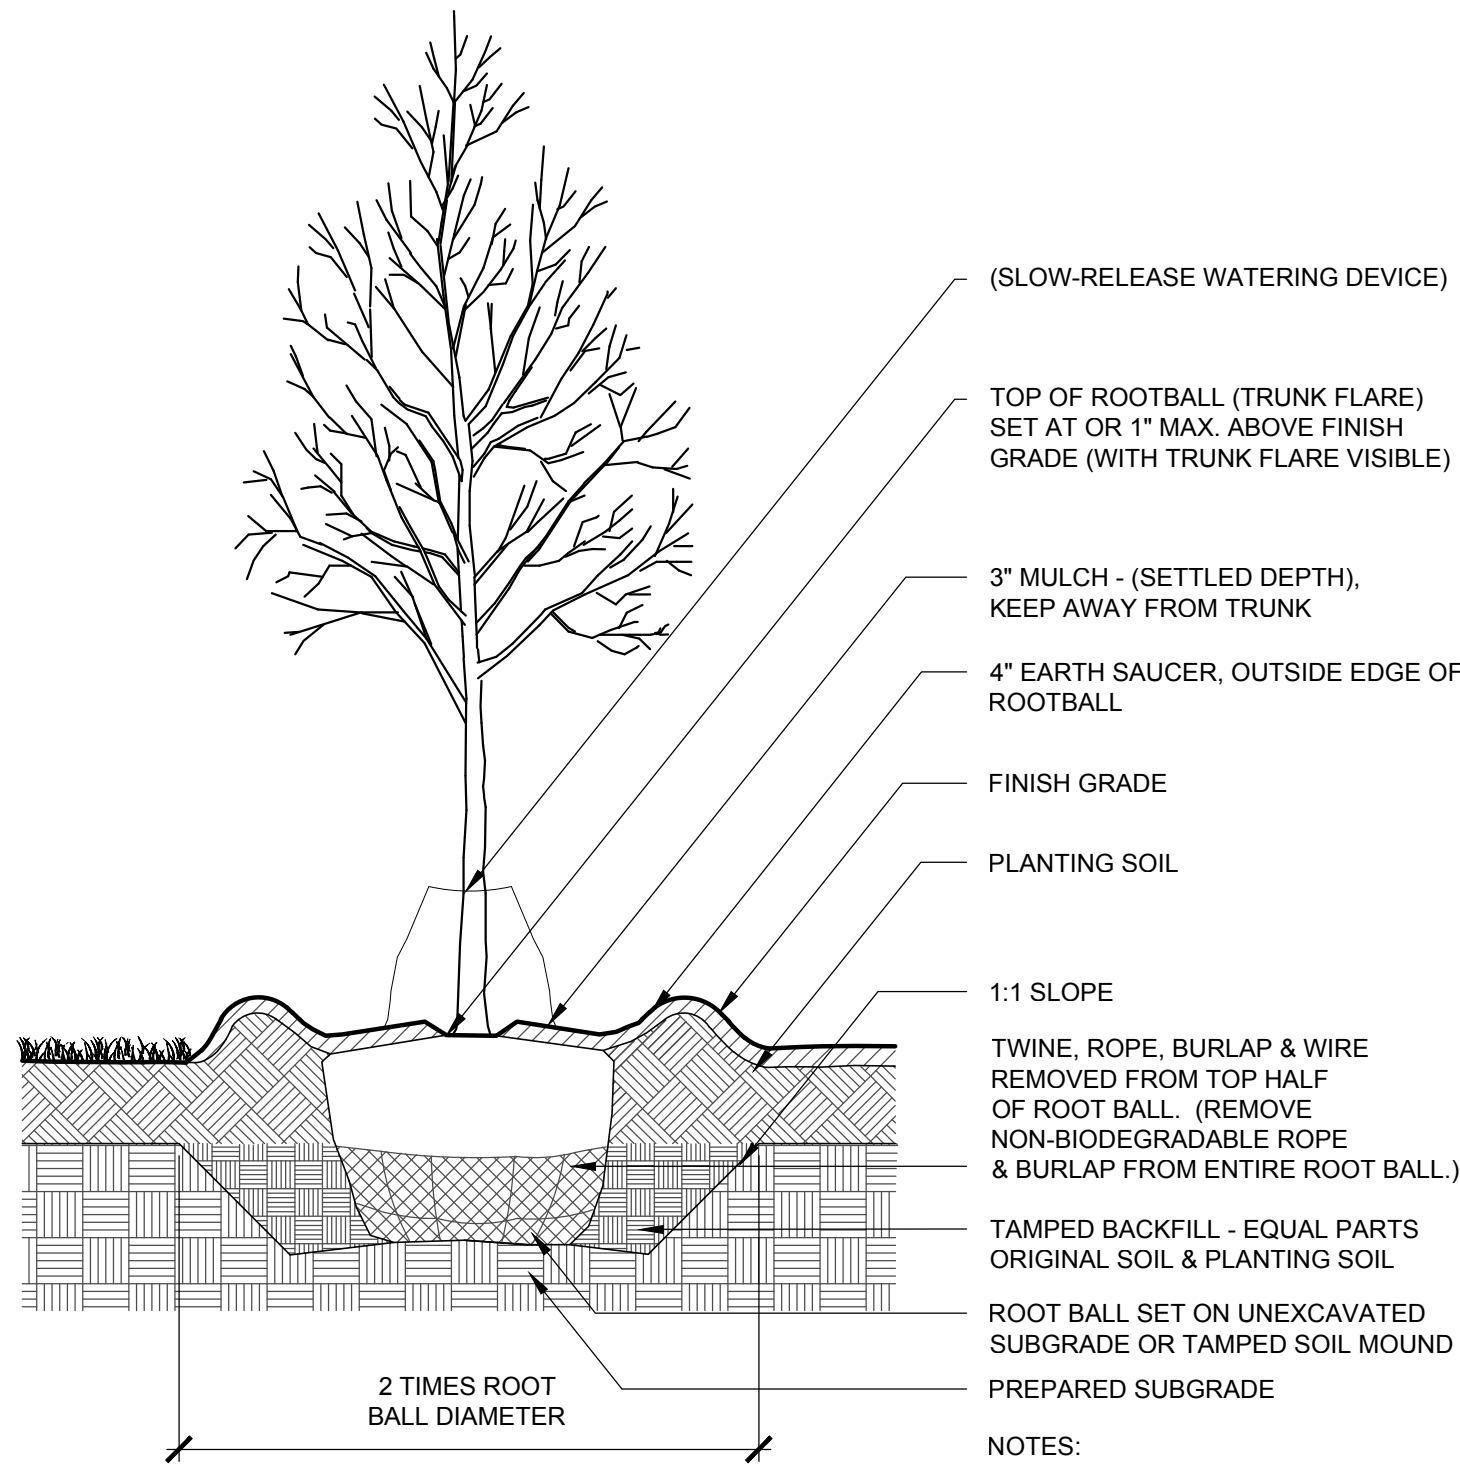

SECT

1 DECIDUOUS TREE PLANTING
LP-501 N.T.S.

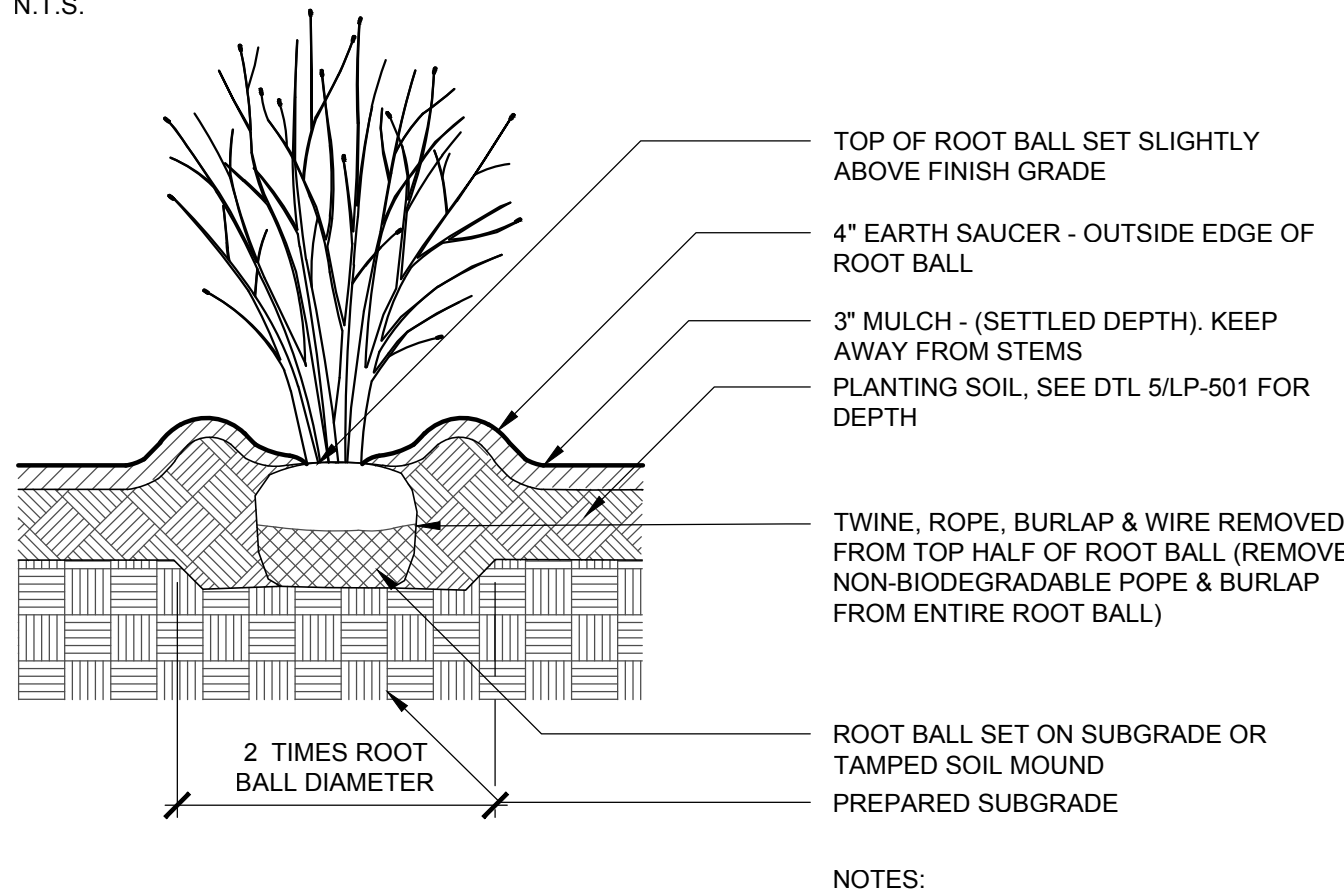


NOTES:

1. SEPARATE AND SPREAD POT-BOUND
ROOTS.
2. PRUNE ONLY AFTER REVIEW WITH
THE LANDSCAPE ARCHITECT.
3. AT END OF WARRANTY PERIOD
REMOVE SAUCER, AND
REDISTRIBUTE, ADD, AND/OR
REPLACE MULCH AS NEEDED.

SECTION

2 SHRUB PLANTING
LP-501 N.T.S.

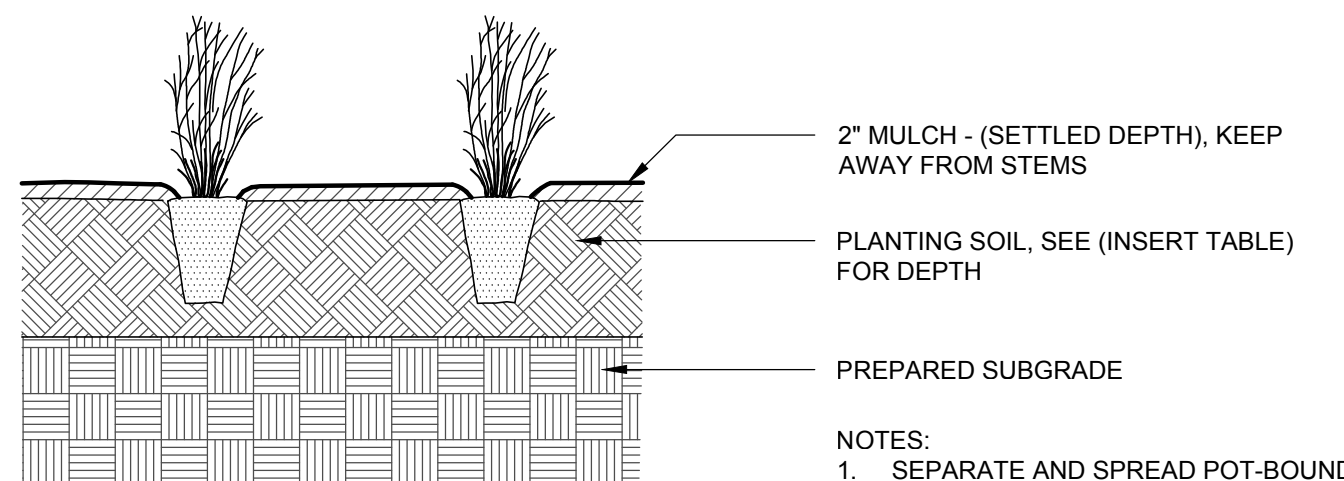


NOTES:

1. SEPARATE AND SPREAD POT-BOUND
ROOTS. DIP ROOT BALLS INTO
SOLUTION OF ROOT DIP BEFORE
PLANTING.

SECTION

4 HERBACEOUS PLANTING
LP-501 N.T.S.

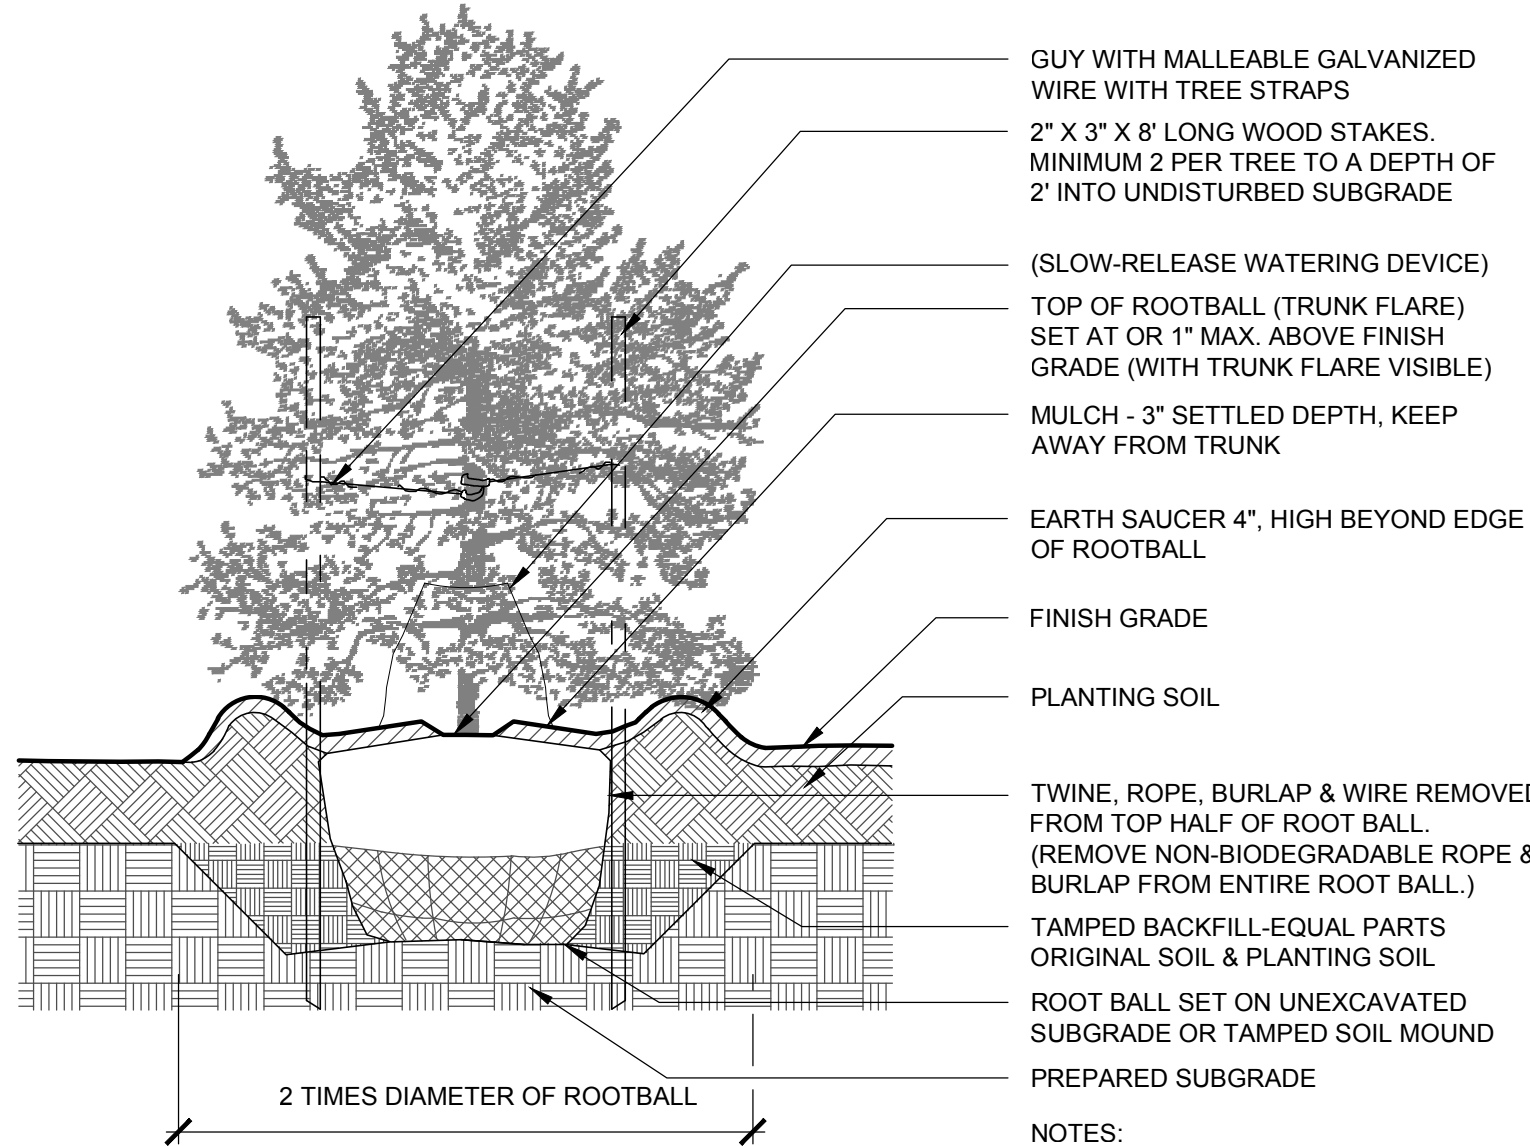


NOTES:

1. PRUNE ONLY AFTER REVIEW WITH
LANDSCAPE ARCHITECT.
2. AT END OF WARRANTY PERIOD,
REMOVE SAUCER AND DISTRIBUTE,
ADD, AND/OR REPLACE MULCH AS
NEEDED.

SECTION

4 EVERGREEN TREE PLANTING
LP-501 N.T.S.

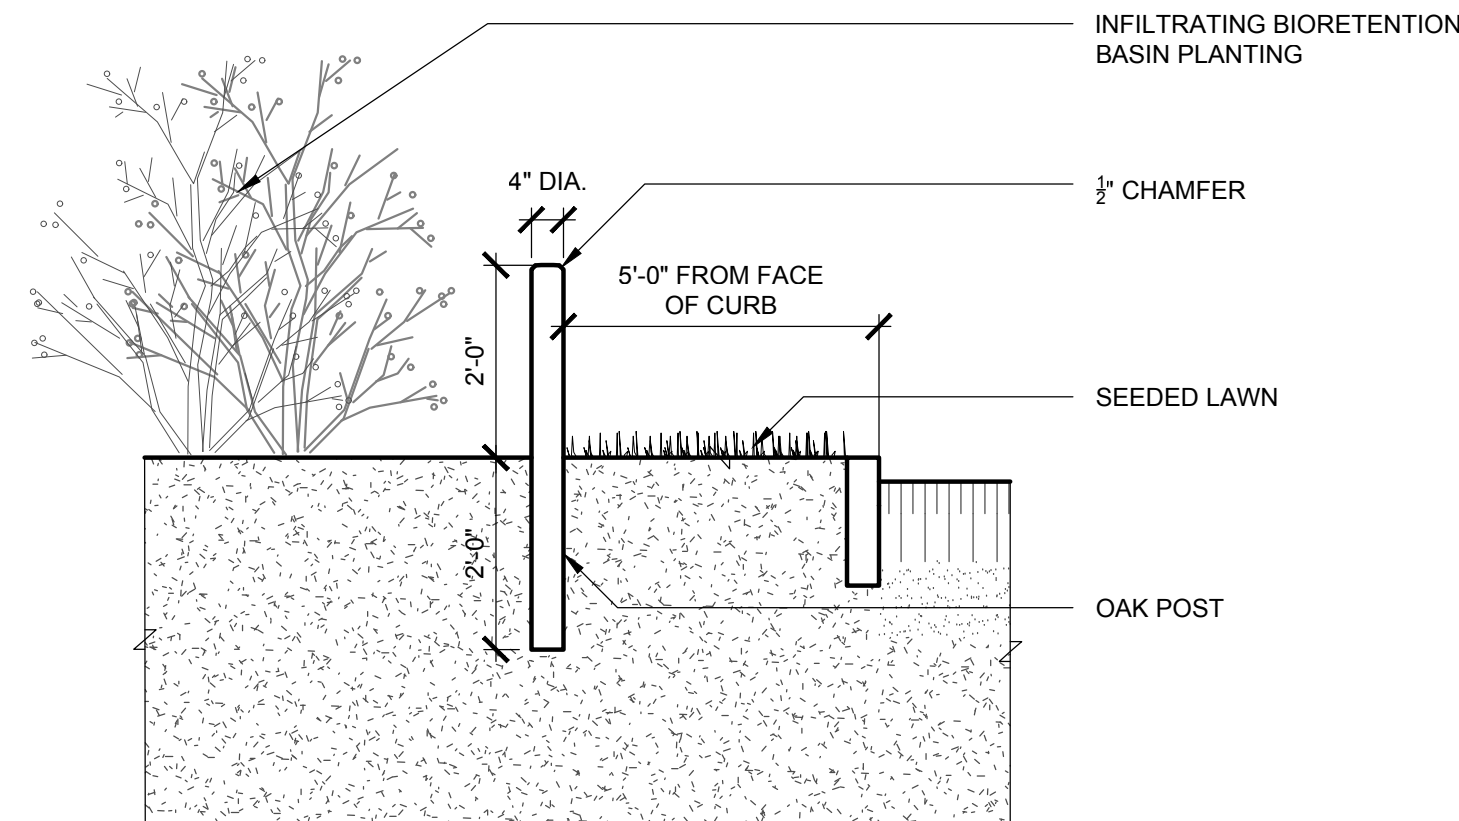


ELEVATION

6 WOOD POST
LP-501 1/2" = 1'-0"

A	O.C. SPACING	B	ROW SPACING
8"		7"	
9"		7 3/4"	
10"		8 5/8"	
12"		10 1/2"	
15"		13"	
18"		15 1/2"	
24"		21"	

PLAN

7 PLANT SPACING
LP-501 N.T.S.

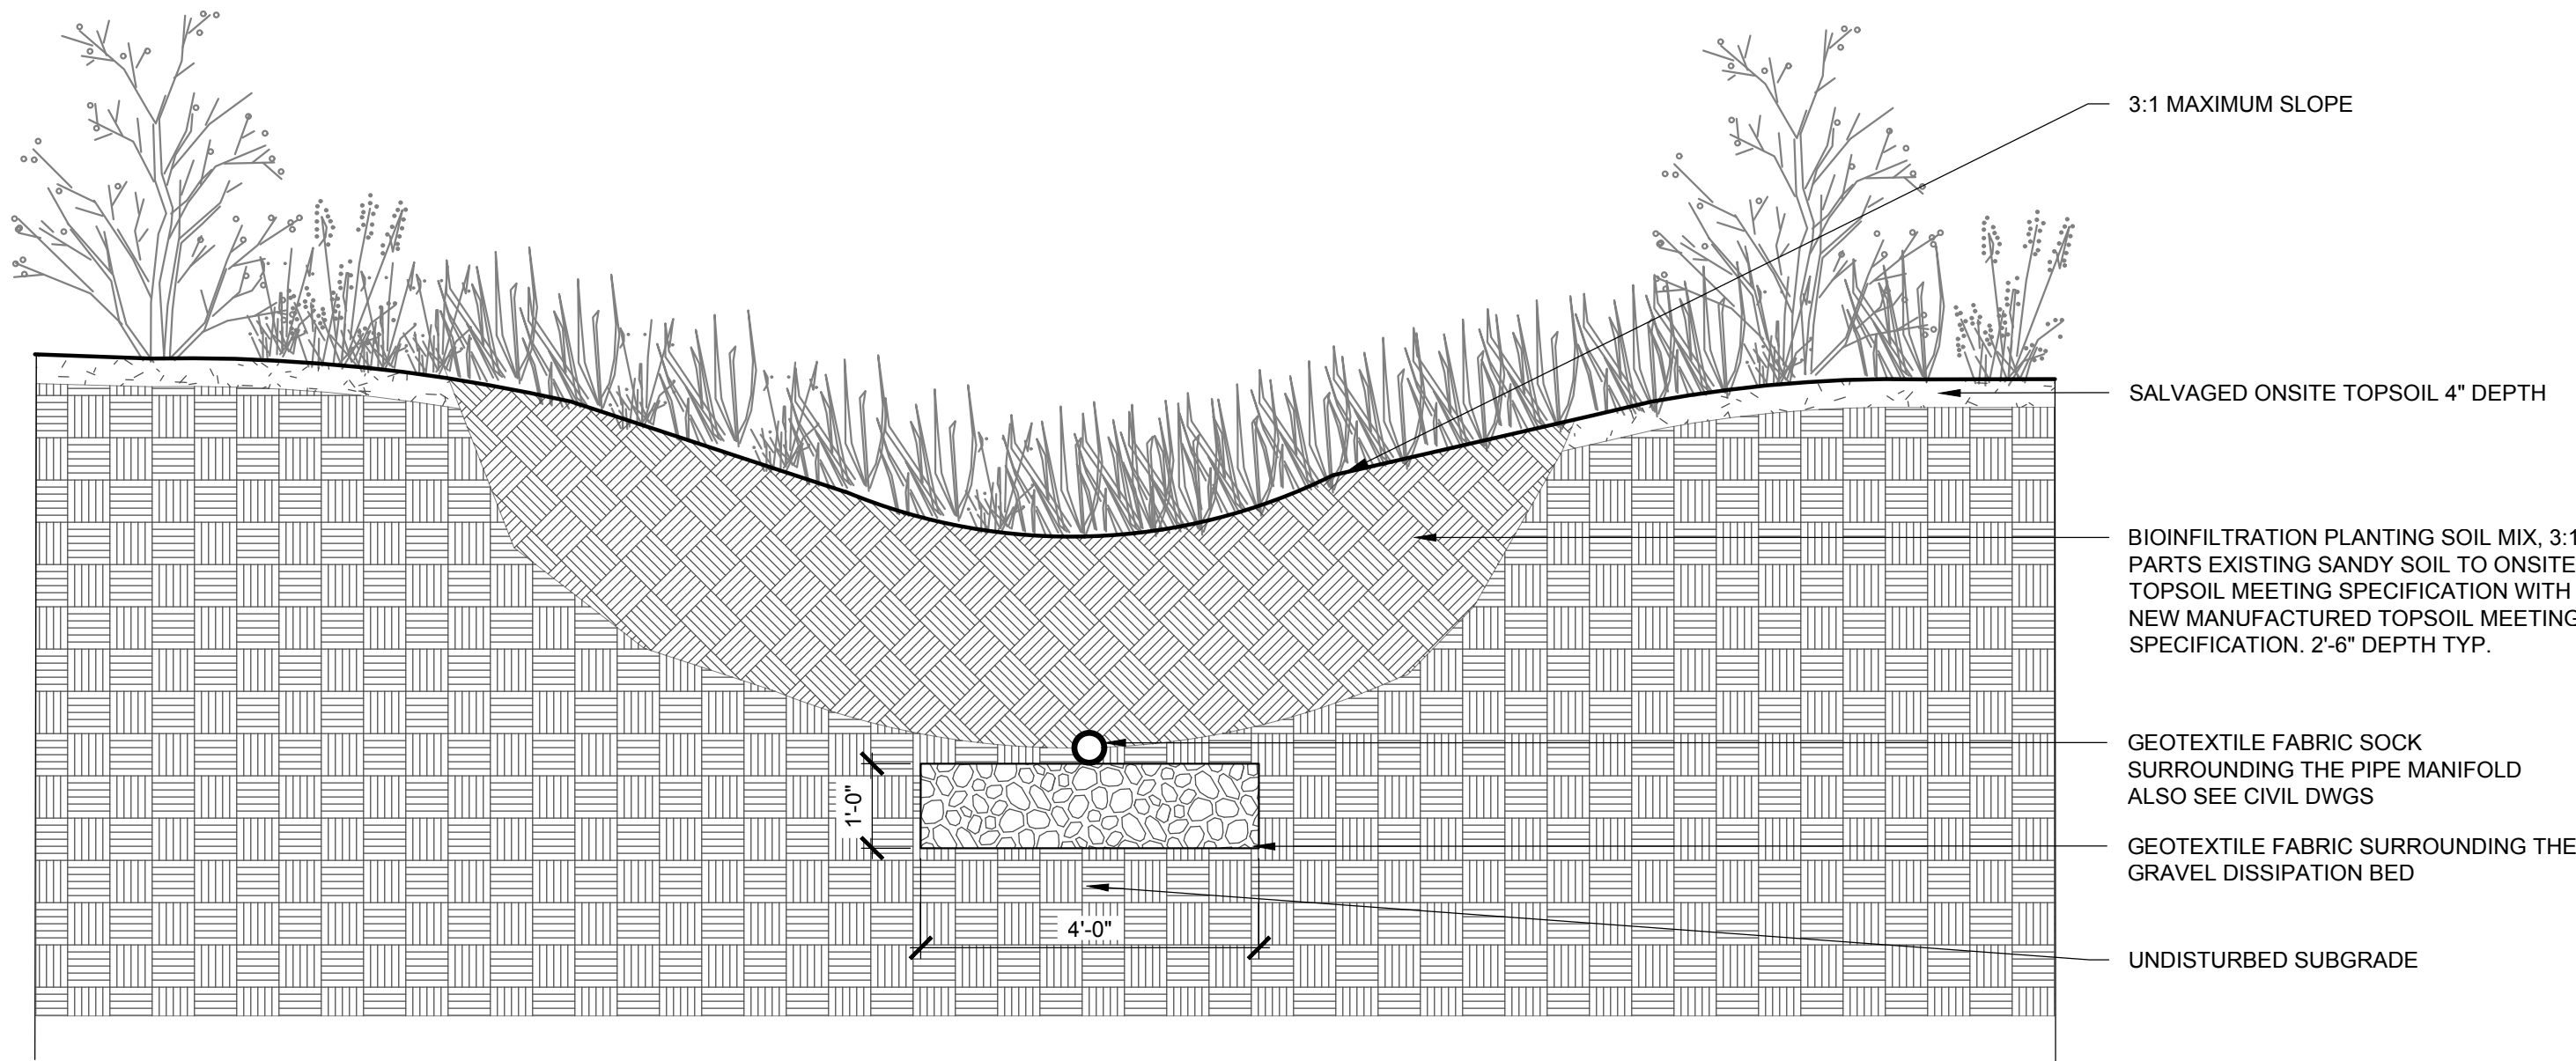

NOTE:

1. TEST SOIL MIXTURES, REPORT TO
ARCHITECT, AND AMEND TO MEET
THE REQUIRED INFILTRATION RATE
IF NECESSARY PRIOR TO SOIL
PLACEMENT
2. SEE C-SERIES DWGS. FOR PIPE,
CONNECTIONS AND SIZING

SECTION

5 INFILTRATING BIORETENTION BASIN
LP-501 1/2"=1'-0"



ANDROPOGON
ASSOCIATES, LTD
10 SHURS LANE
PHILADELPHIA, PA 19127
T: 215.487.0700
F: 215.483.7520
W: www.andropogon.com

PURCHASE COLLEGE
GREEN
INFRASTRUCTURE

PURCHASE COLLEGE
735 ANDERSON HILL ROAD
PURCHASE, NY 10577

LU ENGINEERS
CIVIL ENGINEERING
50 LAKEFRONT BLVD, SUITE 212
ROCHESTER, NY 14202
P: 716.849.0982
www.luengineers.com

ATLANTIC TESTING LABORATORIES
GEOTECHNICAL ENGINEERING
251 UPPER NORTH ROAD
HIGHLAND, NY 12528
P: 845.691.6098
www.atlantictesting.com

REV. DATE DESCRIPTION



STATE OF NEW YORK LIC. NO. 001147-1
BID DOCUMENTS

SCALE:	VARIES
DATE:	07.06.2018
DRAWN BY:	HG
CHECKED BY:	KG
APPROVED BY:	

AA PROJECT #:	150024
PROJECT PHASE:	BID DOCUMENTS

DRAWING TITLE:

LANDSCAPE DETAILS

SHEET:

LP-501