




Rev.	Description	Date
	ISSUED FOR CLIENT APPROVAL	09/03/14
	ISSUED FOR BID	11/10/14

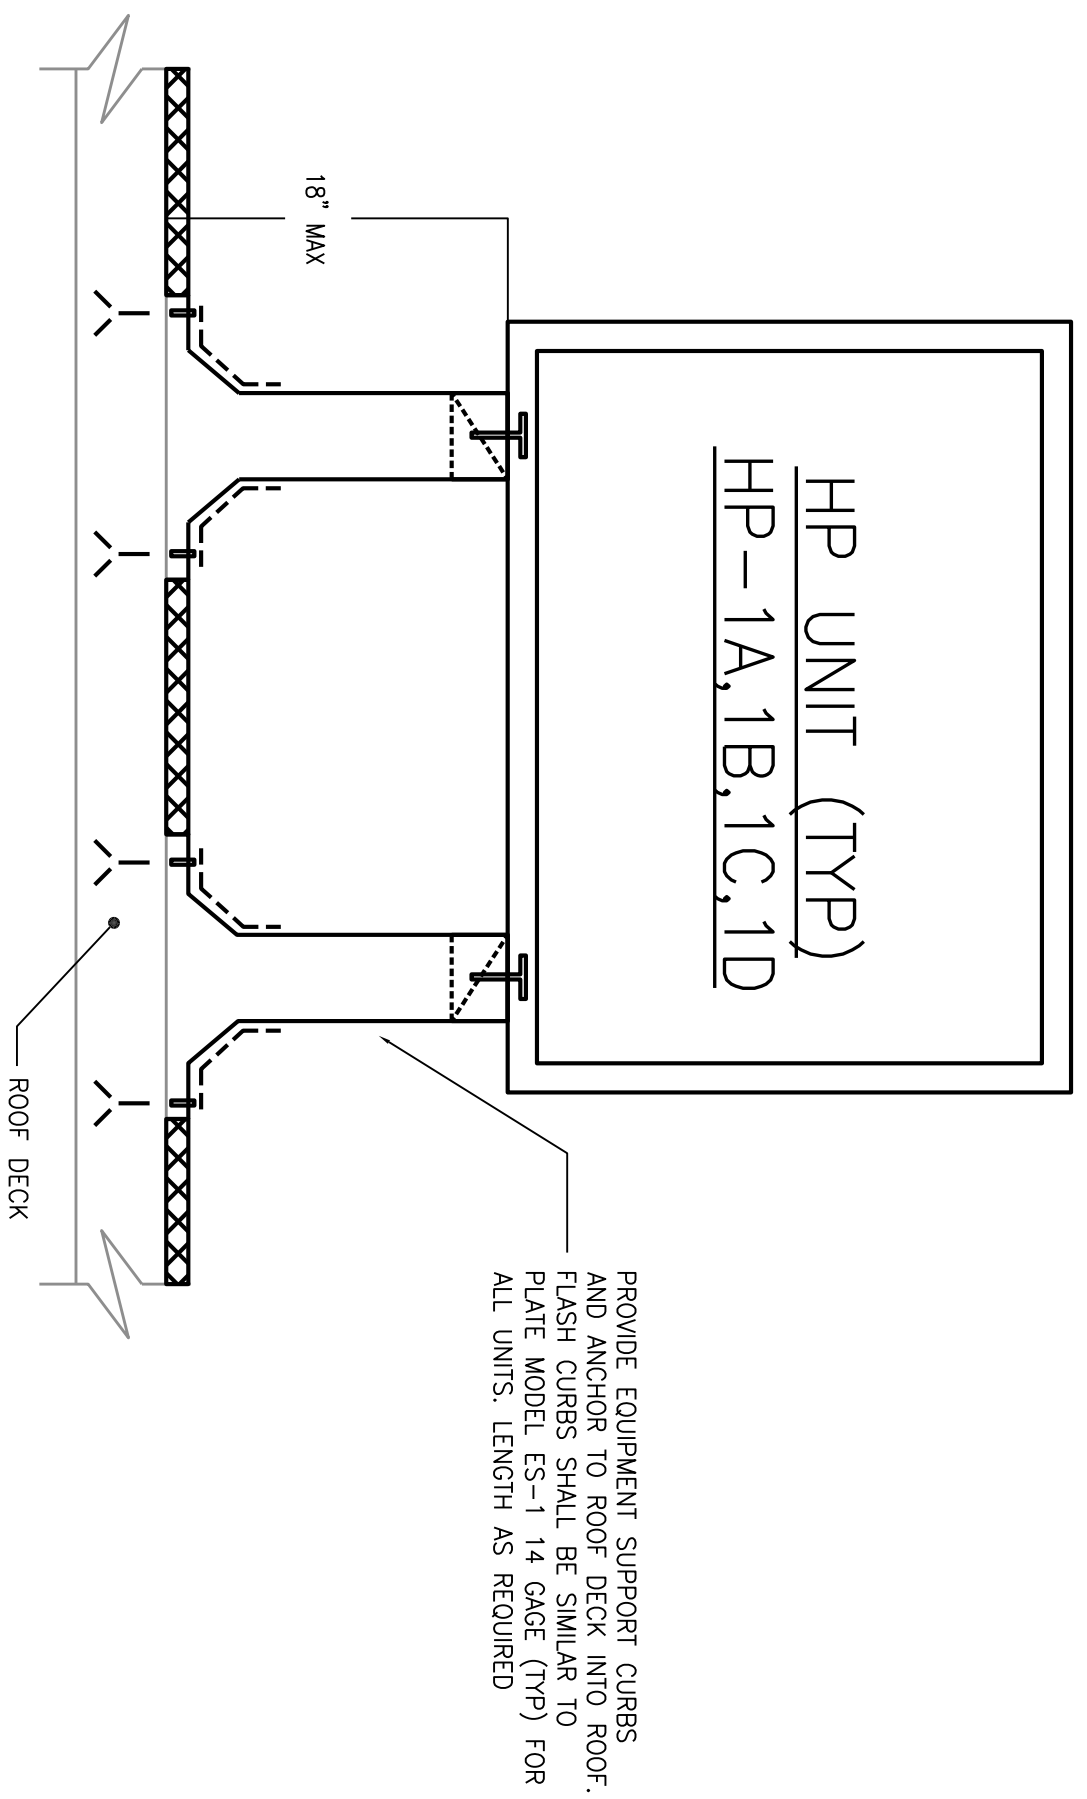

EQUIPMENT SUPPORT DETAIL
NOT TO SCALE

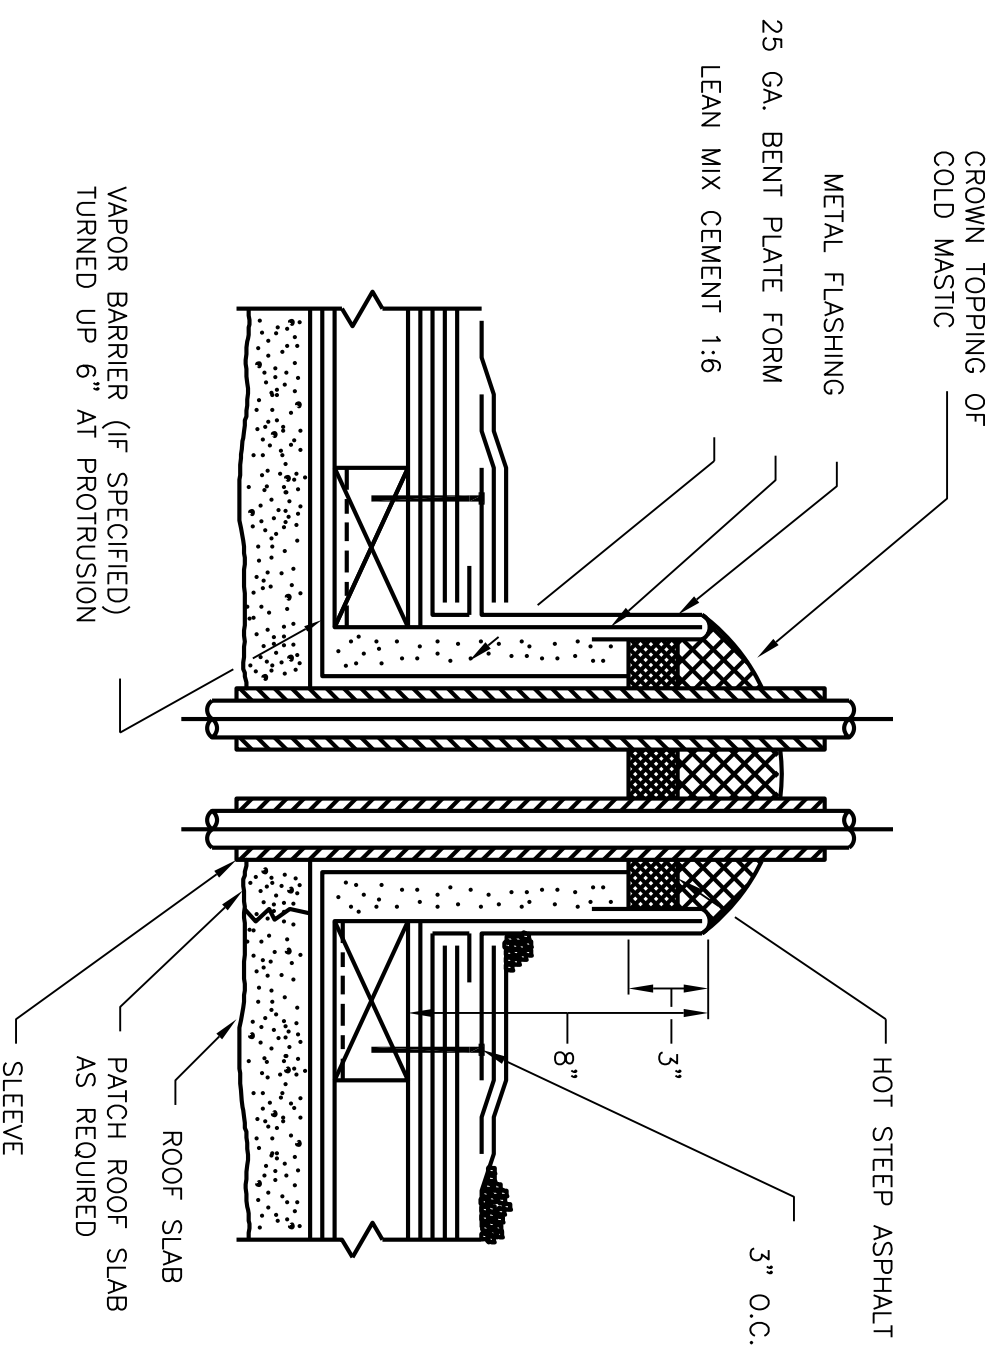


DETAIL OF PIPING THROUGH ROOF
NOT TO SCALE

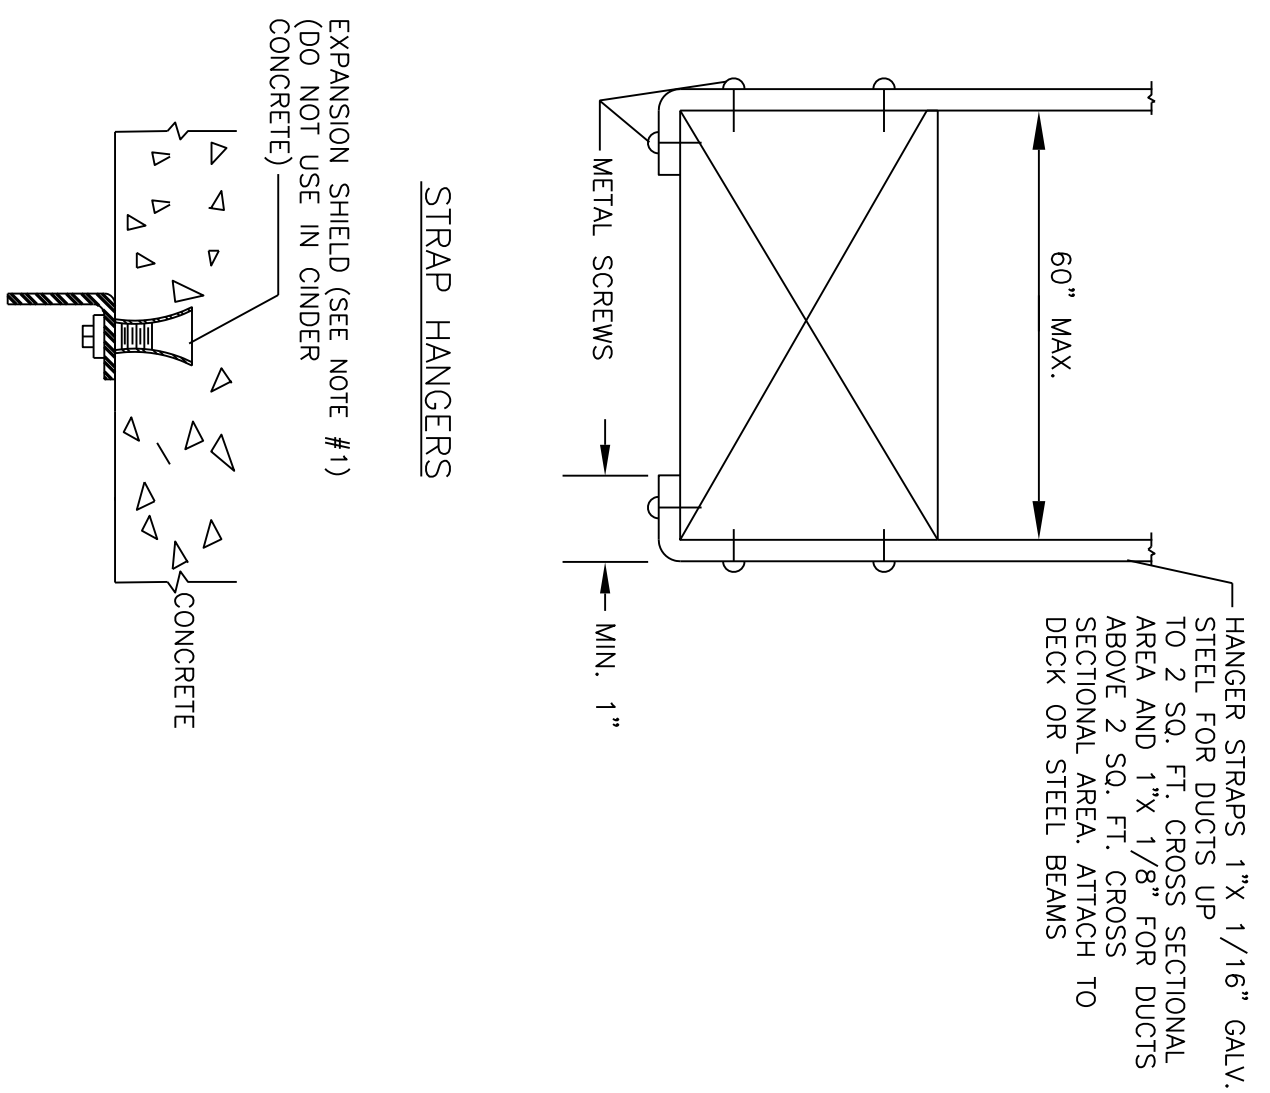


DUCTWORK SUPPORT DETAILS
(CONCRETE AND METAL DECK)
NOT TO SCALE


WALL OPENING	ANGLE SIZE
UP TO 54"	1 1/2"x1 1/2"x1/8"
55" TO 84"	3"x2"x 3/16"
85" TO 120"	3"x2"x 3/16"

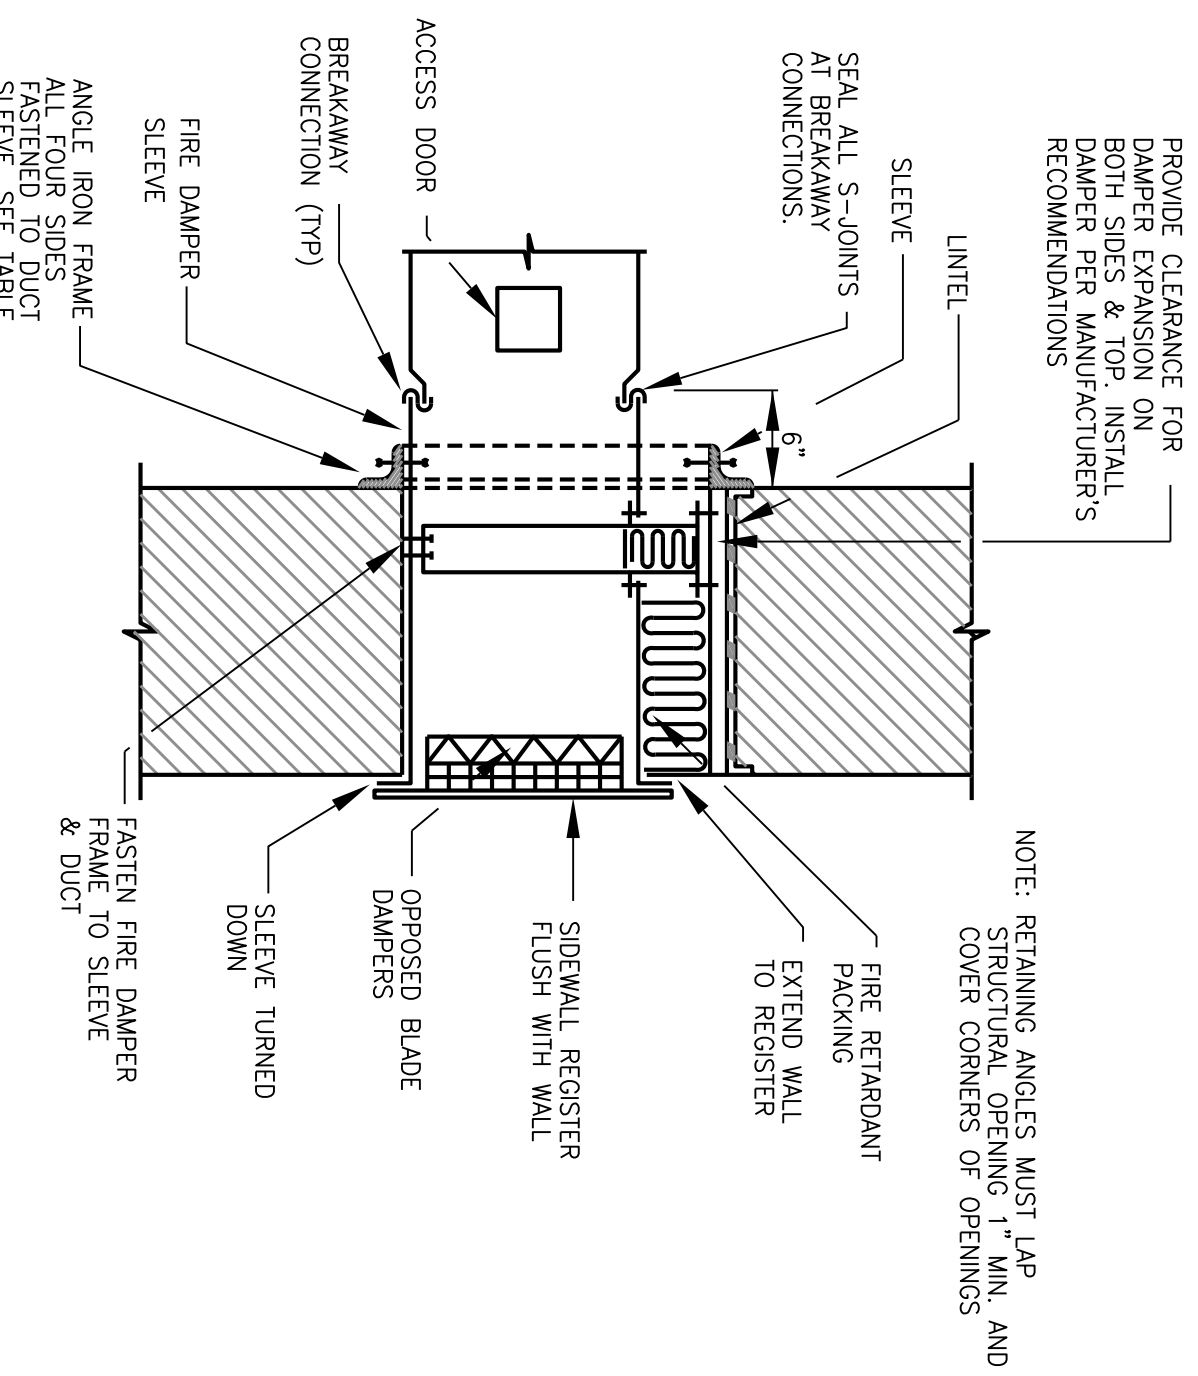

SIDEWALL REGISTER
FIRE DAMPER DETAIL
NOT TO SCALE

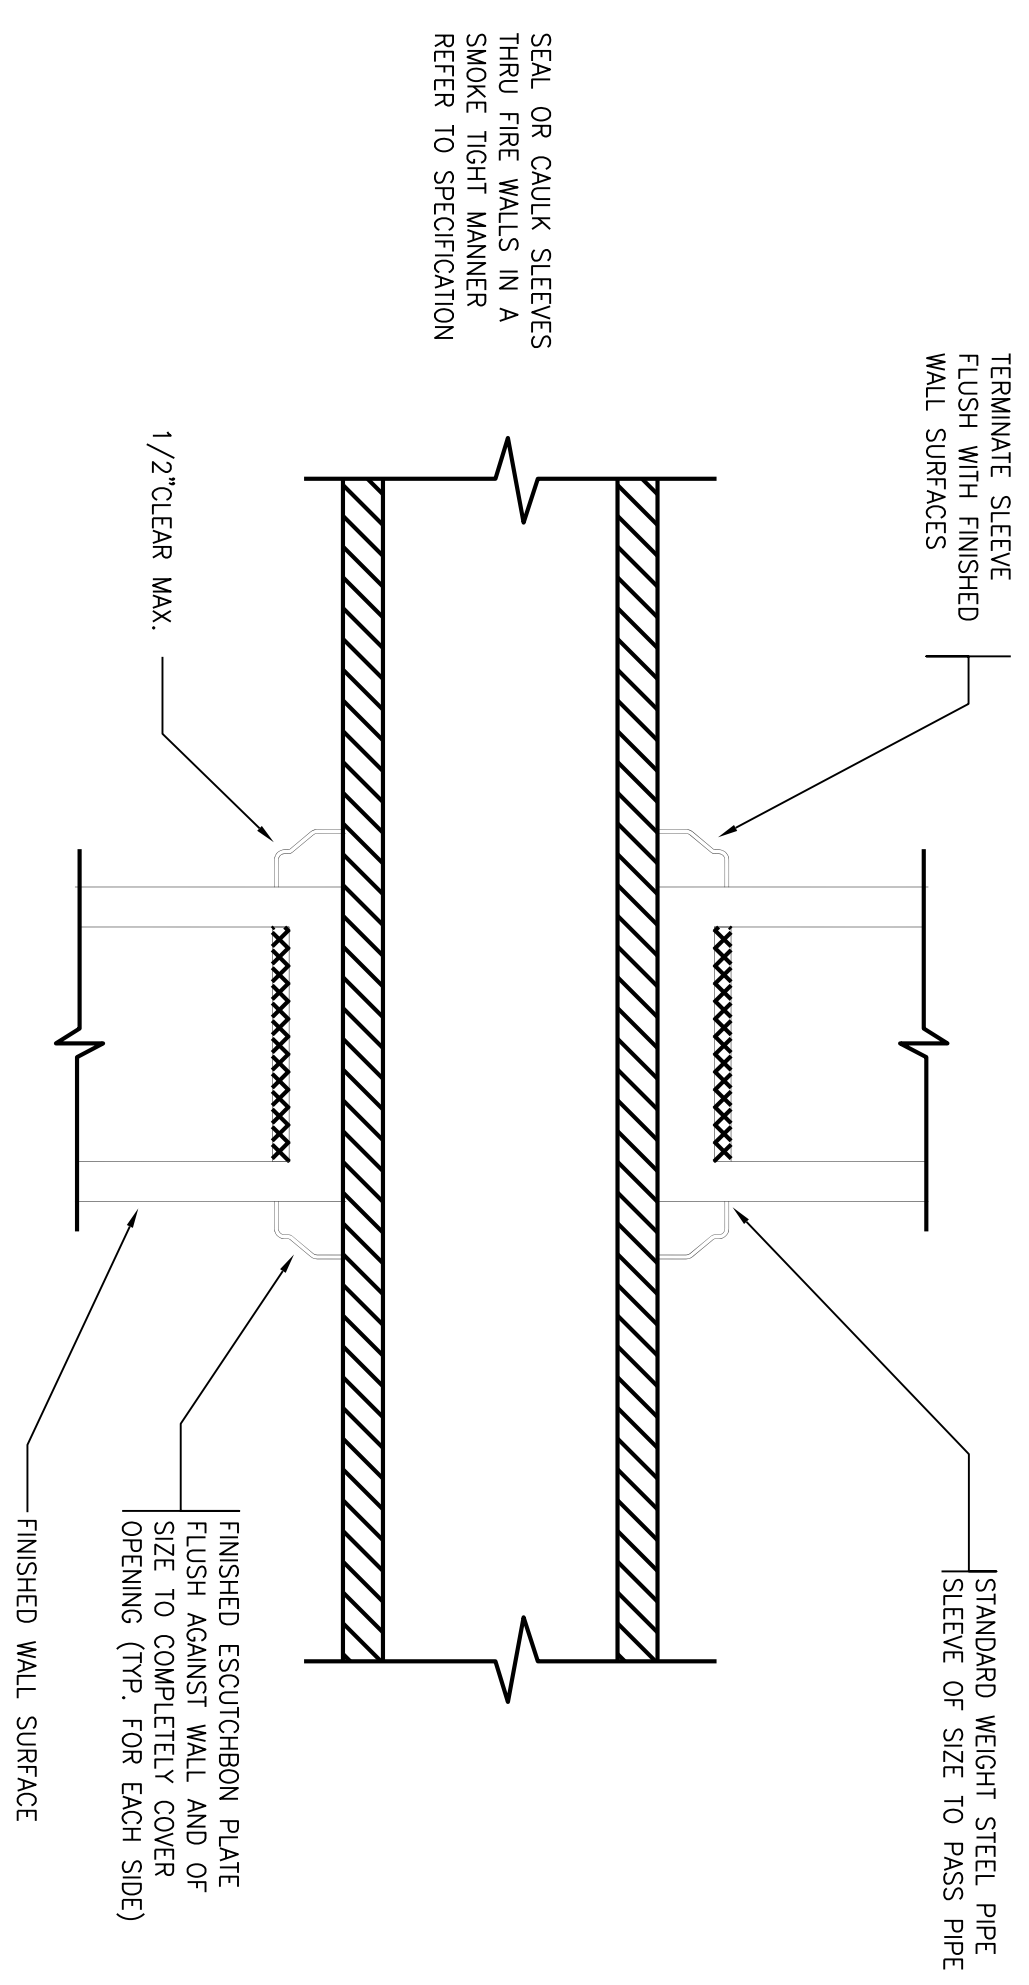


TYPICAL DETAIL OF
PIPE THRU RATED WALL
NOT TO SCALE

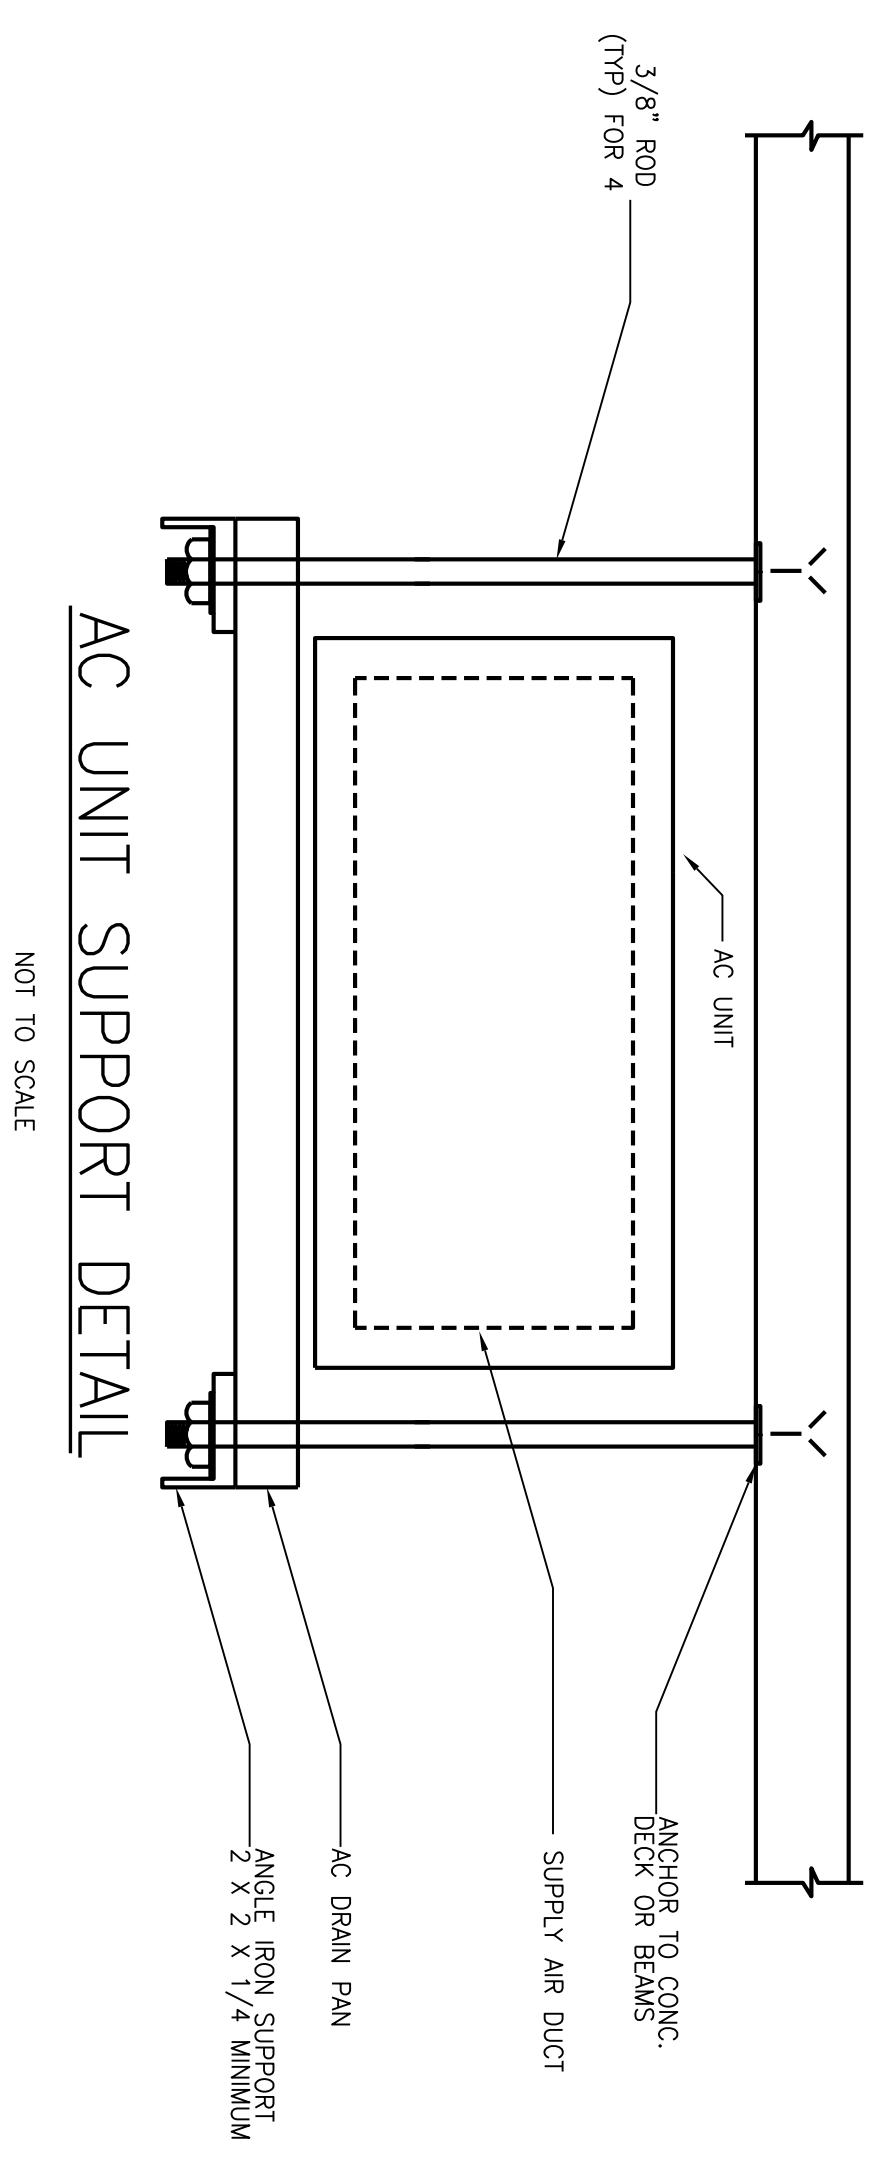

AC UNIT SUPPORT DETAIL
NOT TO SCALE

Collado
ENGINEERS
2 Holland Avenue
White Plains, NY 10603
(914) 332-7658

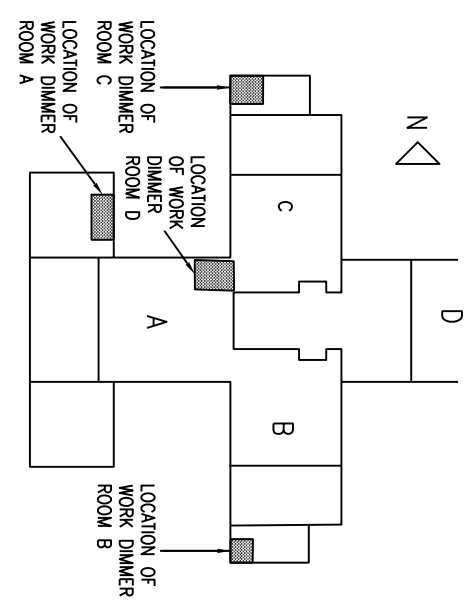

WARNING: IT IS A VIOLATION OF THE NYS EDUCATION LAW ARTICLE 145 FOR ANY PERSON, UNLESS HE IS ACTING UNDER THE DIRECTION OF A LICENSED PROFESSIONAL ENGINEER, TO ALTER THIS ITEM IN ANY WAY.

Client or Agent
State University of New York College at Purchase

Purchase, New York

Project Title
SUNNY PURCHASE DIMMERS ROOMS

Drawing Title
MECHANICAL DETAILS

Scale AS NOTED
Date 7/30/2014
Drawing No. M-300.00

Checked C.E. Job No.
Copyright © 2013 by Collado Engineering, P.C.